

09\_08/99

See Sheet 1A for Index of Sheets

STATE OF NORTH CAROLINA  
DIVISION OF HIGHWAYS

**IREDELL COUNTY**


LOCATION: I-77 FROM MM 36.5 to MM 48.85

WORK TYPE: PAVEMENT REHABILITATION.

|                 |                             |             |              |
|-----------------|-----------------------------|-------------|--------------|
| STATE           | STATE PROJECT REFERENCE NO. | SHEET NO.   | TOTAL SHEETS |
| N.C.            | I-5918                      | 1           |              |
| STATE PROJ. NO. | F.A. PROJ. NO.              | DESCRIPTION |              |
| 45924.1.2       |                             | PE          |              |
| 45924.3.1       | 0077023                     | CONST.      |              |
|                 |                             |             |              |
|                 |                             |             |              |
|                 |                             |             |              |

**TIP PROJECT: I-5918**

**C204948**

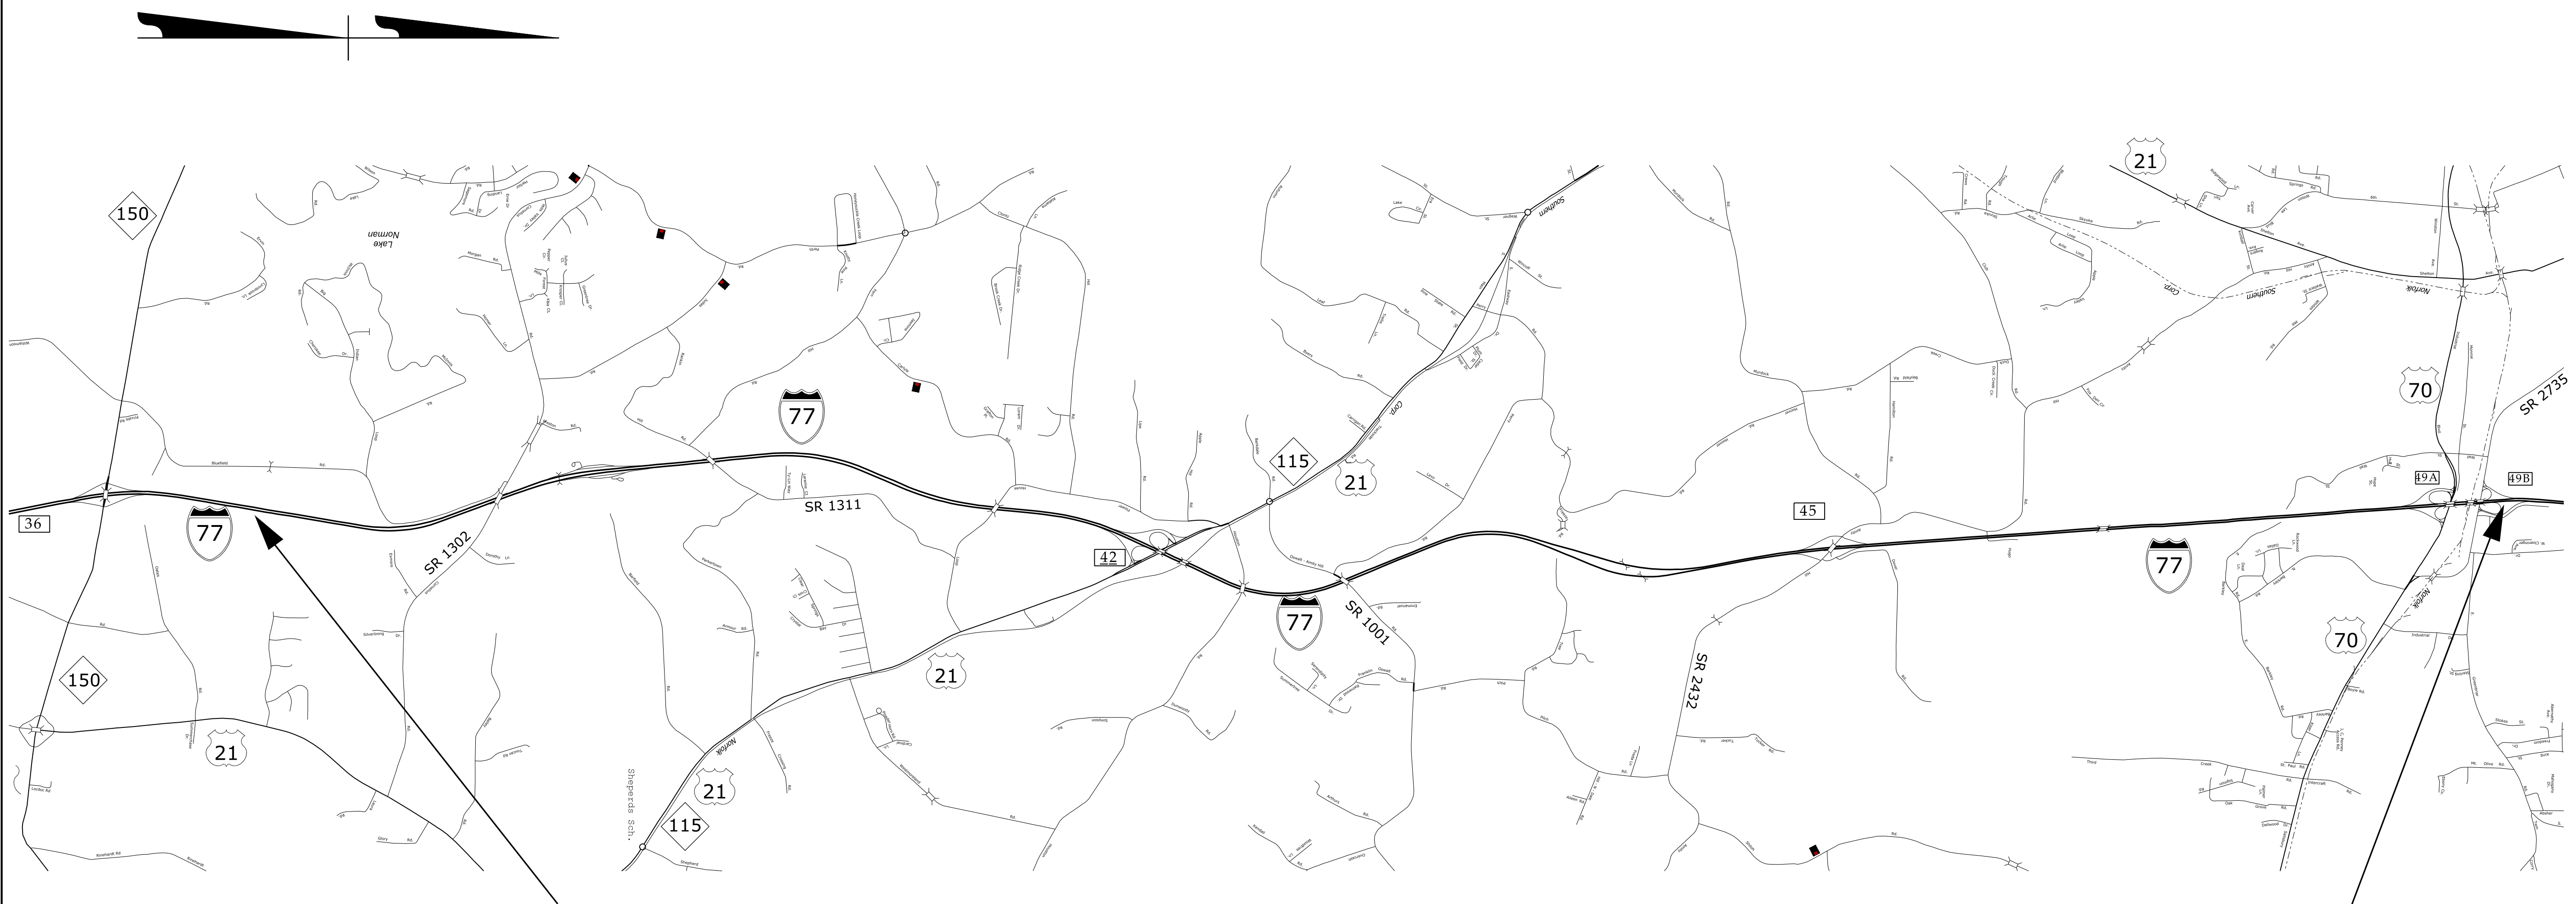

**BEGIN PROJECT I-5918  
MILE MARKER 36.50**

**END PROJECT I-5918  
MILE MARKER 48.85**

**PROJECT LENGTH**

LENGTH ROADWAY TIP PROJECT I-5918 = 12.35 MI


Prepared In the Office of:  
**DIVISION OF HIGHWAYS**  
1710 EAST MARION ST., SHELBY NC 28151

2024 STANDARD SPECIFICATIONS

**JASON WILLIS**  
DIVISION MAINTENANCE ENGINEER

LETTING DATE:  
JULY 16, 2024

**BRYAN K. SOWELL, PE**  
PROJECT DESIGN ENGINEER

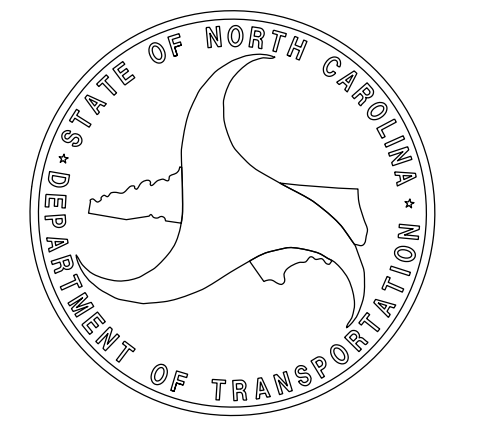

26-APR-2024 07:50  
S:\DDC\District 2\Iredell\I-5918 I-77 MM 36 to 49\Types-Maps-Details\I-5918 Final CADD Files\I-5918\_Rdy\_Tsh\_maps.dgn  
\$\$\$\$\$USERNAME\$\$\$\$\$