

TIP PROJECT: U-6018


CONTRACT: C204798

STATE OF NORTH CAROLINA
DIVISION OF HIGHWAYS


GUILFORD COUNTY

LOCATION: WIDENING OF NC 62 (LIBERTY RD) FROM EAST OF NC 610 (E FAIRFIELD RD) TO EAST OF SR 4066 (MODLIN GROVE RD) AND THE REALIGNMENT OF SR 1154 (KERSEY VALLEY RD) AND SR 1162 (WEANT RD)

TYPE OF WORK: TRAFFIC SIGNALS AND SIGNAL COMMUNICATIONS

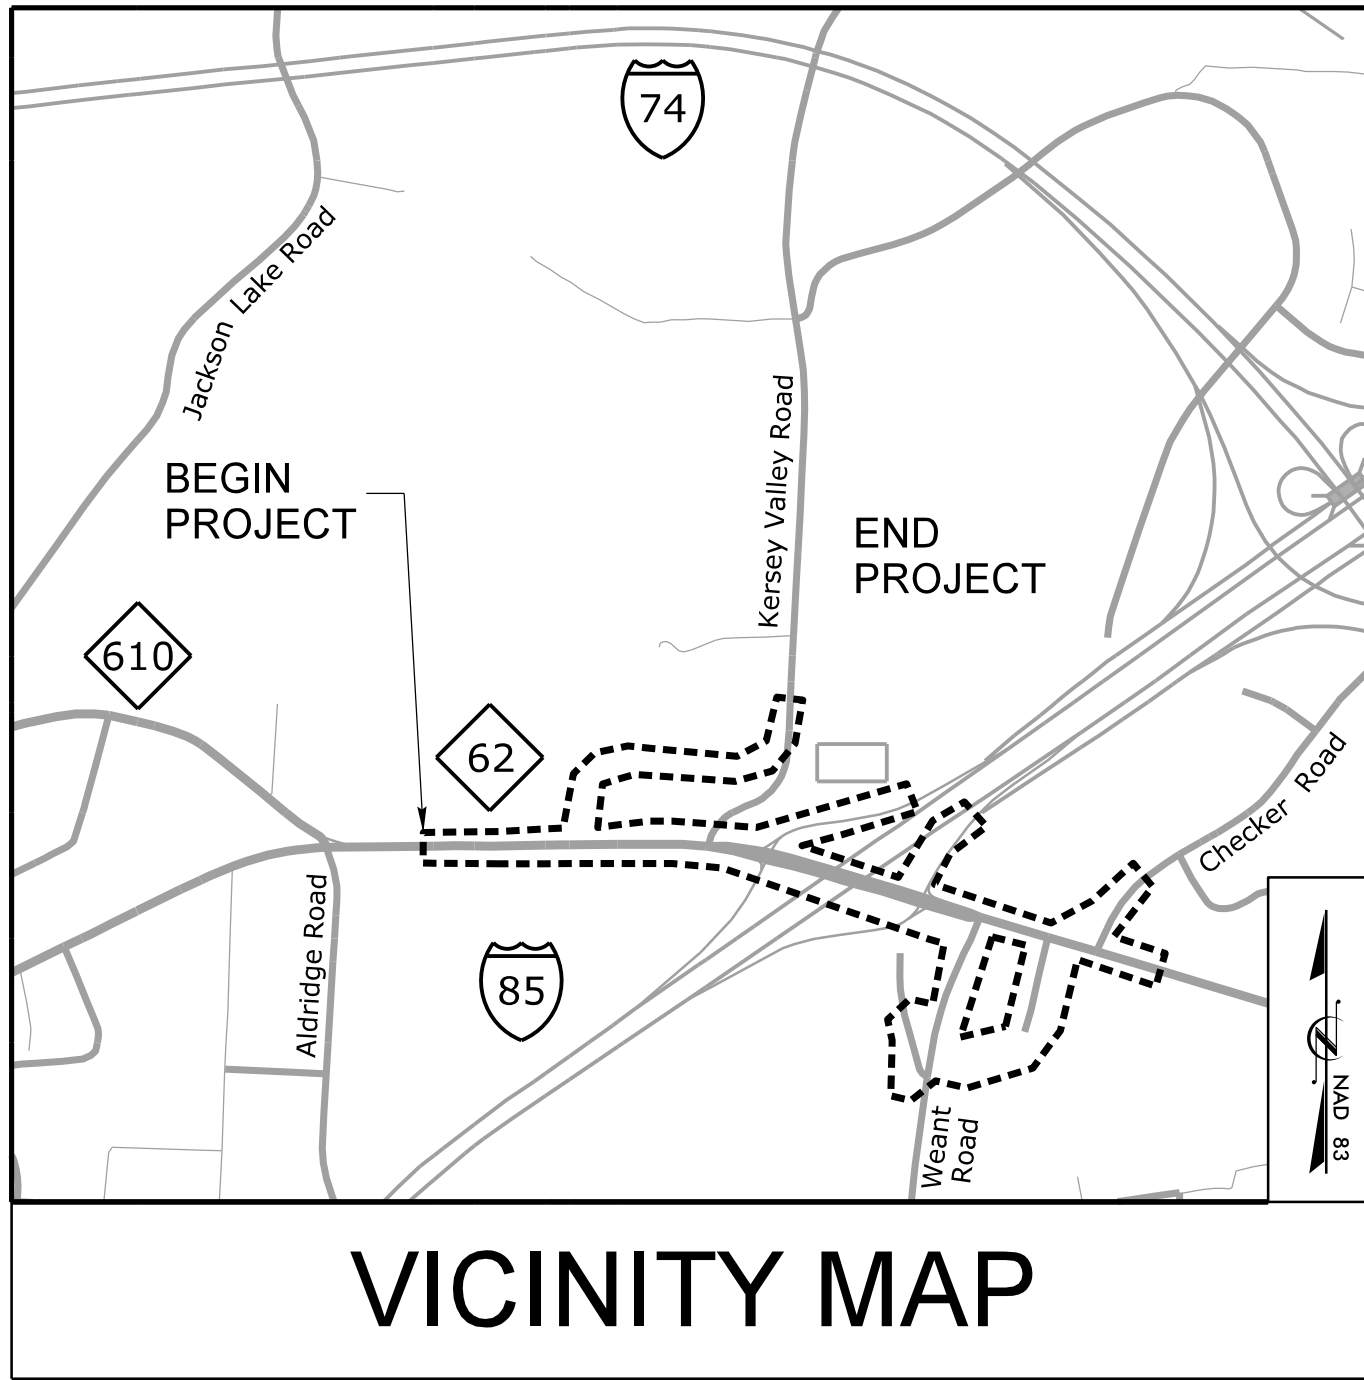

VICINITY MAP

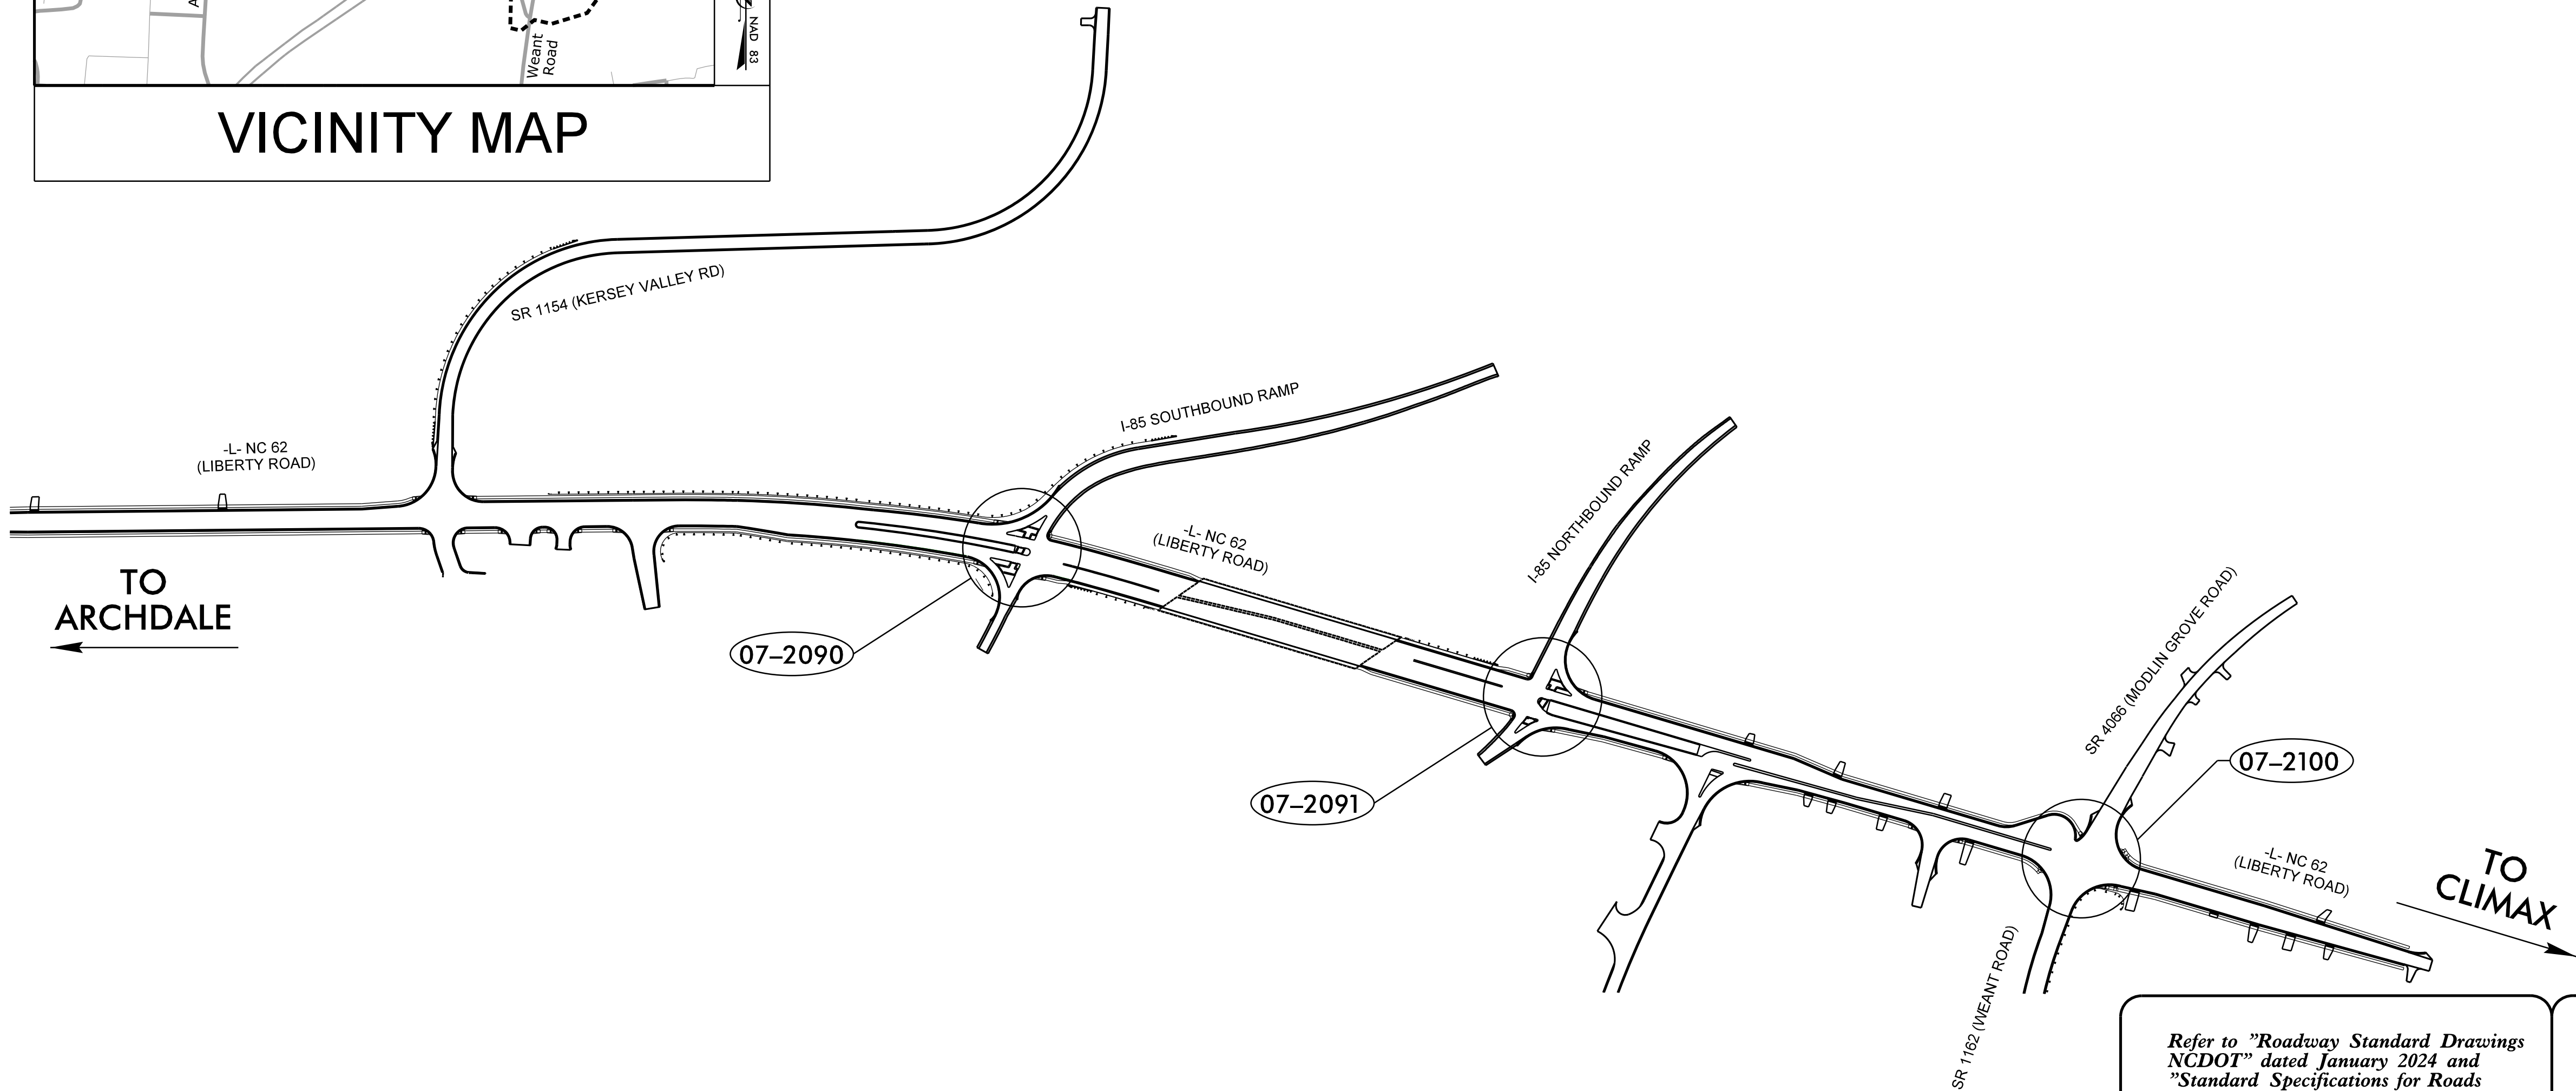

PROJECT REFERENCE NO. U-6018

SHEET NO. Sig 1.0

APPROVED: 

DATE: 3/19/2025

SEAL



DOCUMENT NOT CONSIDERED FINAL
UNLESS ALL SIGNATURES COMPLETED



PLANS PREPARED BY:

Zachary M. Esposito, P.E., TCDS – Project Manager
Andrew W. Poole, E.I. – Project Engineer

INDEX OF PLANS

Sheet Number	SIN	Title Sheet	Location/Description
Sig. 1.0	-	-	-
Sig. 2.0-5.4	07-2090	NC 62 (Liberty Road) at I-85 SB Ramps	
Sig. 6.0-9.2	07-2091	NC 62 (Liberty Road) at I-85 NB Ramps	
Sig. 10.0-12.5	07-2100	NC 62 (Liberty Road) at SR 1162 (Weant Rd)/SR 4066 (Modlin Grove Rd)	
Sig. M1A-M9	-	Standard Metal Poles Drawings	
SCP 1-9	-	Signal Communication Plans	

LEGEND

XX-XXXX

TRAFFIC SIGNAL

TRANSPORTATION SYSTEMS
MANAGEMENT & OPERATIONS UNIT

Contacts:
Robert J. Ziemba, P.E. – Central Region Signals Engineer
D. Todd Joyce, P.E. – Signal Equipment Design Review Engineer
Gregory A. Green – Signal Communications Project Engineer

Refer to "Roadway Standard Drawings
NCDOT" dated January 2024 and
"Standard Specifications for Roads
and Structures" dated January 2024.

**DRMP**

DRMP, INC.
8210 UNIVERSITY EXECUTIVE PARK DR.
SUITE 220
CHARLOTTE, NC 28262
PHONE: 704-546-4260

NC LICENSE NO. F-1524
www.drmp.com