

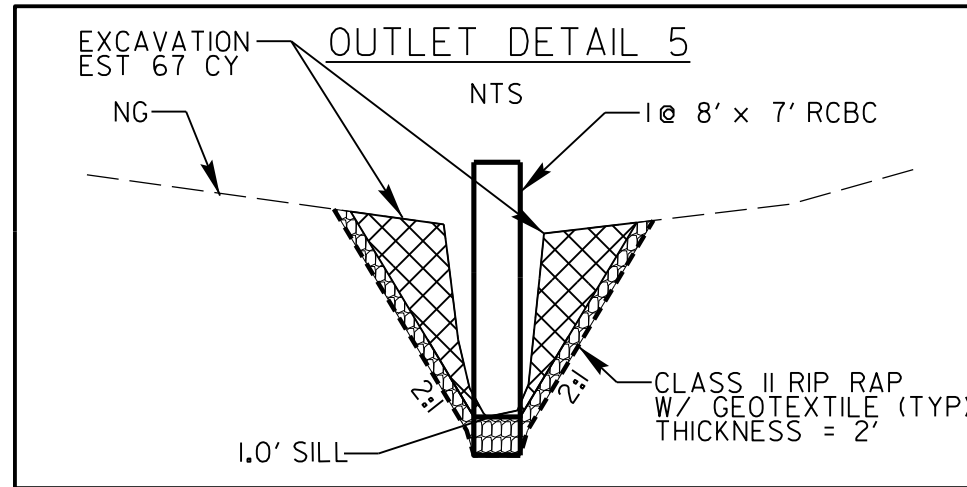
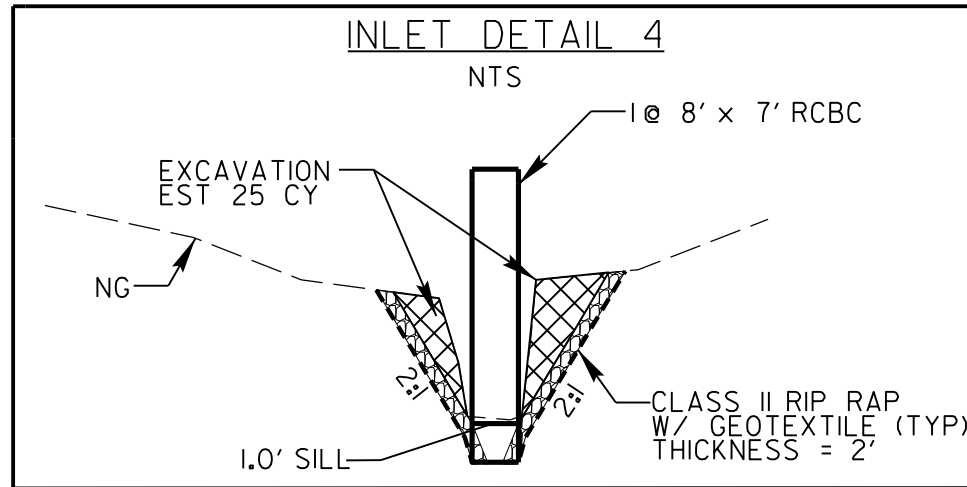
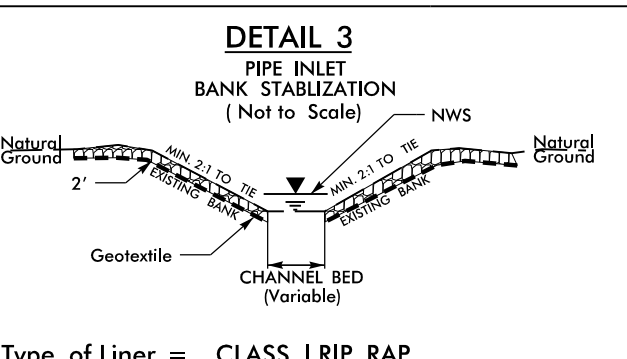


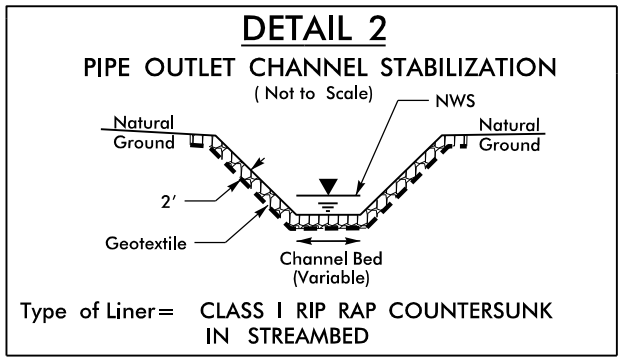

Lochner

H. W. LOCHNER, INC.
2840 PLAZA PLACE, SUITE 202
RALEIGH, NC 27612
(919) 571-7111

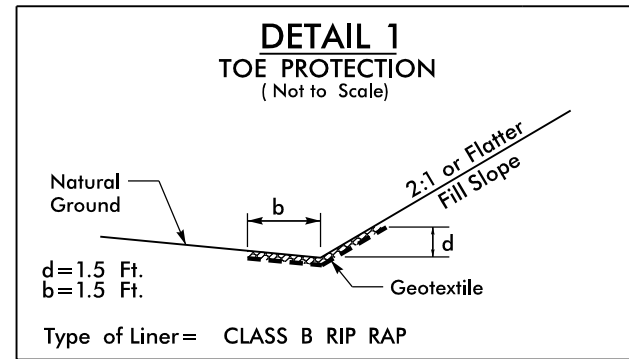


VHB Engineering NC, P.C. (C-3705)
940 Main Campus Drive, Suite 500
Raleigh, NC 27606


NC License
Number F-0159

PROJECT REFERENCE NO.		SHEET NO.	
HL-0033		EC-04C/CONST.04	
RW SHEET NO.		HYDRAULICS ENGINEER	
ROADWAY DESIGN ENGINEER		HYDRAULICS ENGINEER	

CLEARING AND GRUBBING
EROSION CONTROL FOR
EXISTING TELEPHONE LINE
REPLACEMENT

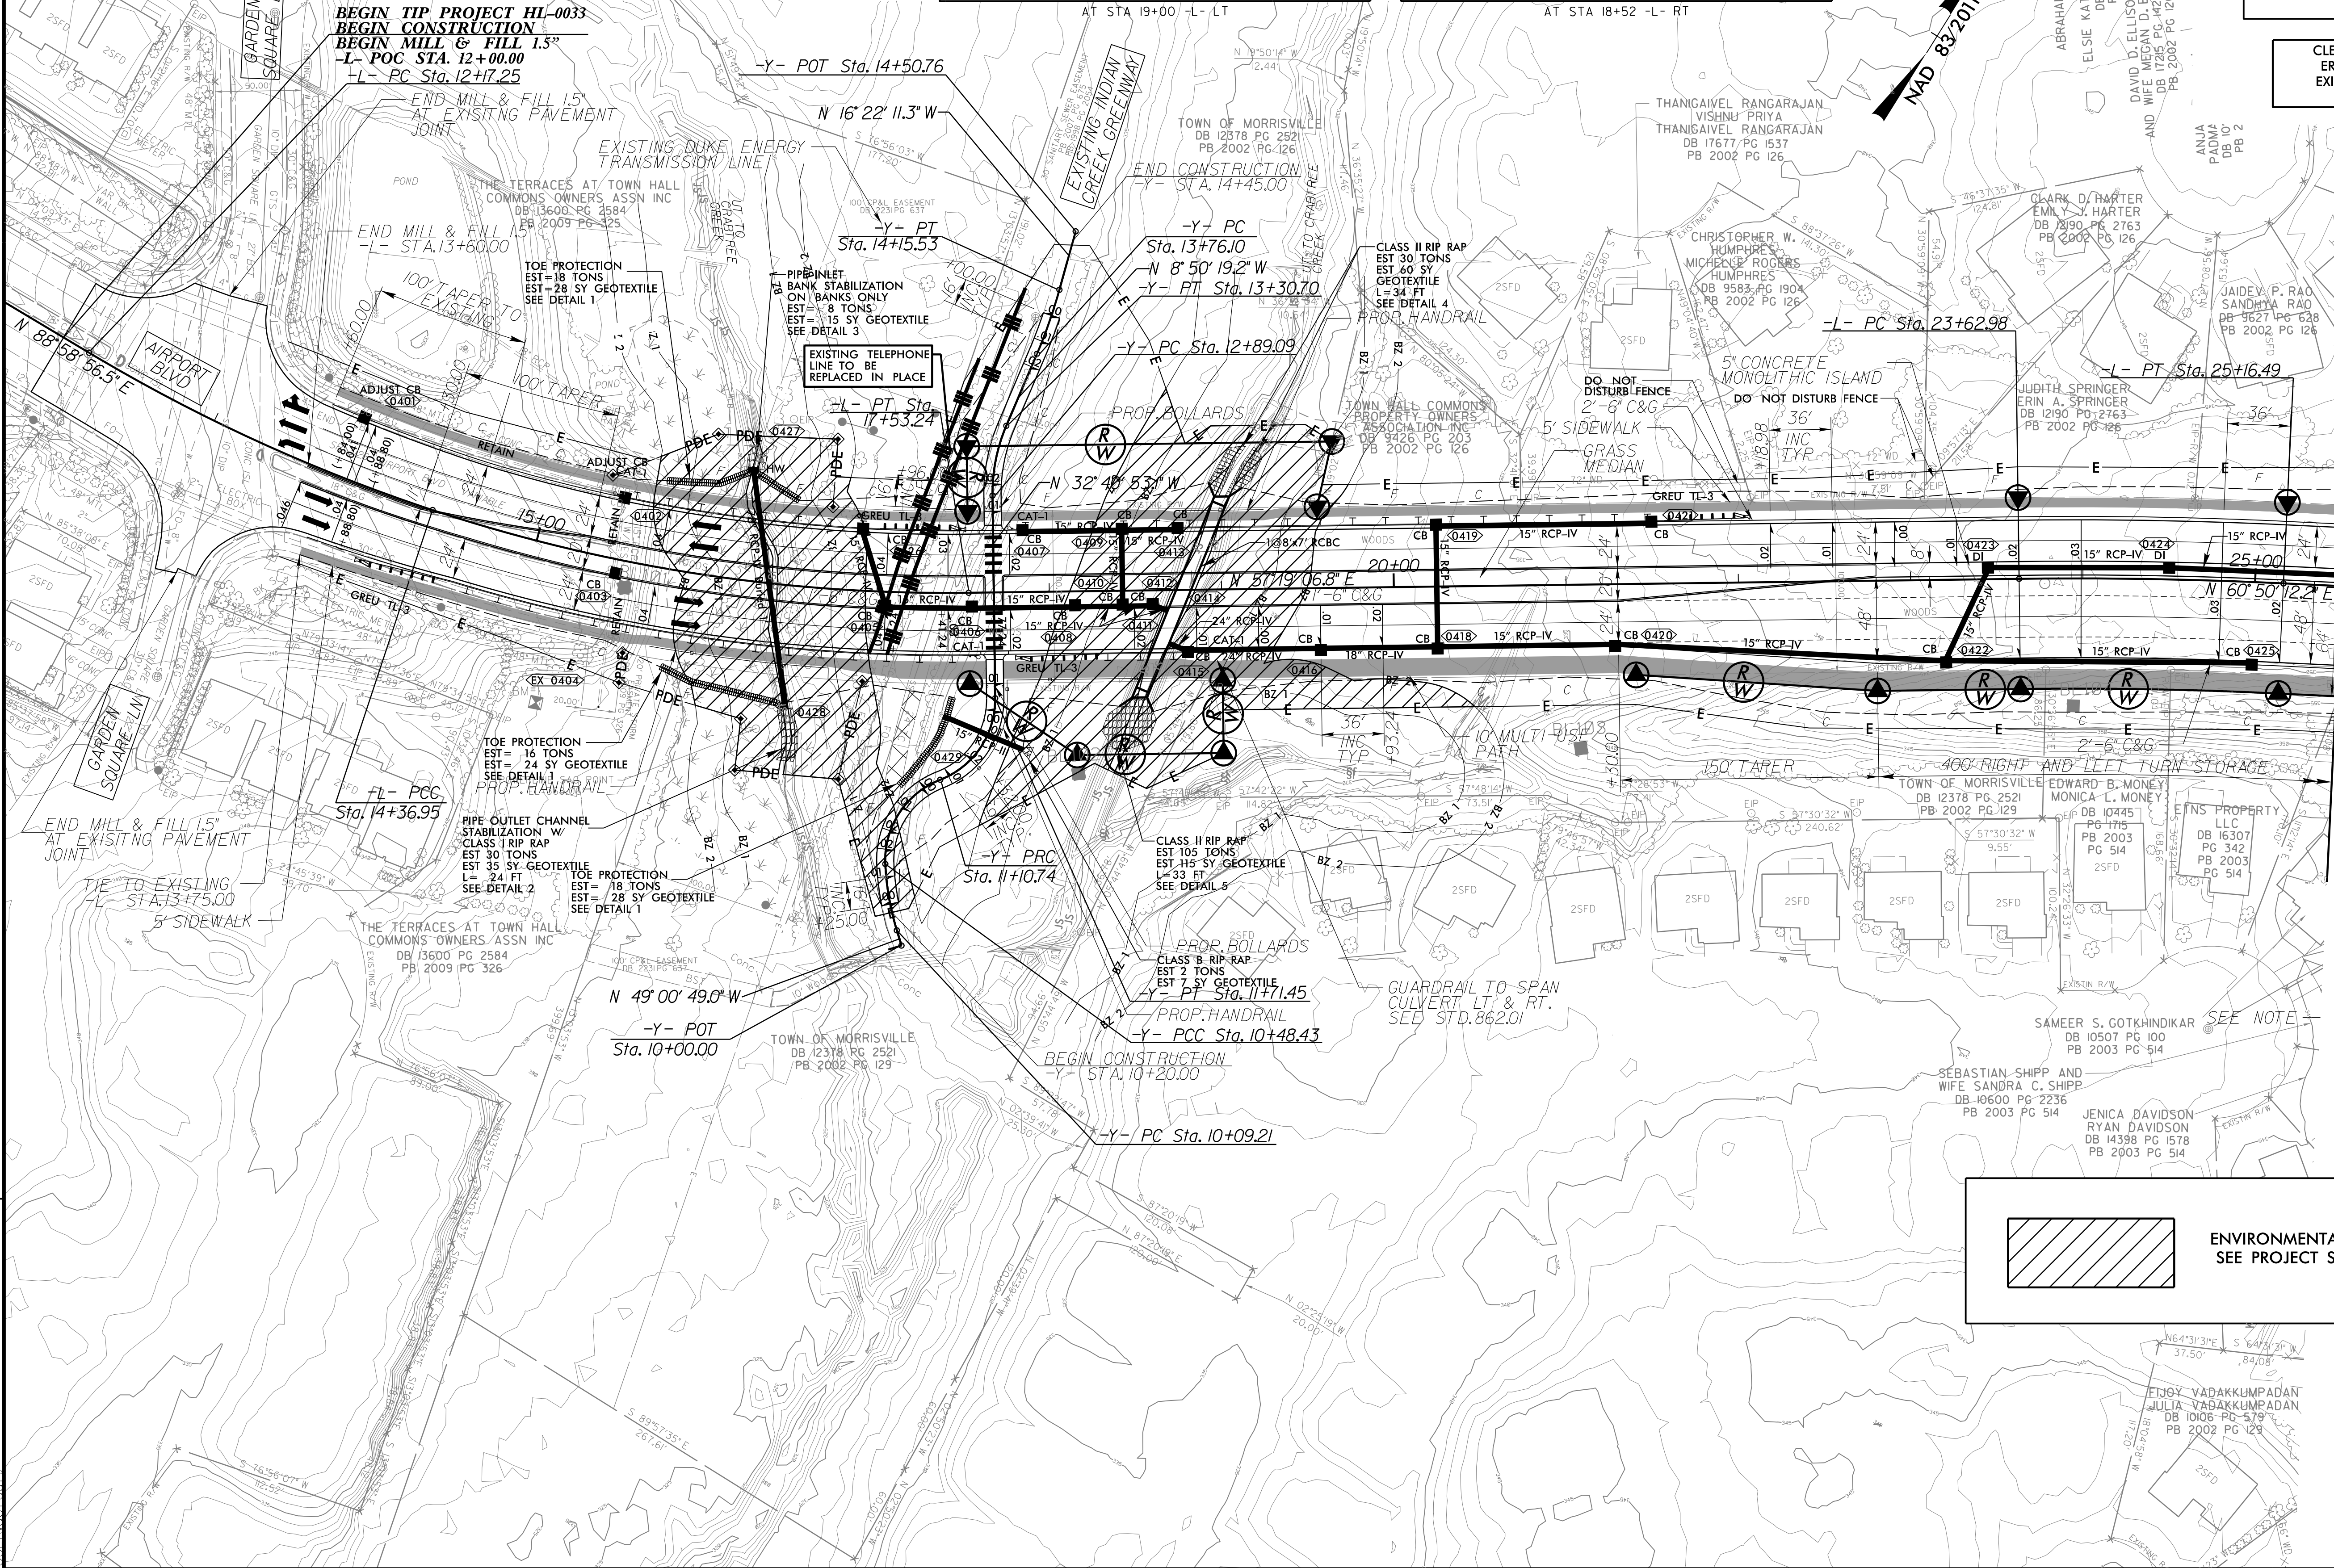

MATCHLINE -L- STA. 25+50
SEE SHEET 5

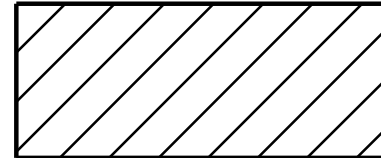

ENVIRONMENTALLY SENSITIVE AREA
SEE PROJECT SPECIAL PROVISIONS