


Project: BR-0168

Project No.	Sheet No.
BR-0168	Sig. 1.0



STATE OF NORTH CAROLINA DIVISION OF HIGHWAYS

FORSYTH COUNTY

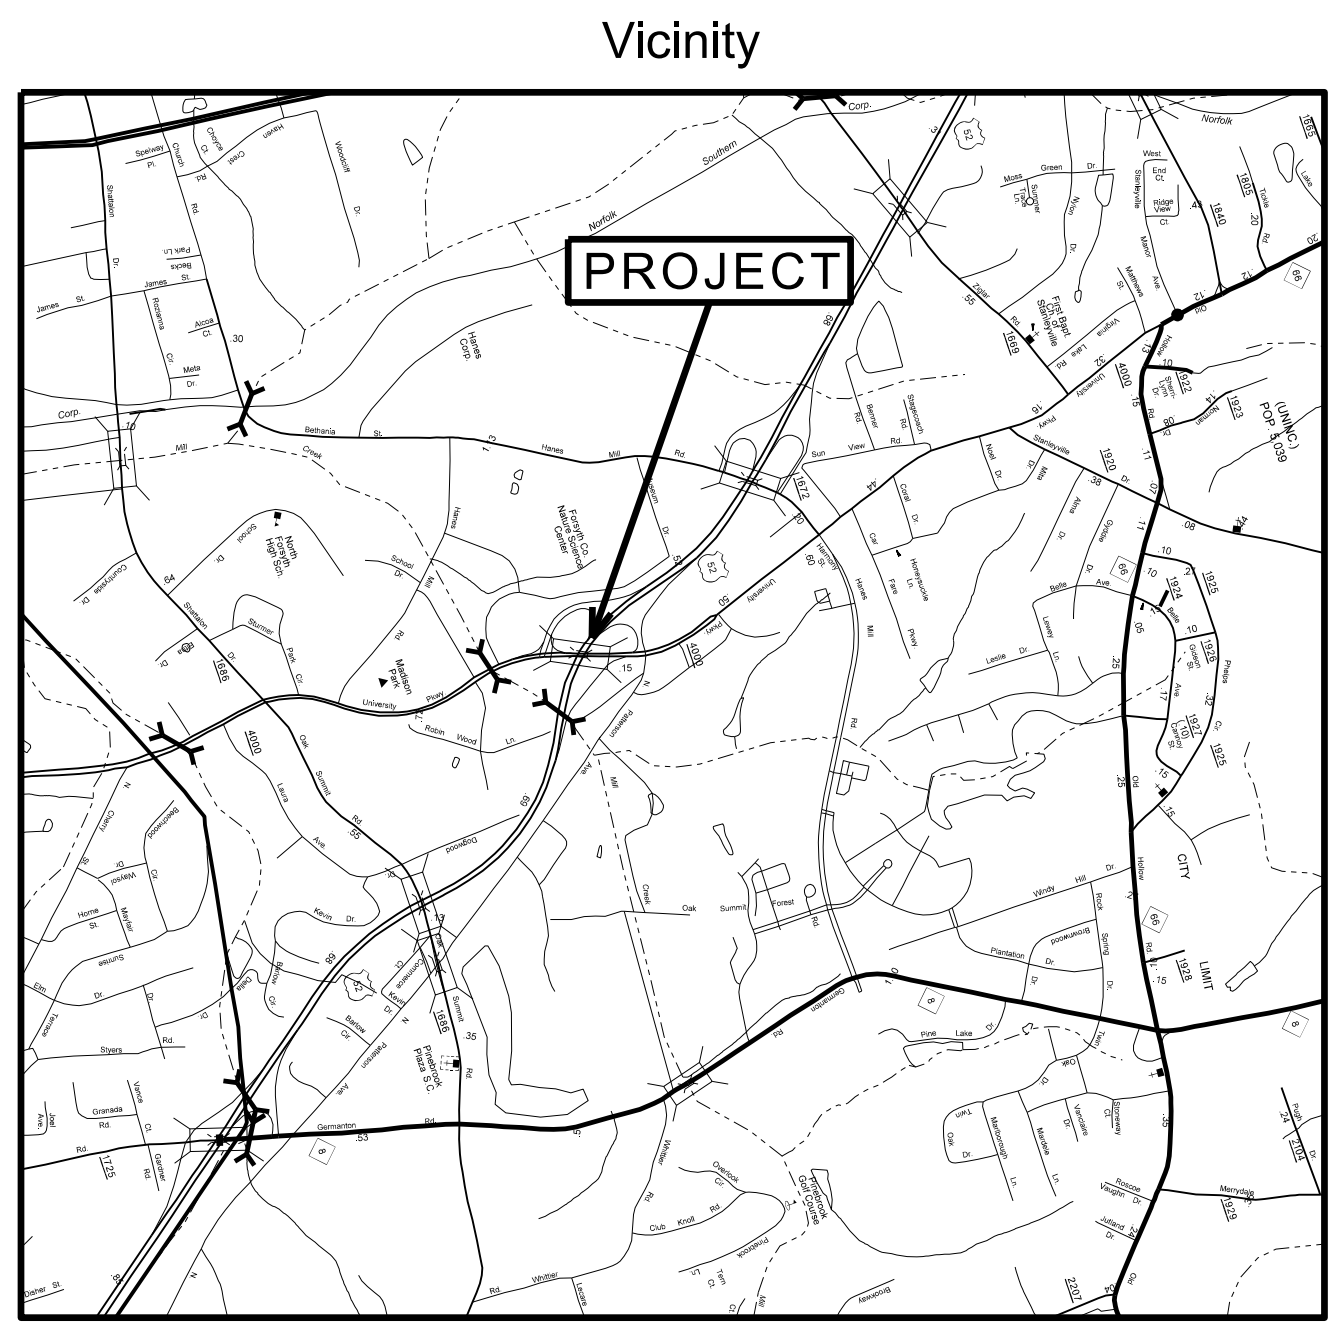

LOCATION: SR 4000 (UNIVERSITY PARKWAY) AT US 52

TYPE OF WORK: TRAFFIC SIGNALS AND SIGNAL COMMUNICATIONS

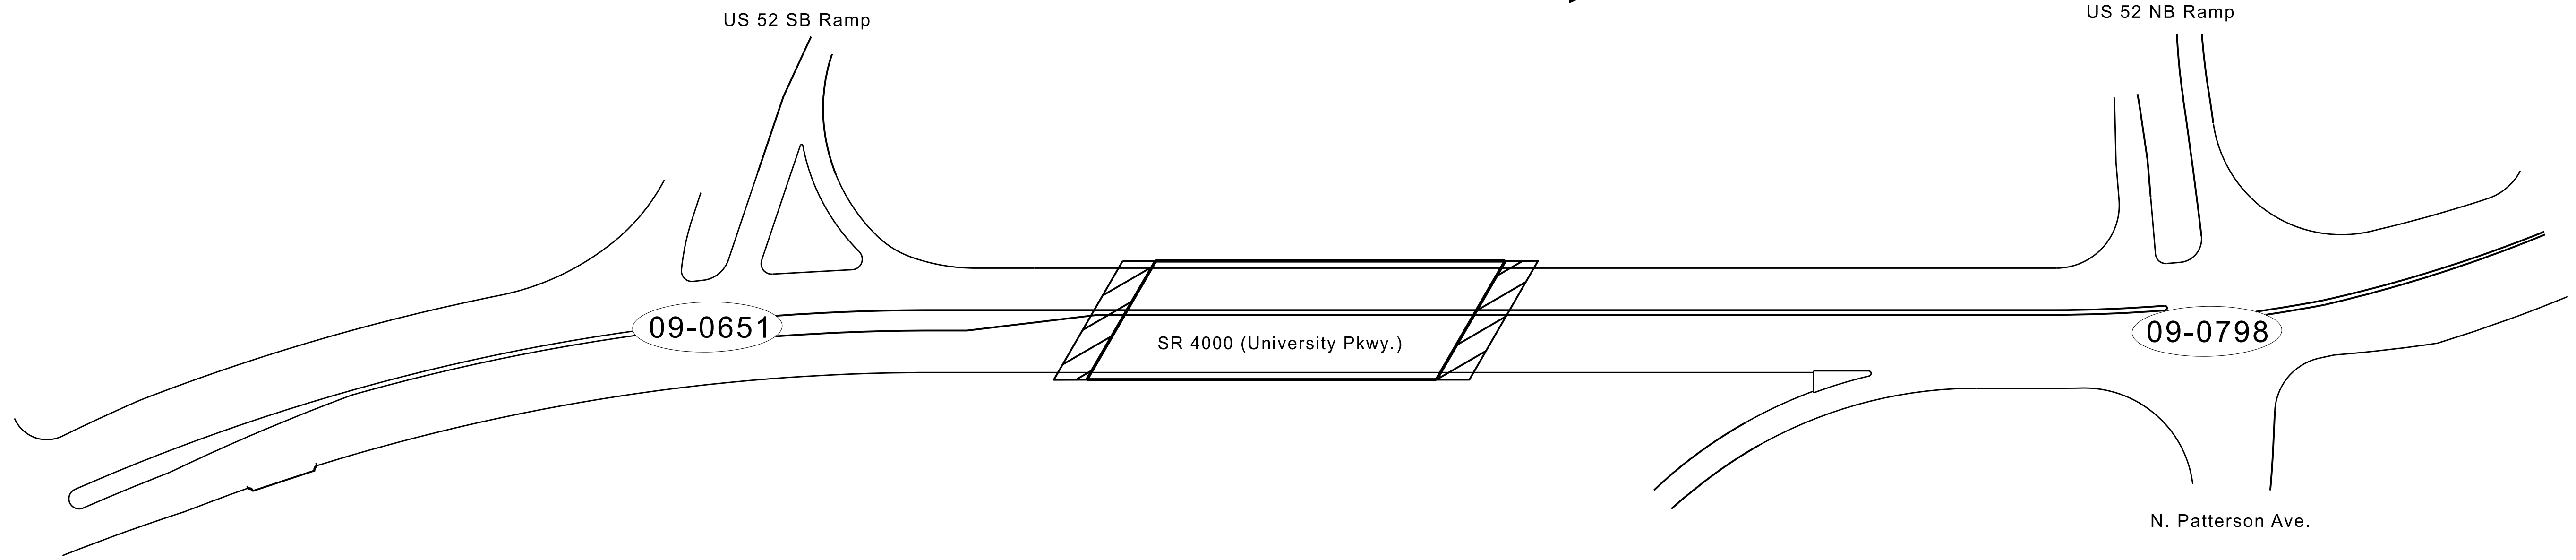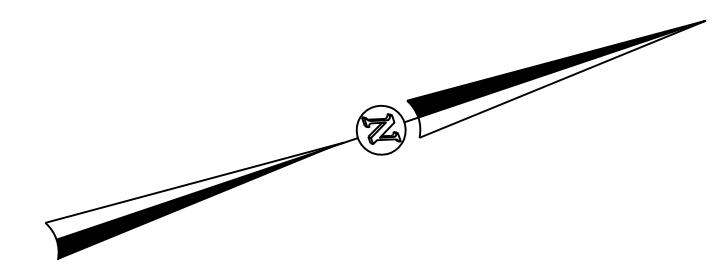

Refer to "Roadway Standard Drawings NCDOT" dated January 2024 and "Standard Specifications for Roads and Structures" dated January 2024.

Sheet #	Reference #	Index of Plans	Location/Description
Sig. 1.0	-----	Title Sheet	
Sig. 2.0-4.6	09-0651	SR 4000 (University Parkway) at US 52 SB Ramps	
Sig. 5.0-7.5	09-0798	SR 4000 (University Parkway) at US 52 NB Ramps	
M1A-M9	-----	Standard Metal Pole Sheets	
SCP 1-7	-----	Signal Communication Plans	

**TRANSPORTATION SYSTEMS
MANAGEMENT & OPERATIONS**

Contacts:

Robert J. Ziembra, PE - Central Region Signals Engineer
 Darrin T. Joyce, PE - Signal Equipment Design Engineer
 Ryan W. Hough, PE - Intelligent Transportation Systems Engineer

Prepared in the Office of:
 DIVISION OF HIGHWAYS
 TRANSPORTATION MOBILITY & SAFETY DIVISION

TSMO Unit
 750 N. Greenfield Pkwy, Garner, NC 27529

I:\FEB_2025_14_10
 S:\T&S\UNITS\Signal Design\Central Region\Div 9\BR-0168\BR-0168_sig_1sh_2026mmadd.dgn
 jabbt