



USE FOR LIGHTING CONSTRUCTION ONLY

METRIC

SCALE

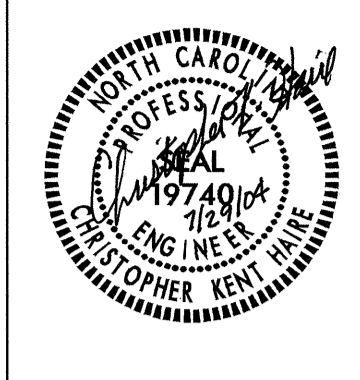

SEE SHEET "E1" FOR LEGEND & Δ NOTES

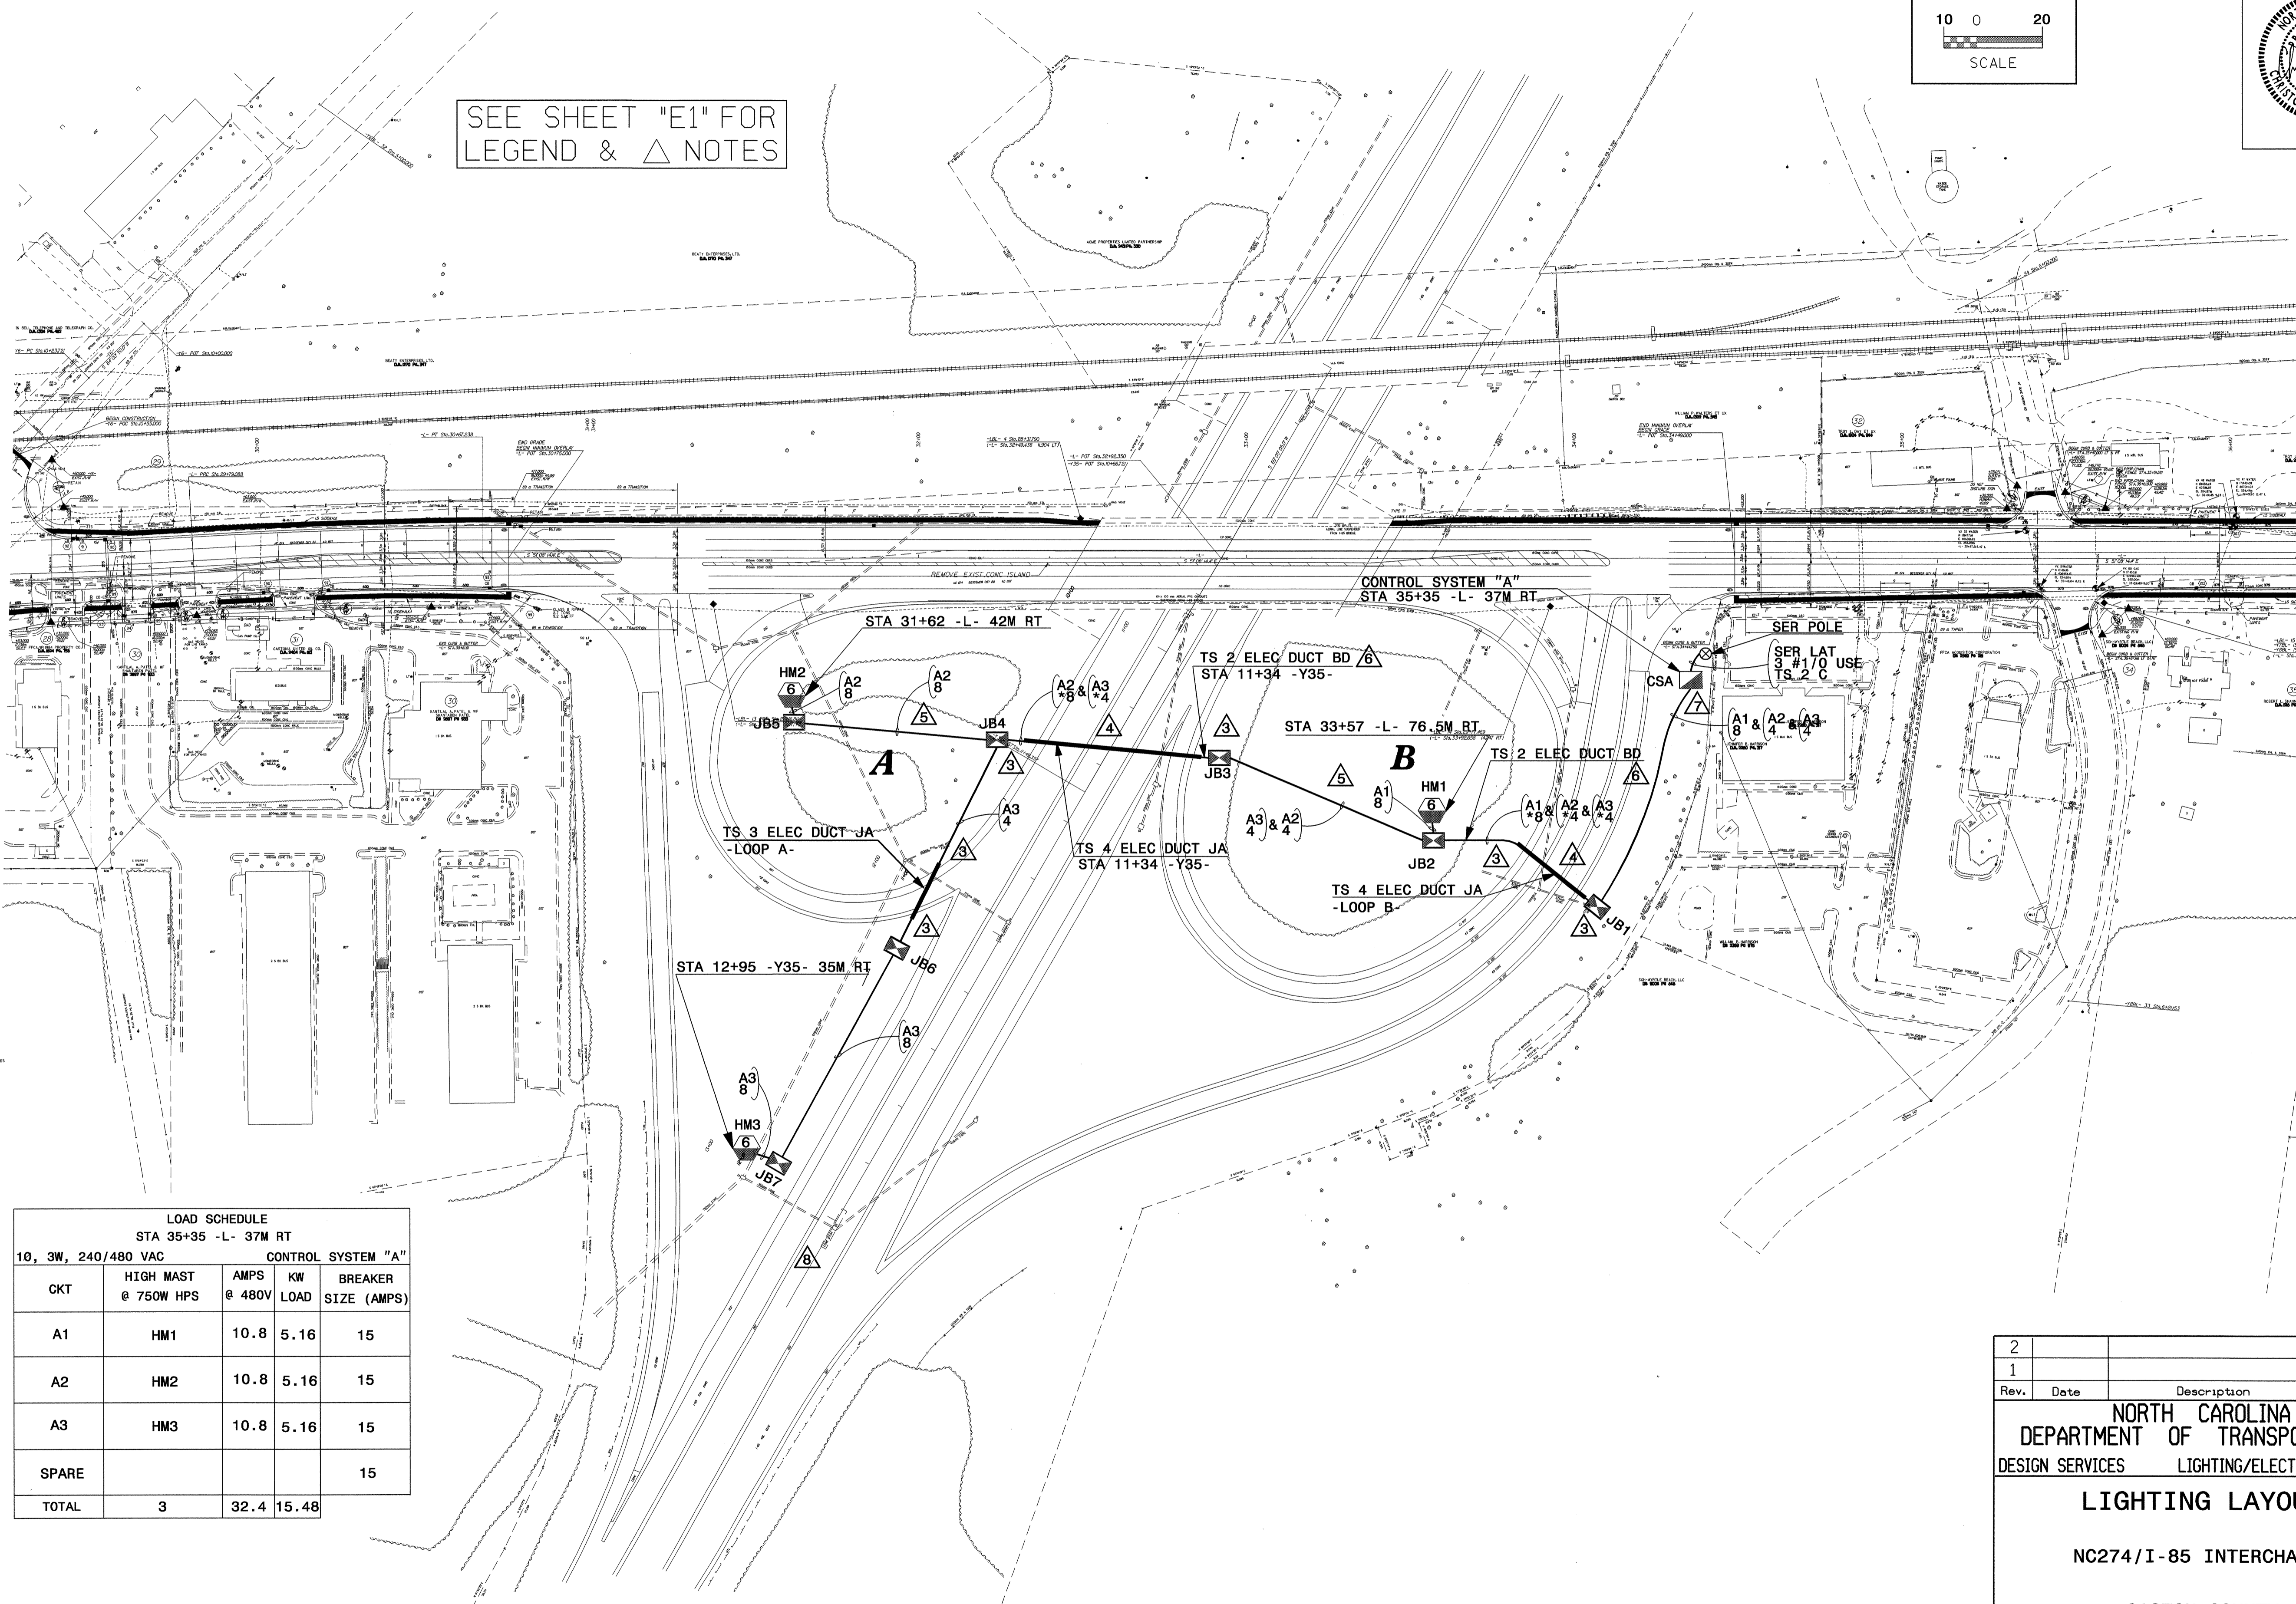

LOAD SCHEDULE
STA 35+35 -L- 37M RT
CONTROL SYSTEM "A"

CKT	HIGH MAST @ 750W HPS	AMPS @ 480V	KW LOAD	BREAKER SIZE (AMPS)
A1	HM1	10.8	5.16	15
A2	HM2	10.8	5.16	15
A3	HM3	10.8	5.16	15
SPARE				15
TOTAL	3	32.4	15.48	

2			
1			
Rev.	Date	Description	Approved
NORTH CAROLINA DEPARTMENT OF TRANSPORTATION DESIGN SERVICES LIGHTING/ELECTRICAL SECTION LIGHTING LAYOUT NC274/I-85 INTERCHANGE GASTON COUNTY			
Drawn By:	Approved By:	Dwg No.:	
RGH			