


STATE OF NORTH CAROLINA  
DIVISION OF HIGHWAYS


**UTILITY CONSTRUCTION PLANS  
CABARRUS COUNTY**

**LOCATION: BRIDGE 176 OVER REEDY CREEK  
ON SR 1136**

**TYPE OF WORK: WATER AND SEWER LINE RELOCATIONS**

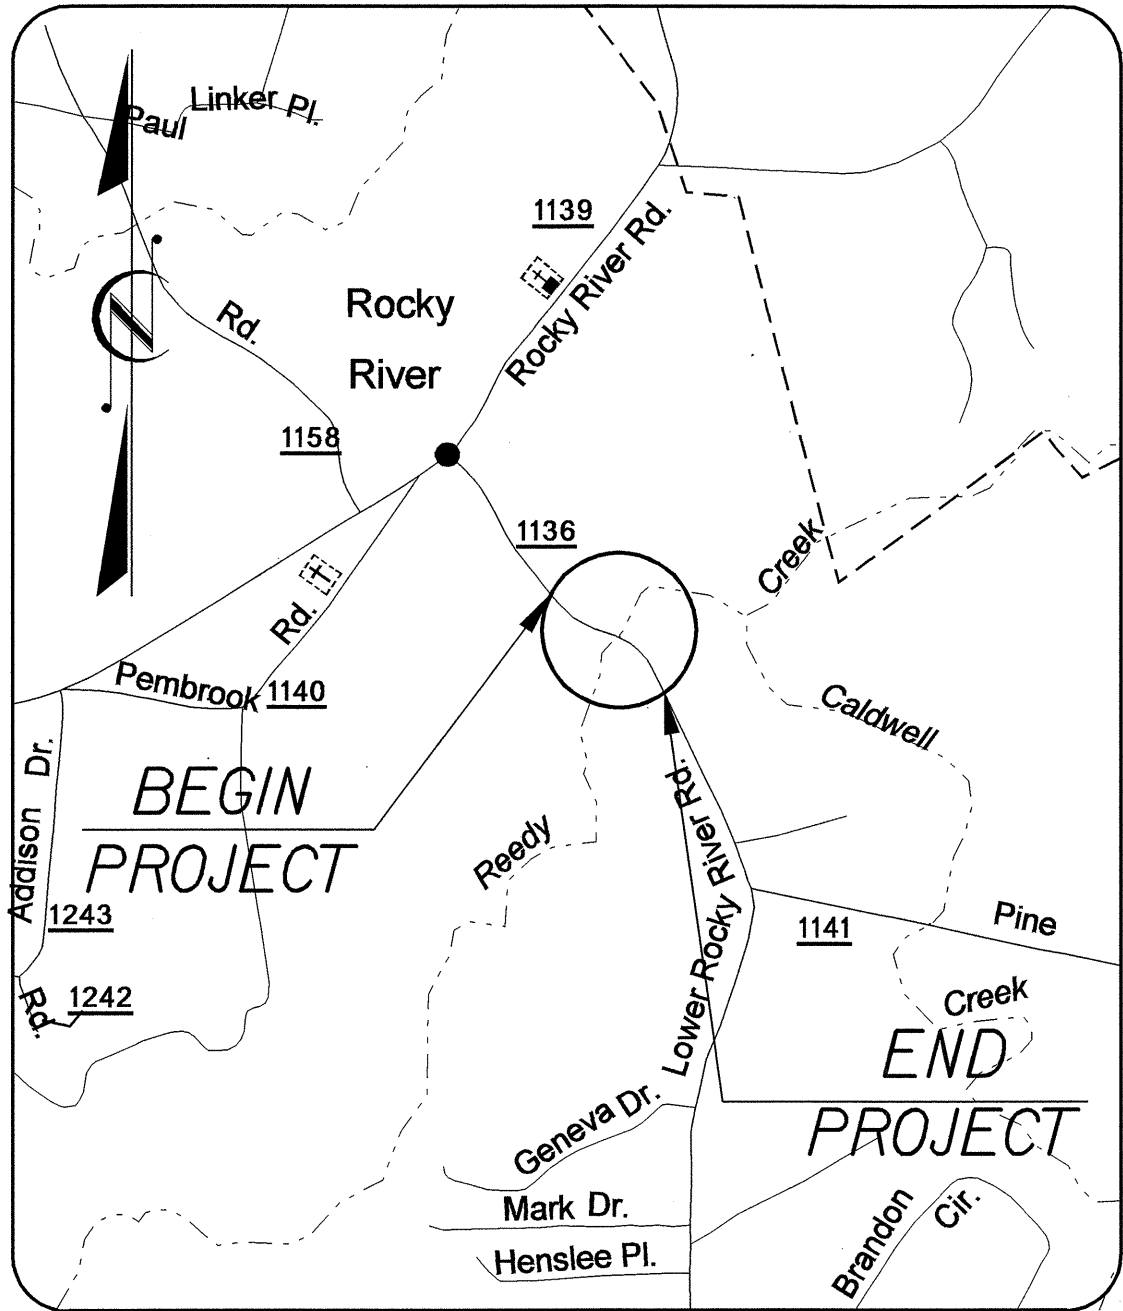

VICINITY MAP

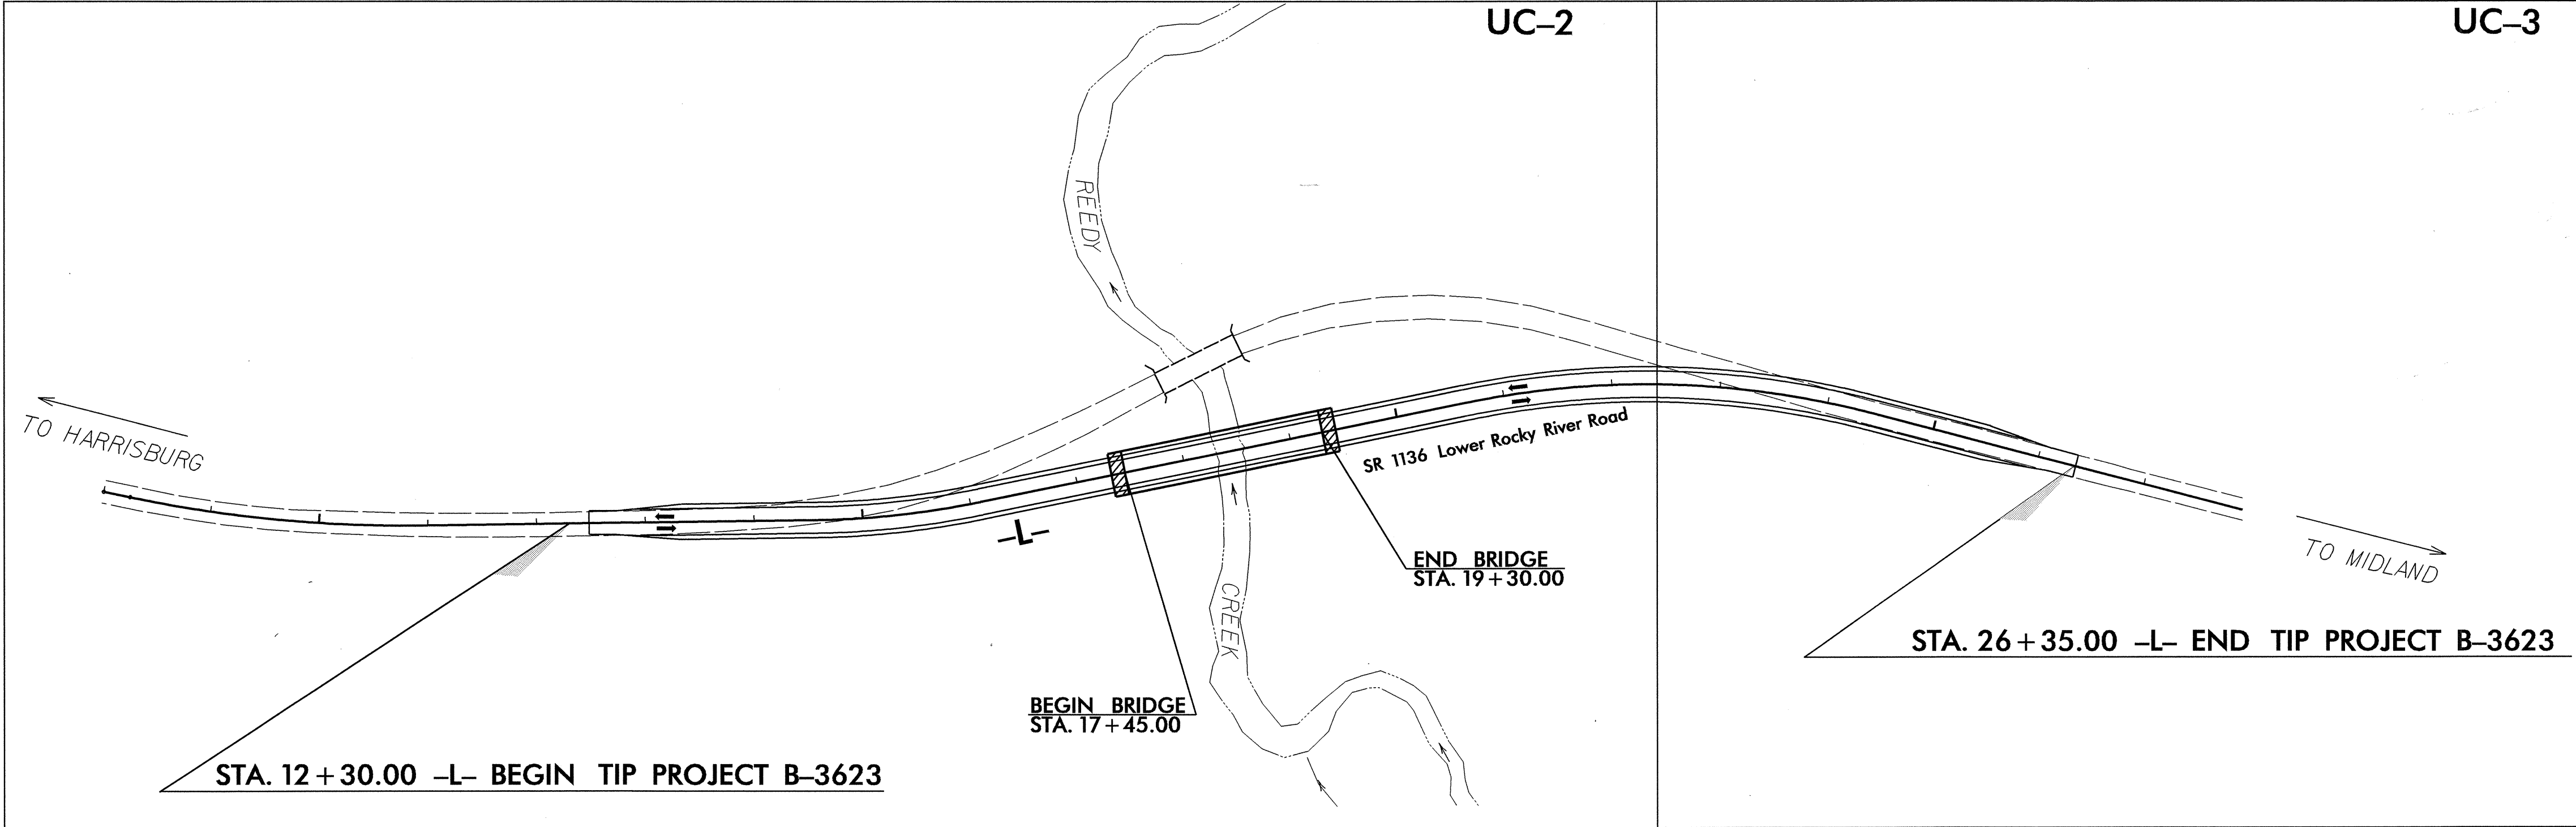

TIP: B-3623



2002 STANDARD SPECIFICATIONS  
FOR ROADWAYS AND  
STRUCTURES

INDEX OF SHEETS	
SHEET NO.	DESCRIPTION
UC-1	TITLE SHEET
UC-2 AND UC-3	UTILITY CONSTRUCTION PLAN AND PROFILE SHEETS
UC-4	DETAIL SHEET

**WATER AND SEWER OWNERS ON PROJECT**

(1) CITY OF CONCORD

SEAL

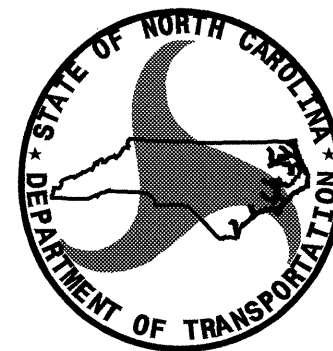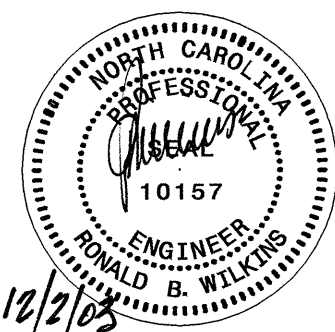

PREPARED IN THE OFFICE OF:  
**DIVISION OF HIGHWAYS  
DESIGN SERVICES  
UTILITY SECTION**  
1591 MAIL SERVICES CENTER  
RALEIGH NC 27699-1591  
PHONE (919) 250-4128  
FAX (919) 250-4119

R. G. WORTHINGTON, PE	UTILITIES SECTION ENGINEER
R. B. WILKINS, PE	UTILITIES SQUAD LEADER PROJECT ENGINEER
V. MOUA	UTILITIES PROJECT DESIGNER