

8/17/99

PAVEMENT MARKING SCHEDULE

PAVEMENT MARKING LINES


- AA - THERMOPLASTIC (4" WHITE, 120 MILS) 4" X 10' SKIP
- AB - THERMOPLASTIC (4" WHITE, 120 MILS) 4" X 2' MINI SKIP
- AD - THERMOPLASTIC (8" YELLOW, 90 MILS) DIAGONAL
- AE - THERMOPLASTIC (4" WHITE, 120 MILS) SOLID LANE LINE
- AF - THERMOPLASTIC (24" WHITE, 120 MILS) STOP BAR
- AG - THERMOPLASTIC (4" YELLOW, 120 MILS) DOUBLE CENTER LINE
- AH - THERMOPLASTIC (4" YELLOW, 120 MILS) SINGLE CENTER LINE
- AI - THERMOPLASTIC (4" YELLOW, 120 MILS) 4" X 10' SKIP


PAVEMENT MARKING SYMBOLS

- BA - THERMOPLASTIC (LEFT TURN ARROW, 90 MILS)
- BB - THERMOPLASTIC (RIGHT TURN ARROW, 90 MILS)
- BC - THERMOPLASTIC (STRAIGHT ARROW, 90 MILS)
- BD - THERMOPLASTIC (COMBINATION STRAIGHT & RIGHT TURN ARROW, 90 MILS)
- BE - THERMOPLASTIC (ONLY, 120 MILS)

NOTE

PAINT MARKINGS AND TRAFFIC CONTROL DEVICES SHALL BE IN ACCORDANCE WITH NCDOT STANDARD SPECIFICATIONS FOR ROADS AND STRUCTURES, NCDOT ROADWAY STANDARD DRAWINGS, AND THE CURRENT EDITION OF THE MANUAL OF UNIFORM TRAFFIC CONTROL DEVICES (MUTCD). QUANTITIES FOR THESE ITEMS HAVE BEEN ACCOUNTED FOR IN THE CONTRACT BID FORM.

PROJECT REFERENCE NO. U-4737	SHEET NO. PM-1
RW SHEET NO.	
ROADWAY DESIGN ENGINEER	HYDRAULICS ENGINEER
	
3/21/05	

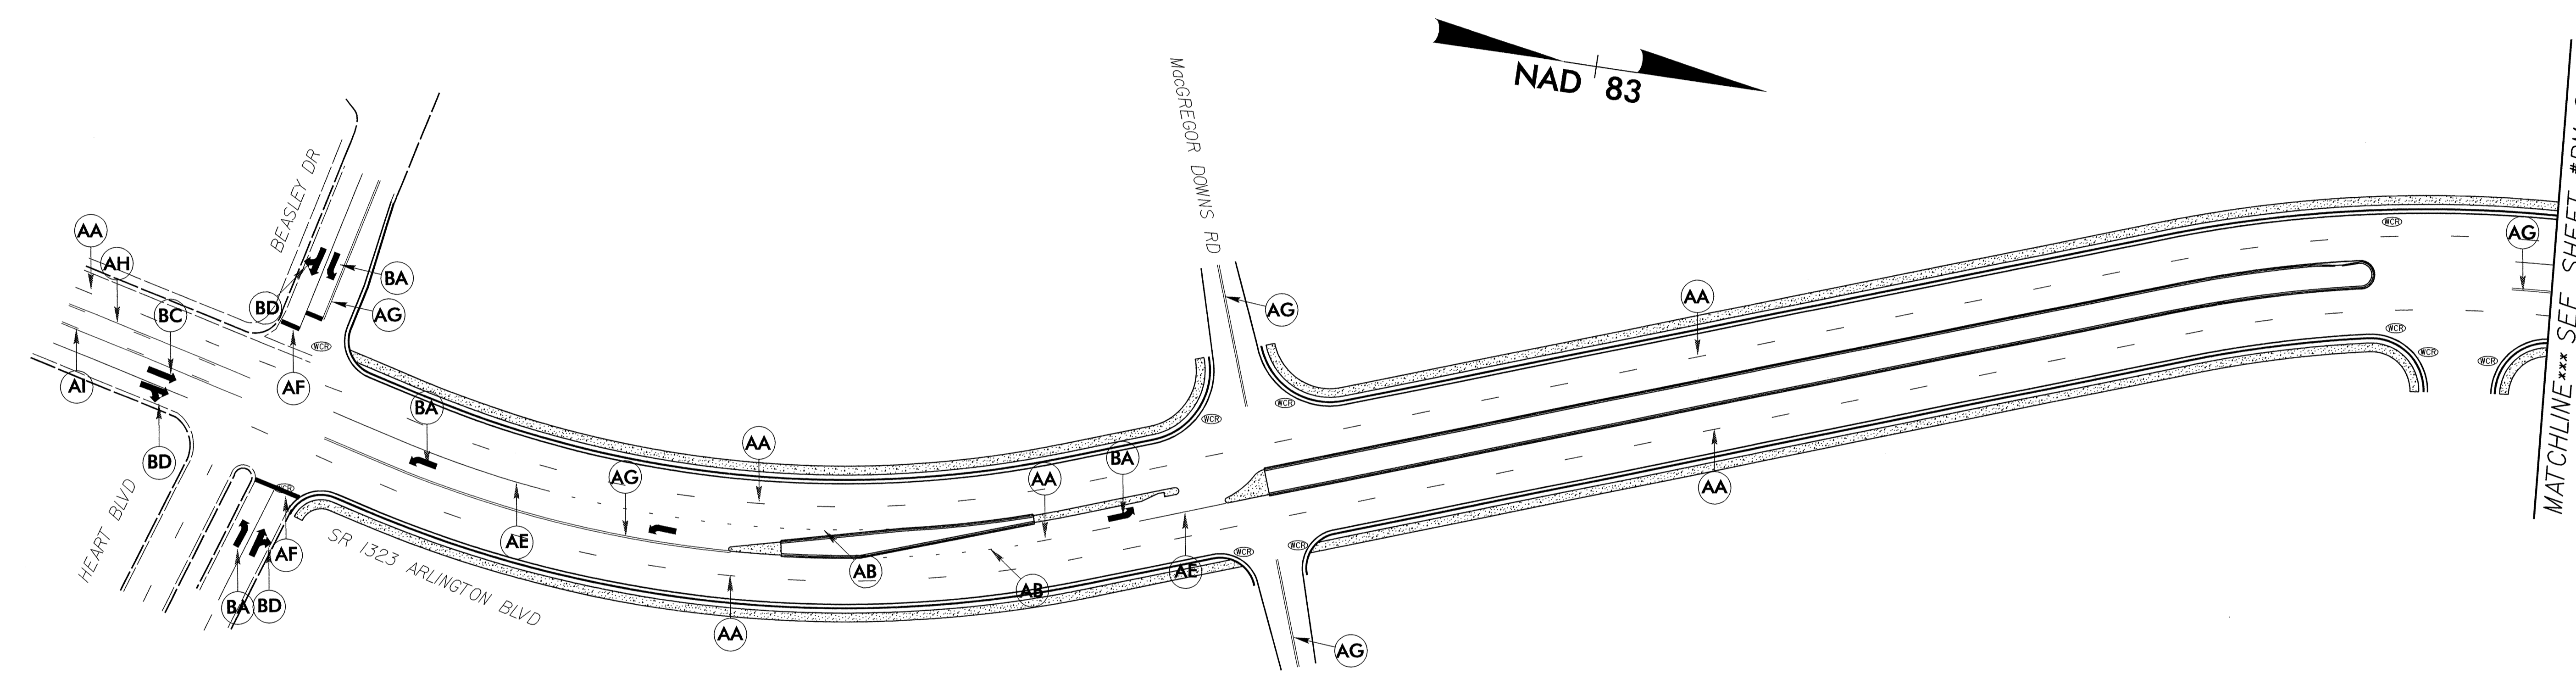

REVISIONS

22-MAR-2005 13:16
 D:\DDC\PROJECTS\PITT\ARLINGTON BLVD\Arlington with left turn\arlington-ddc2-pmi.dgn
 Jackson