
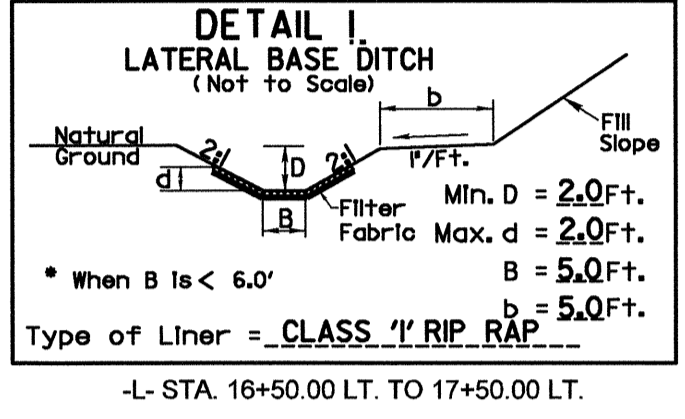


8/17/99

W WETHERILL ENGINEERING
 559 Jones Franklin Rd. Suite 164
 Raleigh, N.C. 27606
 Bus: 919 851 8077
 Fax: 919 851 8107

TRANSPORTATION PLANNING/DESIGN - BRIDGE/STRUCTURE DESIGN
 CIVIL/SITE DESIGN - GIS/GPS - CONSTRUCTION OBSERVATION

| | |
|--|--|
| PROJECT REFERENCE NO. MA05001B | SHEET NO. 3 |
| RW SHEET NO. | |
| ROADWAY DESIGN ENGINEER EDWARD G. WETHERILL 10773 12/21/05 | HYDRAULICS ENGINEER HENRY WELLS 11/1/06 |

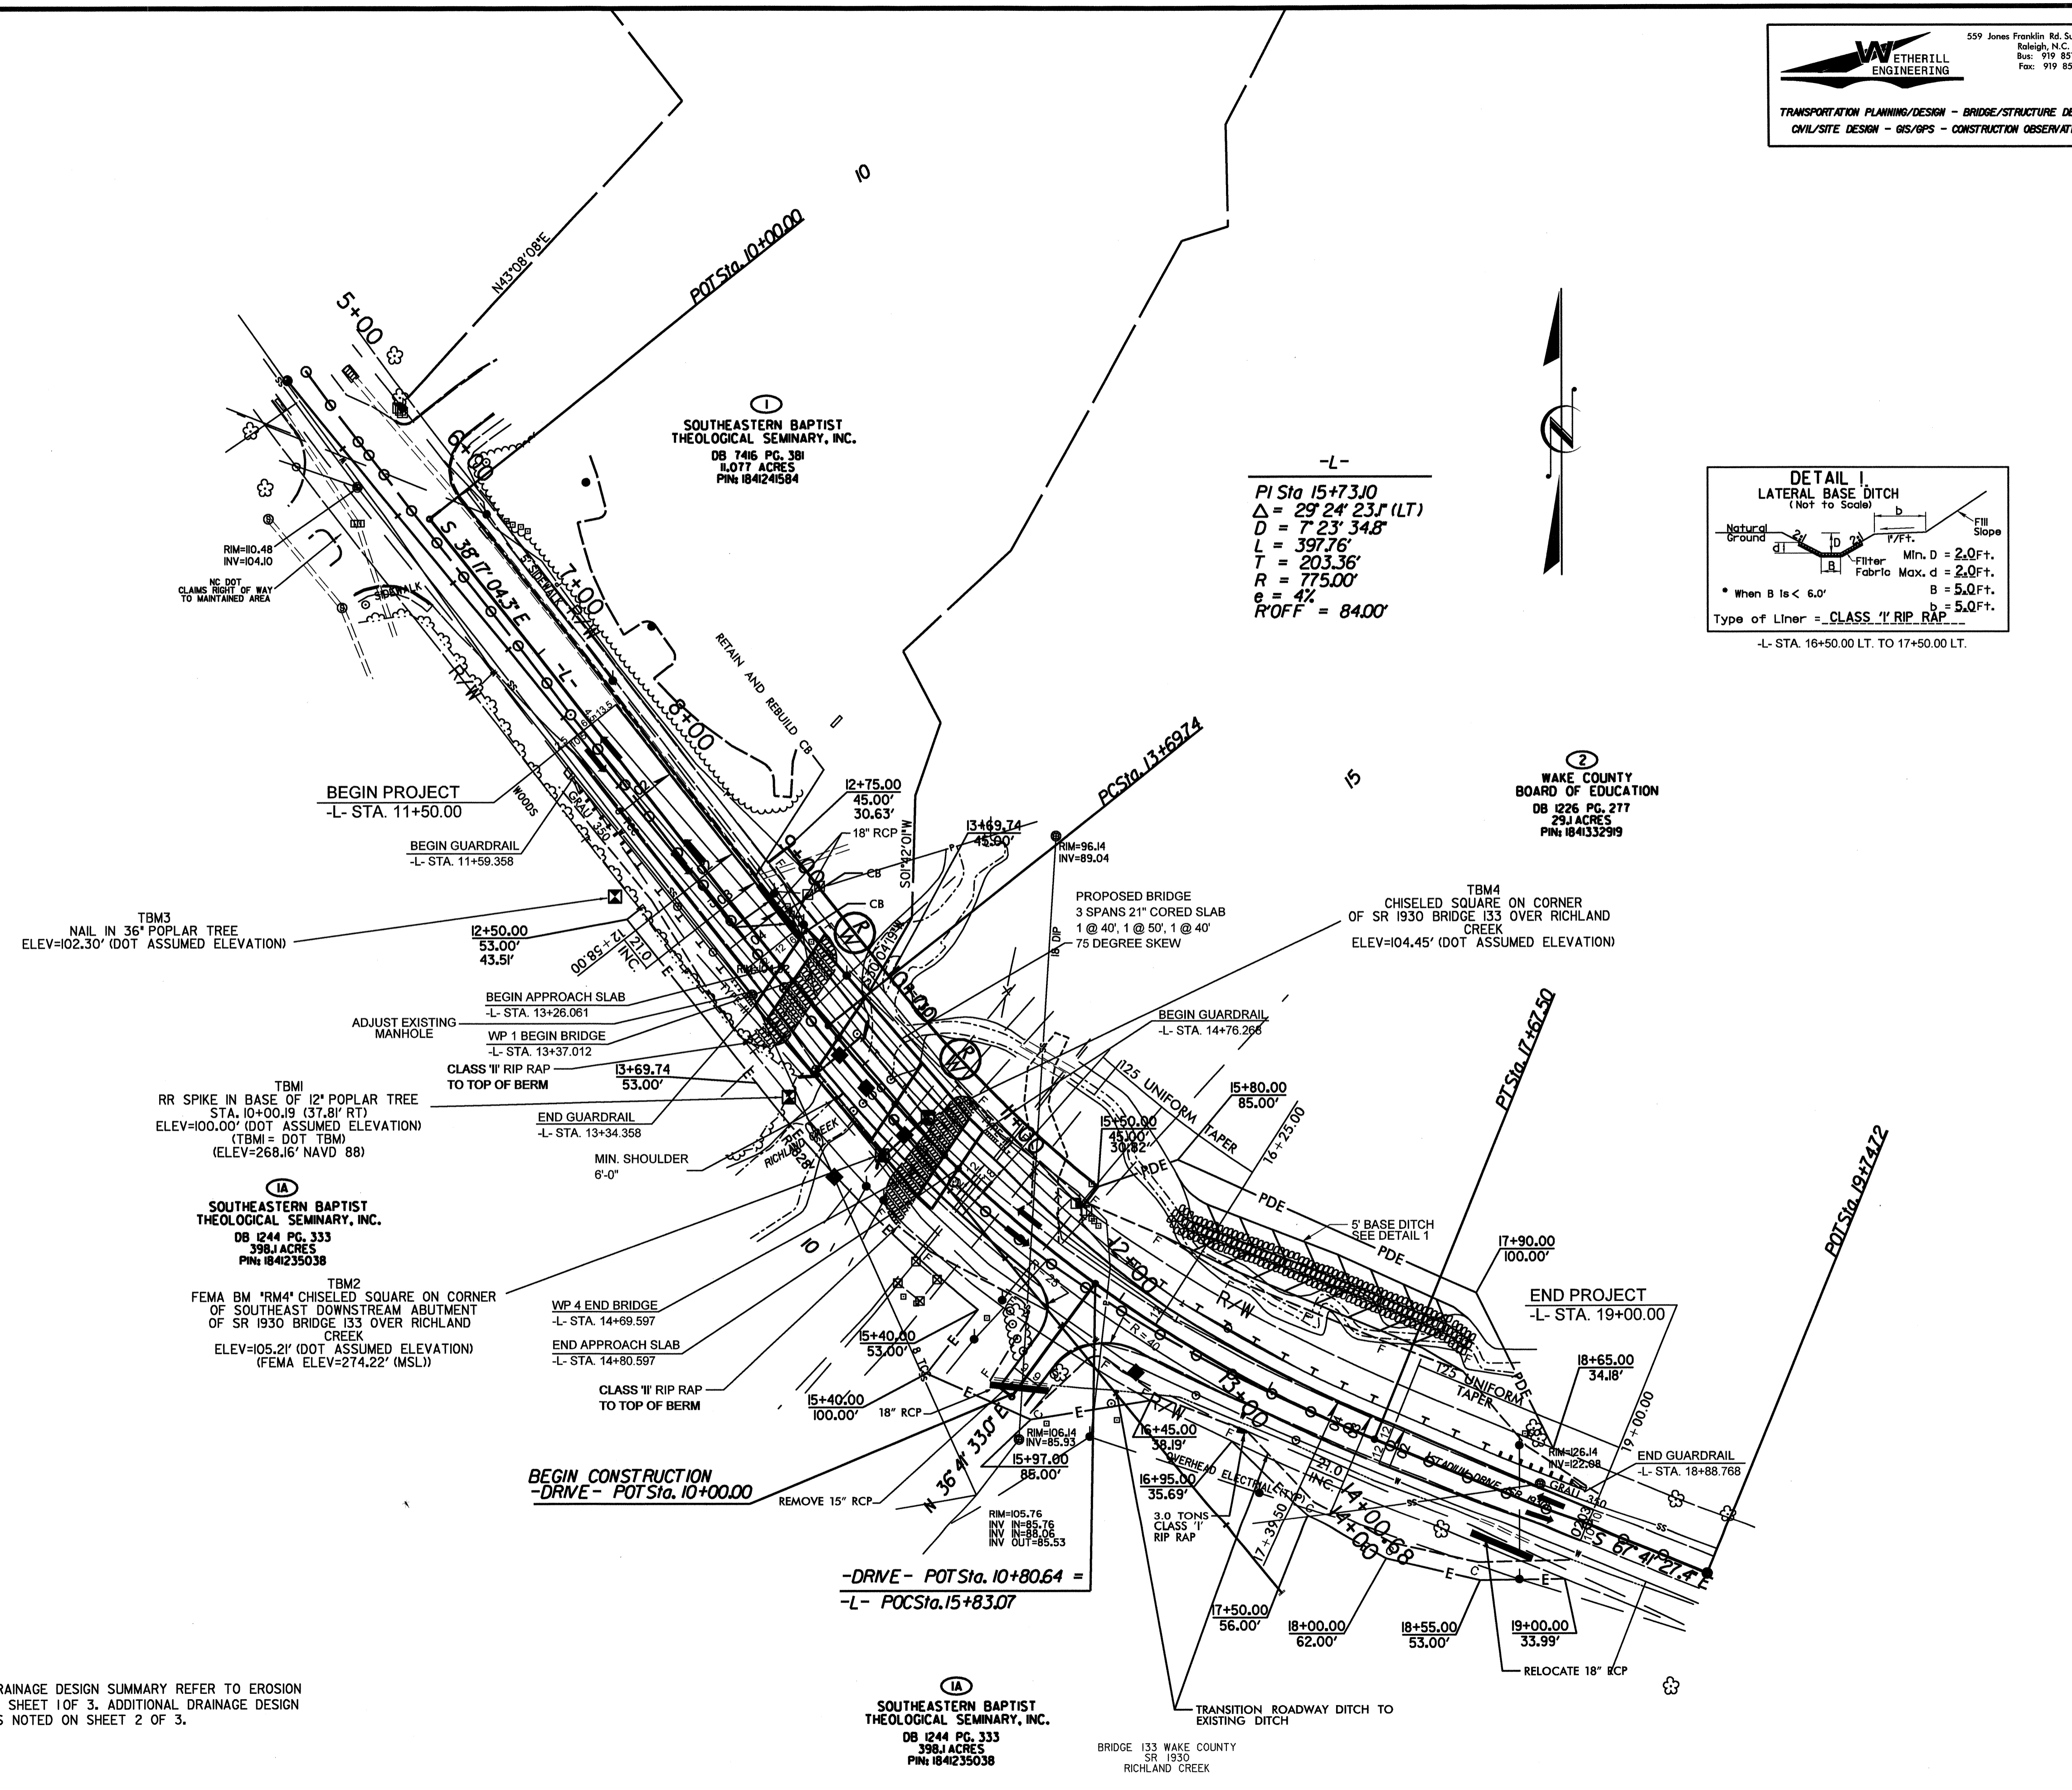

NOTE:
 FOR STORM DRAINAGE DESIGN SUMMARY REFER TO EROSION CONTROL PLAN SHEET 10P 3. ADDITIONAL DRAINAGE DESIGN INFORMATION IS NOTED ON SHEET 2 OF 3.

SEE SHEET 4 FOR PROFILE

2/21/06 1:28 PM
 P:\ASSTEN\MA05001B\Roadway\Pro\133_rdy_FSH4.dgn