 







8/23/99



PROJ. REFERENCE NO.  
31339, 37969, 37977

SHEET NO.  
X-6

150 140 130 120 110 100 90 80 70 60 50 40 30 20 10 0 10 20 30 40 50 60 70 80 90 100 110 120 130 140 150

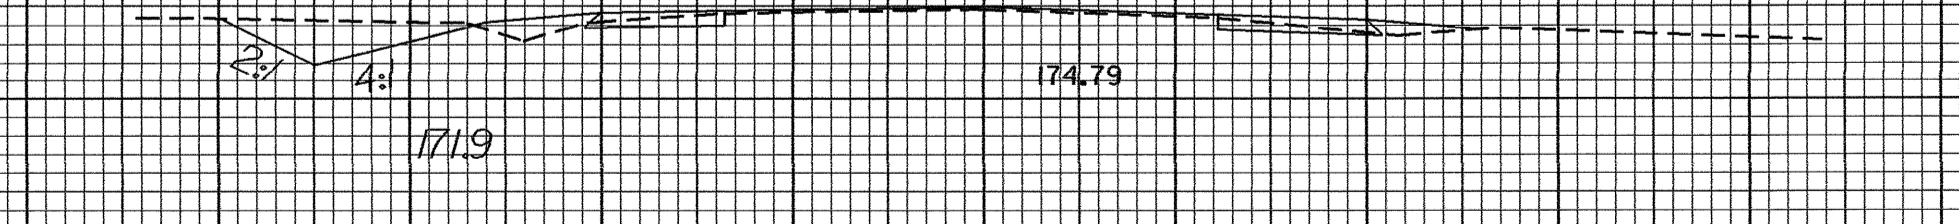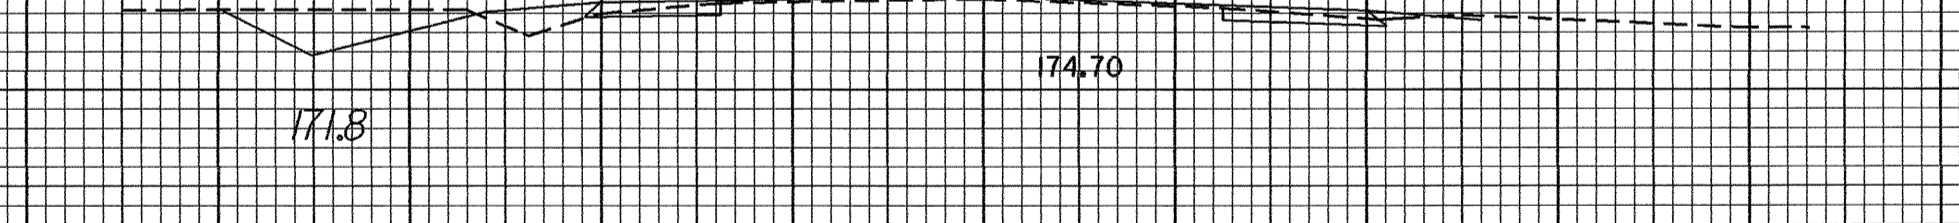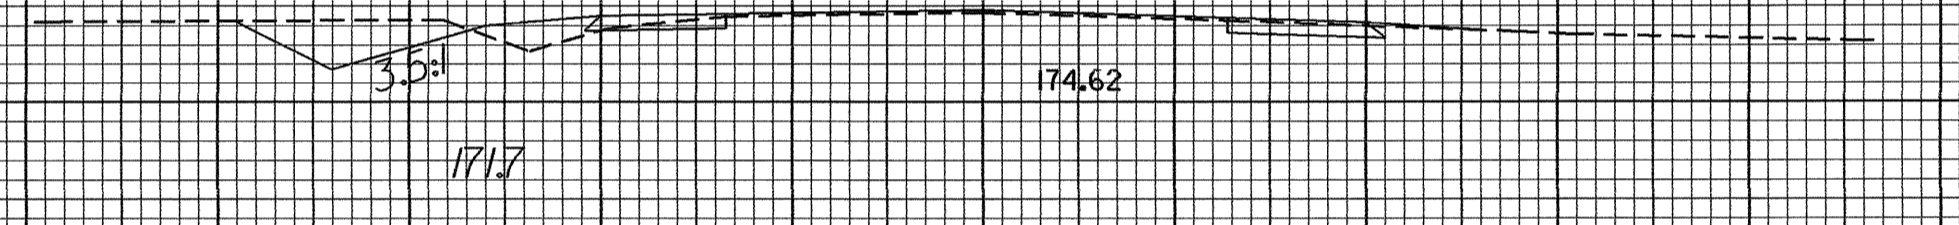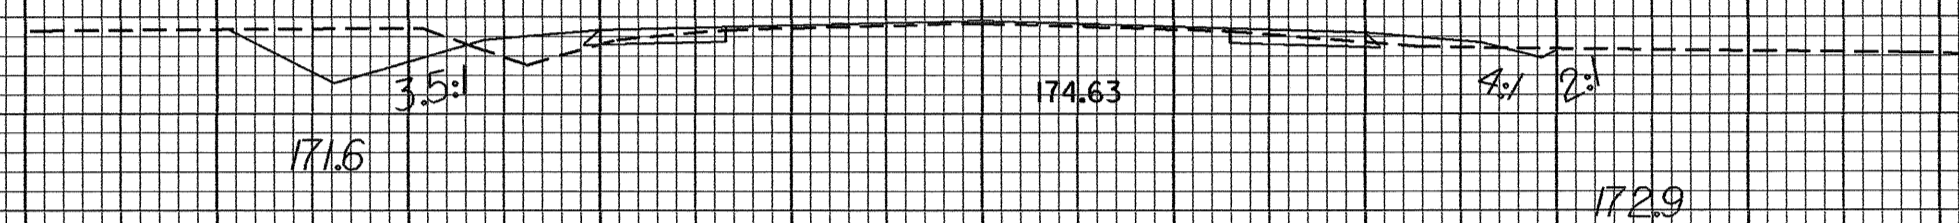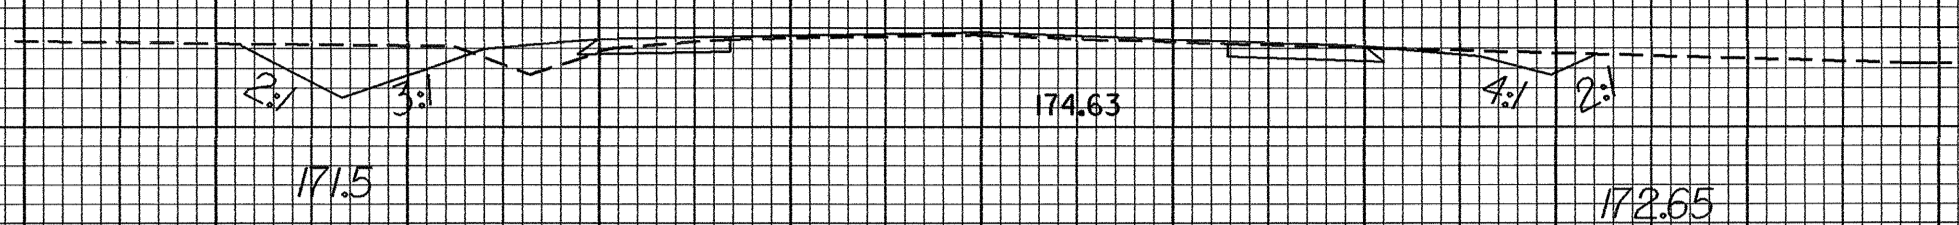

37977 SR 2252/1300 CHICKENFOOT RD

150 140 130 120 110 100 90 80 70 60 50 40 30 20 10 0 10 20 30 40 50 60 70 80 90 100 110 120 130 140 150

21-NOV-2005 08:51 D:\DDC\PROJECT\ES\Drawings\complete\37977 Chickenfoot Rd from 95 to nc20\Chickenfoot Road\06N\sect chick\_xpl.dgn