


8/23/99



PROJ. REFERENCE NO.  
31339, 37969, 37977


SHEET NO.  
X-3

150 140 130 120 110 100 90 80 70 60 50 40 30 20 10 0 10 20 30 40 50 60 70 80 90 100 110 120 130 140 150

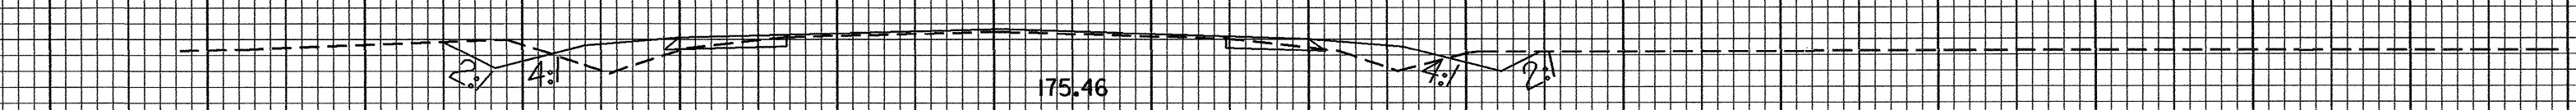

173.2 175.46 173.0

 16+00.00



173.3 175.68 173.1

15+50.00



 
173.4 175.68 173.2

15+00.00



173.5 175.68 173.3

14+50.00



173.6 175.75 173.45

14+00.00

37977 SR 2252/1300 CHICKENFOOT RD

150 140 130 120 110 100 90 80 70 60 50 40 30 20 10 0 10 20 30 40 50 60 70 80 90 100 110 120 130 140 150

21-NOV-2005 08:50 D:\DDC\PROJECTS\37977\37977 Chickenfoot Rd from 95 to nc20\Chickenfoot Road\06N\sheet chick\_xpl.dgn