


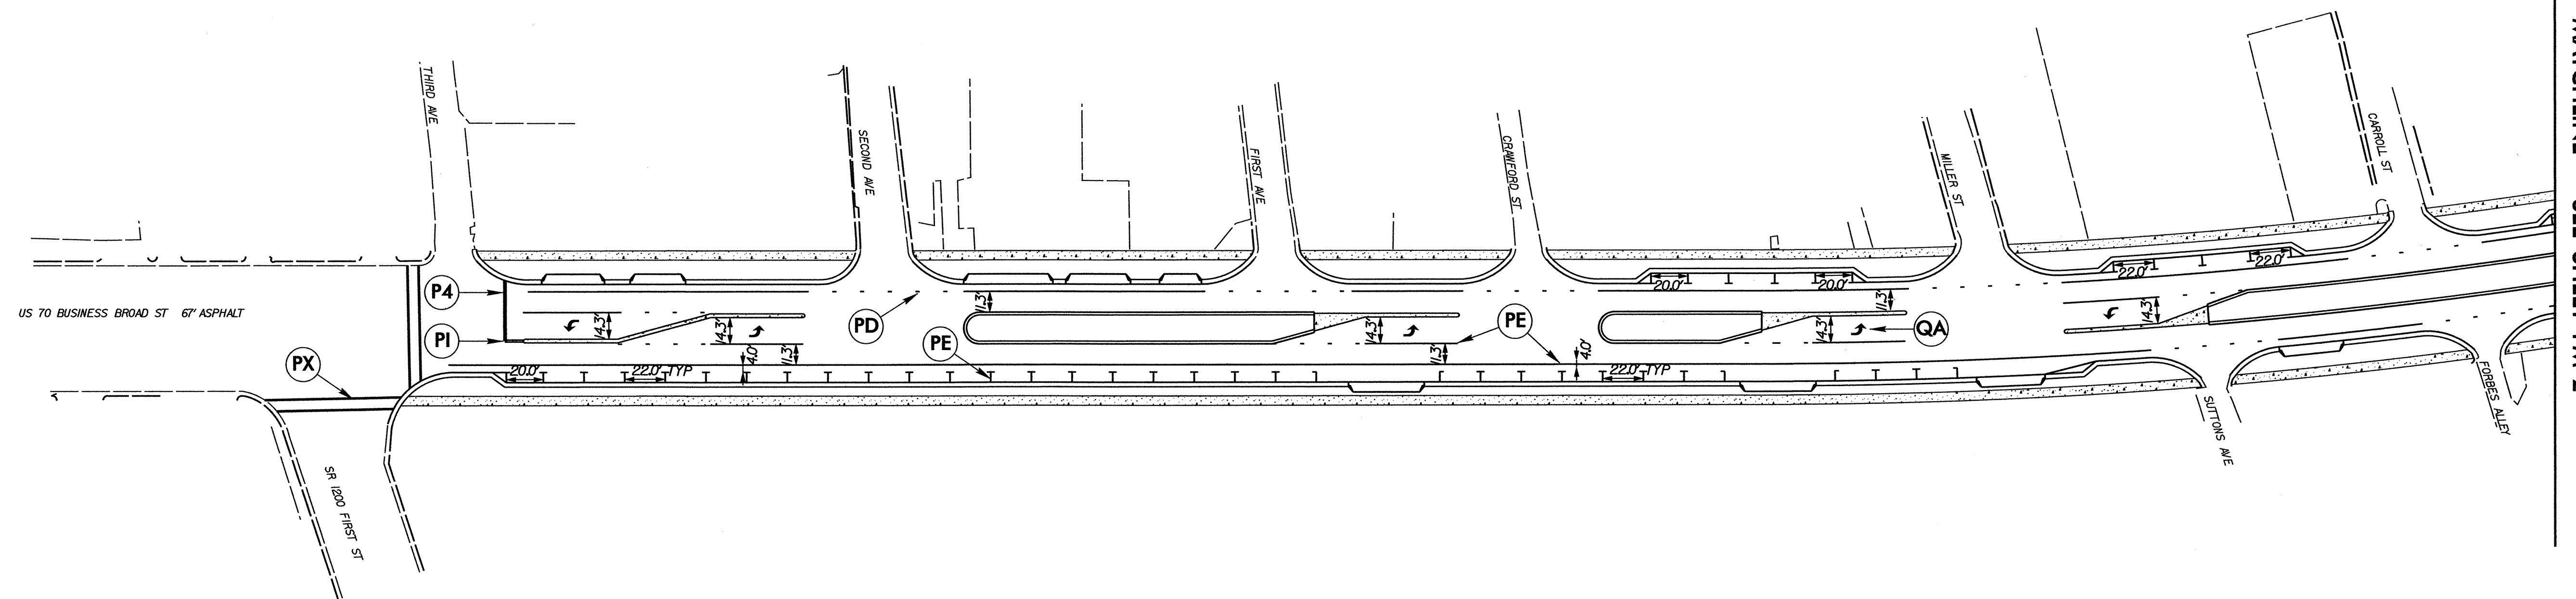
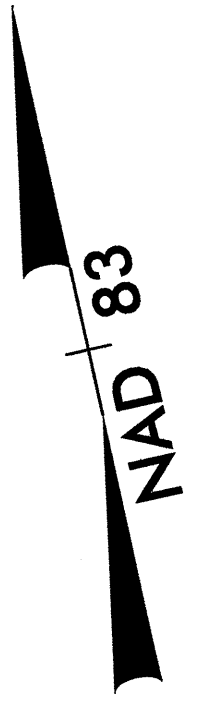
FINAL PAVEMENT MARKING SCHEDULE

SYMBOL	DESCRIPTION	PAY ITEM QUANTITY BREAKDOWN		TOTAL QUANTITY		
		QUANTITY	UNIT	QUANTITY	UNIT	
		PAINT (4")				
PA	WHITE EDGELINE (2X)	25658	LF			
PD	2 FT. WHITE MINISKIP (2X)	889	LF			
PI	YELLOW DOUBLE CENTER (2X)	208	LF			
				TOTAL	26755 LF	
		PAINT (8")				
PR	WHITE GORELINE (2X)	320	LF			
PS	WHITE DIAGONAL (2X)	370	LF			
PX	WHITE CROSSWALK LINE (2X)	4716	LF			
				TOTAL	5406 LF	
		PAINT (24")				
P4	WHITE STOPBAR (2X)	626	LF			
				TOTAL	626 LF	
		PAINT MARKING SYMBOLS				
QA	LEFT TURN ARROW (2X)	42	EA			
QE	COMBO. STRAIGHT/RIGHT (2X)	4	EA			
				TOTAL	46 EA	

04-APR-2008 16:12
 \\vd2-240855\ddc\projects\ncrgven\brood street\copy of broadst-ddc2-psh-pm-1.dgn
 jaronbullard AT DECAD22477

APPROVED: <i>J. Bullard</i> DATE: 4/4/08	FINAL PAVEMENT MARKING PLANS	
	SCALE: NONE	REVISIONS
	DATE: 03/08	
	DWG. BY: WCB	
	DESIGN BY: WCB	
REVIEWED BY: JAB		



PROJ. REFERENCE NO.	SHEET NO.
U-4755	PM-2



MATCHLINE ***SEE SHEET PM-2***

04-APR-2008 16:20
 g:\projects\coraven\broad_street\broadst.dwg2_psh_pm.lldgn
 idr\onbulldr AT D2CAD22417


APPROVED: <i>J. Bull</i> DATE: 4/1/08		FINAL PAVEMENT MARKING PLANS	
		DATE: 03/08	
DWG. BY: WCB			
DESIGN BY: WCB			
REVIEWED BY: JAB			

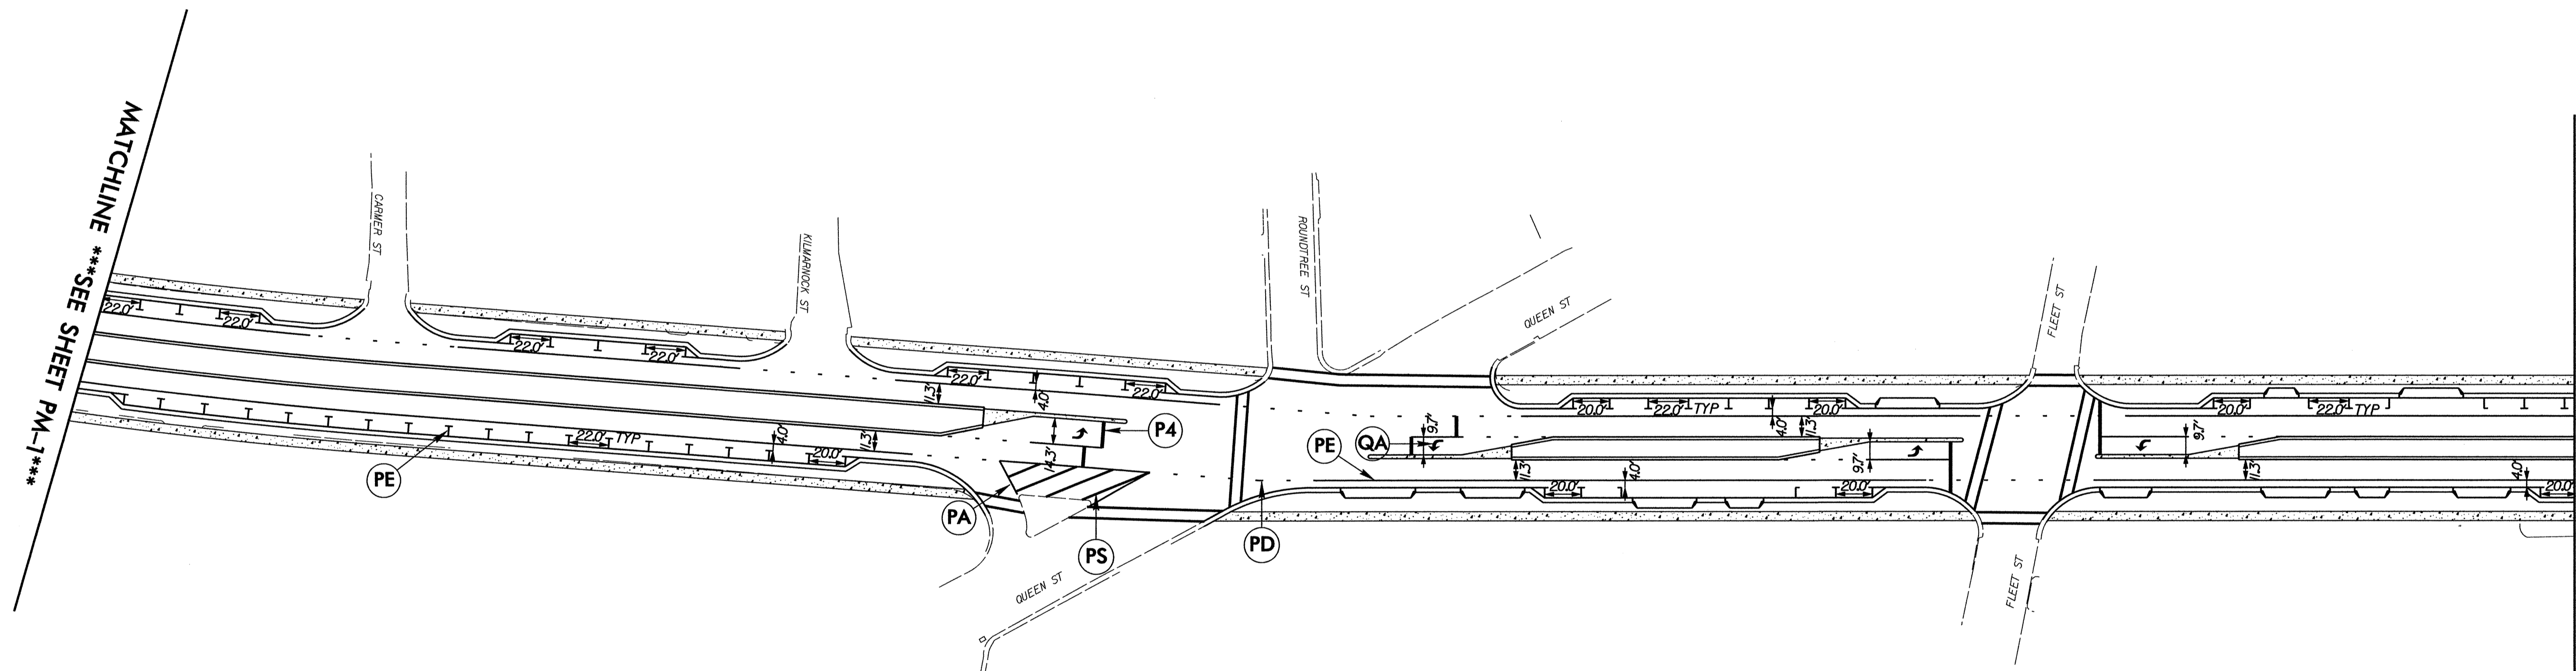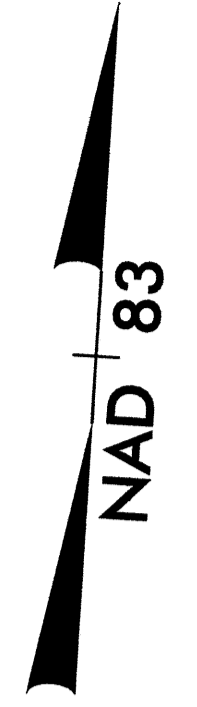


MATCHLINE ***SEE SHEET PM-1***

MATCHLINE ***SEE SHEET PM-3***


04-APR-2008 16:33
 g:\projects\oroven\broad_street\broadst-ddo2_psh_pm_2.dgn
 jaronbullard AT D2CAD224171

APPROVED: <i>JAB</i> DATE: 4/4/08	FINAL PAVEMENT MARKING PLANS									
			SCALE: NONE	<table border="1"> <thead> <tr> <th colspan="2">REVISIONS</th> </tr> </thead> <tbody> <tr><td> </td><td> </td></tr> <tr><td> </td><td> </td></tr> <tr><td> </td><td> </td></tr> </tbody> </table>	REVISIONS					
REVISIONS										
	DATE: 03/08									
	DWG. BY: WCB									
	DESIGN BY: WCB									
	REVIEWED BY: JAB	CADD FILE								

PROJ. REFERENCE NO.	SHEET NO.
U-4755	PM-4

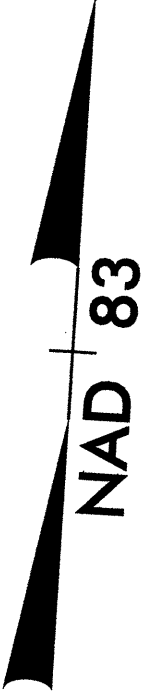

MATCHLINE ***SEE SHEET PM-2***


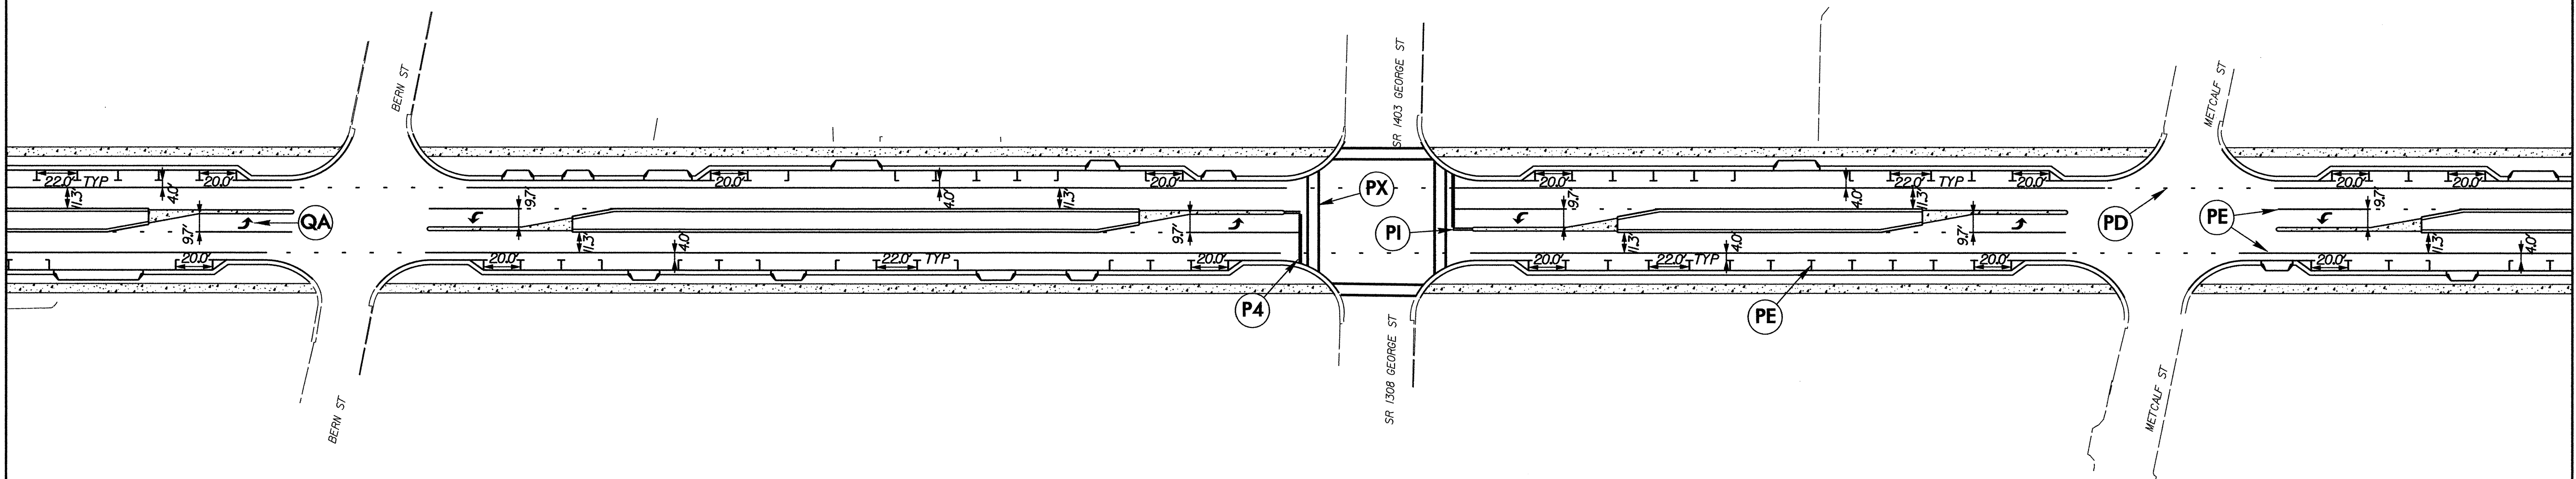


MATCHLINE ***SEE SHEET PM-4***


04-APR-2008 16:37
 g:\projects\oroven\brood_street\broodst-ddc2_psh_pm_3.dgn
 idcrnbulld At D2CAD21477

APPROVED: <i>J. Beard</i> DATE: 4/1/08		FINAL PAVEMENT MARKING PLANS								
	SCALE: NONE			<table border="1"> <tr> <th colspan="2">REVISIONS</th> </tr> <tr> <td> </td> <td> </td> </tr> <tr> <td> </td> <td> </td> </tr> <tr> <td> </td> <td> </td> </tr> </table>	REVISIONS					
	REVISIONS									
DATE: 03/08										
DWG. BY: WCB										
DESIGN BY: WCB										
REVIEWED BY: JAB										


PROJ. REFERENCE NO.	SHEET NO.
U-4755	PM-5

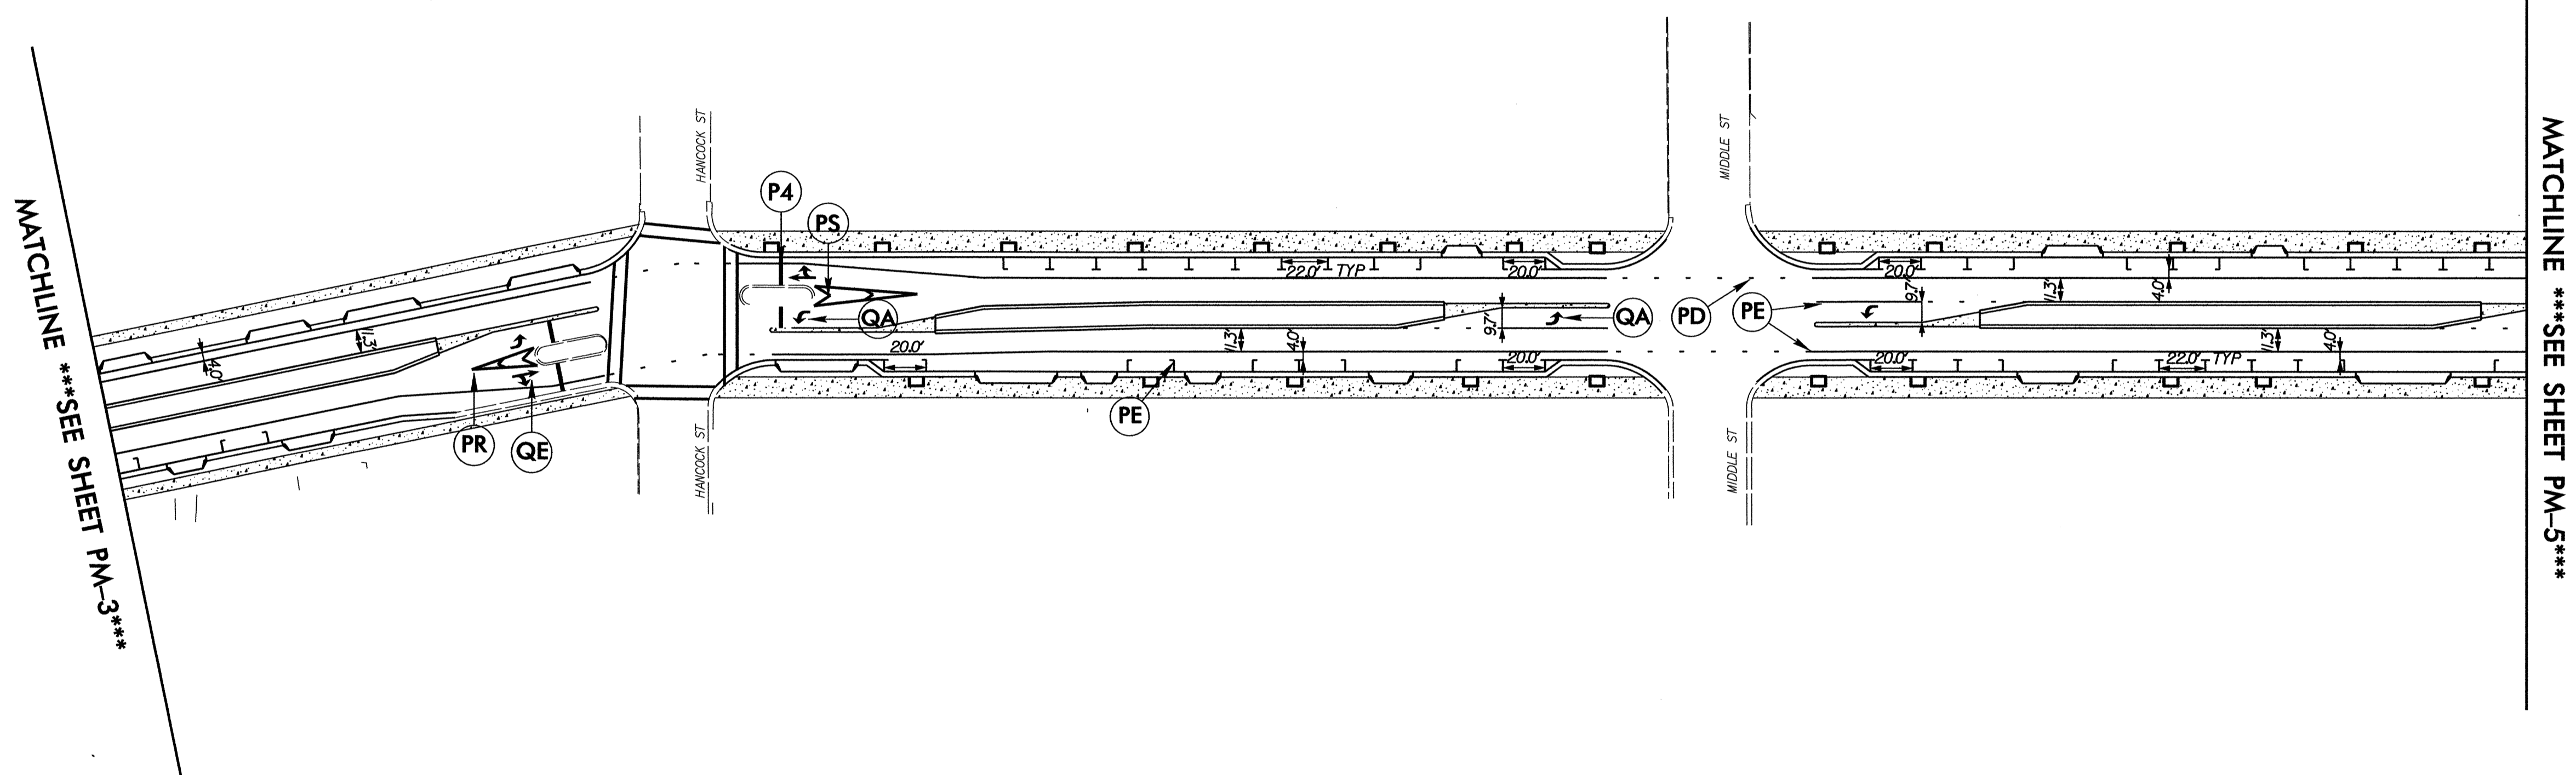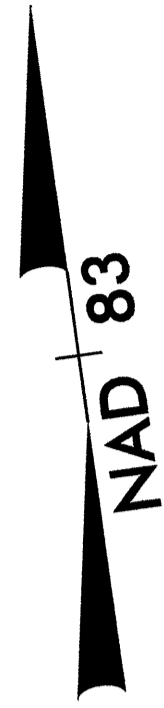


04-APR-2008 16:47
 g:\projects\crown\brood_street\broadst-ddc2-psh-pm_4.dgn
 jdar-onbuildr.d AT DEC022:477

APPROVED: <i>J. Bull</i> DATE: <i>1/1/08</i>		FINAL PAVEMENT MARKING PLANS									
SEAL 	SCALE: NONE			<table border="1"> <thead> <tr> <th colspan="2">REVISIONS</th> </tr> </thead> <tbody> <tr><td> </td><td> </td></tr> <tr><td> </td><td> </td></tr> <tr><td> </td><td> </td></tr> </tbody> </table>		REVISIONS					
	REVISIONS										
DATE: 03/08	CADD FILE										
DWG. BY: WCB											
DESIGN BY: WCB											
REVIEWED BY: JAB											

PROJ. REFERENCE NO.	SHEET NO.
U-4755	PM-6

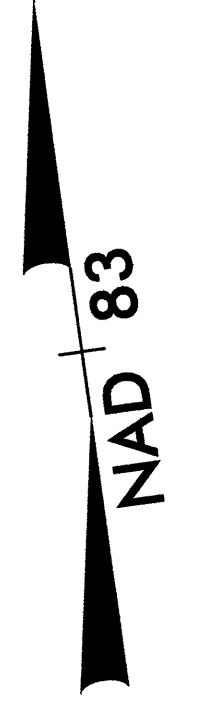

MATCHLINE ***SEE SHEET PM-4***

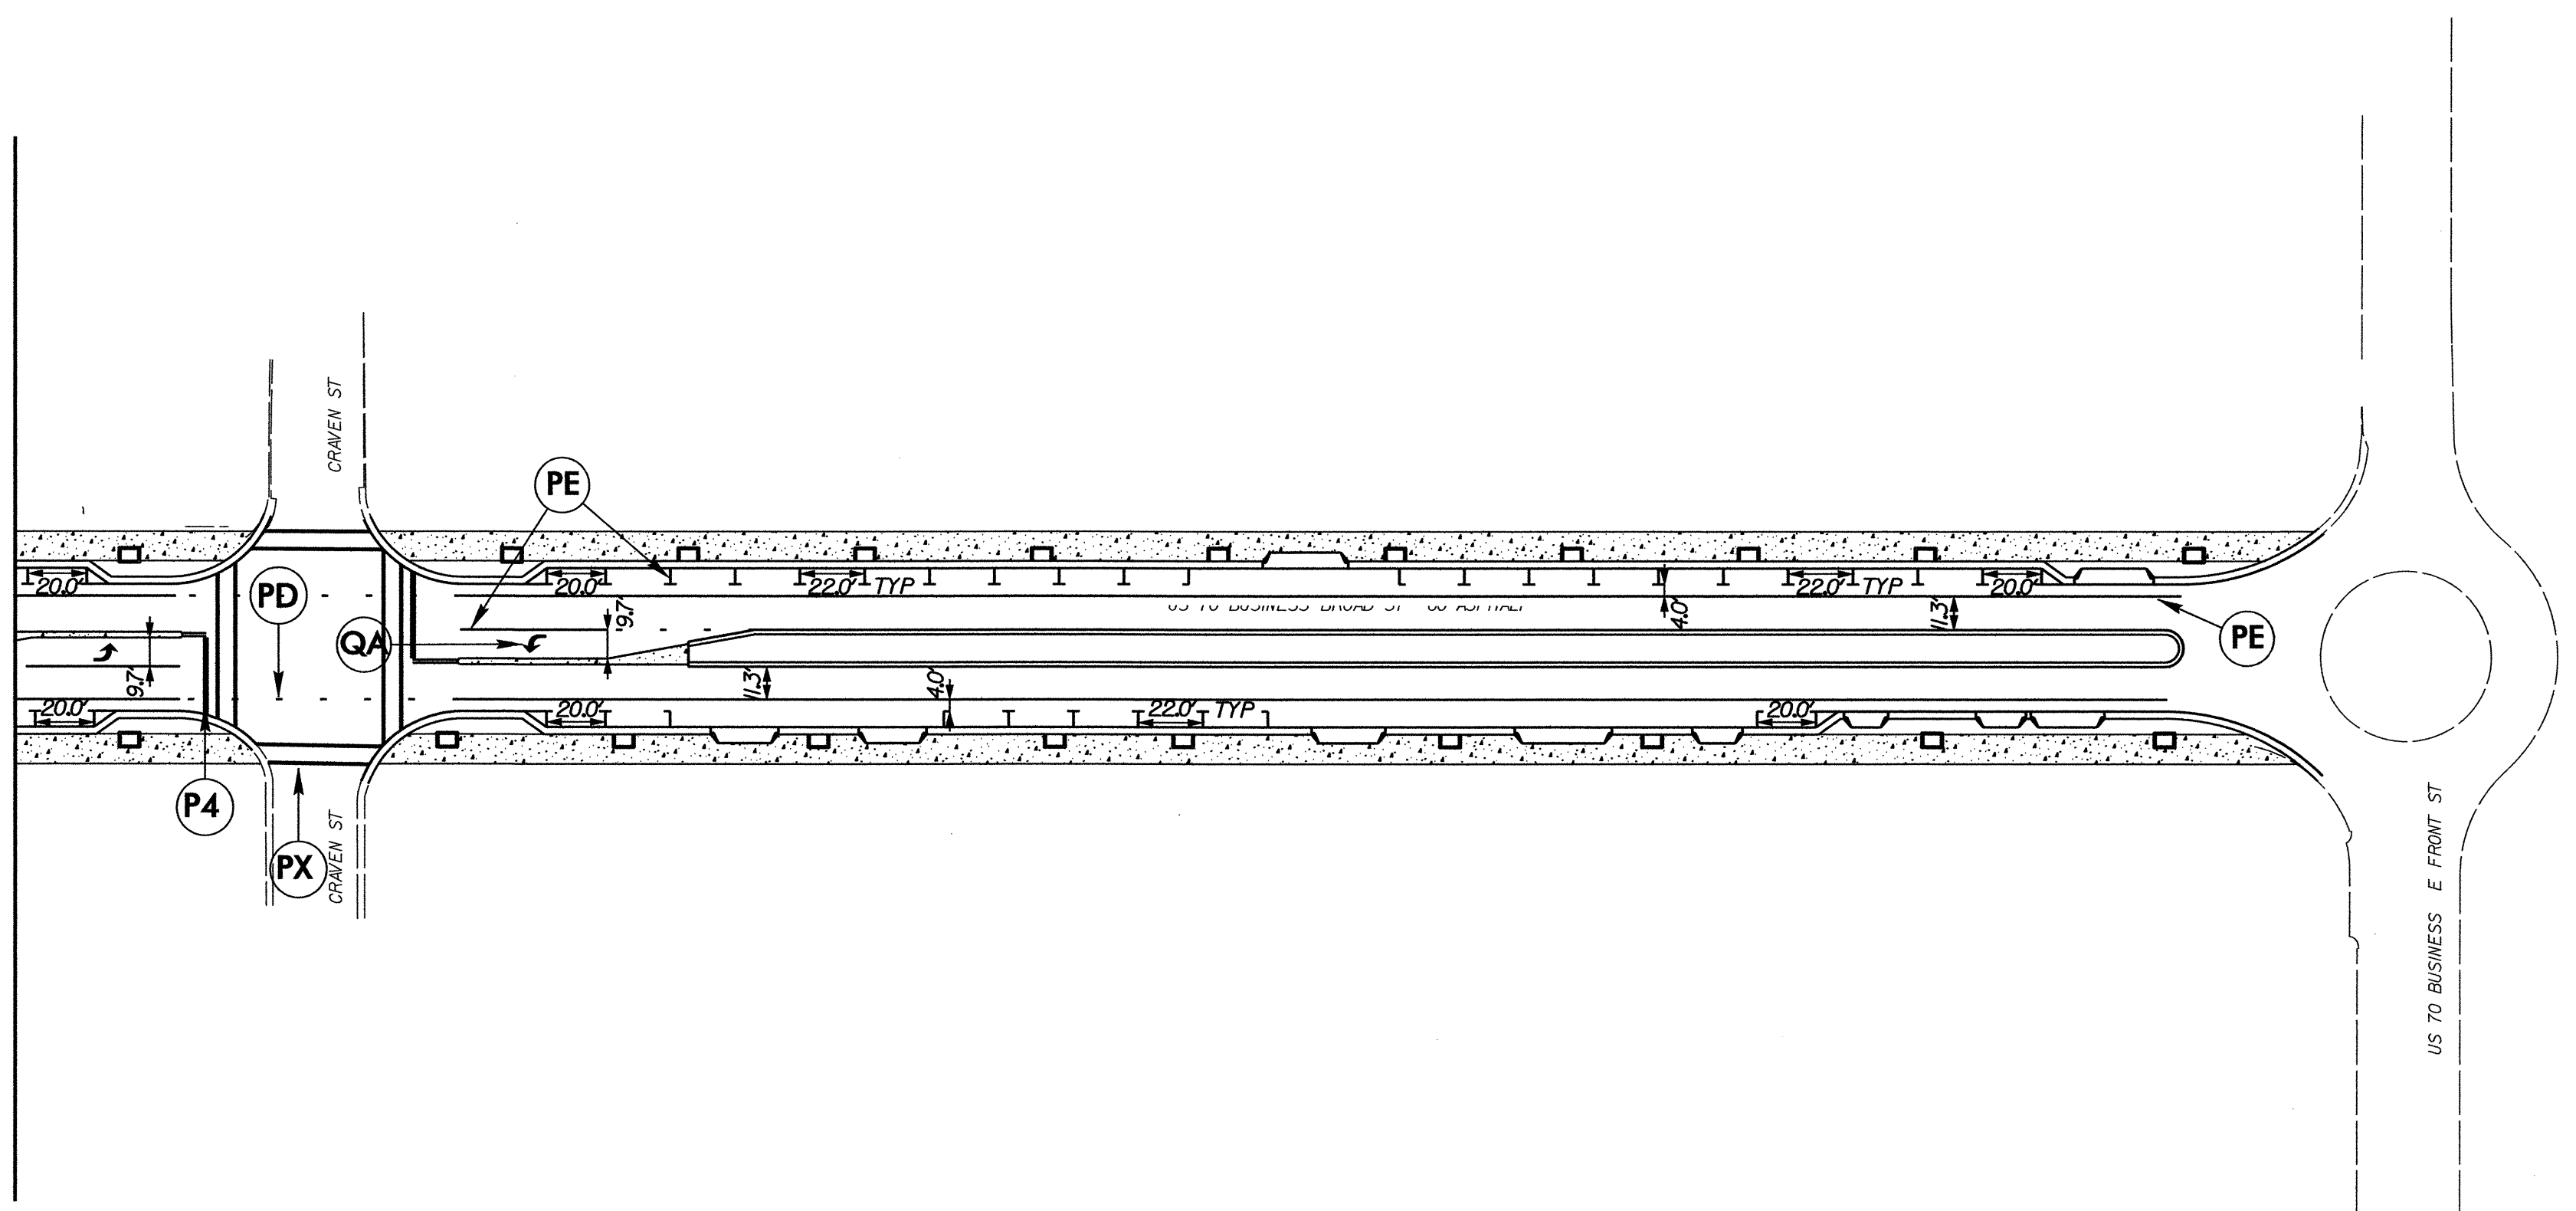

04-APR-2008 16:54
 g:\projects\grdven\br00d_street\broadst_dds2_psh_pm_5.dgn
 jgaronbulldr AT DEC022417

APPROVED: <i>J. Bull</i> DATE: 4/1/08		FINAL PAVEMENT MARKING PLANS									
	SCALE: NONE			<table border="1"> <thead> <tr> <th colspan="2">REVISIONS</th> </tr> </thead> <tbody> <tr><td> </td><td> </td></tr> <tr><td> </td><td> </td></tr> <tr><td> </td><td> </td></tr> </tbody> </table>		REVISIONS					
	REVISIONS										
DATE: 03/08											
DWG. BY: WCB											
DESIGN BY: WCB											
REVIEWED BY: JAB											