
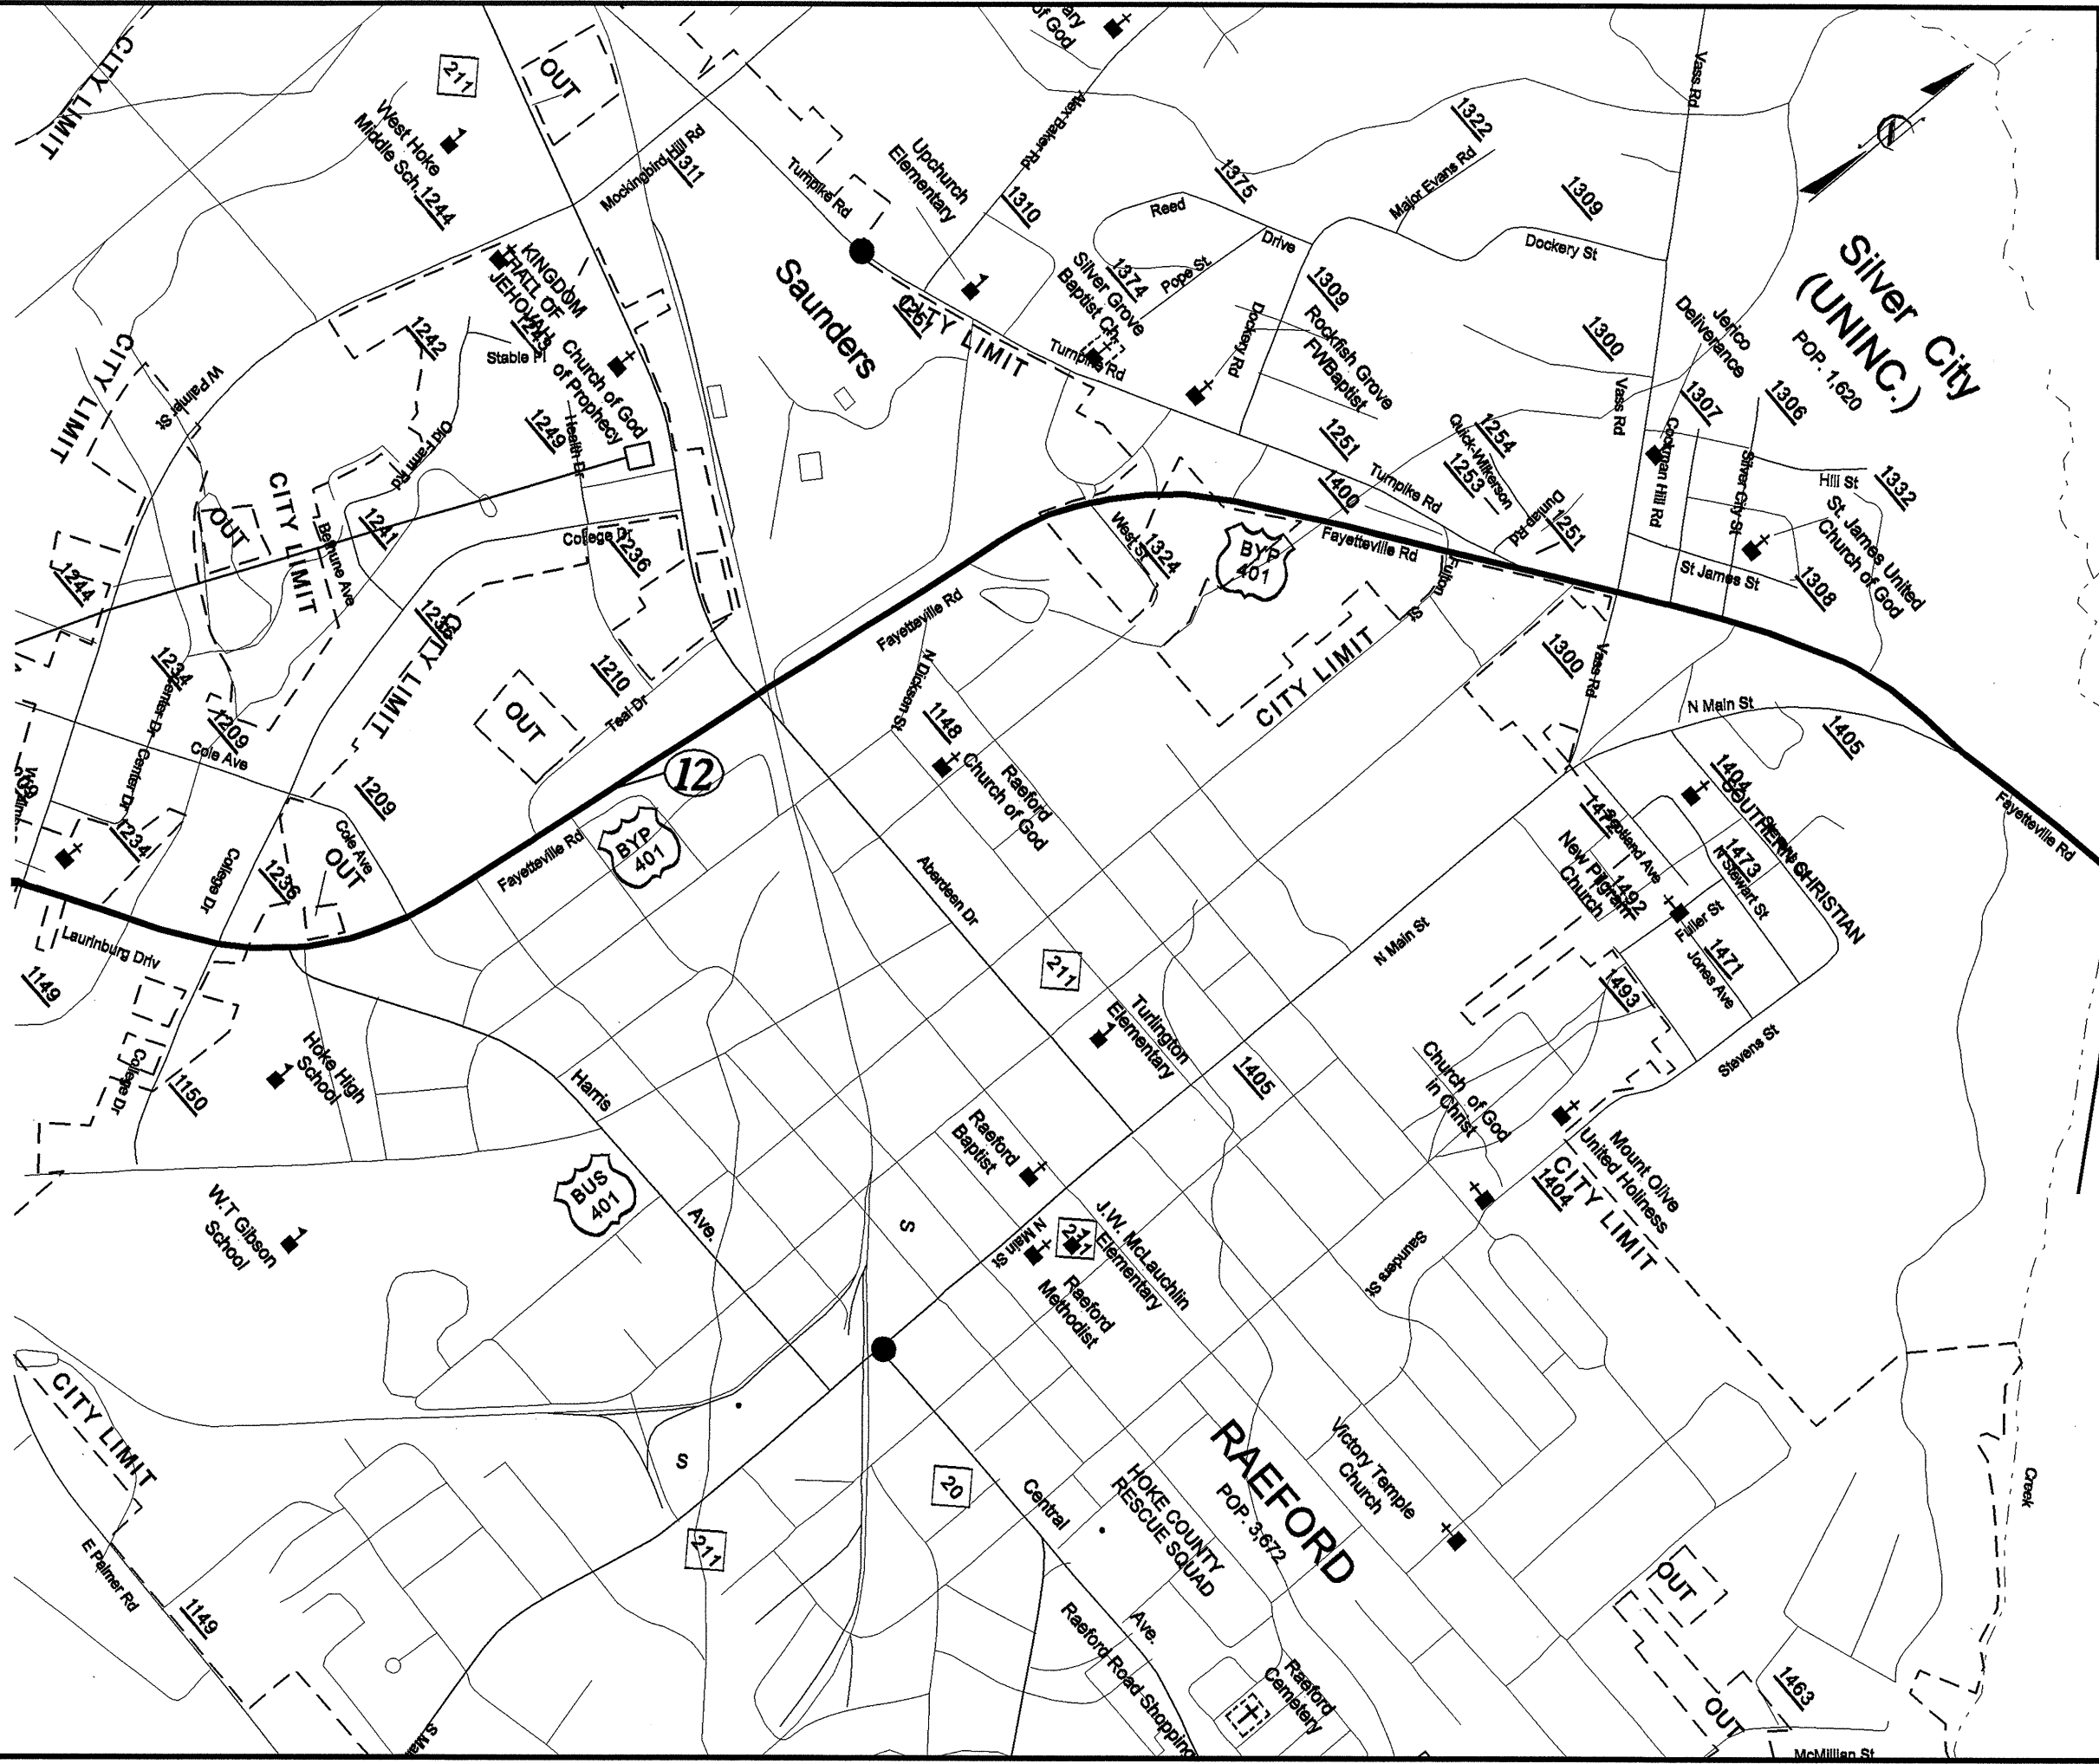
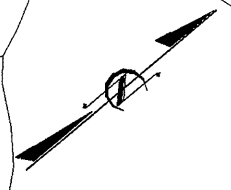


PROJECT REFERENCE NO. R-4425	SHEET NO. HOKE-2
RW SHEET NO.	
DIVISION 8 DDC ENGINEER	
	
4-18-08	



SEE SHEET HOKE-3

REVISIONS

8-APR-2008 13:43
D:\HOV\4425\Hoke\Hoke2.dwg
S. DAVIS


PROJECT REFERENCE NO. R-4425	SHEET NO. HOKE-3
RW SHEET NO.	
DIVISION 8 DDC ENGINEER	

8/17/99

REVISIONS

SEE SHEET HOKE-2


SEE SHEET HOKE-4

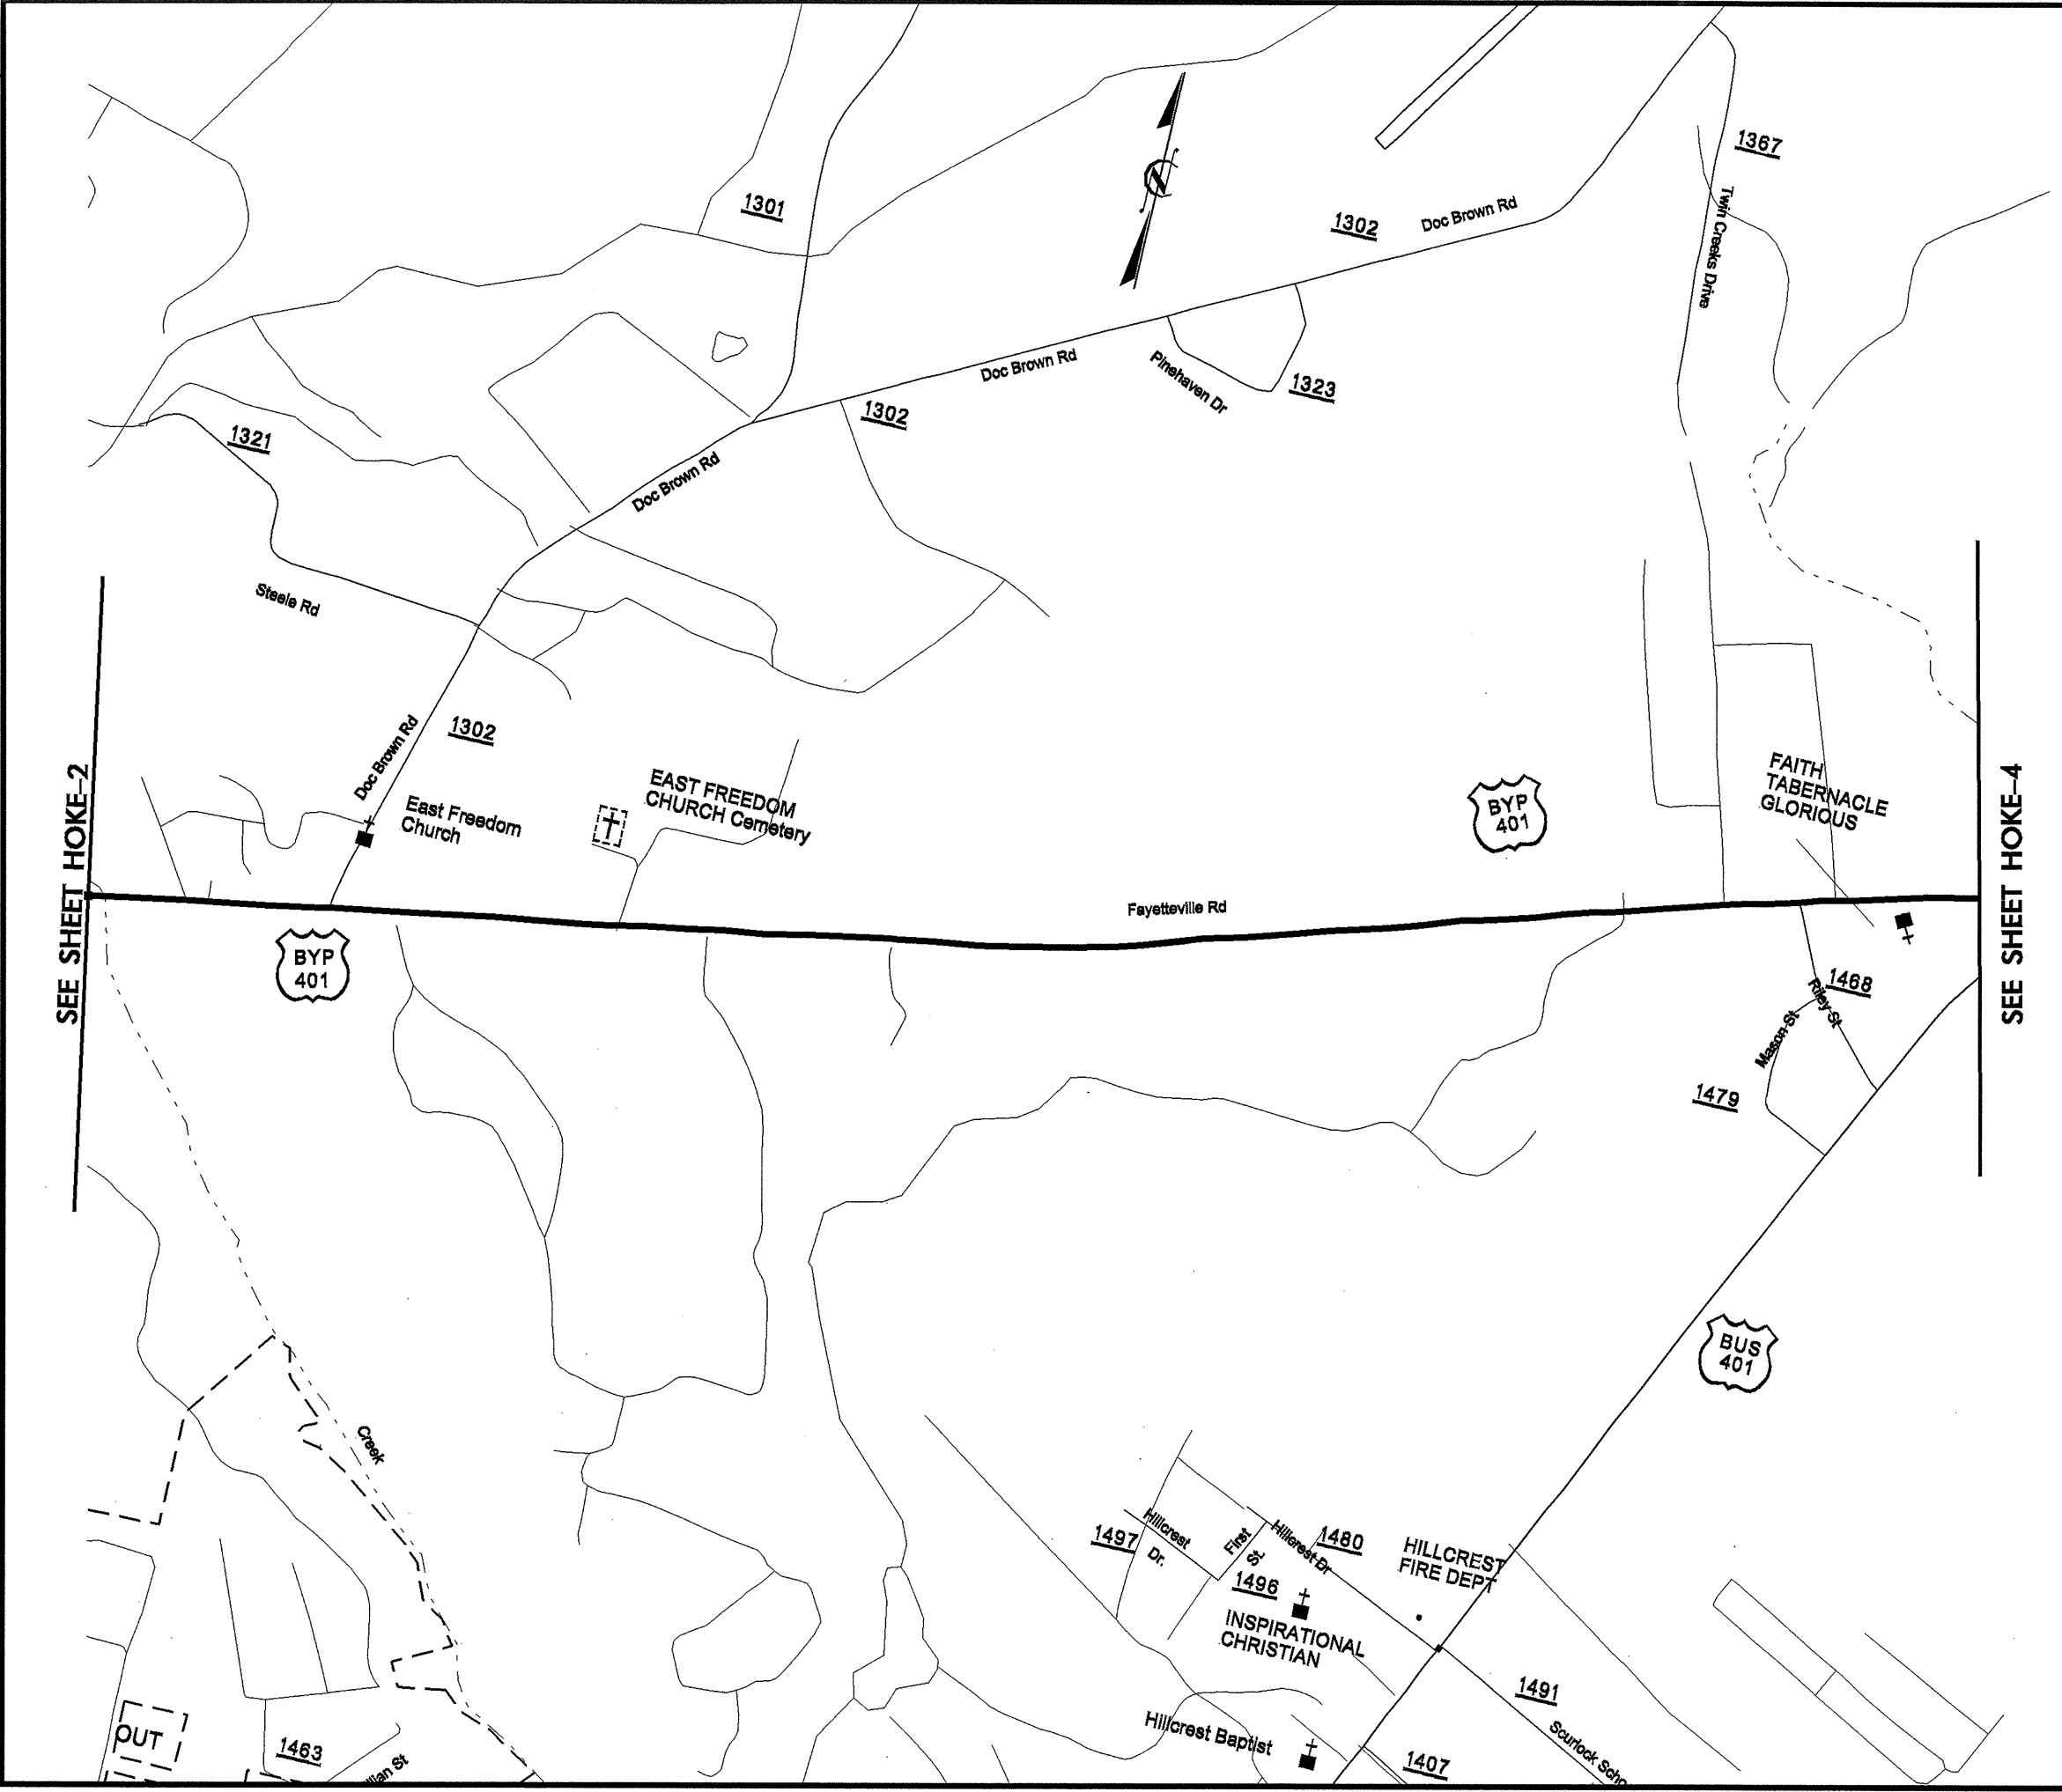

18-APR-2008 13:43
D:\ROY\AR-4425\HOKE\HOKE3.dgn

OUT

PROJECT REFERENCE NO. R-4425	SHEET NO. HOKE-4
RW SHEET NO.	
DIVISION 8 DDC ENGINEER	

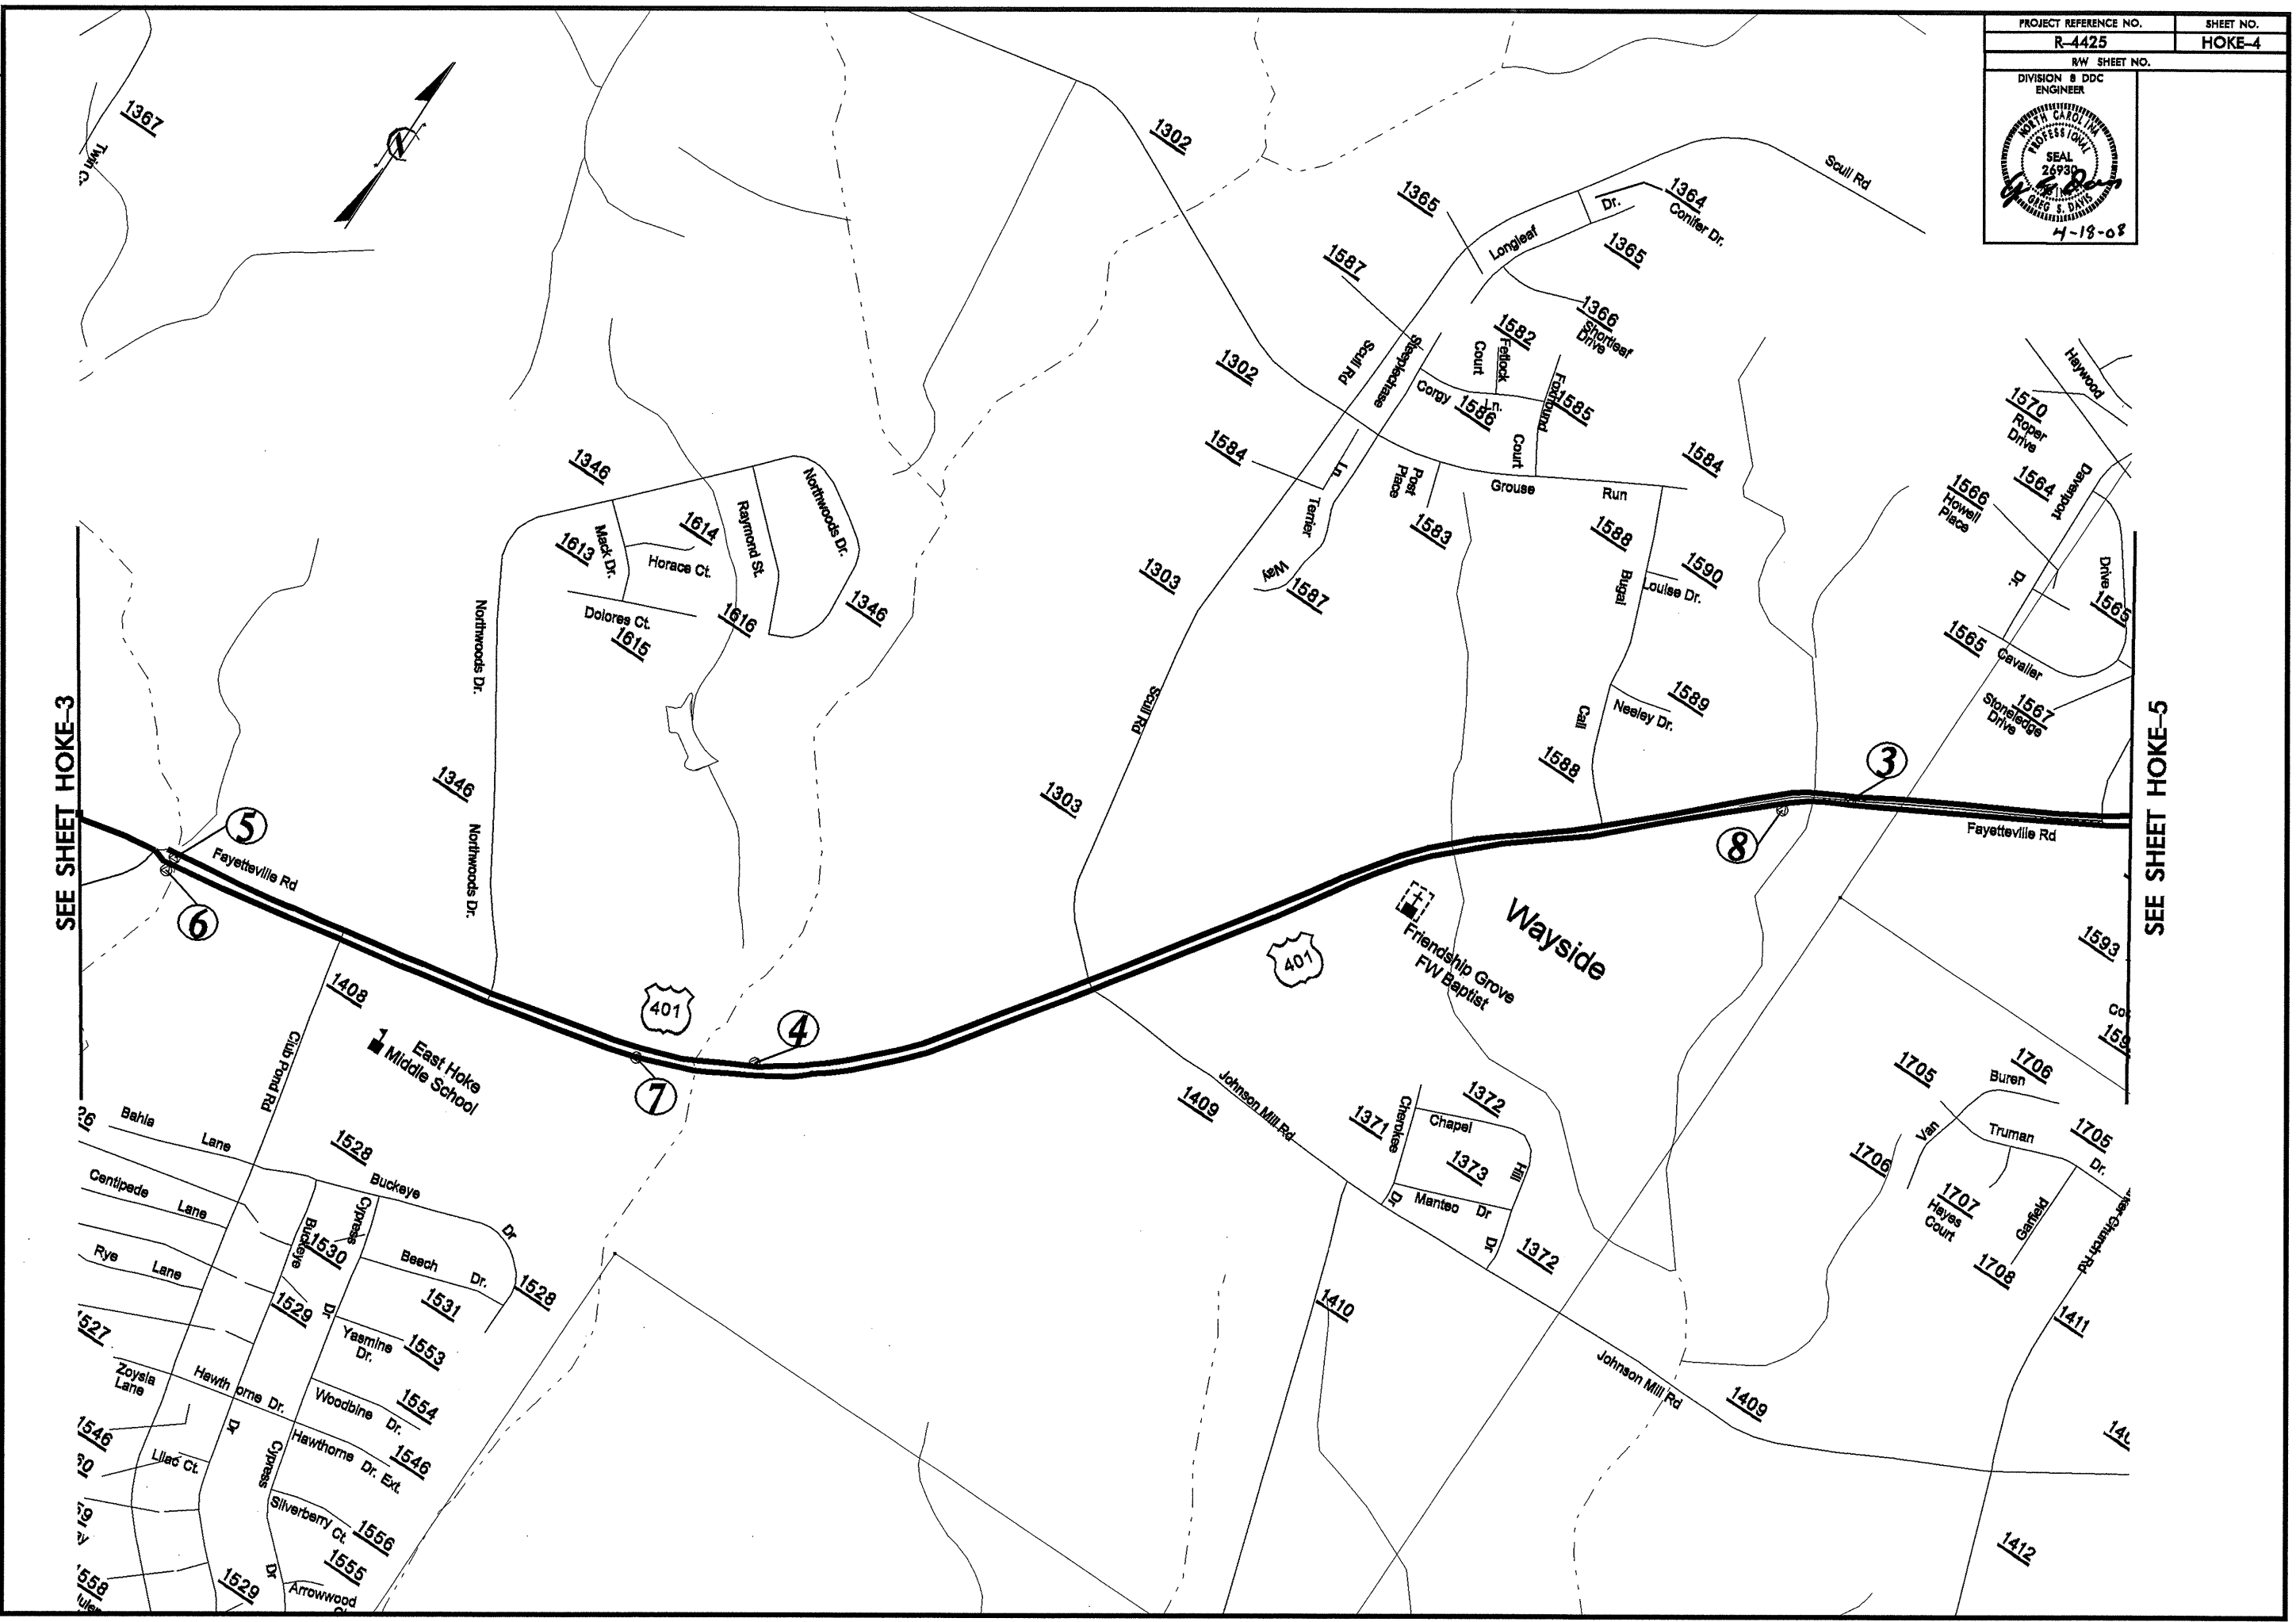


SEE SHEET HOKE-3

SEE SHEET HOKE-5

REVISIONS

18-APR-2008 13:43
D:\PROJ\R-4425\Hoke\hoke4.dgn
11:11 AM 2/23/07

PROJECT REFERENCE NO. R-4425	SHEET NO. HOKE-5
R/W SHEET NO.	
DIVISION 8 DDC ENGINEER	

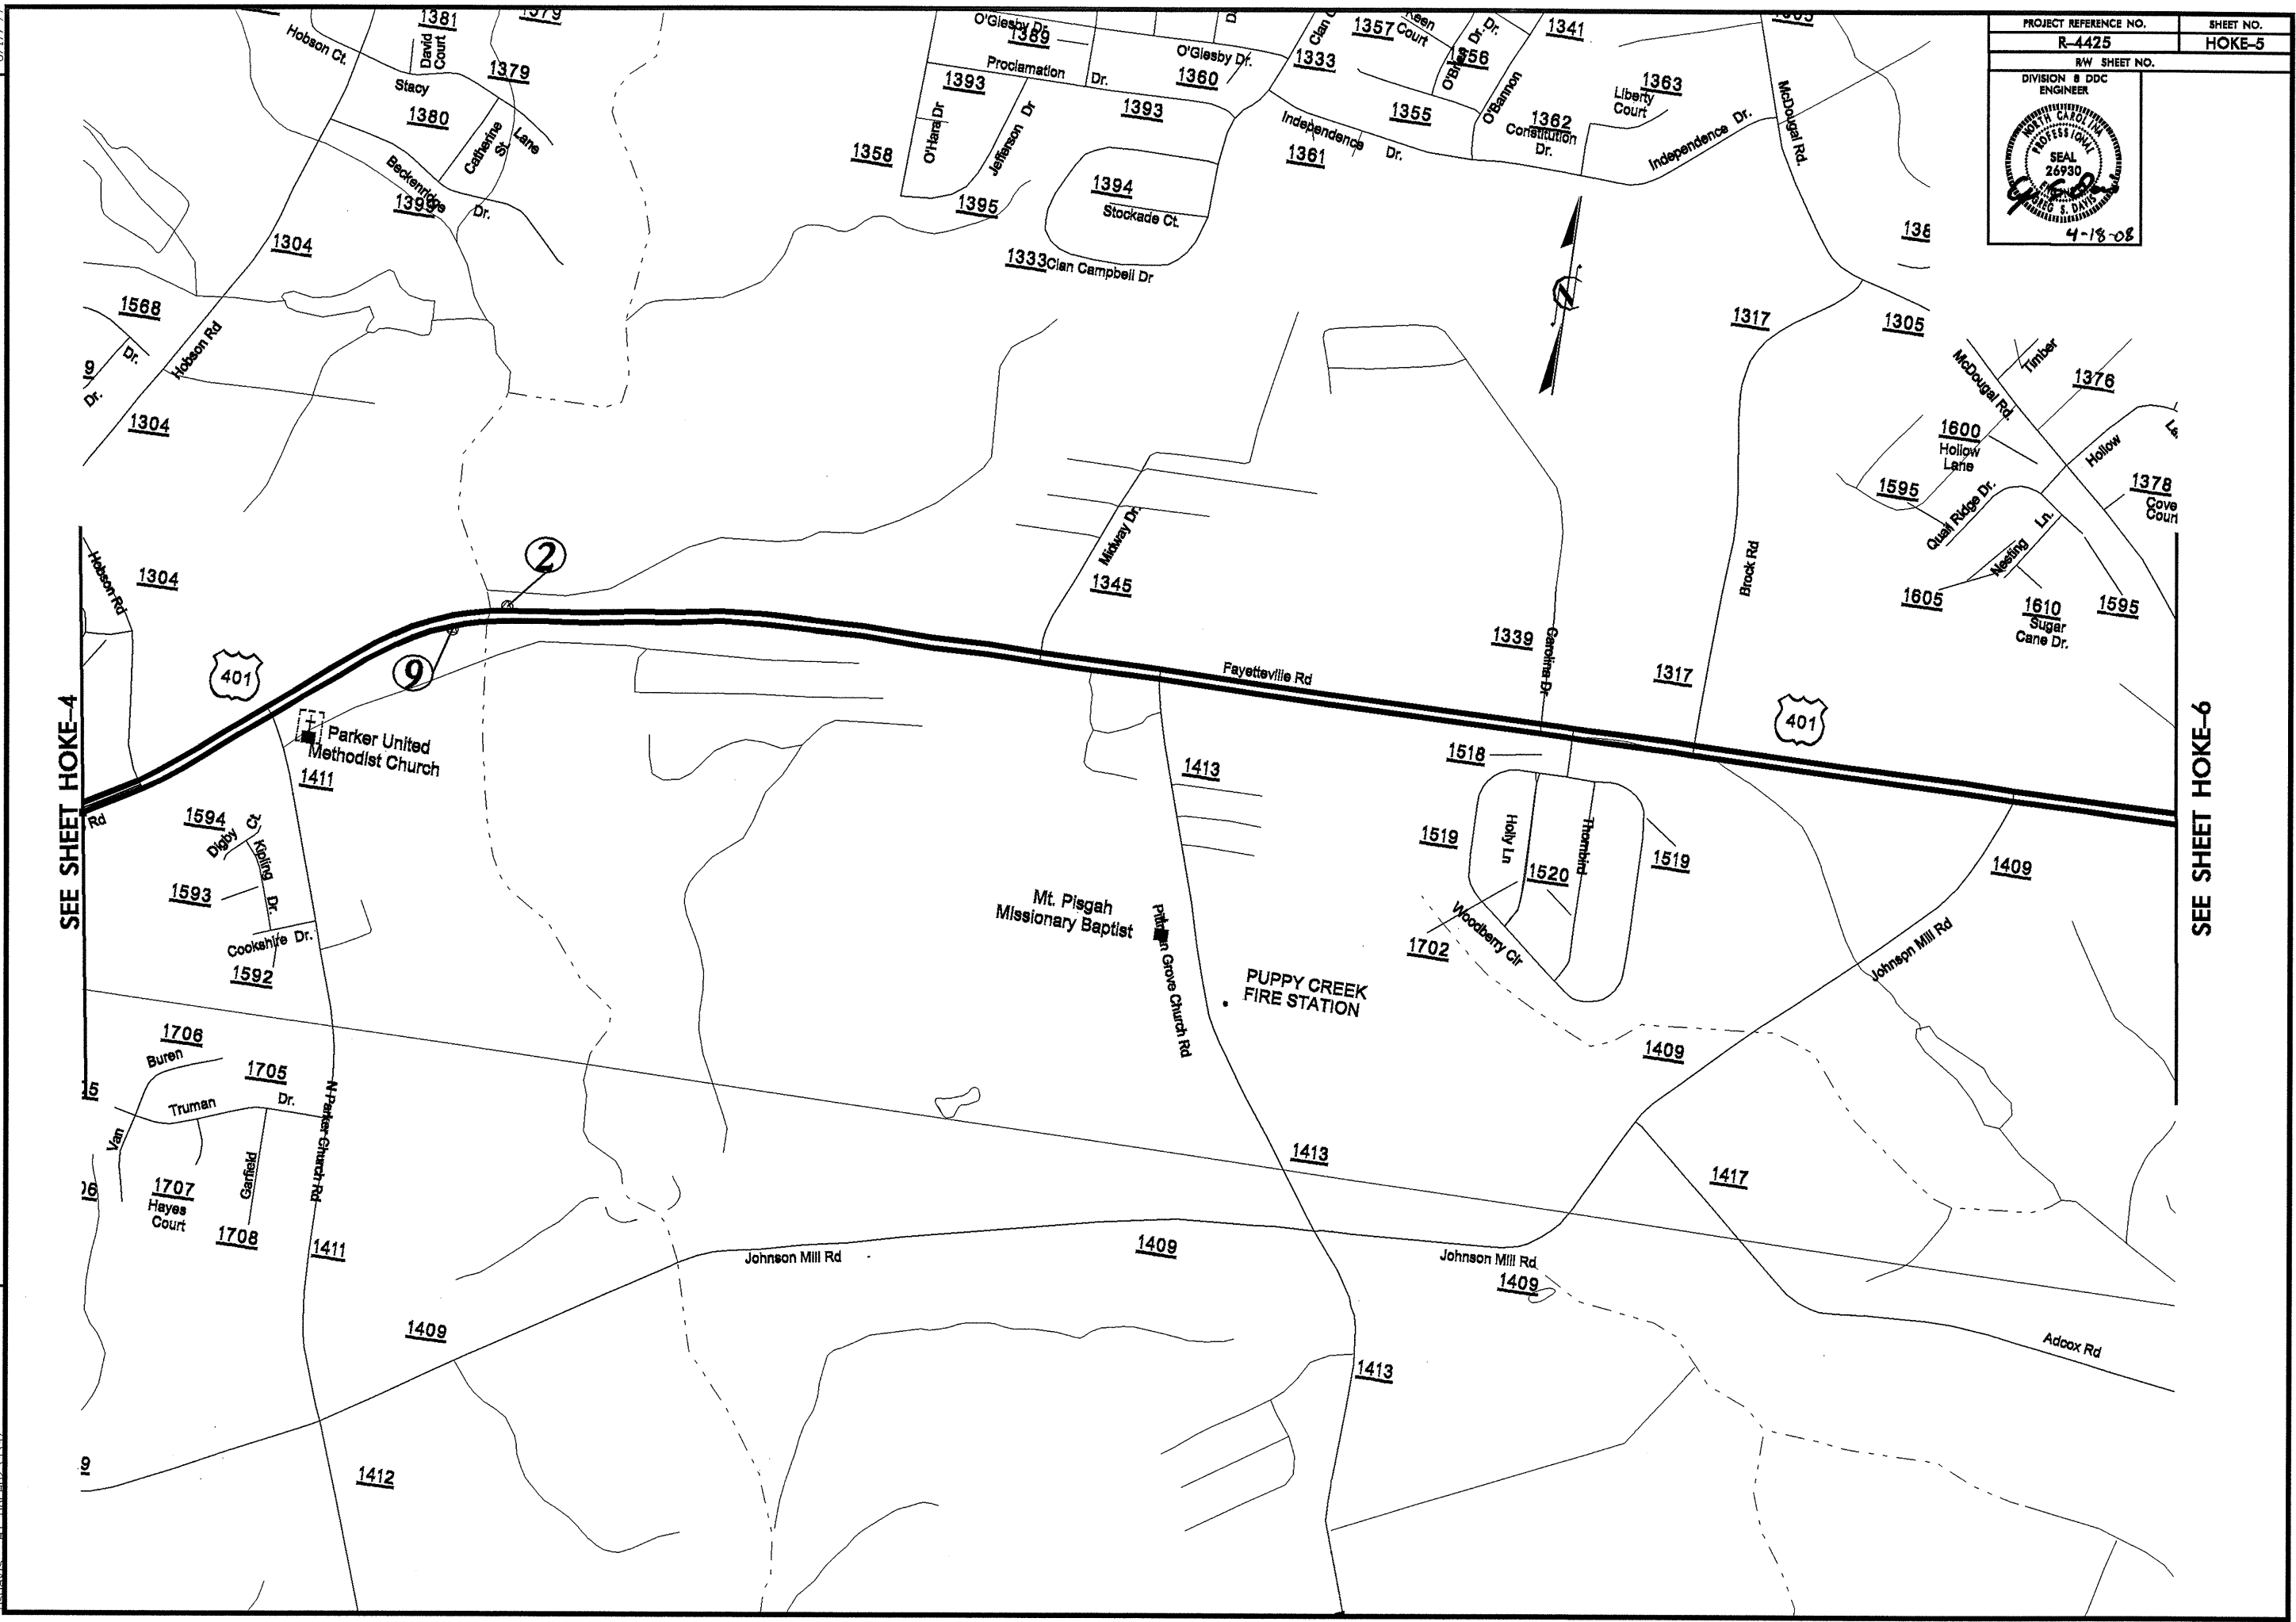


SEE SHEET HOKE-4

SEE SHEET HOKE-6

REVISIONS

8/17/99

18-APR-2008 10:43
D:\PROJ\18-44-25\Hoke\Hoke5.dwg
asdwg


PROJECT REFERENCE NO. R-4425	SHEET NO. HOKE-6
RW SHEET NO.	
DIVISION 8 DDC ENGINEER	
	
4-18-08	

8/17/99

REVISIONS

377
Bobwhite
Court
5
1376

SEE SHEET HOKE-5

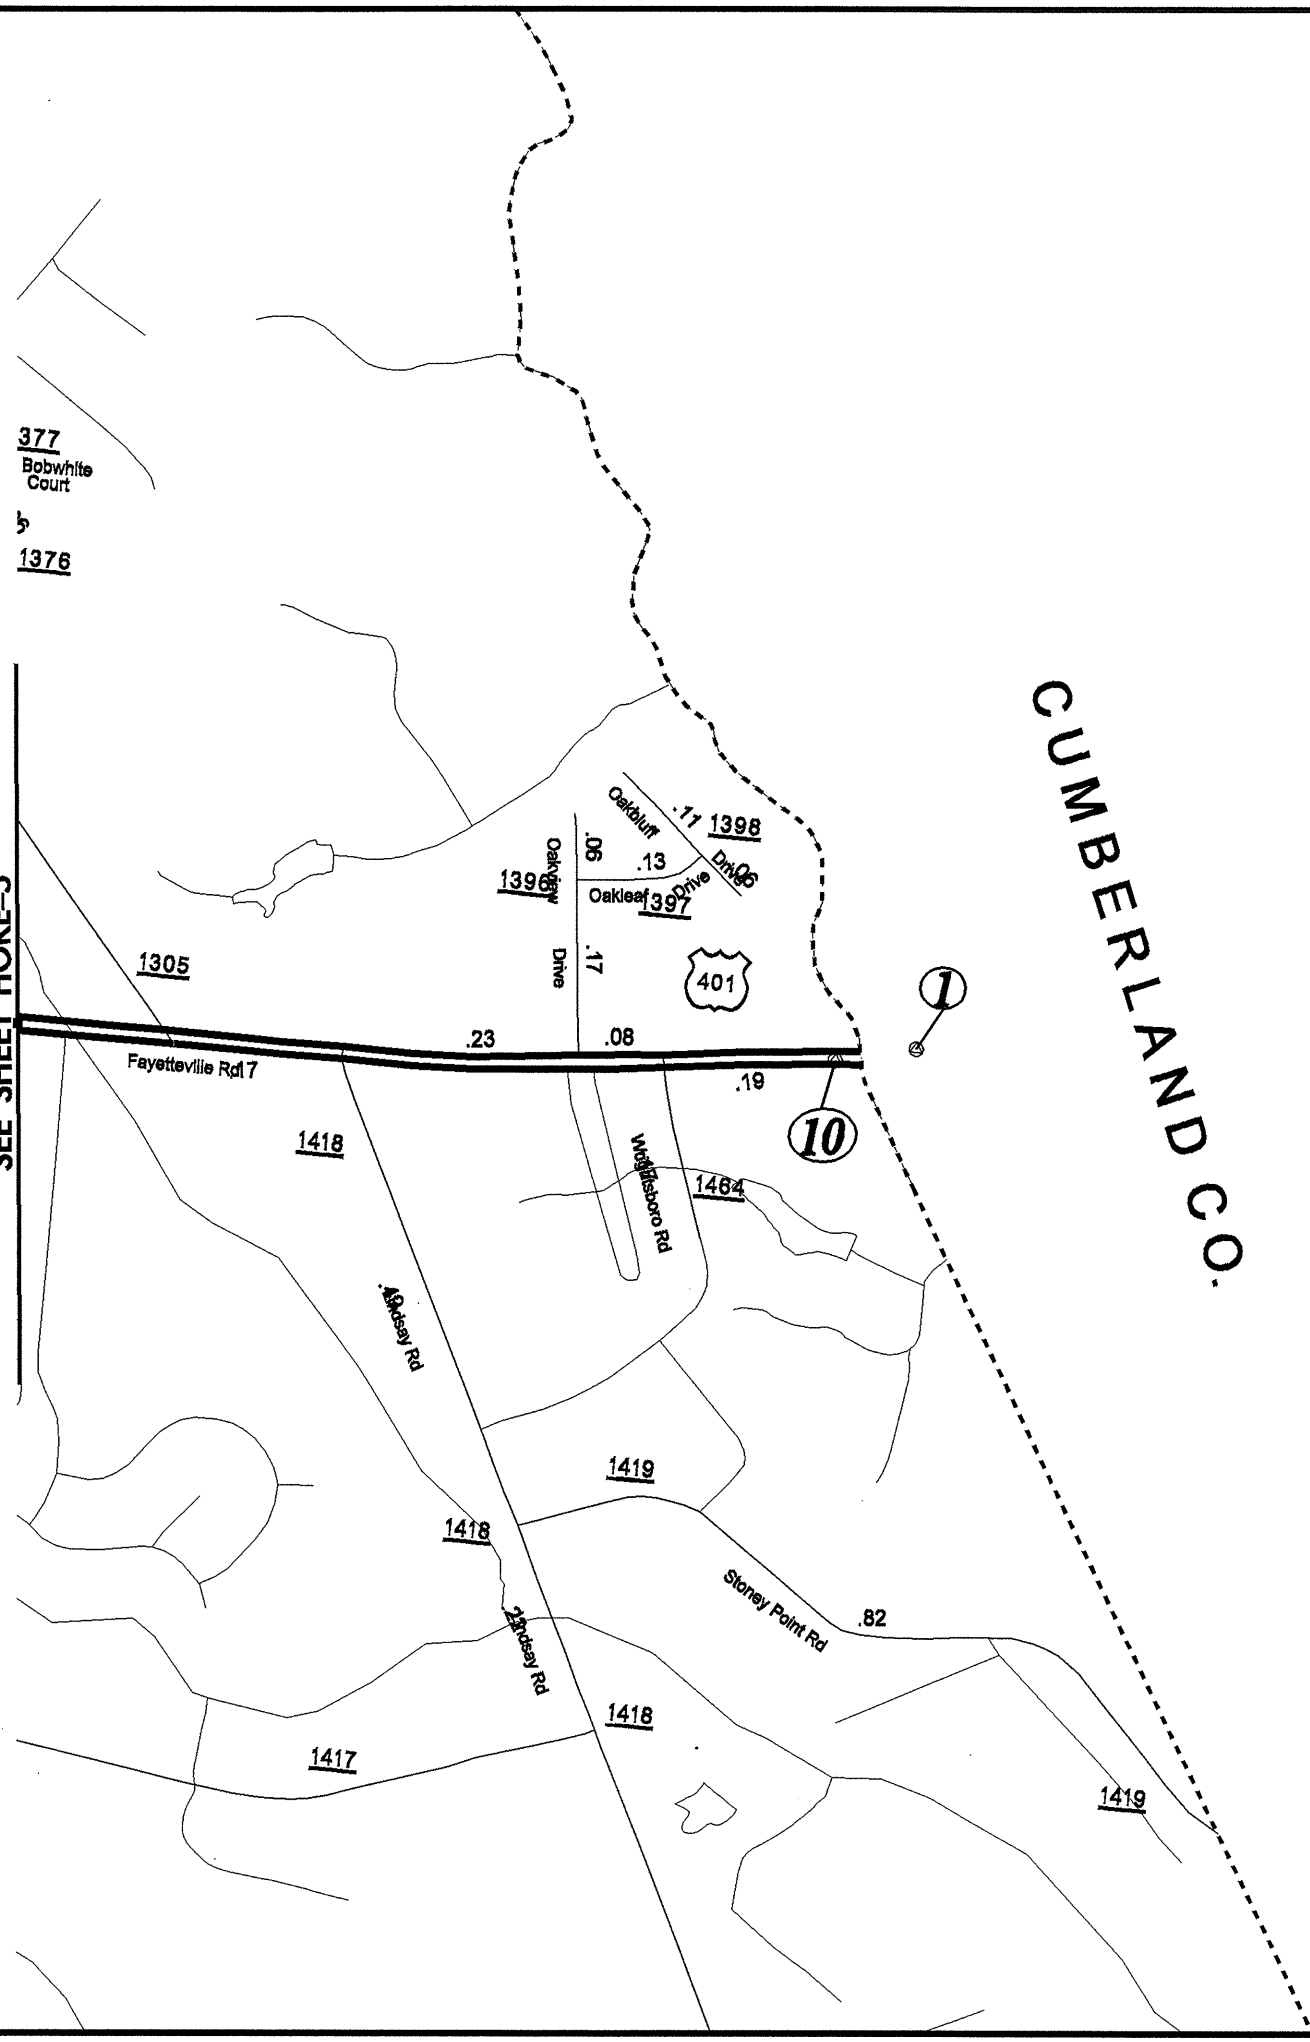

CUMBERLAND CO.

18-APR-2008 13:43
D:\ROY\18-4425\Hoke\Hoke6.dgn