





FINAL PAVT MARKING SCHEDULE

SYMBOL	DESCRIPTION	QUANTITY BREAKDOWN	PAY ITEM	TOTAL QUANTITY
PAVEMENT MARKING LINES				
			THERMOPLASTIC (4", 90 mils)	
TA	WHITE EDGELINE	500 ft	TOTAL	500 ft
			THERMOPLASTIC (4", 120 mils)	
TC	10 ft. WHITE SKIP	98 ft		
TD	2 ft. WHITE MINISKIP	187 ft		
TE	WHITE SOLID LANE LINE	100 ft		
TF	10 ft YELLOW SKIP	1,750 ft		
TH	YELLOW SINGLE CENTER	6,992 ft		
TI	YELLOW DOUBLE CENTER LINE	3,050 ft		
			TOTAL	12,177 ft
			THERMOPLASTIC (8", 90 mils)	
TT	YELLOW DIAGONAL	50	TOTAL	50 ft
			THERMOPLASTIC (24", 120 mils)	
T2	WHITE STOPBAR	72 ft	TOTAL	72 ft
PAVEMENT MARKING SYMBOLS				
			THERMOPLASTIC THICK SYMBOL (90 mils)	
UA	LEFT TURN ARROW	25 ea		
UC	STRAIGHT ARROW	5 ea		
			TOTAL	30 ea
PAVEMENT MARKERS				
			SNOWPLOWABLE RAISED	
ME	CRYSTAL AND RED	15 ea		
MF	YELLOW AND YELLOW	125 ea	TOTAL	140 ea

SEE ROADWAY STANDARD DRAWING NUMBERS 1205.01, 1205.02, 1205.04, 1205.05, 1205.06, 1205.08, 1205.09, 1250.01 AND 1253.01

06-OCT-2011 13:27 S:\DDC\Dist\101\3\Lincoln\W-4712\Plan Sheets\Traffic Control\W-4712-fo.pmp.dgn \$\$\$SERNAME\$\$\$

APPROVED: <i>Mark E. Stafford</i> DATE: 10-1-11 <div style="text-align: center;">  <p>SEAL</p> </div>	<h2 style="margin: 0;">FINAL PAVEMENT MARKING PLAN</h2> <table border="1" style="width: 100%; border-collapse: collapse;"> <tr> <td style="width: 50%;">SCALE: NONE</td> <td style="width: 50%; text-align: center;">REVISIONS</td> </tr> <tr> <td>DATE: 05-21</td> <td></td> </tr> <tr> <td>DWG. BY: BKS</td> <td></td> </tr> <tr> <td>DESIGN BY:</td> <td></td> </tr> <tr> <td>REVIEWED BY:</td> <td></td> </tr> </table> <div style="text-align: center; margin-top: 10px;">  </div>	SCALE: NONE	REVISIONS	DATE: 05-21		DWG. BY: BKS		DESIGN BY:		REVIEWED BY:	
SCALE: NONE	REVISIONS										
DATE: 05-21											
DWG. BY: BKS											
DESIGN BY:											
REVIEWED BY:											

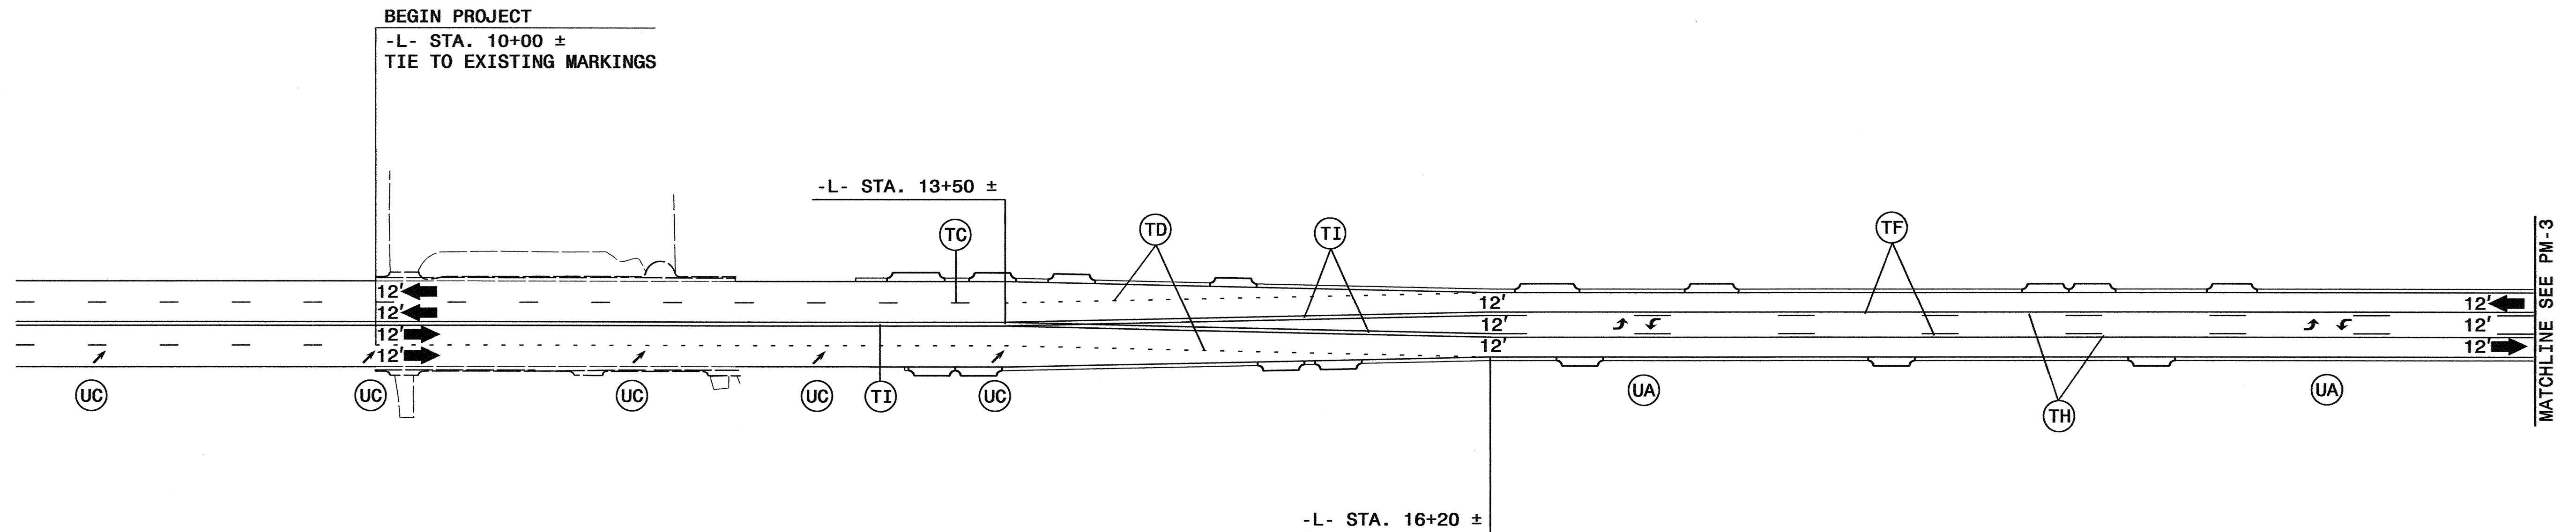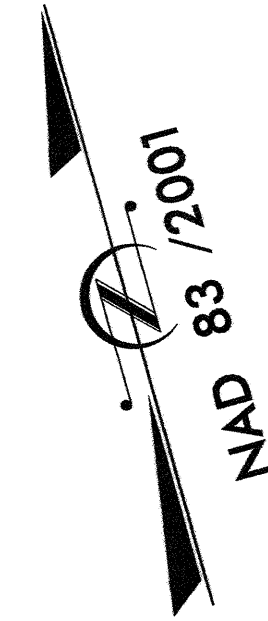


NOTES:

- SEE SHEET PM-1, FOR FINAL PAVEMENT MARKING SCHEDULE.
- PAVEMENT MARKINGS, SYMBOLS, AND CHARACTERS ARE TO BE MARKED ACCORDING TO ROADWAY STANDARD DRAWINGS UNLESS OTHERWISE NOTED IN THE PLANS.
- PAVEMENT MARKERS ARE TO BE SPACED ACCORDING TO THE ROADWAY STANDARD DRAWINGS.

06-OCT-2011 13:25
 S:\DDC\dist\pct_3\Lincoln\W-4712\Plan Sheets\Traffic Control\W-4712-TC_pmp-2.dgn
 \$\$\$USERNAME\$\$\$

APPROVED: <i>Mark E. Stafford</i> DATE: 10-10-11	FINAL PAVEMENT MARKING PLAN							
	SCALE: NONE							
	DATE: 5/21/09							
	DWG. BY: BKS							
	DESIGN BY: REH							
REVIEWED BY:	<table border="1"> <thead> <tr> <th colspan="2">REVISIONS</th> </tr> </thead> <tbody> <tr> <td> </td> <td> </td> </tr> <tr> <td> </td> <td> </td> </tr> </tbody> </table>		REVISIONS					
REVISIONS								

PROJ. REFERENCE NO.	SHEET NO.
W-4712	PM-3

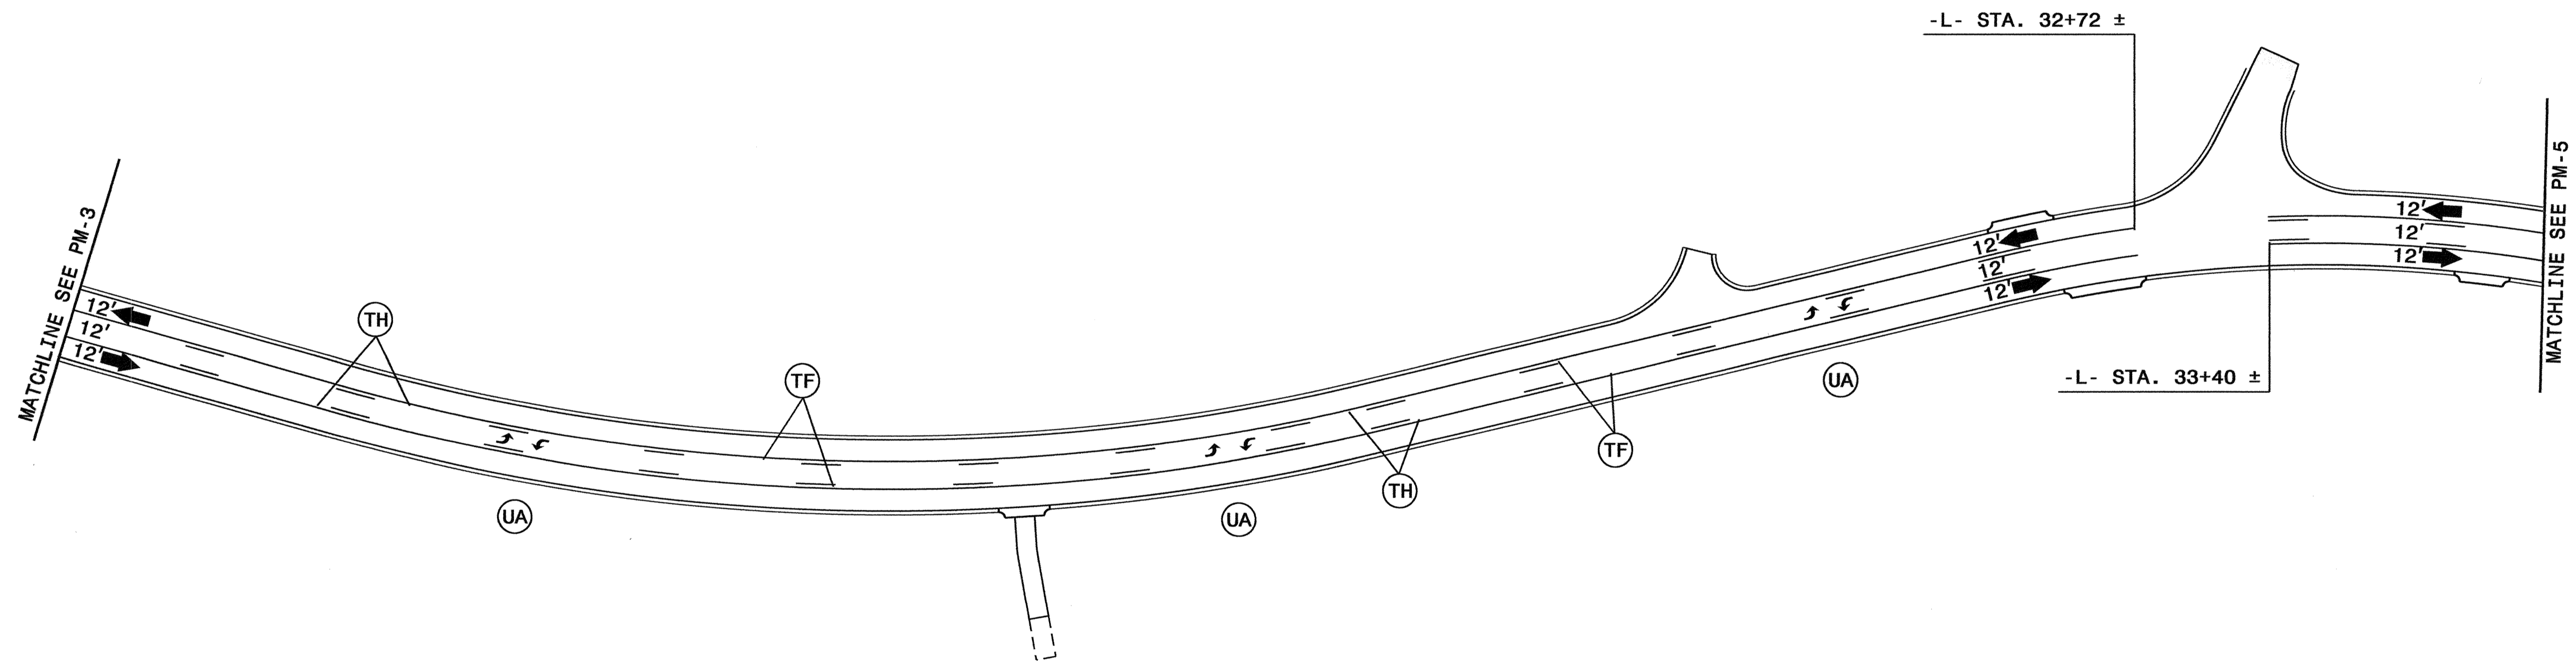


NOTES:

- SEE SHEET PM-1, FOR FINAL PAVEMENT MARKING SCHEDULE.
- PAVEMENT MARKINGS, SYMBOLS, AND CHARACTERS ARE TO BE MARKED ACCORDING TO ROADWAY STANDARD DRAWINGS UNLESS OTHERWISE NOTED IN THE PLANS.
- PAVEMENT MARKERS ARE TO BE SPACED ACCORDING TO THE ROADWAY STANDARD DRAWINGS.

06-OCT-2011 13:23
 S:\DDC\District 3\Lincoln\W-4712\Plan Sheets\Traffic Control\w-4712.tc.pmp_3.dgn
 \$\$\$USERNAME\$\$\$

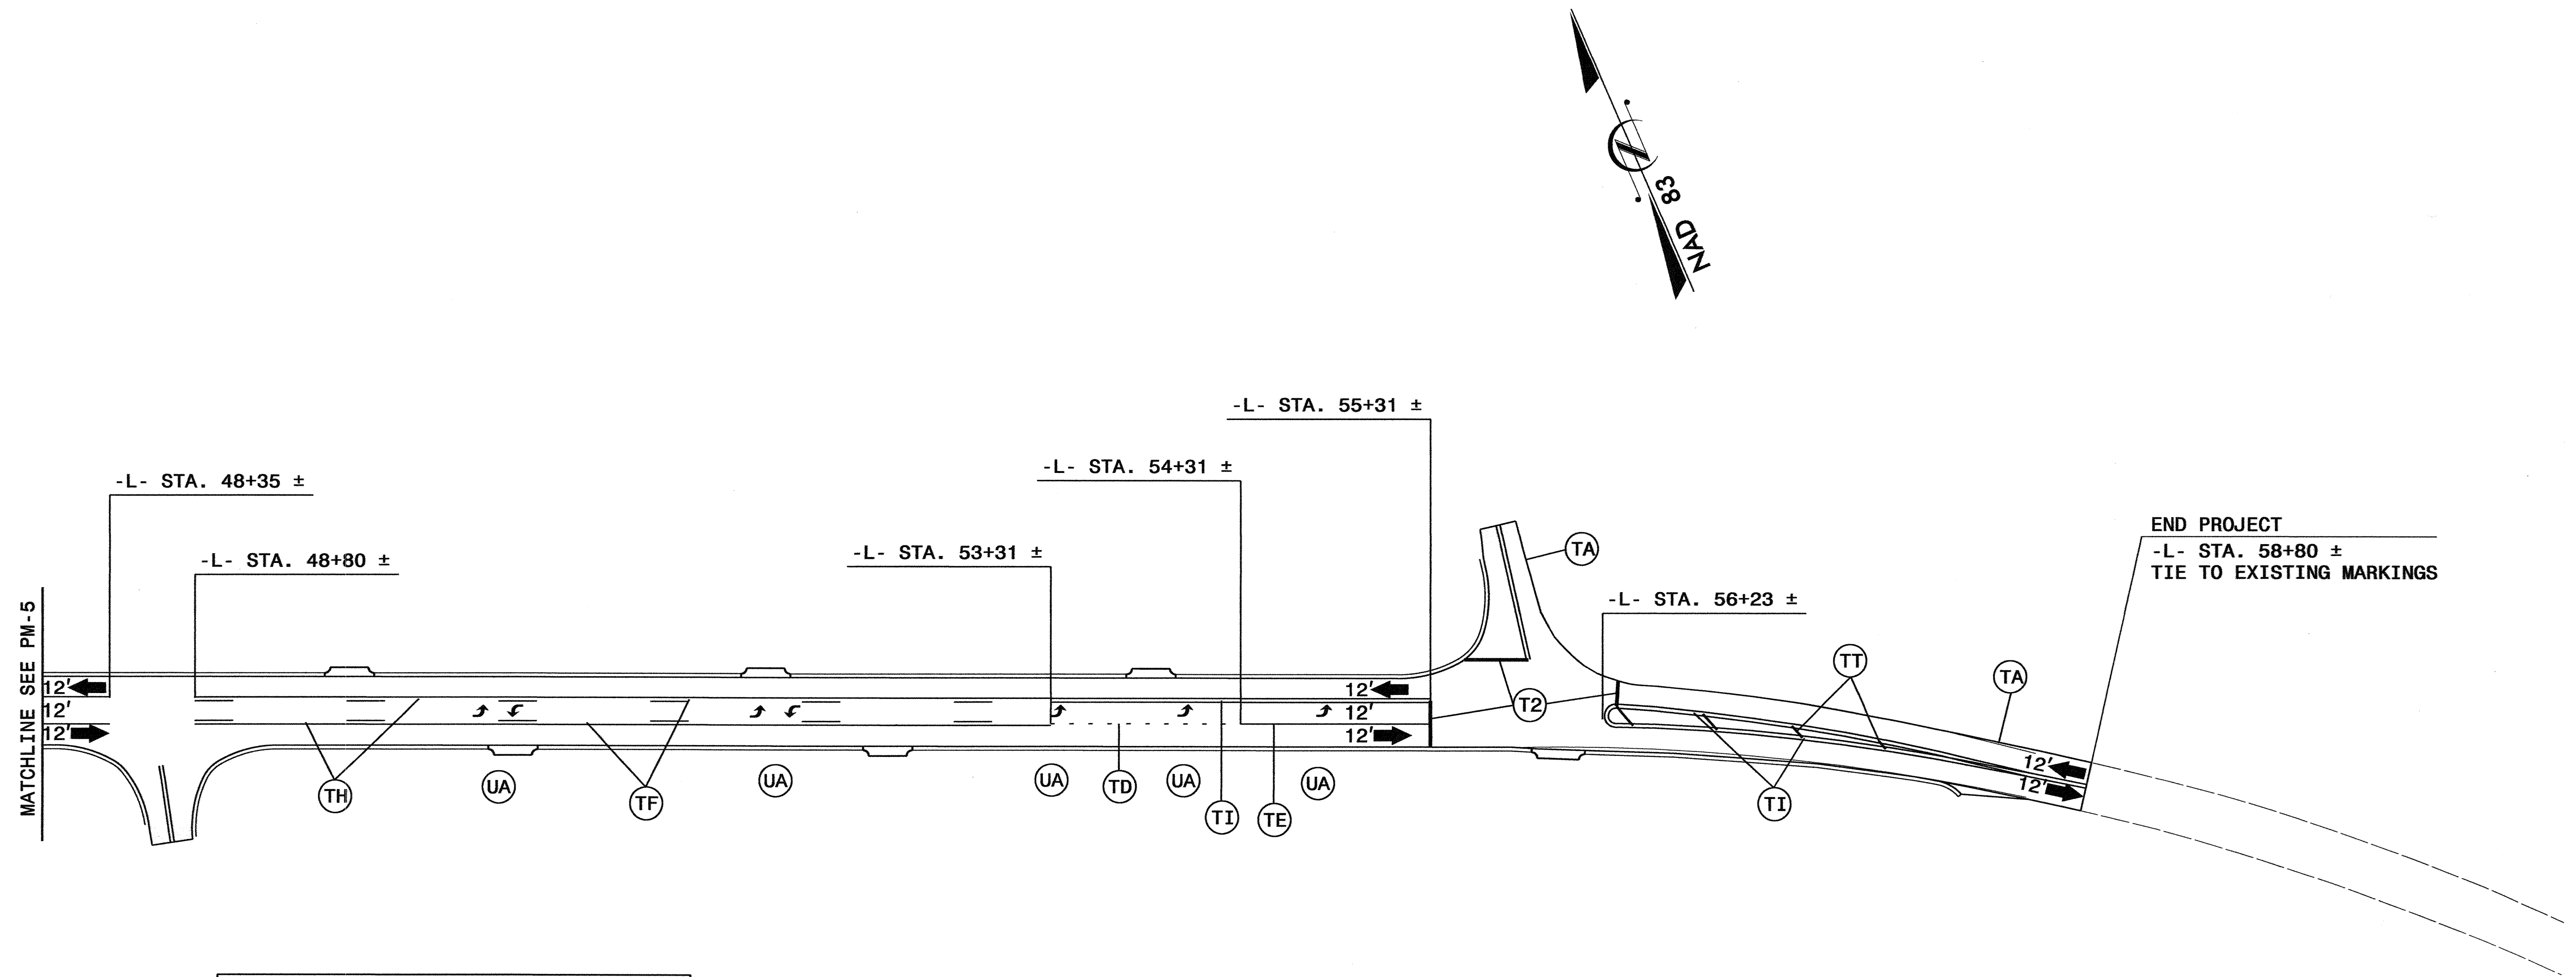

APPROVED: <i>Mark E. Stafford</i> DATE: 10-15-11	FINAL PAVEMENT MARKING PLAN	
	SCALE: NONE	
	DATE: 5/21/09	
	DWG. BY: BKS	
	DESIGN BY: REH	
REVIEWED BY:	REVISIONS	



NOTES:

- SEE SHEET PM-1, FOR FINAL PAVEMENT MARKING SCHEDULE.
- PAVEMENT MARKINGS, SYMBOLS, AND CHARACTERS ARE TO BE MARKED ACCORDING TO ROADWAY STANDARD DRAWINGS UNLESS OTHERWISE NOTED IN THE PLANS.
- PAVEMENT MARKERS ARE TO BE SPACED ACCORDING TO THE ROADWAY STANDARD DRAWINGS.

06-OCT-2011 11:55
 3: \D:\CADD\STAFF\W-4712\Lincoln\W-4712\Plan Sheets\Traffic Control\w-4712-tp.pmp_5.dgn
 \$\$\$USERNAME\$\$\$

APPROVED: <i>Mark E. Stafford</i> DATE: 5/21/09	FINAL PAVEMENT MARKING PLAN	
		
SCALE: NONE		REVISIONS
DATE: 5/21/09		
DWG. BY: BKS		
DESIGN BY: REH		
REVIEWED BY:		CADD FILE