



PROJECT REFERENCE NO. W-5146	SHEET NO. PM-1
SHEET NO.	
DIVISION ZONE FILE	
ENGINEER	

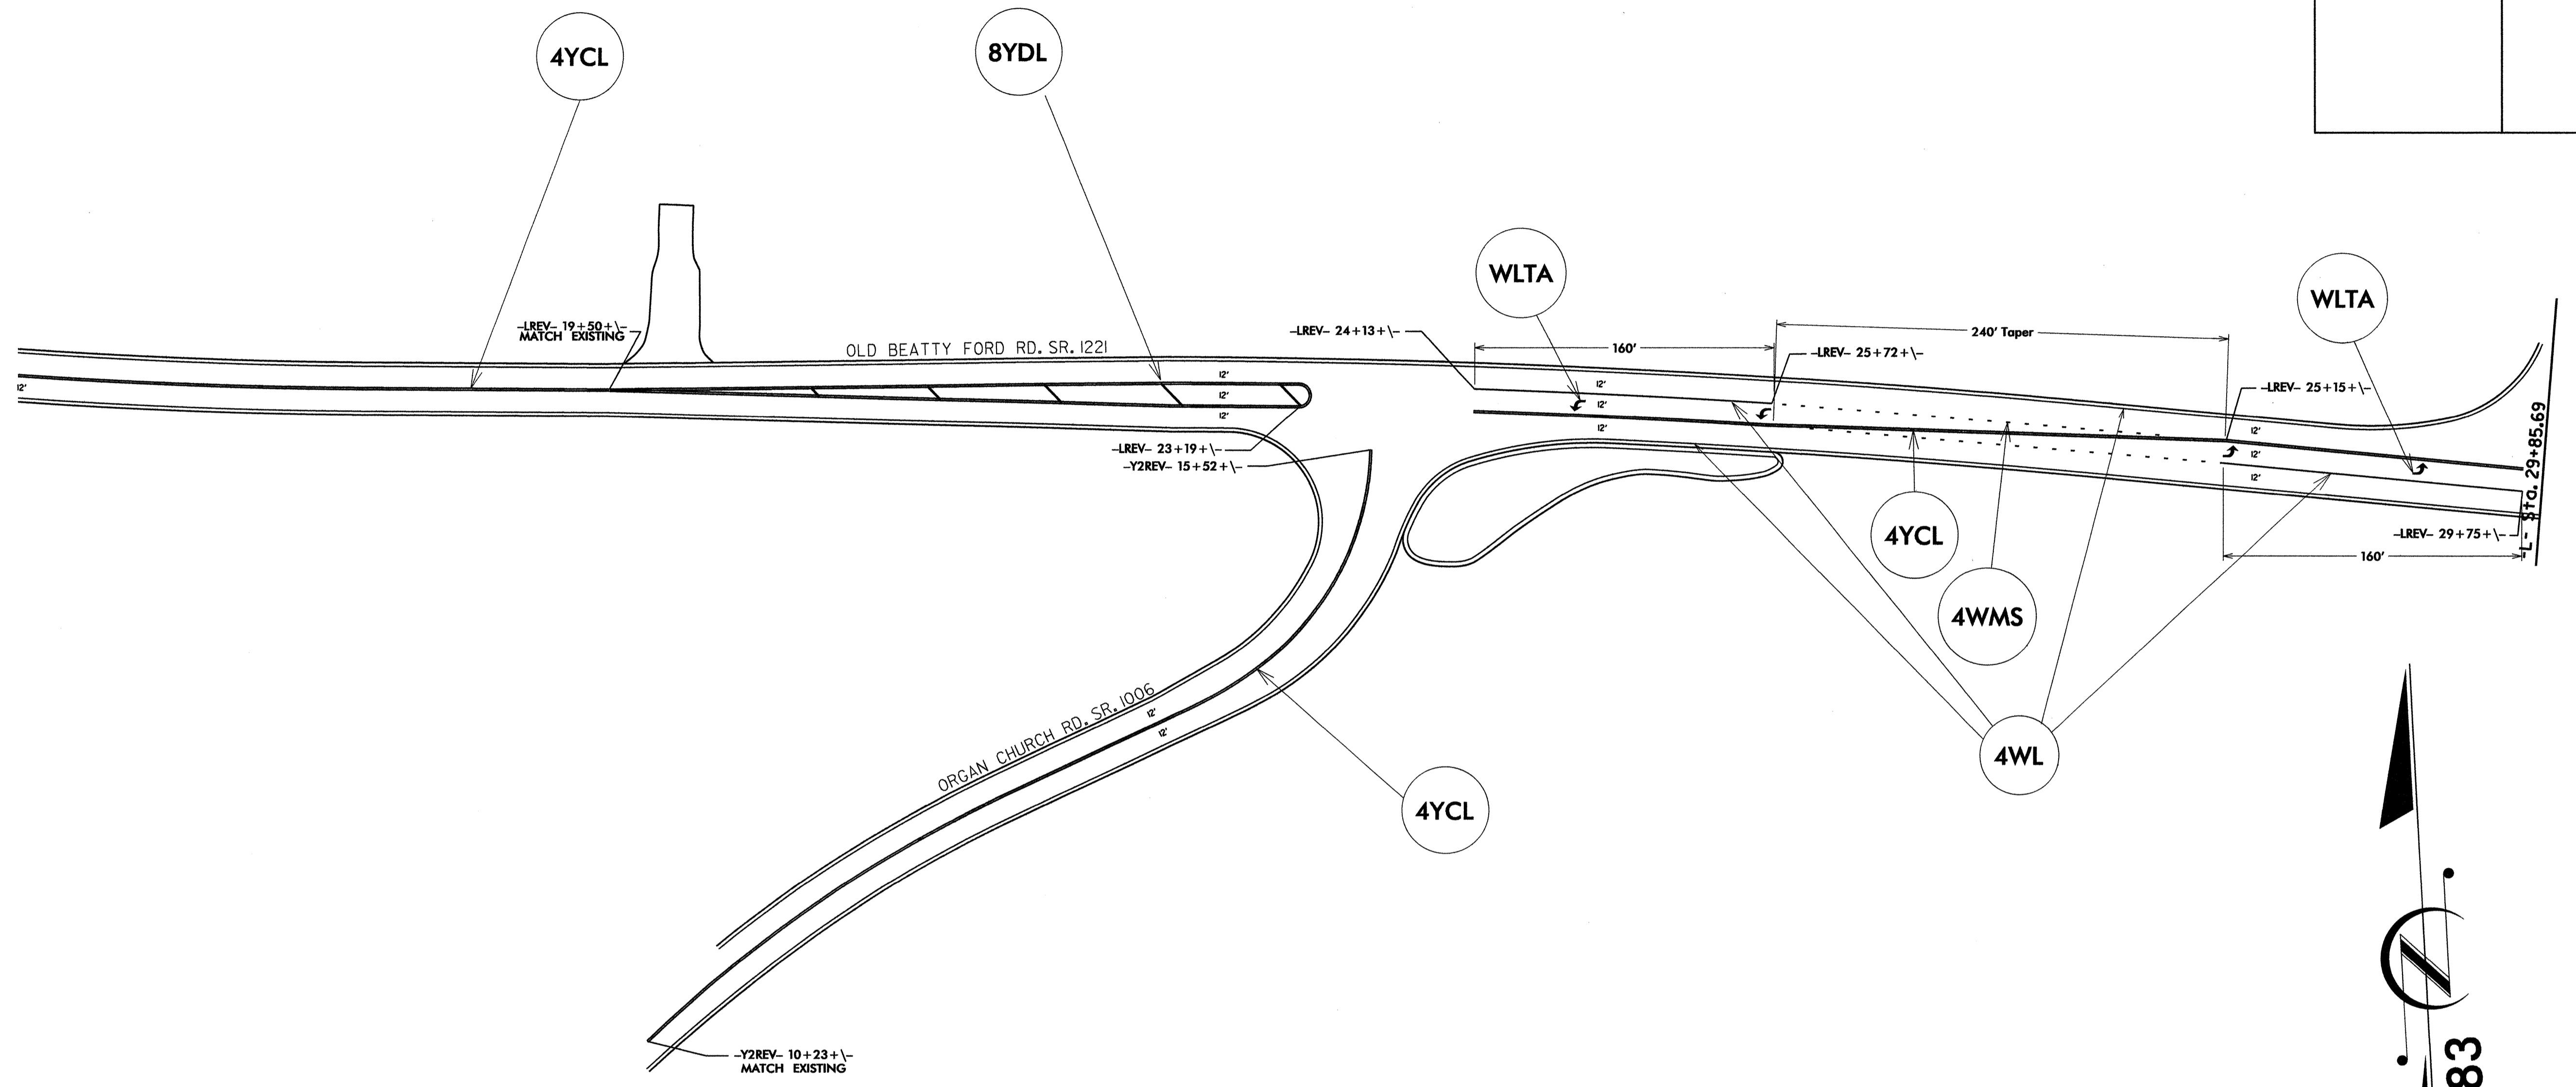

REVISIONS


Legend	
4YCL	- 4" Yellow Center Line 4" spacing
4WL	- 4" White Lane Line
4WMS	- 4" White 3' - 9" SP Mini Skip Line
8YDL	- 8" Yellow Diagonal Line
WLTA	- White Left Turn Arrow

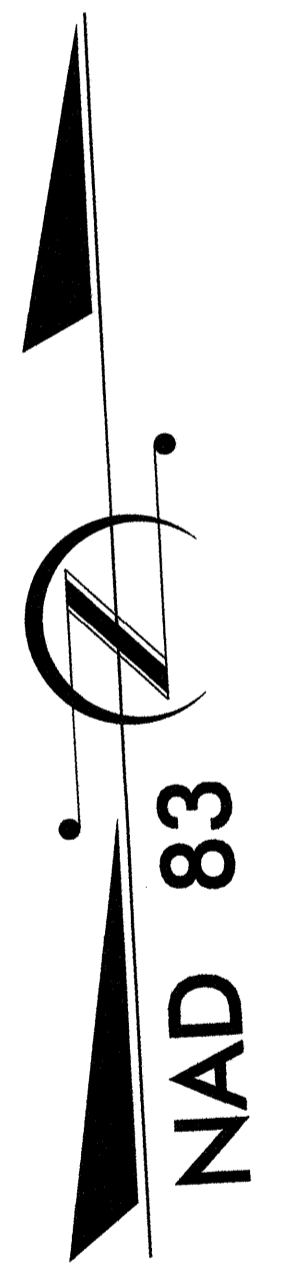

All Pavement Markings/Markers should adhere to the 2012 Standard Drawings

9/23/10
 30-JUL-2012 11:29
 S:\DDC\2810 01.dwg
 Beatty Ford, Organ Ch.W-5146_Rdy-pvmarkings-psh4.dgn
 Al DDC 2810 38

PROJECT REFERENCE NO.	SHEET NO.
	PM-2
SHEET NO.	
DIVISION TRAFFIC ENGINEER	

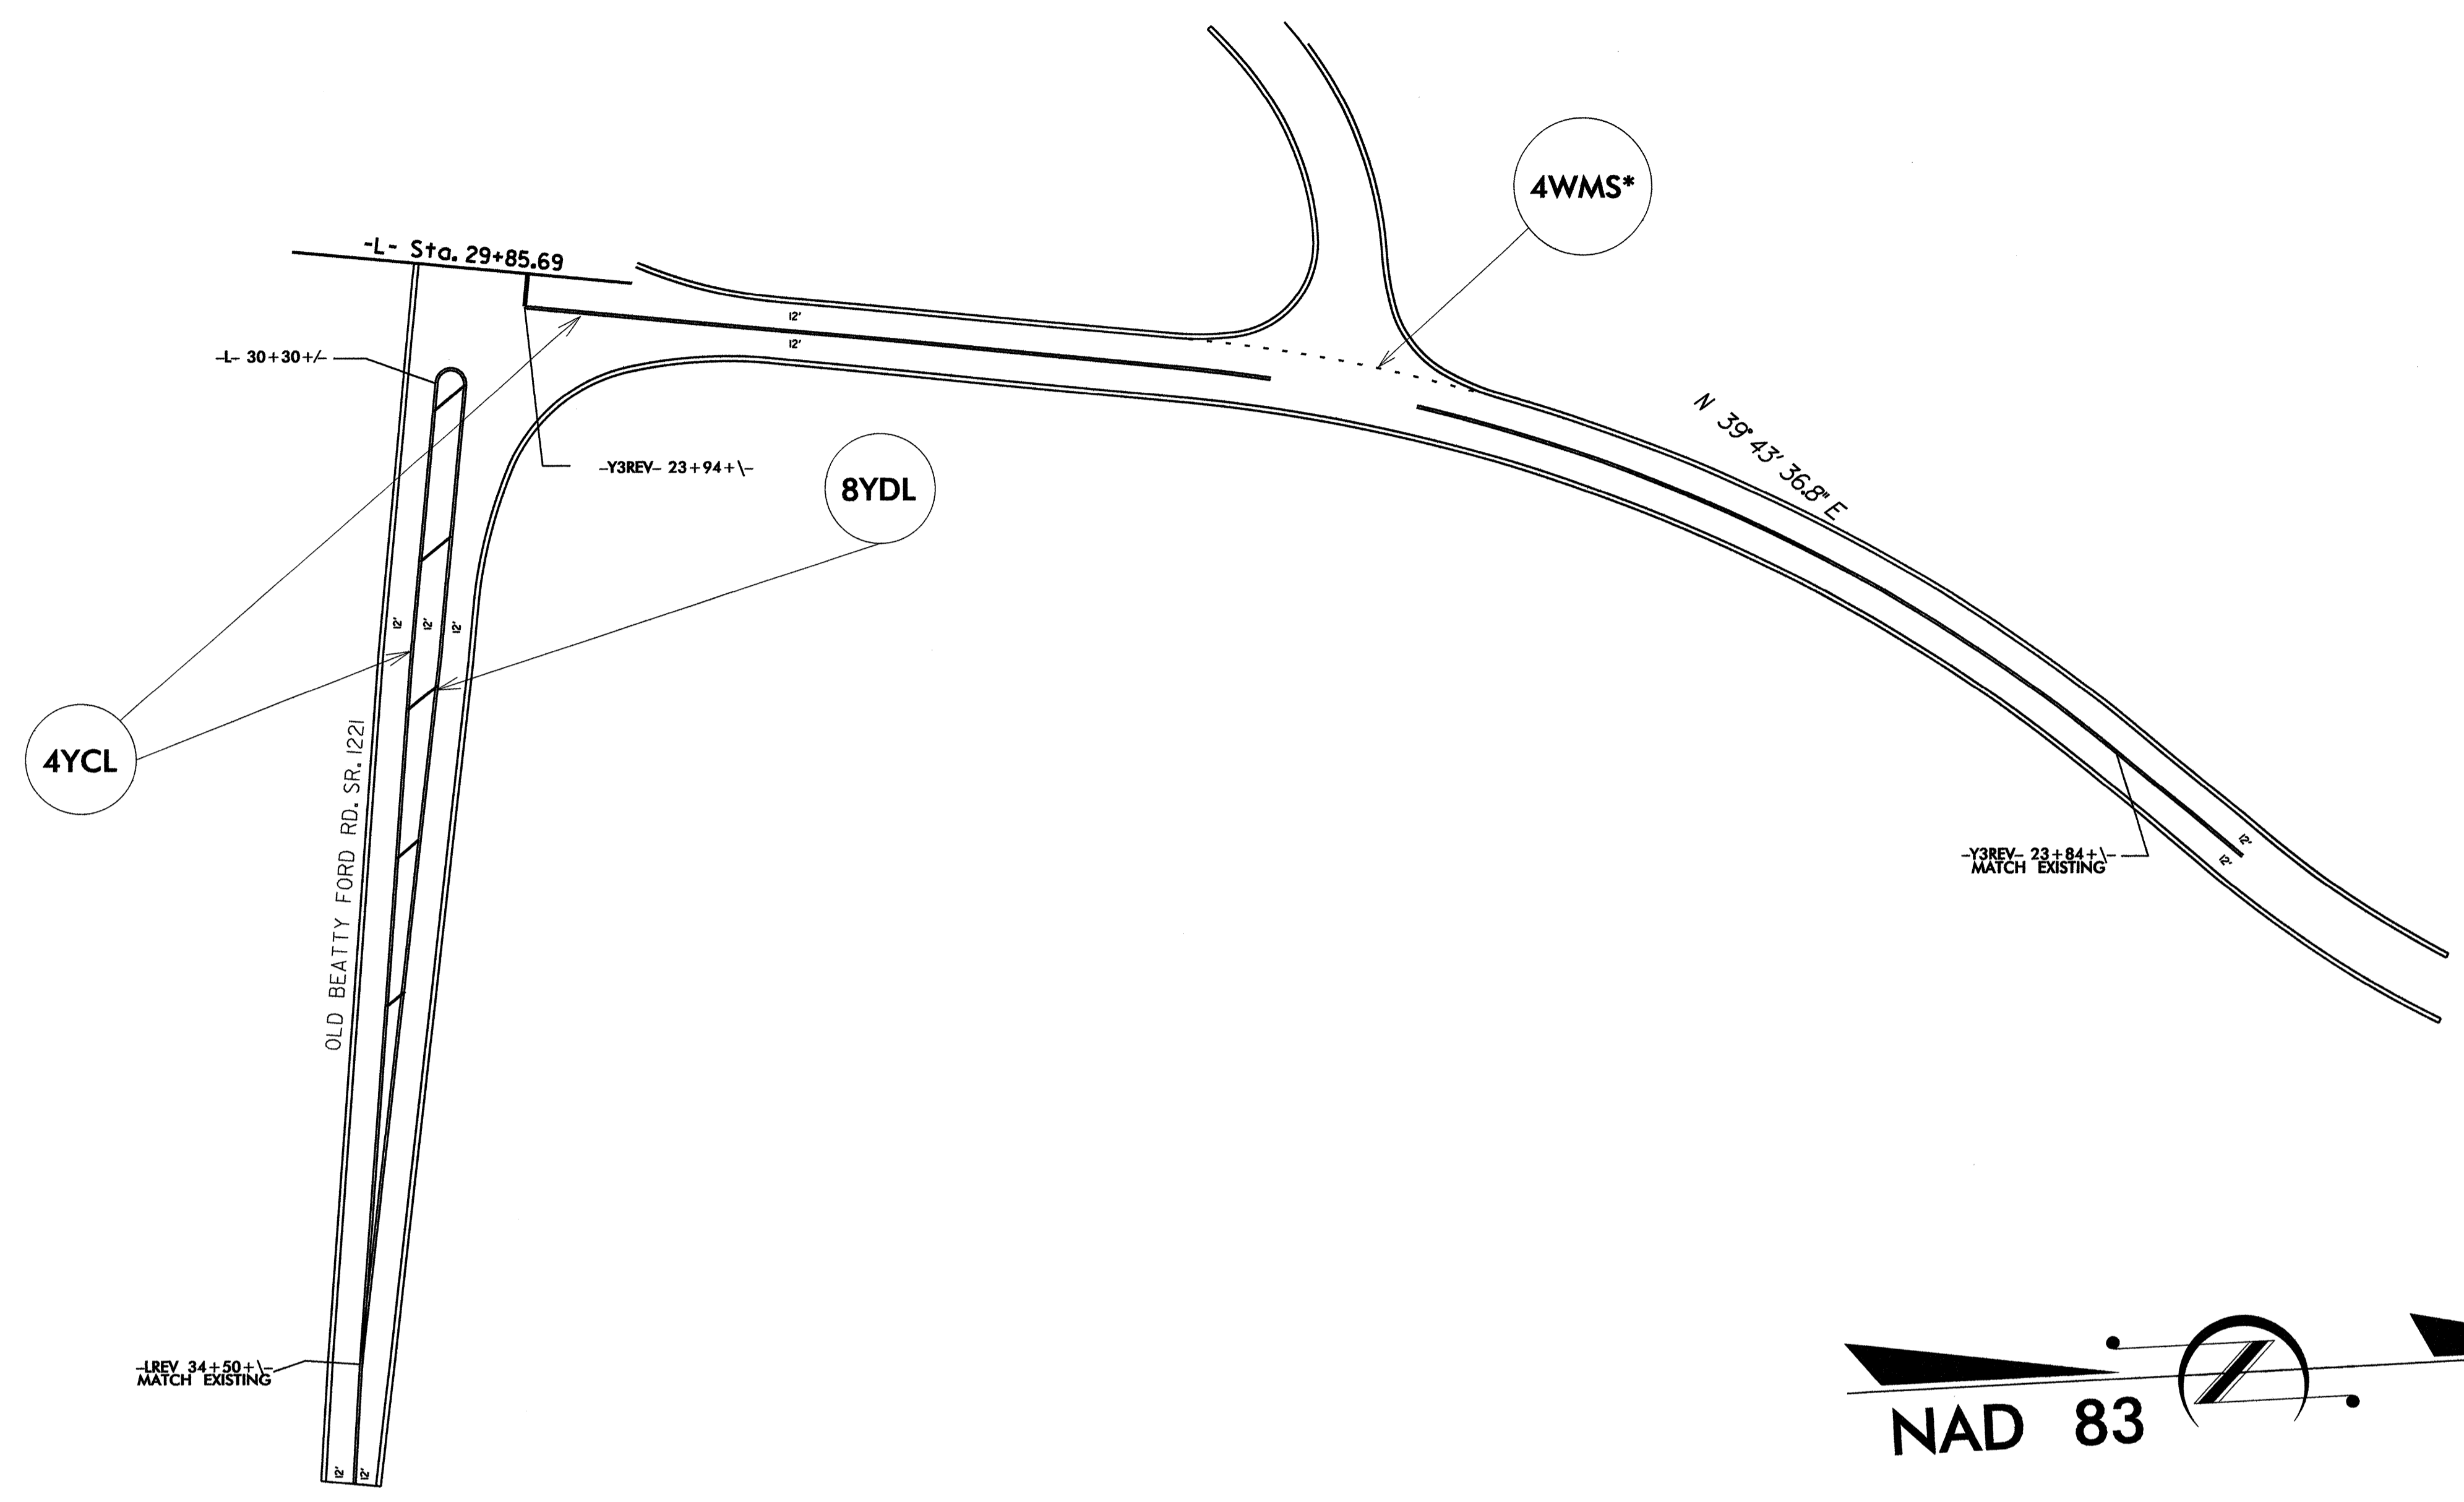

Legend	
4YCL	- 4" Yellow Center Line 4" spacing
4WL	- 4" White Lane Line
4WMS*	- 4" White 2' - 6'/SP Mini Skip Line
8YDL	- 8" Yellow Diagonal Line

All Pavement Markings/Markers should adhere to the 2012 Standard Drawings

REVISIONS

8/17/99
 30-JUL-2012 11:20 BeatyFord_Origan_Ch.W-5146_rdy-pvmarkings-pah5.dgn
 S:\DB\2010 Old Road\AL\5146\25838