


5/2/2013 K:\PAL\_Roadway\01746003 (Berkeley Blvd)\Plan\WaterSewer\01746003\_Luc01-A.dgn

**TIP PROJECT: U-3609A**

**CONTRACT: C202603**

T.I.P. NO.	SHEET NO.
U-3609A	UC-1



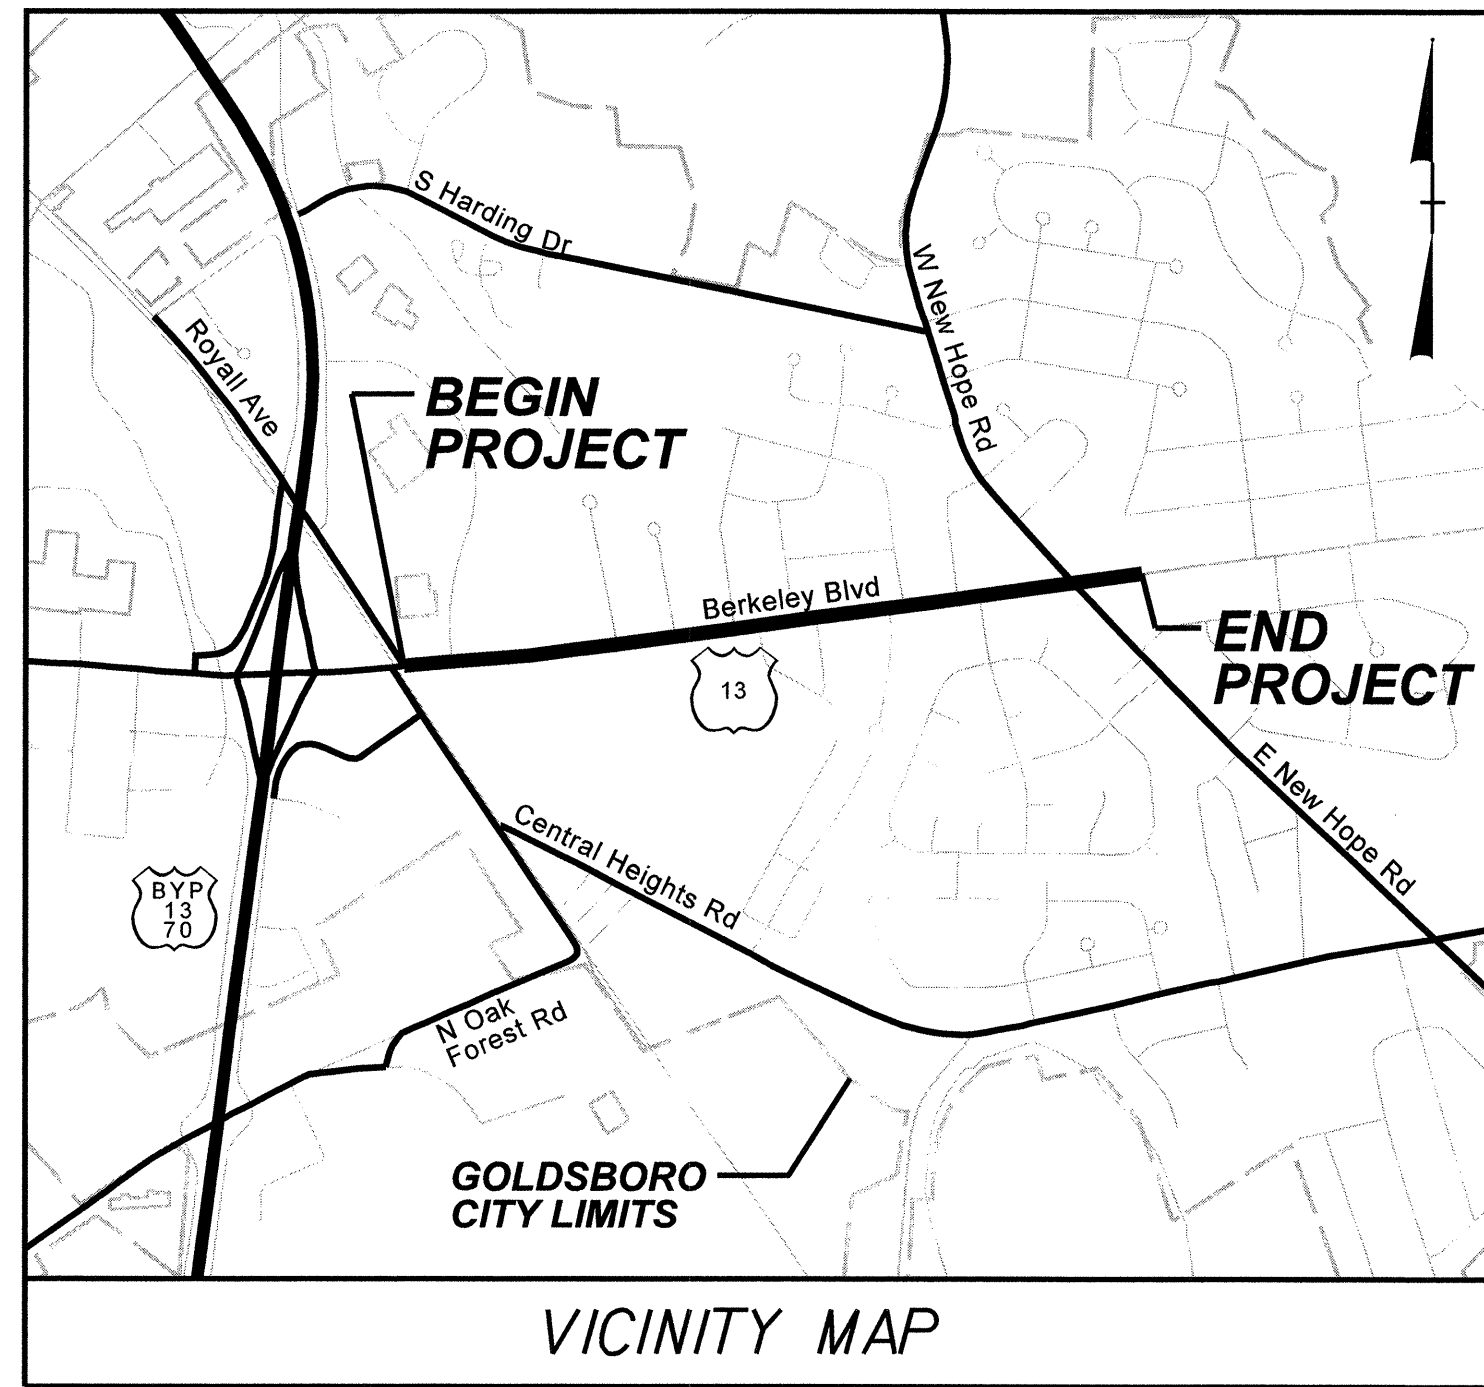


STATE OF NORTH CAROLINA  
DIVISION OF HIGHWAYS


**UTILITY CONSTRUCTION PLANS  
WAYNE COUNTY**

**LOCATION: US 13 (BERKELEY BOULEVARD) FROM ROYALL AVENUE  
TO SOUTH DRIVE**

**TYPE OF WORK: GRADING, DRAINAGE, PAVING AND CULVERT**

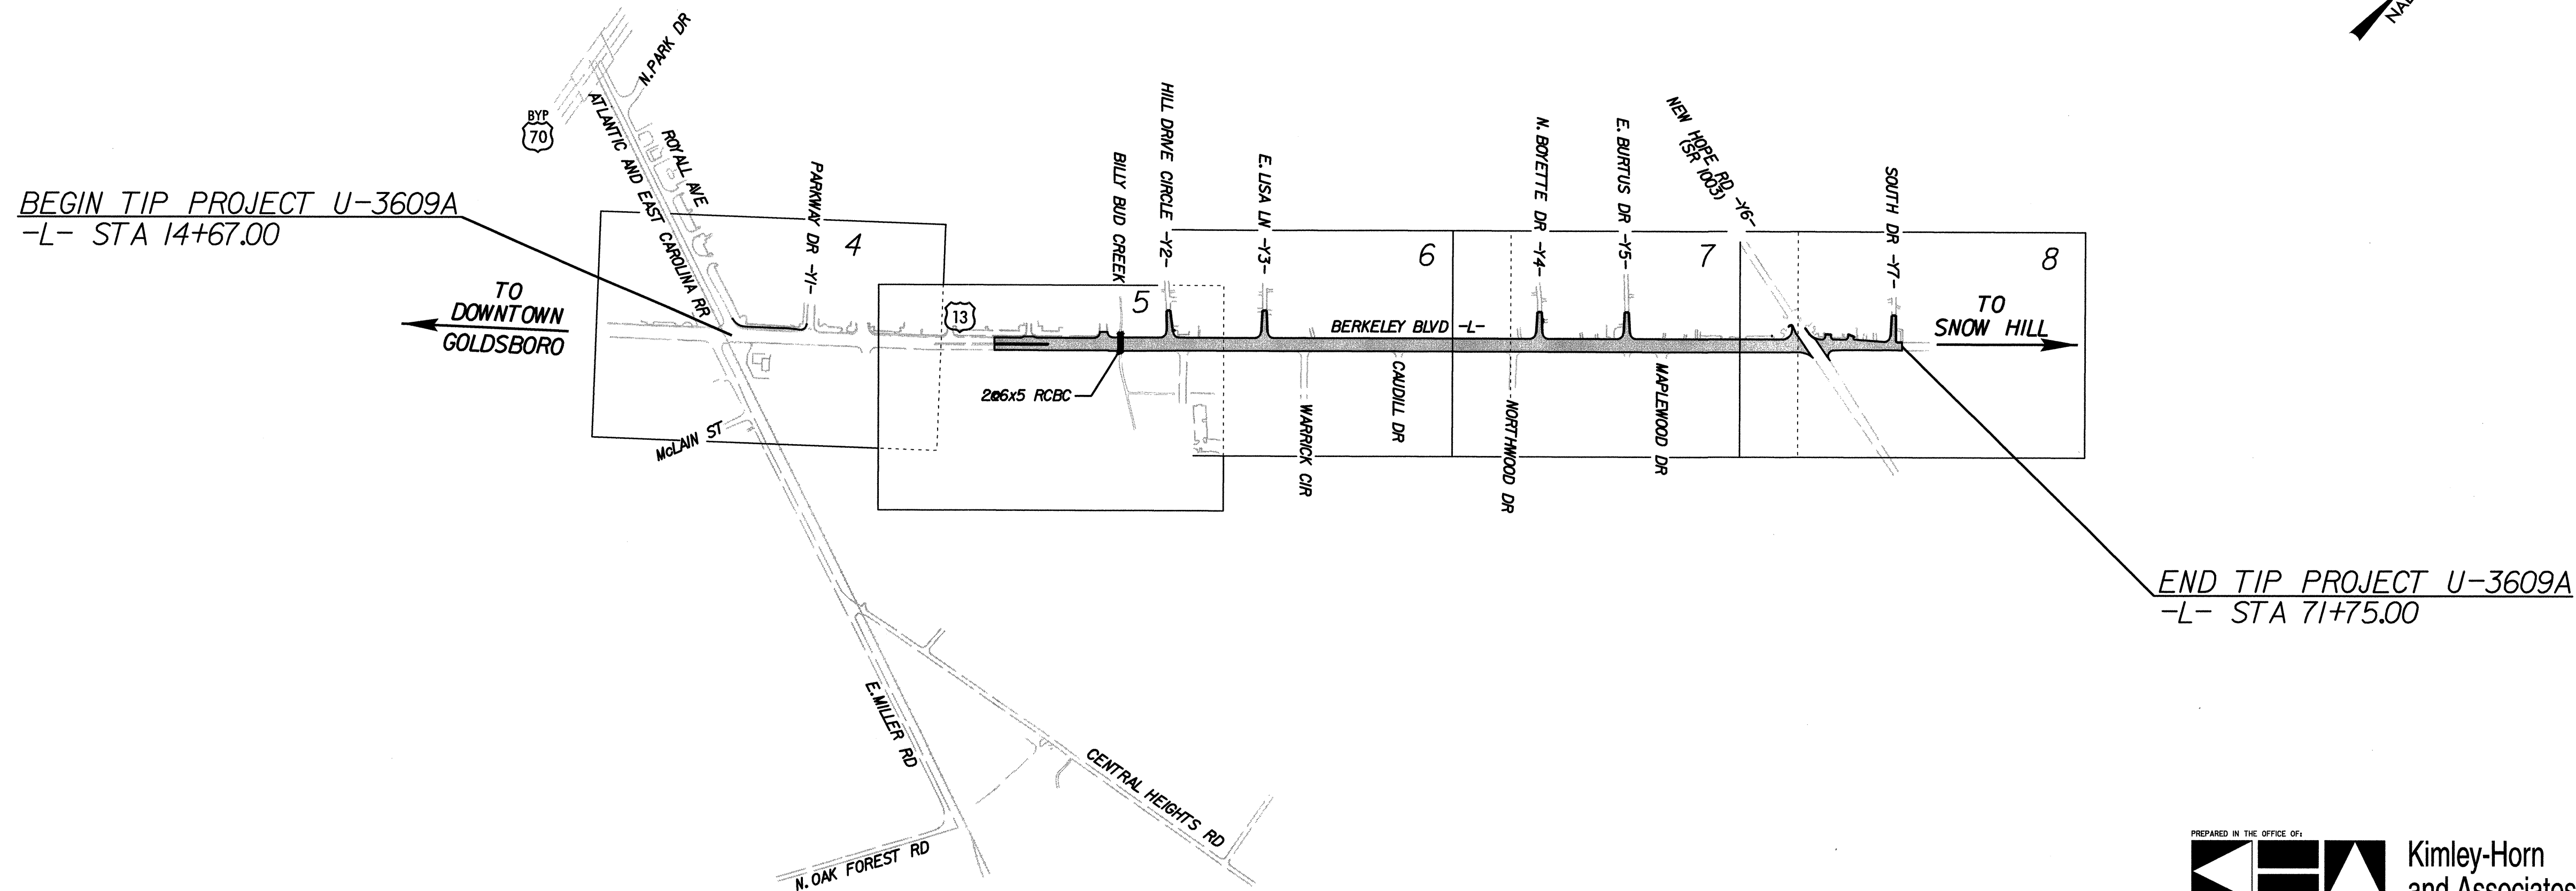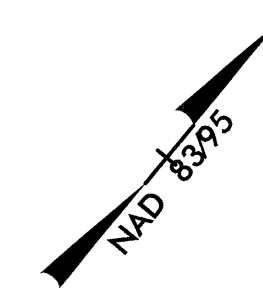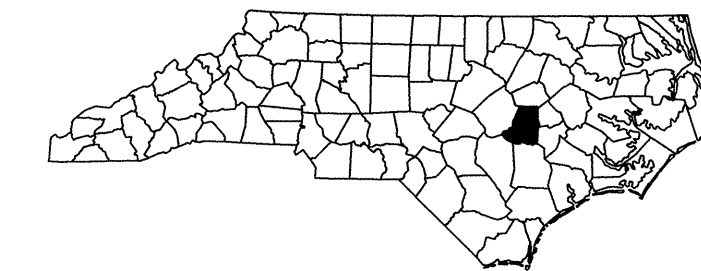

PREPARED IN THE OFFICE OF:  
**Kimley-Horn and Associates, Inc.**  
P.O. BOX 33068 - RALEIGH, NORTH CAROLINA 27636-3068  
PHONE: (919) 677-2000 FAX: (919) 677-2050 PE NO. F-0102

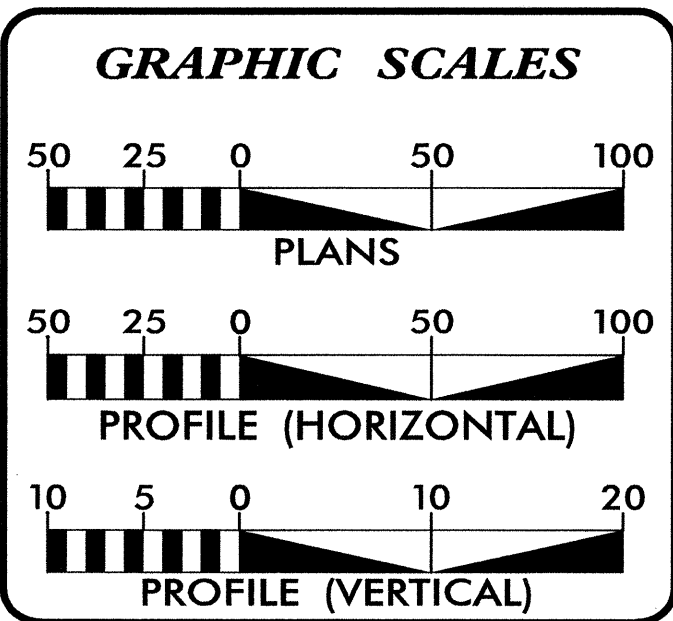

**INDEX OF SHEETS**

SHEET NO.	DESCRIPTION
UC-1A	TITLE SHEET
UC-1	PLAN SHEET
UC-2	PLAN SHEET
UC-3	PLAN AND PROFILE SHEET
UC-4	PLAN AND PROFILE SHEET
UC-5	PLAN SHEET
UC-6	DETAIL SHEET

**WATER AND SEWER OWNERS ON PROJECT**

(1) WATER/SEWER - CITY OF GOLDSBORO PUBLIC UTILITIES



PREPARED IN THE OFFICE OF:  
**DIVISION OF HIGHWAYS  
UTILITIES UNIT  
UTILITIES ENGINEERING**

1591 MAIL SERVICES CENTER  
RALEIGH NC 27699-1591  
PHONE (919) 707-6690  
FAX (919) 250-4151

**Roger Worthington, P.E.** UTILITIES SECTION ENGINEER  
**Ron Wilkins, P.E.** UTILITIES SQUAD LEADER PROJECT ENGINEER