


USE FOR LIGHTING CONSTRUCTION ONLY

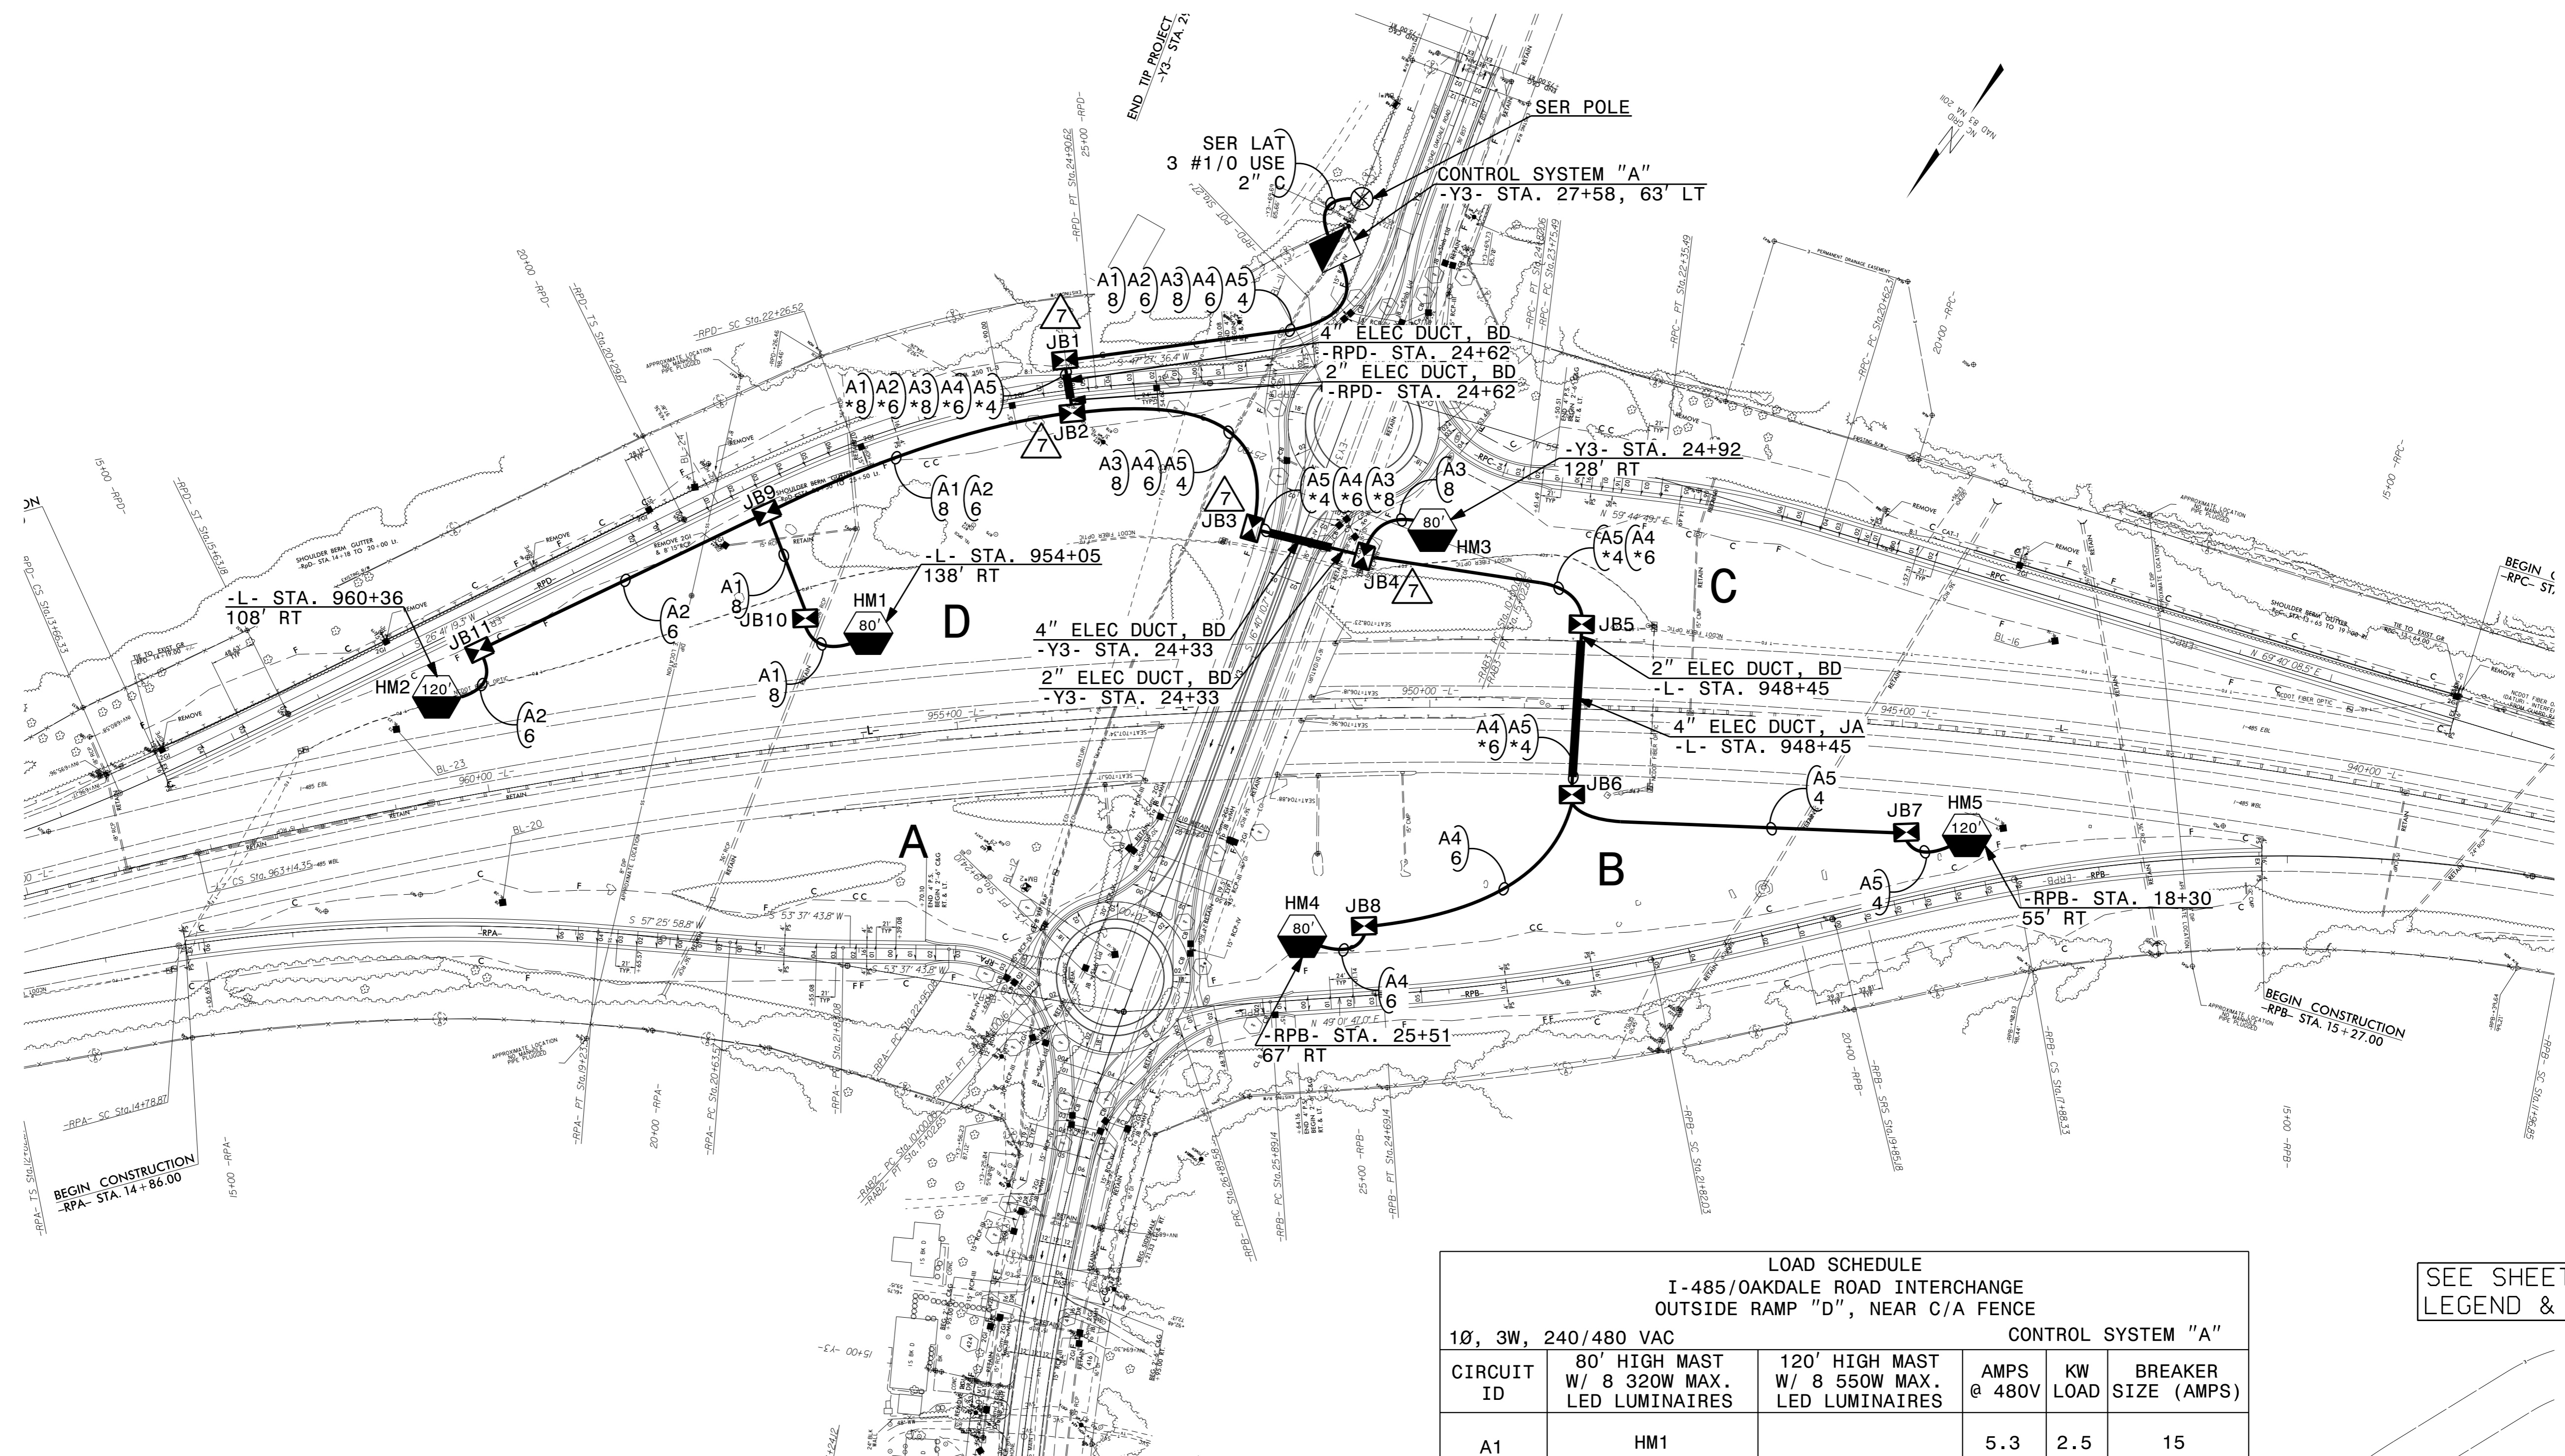

LOAD SCHEDULE
I-485/OAKDALE ROAD INTERCHANGE
OUTSIDE RAMP "D", NEAR C/A FENCE
CONTROL SYSTEM "A"

CIRCUIT ID	80' HIGH MAST W/ 8 320W MAX. LED LUMINAIRES	120' HIGH MAST W/ 8 550W MAX. LED LUMINAIRES	AMPS @ 480V	KW LOAD	BREAKER SIZE (AMPS)
A1	HM1		5.3	2.5	15
A2		HM2	8.8	4.2	15
A3	HM3		5.3	2.5	15
A4	HM4		5.3	2.5	15
A5		HM5	8.8	4.2	15
SPARE					15
TOTAL	3	2	33.5	15.9	

SEE SHEET "E1" FOR LEGEND & △ NOTES

2			
1			
Rev.	Date	Description	Approved
NORTH CAROLINA DEPARTMENT OF TRANSPORTATION ROADWAY DESIGN LIGHTING/ELECTRICAL SECTION LIGHTING LAYOUT I-485/OAKDALE ROAD INTERCHANGE MECKLENBURG COUNTY			
Drawn By:	RGH	Approved By:	PC
Dwg No.:			

09-MAR-2015 16:48
 R:\Lighting\I-485\Lighting Design\R2248G.le_PSH.E2.dgn
 rghal AT RDS78044