


TIP PROJECT: R-2248G


STATE OF NORTH CAROLINA
DIVISION OF HIGHWAYS

T.I.P. NO.	SHEET NO.
R-2248G	UC-1

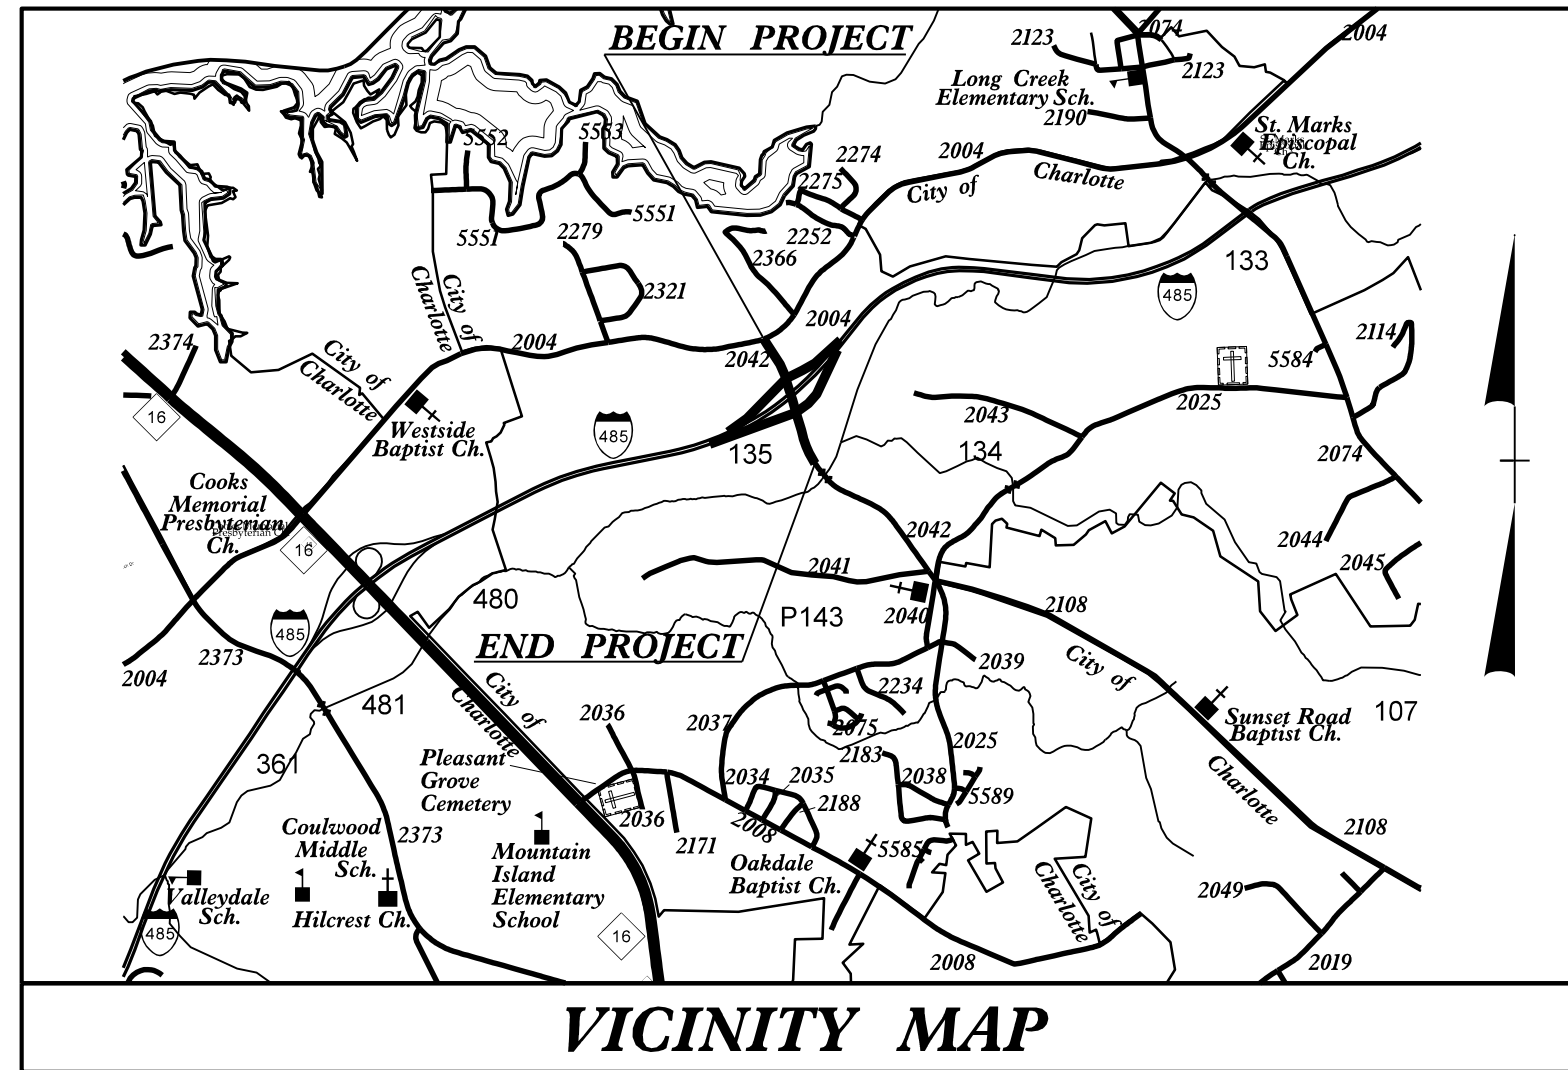


UTILITY CONSTRUCTION PLANS MECKLENBURG COUNTY

**LOCATION: I-485 CHARLOTTE OUTER LOOP INTERCHANGE WITH
SR 2042 (OAKDALE ROAD)**
**TYPE OF WORK: WATER SERVICE AND FIRE HYDRANT
RELOCATIONS**

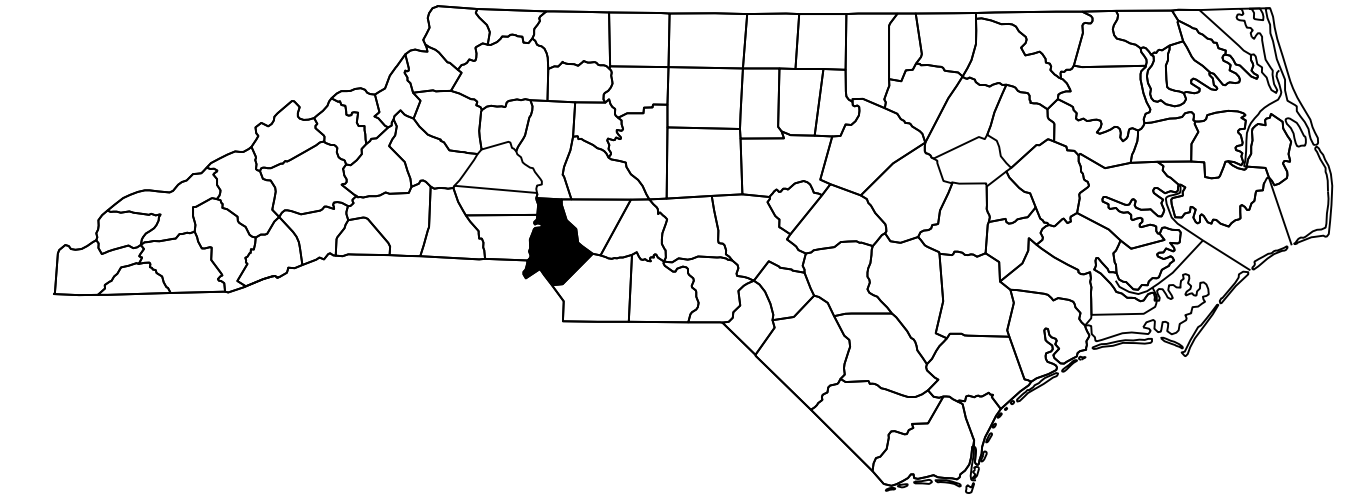

BEGIN TIP PROJECT R-2248G
-Y3- STA. 9+67.23

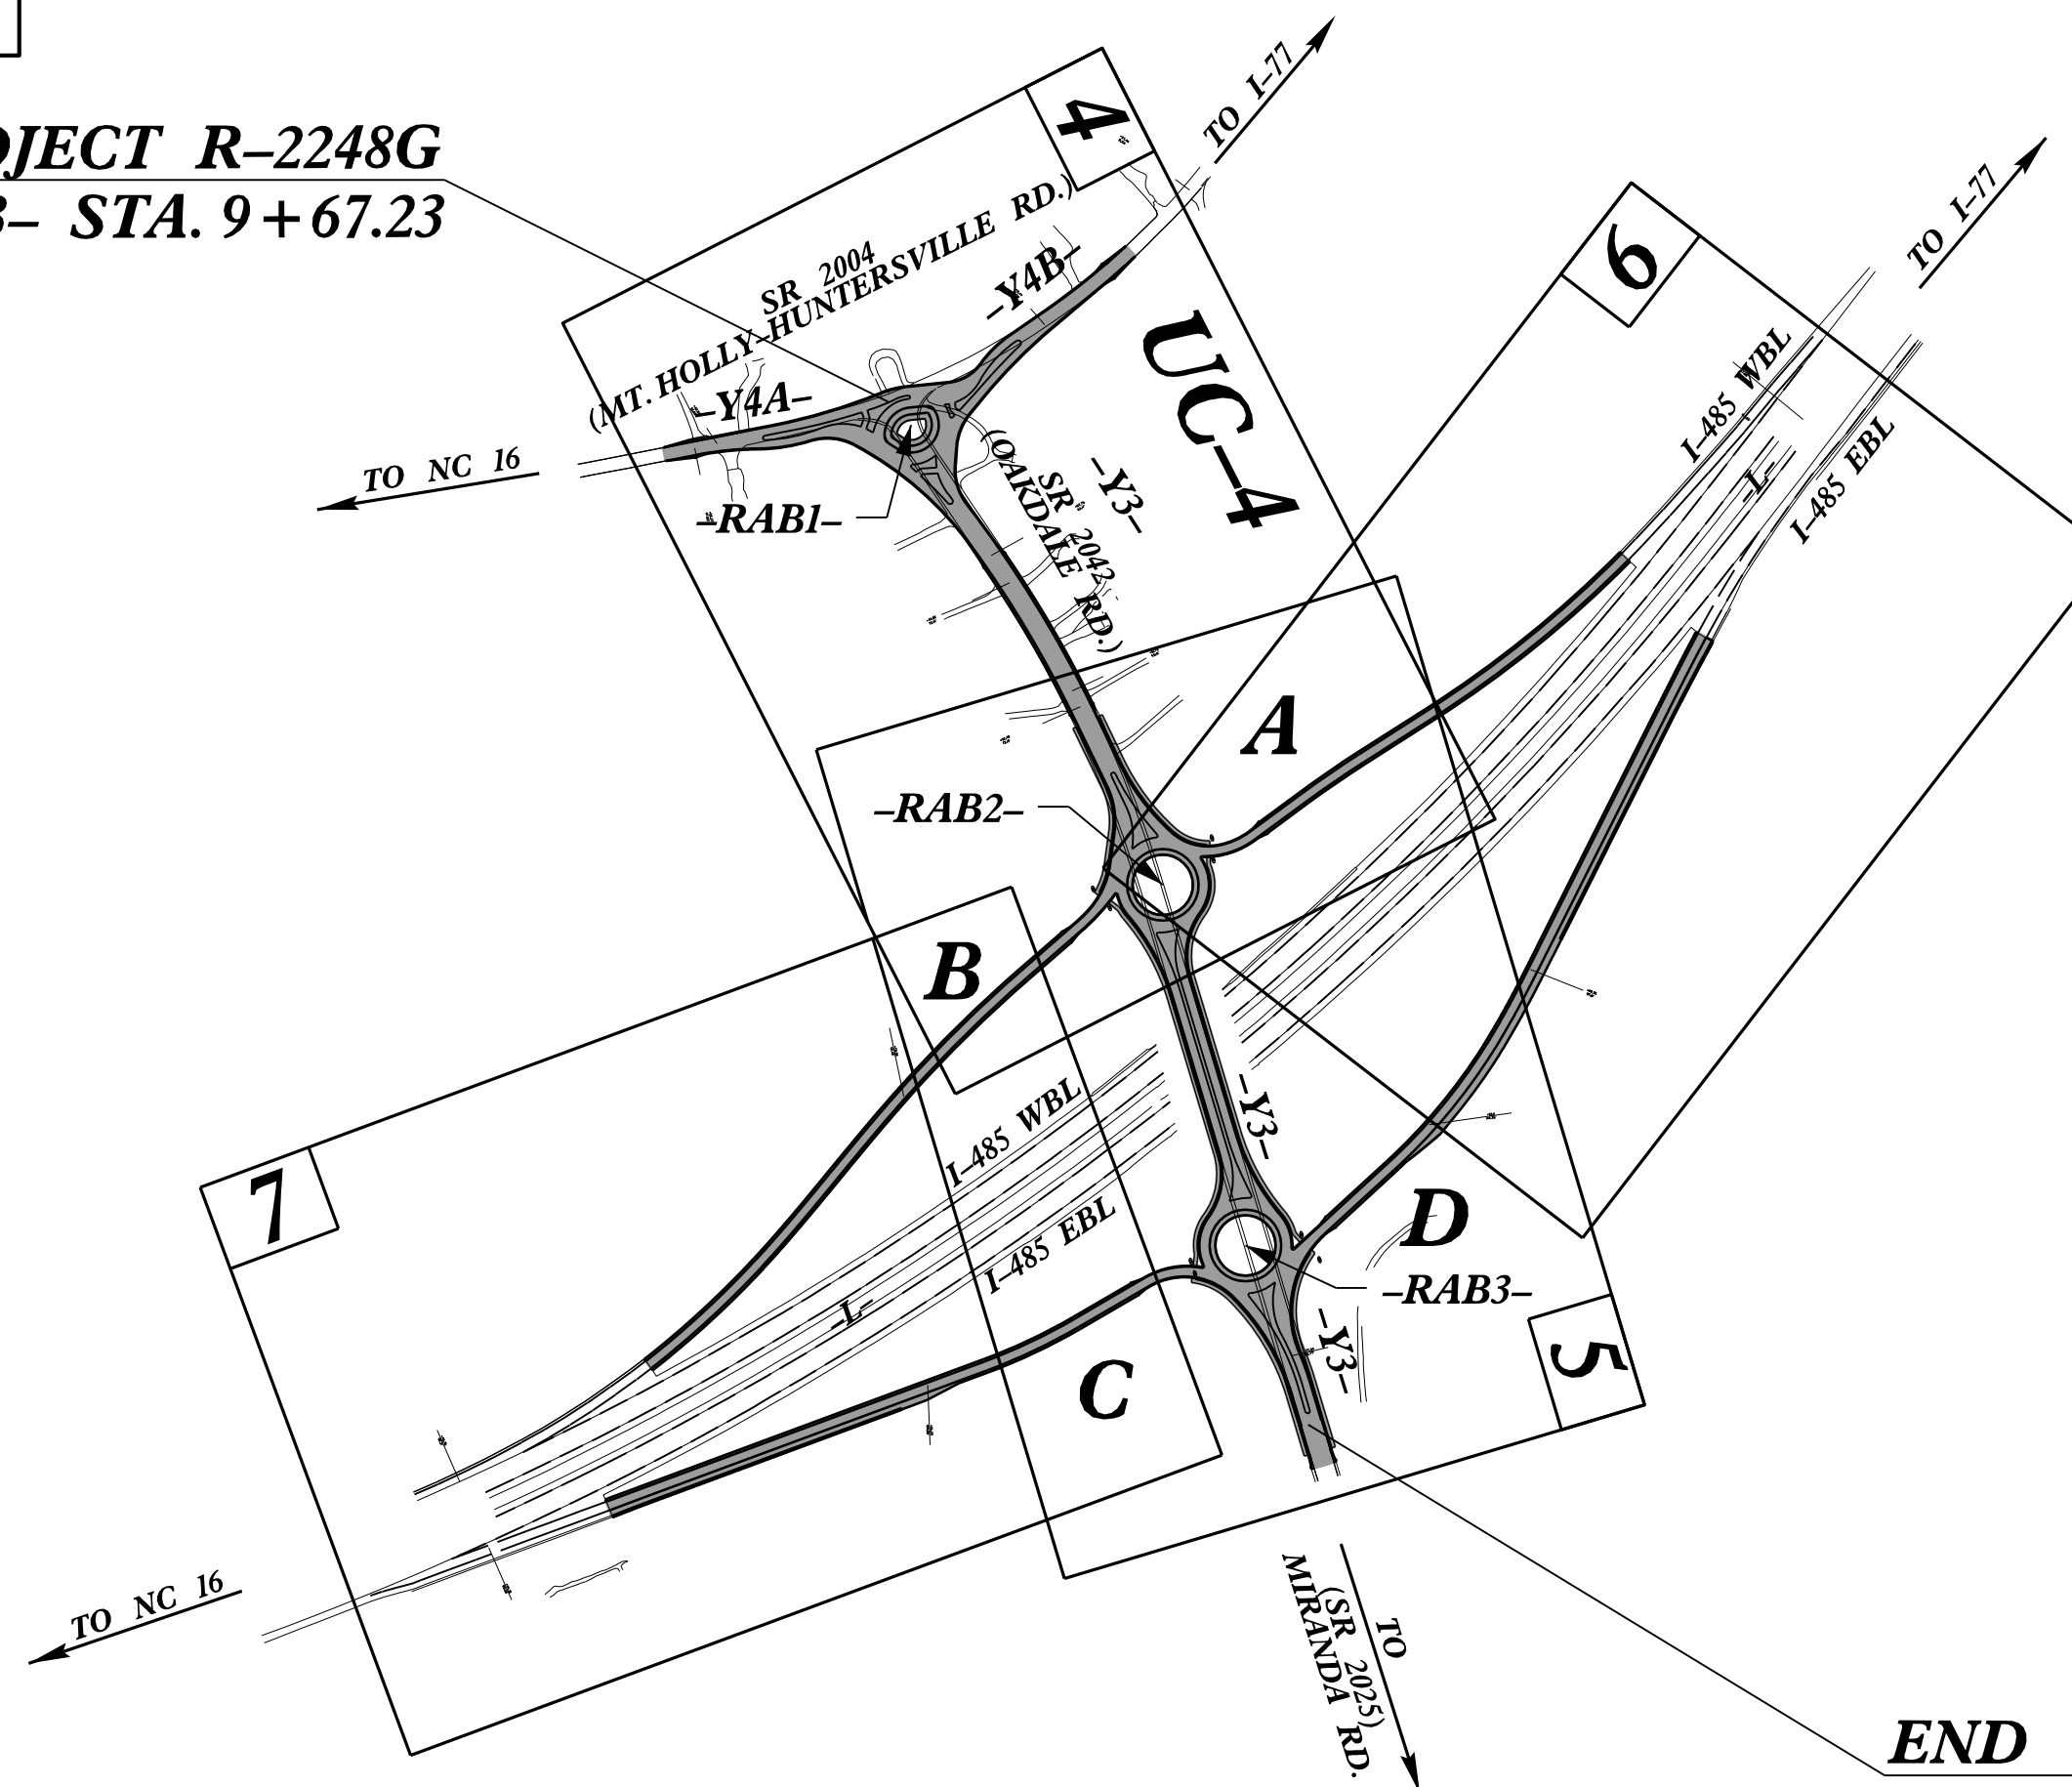


END TIP PROJECT R-2248G
-Y3- STA. 29+00.00

NAD 83/NA 2011

CLEARING ON THIS PROJECT SHALL BE PERFORMED TO THE LIMITS ESTABLISHED BY METHOD ____.
THIS PROJECT IS NOT WITHIN ANY MUNICIPAL BOUNDARIES.

GRAPHIC SCALES

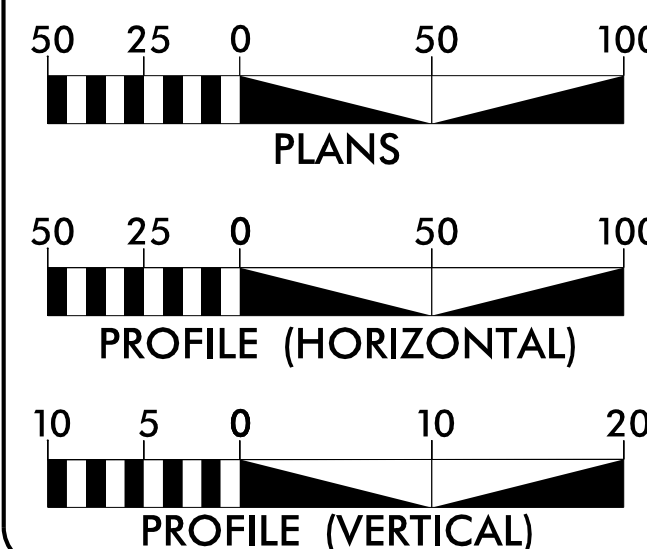

INDEX OF SHEETS

SHEET NO.	DESCRIPTION
UC-1	TITLE SHEET
UC-2	SYMBOLGY SHEET
UC-3	GENERAL NOTES SHEET
UC-3A THRU UC-3C	DETAIL SHEETS
UC-4	UTILITY PLAN SHEET

WATER AND SEWER OWNERS ON PROJECT

(1) WATER - CHARLOTTE WATER

HINDE ENGINEERING
License No. C-2639
7520 E. Independence Blvd., Suite 230 Charlotte, NC 28227

PREPARED IN THE OFFICE OF:
**DIVISION OF HIGHWAYS
UTILITIES UNIT
UTILITIES ENGINEERING**

1555 MAIL SERVICES CENTER
RALEIGH NC 27699-1555
PHONE (919) 707-6690
FAX (919) 250-4151

Roger Worthington, P.E. UTILITIES SECTION ENGINEER
Carl Barclay, P.E. UTILITIES SQUAD LEADER PROJECT ENGINEER
Bo Hemphill, P.E. UTILITIES PROJECT DESIGN ENGINEER
Corey Bousquet, P.E. HINDE ENGINEERING PROJECT MANAGER