
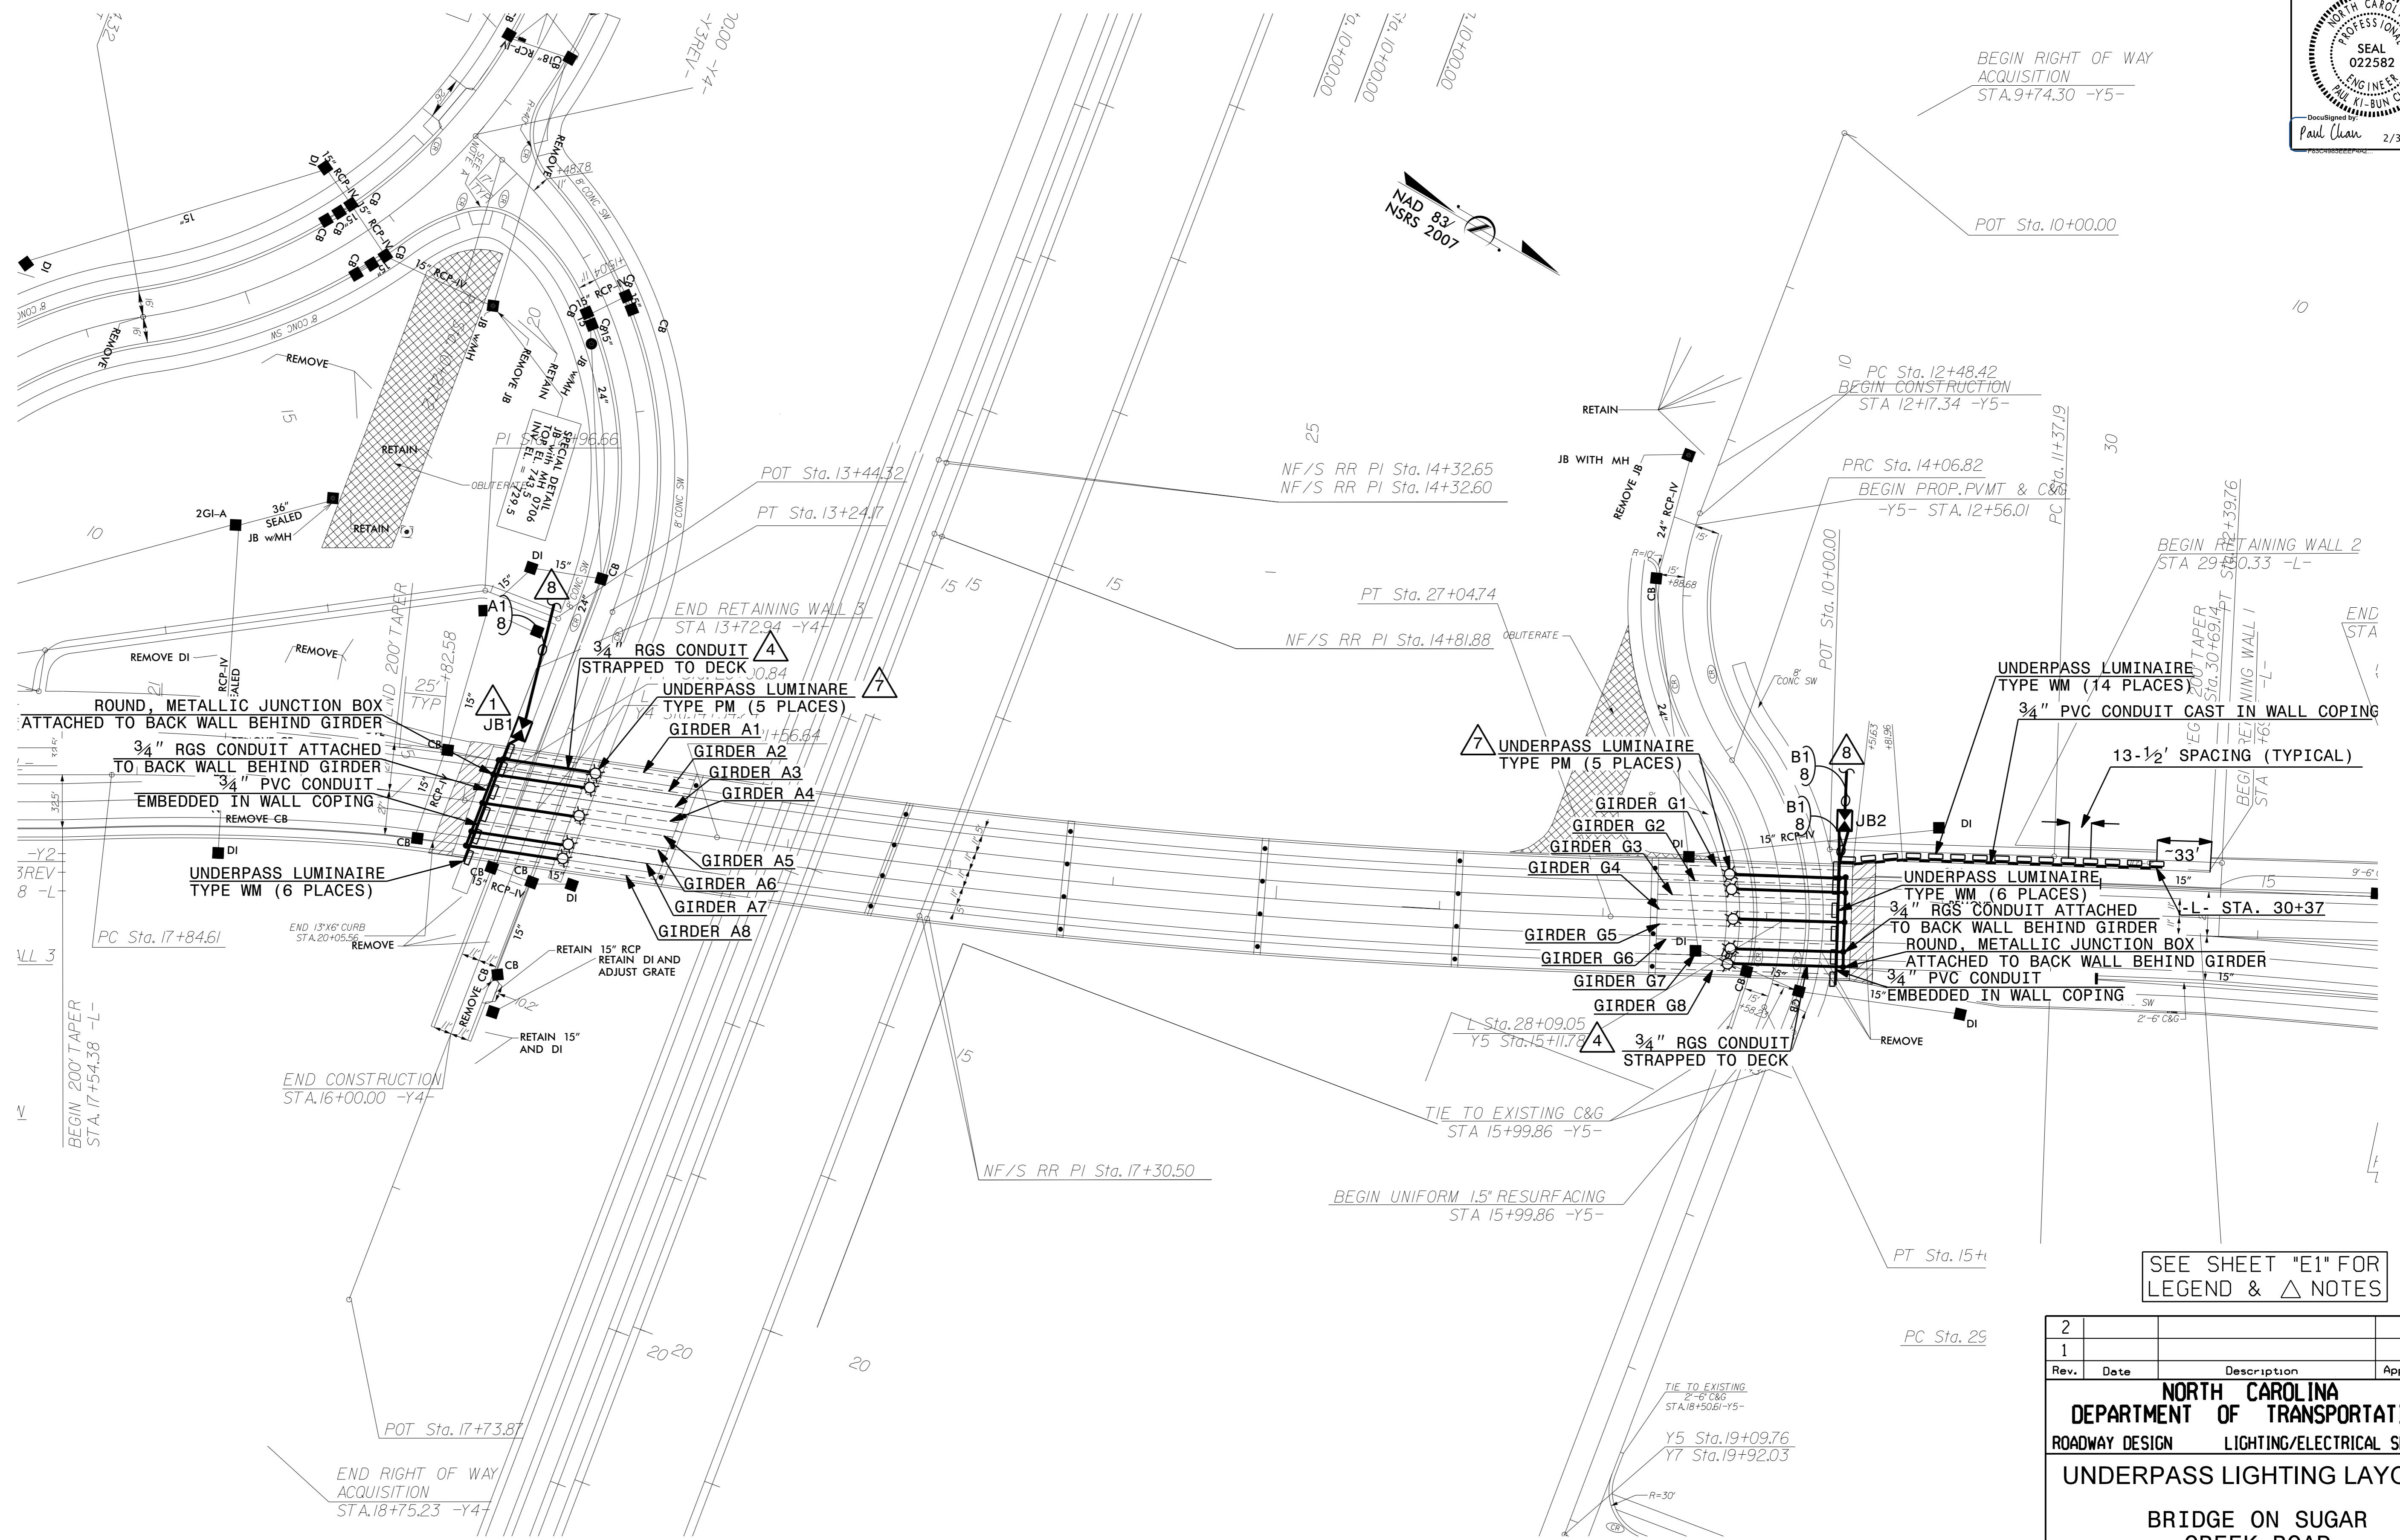


USE FOR LIGHTING CONSTRUCTION ONLY

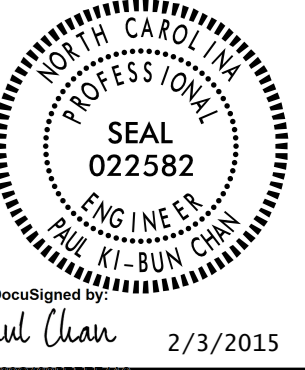

SEE SHEET "E1" FOR LEGEND & △ NOTES

Rev.	Date	Description	Approved
2			
1			

**NORTH CAROLINA DEPARTMENT OF TRANSPORTATION**  
ROADWAY DESIGN LIGHTING/ELECTRICAL SECTION

**UNDERPASS LIGHTING LAYOUT**

**BRIDGE ON SUGAR CREEK ROAD**

MECKLENBURG COUNTY

Drawn By: RGH Approved By: PC Dwg No.:

03-FEB-2015 12:41 R:\Lighting\Lighting Design\U-5008\_LE\_PSH\_E2.dgn rghal AT-RD578044