


UTILITY PLAN SHEET UC-8 CORRESPONDS WITH ROADWAY PLAN SHEET 8

Rivers
& Associates, Inc.
107 East Second Street
Greenville, NC 27858 (252) 752-4135
6131 Falls of Neuse Road, Suite 300
Raleigh, NC 27615 (919) 848-3347
Engineers - Planners - Surveyors
NC License: F-0334

Kimley-Horn
and Associates, Inc.
P.O. BOX 33068
RALEIGH, N.C. 27636-3068

PROJECT REFERENCE NO. U - 3315	SHEET NO. UC - 8
DESIGNED BY: FDT /GJC	
DRAWN BY: JHT	
CHECKED BY: FDT /GJC	
APPROVED BY: FDT /GJC	REVISED: 3-31-15
NORTH CAROLINA DEPARTMENT OF TRANSPORTATION	
RIGHT-OF-WAY REV:	PROJECT SERVICES UNIT PHONE: (919) 250-4128 FAX: (919) 250-4119
CONSTRUCTION REV:	

REVISIONS

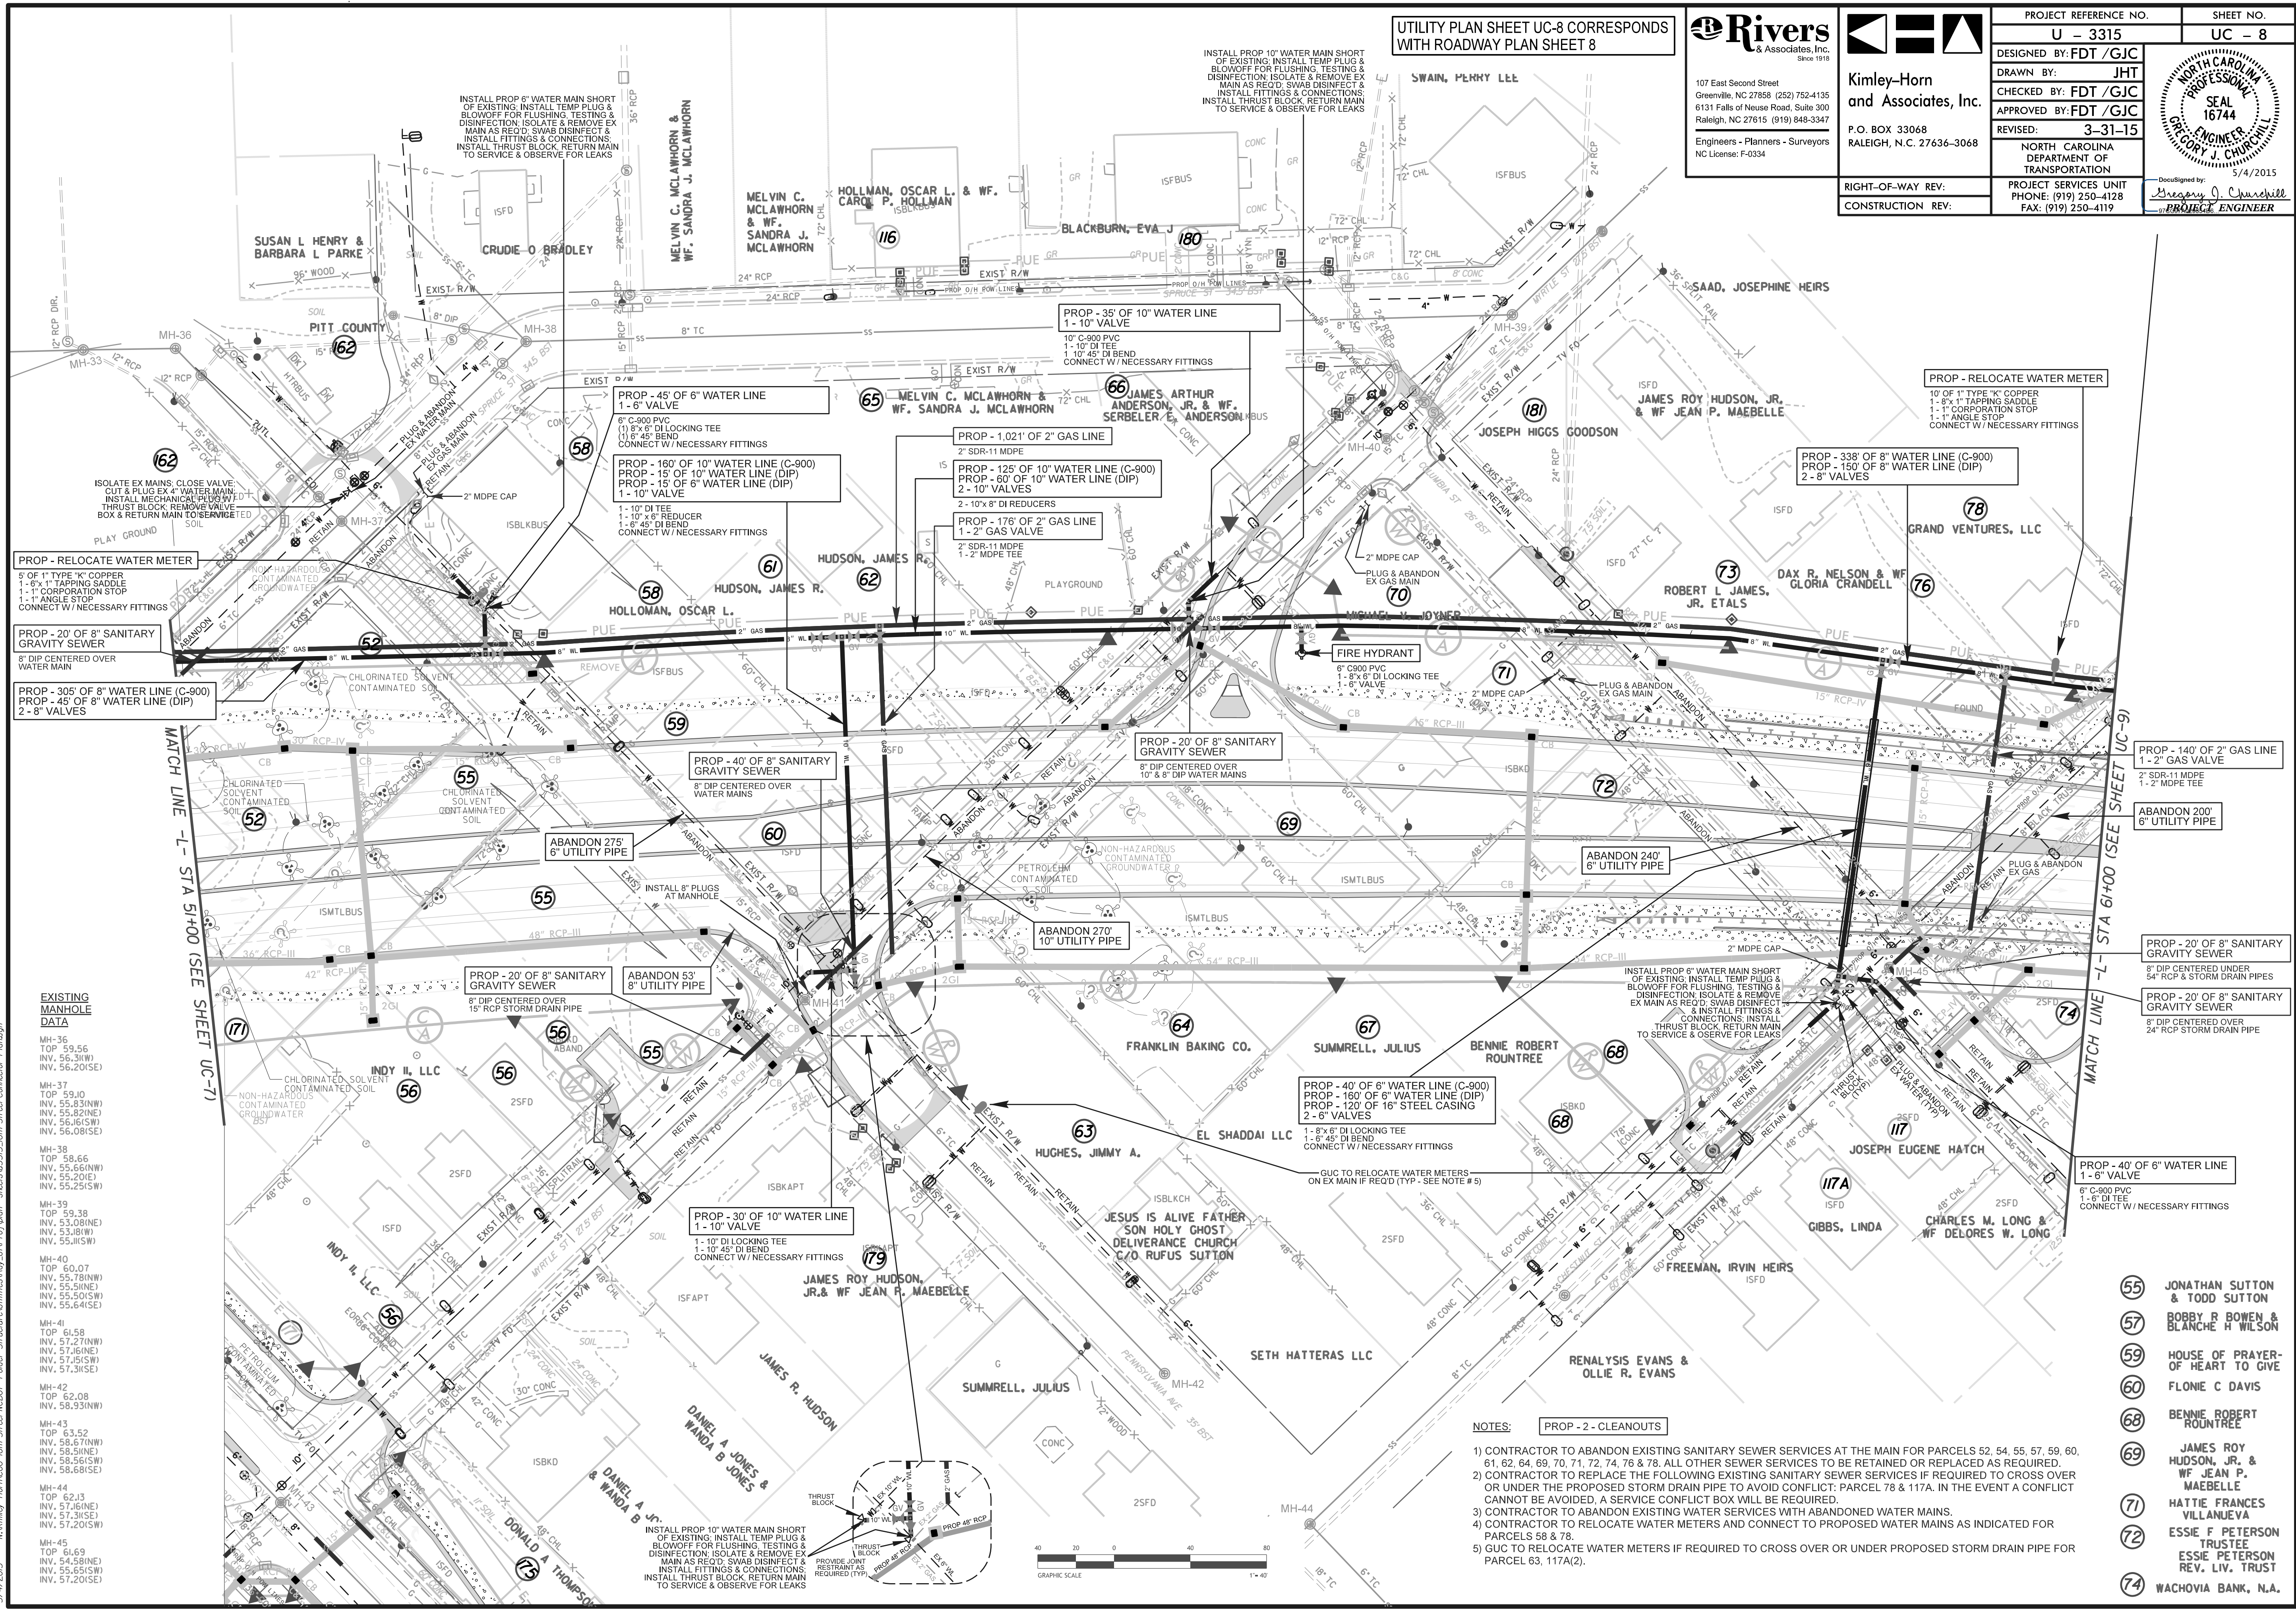

EXISTING MANHOLE DATA

MH-36	TOP 59.56	INV. 56.5(W)	INV. 56.20(SE)
MH-37	TOP 59.10	INV. 55.83(NW)	INV. 55.82(NE)
MH-38	TOP 58.66	INV. 55.56(NW)	INV. 55.25(SW)
MH-39	TOP 59.38	INV. 53.08(NE)	INV. 53.51(W)
MH-40	TOP 60.07	INV. 55.78(NW)	INV. 55.51(NE)
MH-41	TOP 61.58	INV. 57.27(NW)	INV. 57.35(SE)
MH-42	TOP 62.08	INV. 58.33(NW)	
MH-43	TOP 63.52	INV. 58.67(NW)	INV. 58.51(NE)
MH-44	TOP 62.13	INV. 57.16(NE)	INV. 57.31(SE)
MH-45	TOP 61.69	INV. 54.58(NE)	INV. 55.65(SW)

- NOTES:**
- CONTRACTOR TO ABANDON EXISTING SANITARY SEWER SERVICES AT THE MAIN FOR PARCELS 52, 54, 55, 57, 59, 60, 61, 62, 64, 69, 70, 71, 72, 74, 76 & 78. ALL OTHER SEWER SERVICES TO BE RETAINED OR REPLACED AS REQUIRED.
 - CONTRACTOR TO REPLACE THE FOLLOWING EXISTING SANITARY SEWER SERVICES IF REQUIRED TO CROSS OVER OR UNDER THE PROPOSED STORM DRAIN PIPE TO AVOID CONFLICT: PARCEL 78 & 117A. IN THE EVENT A CONFLICT CANNOT BE AVOIDED, A SERVICE CONFLICT BOX WILL BE REQUIRED.
 - CONTRACTOR TO ABANDON EXISTING WATER SERVICES WITH ABANDONED WATER MAINS.
 - CONTRACTOR TO RELOCATE WATER METERS AND CONNECT TO PROPOSED WATER MAINS AS INDICATED FOR PARCELS 58 & 78.
 - GUC TO RELOCATE WATER METERS IF REQUIRED TO CROSS OVER OR UNDER PROPOSED STORM DRAIN PIPE FOR PARCEL 63, 117A(2).
- 55 JONATHAN SUTTON & TODD SUTTON
 - 57 BOBBY R BOWEN & BLANCHE H WILSON
 - 59 HOUSE OF PRAYER-OF HEART TO GIVE
 - 60 FLONIE C DAVIS
 - 68 BENNIE ROBERT ROUNTREE
 - 69 JAMES ROY HUDSON, JR. & WF JEAN P. MAEBELLE
 - 71 HATTIE FRANCES VILLANUEVA
 - 72 ESSIE F PETERSON TRUSTEE
 - 74 WACHOVA BANK, N.A.

