


PROJECT REFERENCE NO. W-5103A	SHEET NO. 1C-4
RW SHEET NO.	

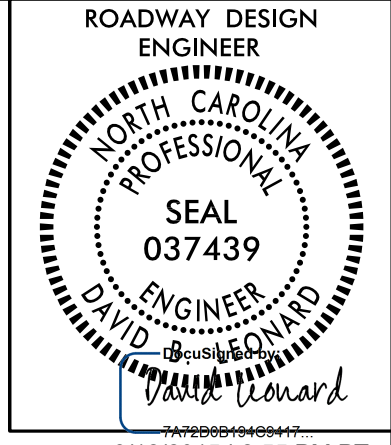

8/12/2015 | 2:55 PM PT


NAD 83/NSRS 2007

STATE OF NORTH CAROLINA
DIVISION OF HIGHWAYS
SURVEY CONTROL SHEET

8/17/99

REVISIONS

03 AUG 2015 12:47 PM HANDOVER\W-5103-41867-1.1.1.US 421 Median Crossover Relet (use this file)\ROADWAY\Proj\Plan_Sheets\W5103A-D03_RdJ-1C-4.dgn

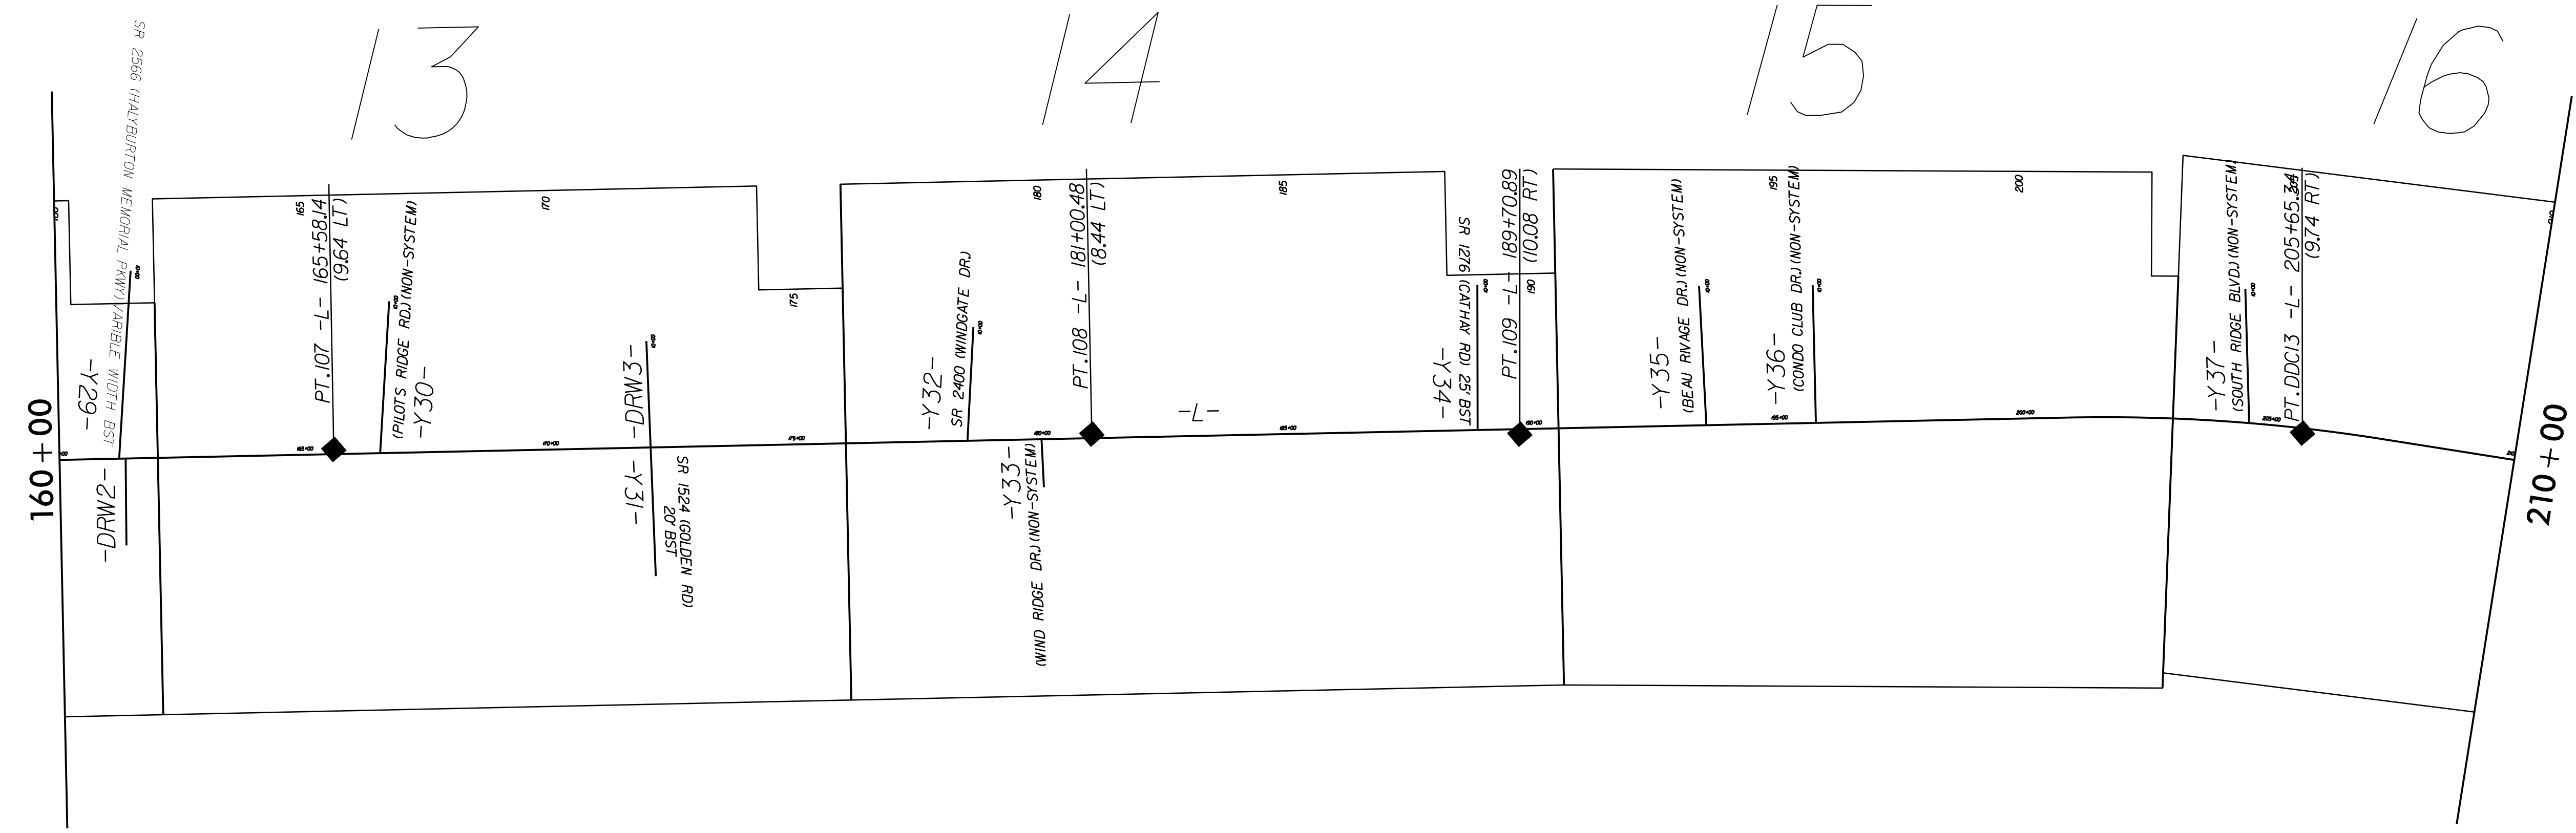

CONTROL POINTS LIST (THIS SHEET):
 PT.107 : N 131050.43 : E 2333109.91 : Z 36.66
 PT.108 : N 132585.67 : E 2332962.15 : Z 53.17
 PT.109 : N 133453.80 : E 2332896.53 : Z 52.70
 PT.DDC13 : N 135041.13 : E 2332774.16 : Z 42.09

NOT TO SCALE