



PROJECT REFERENCE NO. W-5103A	SHEET NO. 1C-8
RW SHEET NO.	

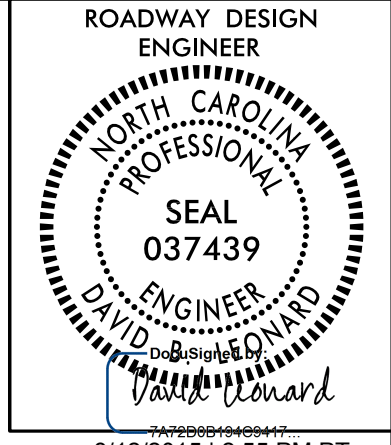

8/12/2015 12:55 PM PT

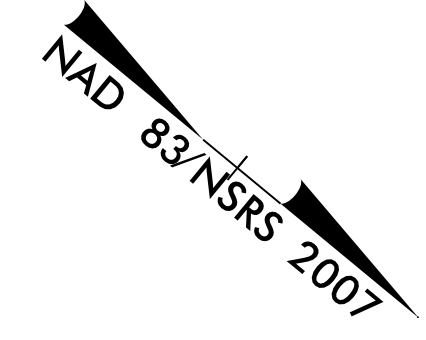


STATE OF NORTH CAROLINA
DIVISION OF HIGHWAYS
SURVEY CONTROL SHEET

8/17/99

REVISIONS

03-AUG-2015 12:47 NEW HANDOVER W-5103-41867-1.1.1 US 421 Median Crossover Relet (use this file) \ROADWAY\Proj\Plan_Sheets\W5103A-D03_RdJ-1C-8.dgn
\$\$\$\$\$SUSPENSE\$\$\$\$\$

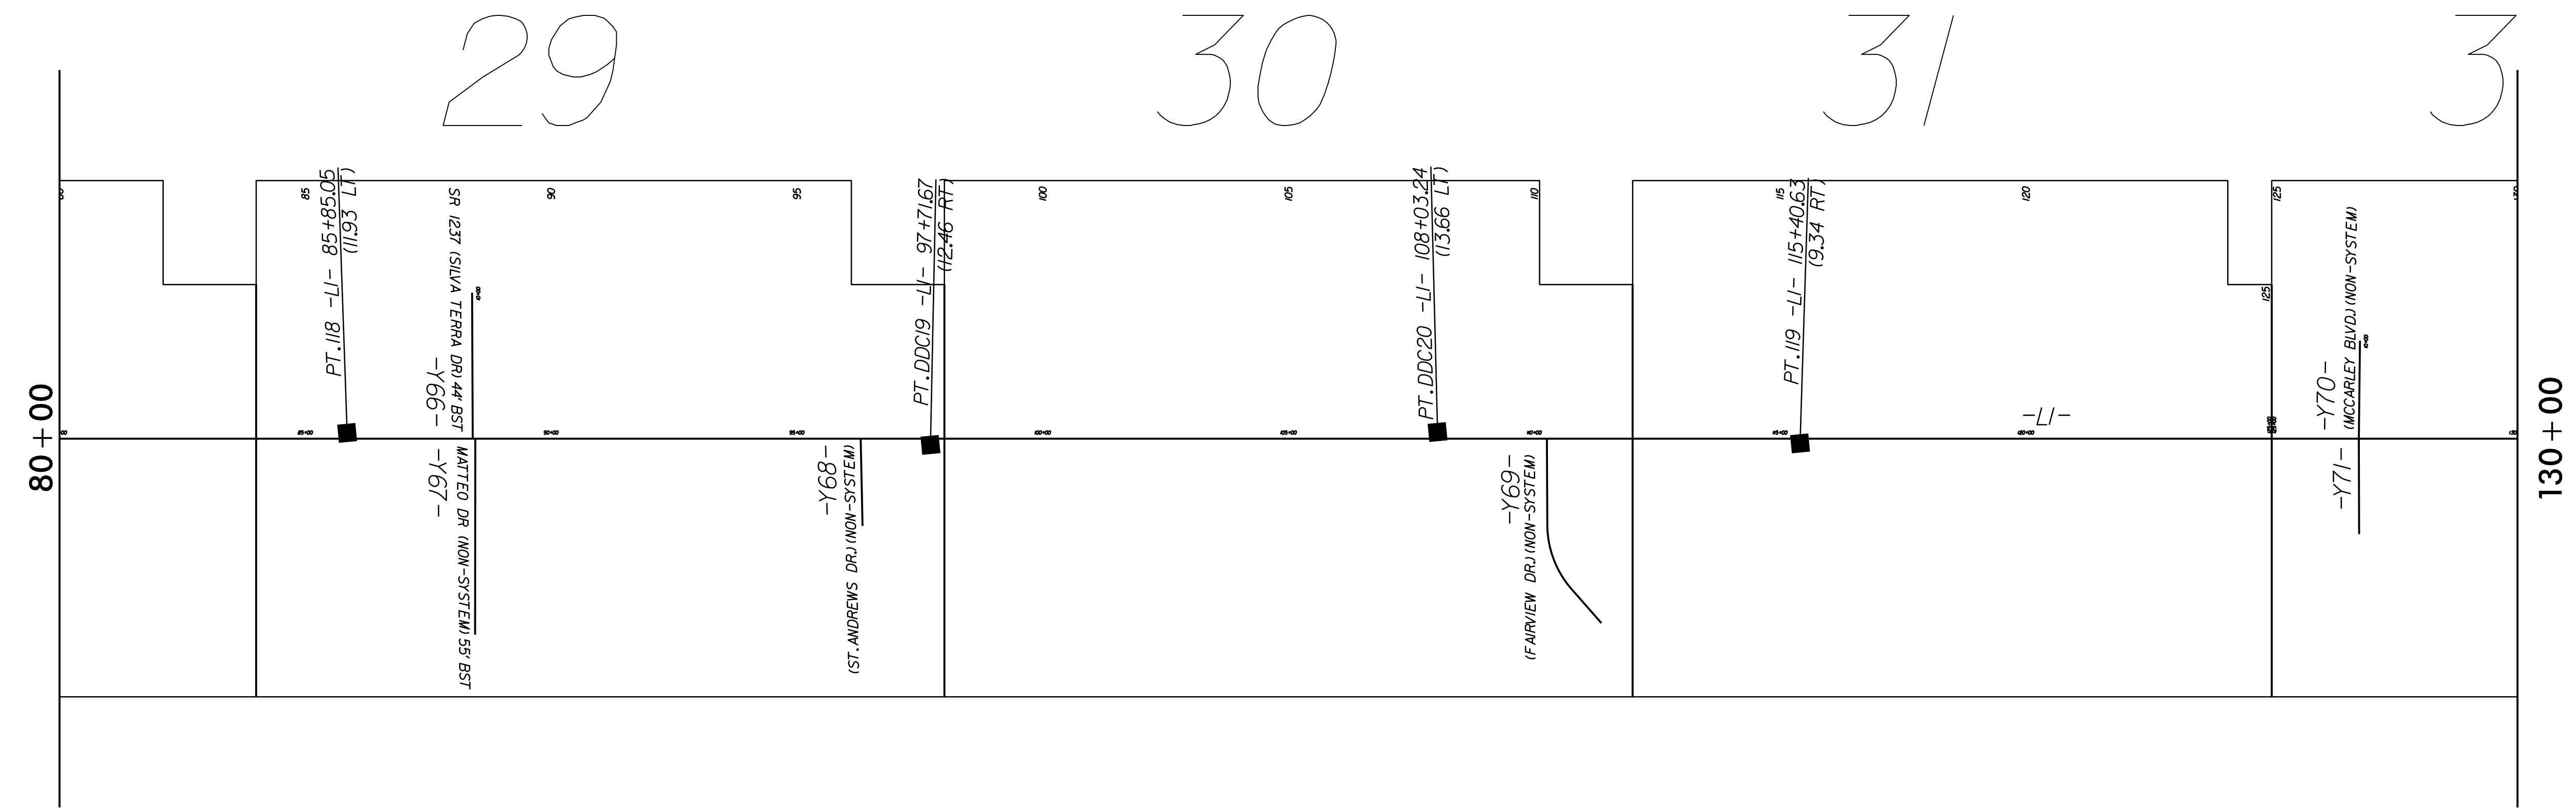

CONTROL POINTS LIST (THIS SHEET):
 PT 118 : N 149555.77 : E 2330085.79 : Z 20.42
 PT 119 : N 151847.60 : E 2328219.39 : Z 18.15
 PT DDC19 : N 150486.01 : E 2329348.68 : Z 10.40
 PT DDC20 : N 151264.55 : E 2328671.40 : Z 18.00

NOT TO SCALE