


PROJECT REFERENCE NO. W-5103A	SHEET NO. 1C-9
RW SHEET NO.	

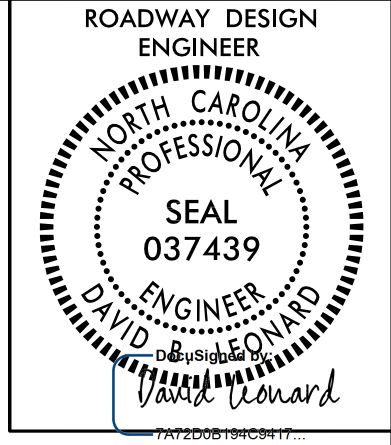


NAD 83/NSRS 2007

STATE OF NORTH CAROLINA  
DIVISION OF HIGHWAYS  
**SURVEY CONTROL SHEET**

8/17/99  
 03-AUG-2015 12:47  
 C:\P\PROJECTS\NEW HANDOVER\W-5103-41867-1-1-1\IS 421 Medham Crossover Relet (use this file)\ROADWAY\Proj\Plan\_Sheets\W5103A-D03-RdJ-1C-9.dgn  
 \$\$\$SUSTAINABLE\$\$\$

REVISIONS

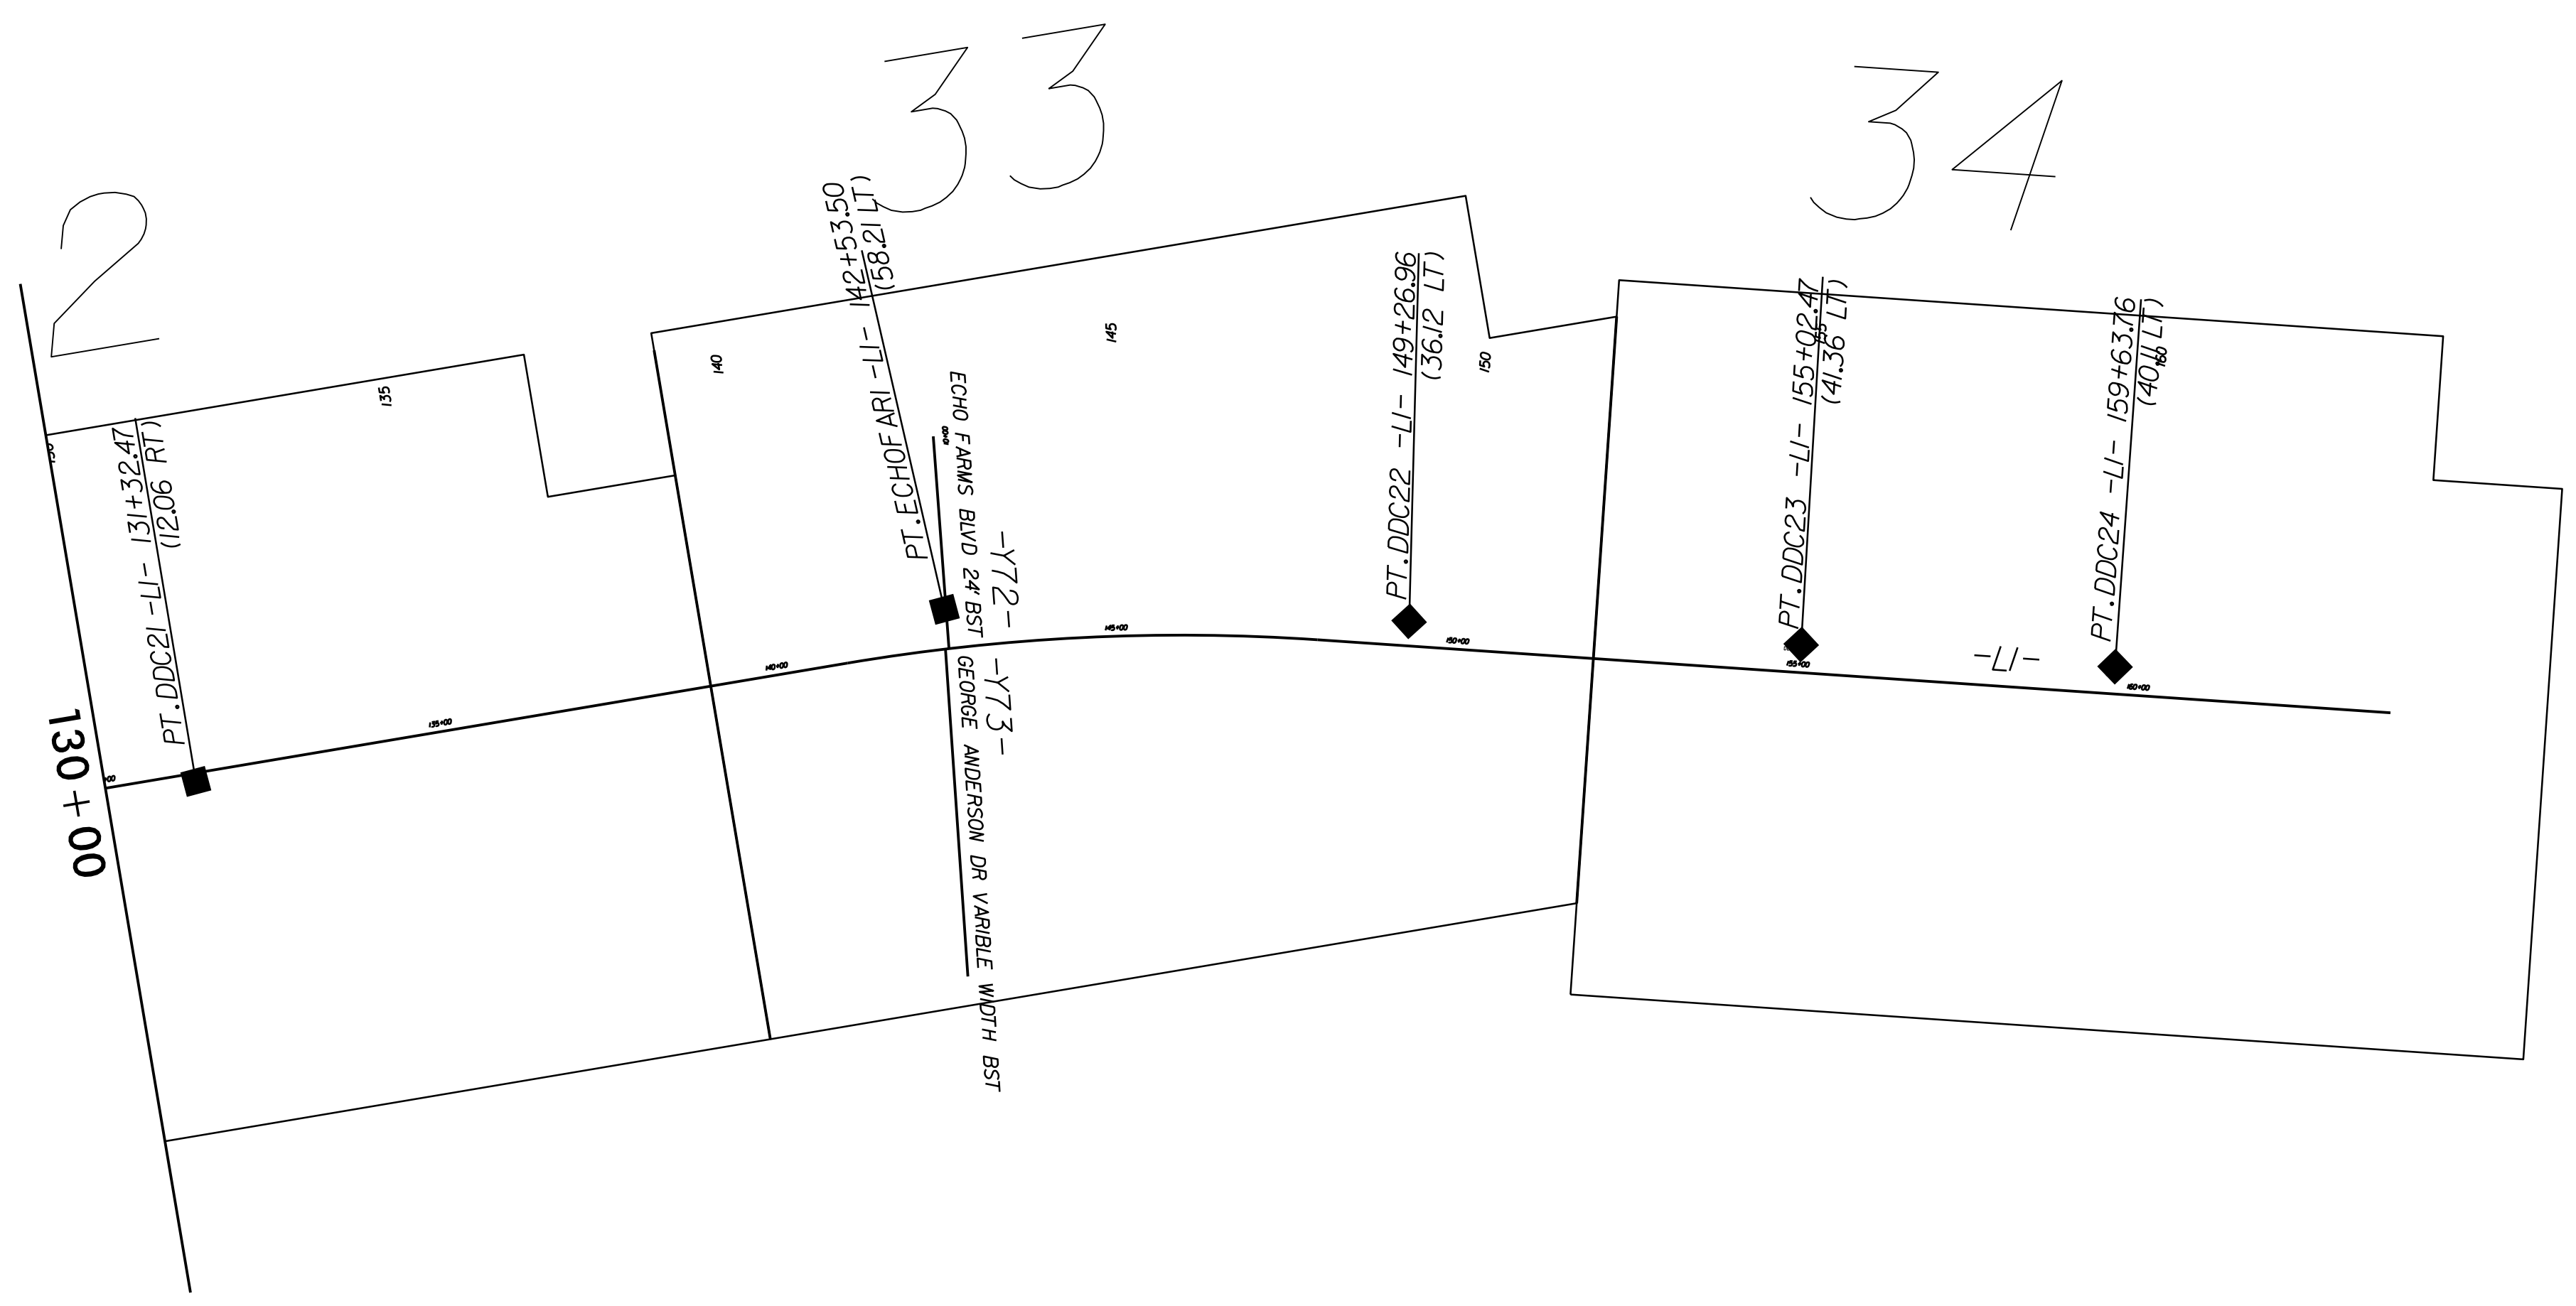

CONTROL POINTS LIST (THIS SHEET):  
 PT DDC21 : N 153076.39 : E 2327207.45 : Z 21.04  
 PT DDC22 : N 154499.52 : E 2326115.02 : Z 26.25  
 PT DDC23 : N 155014.04 : E 2325857.11 : Z 24.75  
 PT DDC24 : N 155428.83 : E 2325655.29 : Z 27.63  
 PT ECHOFARI : N 153900.48 : E 2326440.31 : Z 26.71

**NOT TO SCALE**