


STATE OF NORTH CAROLINA
DIVISION OF HIGHWAYS



UTILITIES BY OTHERS PLANS
ROWAN COUNTY

LOCATION: SR 1210 (OLD BEATTY FORD RD.) FROM WEST OF
SR 1221 (BOSTIAN RD.) INTERSECTION TO SR 1337
(LENTZ RD.)
TYPE OF WORK: UTILITIES BY OTHERS

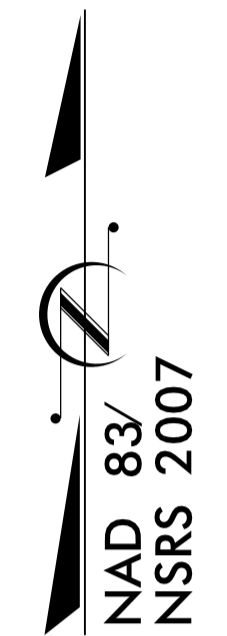

TIP PROJECT: W-5516

CONTRACT: C203652

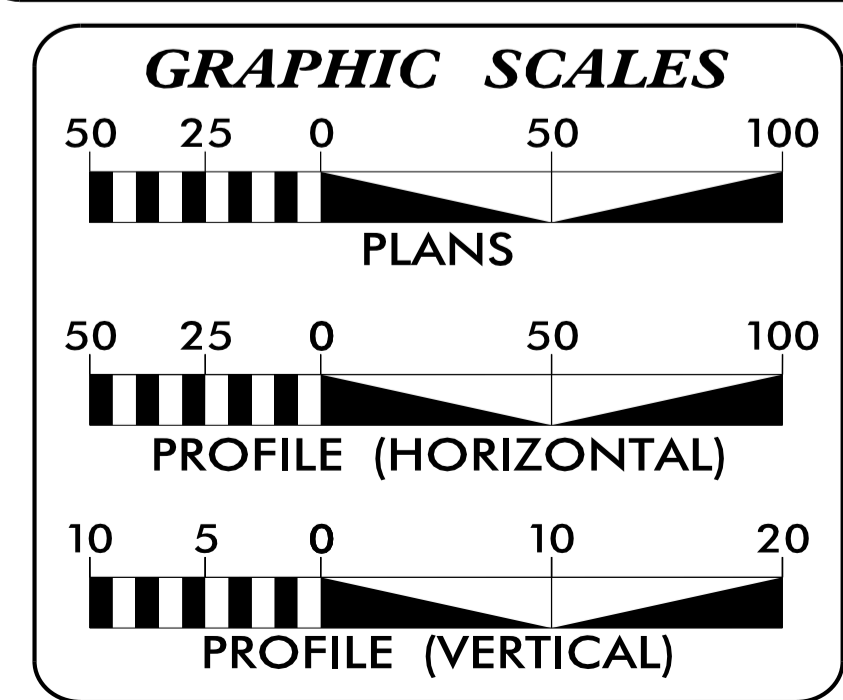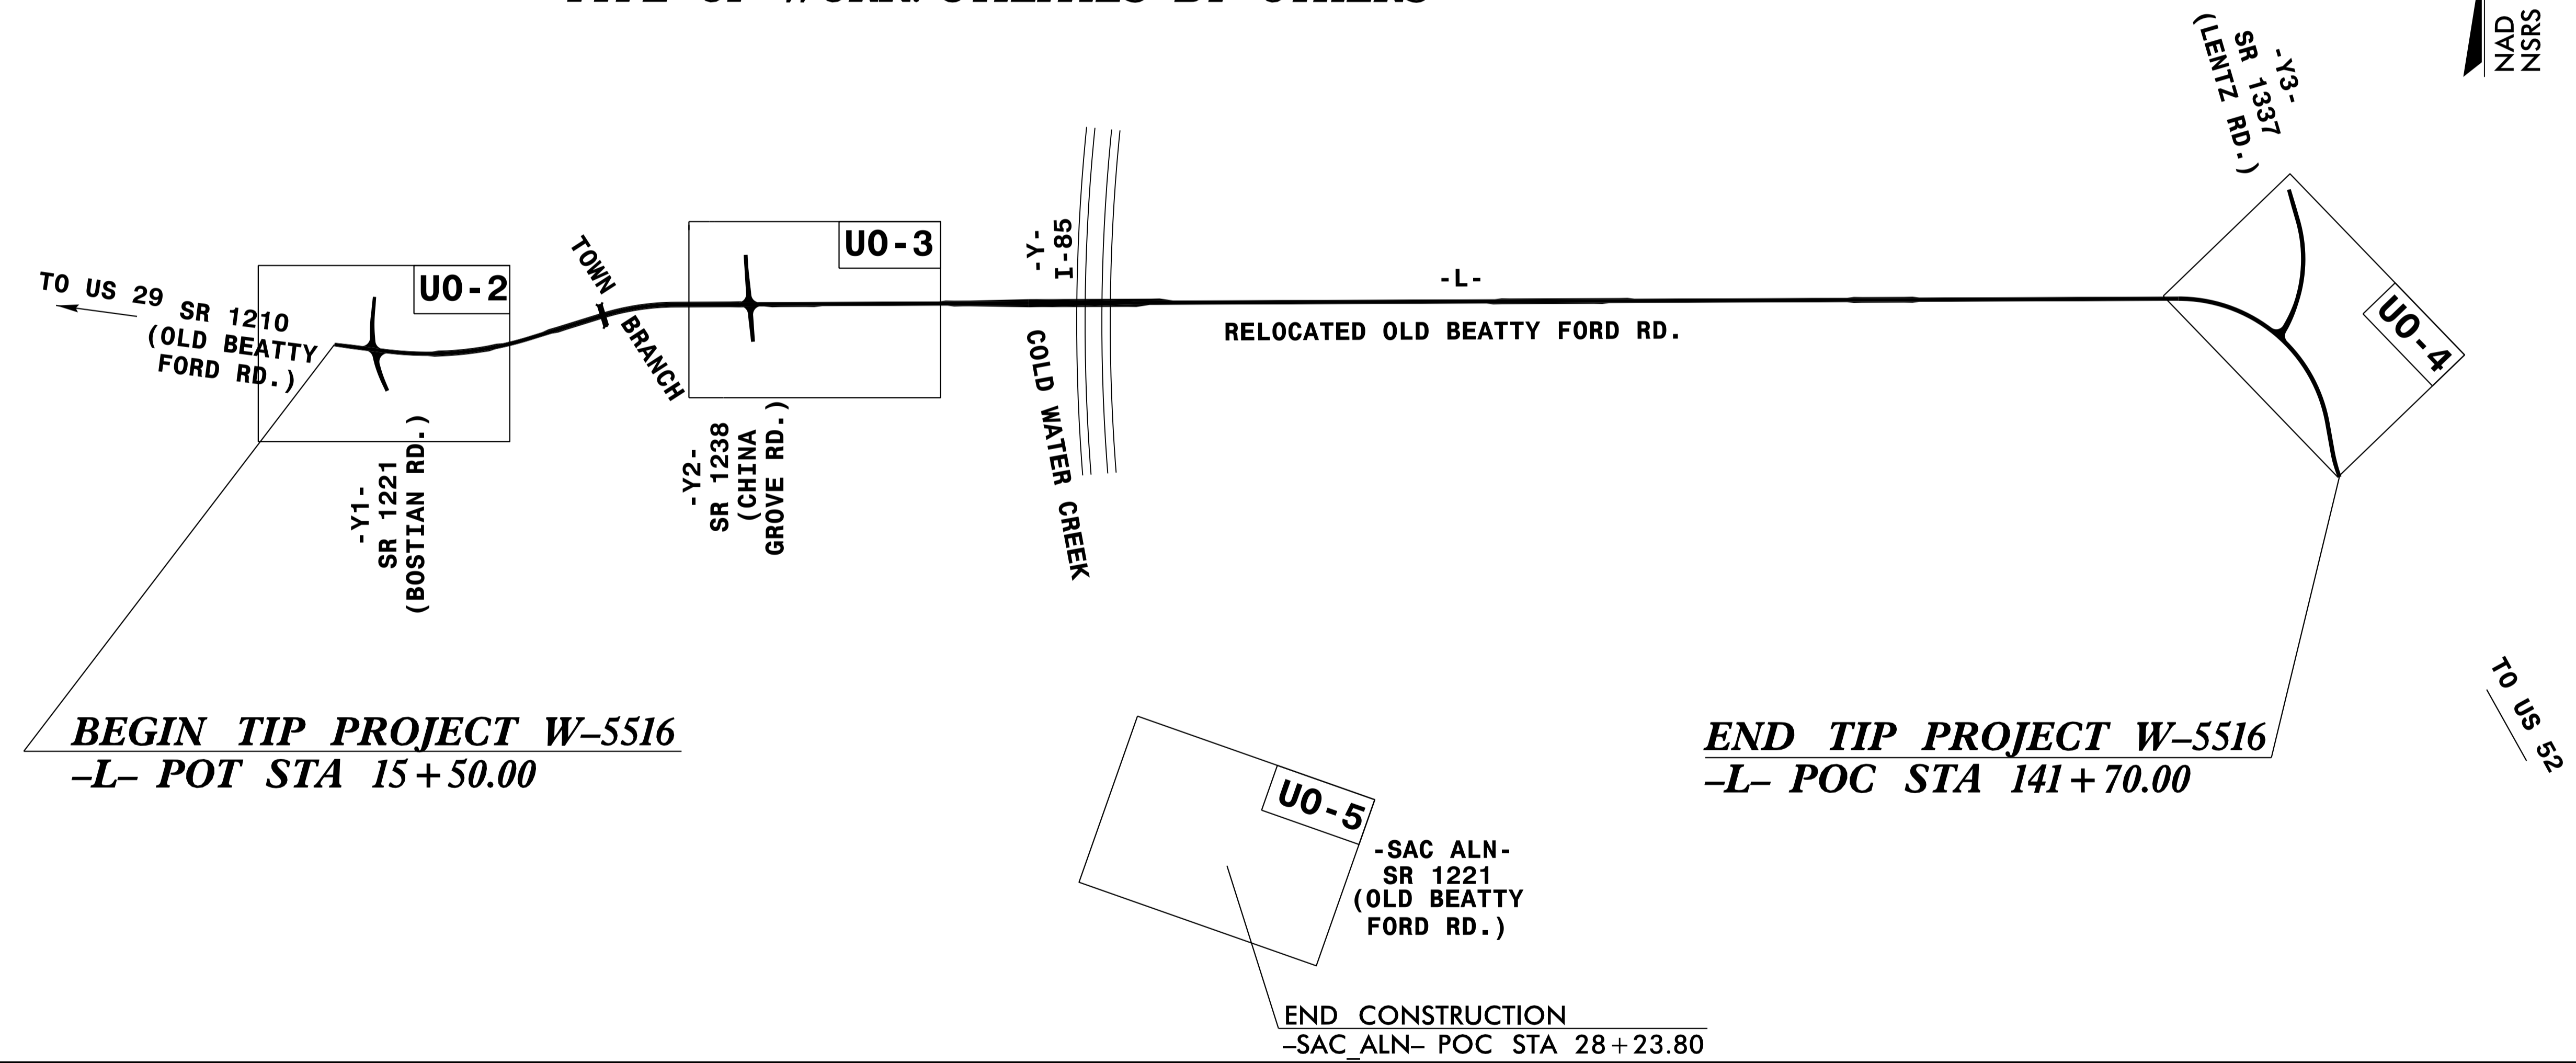

INDEX OF SHEETS

SHEET NO.	DESCRIPTION
UO-1	TITLE SHEET
UO-2 - UO-6	UTILITY BY OTHERS PLAN SHEETS

UTILITY OWNERS ON PROJECT

(A) POWER (DISTRIBUTION) - DUKE ENERGY
(B) COMMUNICATIONS - WINDSTREAM
(C) CABLE TELEVISION - TIME WARNER

PREPARED IN THE OFFICE OF:
DIVISION OF HIGHWAYS
DIVISION 9

375 SILAS CREEK PKWY
WINSTON-SALEM, NC 27127
PHONE (336) 747-7800
FAX (336) 703-6693

J. BRETT ABERNATHY, PE, PLS	DIVISION PROJECT MANAGER
W. AL BLANTON, PE, PLS	DIVISION DESIGN ENGINEER
R. DAVID TRANTHAM	DIVISION UTILITY COORDINATOR

25-JUN-2015 15:11 S:\DDC\2013_W5516-Old Beatty Ford Rd\Utilities\UB0\W5516-ddc-uo-1.dgn \$\$\$\$USERNAME\$\$\$