



PROJECT REFERENCE NO. 1-5505	SHEET NO. 5
RW SHEET NO.	
ROADWAY DESIGN ENGINEER WILLIAM A. BLANTON PROFESSIONAL SEAL 025499 1/5/2016	HYDRAULICS ENGINEER GALIN LAIL PROFESSIONAL SEAL 022000 1/7/2016
DocuSigned by: William A. Blanton	DocuSigned by: Galun Lail

DOCUMENT NOT CONSIDERED FINAL  
UNLESS ALL SIGNATURES COMPLETED

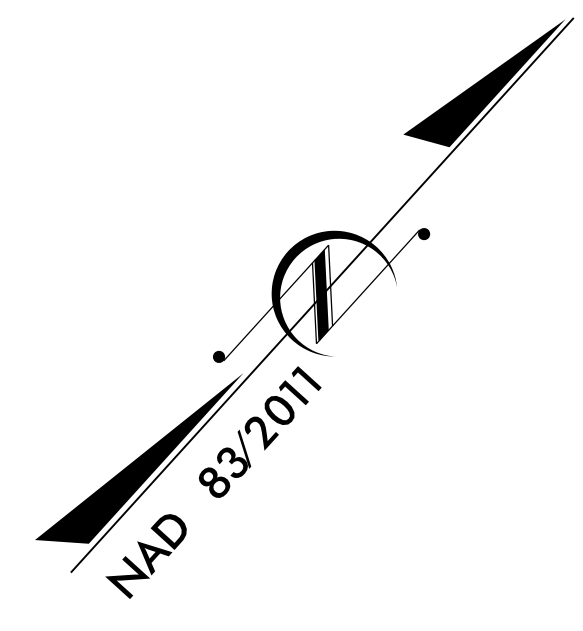

APPROXIMATE AREA OF PAVEMENT REPAIR.  
ACTUAL AREA OF REPAIR TO BE DETERMINED  
BY FIELD ENGINEER.

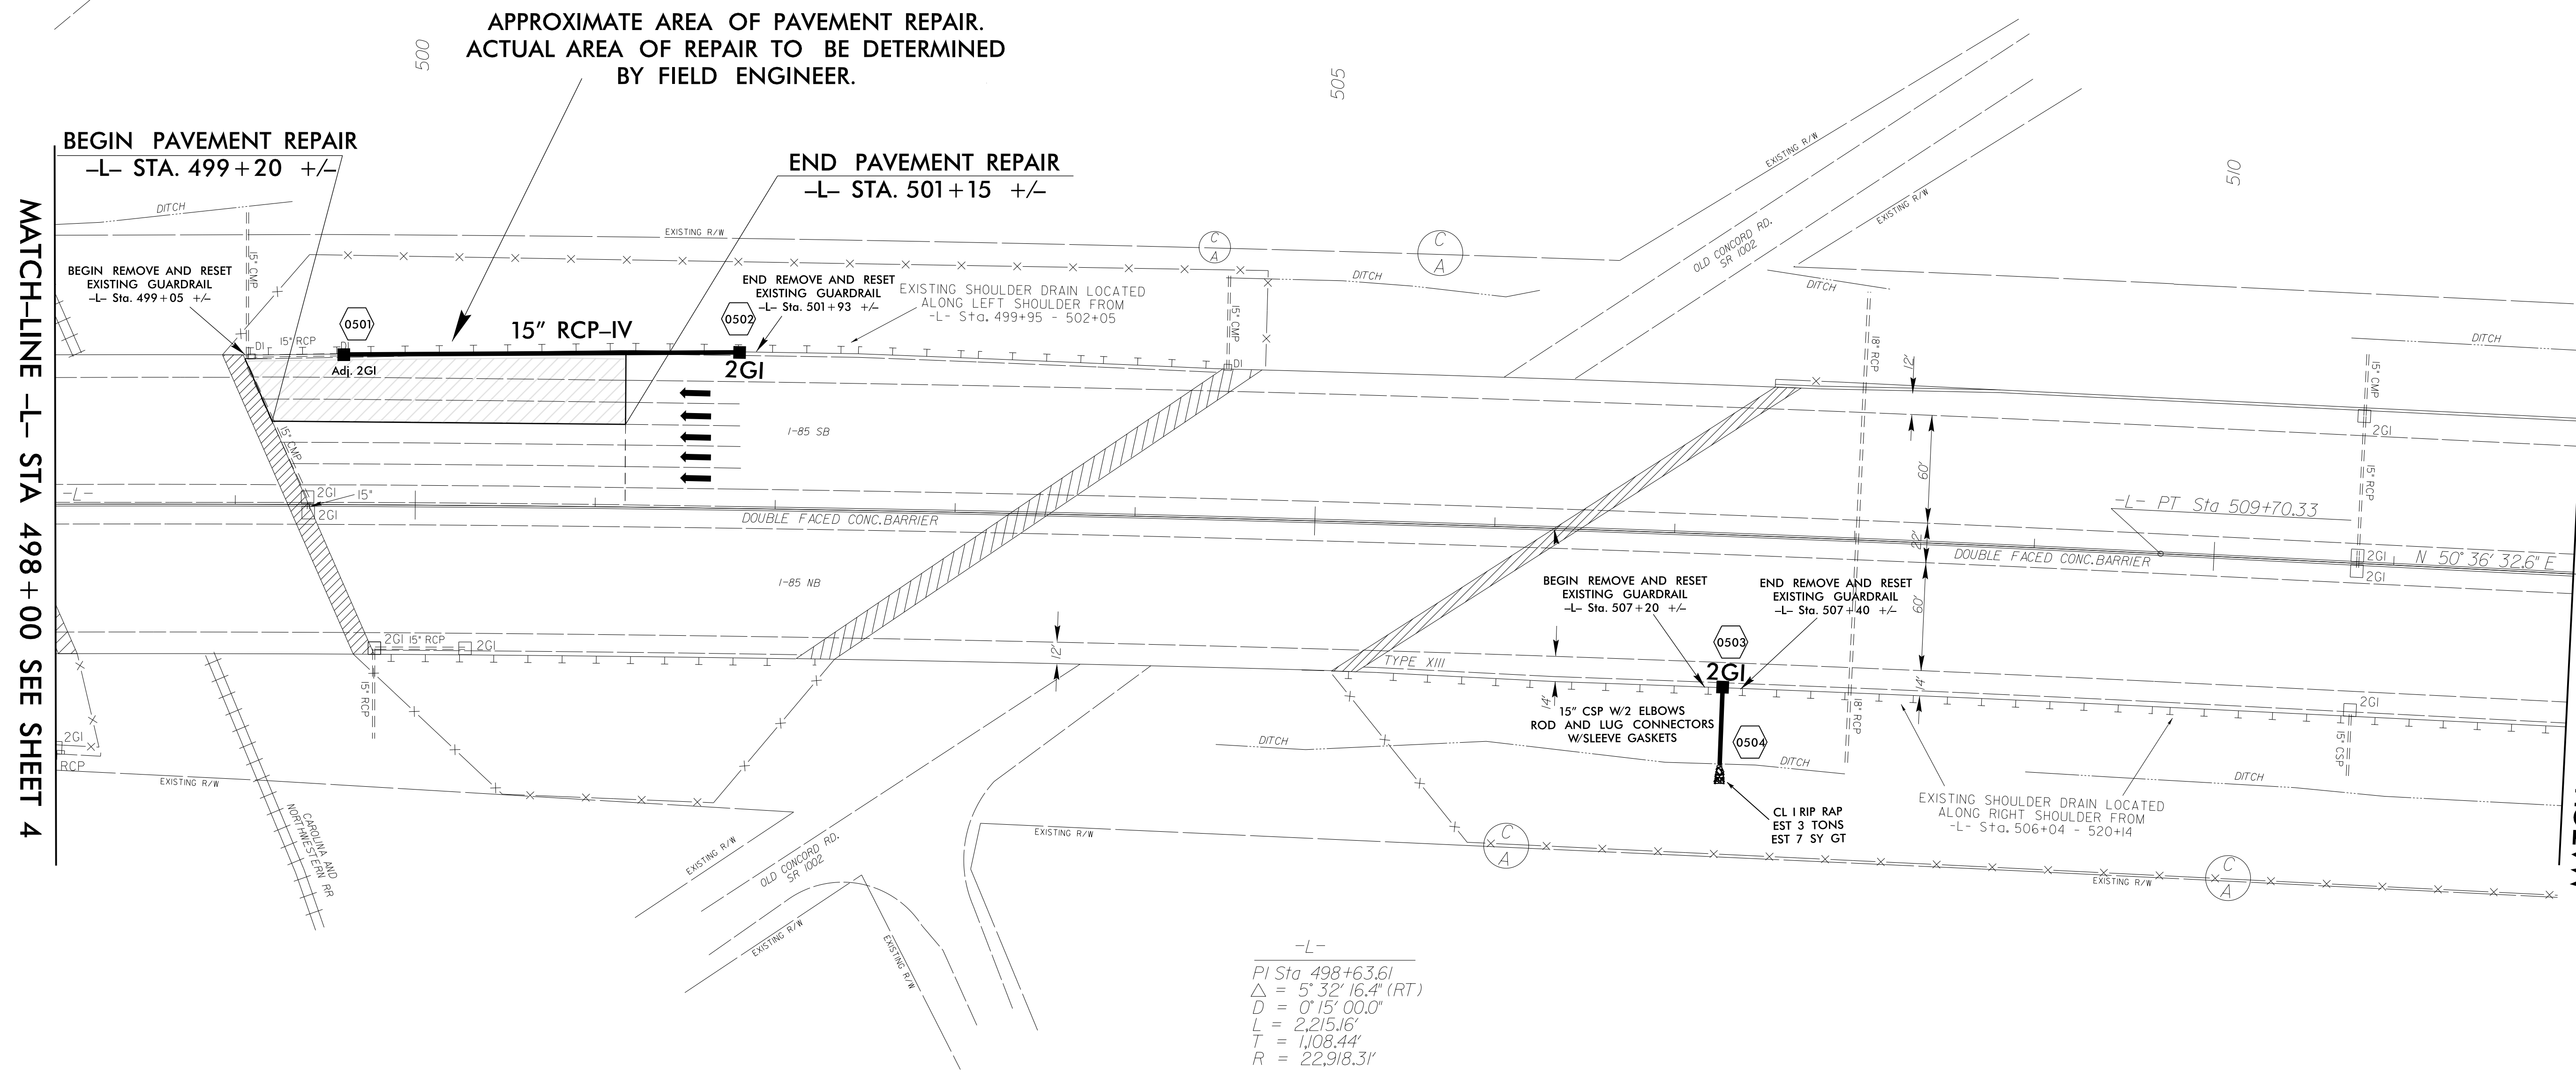

-L-  
 PI Sta. 498+63.61  
 $\Delta = 5^{\circ} 32' 16.4''$  (RT)  
 $D = 0^{\circ} 15' 00.0''$   
 $L = 2,215.16'$   
 $T = 1,108.44'$   
 $R = 22,918.31'$

MATCH-LINE -L- STA 498 + 00 SEE SHEET 4

MATCH-LINE -L- STA 512 + 00 SEE SHEET 6

REVISIONS

8/17/99

23-DEC-2016 14:57 I:\5505-1 85-Rovam\Plansheets\15505-ddc-ps15.dgn