


09/06/99

25-FEB-2016 09:21 H:\DDC\Projects\I-5847-I-74 from Bus 74 to NC 710_Resurface and Bridges_Robeson Co\Proj\I-5847_Rdy.tsh.dgn \$\$\$USERNAME\$\$\$

TIP PROJECT: I-5847

CONTRACT: C203841

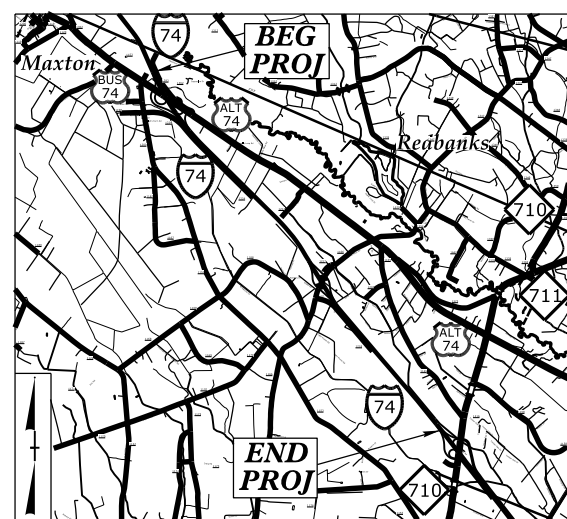

STATE OF NORTH CAROLINA
DIVISION OF HIGHWAYS

ROBESON COUNTY




LOCATION: I-74 FROM US 74 ALTERNATE TO NC 710

TYPE OF WORK: PAVEMENT REHABILITATION

STATE	STATE PROJECT REFERENCE NO.	SHEET NO.	TOTAL SHEETS
N.C.	I-5847	1	
STATE PROJ. NO.	F.A. PROJ. NO.	DESCRIPTION	
53052.1.FS1	NHPP-0074(183)	P.E.	
53052.3.FS1	NHPP-0074(183)	CONSTR.	

BEGIN TIP PROJECT I-5847
-L- STA 10+00.00

END TIP PROJECT I-5847
-L- STA 353+20.00

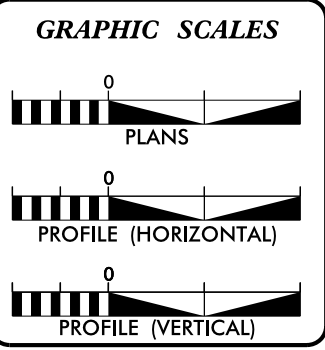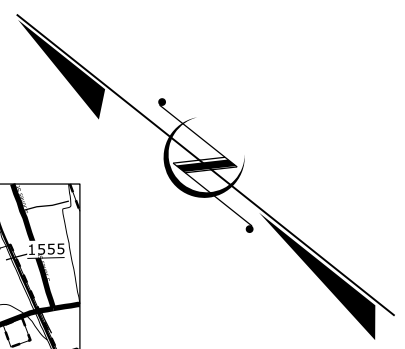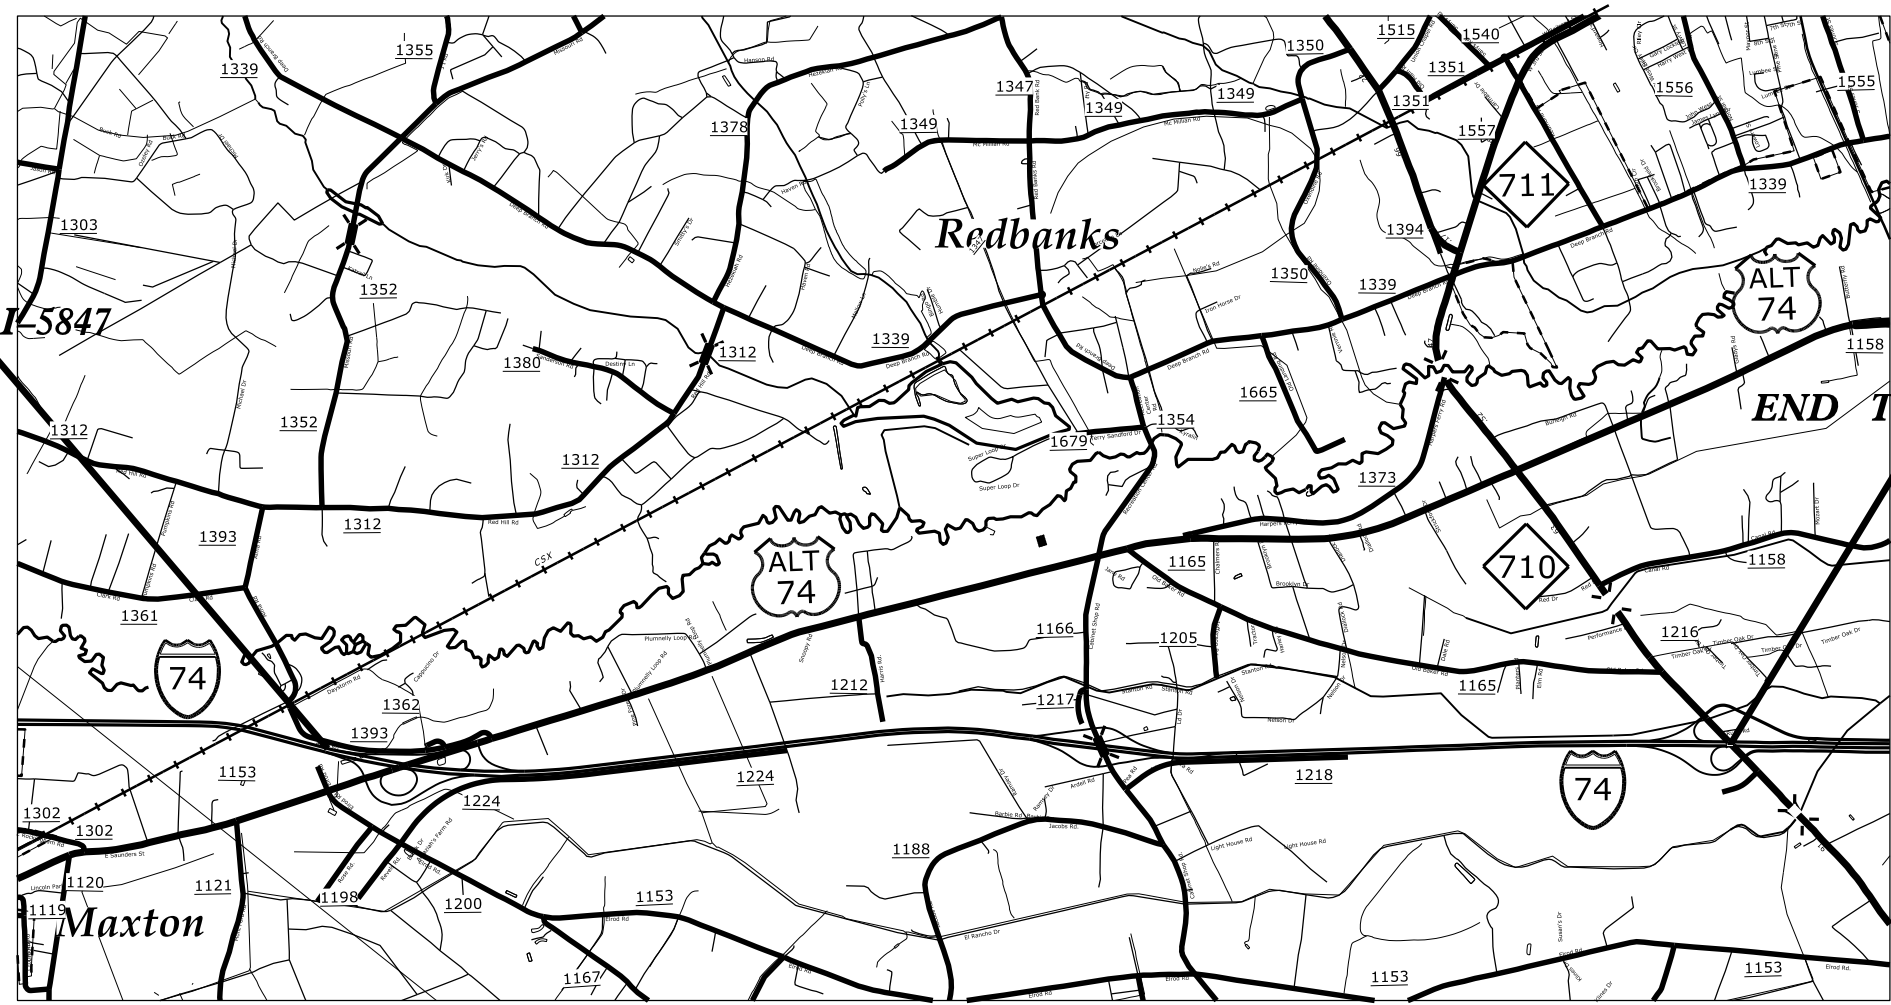

DESIGN DATA

ADT 2016 = 10600

PROJECT LENGTH

TOTAL PROJECT LENGTH = 6.5 MILES

Prepared in the Office of:
DIVISION OF HIGHWAYS
1000 Birch Ridge Dr., Raleigh NC, 27610

2012 STANDARD SPECIFICATIONS

RIGHT OF WAY DATE:
NA

LETTING DATE:
MAY 17, 2016

