



PIER 3

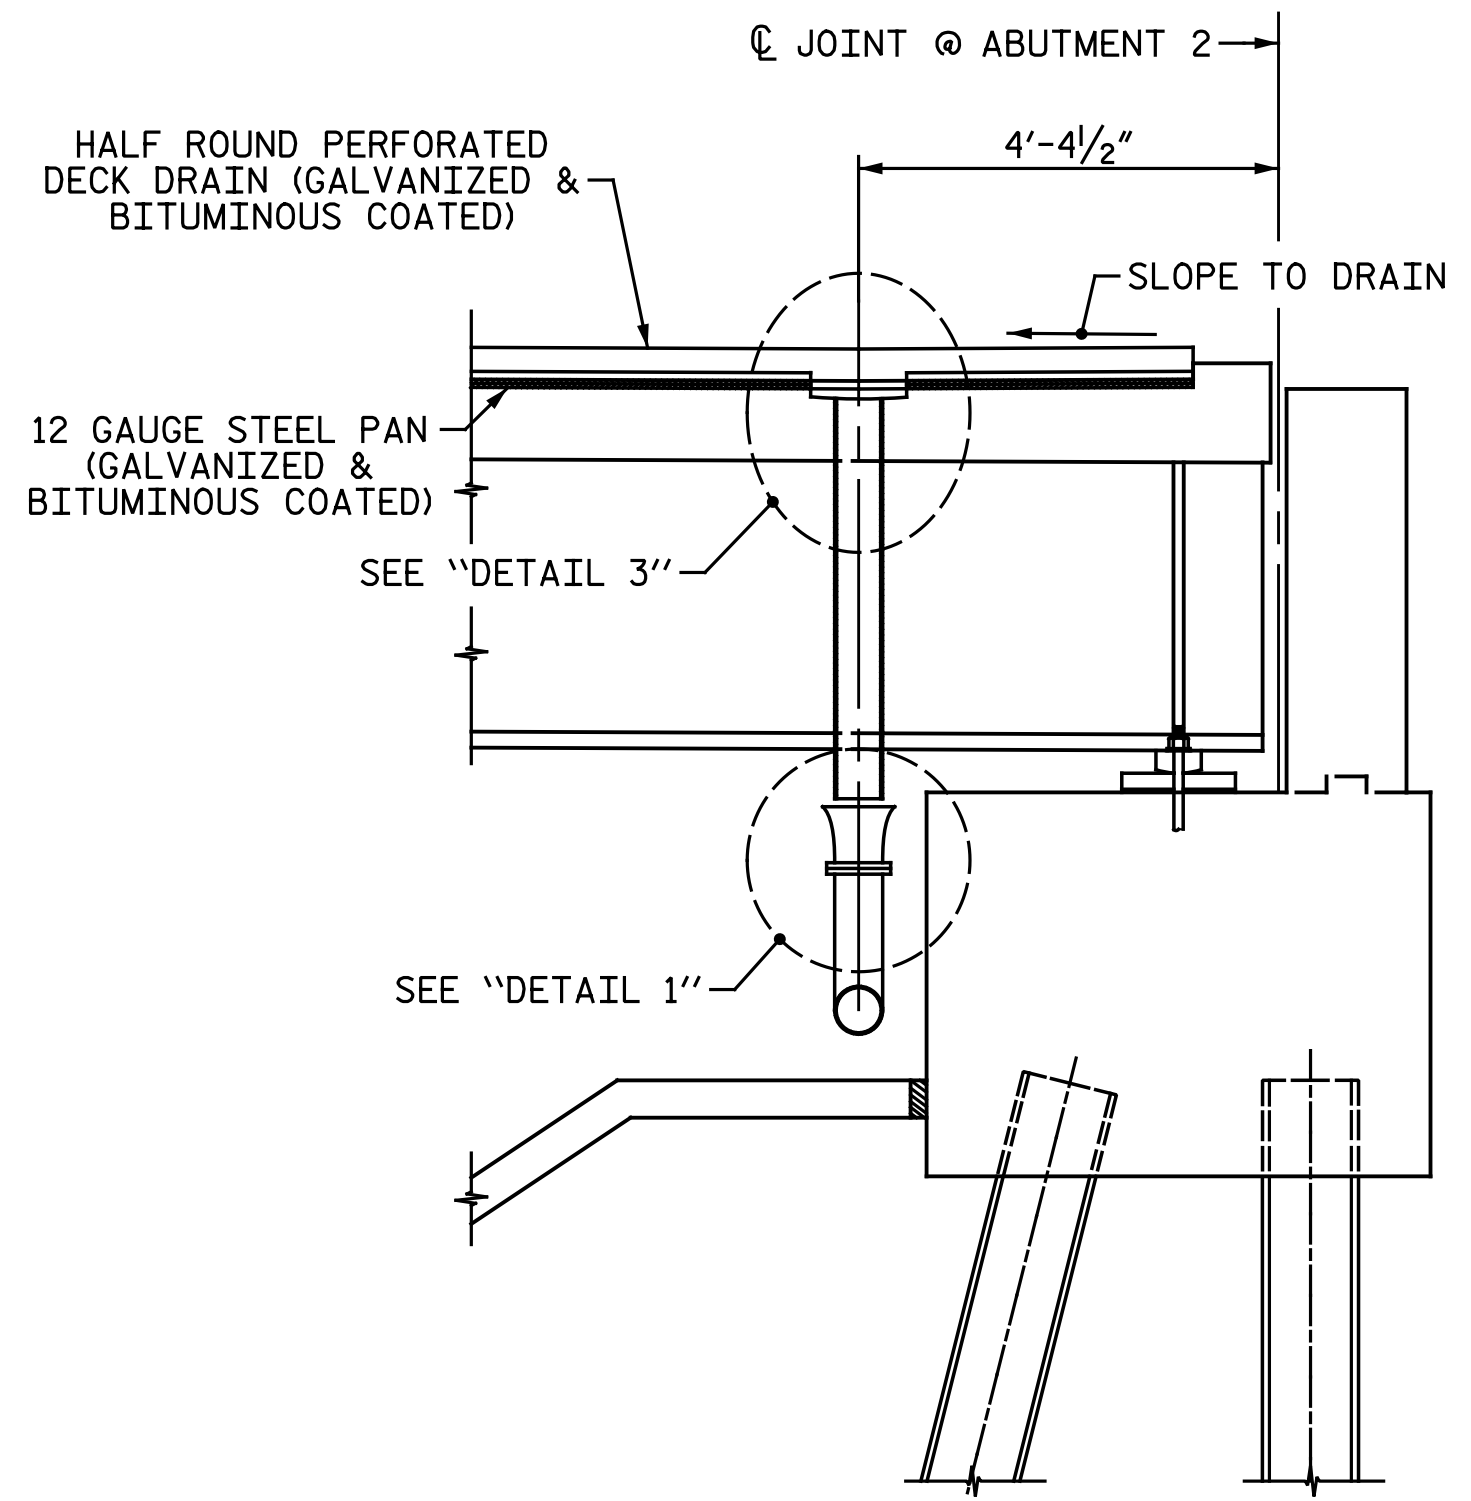



ABUTMENT 2

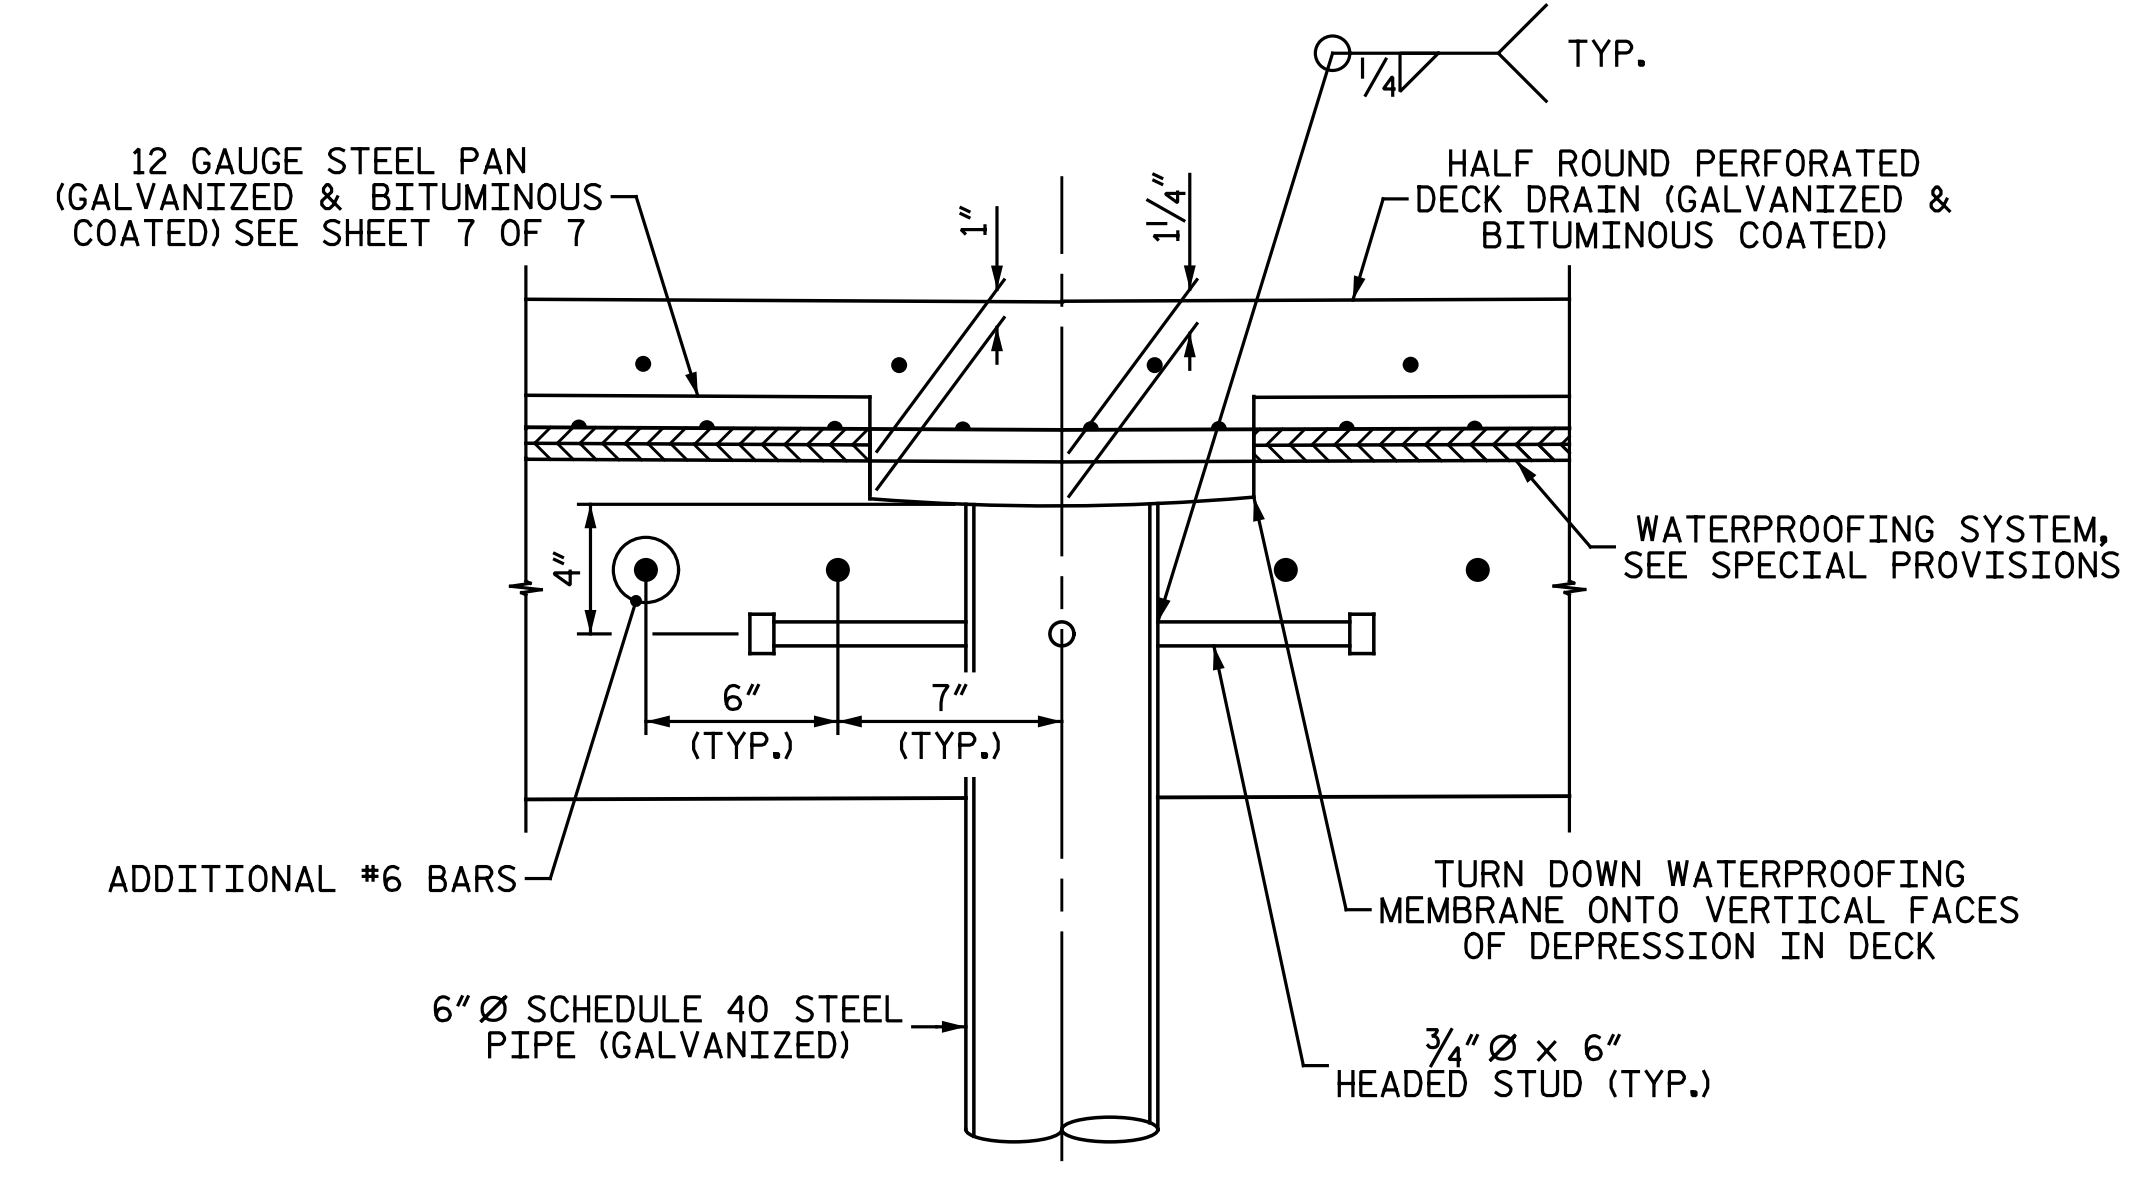


DETAIL 3

NOTES:
 ALL DIMENSIONS ARE SUBJECT TO ADJUSTMENTS TO FIT MEASUREMENTS TAKEN AFTER DECKS HAVE BEEN POURED.
 6" Ø VERTICAL DECK DRAINS SHALL NOT BE RIGIDLY JOINED TO 6" FLANGE AND FLARE. SEE "DETAIL 1" AND "DETAIL 2" ON SHEET 1 OF 7.
 FOR "DETAIL 1" AND "DETAIL 2", SEE SHEET 1 OF 7.

DRAINAGE DETAILS

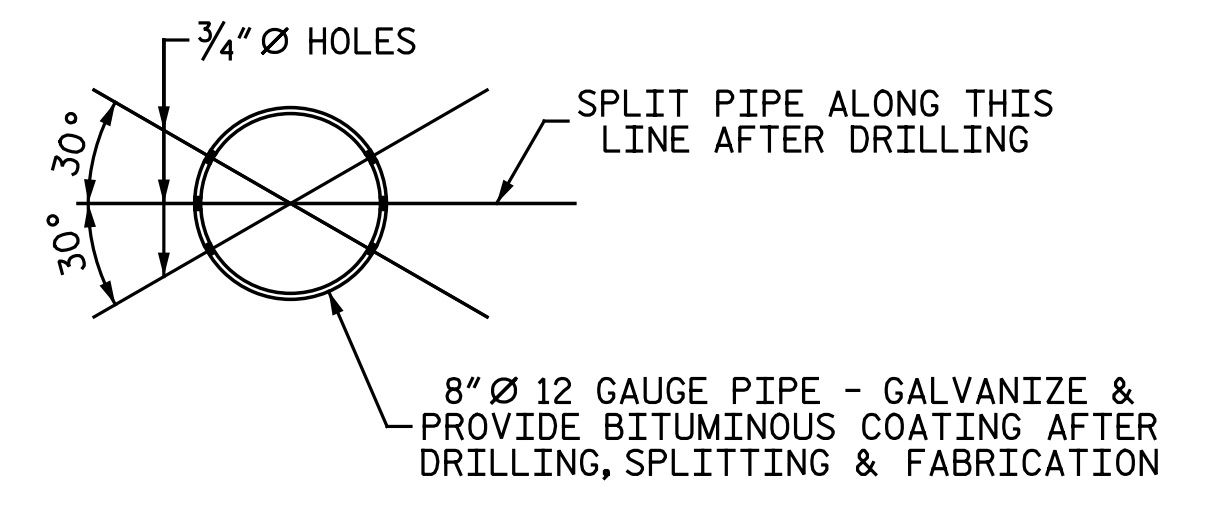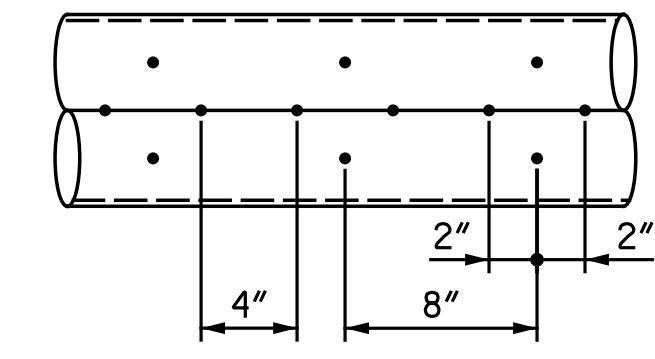


8" Ø PERFORATED PIPE DETAIL

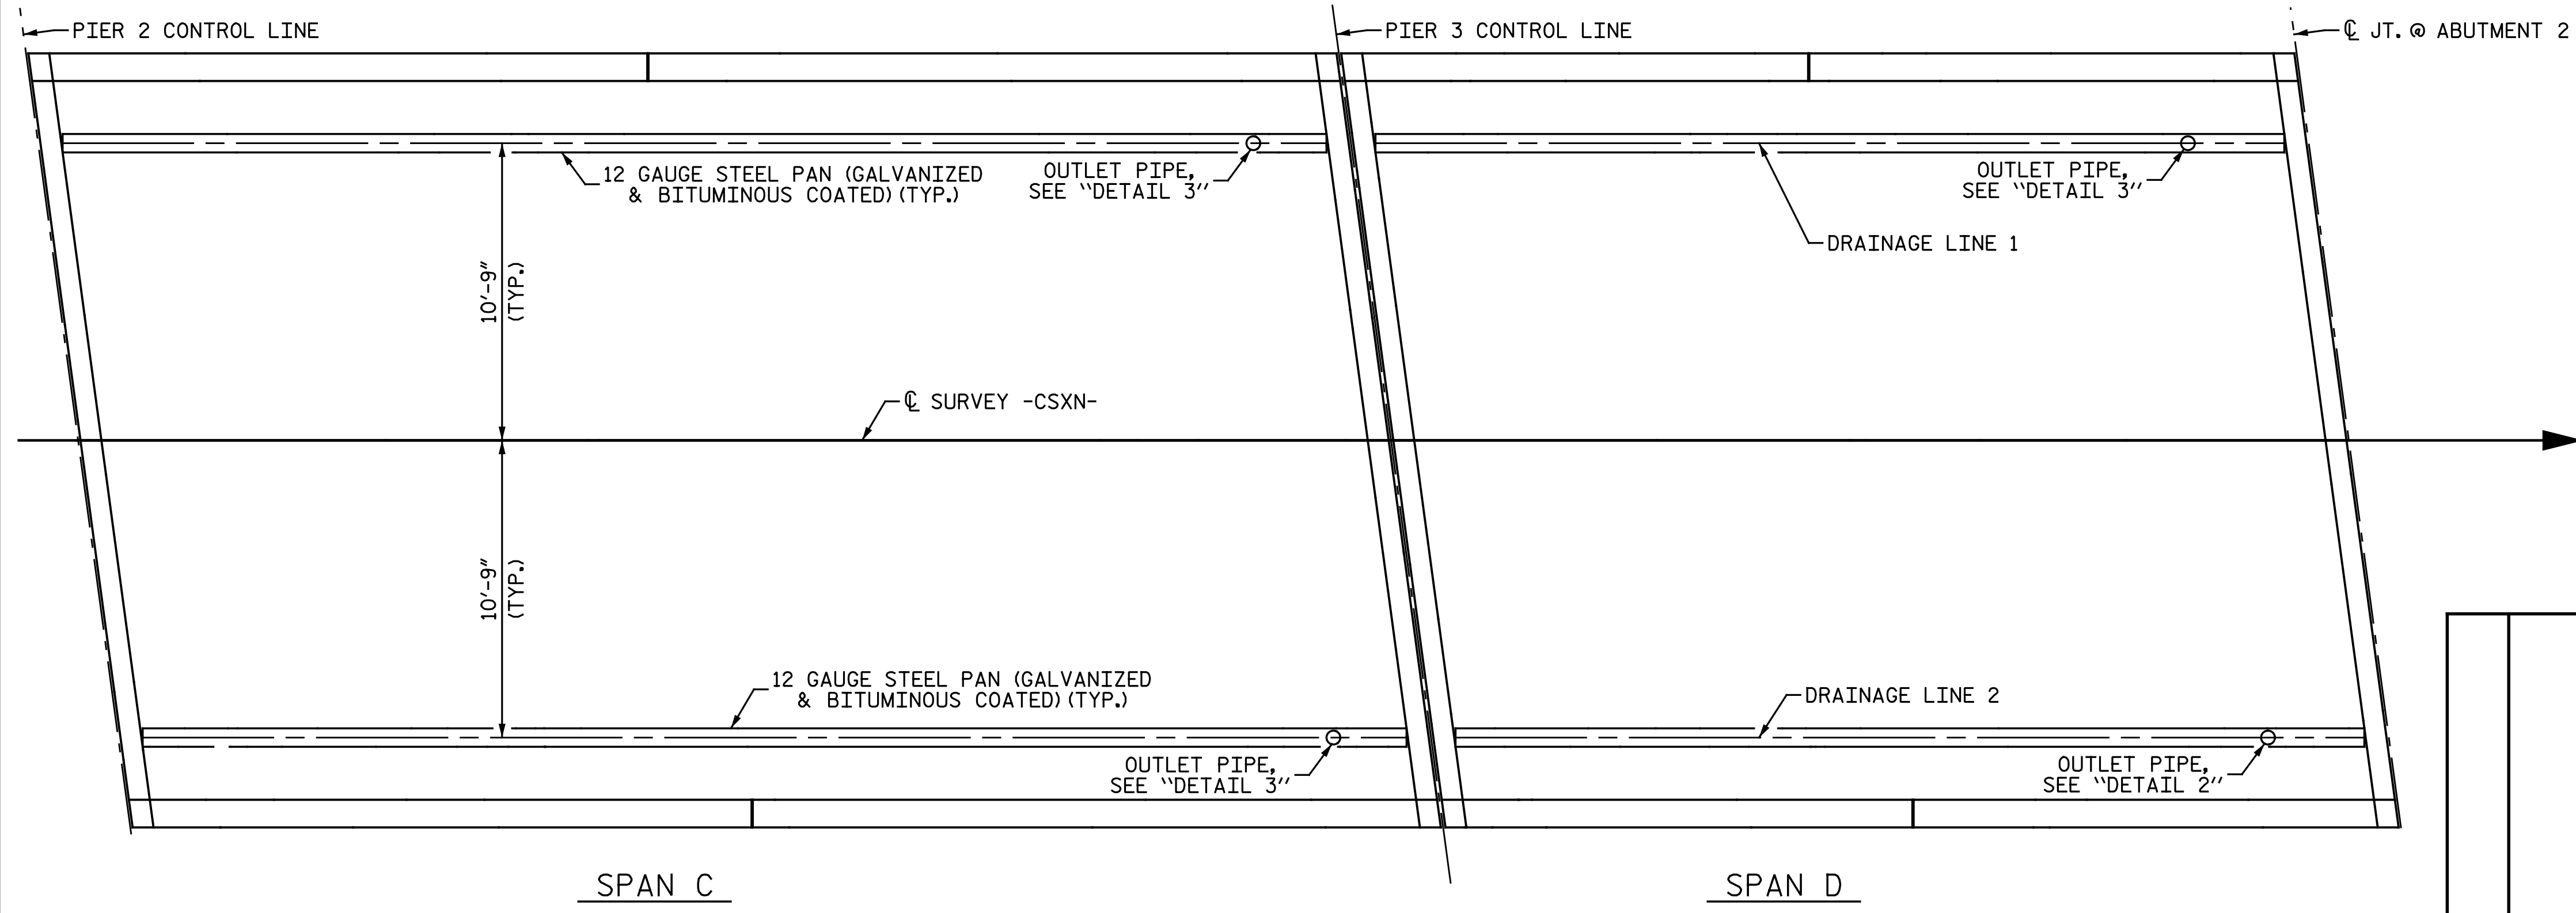

DRAINAGE LAYOUT

PROJECT NO. U-3308
DURHAM COUNTY
 STATION: 24+55.20 -LALT-
13+22.18 -CSXN-
 SHEET 2 OF 7

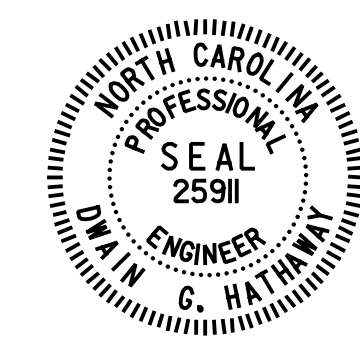

Designed by
 Duane Holloway
 5/3/2016

Michael Baker INTERNATIONAL

Michael Baker Engineering
 8000 Regency Parkway, Suite 600
 Cary, North Carolina 27618
 NC License No.: F-1084

STATE OF NORTH CAROLINA
 DEPARTMENT OF TRANSPORTATION
 RALEIGH
 SUPERSTRUCTURE
 STRUCTURE DRAINAGE
 DETAILS
 SPANS C & D

REVISIONS						SHEET NO. S4-46
NO.	BY:	DATE:	NO.	BY:	DATE:	
1			3			TOTAL SHEETS 68
2			4			

cmayhew 5/3/2016 9:37:26 AM
 File name: Y:\Projects\NCDOT\U-3308\Structures\Drawings\Final\404_046_U3308_SMU_SD02.dgn

DRAWN BY : M. D. MAYHEW DATE : 1-10-14
 CHECKED BY : S. A. DENNEY DATE : 3-6-14