
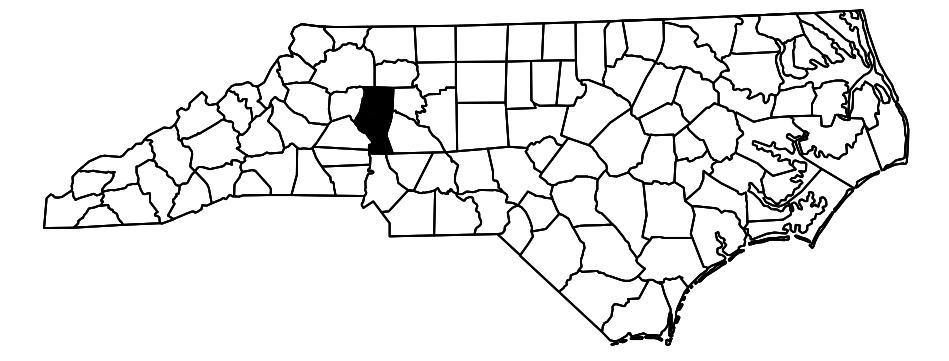


STATE OF NORTH CAROLINA DIVISION OF HIGHWAYS



UTILITY CONSTRUCTION PLANS IREDELL COUNTY

LOCATION: BRIDGE NO. 57 ON SR 1302
OVER CORNELIUS CREEK

TYPE OF WORK: WATER AND FM SEWER UTILITIES

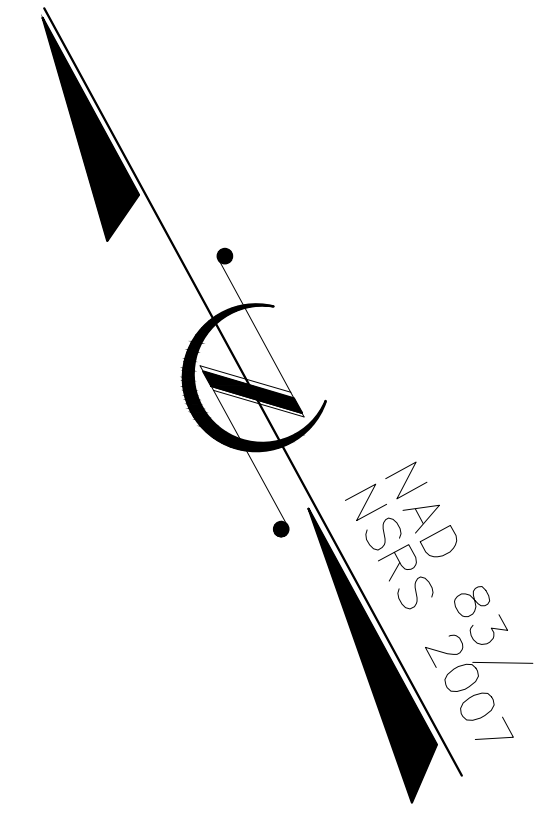


TIP PROJECT: B-5142

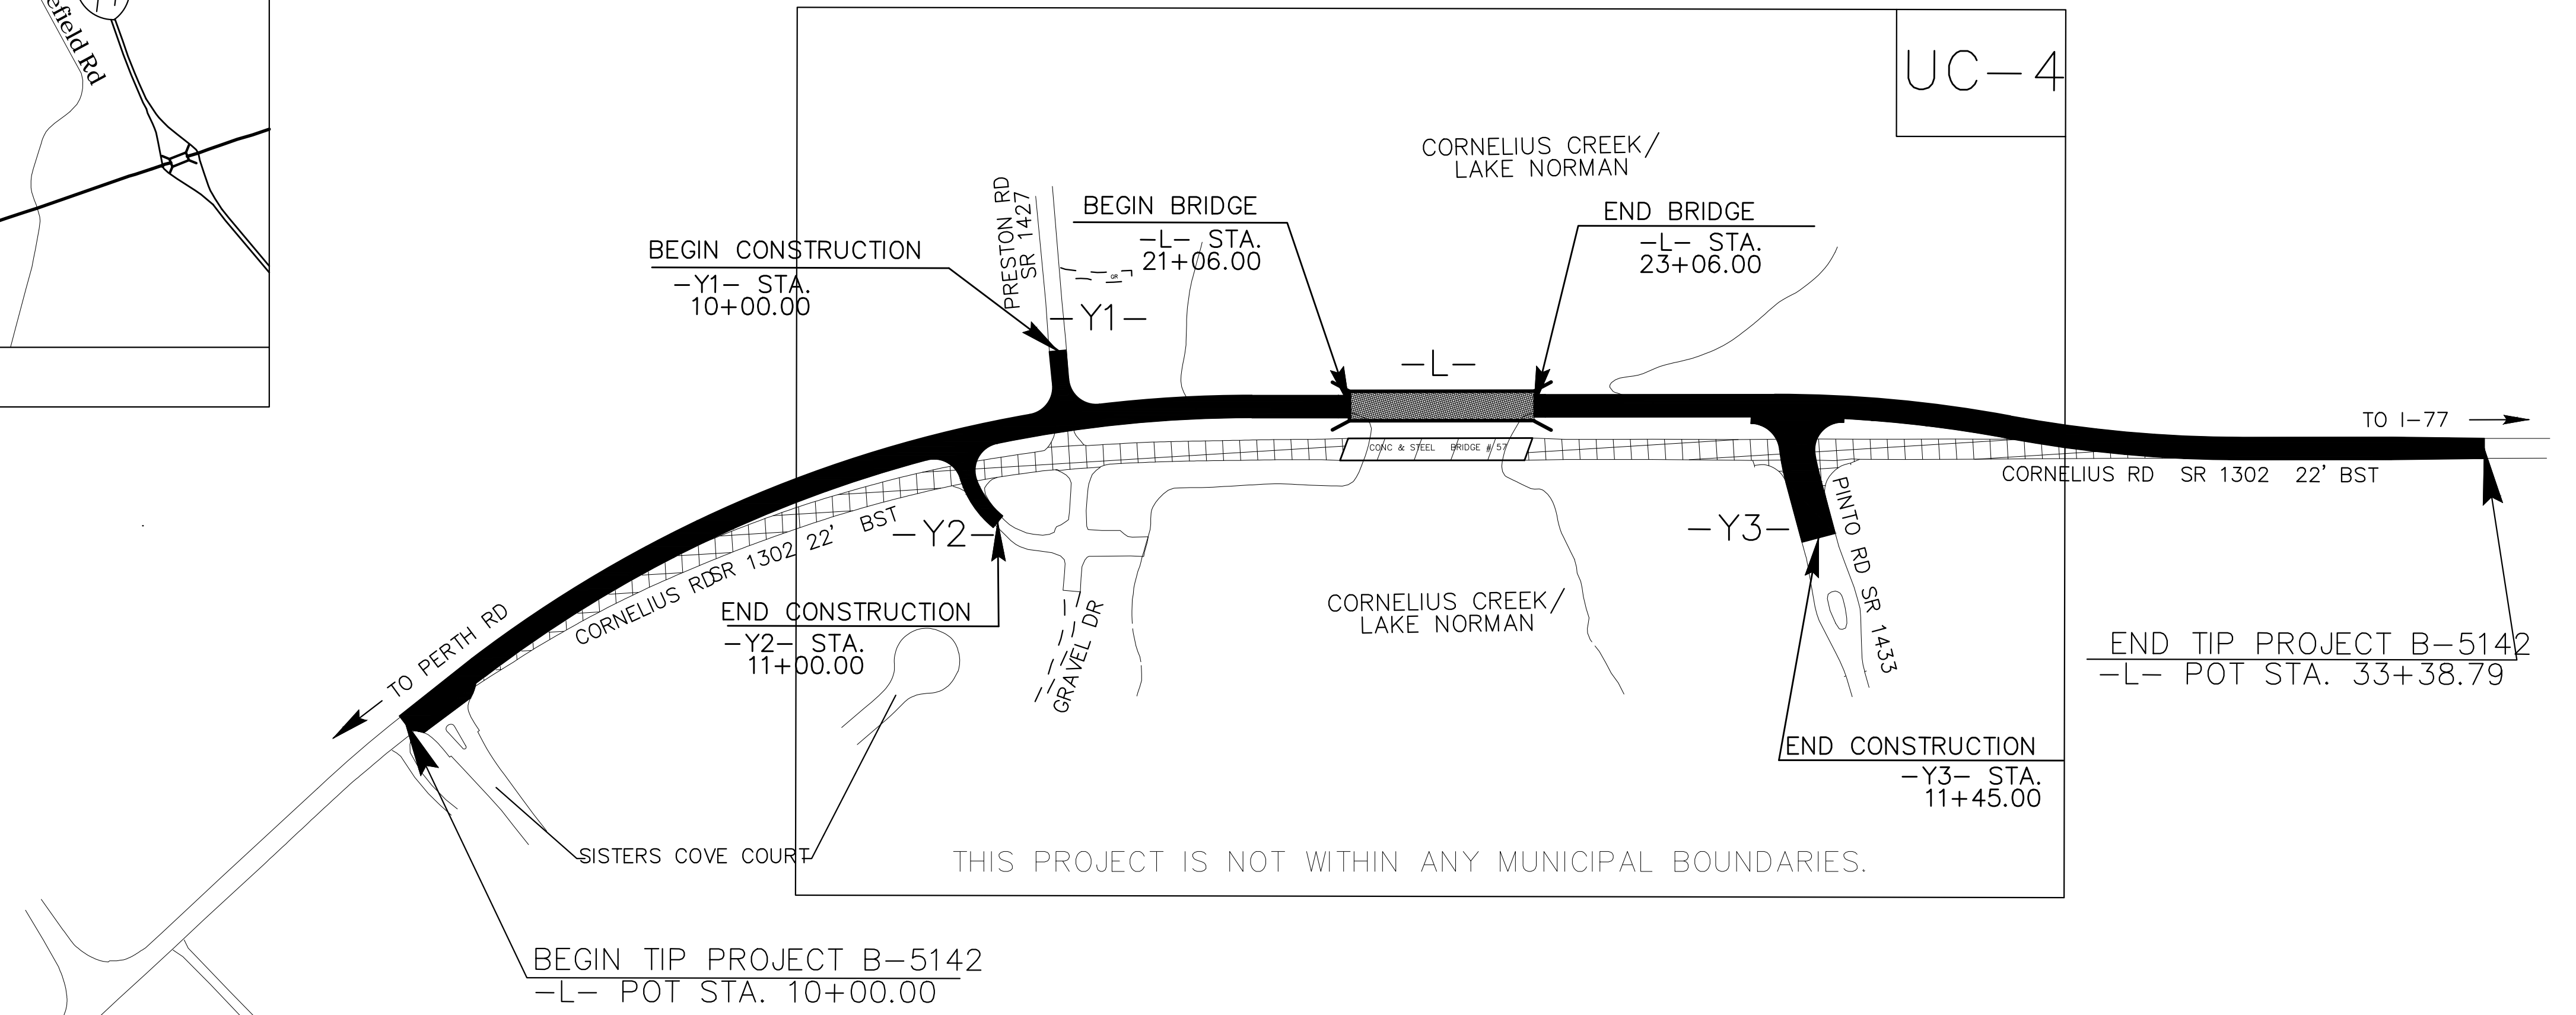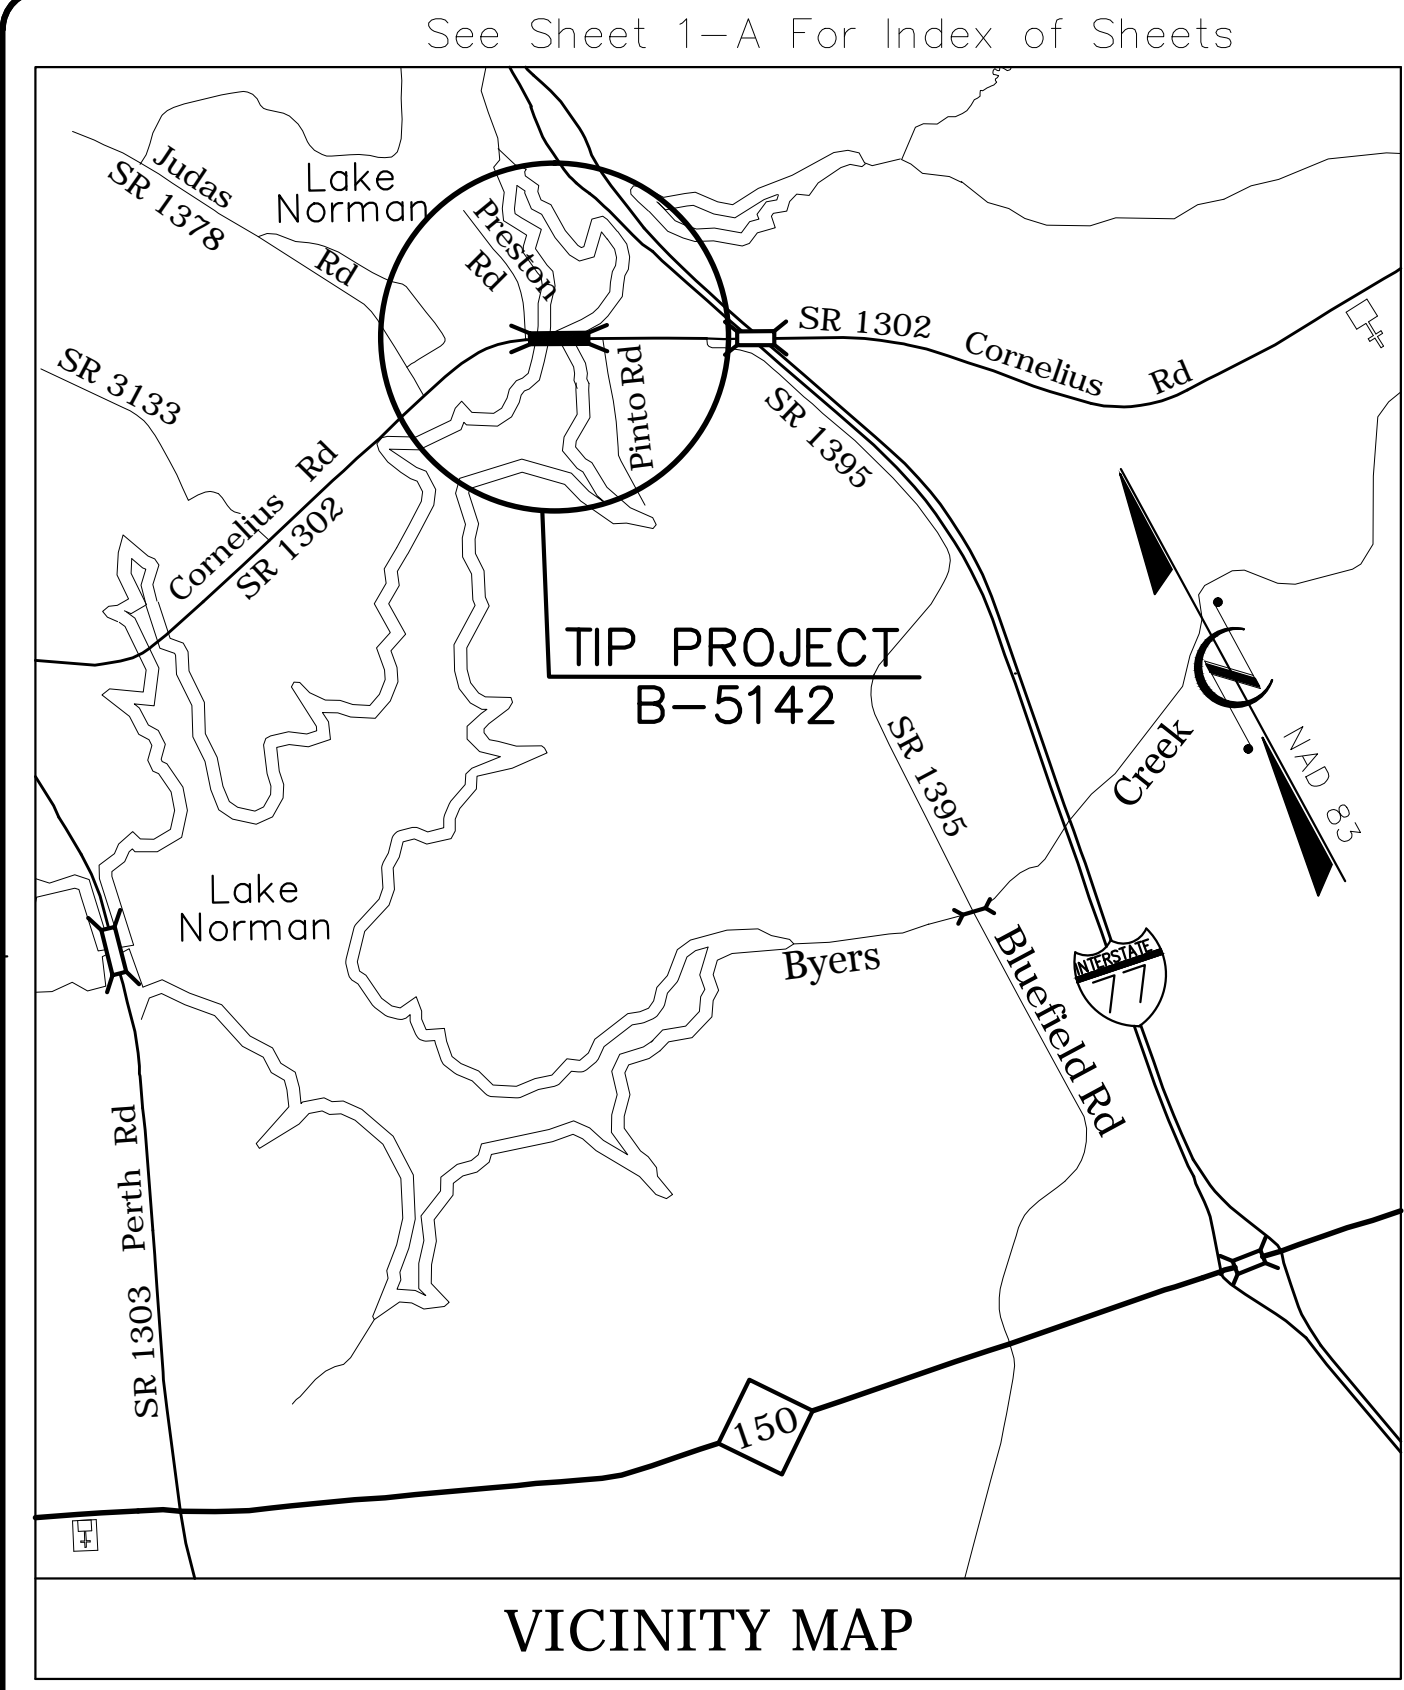

NOTE TO CONTRACTOR: ALL VALVES FOR WATER AND SEWER ARE TO BE "GATE VALVES".

**INDEX OF SHEETS
(REFER TO STRUCTURAL UTILITY PLANS)**


SHEET NO.	DESCRIPTION
SU-1	UTILITY ATTACHMENT SEC & DETAILS
SU-2	END BENT & INTERMEDIATE DIAPHRAGM
SU-3	PLAN-INTEGRAL END BENT & DETAILS
SU-4	UTILITY STORM CROSSING SECTIONS

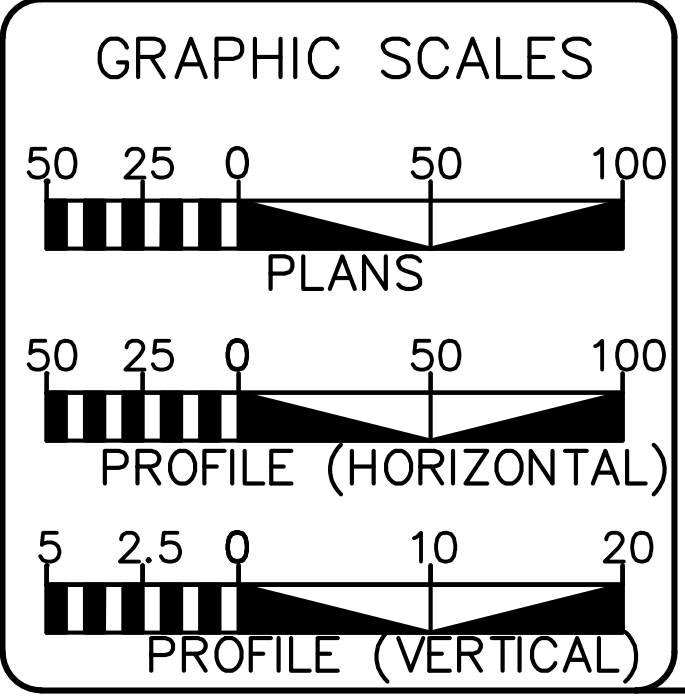

SHEET NO.	DESCRIPTION
UC-1	TITLE SHEET
UC-2	UTILITY SYMBOLOGY
UC-3	NOTES
UC-3A	DETAILS
UC-3B	DETAILS
UC-4	UTILITY CONSTRUCTION PLAN
UC-5 THRU UC-6	UTILITY PROFILES

WATER AND SEWER OWNERS ON PROJECT

- (1) WATER—TOWN OF MOORESVILLE
- (2) FM SANITARY SEWER—TOWN OF MOORESVILLE

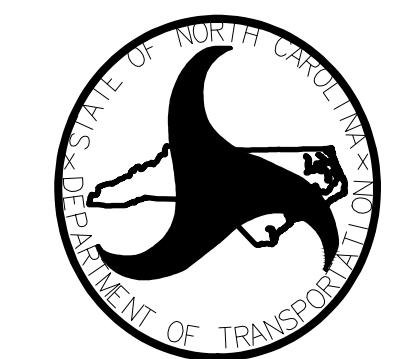

PREPARED IN THE OFFICE OF:
DIVISION OF HIGHWAYS
UTILITIES UNIT
UTILITIES ENGINEERING

1555 MAIL SERVICES CENTER
RALEIGH, NC 27699-1555
PHONE (919) 707-6690
FAX (919) 250-4151

Roger Worthington, P.E. UTILITIES SECTION ENGINEER
Carl Barclay, P.E. UTILITIES SQUAD LEADER PROJECT ENGINEER
James E. Swinson UTILITIES PROJECT DESIGNER

