


TIP PROJECT: U-3440

T.I.P. NO.	SHEET NO.
U-3440	UC-1


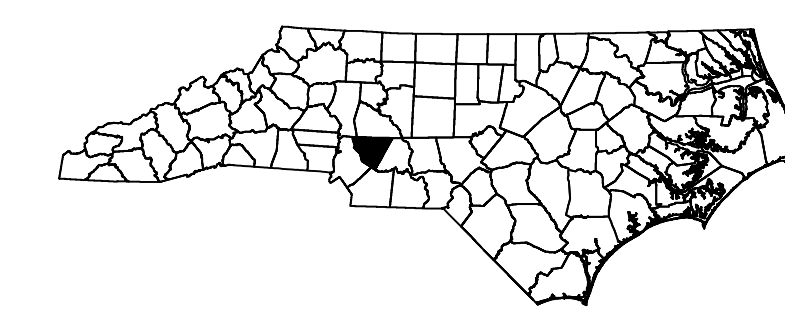


STATE OF NORTH CAROLINA
DIVISION OF HIGHWAYS

CABARRUS COUNTY

LOCATION: NC 3, PROPOSED WEST SIDE BYPASS (U-2009)
TO SR 1691 (LOOP ROAD) IN KANNAPOLIS

TYPE OF WORK: UTILITY CONSTRUCTION

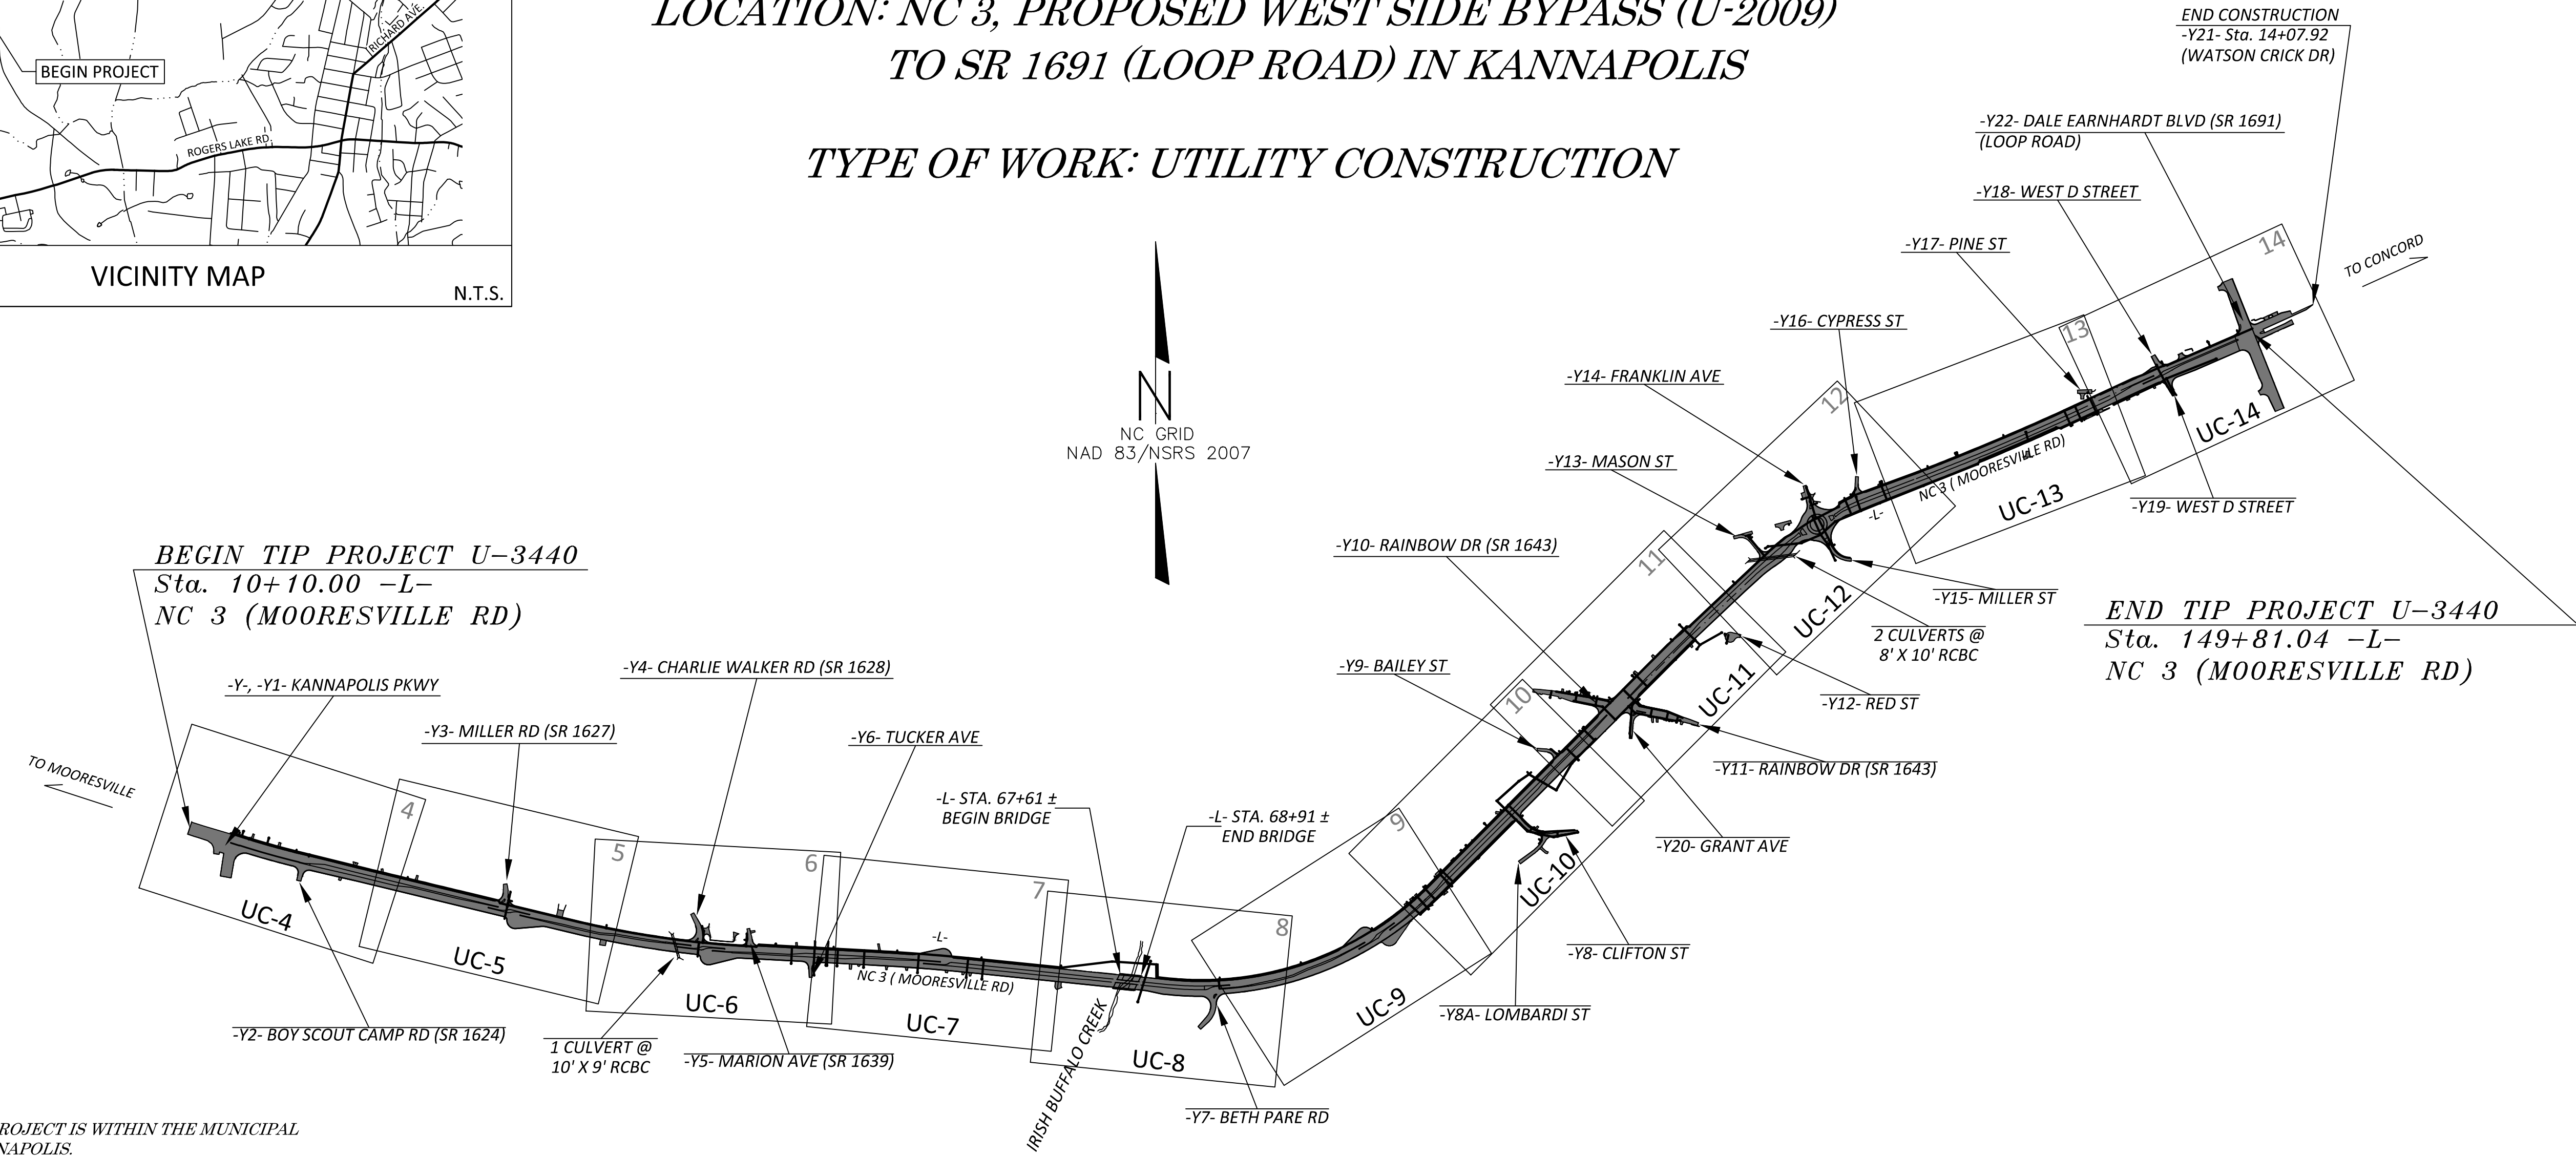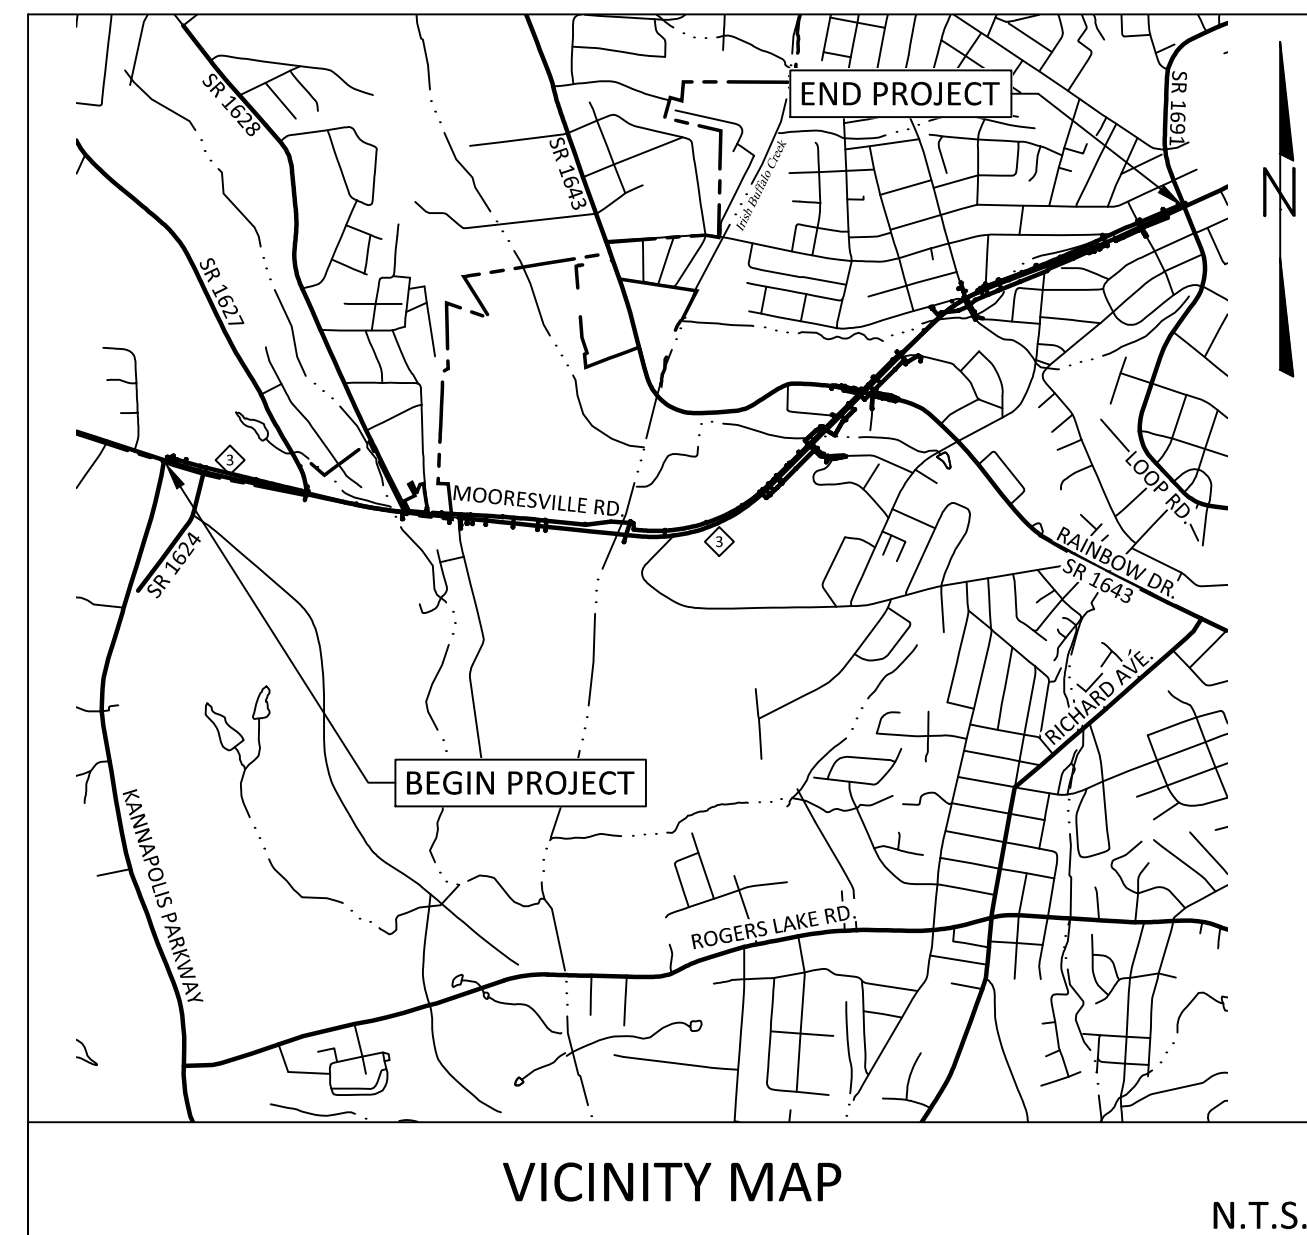


A PORTION OF THIS PROJECT IS WITHIN THE MUNICIPAL BOUNDARIES OF KANNAPOLIS.

THIS IS A PARTIAL CONTROLLED-ACCESS PROJECT WITH ACCESS BEING LIMITED TO POINTS AS SHOWN ON THE PLANS.

CLEARING ON THIS PROJECT SHALL BE PERFORMED TO THE LIMITS ESTABLISHED BY METHOD _____.

DOCUMENT NOT CONSIDERED FINAL
UNLESS ALL SIGNATURES COMPLETED

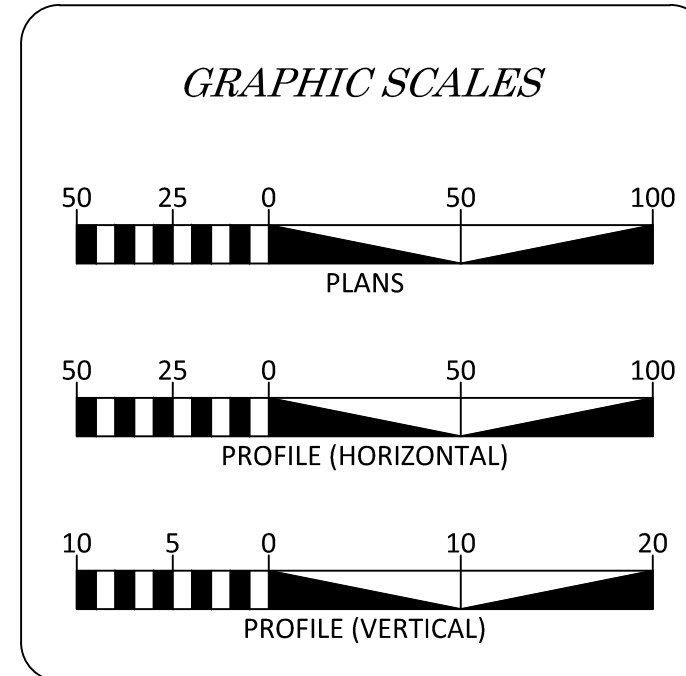

INDEX OF SHEETS

SHEET NO.	DESCRIPTION
UC-1	TITLE SHEET
UC-2	UTILITY SYMBOLOLOGY SHEET
UC-3	NOTES SHEET
UC-3A THRU UC-3E	DETAIL SHEETS
UC-4 THRU UC-14	UTILITY PLAN SHEETS
UC-15 THRU UC-28	UTILITY PROFILE SHEETS

WATER AND SEWER OWNERS ON PROJECT

(1) WATER & SEWER - CITY OF KANNAPOLIS
(2) SEWER - WATER AND SEWER AUTHORITY OF CABARRUS COUNTY (WSACC)

SEAL:

6/29/2016

aww
alley, williams, carmen, & king, inc.
CONSULTING ENGINEERS
130 SOUTH MAIN STREET
KANNAPOLIS, NC 28082
P.O. BOX 1248
704/938-1515

DIVISION OF HIGHWAYS
UTILITIES UNIT
UTILITIES ENGINEERING

1555 MAIL SERVICES CENTER
RALEIGH, NC 27689-1555
PHONE: (919) 707-6690
FAX: (919) 250-4151

Roger Worthington, P.E. UTILITIES SECTION ENGINEER
Carl A. Barclay, P.E. UTILITIES SQUAD LEADER PROJECT ENGINEER
Michael Bright UTILITIES PROJECT DESIGNER
Jeffery D. Moody, P.E. AWKC ENGINEERING PROJECT ENGINEER