


STATE	STATE PROJECT REFERENCE NO.	SHEET NO.	TOTAL SHEETS
N.C.	I-5833	2	

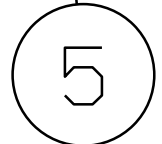


BUNCOMBE COUNTY
McDOWELL COUNTY


TO ASHEVILLE



TRUCK WARNING STATION

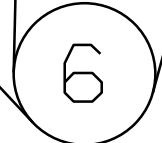

RUNAWAY TRUCK RAMPS

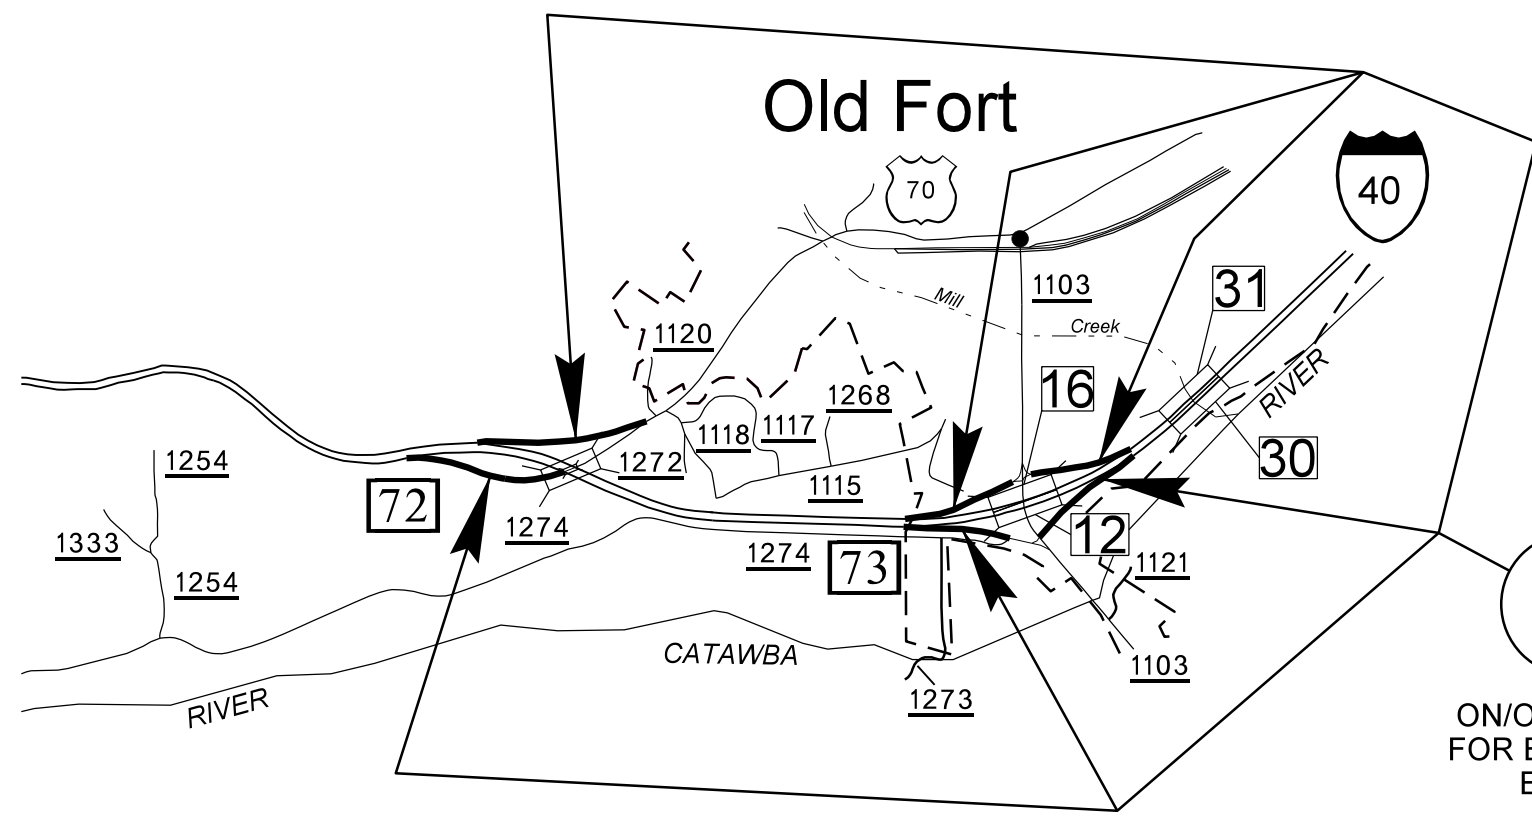

ON/OFF RAMPS FOR EXIT 72 AND EXIT 73

McDOWELL COUNTY

10-OCT-2016 11:11 S:\DDC\rdy\interstate Maintenance Preservation Program\McDowell\I-5833\Revisions\I-5833 Location Maps.dgn \$\$\$USERNAME\$\$\$

09/08/99