


STATE OF NORTH CAROLINA
DIVISION OF HIGHWAYS

STATE	STATE PROJECT REFERENCE NO.	SHEET NO.	TOTAL SHEETS
N.C.	I-5809	1	
STATE PROJ. NO.	F.A. PROJ. NO.	DESCRIPTION	
50452.1.1	NHPP-0040(027)	PE	
50452.3.1	NHPP-0040(027)	CONST.	

30-NOV-2016 13:48 S:\DDC\rdy\interstate Maintenance Preservation Program\McDowell\I-5809\Releigh Revisions\I-5809 Location Maps - Revision.dgn \$\$\$USERNAME\$\$\$

TIP PROJECT: I-5809

CONTRACT: C203870

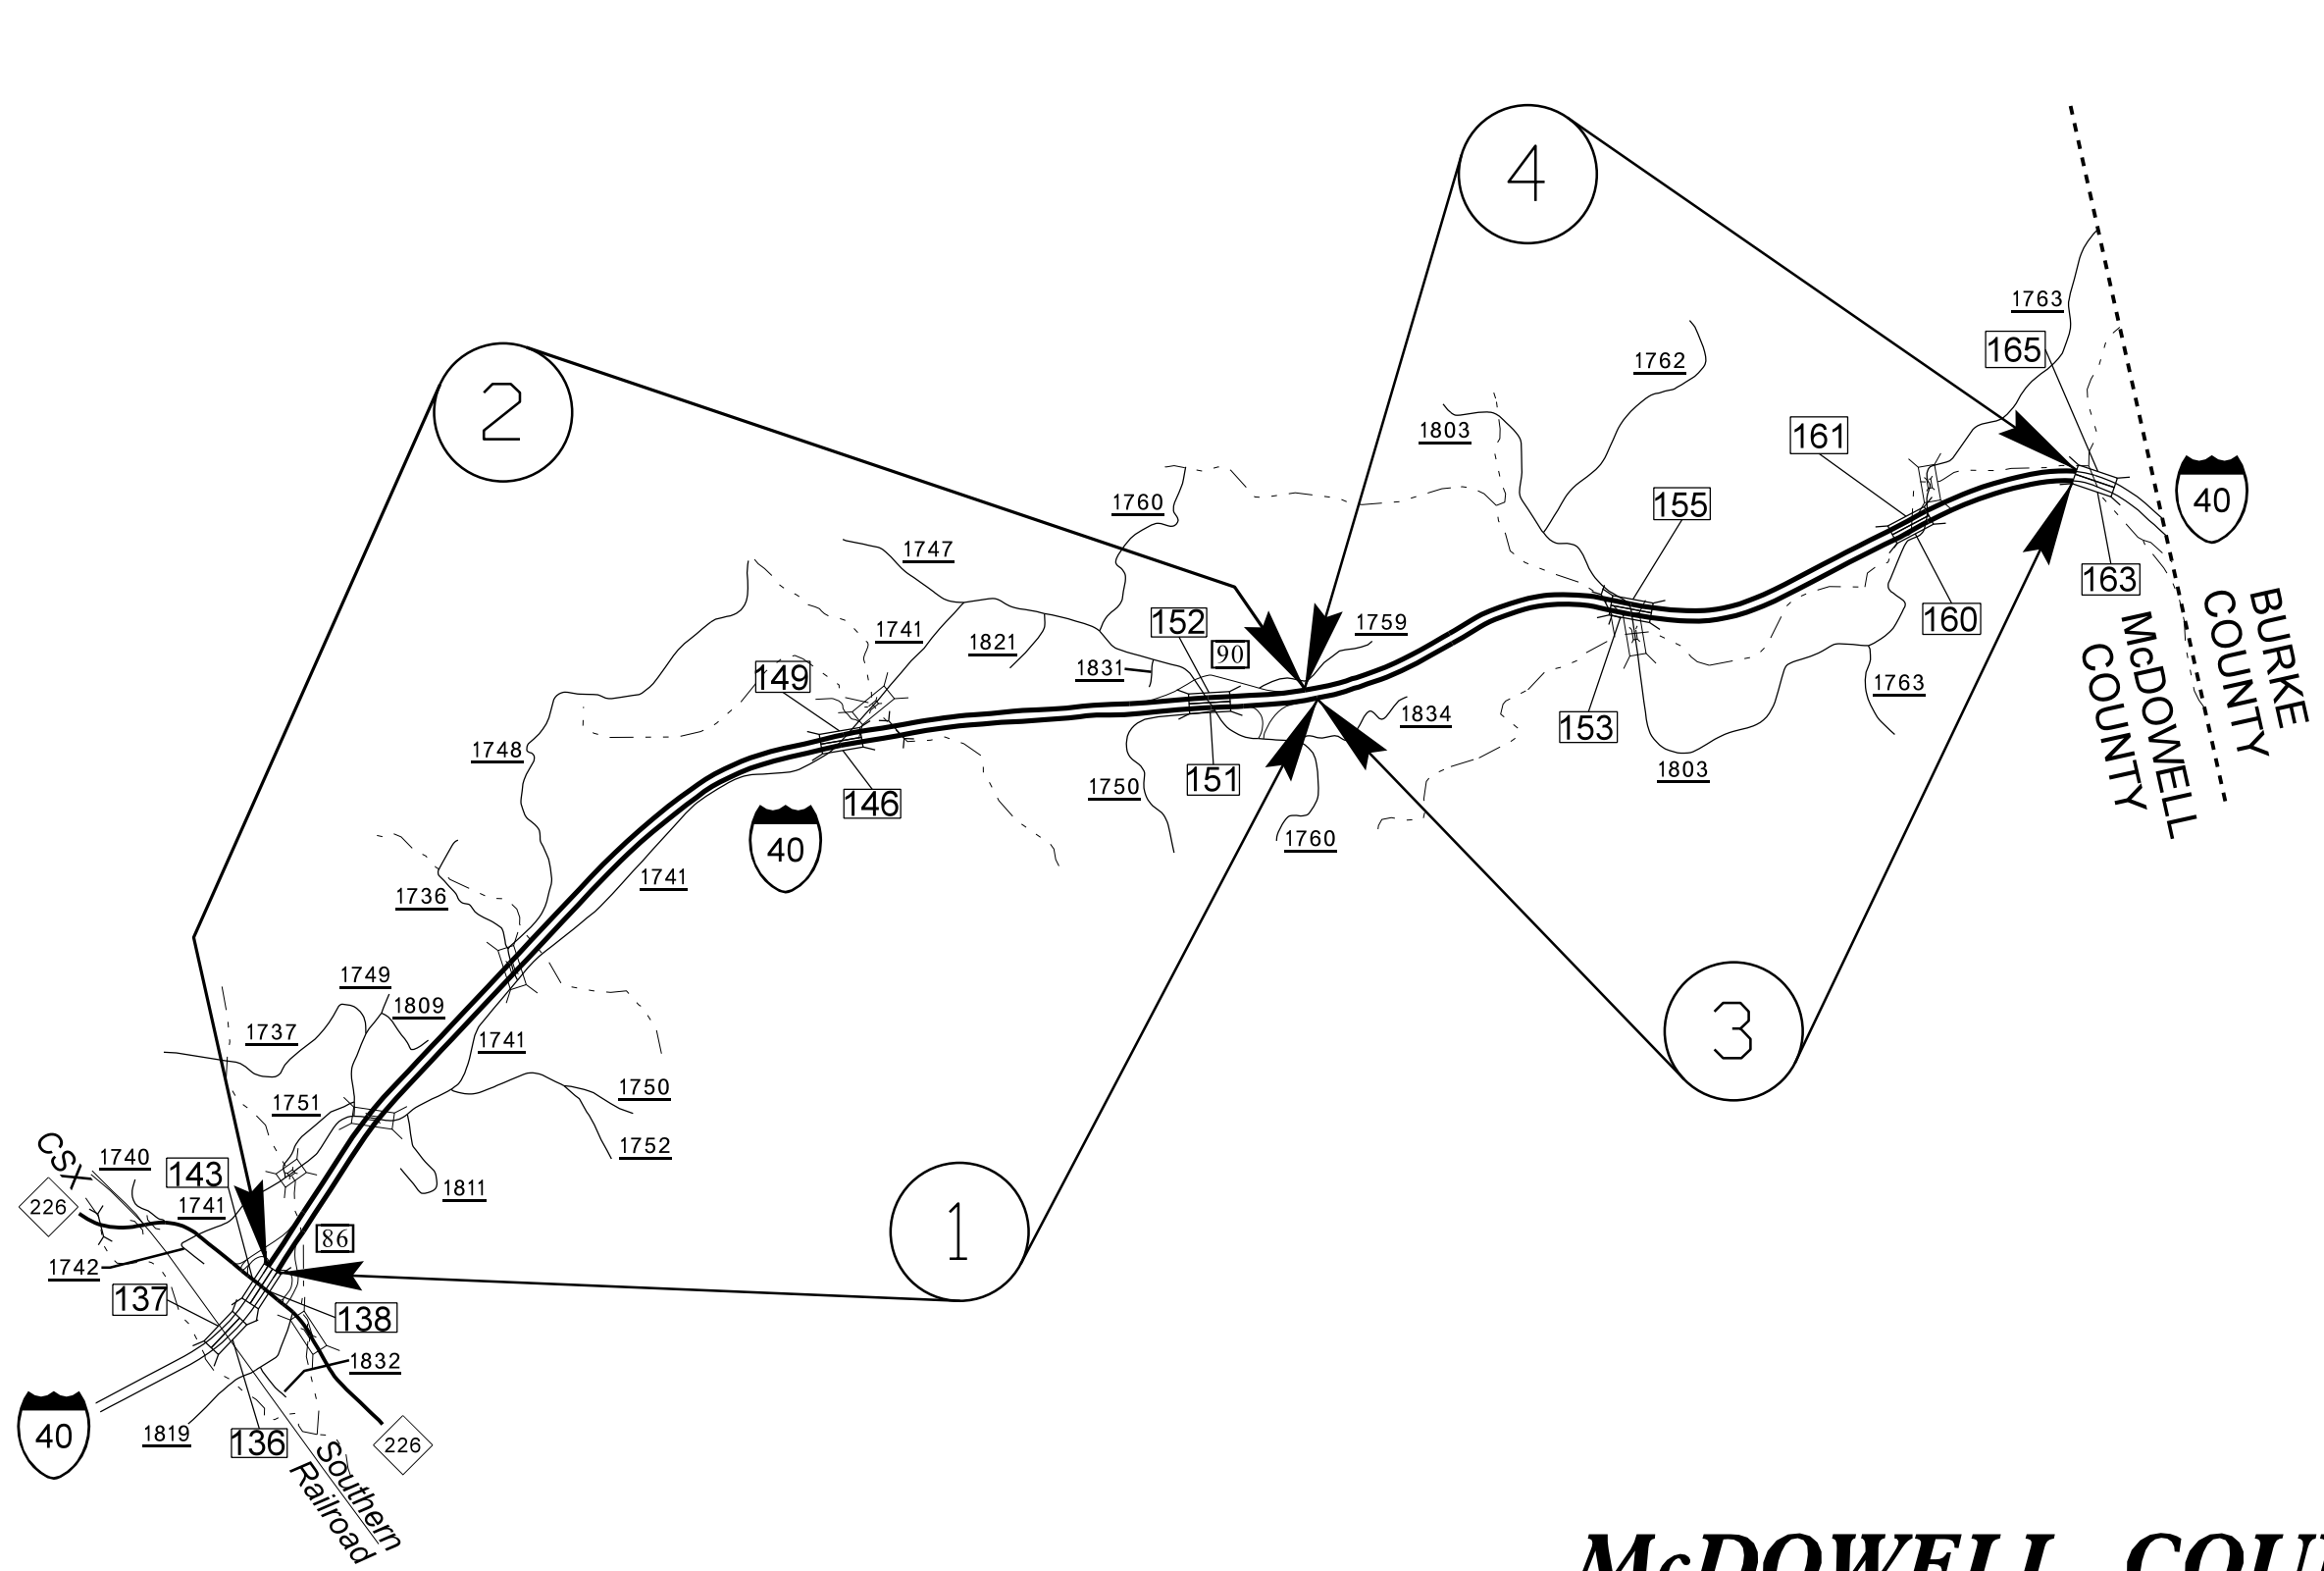

McDOWELL COUNTY