


STATE	STATE PROJECT REFERENCE NO.	SHEET NO.	TOTAL SHEETS
N.C.	I-5809	2	

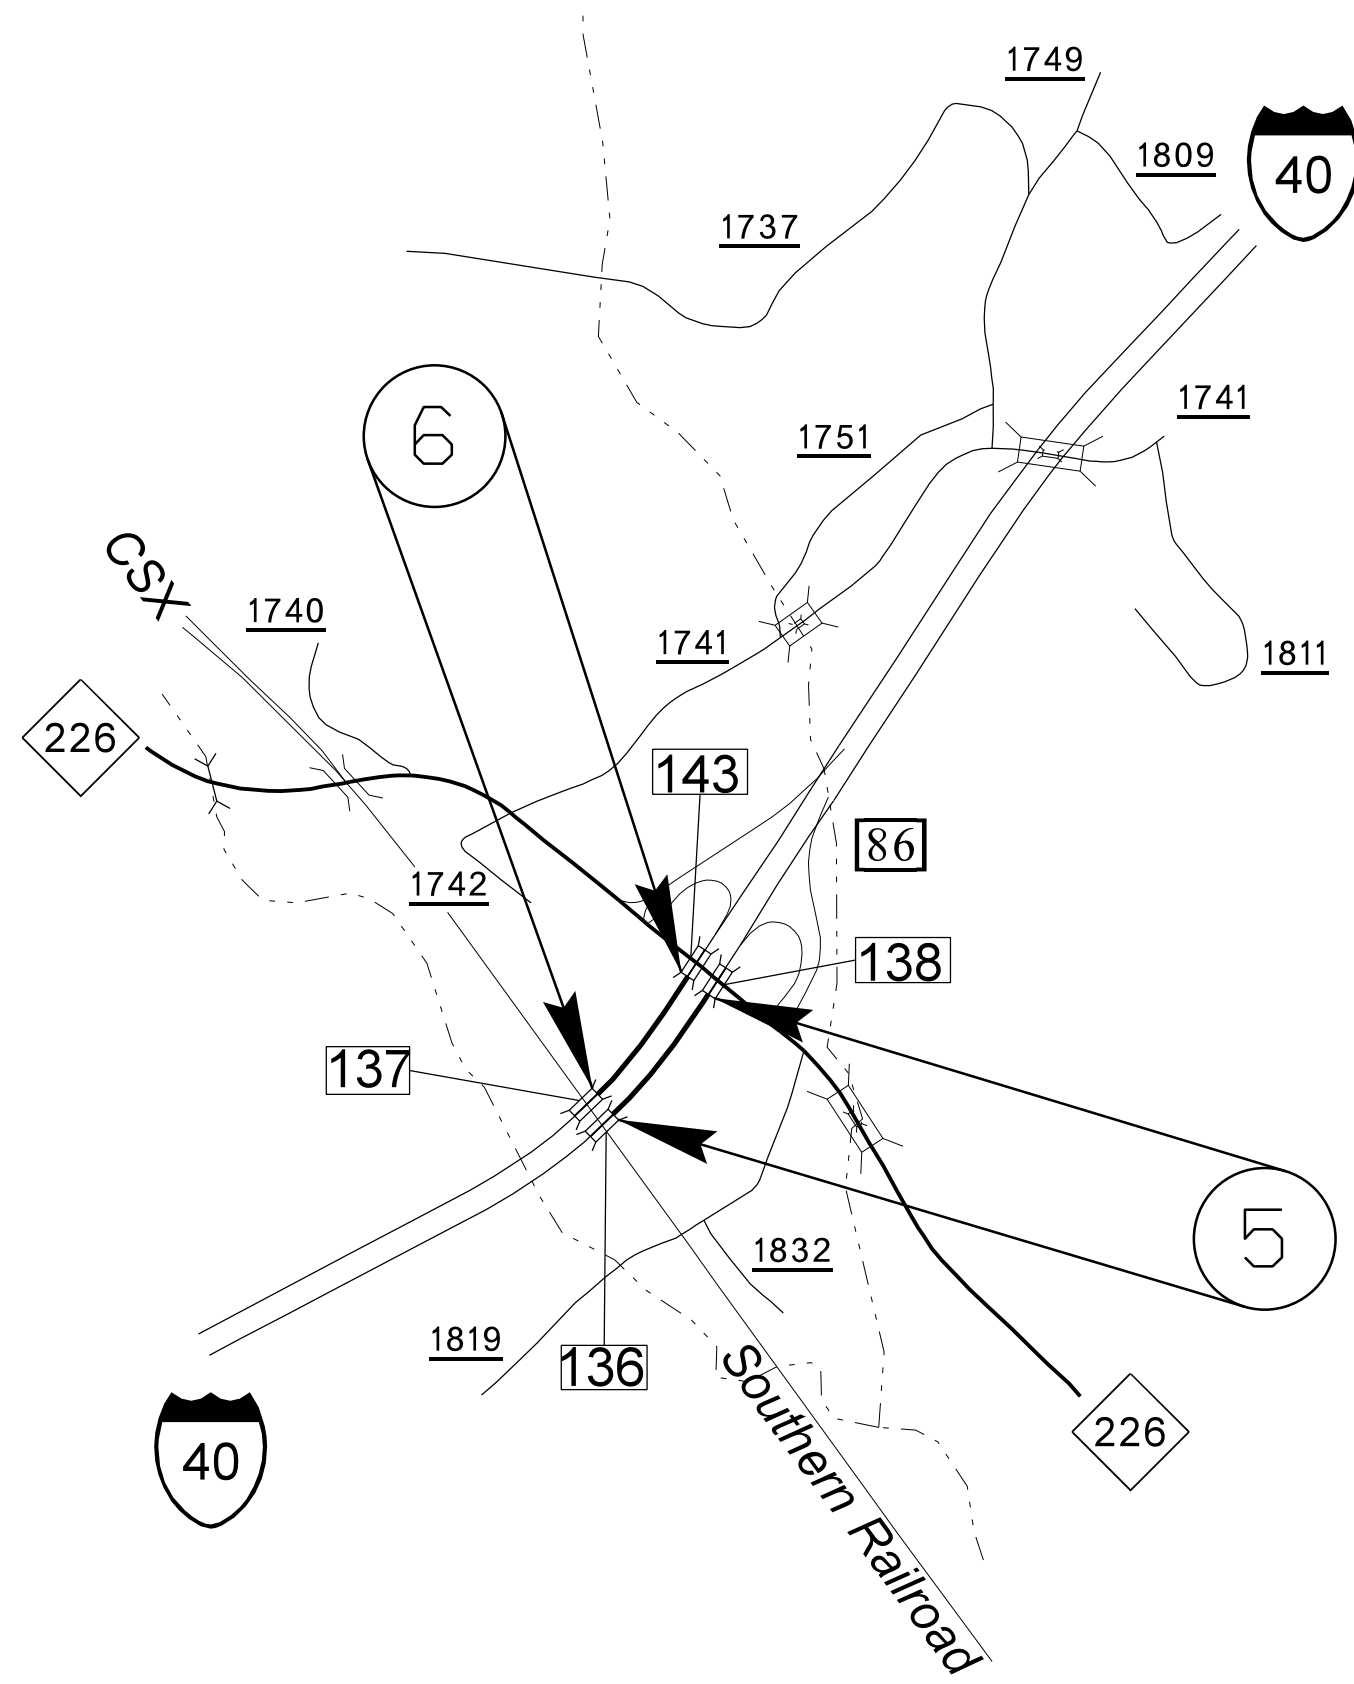

McDOWELL COUNTY

21-OCT-2016 10:21
 S:\DDC\rdy\interstate Maintenance Preservation Program\McDowell\I-5809\Raleigh Letting Package\I-5809 Location Maps.dgn
 \$\$\$USERNAME\$\$\$

09/08/99