


STATE OF NORTH CAROLINA
DIVISION OF HIGHWAYS

STATE	STATE PROJECT REFERENCE NO.	SHEET NO.	TOTAL SHEETS
N.C.	I-5892	1	
STATE PROJ. NO.	F.A. PROJ. NO.	DESCRIPTION	
46413.1.1	NHPP-0026(007)	PE	
46413.3.1	NHPP-0026(007)	CONST.	

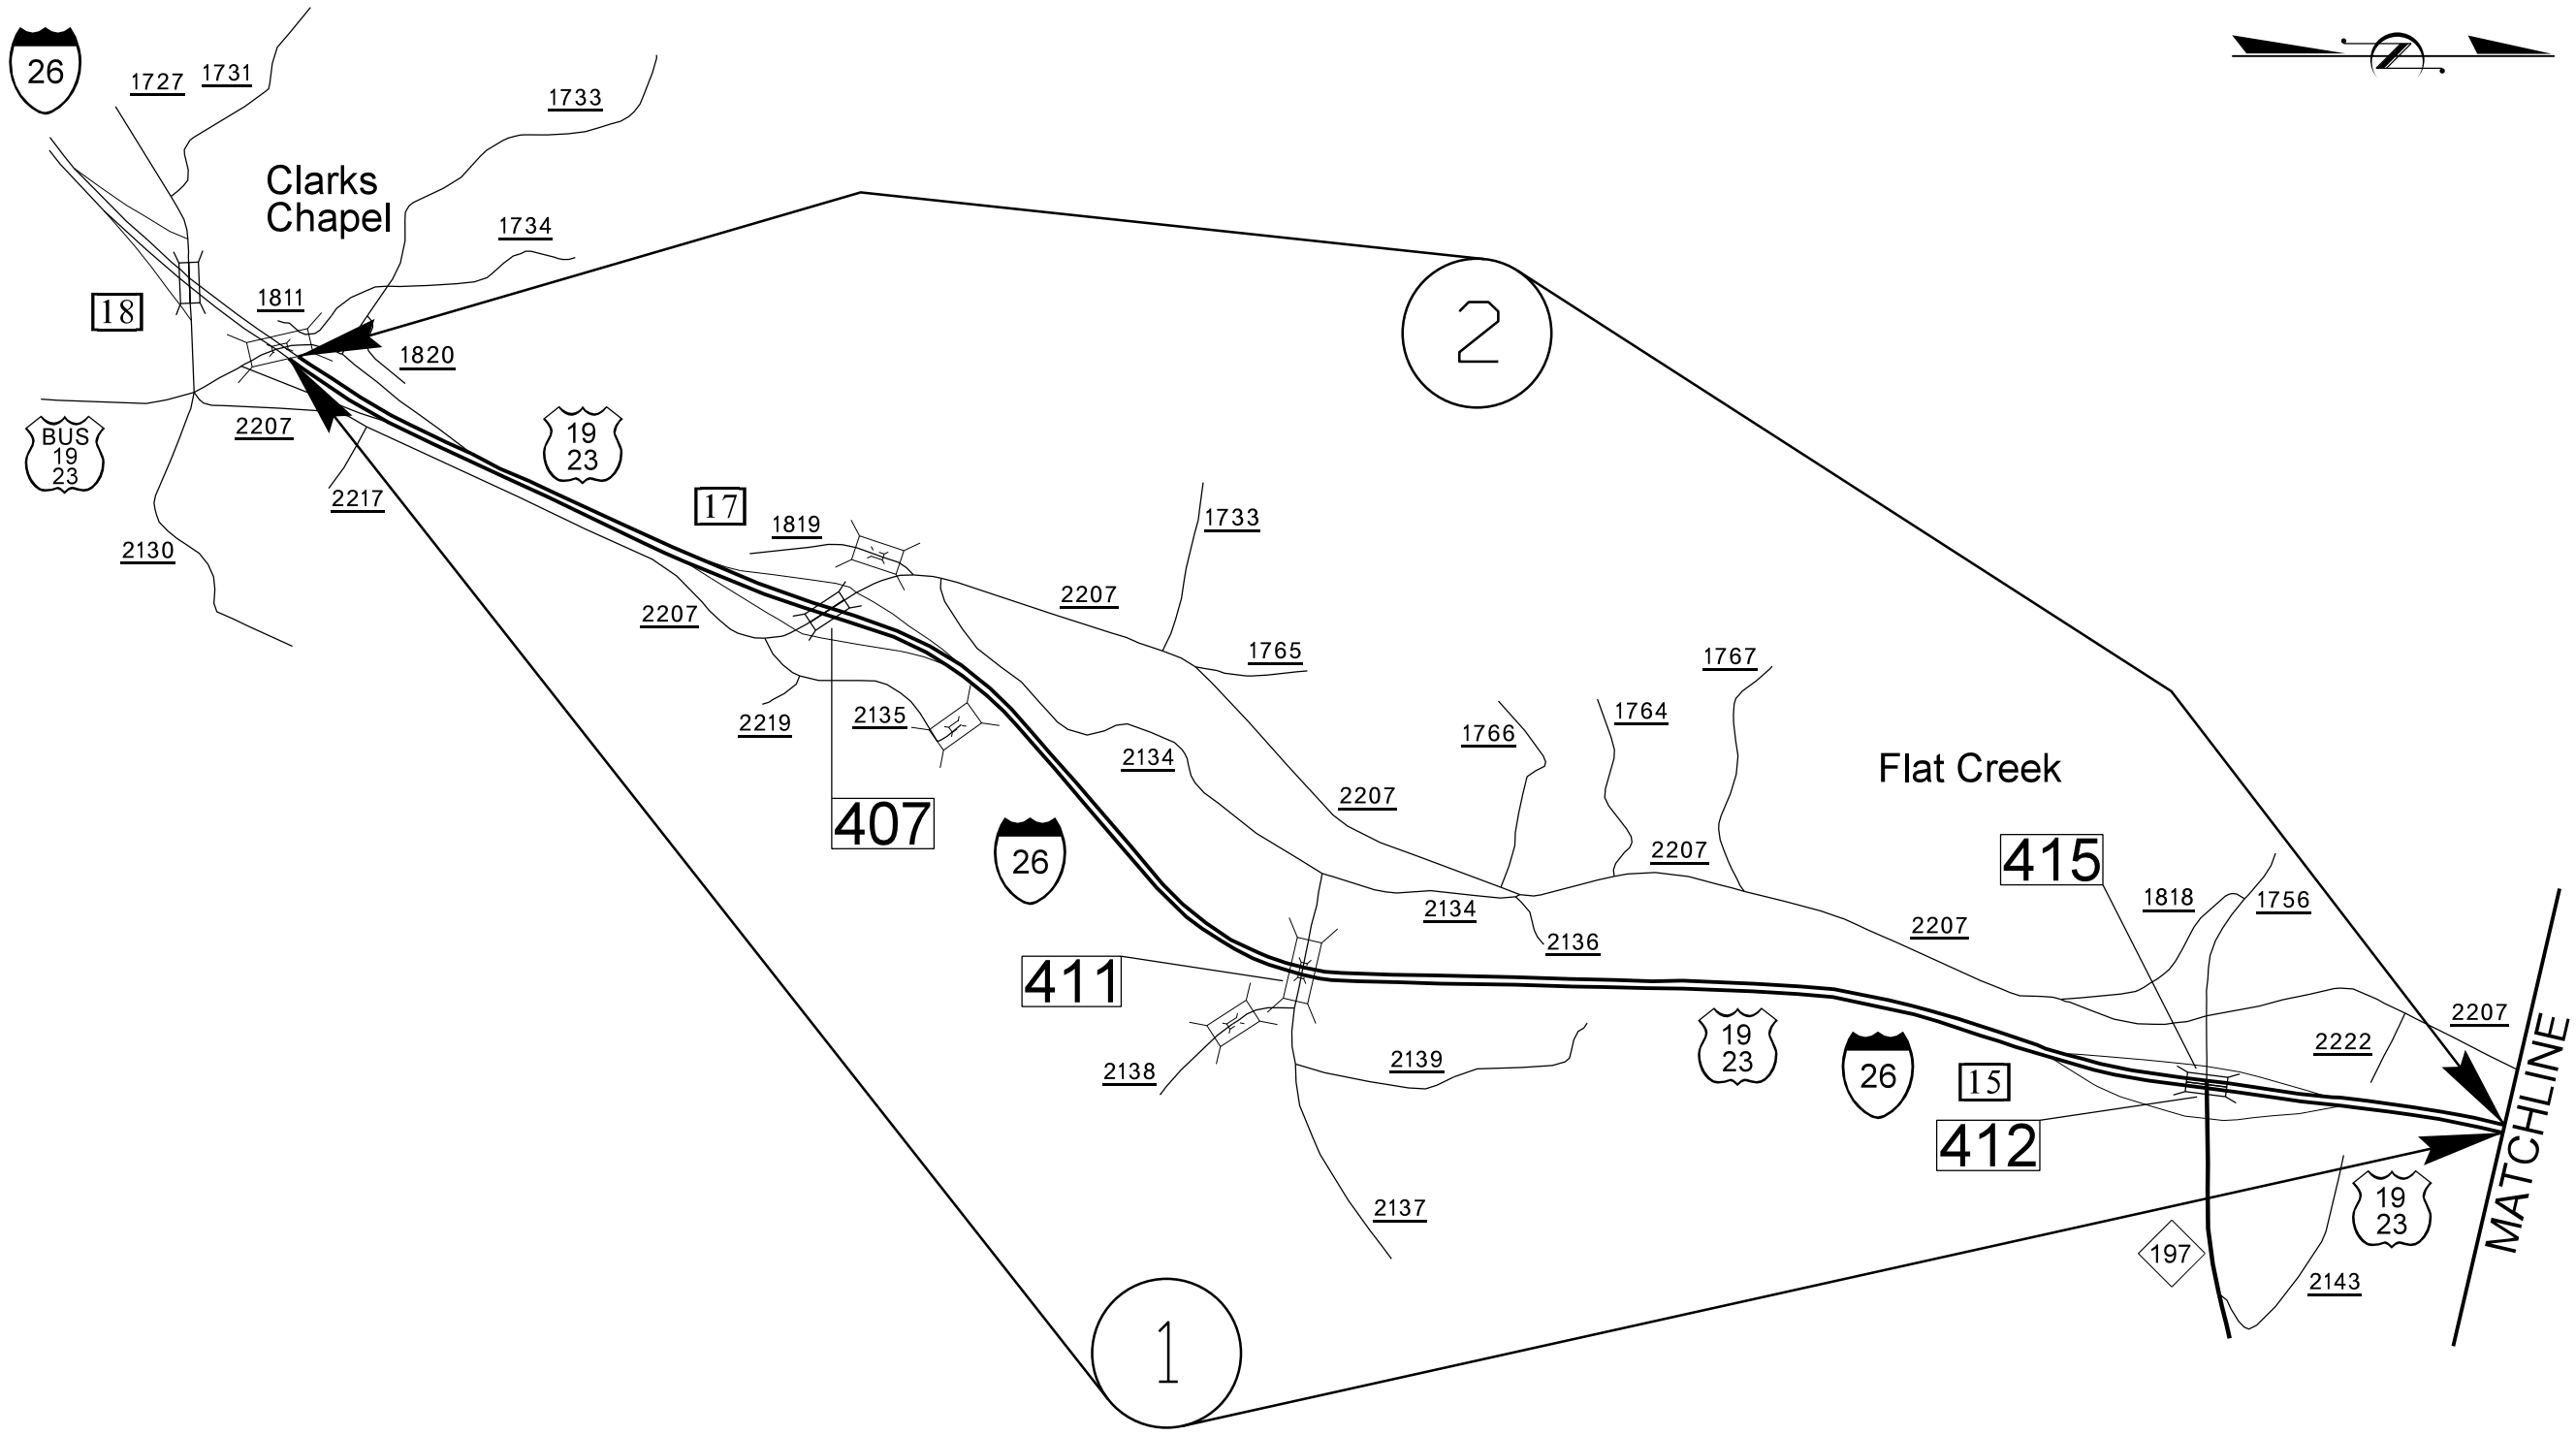

TIP PROJECT: I-5892

CONTRACT: C203873

BUNCOMBE COUNTY

\\DEC-2016 15:36 S:\DDC\rdy\interstate Maintenance Preservation Program\Buncombe\I-5892\Vicinity Maps\I-5892_Location_Map.dgn \$\$\$USERNAME\$\$\$

09/08/99