

13-FEB-2017 15:04 S:\DDC\District\Gaston\I-5894-I-85 MM22 to Countyline\I-5894-Interstate\_Maint\_Gaston\_2017\I-5894-Interstate\_Maintenance\_2017\_Gaston\RDY\_Plans\I-5894\_Rdy\_Tsh.dgn \$\$\$USERNAME\$\$\$


**CONTRACT: C203934** **TIP PROJECT: I-5894**

STATE OF NORTH CAROLINA  
DIVISION OF HIGHWAYS

**GASTON COUNTY**

LOCATION: I-85 -L- LINE AND RAMPS MILE MARKER 22  
TO BRIDGE OVER CATAWBA RIVER (MECKLENBURG COUNTY)

STATE	STATE PROJECT REFERENCE NO.	SHEET NO.	TOTAL SHEETS
N.C.	I-5894	1	
STATE PROJ. NO.	F.A. PROJ. NO.	DESCRIPTION	
46436.1.1	NHPIM-0085(031)	PE	
46436.3.1	NHPIM-0085(031)	CONST.	

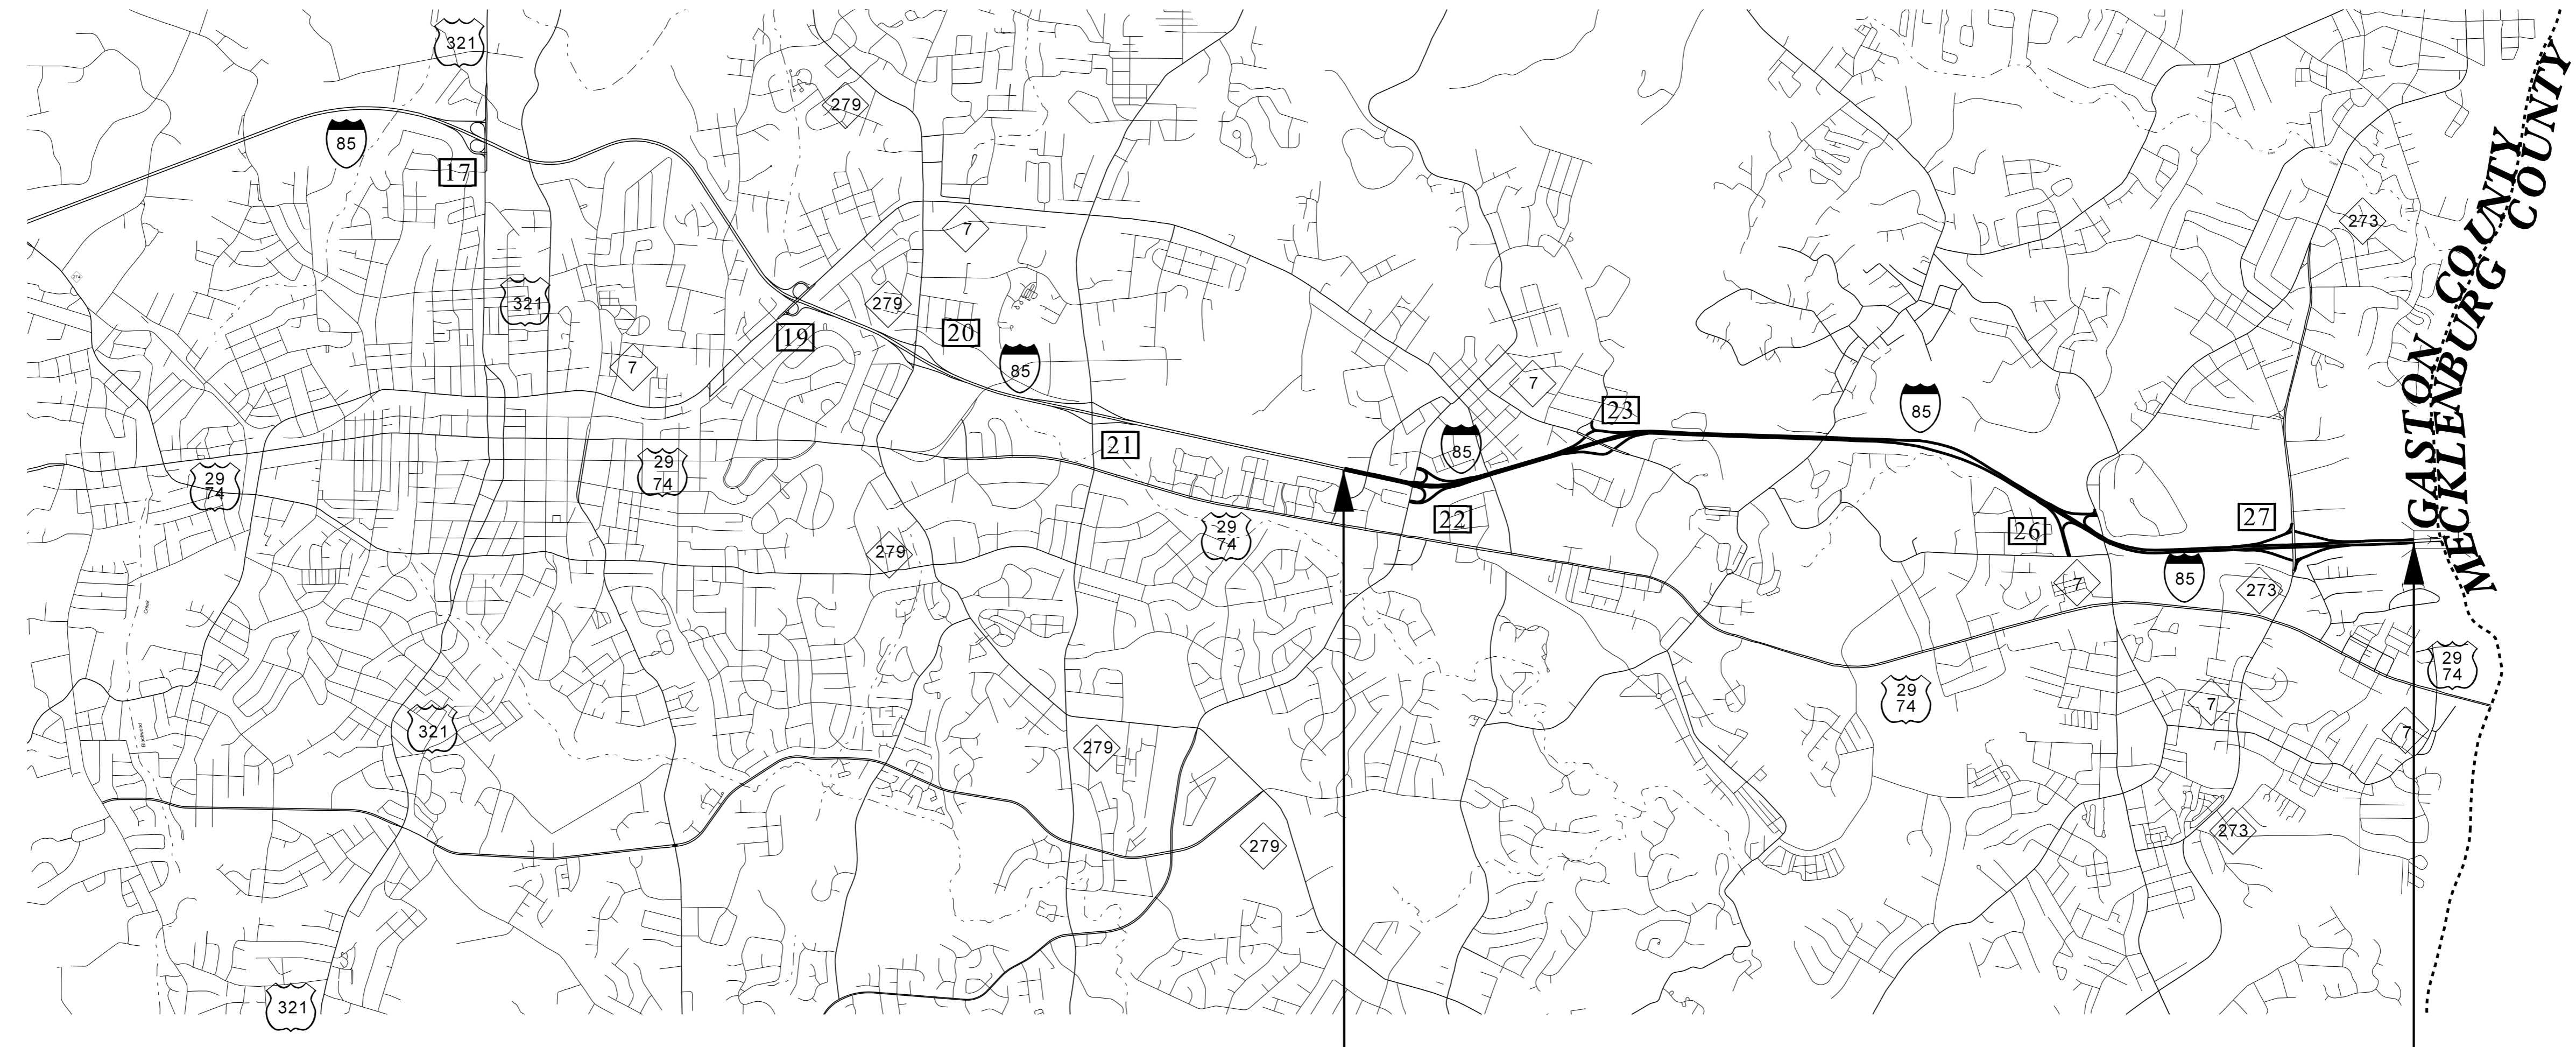

**BEGIN PROJECT I-5894**  
**MILE MARKER 22**

**END PROJECT I-5894**  
**BRIDGE OVER CATAWBA RIVER**

**PROJECT LENGTH**

LENGTH ROADWAY TIP PROJECT I-5894 = 5.6 MI

Prepared in the Office of:  
**DIVISION OF HIGHWAYS**  
1710 EAST MARION ST., SHELBY NC 28151

2012 STANDARD SPECIFICATIONS

LETTING DATE:  
MARCH 21, 2017

C.G. GURLEY, PE  
DIVISION MAINTENANCE ENGINEER

B.K. SOWELL, PE  
PROJECT DESIGN ENGINEER

