
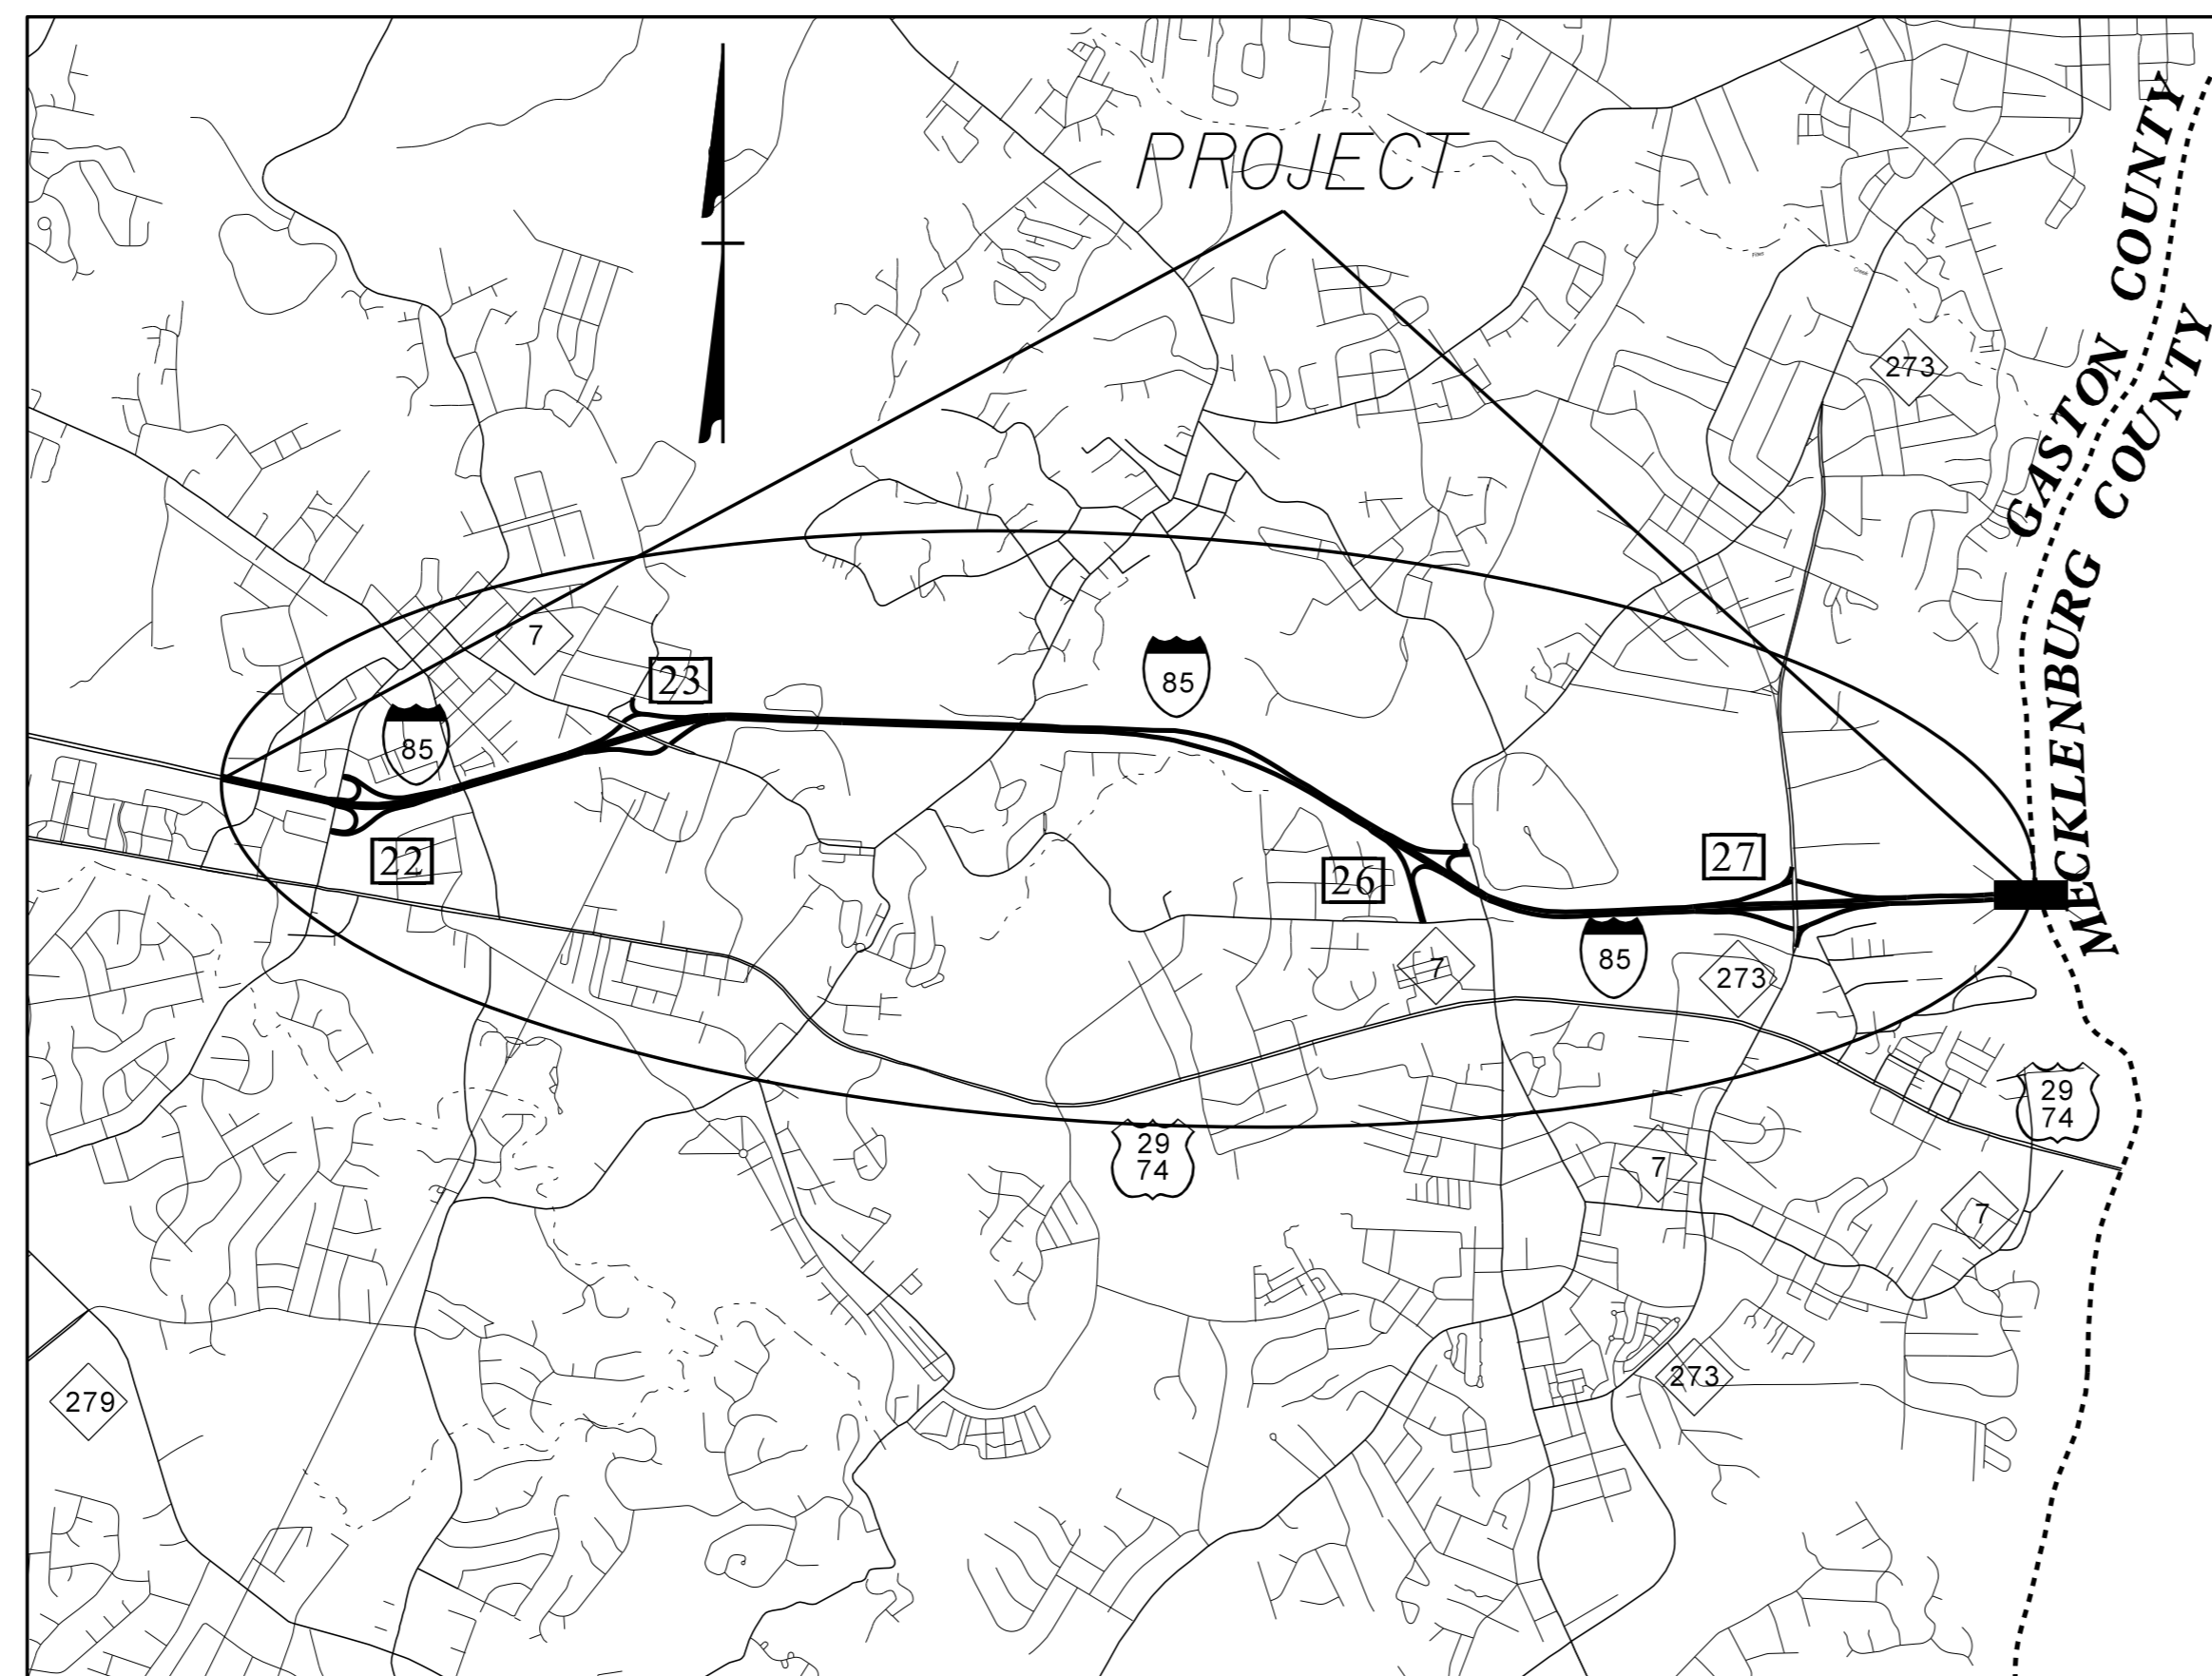


STATE OF NORTH CAROLINA  
DIVISION OF HIGHWAYS

**TRANSPORTATION MANAGEMENT PLAN**

**GASTON COUNTY**

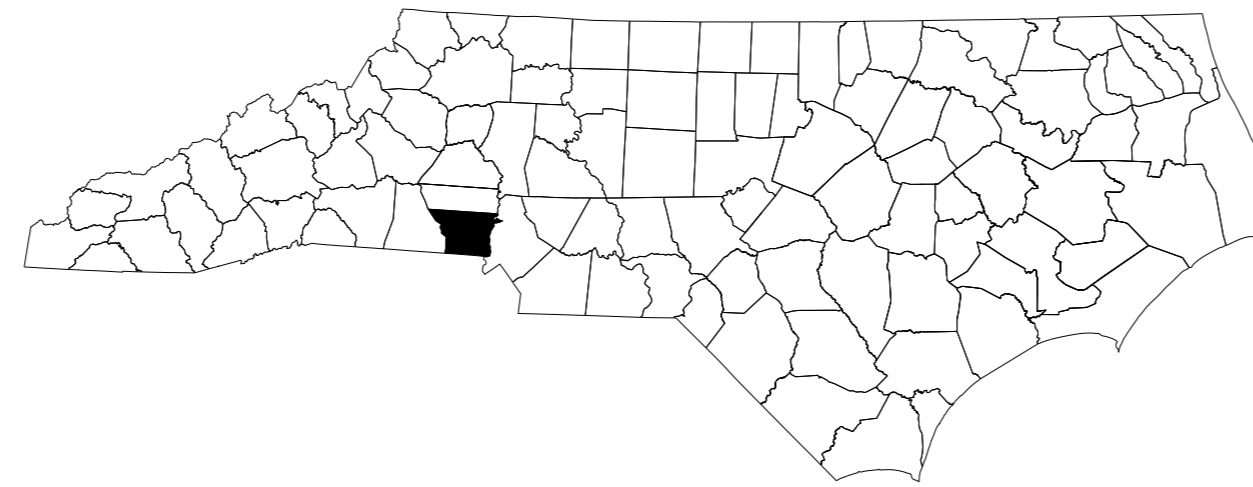

VICINITY MAP

SHEET NO.	TITLE
TMP-1	TITLE SHEET, VICINITY MAP, AND INDEX OF SHEETS
TMP-1A	LIST OF APPLICABLE ROADWAY STANDARD DRAWINGS, AND LEGEND
TMP-1B	TRANSPORTATION OPERATIONS PLAN: (MANAGEMENT STRATEGIES, GENERAL NOTES, AND LOCAL NOTES)
TMP-2-9	DETOURS FOR RAMP AND LOOP CLOSURES
TMP-10	STATIONARY ADVANCE WARNING SIGNS
TMP-11	WORK ZONE VARIABLE SPEED LIMIT DIGITAL SIGNS
TMP-12	WORK ZONE PRESENCE LIGHTING

SHEET NO.  
TMP-1

**I-5894**



**TIP PROJECT:**

DOCUMENT NOT CONSIDERED FINAL  
UNLESS ALL SIGNATURES COMPLETED

APPROVED: *Bryan Sowell*

DATE: 1/31/2017

SEAL

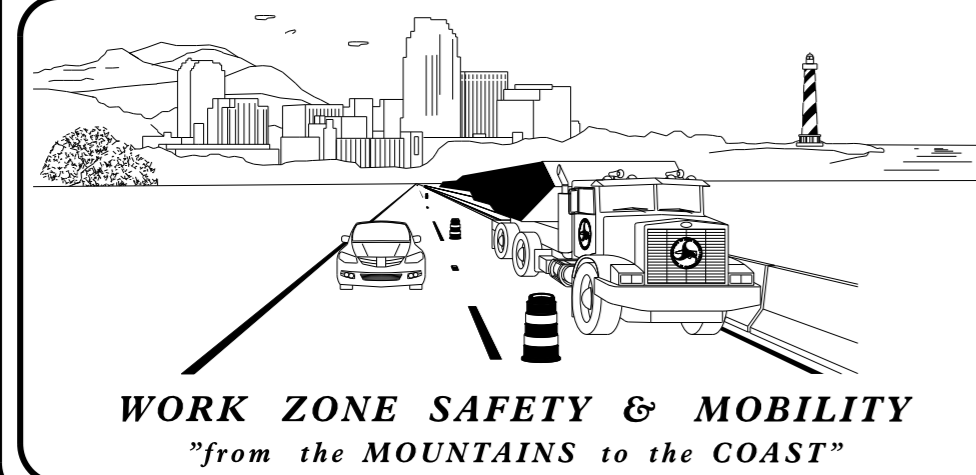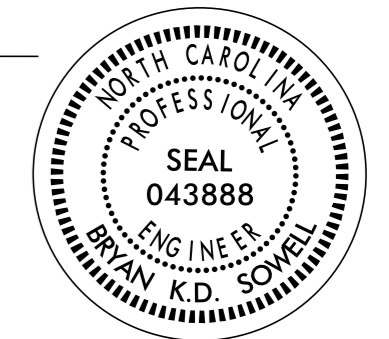


**N.C.D.O.T. WORK ZONE TRAFFIC CONTROL**  
1561 MAIL SERVICE CENTER (MSC) RALEIGH, NC 27699-1561  
750 N. GREENFIELD PARKWAY, GARNER, NC 27529 (DELIVERY)  
PHONE: (919) 773-2800 FAX: (919) 771-2745

J. S. BOURNE, P.E. STATE TRAFFIC MANAGEMENT ENGINEER

TRAFFIC CONTROL PROJECT ENGINEER

TRAFFIC CONTROL PROJECT DESIGN ENGINEER

TRAFFIC CONTROL DESIGN ENGINEER

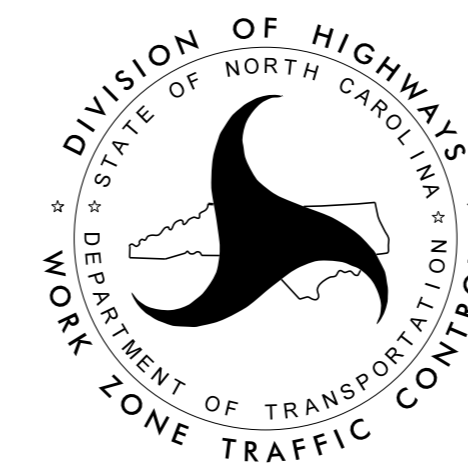

31-JAN-2017 13:19 S:\DDC\DISTRICT\Gaston\I-5894\I-5894\_Interstate\_Maint\_Gaston\_2017\I-5894\_Interstate\_Maintenance\_2017\_Gaston\Traffic Control\Plans\I-5894\_TC\_TMP\_01.dgn