




WIRELESS COMMUNICATIONS PLAN

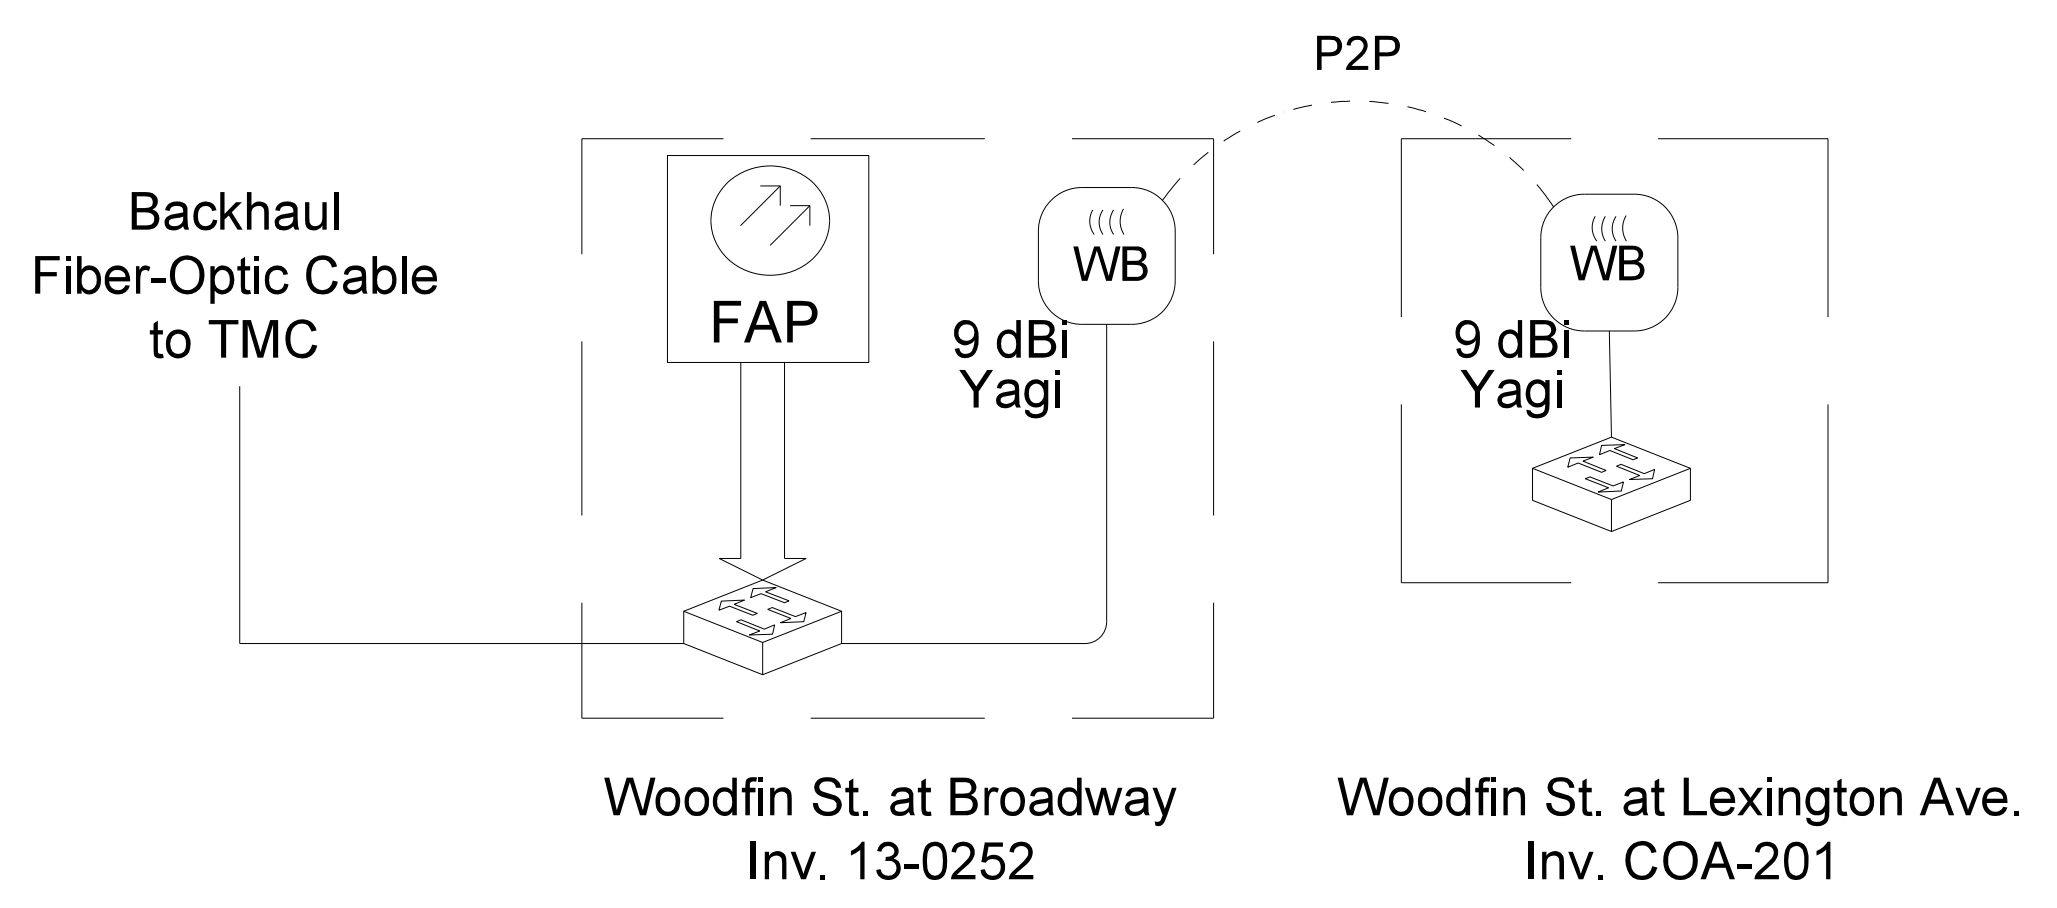

Woodfin Street

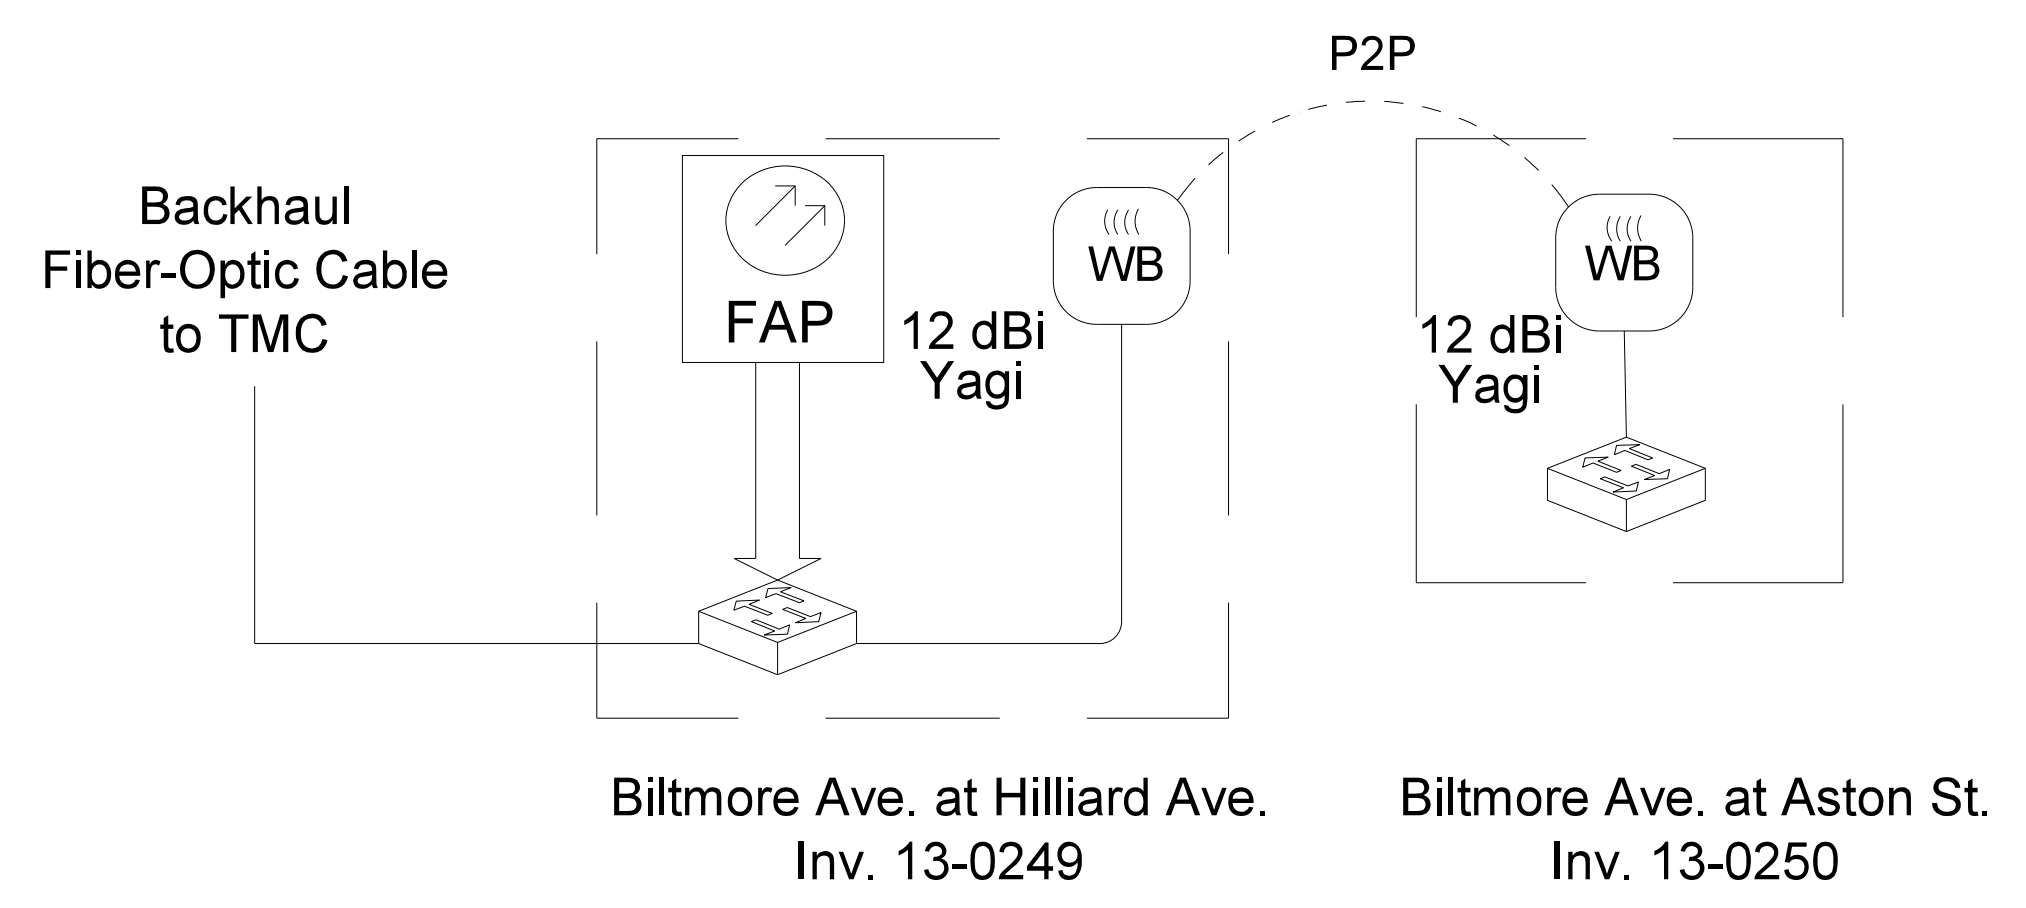

Biltmore Avenue

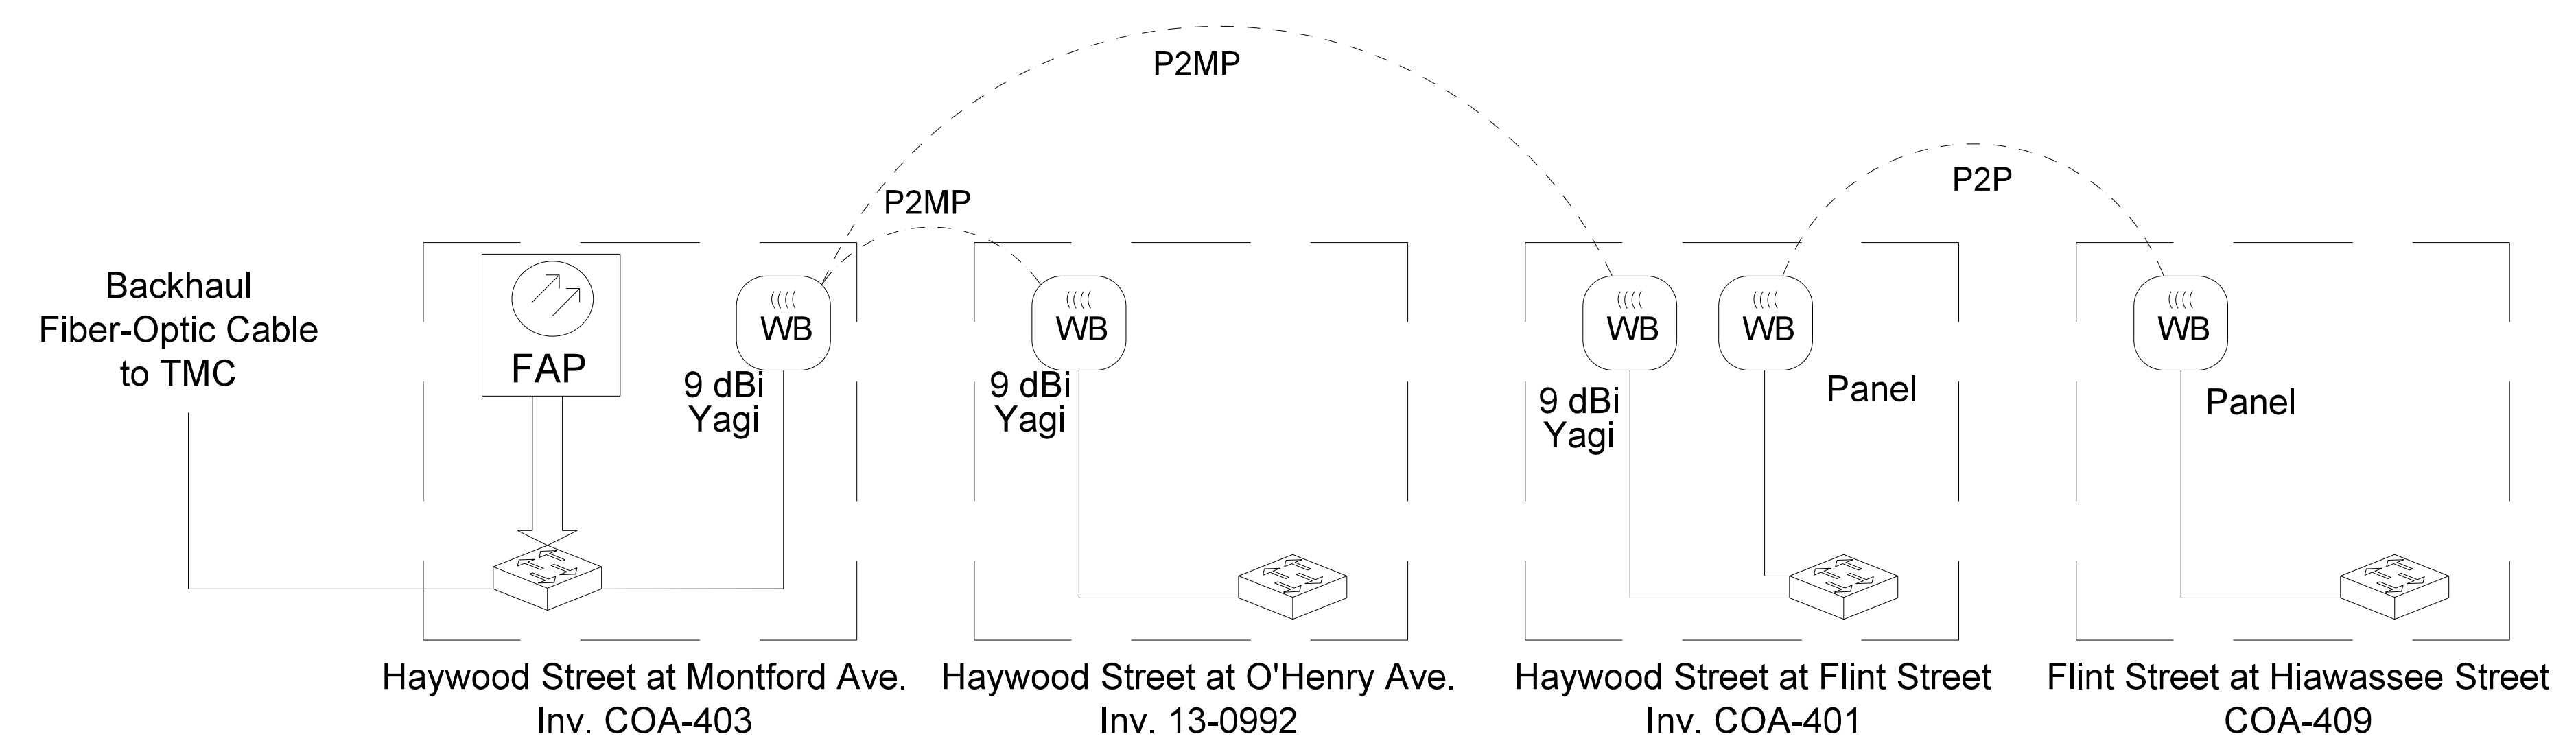

Haywood Street/Flint Street

LEGEND:

- FAP- Fiber Access Point
- WB- Wireless Bridge
- WR- Wireless Repeater
- Ethernet Switch
- Firewall
- Cellular Modem

21-DEC-2016, 14:13
G:\Transportation\Projects\Asheville\1100048632_U-4715B_Ashville\1100048632_U-4715B_ITS-3.03.dgn
0:\Users\jbrooks\Documents\Projects\Asheville\1100048632_U-4715B_ITS-3.03.dgn
00107303 AT LUS355195

ATKINS
1616 EAST MILLBROOK ROAD, SUITE 310
RALEIGH, NORTH CAROLINA 27609
(919) 876-6888 NCBES #F-0326

DOCUMENT NOT CONSIDERED FINAL
UNLESS ALL SIGNATURES COMPLETED

Seal of the State of North Carolina
Professional Engineer
HENRY ALFRED BADGETT
SEAL 019962

NC <i>Transportation</i>	Wireless Corridor Design Asheville Signal System (2 of 7)							
	Division 13	Buncombe County Asheville						
750 Greenfield Parkway, Garner, NC 27529	SCALE N.T.S.	<table border="1" style="width: 100%; border-collapse: collapse;"> <tr> <td style="width: 50%;">PREPARED BY: G B Spell</td> <td style="width: 50%;">REVIEWED BY: H A Badgett</td> </tr> <tr> <td style="width: 50%;">REVISIONS</td> <td style="width: 50%;">INIT. DATE</td> </tr> <tr> <td> </td> <td> </td> </tr> </table>	PREPARED BY: G B Spell	REVIEWED BY: H A Badgett	REVISIONS	INIT. DATE		
PREPARED BY: G B Spell	REVIEWED BY: H A Badgett							
REVISIONS	INIT. DATE							

Prepared for the Offices of:

12/21/2016
DATE

CADD File name: 270_007_U-4715B