
 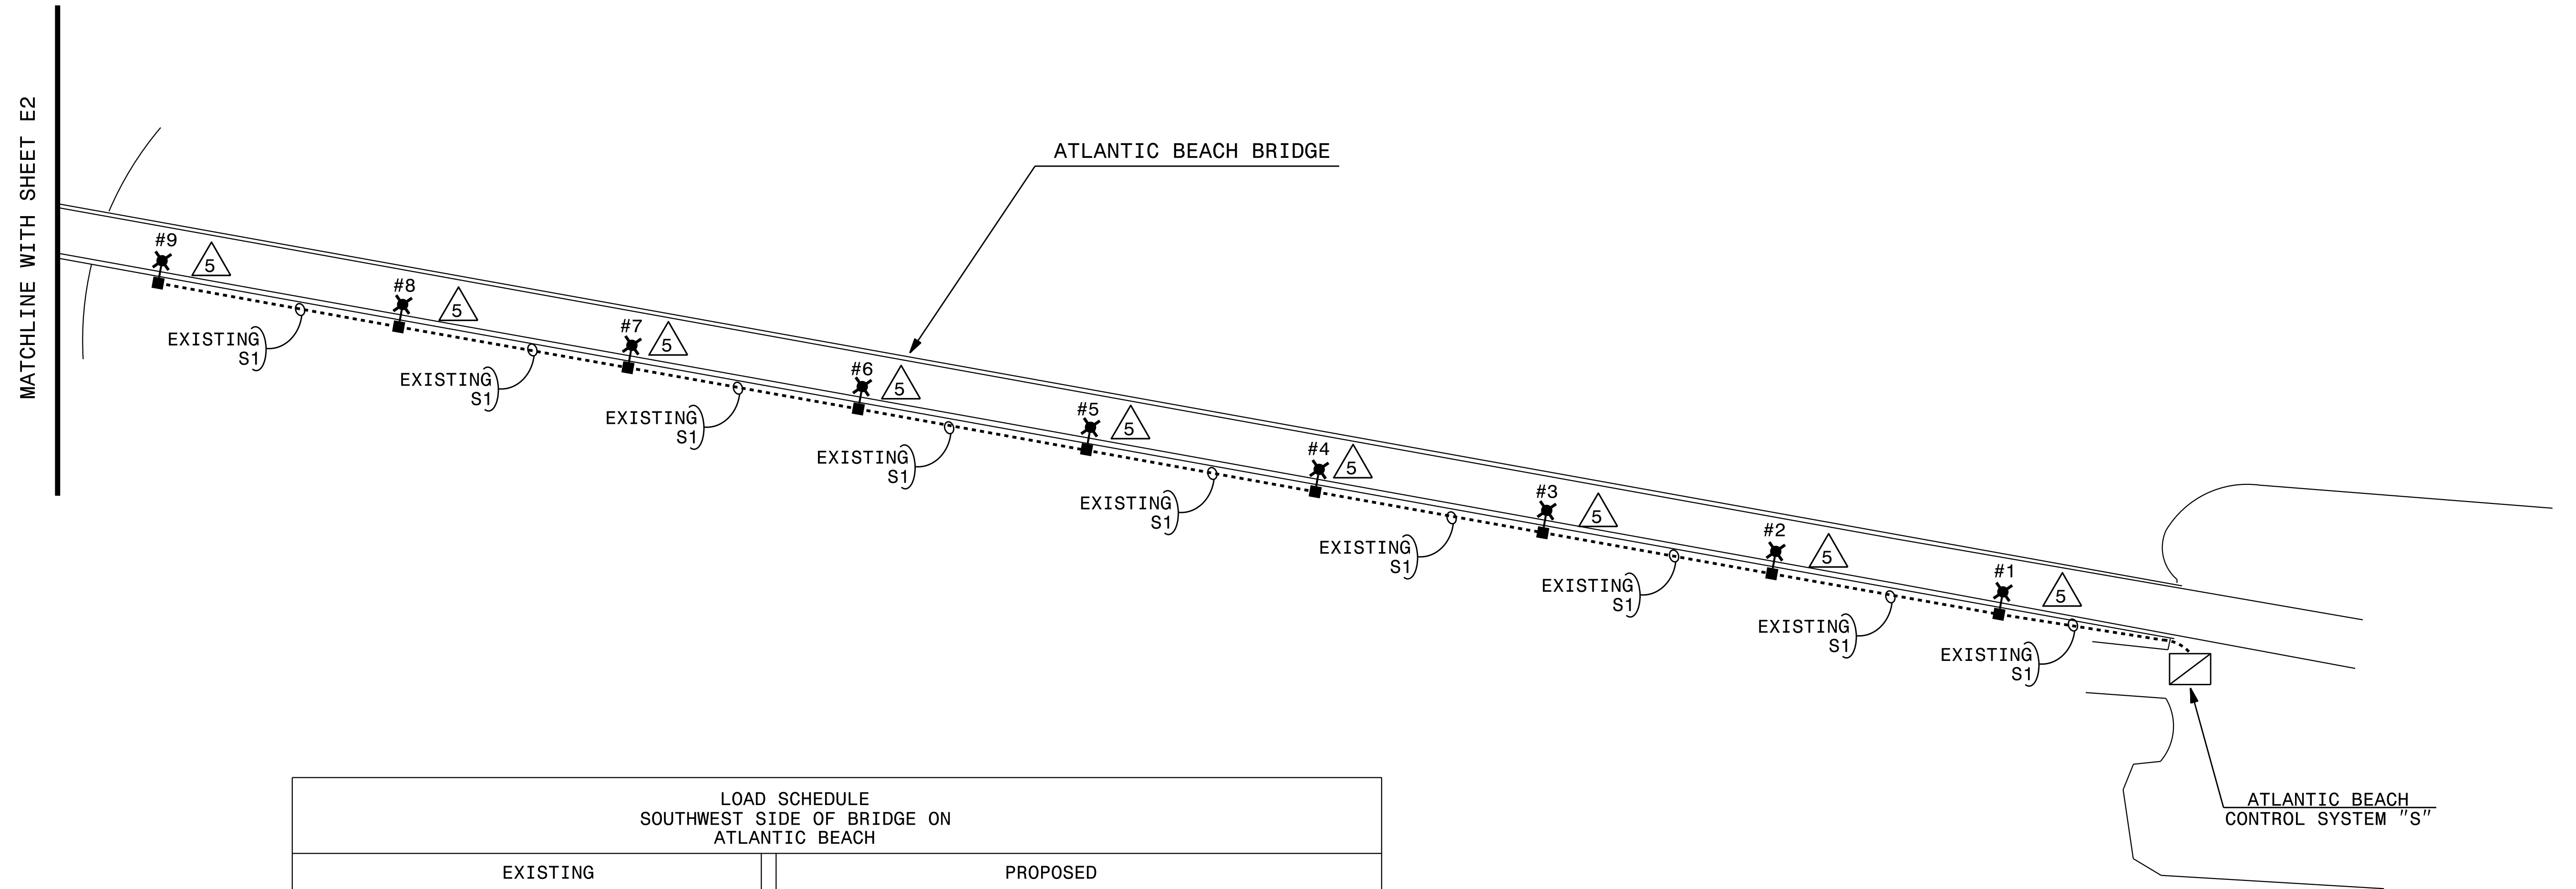


USE FOR LIGHTING CONSTRUCTION ONLY

DCM



LOAD SCHEDULE SOUTHWEST SIDE OF BRIDGE ON ATLANTIC BEACH								
EXISTING				PROPOSED				
1Ø, 3W, 120/240 VAC				1Ø, 3W, 120/240 VAC				
CIRCUIT ID	SINGLE ARM 1 @ 250W HPS	AMPS @ 240V	KW LOAD	CIRCUIT ID	SINGLE ARM 1 @ 220W MAX. LED	AMPS @ 240V	KW LOAD	BREAKER SIZE (AMPS)
S1	#1-#9	12.0	2.9	S1	#1-#9	8.25	1.98	UNKNOWN
SPARE				SPARE				UNKNOWN
TOTAL	9	12.0	2.9	TOTAL	9	8.25	1.98	


* NOTE: ORIGINAL WORK WAS DONE ON SUPPLEMENTAL AGREEMENT DATED 12-3-1986 UNDER STATE PROJECT # 8.2160203

PROJECT NO. **B-5938**
CARTERET COUNTY

SHEET 3 OF 6

STATE OF NORTH CAROLINA
 DEPARTMENT OF TRANSPORTATION
 RALEIGH

LIGHTING LAYOUT
 ATLANTIC BEACH BRIDGE
 BRIDGE # 68 ON SR 1182
 OVER BOGUE SOUND

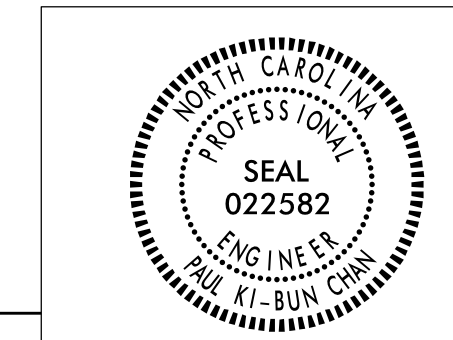

DocuSigned by:
 Paul Chan
 1/20/2017

SEE PROJECT SPECIAL PROVISIONS TITLED
 "LIGHTING" FOR MATERIALS
 CONSTRUCTION METHODS AND PAYMENT.

REVISIONS						SHEET NO. L-3
NO.	BY:	DATE:	NO.	BY:	DATE:	
1			3			TOTAL SHEETS 6
2			4			

18-JAN-2017 12:35
 P:\Projects\18-0000\18-0000\Lighting Design\B5938-1&e-psh.e3.dgn
 \$\$\$USERNAME\$\$\$