
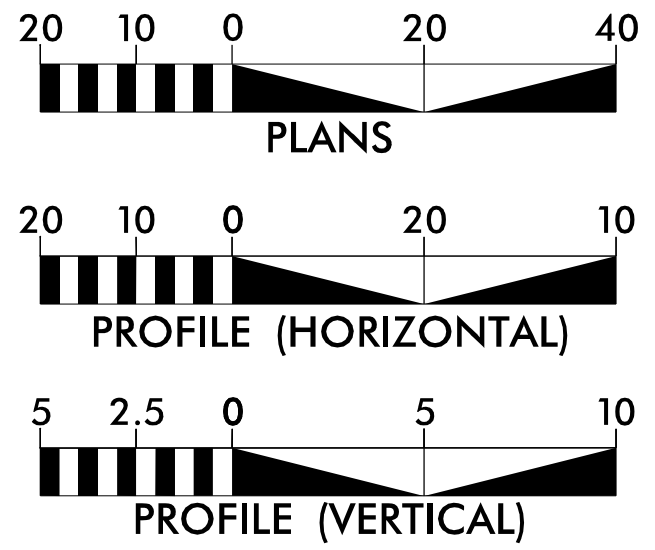


8/17/09



# STREAM CHANNEL CHANGE ALIGNMENT DETAIL

Prepared by  
**URS**  
 URS Corporation - North Carolina  
 1600 Perimeter Park Drive  
 Morrisville, North Carolina 27560  
 TELEPHONE 1 919 461-1100 FAX 1 919 461-1415  
 NC LIC# 02666 • C-2243

PROJECT REFERENCE NO. R-3100B	SHEET NO. 2D-1
RW SHEET NO.	
HYDRAULICS ENGINEER	
DOCUMENT NOT CONSIDERED FINAL UNLESS ALL SIGNATURES COMPLETED	

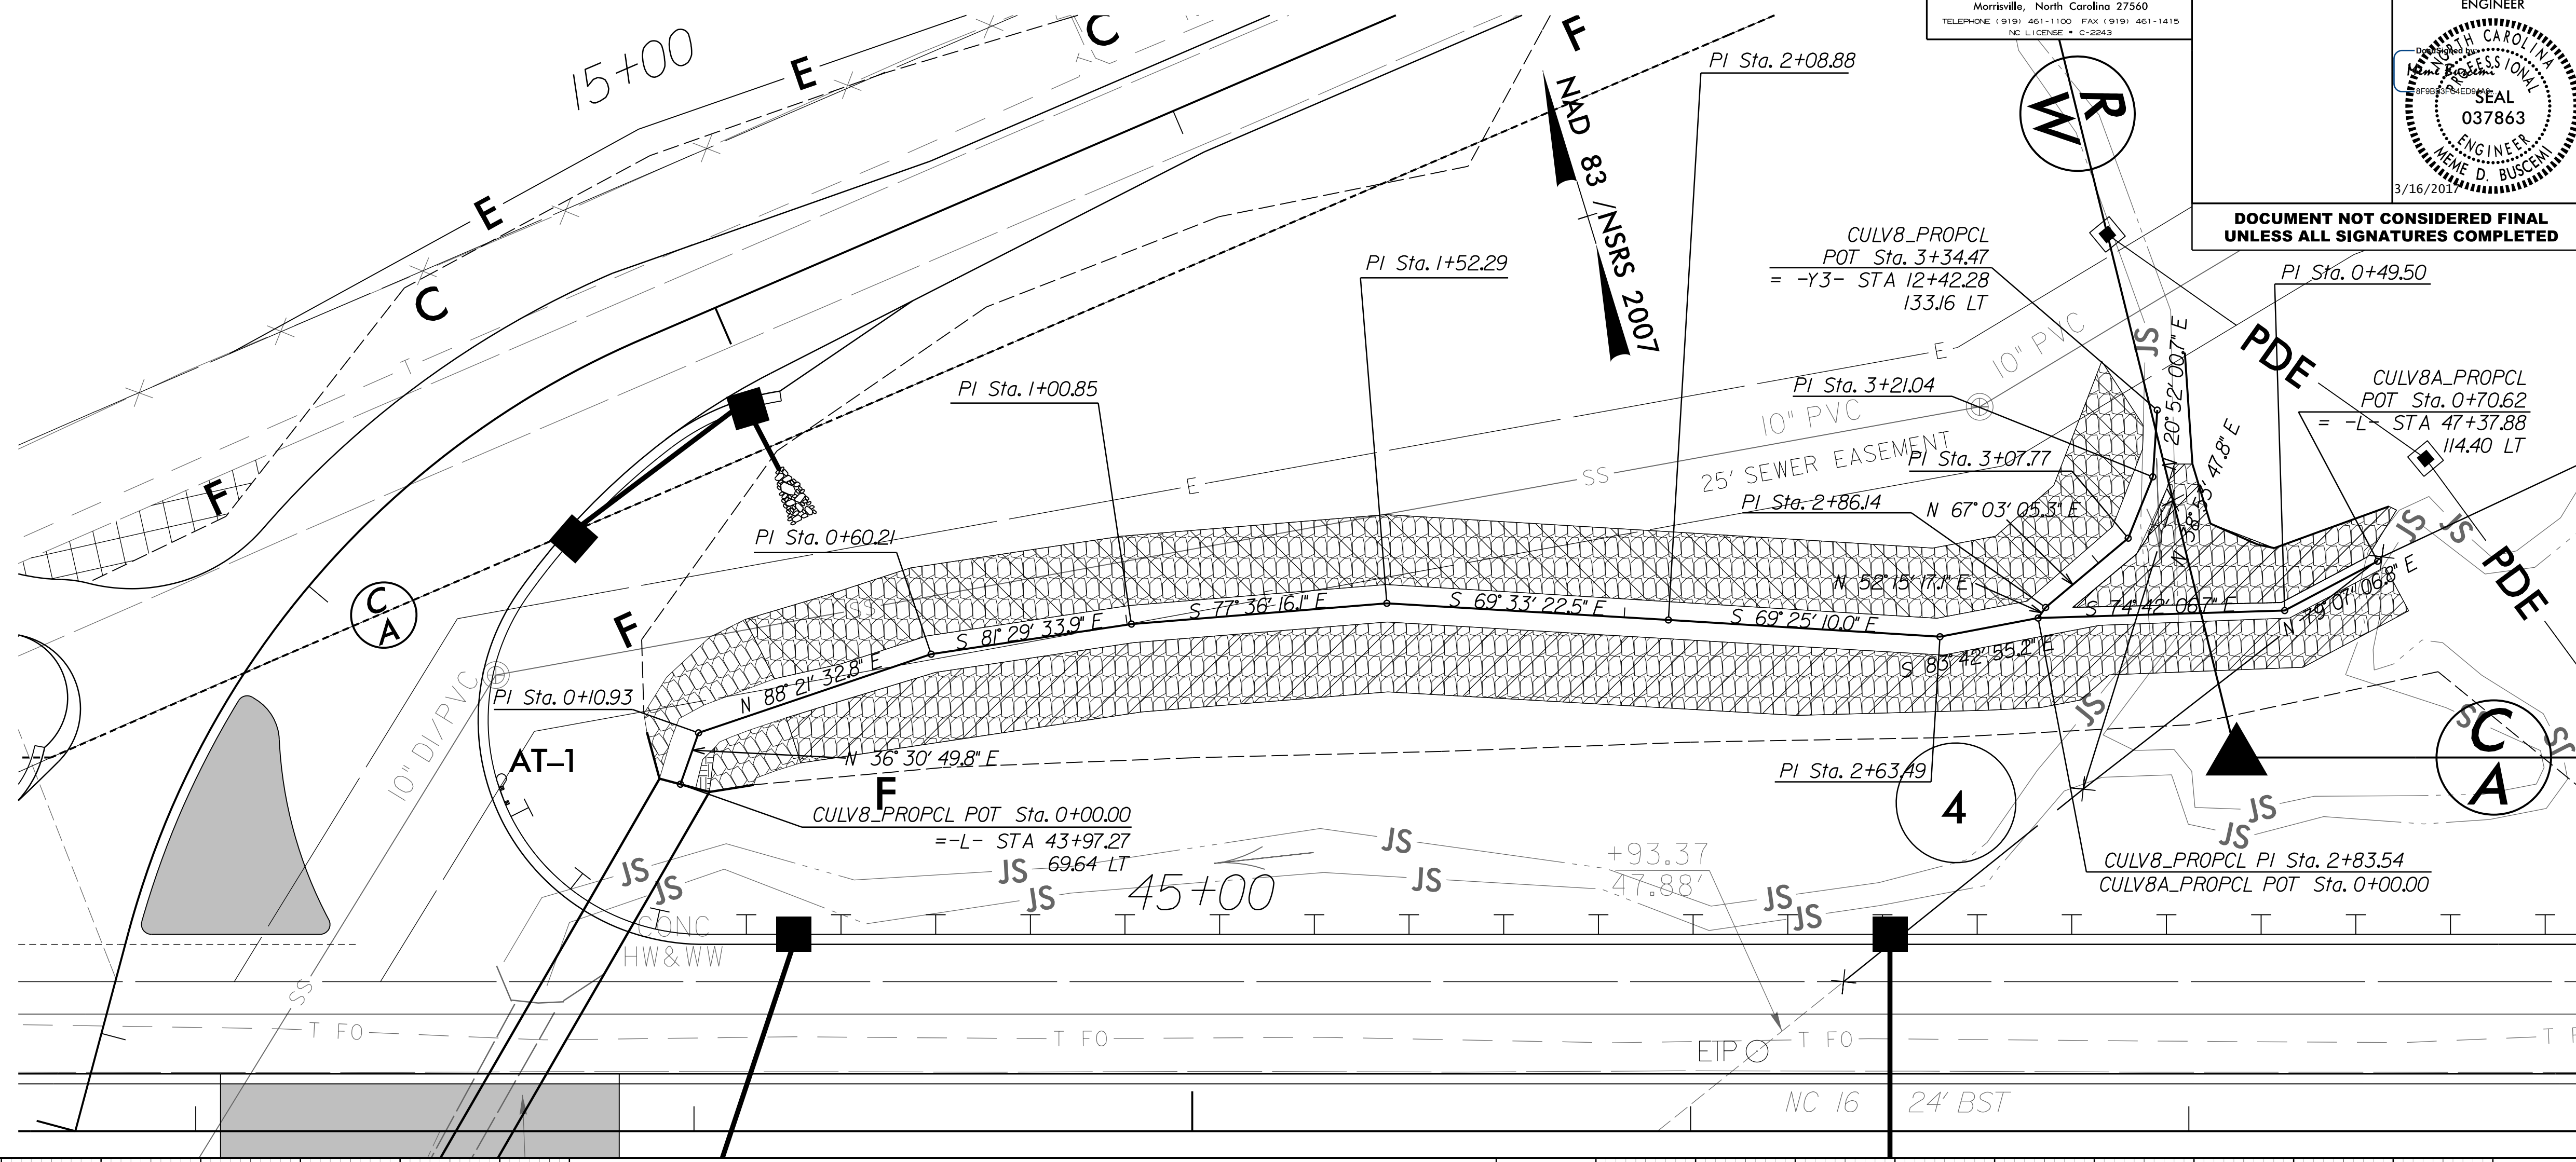

FOR ROADWAY AND DRAINAGE PLANS SEE SHEET 6  
 FOR ROADWAY AND DRAINAGE PROFILES SEE SHEETS 19 & 25

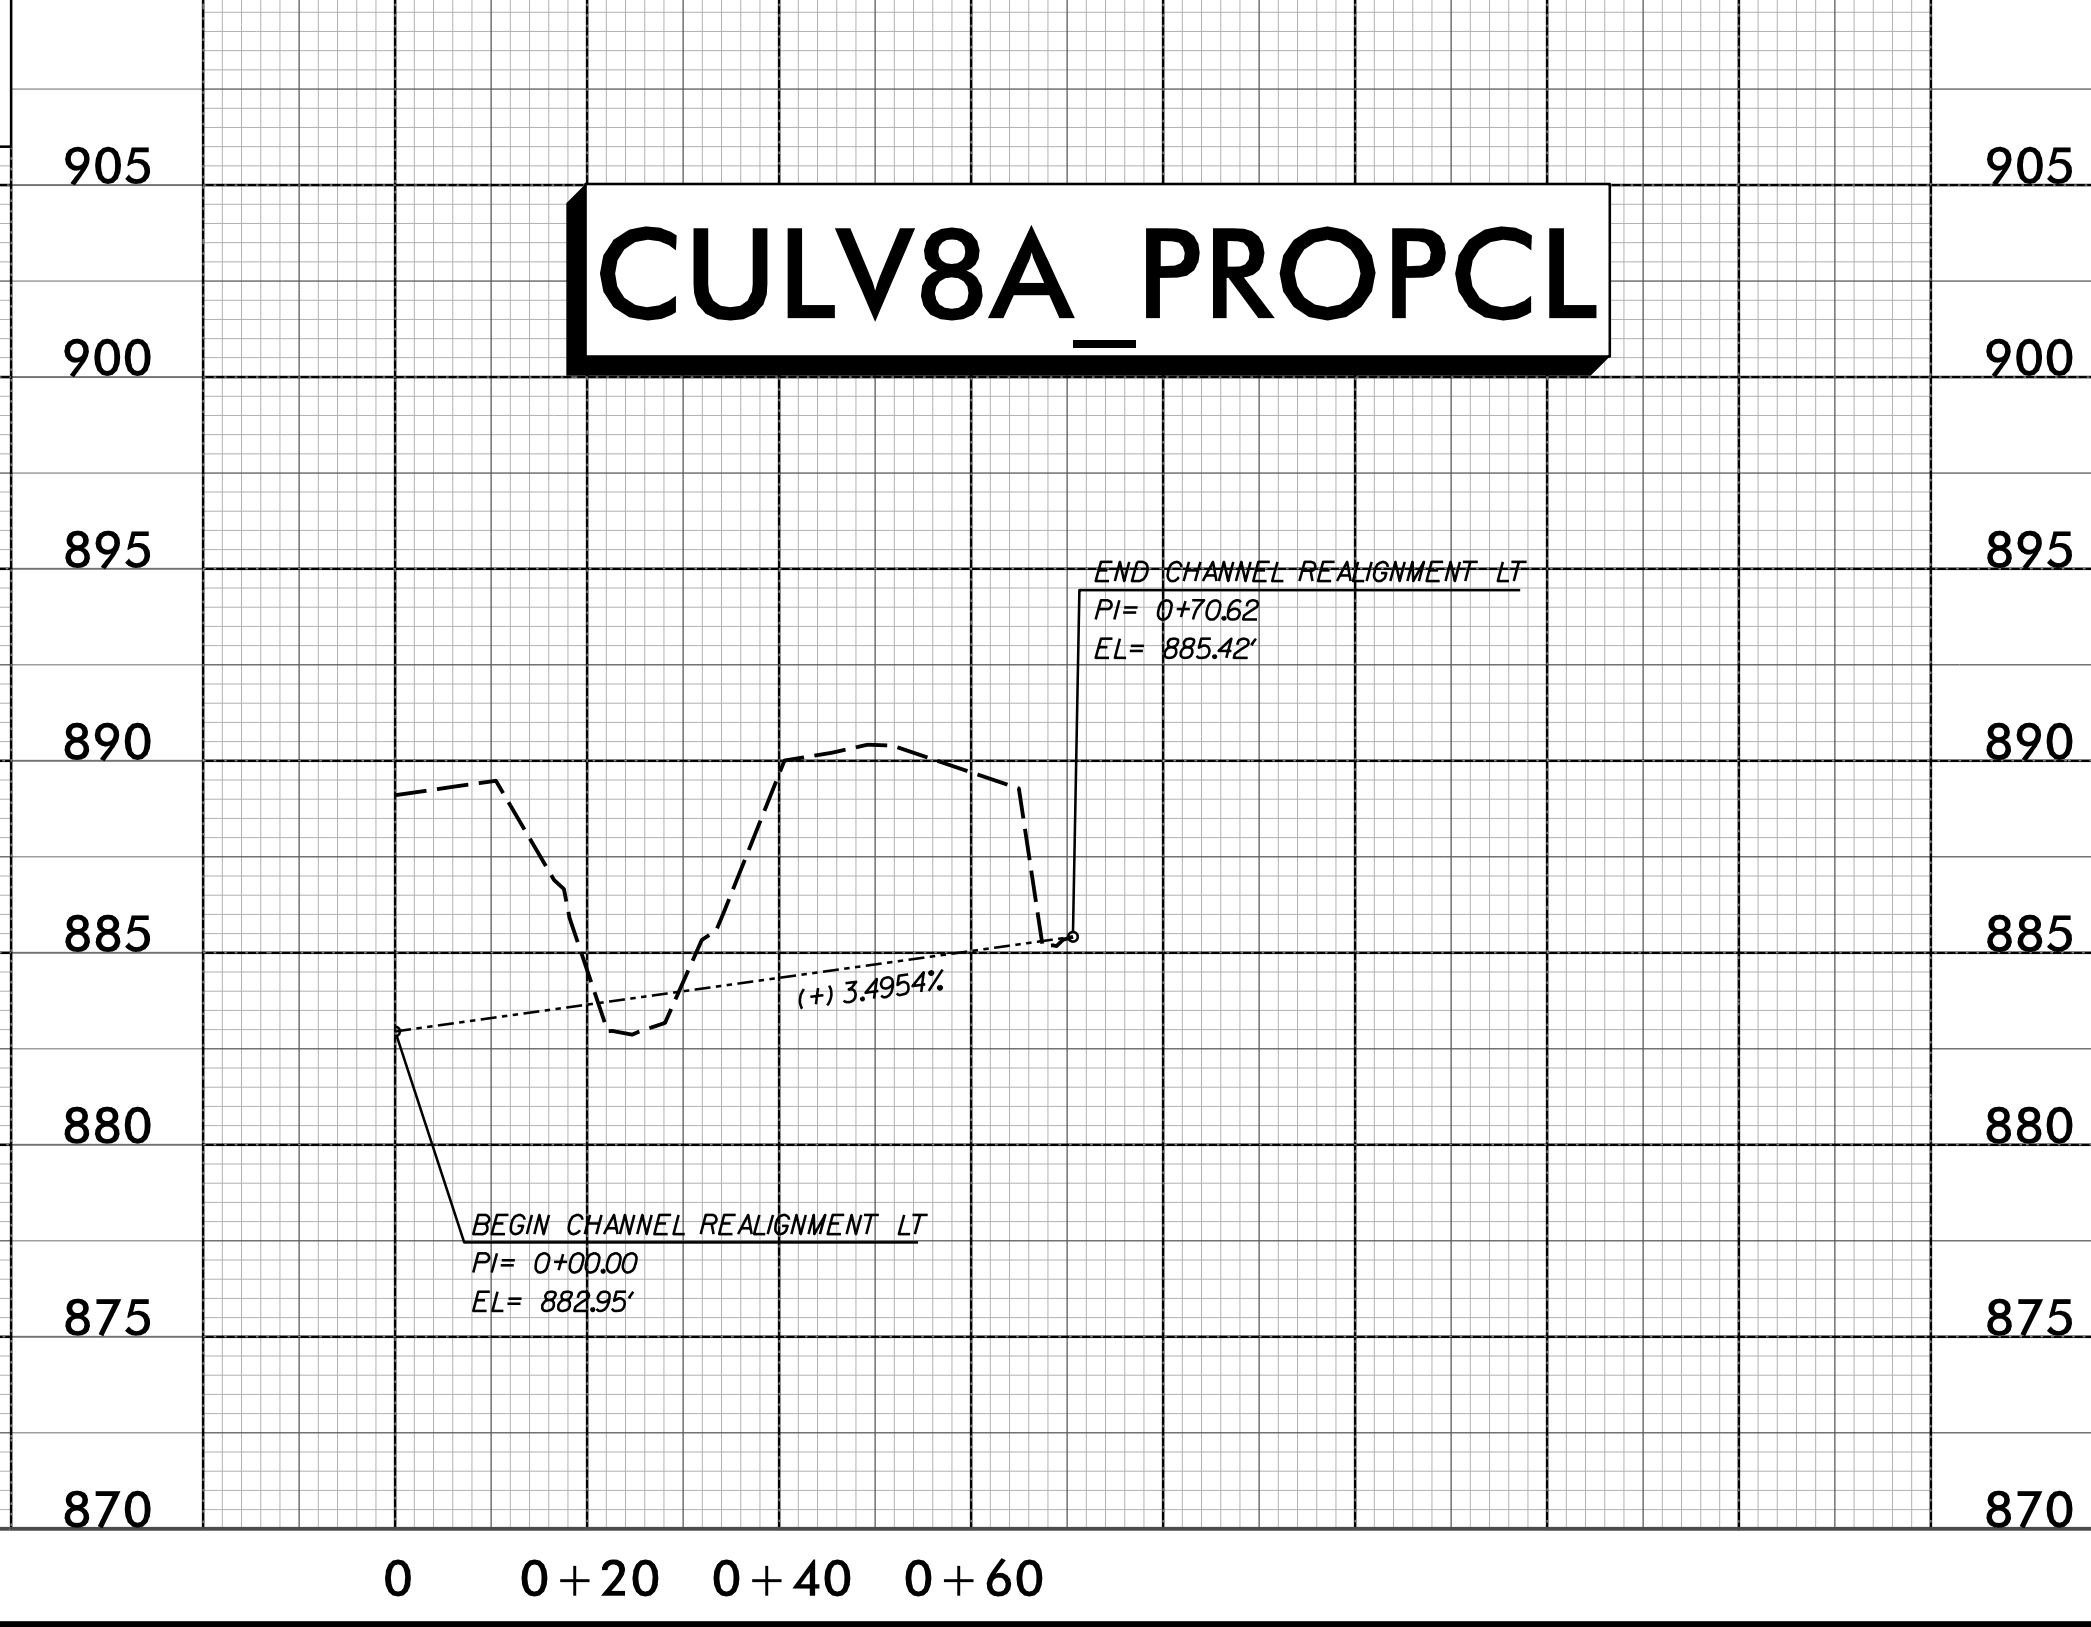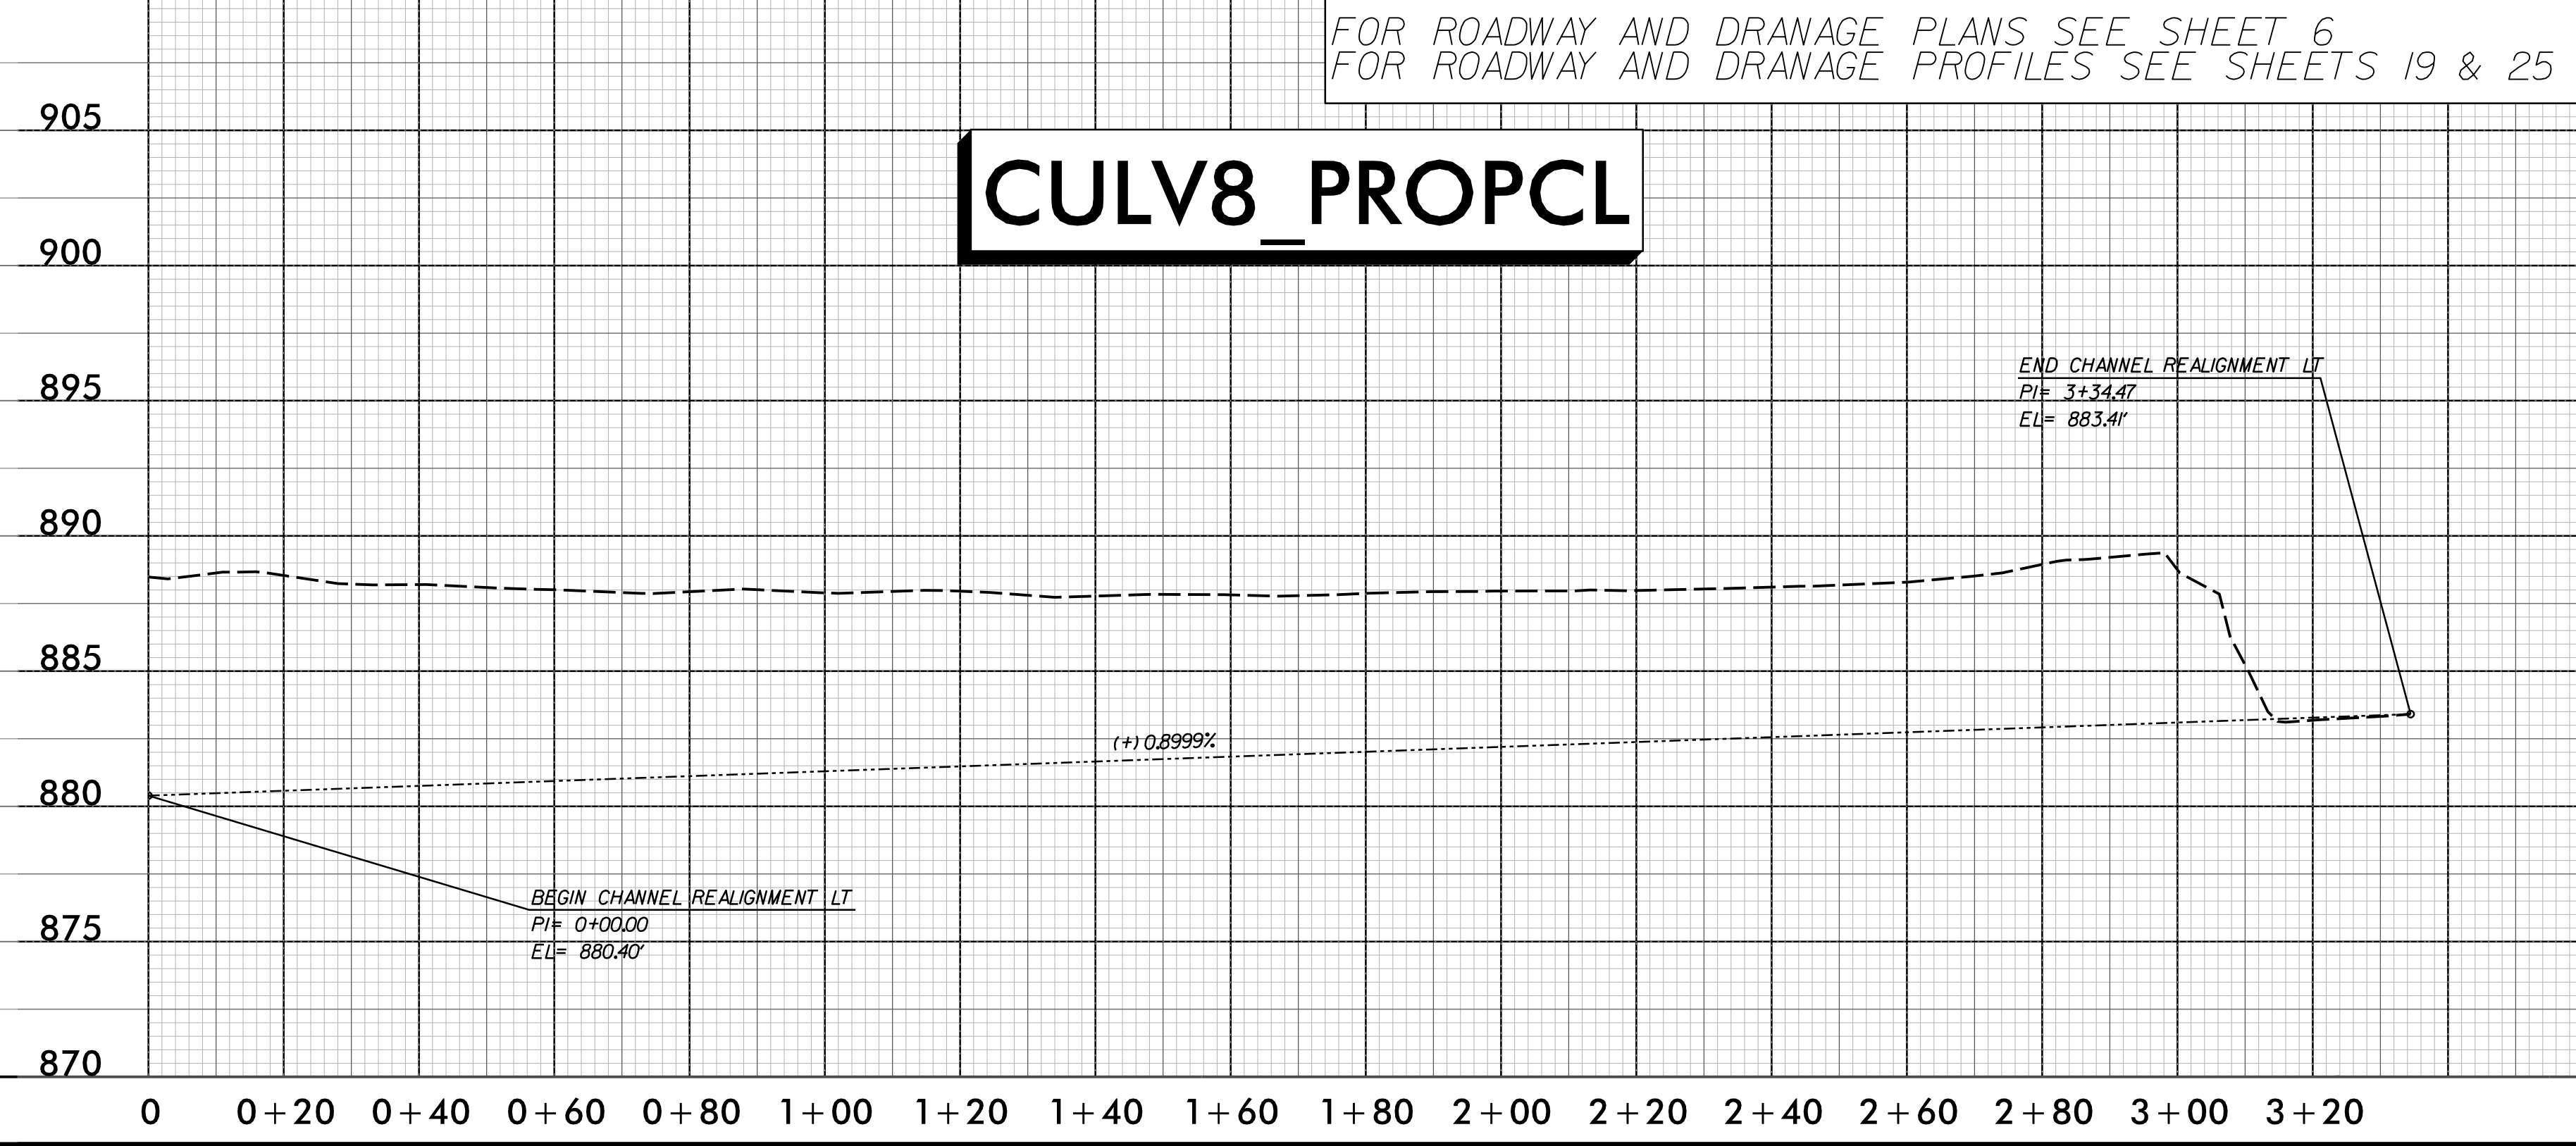

R:\16\2017\09\08\09\Proj\31000b\_rdy\_PSH2D-1.dgn  
 8/16/2017 10:08:00 AM  
 js

REVISIONS