

09/08/99

TIP PROJECT: R-2707C



STATE OF NORTH CAROLINA
DIVISION OF HIGHWAYS

T.I.P. NO.	SHEET NO.
R-2707C	UC-1


UTILITY CONSTRUCTION PLANS
CLEVELAND COUNTY

LOCATION: US 74 SHELBY BYPASS FROM EAST OF NC 226
TO EAST OF NC 150

TYPE OF WORK: WATER LINE AND SEWER FORCE MAIN

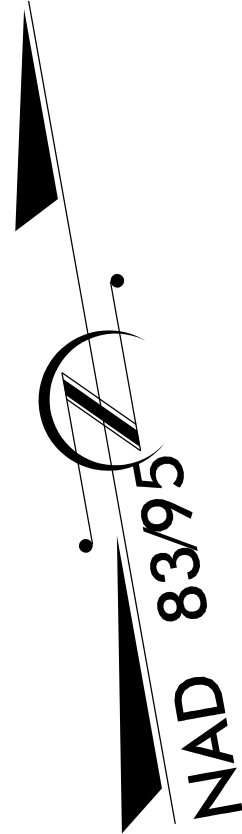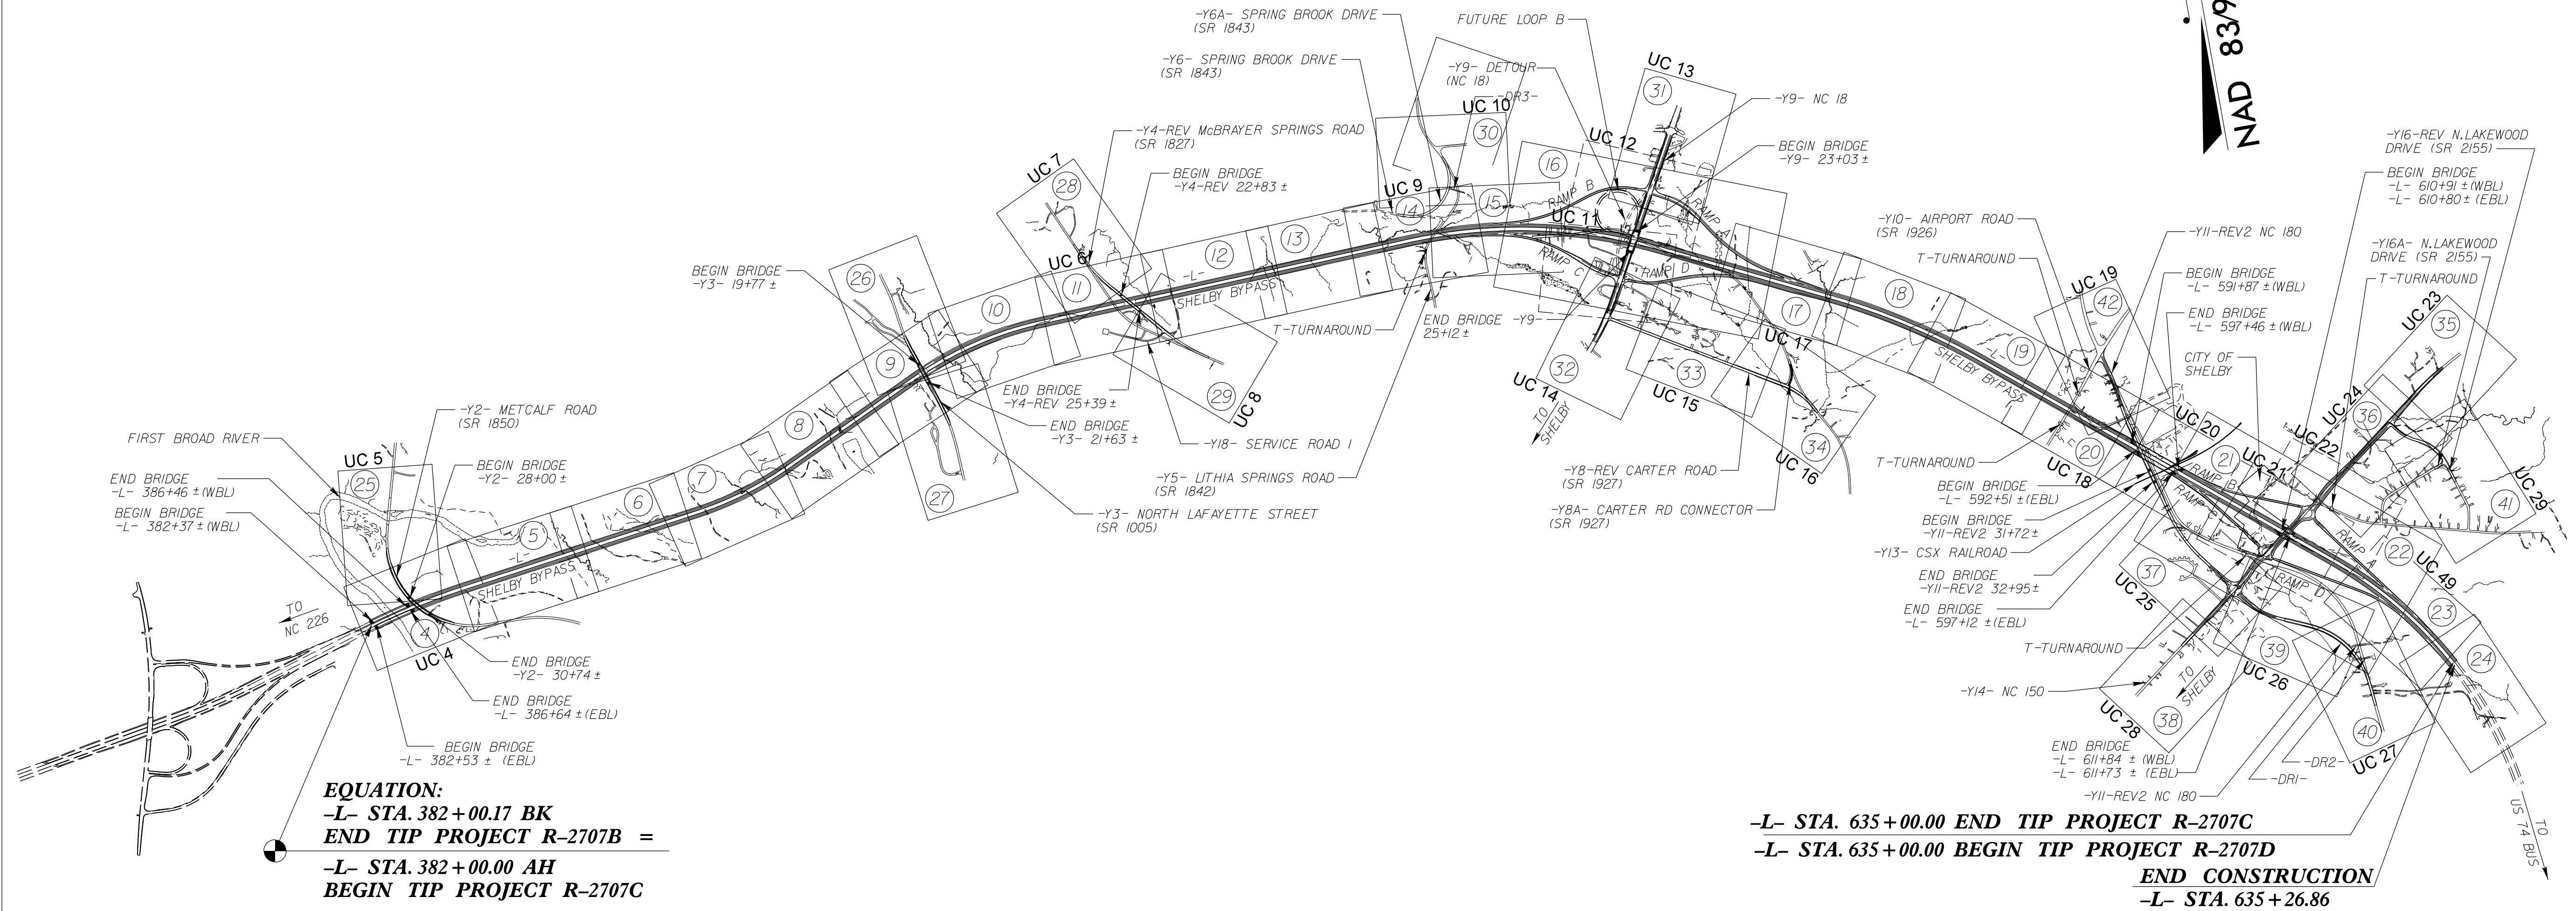

DOCUMENT NOT CONSIDERED FINAL
UNTIL ALL SIGNATURES ARE COMPLETED

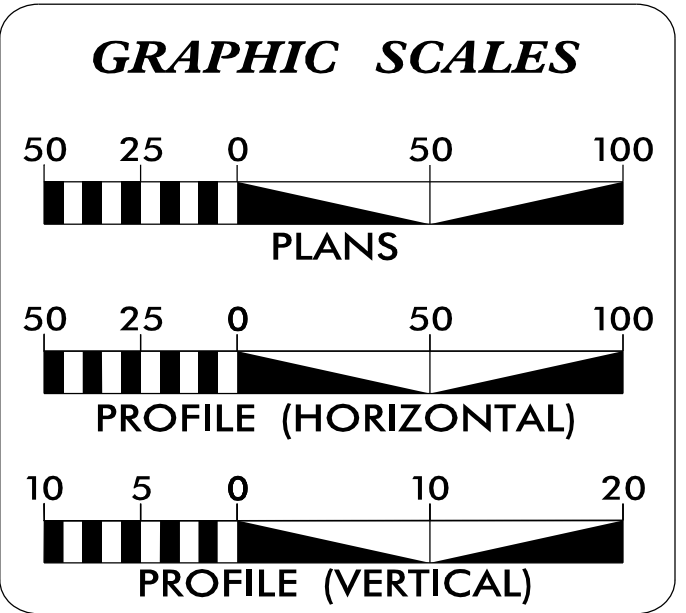

INDEX OF SHEETS

SHEET NO.:	DESCRIPTION:
UC-1	TITLE SHEET
UC-2	UTILITY SYMBOLOGY
UC-3	NOTES
UC-3A THRU UC-3D	DETAILS
UC-4 THRU UC-29	UTILITY PLAN SHEETS
UC-30 THRU UC-41	UTILITY PROFILES

WATER, SEWER AND GAS OWNERS ON PROJECT

(A) WATER - CLEVELAND COUNTY WATER
 (B) WATER - CITY OF SHELBY
 (C) SANITARY SEWER FORCE MAIN - CITY OF SHELBY
 (D) GAS - CITY OF SHELBY

WATER AND SEWER FORCE MAIN RELOCATIONS
PREPARED IN THE OFFICE OF:

McGill ASSOCIATES
ENGINEERING · PLANNING · FINANCE
55 BROAD STREET ASHEVILLE, NC 28801 PH. (828) 252-0575 FIRM LICENSE # C-0459

MICHAEL J. WARESAK, PE CONSULTANT CONTACT #1
VANN WATERS, ENG. TECH. CONSULTANT CONTACT #2

SEAL

DIVISION OF HIGHWAYS UTILITIES UNIT
 1555 MAIL SERVICES CENTER
 RALEIGH NC 27699-1555
 PHONE (919) 707-6690
 FAX (919) 250-4151

CARL BARCLAY UTILITIES REGIONAL ENGINEER
JAMES SWINSON UTILITIES ENGINEER
AMY DUPREE UTILITIES AREA COORDINATOR
STEVE TREXLER UTILITIES COORDINATOR