



R 2707C-5

2/3/2017
\\405-017-R2707C-SMU-FP01-S5-9.dgn
USERdefault

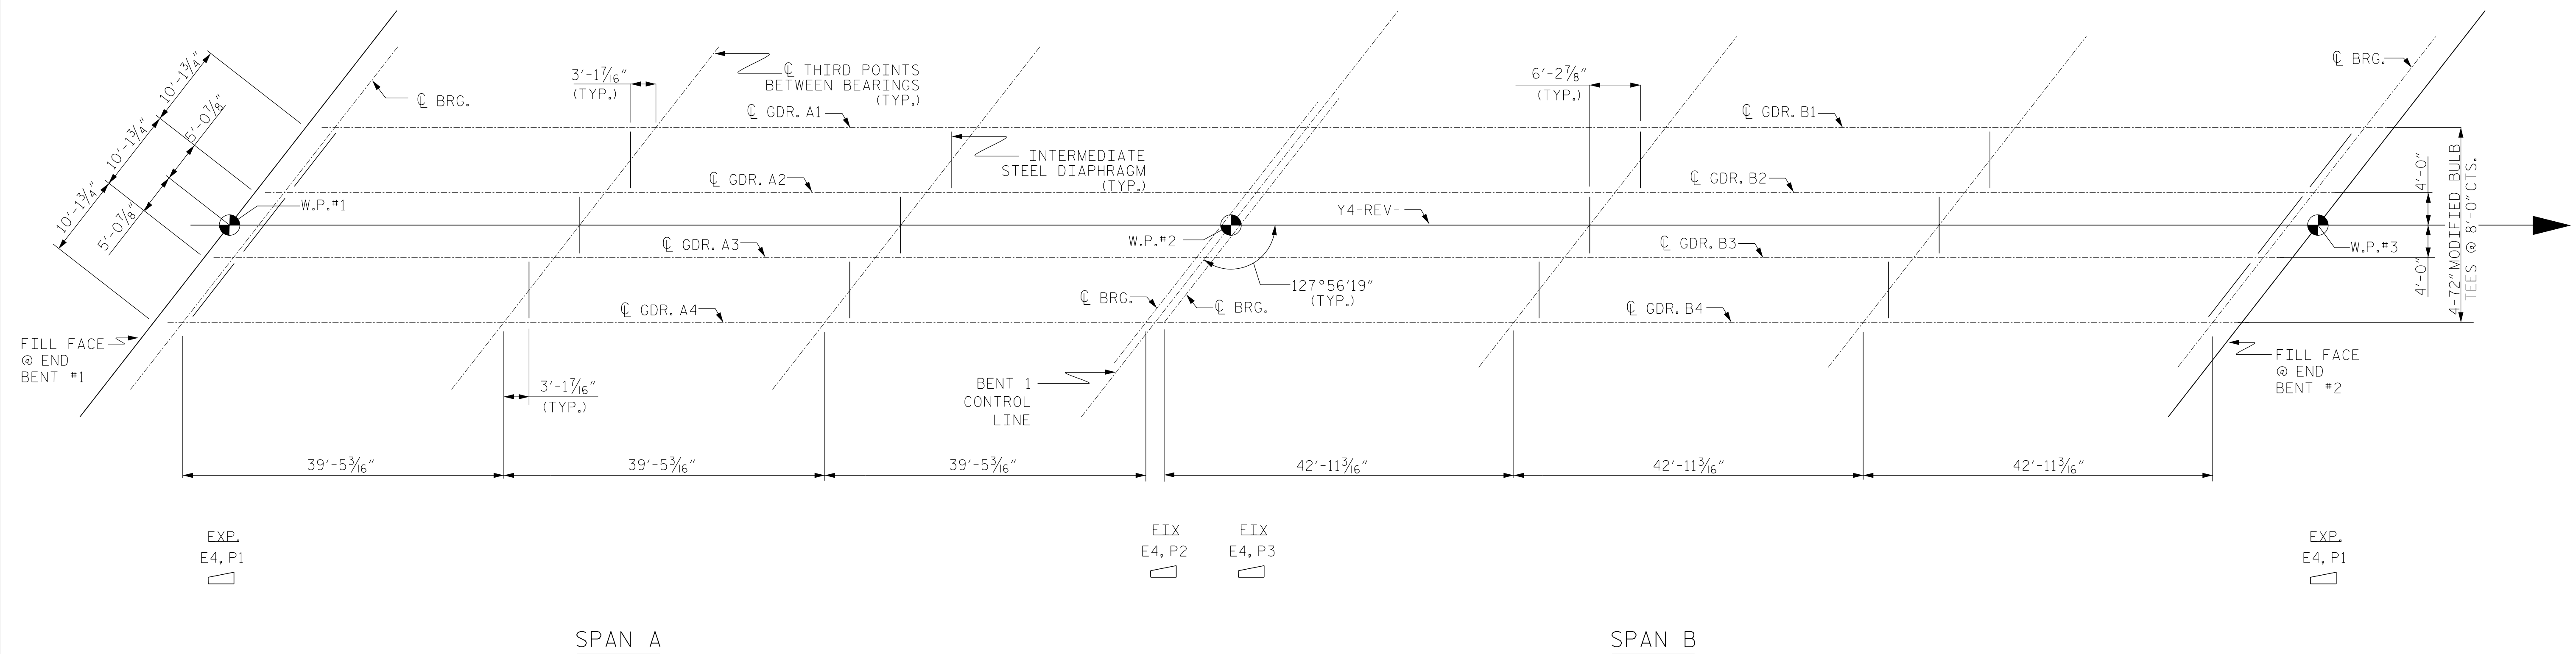

FRAMING PLAN

PROJECT NO. R-2707C
CLEVELAND COUNTY
STATION: 24+05.50-Y4-REV POT

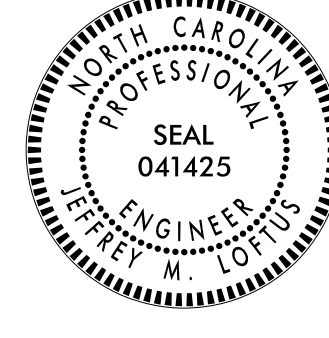

DocuSigned by:
Jeff Loftus 2/3/2017

STEWART

Firm License No. C-1051
421 Fayetteville St,
Suite 400
Raleigh, NC 27601
T 919.380.8750
www.stewartinc.com

STATE OF NORTH CAROLINA DEPARTMENT OF TRANSPORTATION RALEIGH					
SUPERSTRUCTURE FRAMING PLAN					
REVISIONS					
NO.	BY:	DATE:	NO.	BY:	DATE:
1			3		
2			4		
SHEET NO. S5-9					TOTAL SHEETS 29

DRAWN BY: H.ASSFOURA DATE: 02/16
 CHECKED BY: J. LOFTUS DATE: 11/16
 DESIGN ENGINEER OF RECORD: J. LOFTUS DATE: 01/17

STR. #5