
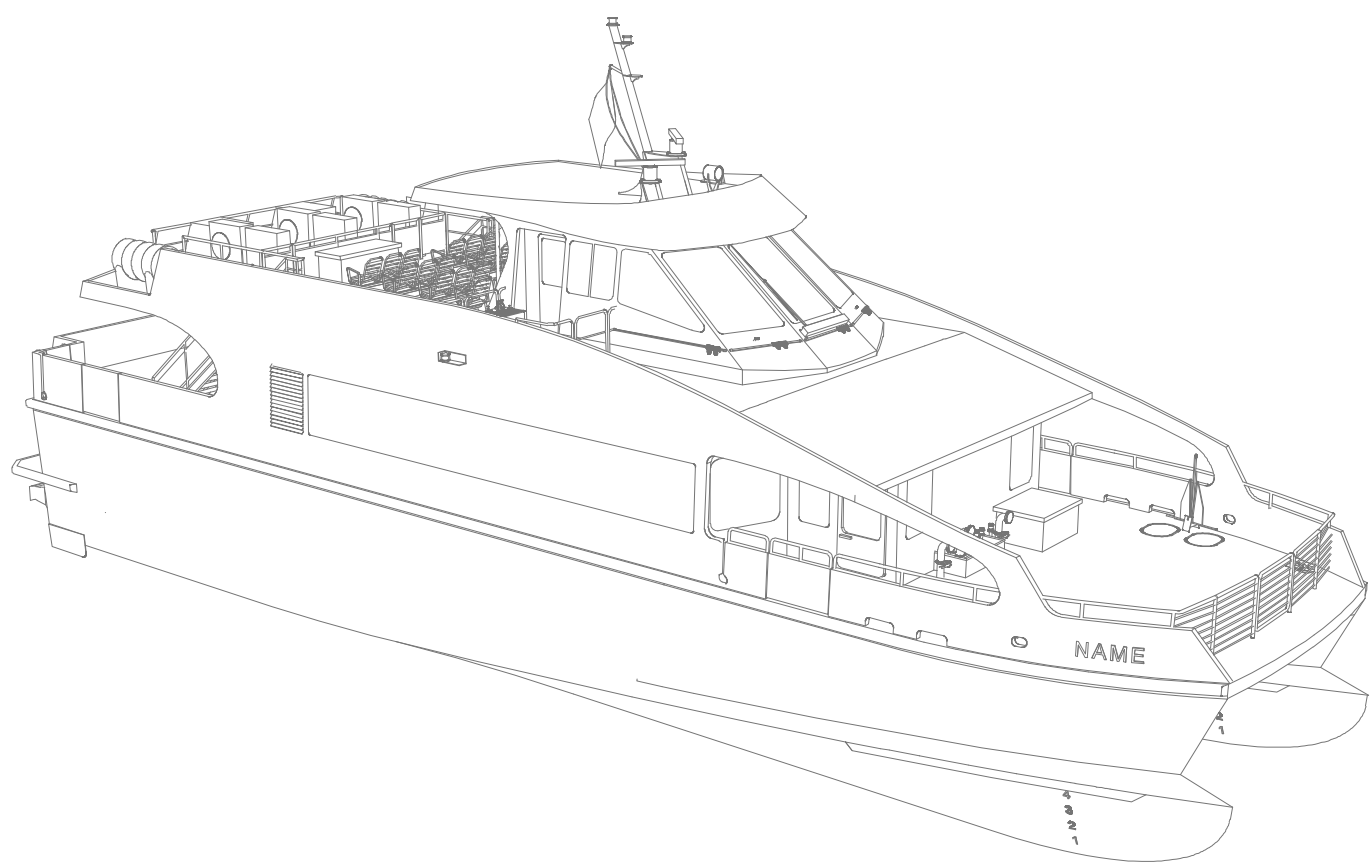


CONFIDENTIAL AND PROPRIETARY PROPERTY OF
Elliott Bay Design Group North Carolina, PLLC
 MAY NOT BE USED FOR CONSTRUCTION OR PROVIDED TO
 ANY THIRD PARTIES WITHOUT PRIOR WRITTEN CONSENT.
 © 2017 ELLIOTT BAY DESIGN GROUP.

VESSEL DRAWINGS

| DRAWING NO. | DRAWING TITLE |
|-----------------|---|
| 16109-003-100-1 | LINES PLAN |
| 16109-003-065-0 | HVAC BLOCK DIAGRAM |
| 16109-003-101-1 | PROFILES AND ARRANGEMENTS |
| 16109-003-110-0 | MIDSHIP SECTION |
| 16109-003-120-0 | HULL STRUCTURE |
| 16109-003-130-0 | SUPERSTRUCTURE |
| 16109-003-170-1 | PROPULSION EQUIPMENT ARRANGEMENT |
| 16109-003-201-1 | MACHINERY ARRANGEMENTS |
| 16109-003-259-1 | EXHAUST SYSTEM |
| 16109-003-261-0 | FUEL, WATER AND SEWAGE TANK CONFIGURATION |
| 16109-003-261-1 | FUEL OIL DIAGRAM |
| 16109-003-320-0 | ELECTRICAL ONE LINE DIAGRAM |
| 16109-003-401-0 | PILOTHOUSE ARRANGEMENT |
| 16109-003-520-0 | SEA CHESTS AND SEAWATER PIPING |
| 16109-003-521-0 | FIRE MAIN SYSTEM |
| 16109-003-528-0 | SANITARY DRAINS AND SEWAGE DISCHARGE SYSTEM |
| 16109-003-529-1 | BILGE SYSTEM |
| 16109-003-529-2 | DECK DRAINS |
| 16109-003-533-0 | POTABLE WATER SYSTEM |
| 16109-003-601-0 | PASSENGER SPACE ARRANGEMENT |
| 16109-003-601-2 | FOOD SERVICES ARRANGEMENT |
| 16109-003-631-0 | PAINT AND VINYL LAYOUT |
| 16109-003-635-0 | INSULATION AND LININGS PLAN |
| 16109-003-635-1 | CEILING AND LIGHTING PLAN |

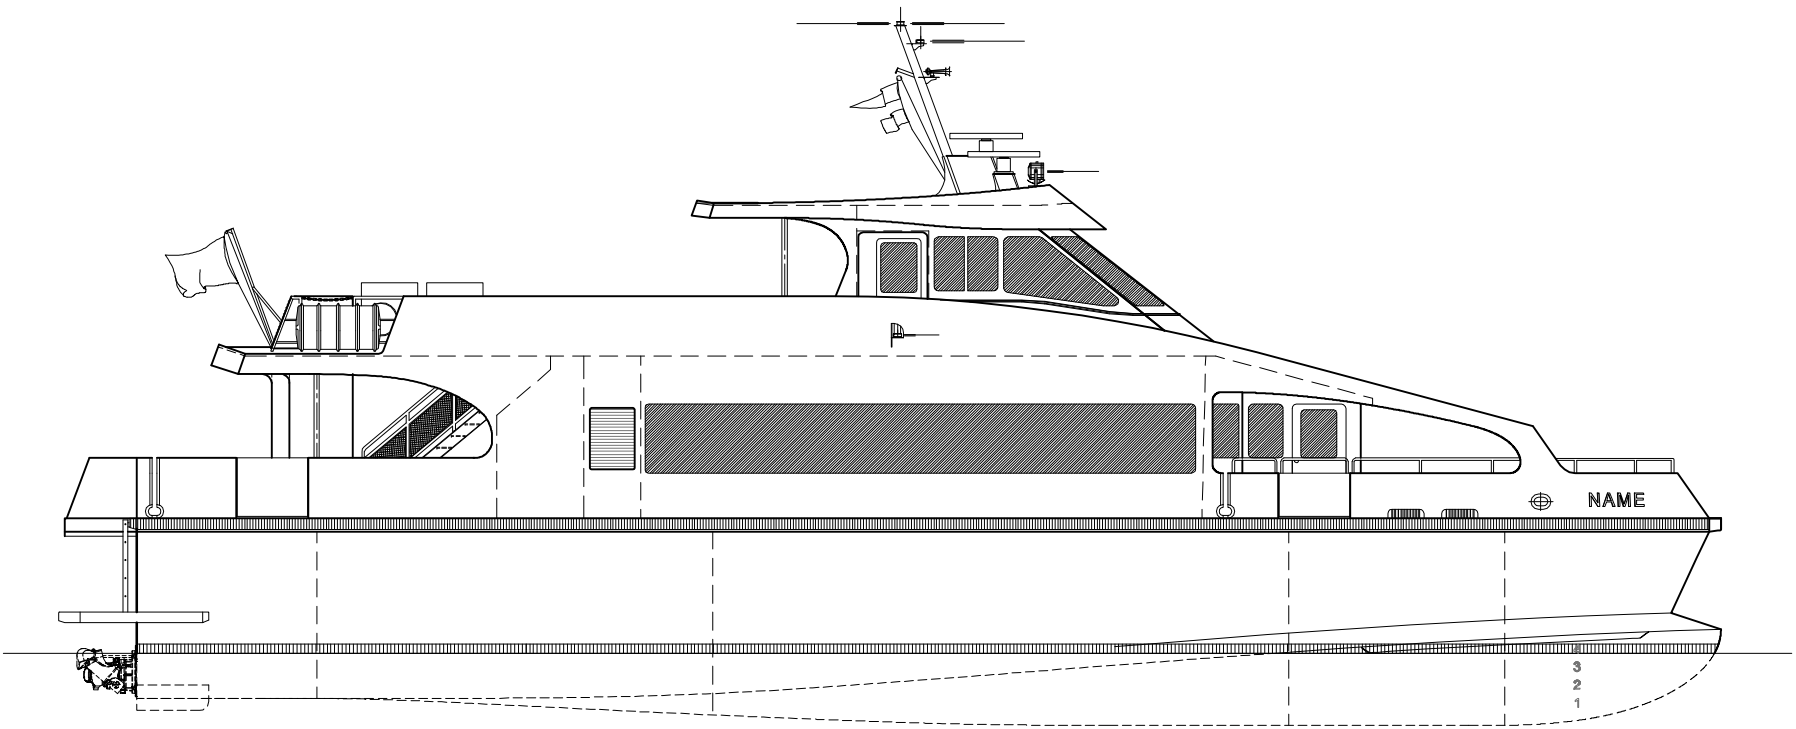

| | | |
|--|--|--|
| | Elliott Bay Design Group North Carolina, PLLC | |
| | CLIENT | NORTH CAROLINA D.O.T. RALEIGH, NORTH CAROLINA |
| | PROJECT | PEDESTRIAN FERRY |

| | | | |
|---------------|------------------|-------|--------------------|
| DRAWING INDEX | | | |
| SIZE | DWG NO. | REV | |
| D | 16109-003-000-0 | - | |
| SCALE | FILE NAME | SHEET | OF |
| NONE | 16109-003-000-0- | 1 | 1 |
| DWN | MOD | CKD | APVD |
| MWR | | | APVD DATE 3/3/2017 |

3/3/2017 8:06:24 AM