




5121 Kingdom Way,
Suite 100
Raleigh, NC 27607
NC License No: F-0258

PROJECT REFERENCE NO.	SHEET NO.
R-5311A	EC-14/CONST.2B-6
ROADSIDE ENVIRONMENTAL PROJECT ENGINEER	


LEVEL III CERTIFIED BY:
STACEY H. BAILEY, PE
CERTIFICATION NUMBER: 3074
ISSUED: JANUARY 13, 2017

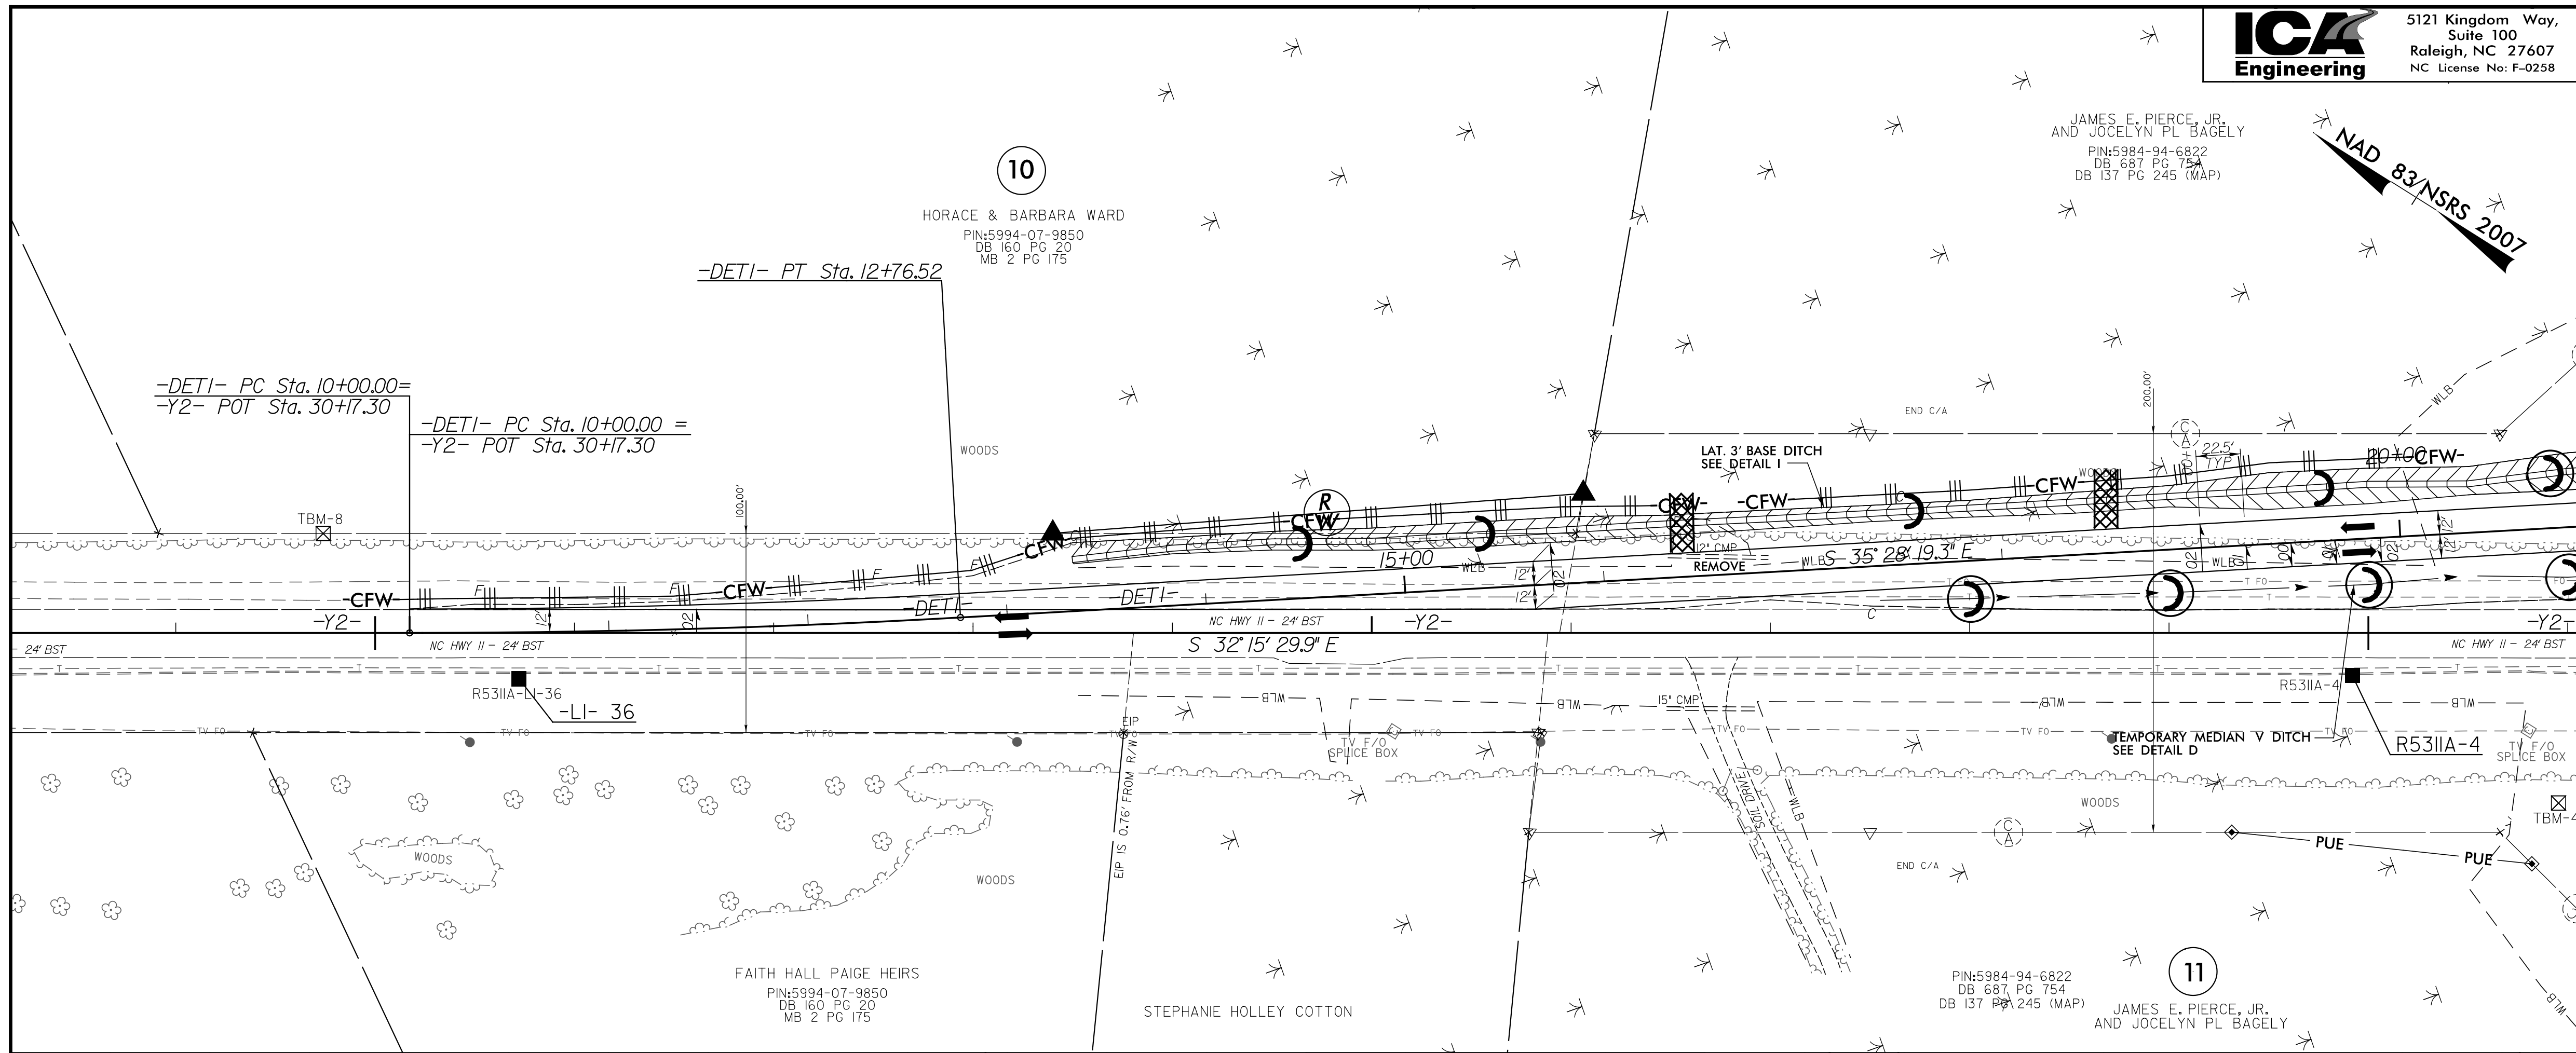

JAMES E. PIERCE, JR.
AND JOCELYN PL. BAGELY
PIN: 5984-94-6822
DB 687 PG 754
DB 137 PG 245 (MAP)

MATCHLINE
-DET1- STA 21+00
SEE SHEET 2B-7

FINAL EROSION CONTROL FOR
CONSTRUCTION SHEET 2B-6

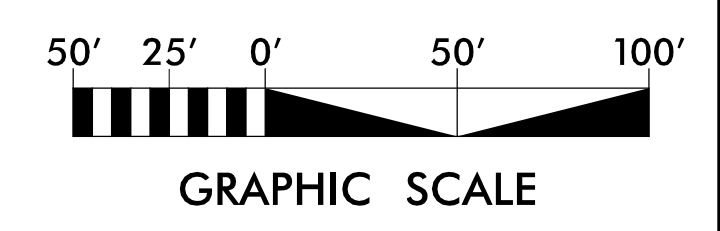

-DET1-

