


See Sheet 1-A For Index of Sheets

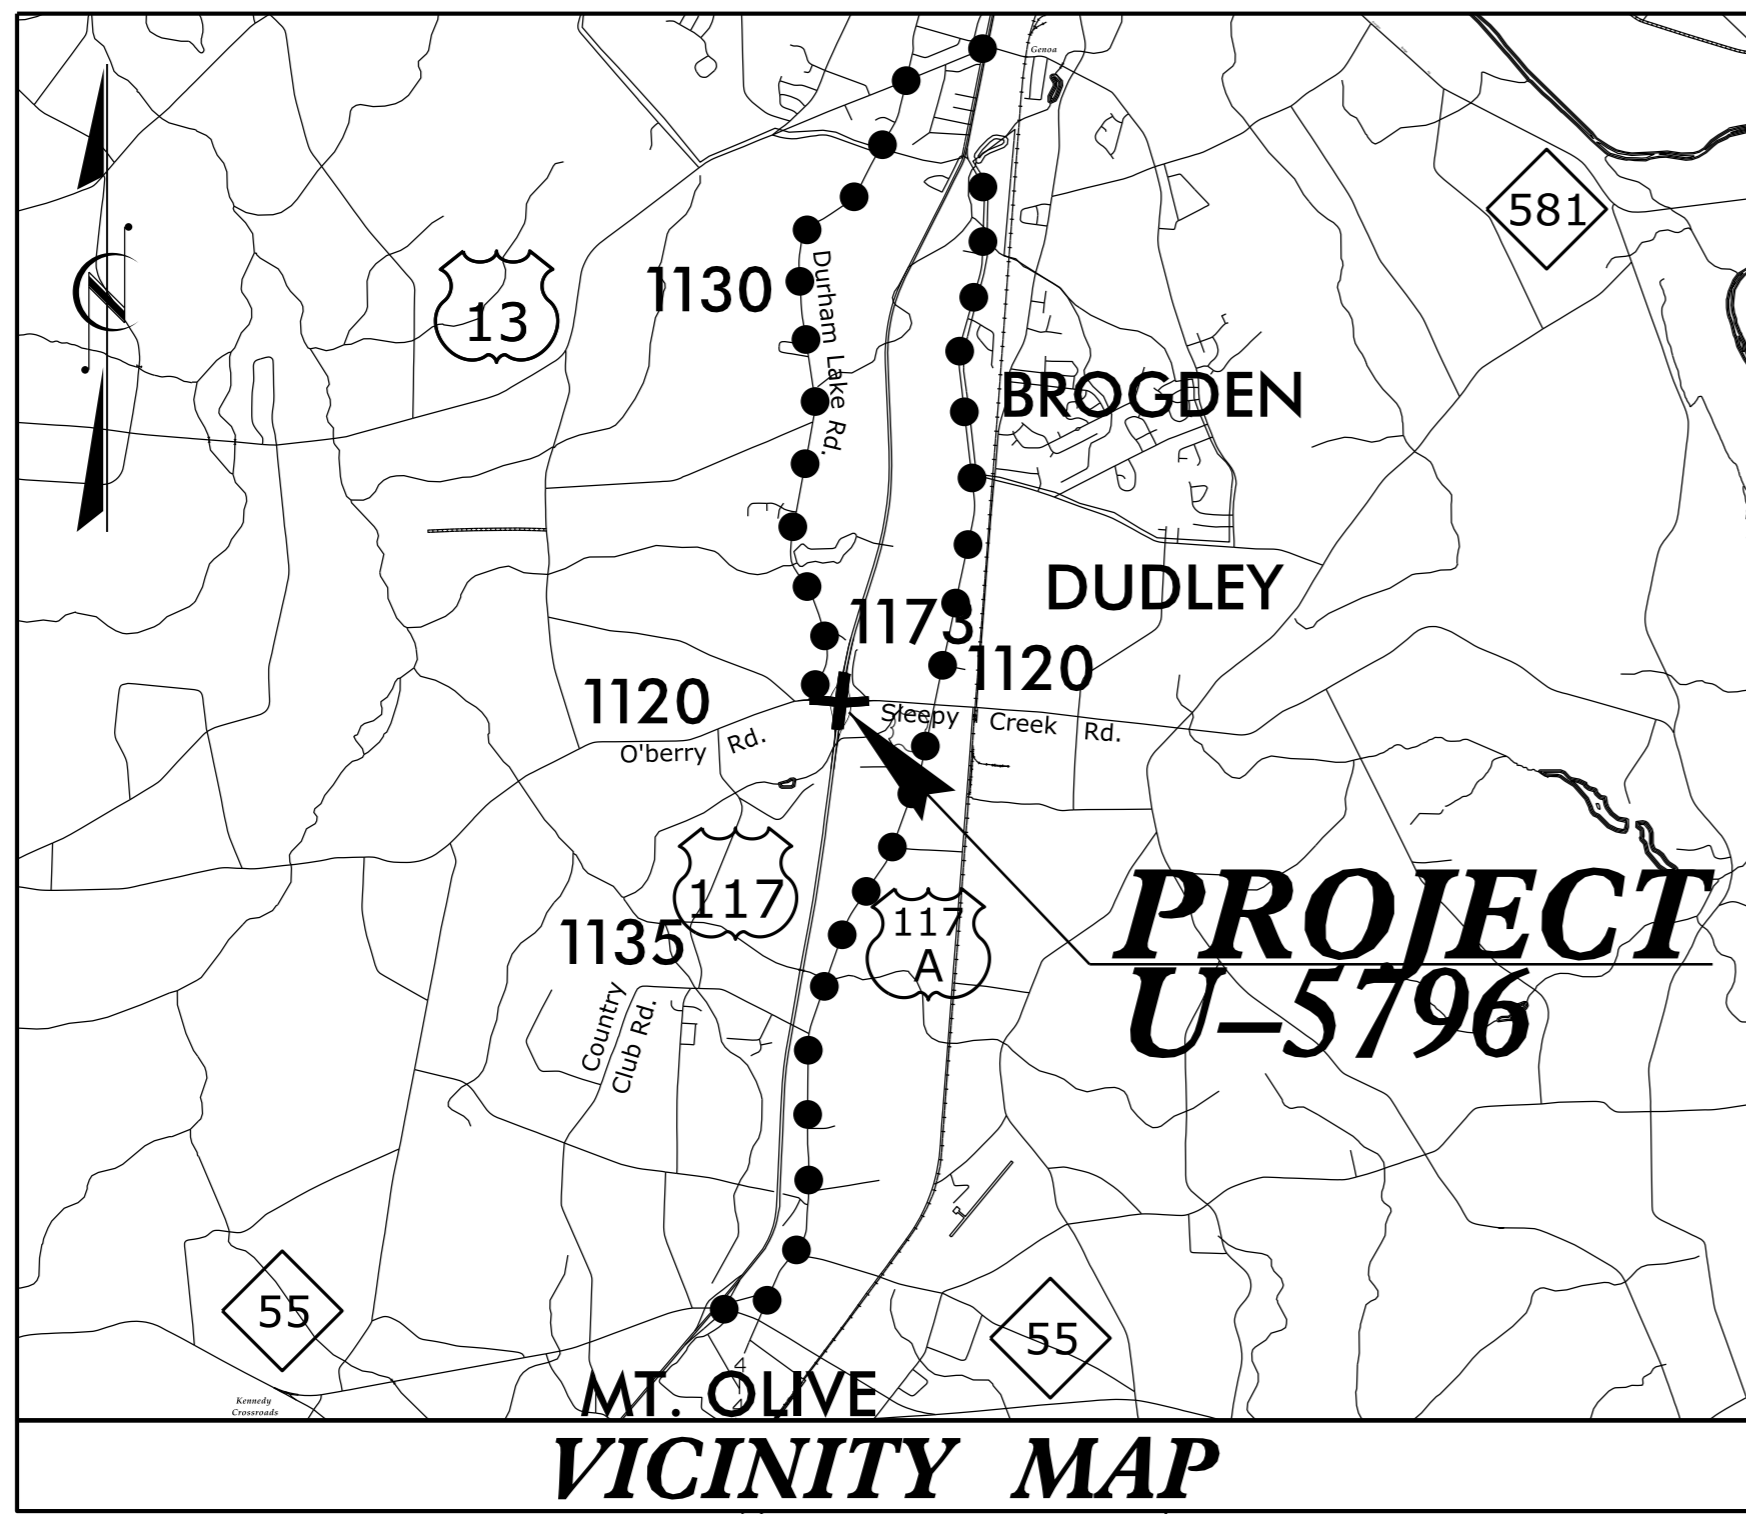

STATE OF NORTH CAROLINA
DIVISION OF HIGHWAYS


WAYNE COUNTY

LOCATION: CONSTRUCT INTERCHANGE AT US-117 AND SR-1120 (O'BERRY ROAD)

TYPE OF WORK: GRADING, DRAINAGE, PAVING, AND STRUCTURE.

STATE	STATE PROJECT REFERENCE NO.	SHEET NO.	TOTAL SHEETS
N.C.	U-5796	1	
STATE PROJ. NO.	F.A. PROJ. NO.	DESCRIPTION	
54039.1.FD1	NHP-0117(32)	PE	
54039.2.1		RW & UTIL.	
50473.3.1		CONST.	

TIP PROJECT: U-5796

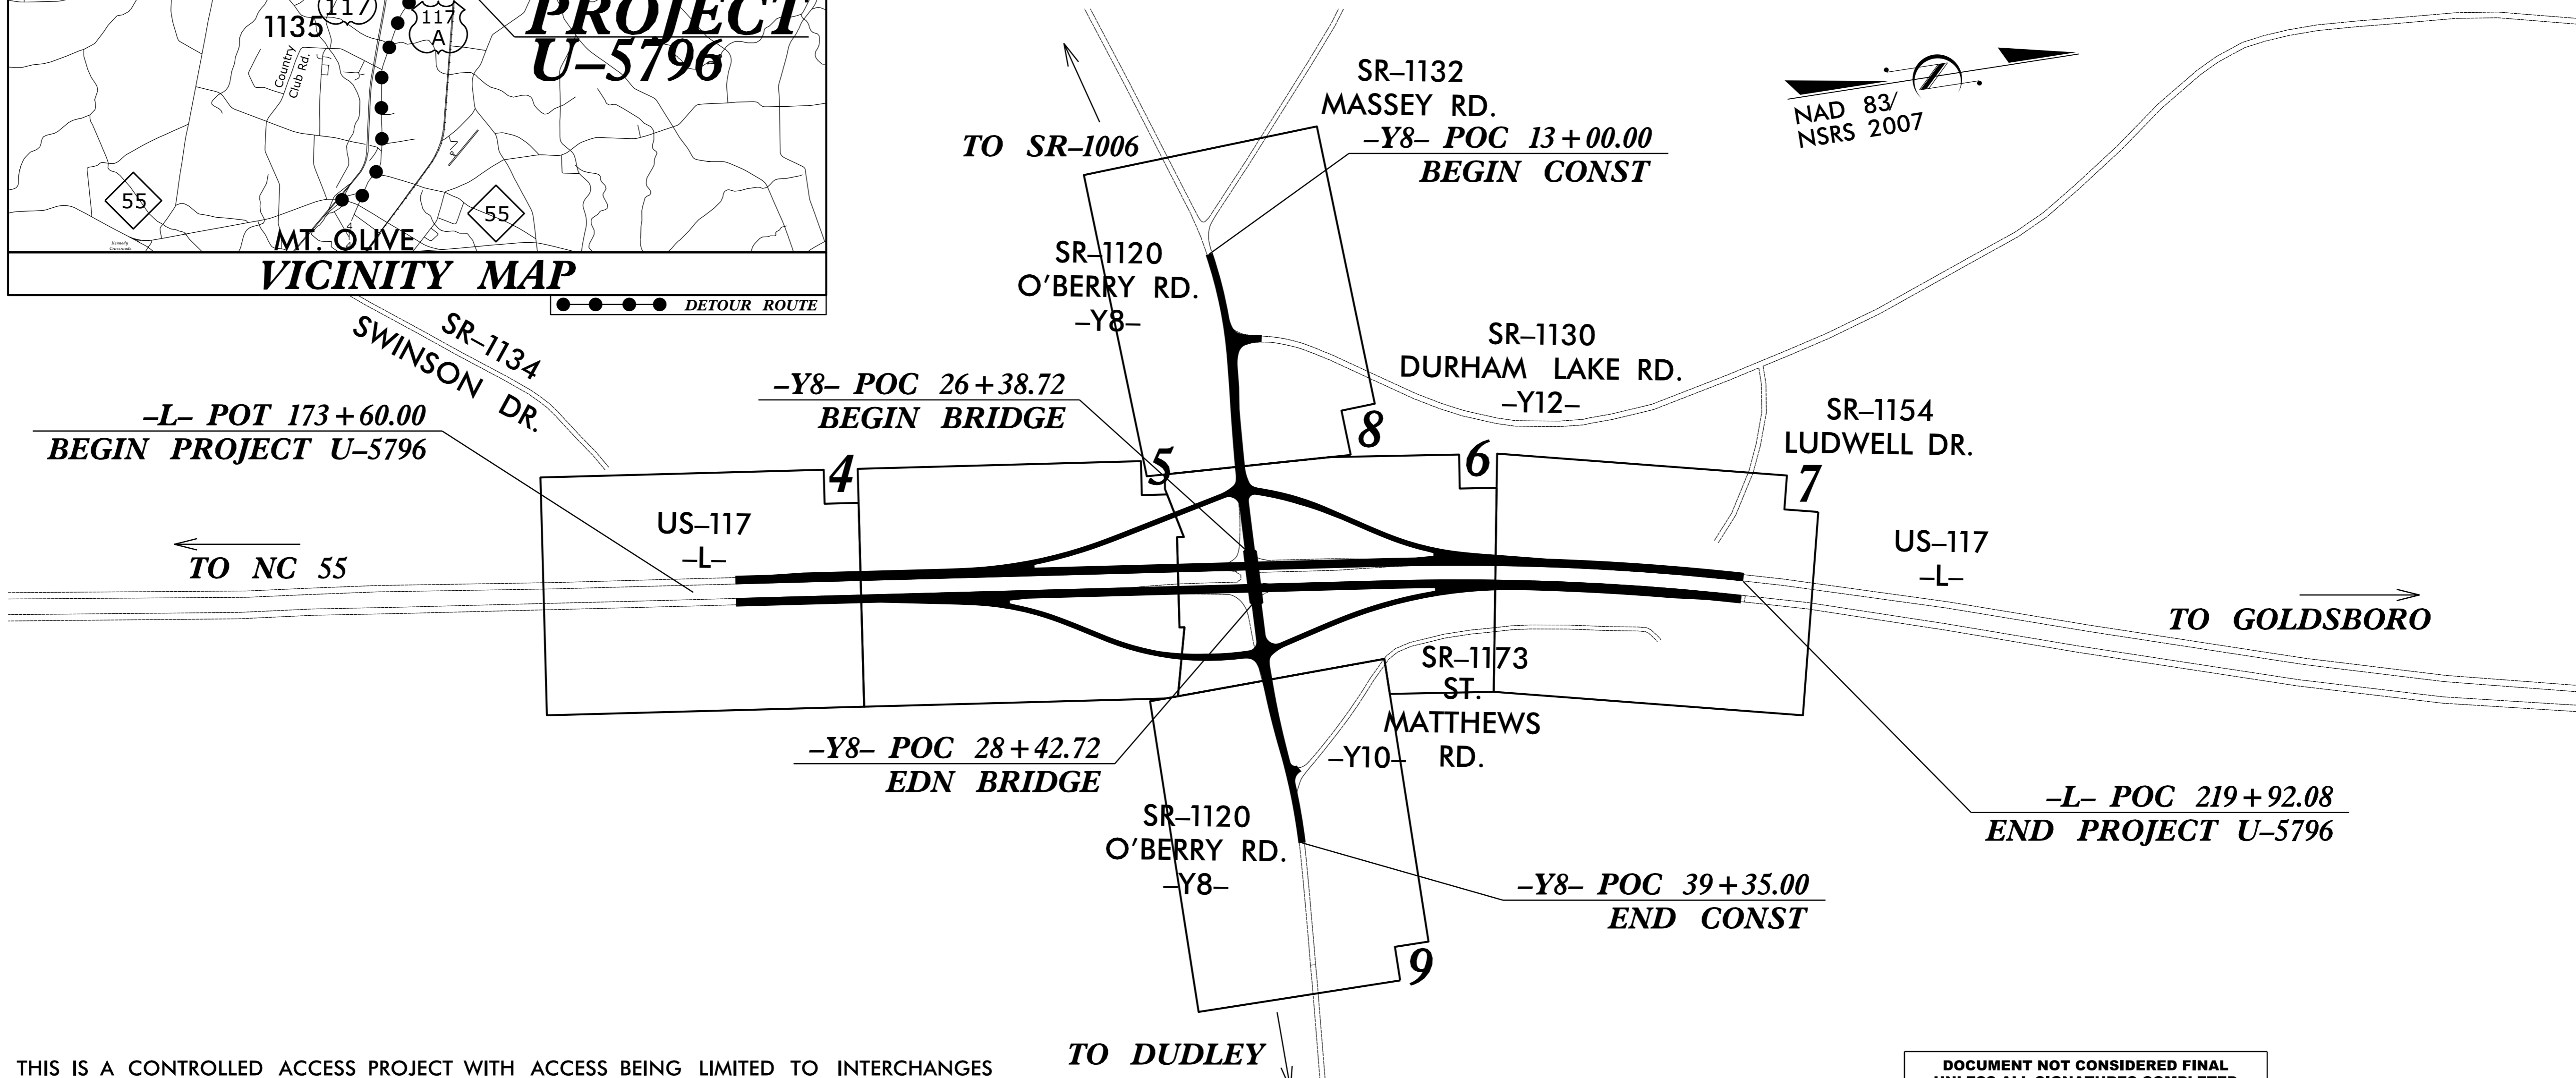

THIS IS A CONTROLLED ACCESS PROJECT WITH ACCESS BEING LIMITED TO INTERCHANGES

DOCUMENT NOT CONSIDERED FINAL UNLESS ALL SIGNATURES COMPLETED

<p>GRAPHIC SCALES</p> <p>50 25 0 50 100 PLANS</p> <p>50 25 0 50 100 PROFILE (HORIZONTAL)</p> <p>10 5 0 10 20 PROFILE (VERTICAL)</p>	<p>DESIGN DATA</p> <p>ADT 2017 = 15,200 ADT 2037 = 25,800 K = 8 % D = 55 % T = 13 % * V = 70 MPH * TTST 8% DUAL 5% PRINCIPAL ARTERIAL STATEWIDE TIER</p>	<p>PROJECT LENGTH</p> <p>LENGTH ROADWAY TIP PROJECT U-5796 = 0.877 TOTAL LENGTH TIP PROJECT U-5796 = 0.877</p>	<p>Prepared in the Office of: DIVISION OF HIGHWAYS Division 4 DDC 509 Ward Blvd., Wilson NC, 27895</p> <p>2012 STANDARD SPECIFICATIONS</p> <p>RIGHT OF WAY DATE: AUGUST 01, 2016</p> <p>LETTING DATE: June 20, 2017</p> <p>TIM LITTLE, PE PROJECT ENGINEER</p> <p>D.R. ETHRIDGE PROJECT DESIGN ENGINEER</p>	<p>HYDRAULICS ENGINEER</p> <p>4/7/2017</p> <p>DocuSigned by: James C. Davis E798FAFAC22FAE8 SIGNATURE:</p> <p>SEAL 18462 JAMES C. DAVIS P.E.</p> <p>ROADWAY DESIGN ENGINEER</p> <p>4/6/2017</p> <p>DocuSigned by: D.R. Ethridge E2A8AD8185740A SIGNATURE:</p> <p>SEAL 18537 D.R. ETHRIDGE P.E.</p>	<p>DIVISION OF HIGHWAYS STATE OF NORTH CAROLINA</p> <p>STATE HIGHWAY DESIGN ENGINEER P.E.</p>
--	---	---	--	--	--