



STATE	STATE PROJECT REFERENCE NO.	SHEET NO.	TOTAL SHEETS
N.C.	I-5852B	1	
STATE PROJ. NO.	F.A. PROJ. NO.	DESCRIPTION	
53056.1.1	NHPIM-0085(34)	PE	
53056.3.3	NHPIM-0085(34)	CONST	

STATE OF NORTH CAROLINA
DIVISION OF HIGHWAYS

GUILFORD COUNTY

**LOCATION: I-73 FROM 0.7 MILE SOUTH OF I-40 TO
0.73 MILE SOUTH OF SR 2085 (JOSEPH
M BRYAN BLVD) IN GREENSBORO**

TYPE OF WORK: PAVEMENT REHABILITATION

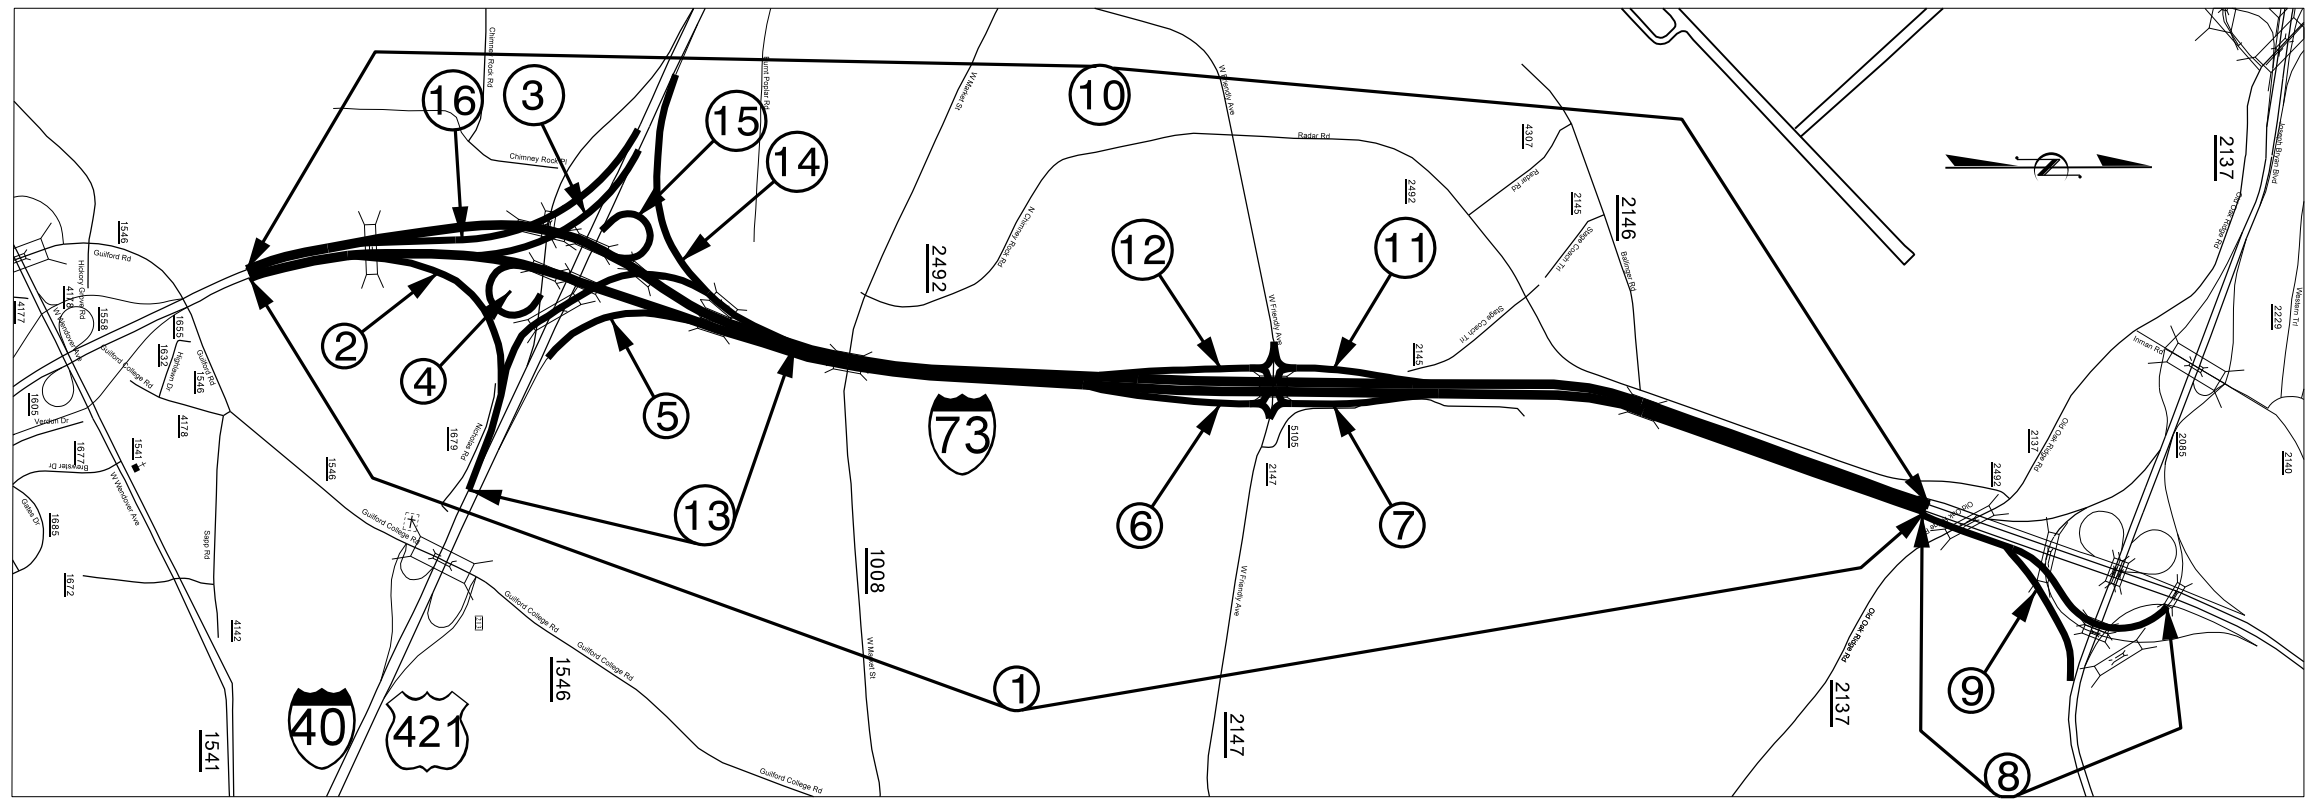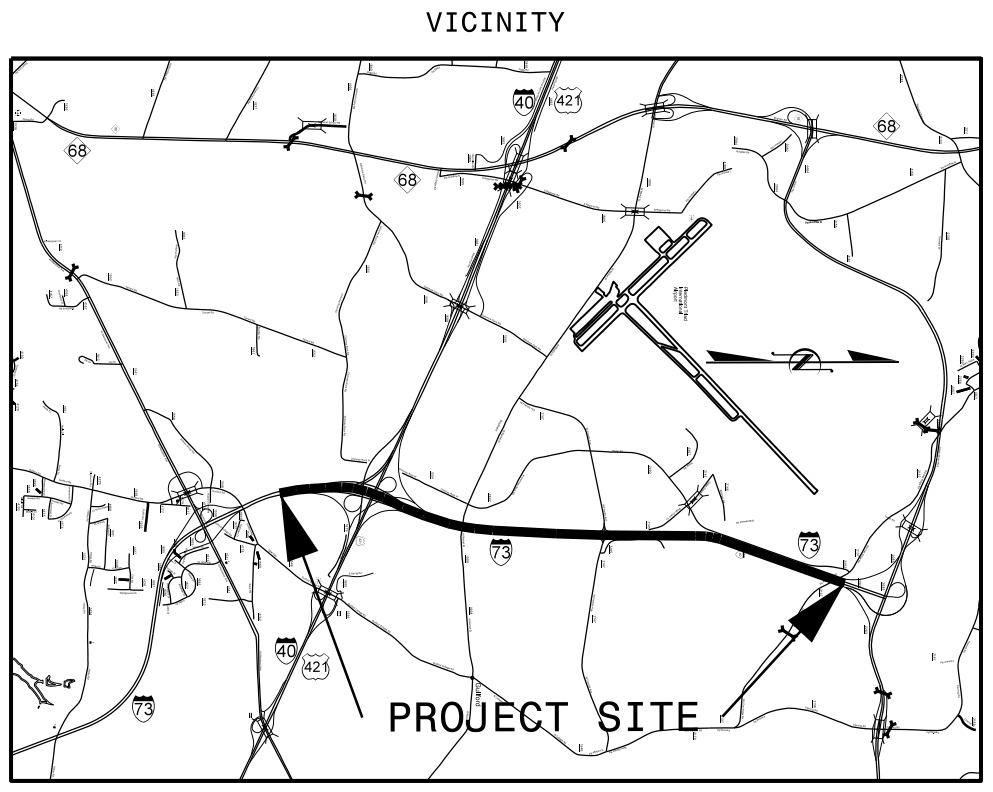

GRAPHIC SCALES
NOT TO SCALE

DESIGN DATA
NA


PROJECT LENGTH
I-5852B: 3.900 miles

Prepared in the Office of:
DIVISION OF HIGHWAYS
1000 Birch Ridge Dr., Raleigh NC, 27610
2012 STANDARD SPECIFICATIONS

C. B. SMITHERMAN, P.E.
PROJECT ENGINEER

CLINTON A. WILES
ENGINEERING TECHNICIAN

LETTING DATE:
July 18, 2017

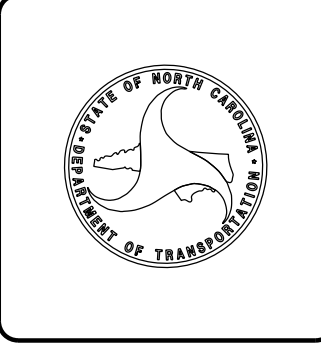

CONTRACT: C204045 **TIP PROJECT: I-5852B**

14-JUN-2017 09:56
 S:\DDC\3-Guilford\I-5852B Rehab\CADD\I-5852B Title.dgn
 AT DIV07-300048
 cwiles