


CONFIDENTIAL AND PROPRIETARY PROPERTY OF  
**EBDG - NC, PLLC**  
 MAY NOT BE USED FOR CONSTRUCTION OR PROVIDED TO  
 ANY THIRD PARTIES WITHOUT PRIOR WRITTEN CONSENT.  
 © 2017 ELLIOTT BAY DESIGN GROUP.


REVISION HISTORY				
REV	ZONE	DESCRIPTION	DWN	DATE

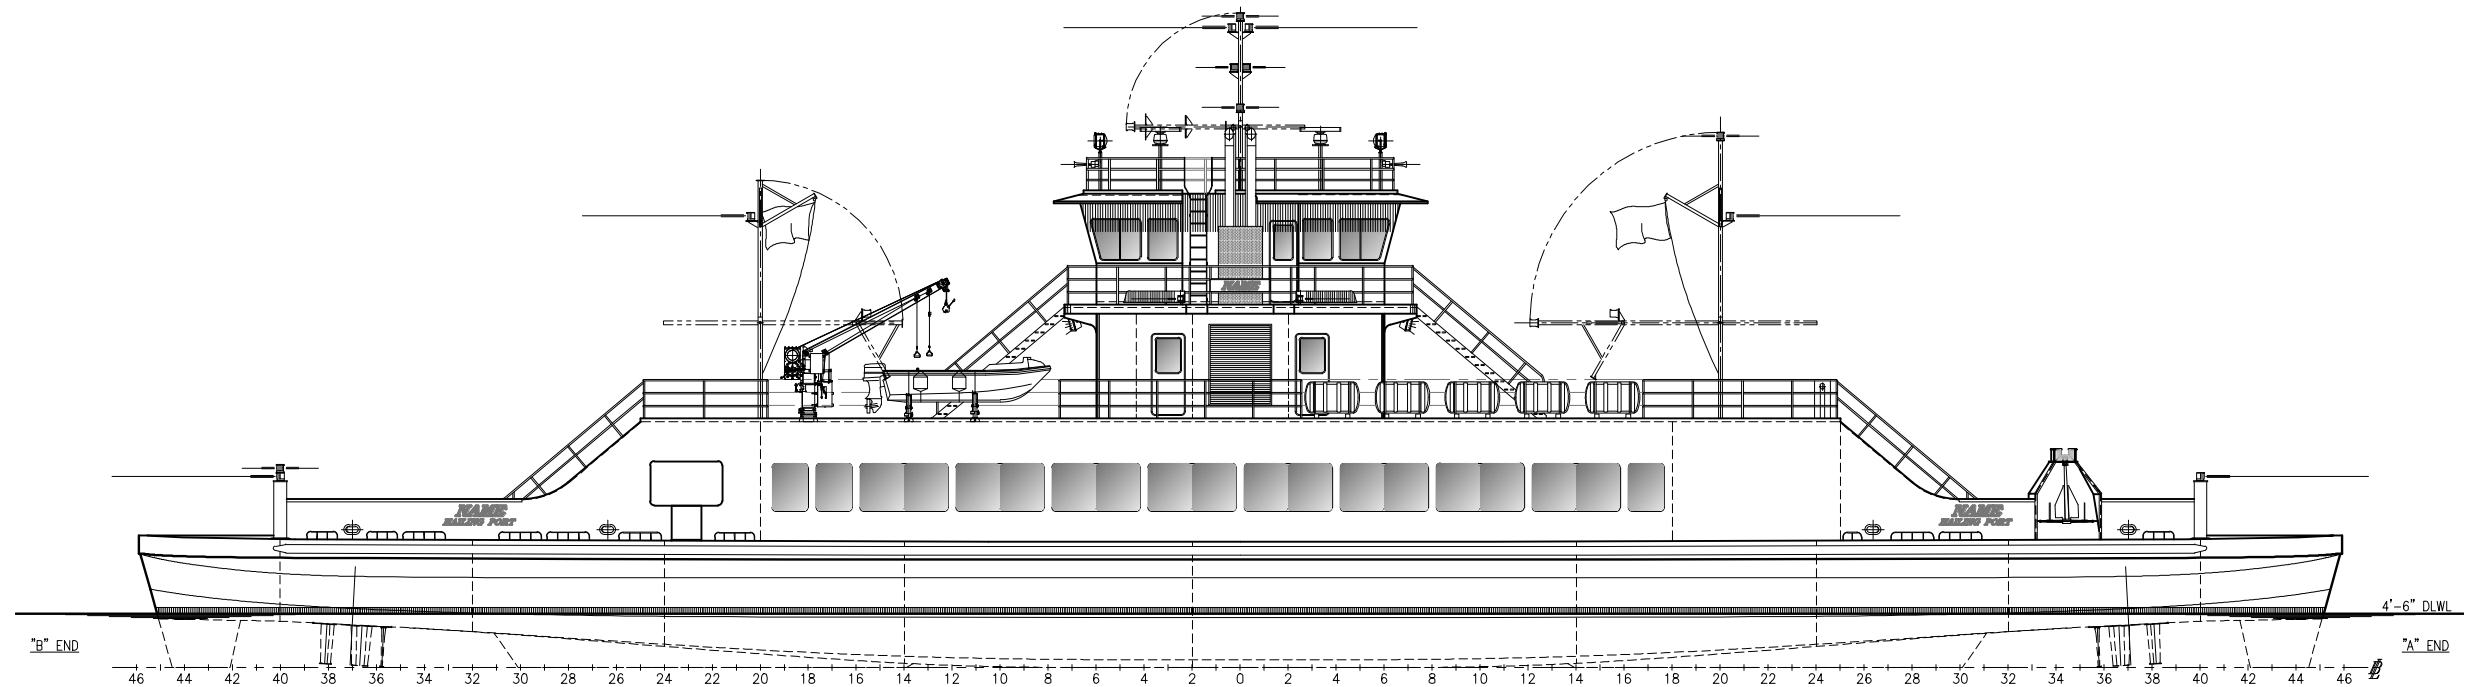

VESSEL DRAWINGS		
Drawing No.	Rev	Drawing Title
16101-200-100-1	---	Lines Plan
16101-200-101-1	---	Profiles and Deck Arrangements
16101-200-101-3	---	Lifesaving Equipment Arrangement
16101-200-101-7	---	Fire Zone Plan
16101-200-101-8	---	Emergency Evacuation Plan
16101-200-110-1	---	Bottom and Side Shell
16101-200-110-2	---	Skegs
16101-200-120-1	---	Midship Section
16101-200-120-2	---	Inboard Structural Profile
16101-200-120-3	---	Hull Transverse Bulkheads
16101-200-120-4	---	Hull Transverse Frames
16101-200-120-5	---	Hull Longitudinal Bulkheads and Girders
16101-200-130-2	A	Main Deck
16101-200-150-1	A	Superstructure Main Deck to 01 Deck
16101-200-150-2	A	Superstructure 01 Deck to Pilot House Top
16101-200-150-3	---	Main Deck Bulwarks
16101-200-170-1	---	Masts
16101-200-180-1	A	Propulsion Unit Foundations
16101-200-201-1	---	Machinery Arrangement

VESSEL DRAWINGS		
Drawing No.	Rev	Drawing Title
16101-200-243-1	---	Shaft Arrangement
16101-200-256-1	---	Cooling System Schematic
16101-200-259-1	---	Exhaust Arrangement
16101-200-261-1	A	Fuel Oil Piping Schematic
16101-200-320-1	---	Ships Service Electrical One Line Diagram
16101-200-330-1	---	Power and Lighting Plan
16101-200-422-1	---	Navigation Light Arrangement and Block Diagram
16101-200-506-1	---	Fills, Vents, and Sounds
16101-200-513-1	---	Machinery Ventilation Arrangement
16101-200-521-1	---	Fire Main System Schematic
16101-200-526-1	---	Deck Drain Piping Schematic
16101-200-528-1	---	Sanitary Drains Schematic
16101-200-529-1	---	Bilge and Ballast Schematic
16101-200-529-2	A	Lube Oil and Waste Oil Piping Schematic
16101-200-533-1	A	Potable and Sanitary Water Piping Schematic
16101-200-551-1	---	Compressed Air Piping Schematic
16101-200-624-1	---	Window Schedule
16101-200-624-2	---	Door Schedule
16101-200-624-3	---	Hatch Schedule



 <b>Elliott Bay Design Group</b> North Carolina, PLLC	
CLIENT	NORTH CAROLINA D.O.T. RALEIGH, NORTH CAROLINA
PROJECT	NEW RIVER CLASS FERRY
DRAWING INDEX	
SIZE	D
DWG NO.	16101-200-000-1
SCALE	NONE
FILE NAME	16101-200-000-1-
SHEET	1 OF 1
DWN	
MOD	
CKD	
APVD	
APVD DATE	

7/28/2017 5:43:56 PM