



USE FOR LIGHTING CONSTRUCTION ONLY

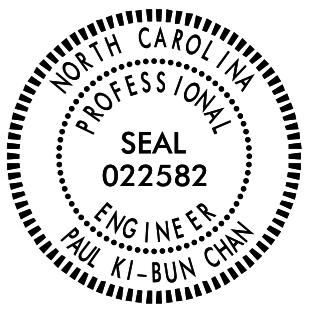



Documented by:  
Paul Chan 11/17/2017

DOCUMENT NOT CONSIDERED FINAL  
UNLESS ALL SIGNATURES COMPLETED

MATCHLINE WITH SHEET E2

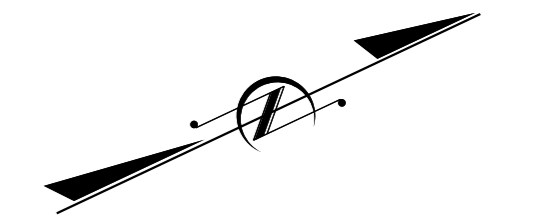

SEE SHEET "E1" FOR  
LEGEND & △ NOTES

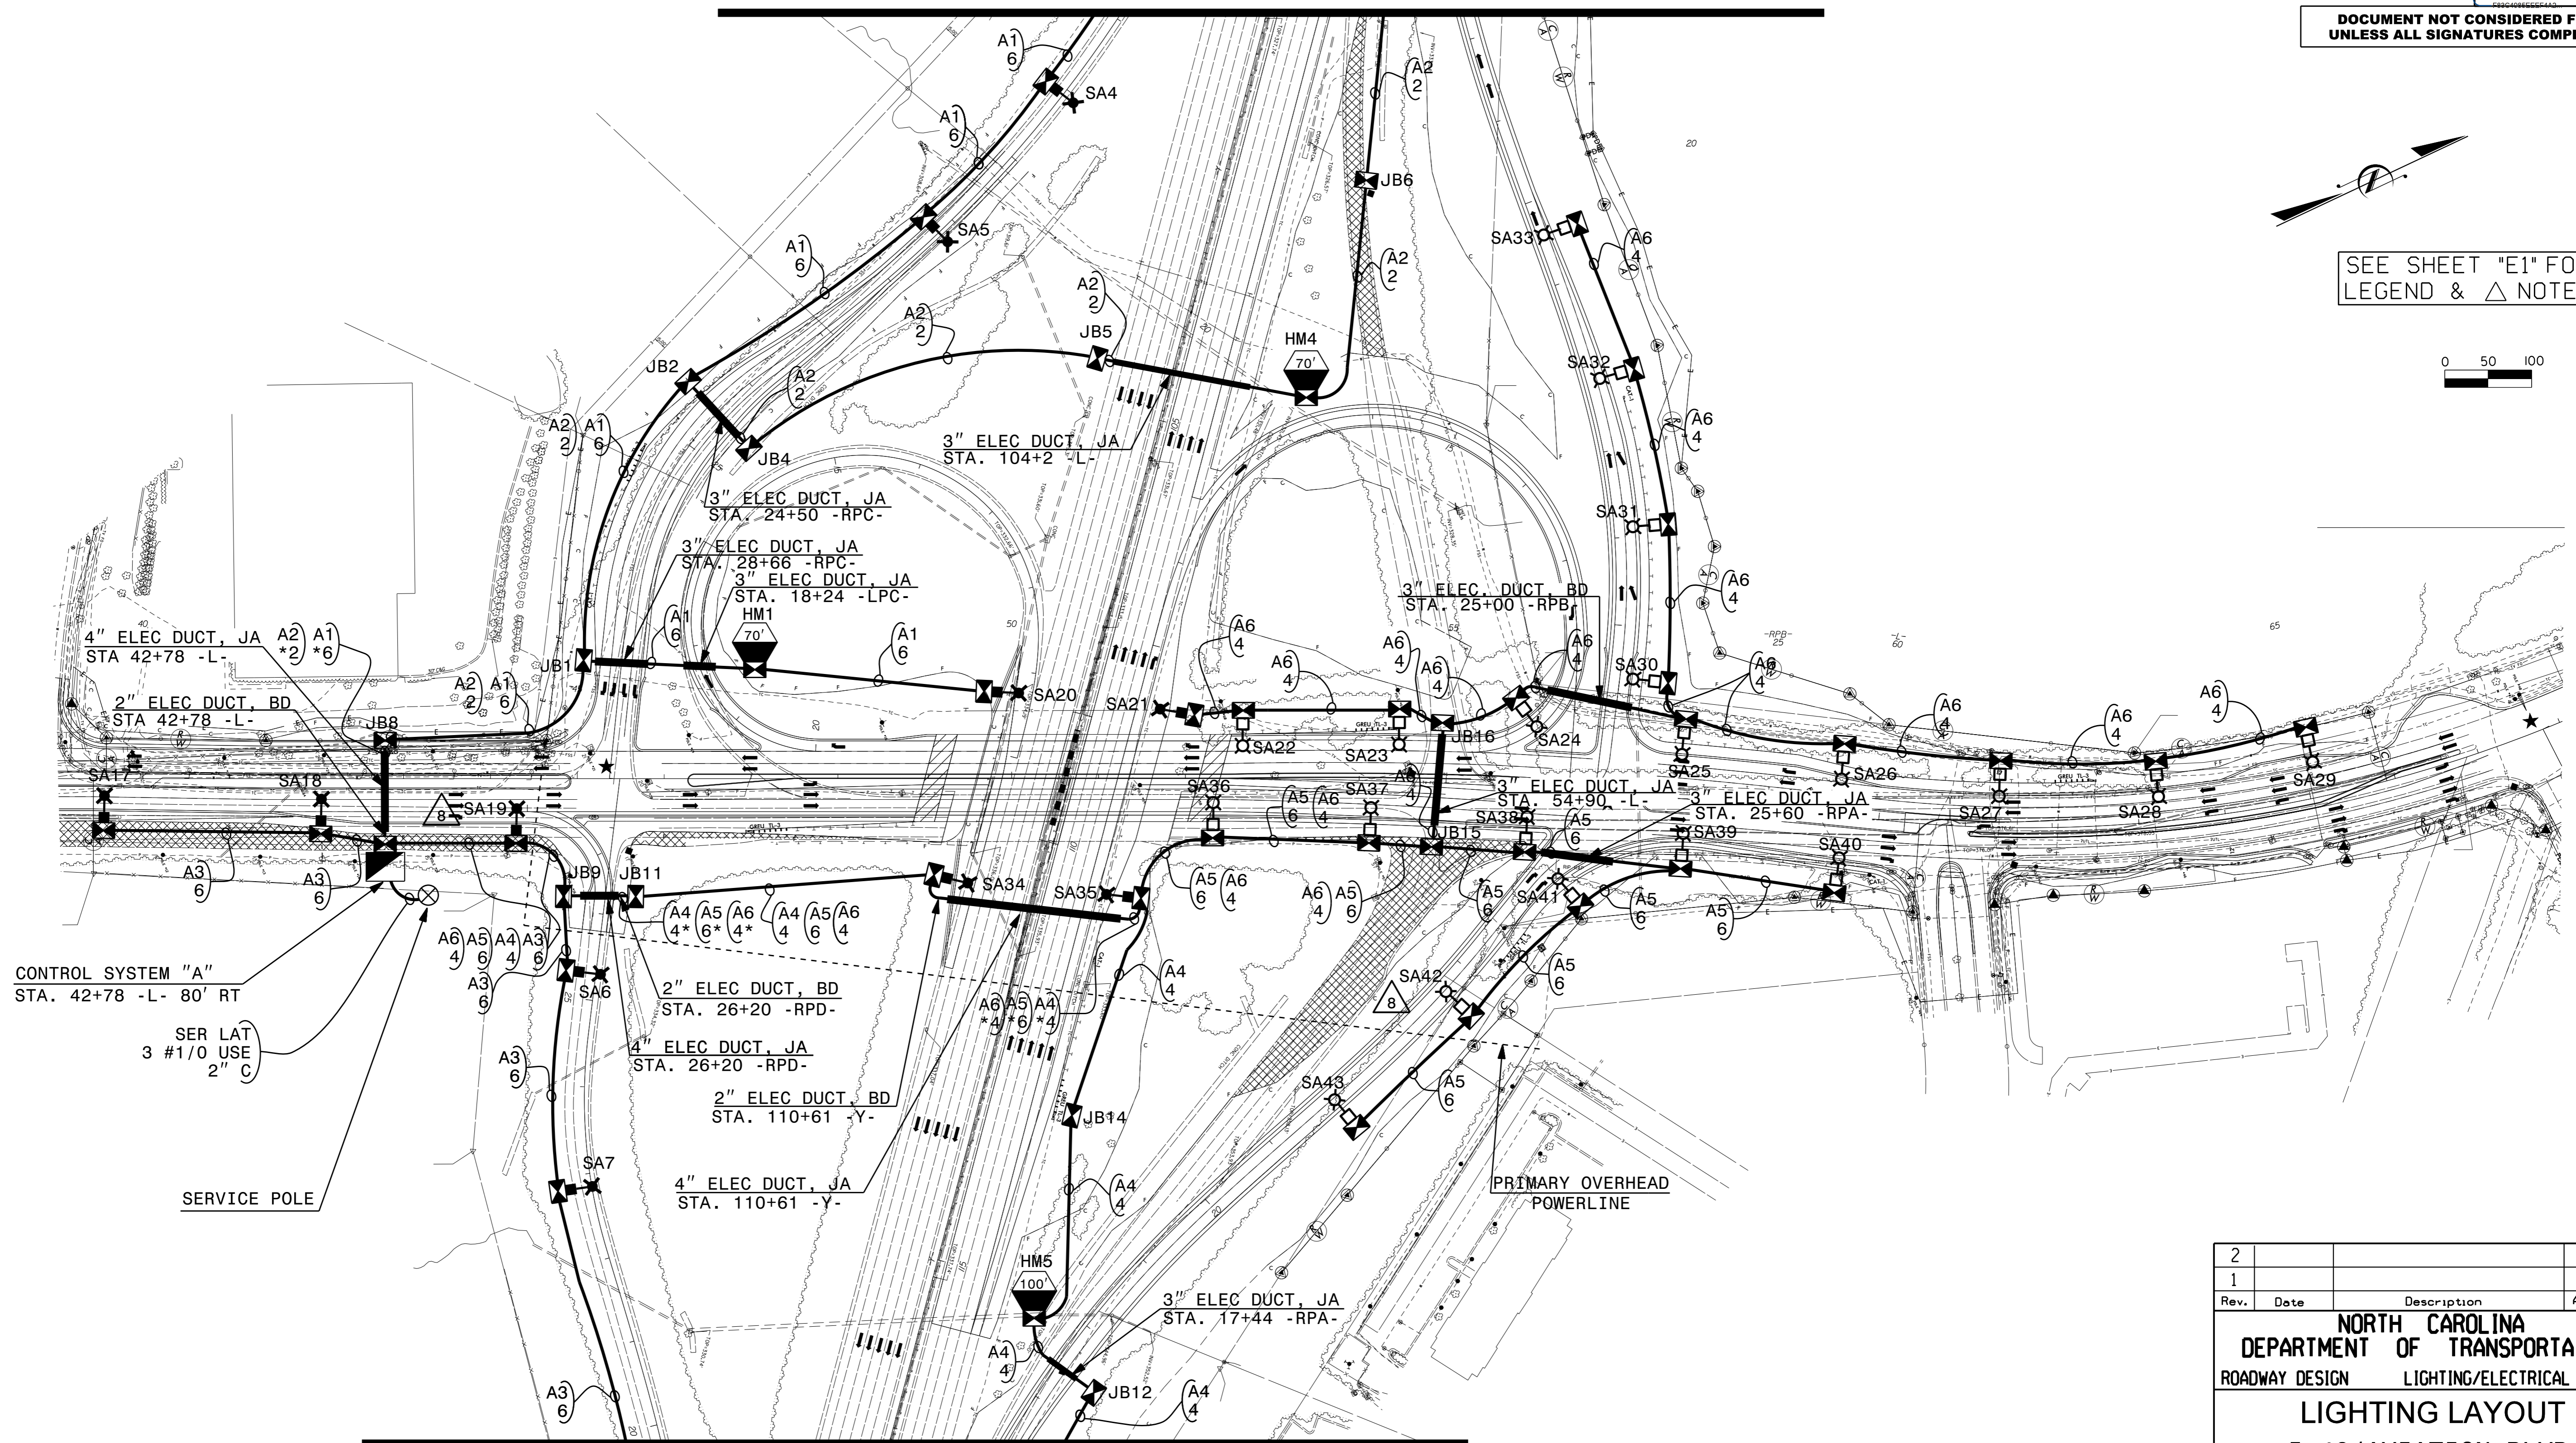 

MATCHLINE WITH SHEET E4

2			
1			
Rev.	Date	Description	Approved
NORTH CAROLINA DEPARTMENT OF TRANSPORTATION ROADWAY DESIGN LIGHTING/ELECTRICAL SECTION <b>LIGHTING LAYOUT</b> I-40/AVIATION BLVD. INTERCHANGE WAKE COUNTY			
Drawn By:	AB	Approved By:	Dwg No.:

I7-NOV-2017 10:24  
 F:\Lighting\Lighting Design\I5506.l&e.psh.E3.dgn  
 1abr.cwr 11/17/2017 2:03:15