


**DOCUMENT NOT CONSIDERED FINAL
UNLESS ALL SIGNATURES COMPLETED**

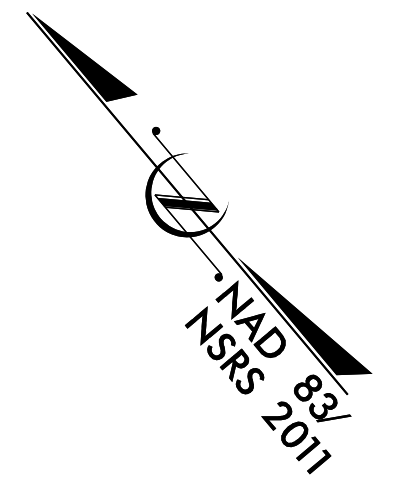


STATE OF NORTH CAROLINA
DIVISION OF HIGHWAYS

MECKLENBURG COUNTY


**LOCATION: NC 16 (BROOKSHIRE BOULEVARD) FROM
NORTH OF SR 2004 (MOUNT HOLLY-HUNTERSVILLE ROAD) TO
SOUTH OF INTERSTATE 485 RAMP**

**TYPE OF WORK: FIBER CABLE INSTALLATION, CCTV CAMERA INSTALLATION
AND CONNECTING NEW SIGNALS**

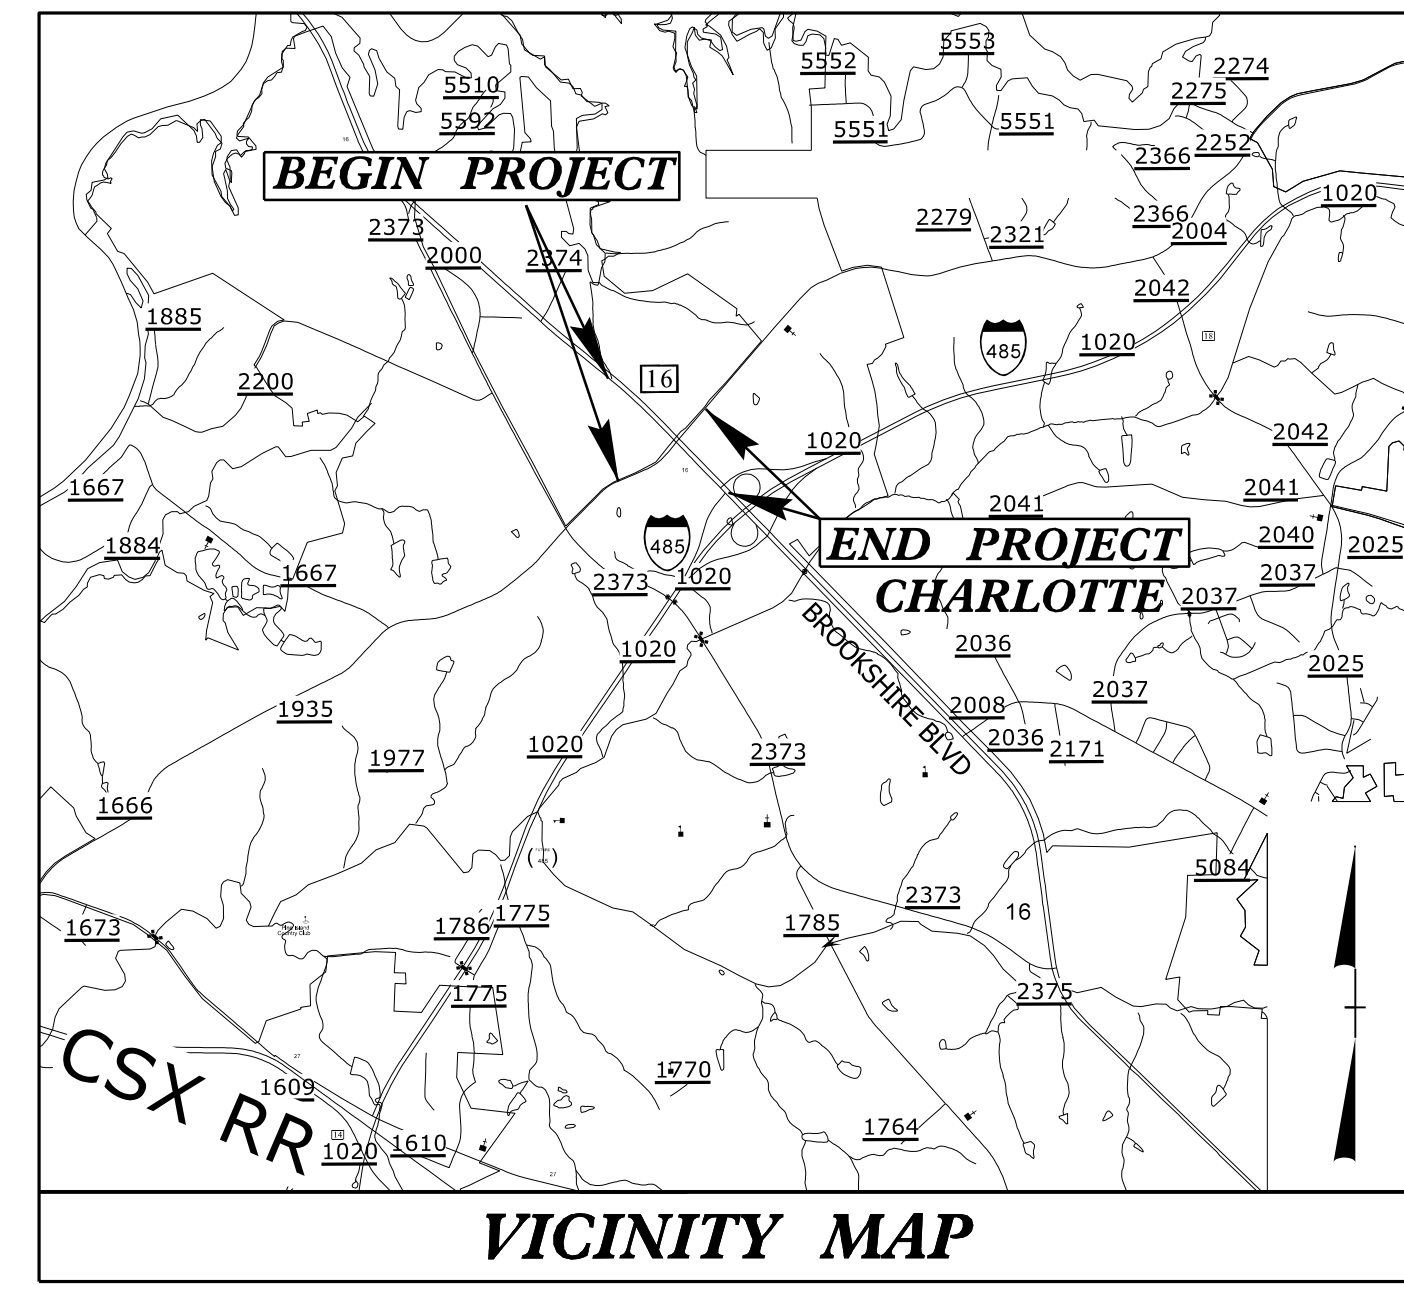

TIP PROJECT: U-6084

CONTRACT: C204126

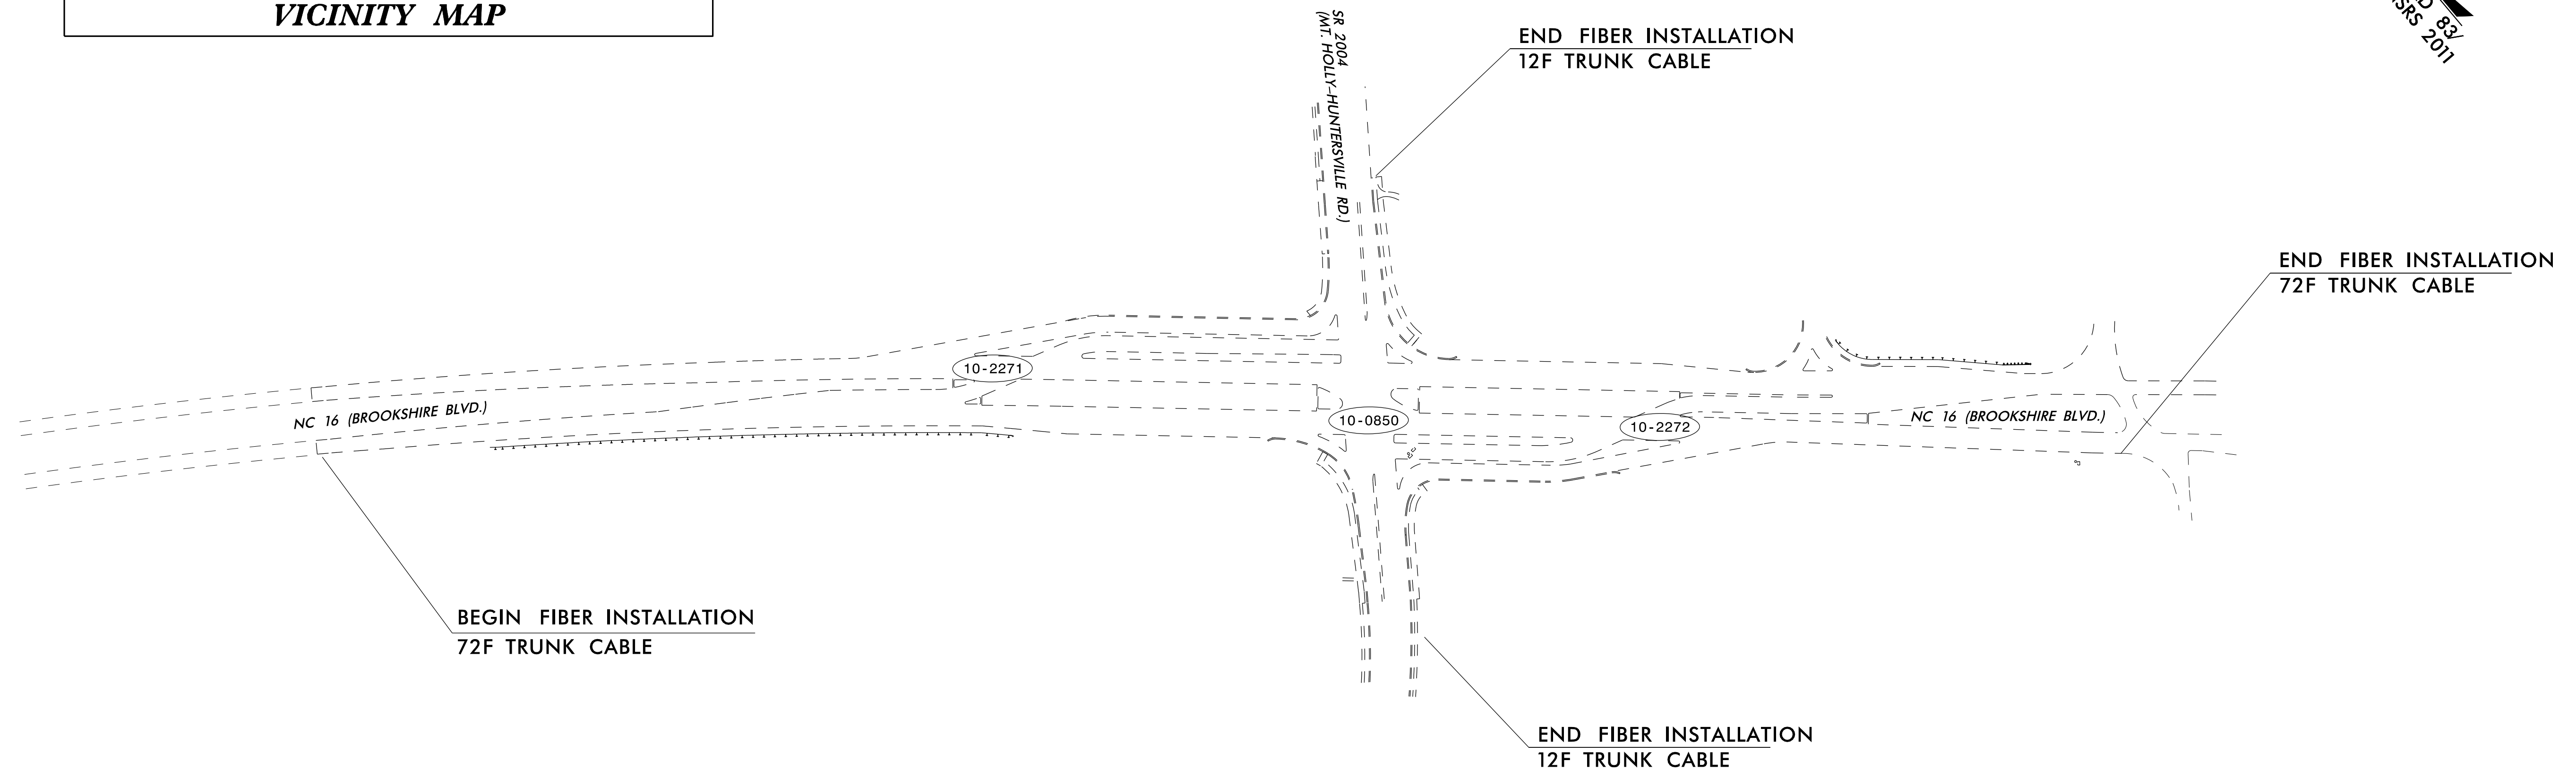

INDEX OF PLANS	
SHEET NUMBER	LOCATION / DESCRIPTION
SCP-01	TITLE SHEET
SCP-02	SCHEMATIC ONE-LINE DIAGRAM
SCP-03	DRAWING FORMAT ITEMS - CONSTRUCTION NOTES, CABLE INSTALLATION NOTES
SCP-04 thru SCP-07	TRUNK FIBER INSTALLATION FIBER CABLE ROUTING
SCP-08 thru SCP-14	FIBER CABLE SPLICING DETAILS

ROADWAY STANDARD DRAWINGS	
THE FOLLOWING ROADWAY STANDARDS AS APPEAR IN "ROADWAY STANDARD DRAWINGS" ROADWAY DESIGN UNIT - N.C. DEPARTMENT OF TRANSPORTATION - RALEIGH, N.C. DATED JANUARY 2012 ARE APPLICABLE TO THIS PROJECT AND BY REFERENCE HEREBY ARE CONSIDERED A PART OF THESE PLANS.	
STD. No.	TITLE
1101.01	WORK ZONE WARNING SIGNS
1101.02	TEMPORARY LANE CLOSURE
1101.03	TEMPORARY SHOULDER CLOSURE
1715.01	UNDERGROUND CONDUIT
1716.01	JUNCTION BOXES
1730.01	FIBER OPTIC CABLE

LEGEND	
	SIGNAL INVENTORY No.

Stantec Stantec Consulting Services Inc. 801 Jones Franklin Rd-Suite 300 Raleigh, NC 27606 Tel. 919.851.6866 Fax. 919.851.7024 www.stantec.com License No. F-0872

Betsy L. Watson, PE Senior Principal
Dean Harris Senior Transportation Engineer
Jim Ingram Senior ITS Designer

NCDOT CONTACT:
 TRANSPORTATION SAFETY AND MOBILITY
 INTELLIGENT TRANSPORTATION SYSTEMS SECTION
I. Neal Avery Signal Communication Project Engineer
Heidi Berggren, EI Signal Communication Project Design Engineer

Plans Prepared for:
DIVISION OF HIGHWAYS

750 N. Greenfield Parkway, Garner, NC 27529

Seal of the State of North Carolina
 SEAL 29449
 DATE 1/23/2018
 SIGNATURE DATE