


STATE	PROJECT NO.	SHEET NO.
N.C.	I-5853	2

GUILFORD COUNTY

I - 5853

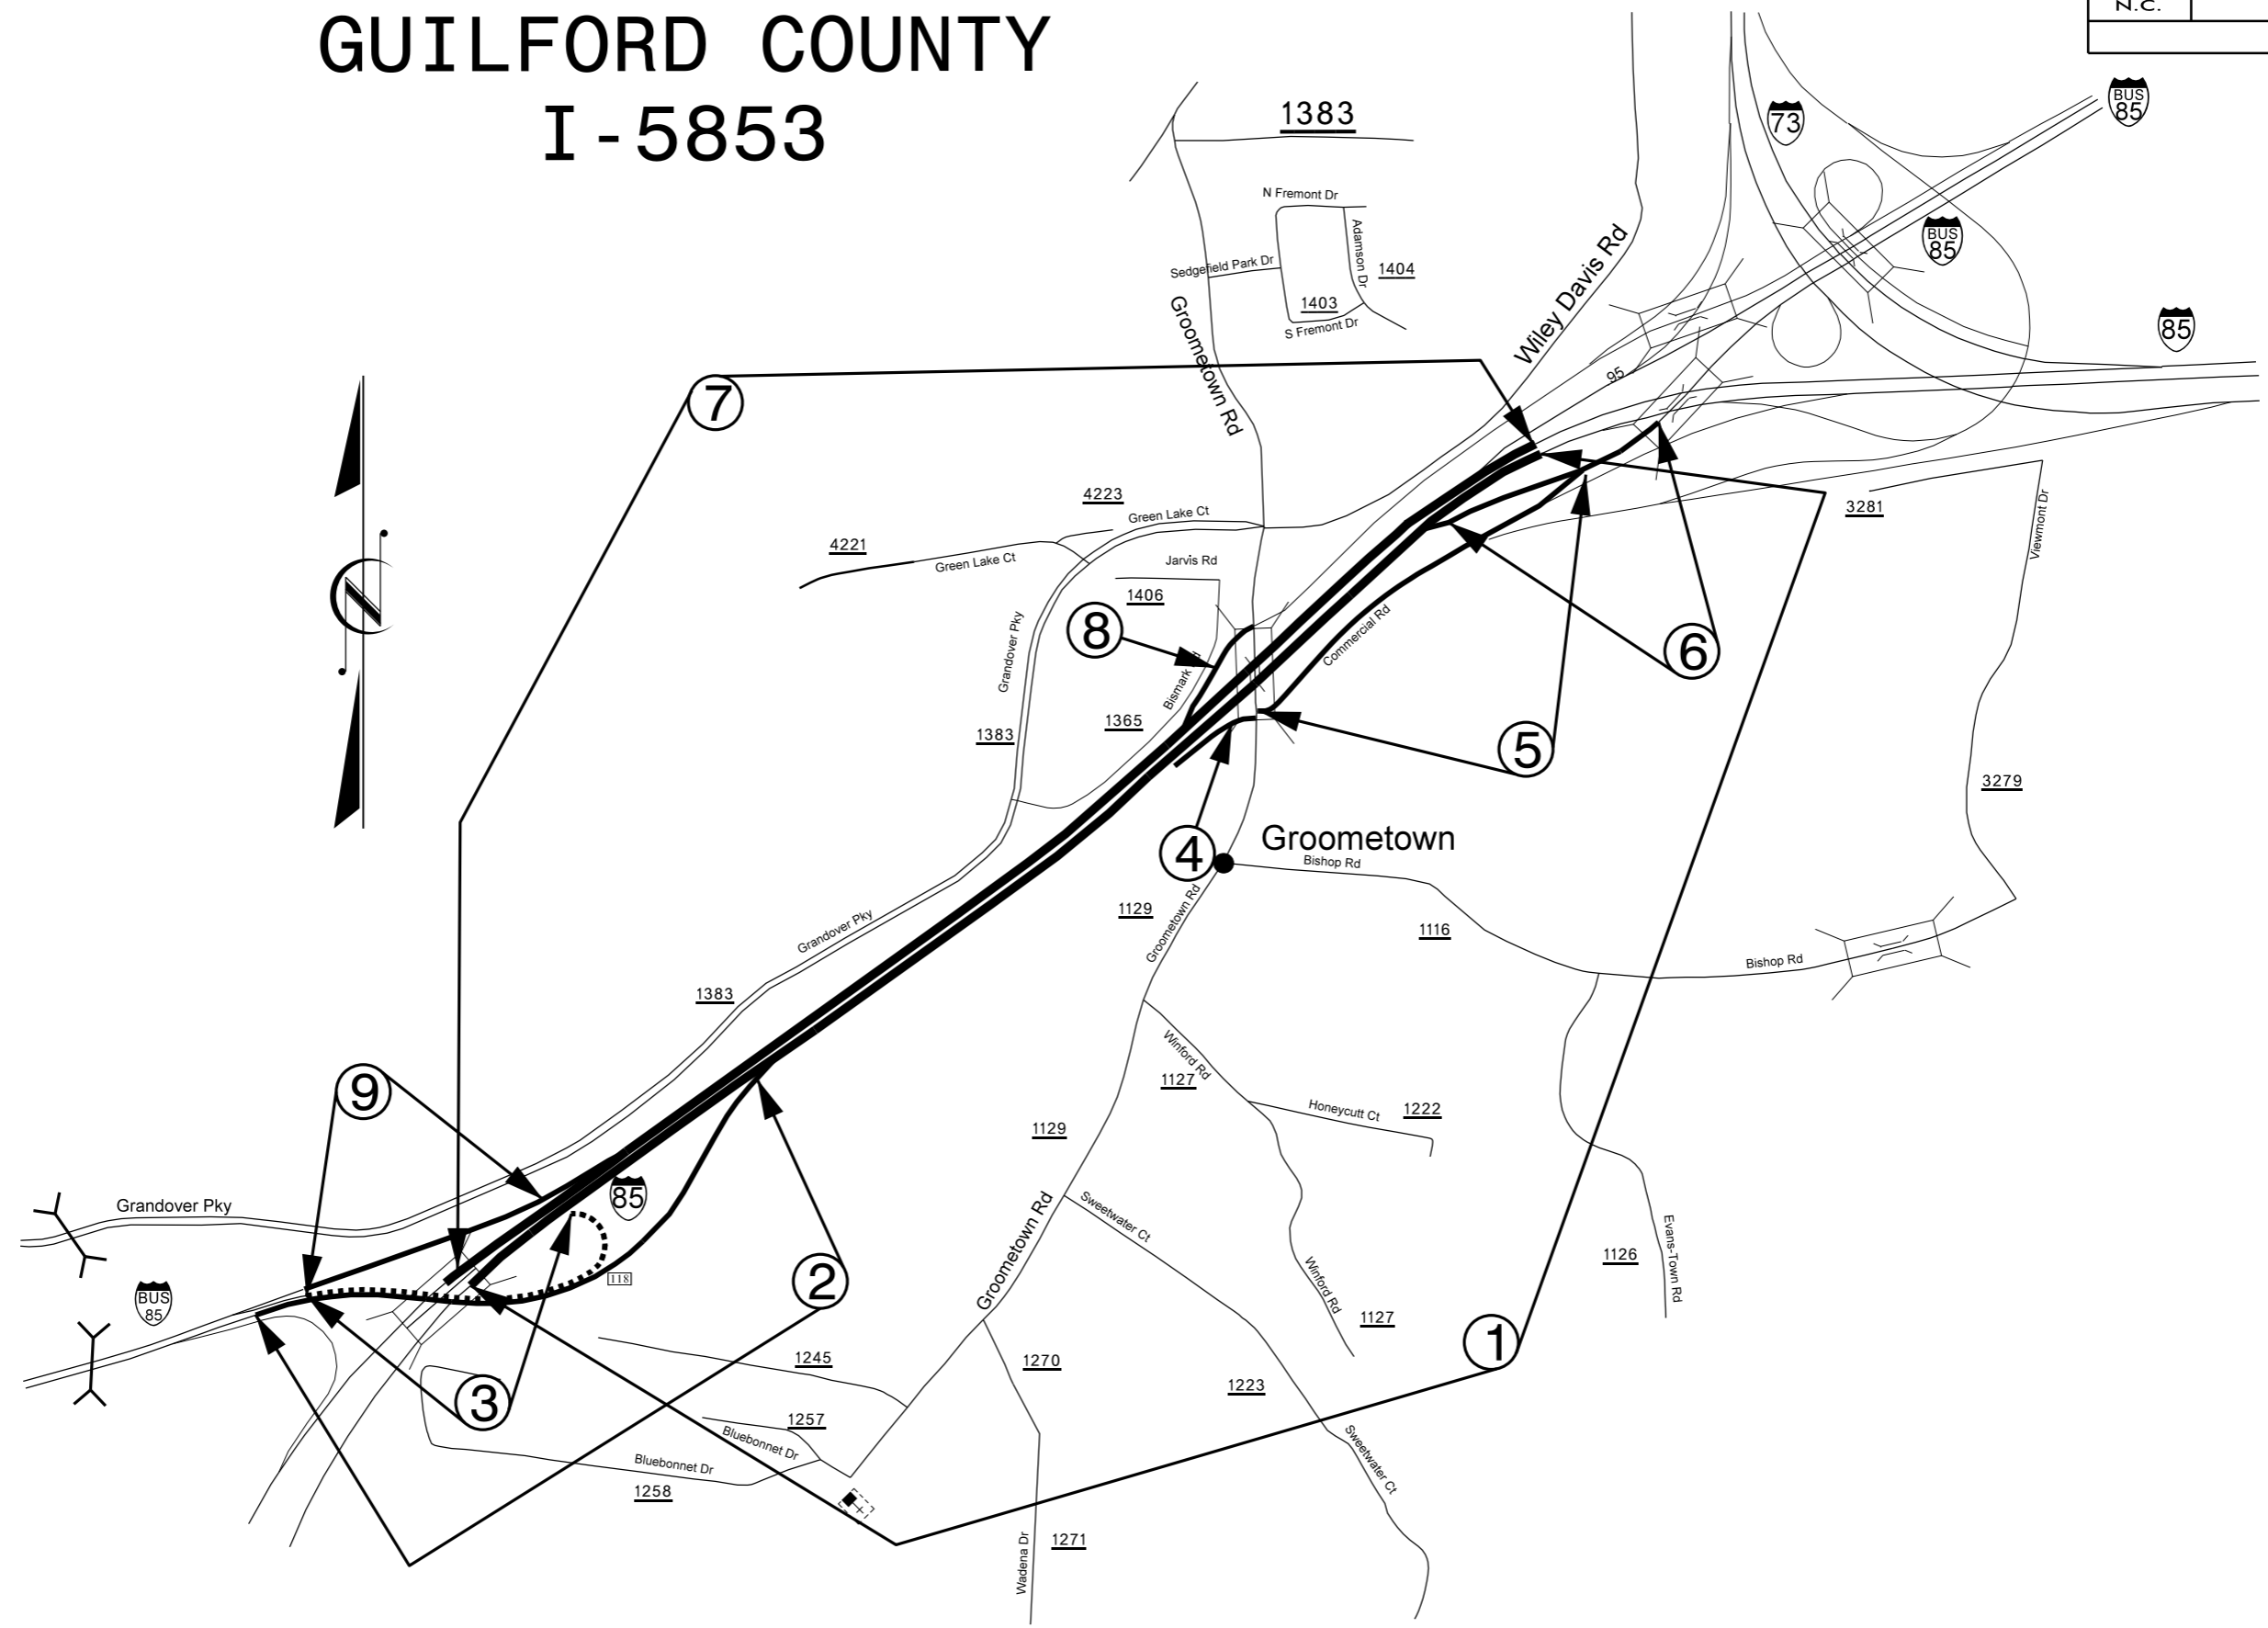

09-JAN-2018 07:57
 S:\DDC\3-Guilford\I-5853\CADD\I-5853 vicinity.dgn
 cwiles A:\DIV07-300048