

Project: U-2412A


STATE OF NORTH CAROLINA
DIVISION OF HIGHWAYS

Project No.	Sheet No.
U-2412A	Sig. 1.0


GUILFORD COUNTY

LOCATION: SR 4121 (JAMESTOWN PARKWAY) FROM I-74/US 311
TO SR 4228 (VICKREY CHAPEL ROAD)

TYPE OF WORK: TRAFFIC SIGNALS AND SIGNAL COMMUNICATIONS

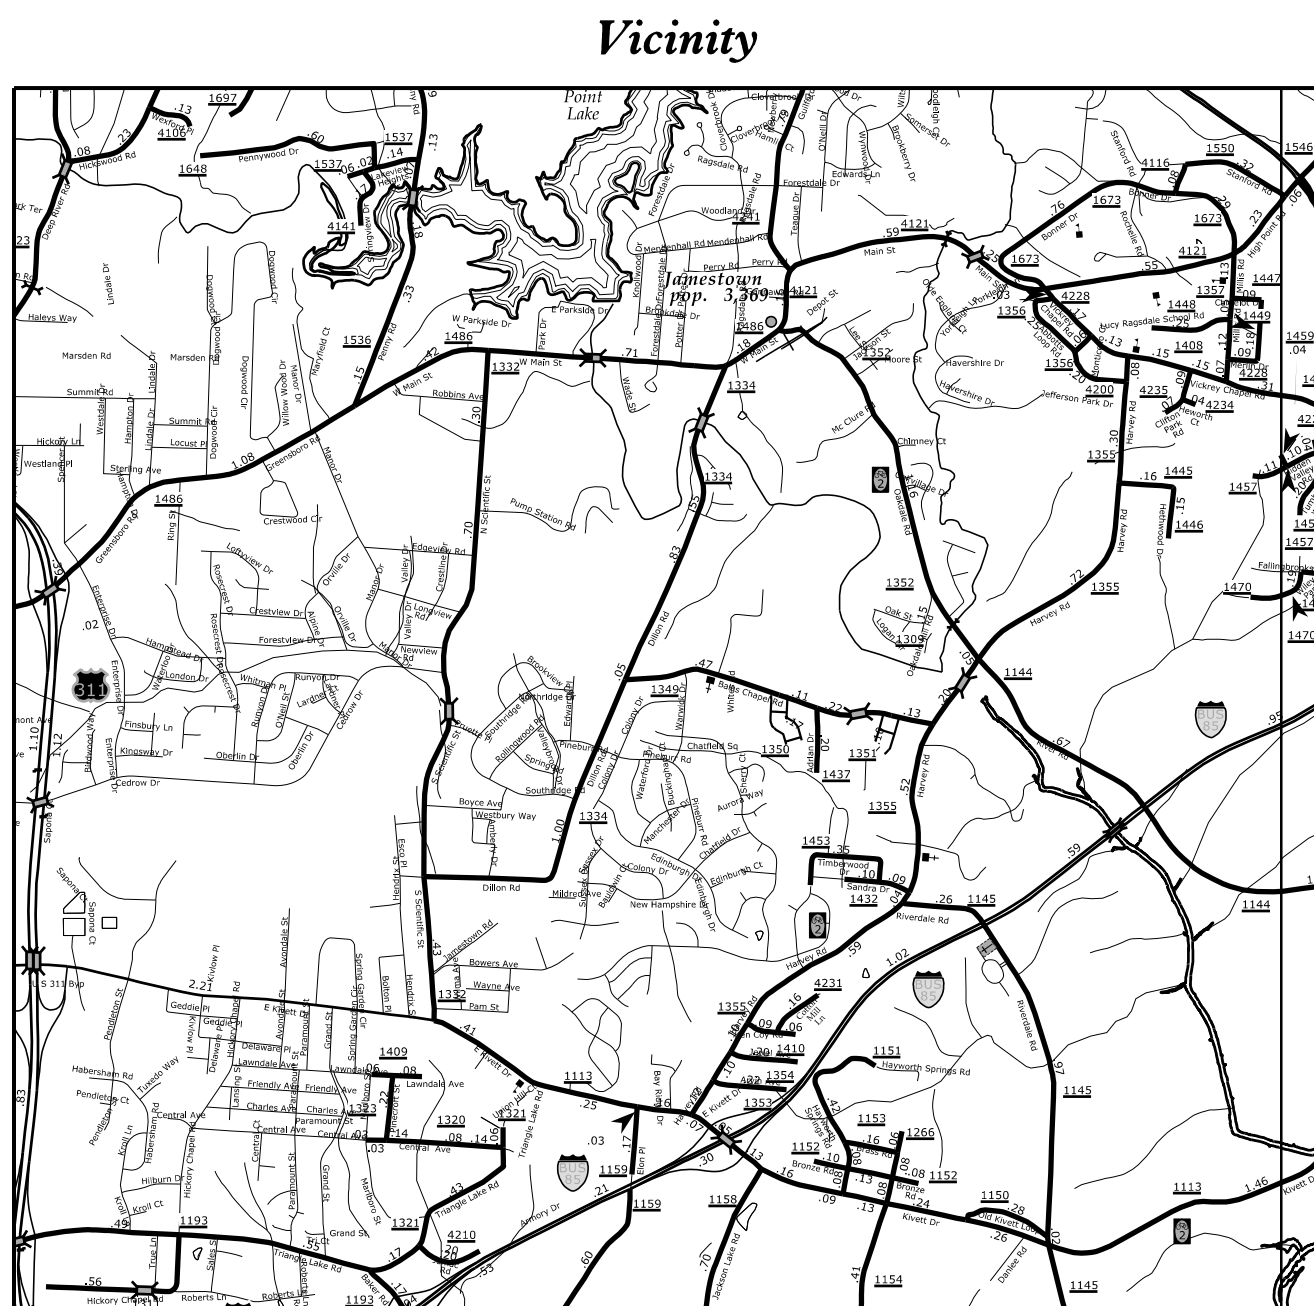

END TIP PROJECT U-2412A
-L- STA 214+47.00

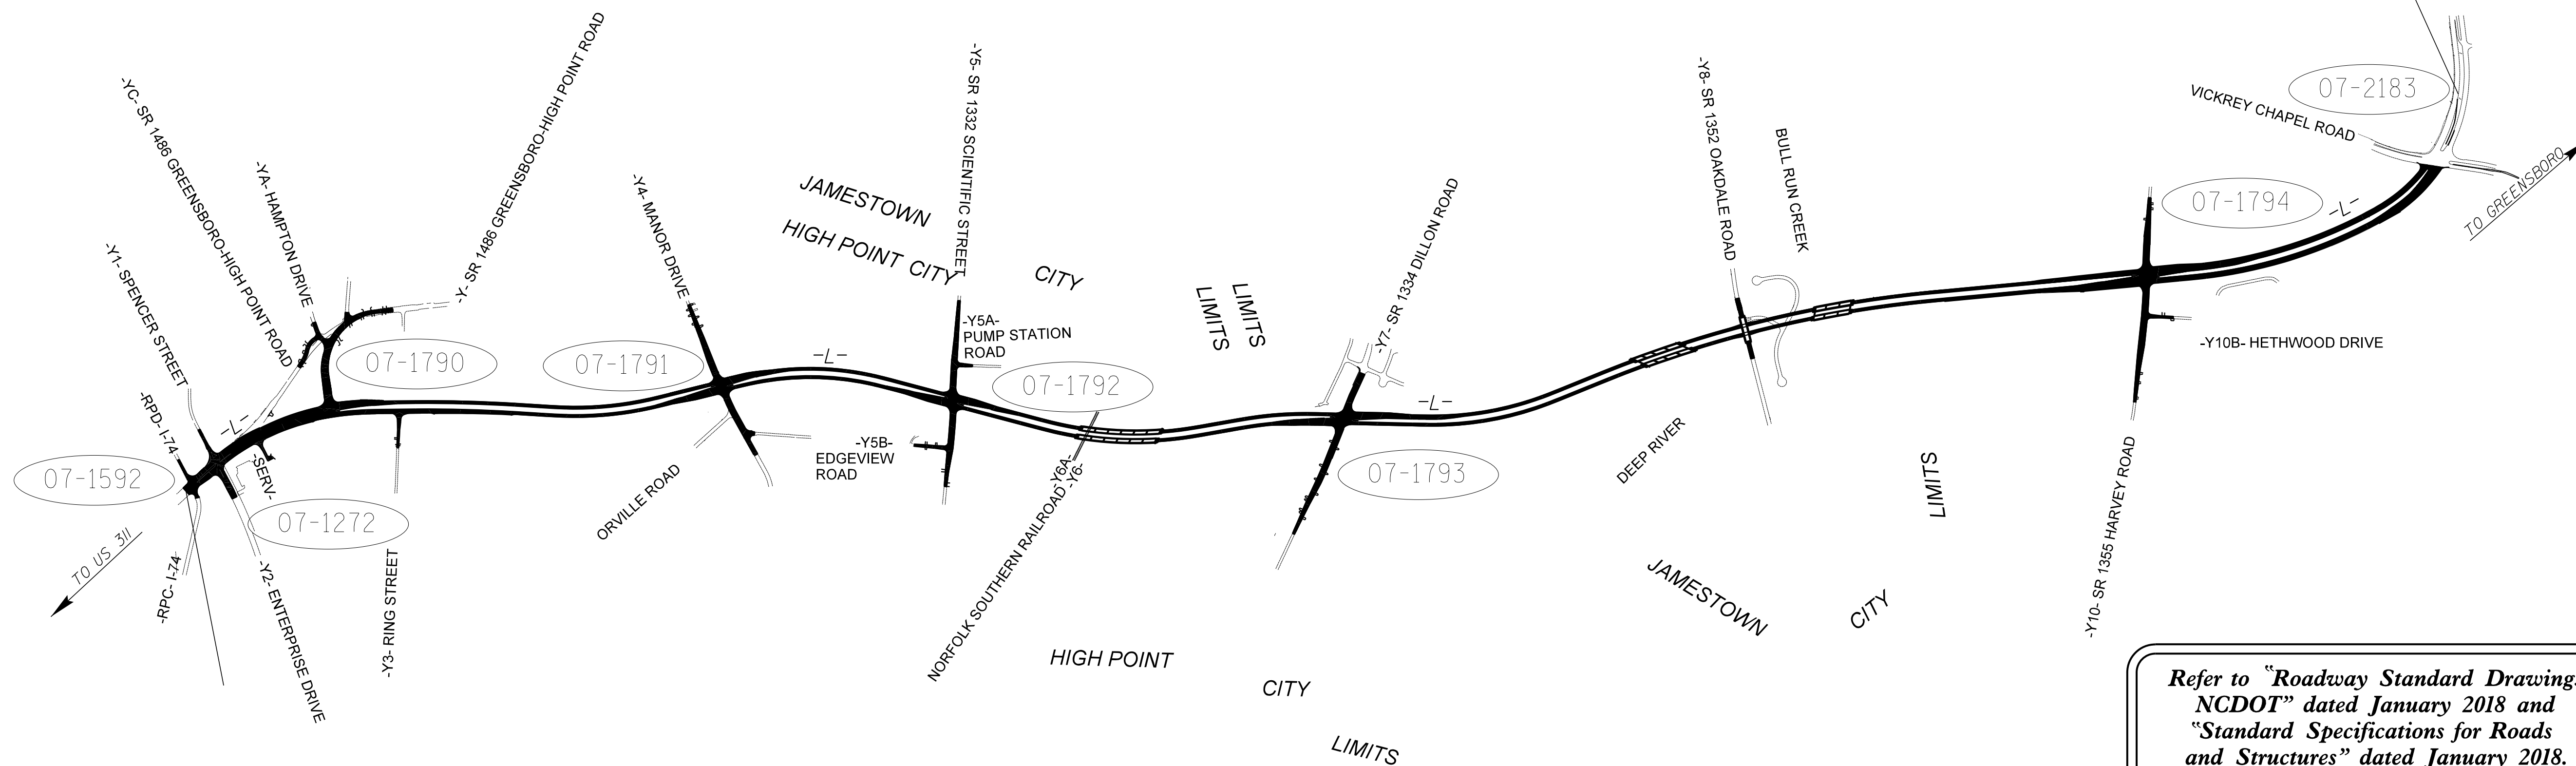

Refer to "Roadway Standard Drawings NCDOT" dated January 2018 and "Standard Specifications for Roads and Structures" dated January 2018.

Sheet #	Reference #	Location/Description
Sig. 1.0	-----	Title Sheet
Sig. 2.0-3.4	07-1592	SR 1486 (Greensboro Rd) at I-74 WB/US 311 NB Ramp
Sig. 4.0-5.2	07-1272	SR 1486 (Greensboro Rd) at Enterprise Dr
Sig. 6.0-6.1	07-1790	SR 1486 (Greensboro Rd) at SR 4121 (Jamestown Pkwy)
Sig. 7.0-7.2	07-1791	SR 4121 (Jamestown Pkwy) at Manor Dr
Sig. 8.0-8.2	07-1792	SR 4121 (Jamestown Pkwy) at SR 1332 (Scientific St)
Sig. 9.0-9.2	07-1793	SR 4121 (Jamestown Pkwy) at SR 1334 (Dillon Rd)
Sig. 10.0-10.6	07-1794	SR 4121 (Jamestown Pkwy) at SR 1355 (Harvey Rd)
Sig. 11.0-12.1	07-2183	SR 4121 (Jamestown Pkwy) at SR 4228 (Vickrey Chapel Rd)
Sig. 13.0-13.2	-----	Standard Plate Sheets
M1-M8	-----	Metal Pole Sheets
SCP 1-10	-----	Signal Communication Plans

M M
MOTT MACDONALD
PO Box 700
Fuquay-Varina, NC 27526
www.mottmac.com
License No. F-0659

INTELLIGENT TRANSPORTATION AND SIGNALS UNIT
Contacts:
Rob Ziemba, PE, CPM - Central Region Signals Engineer
Keith Mims, PE - Signal Equipment Design Engineer
I. Neil Avery - Signal Communication Project Engineer

Prepared for the Office of:
DIVISION OF HIGHWAYS
TRANSPORTATION MOBILITY AND SAFETY DIVISION

750 N. Greenfield Parkway, Garner, NC 27529