


TIP PROJECT: U-6015

CONTRACT: C204111

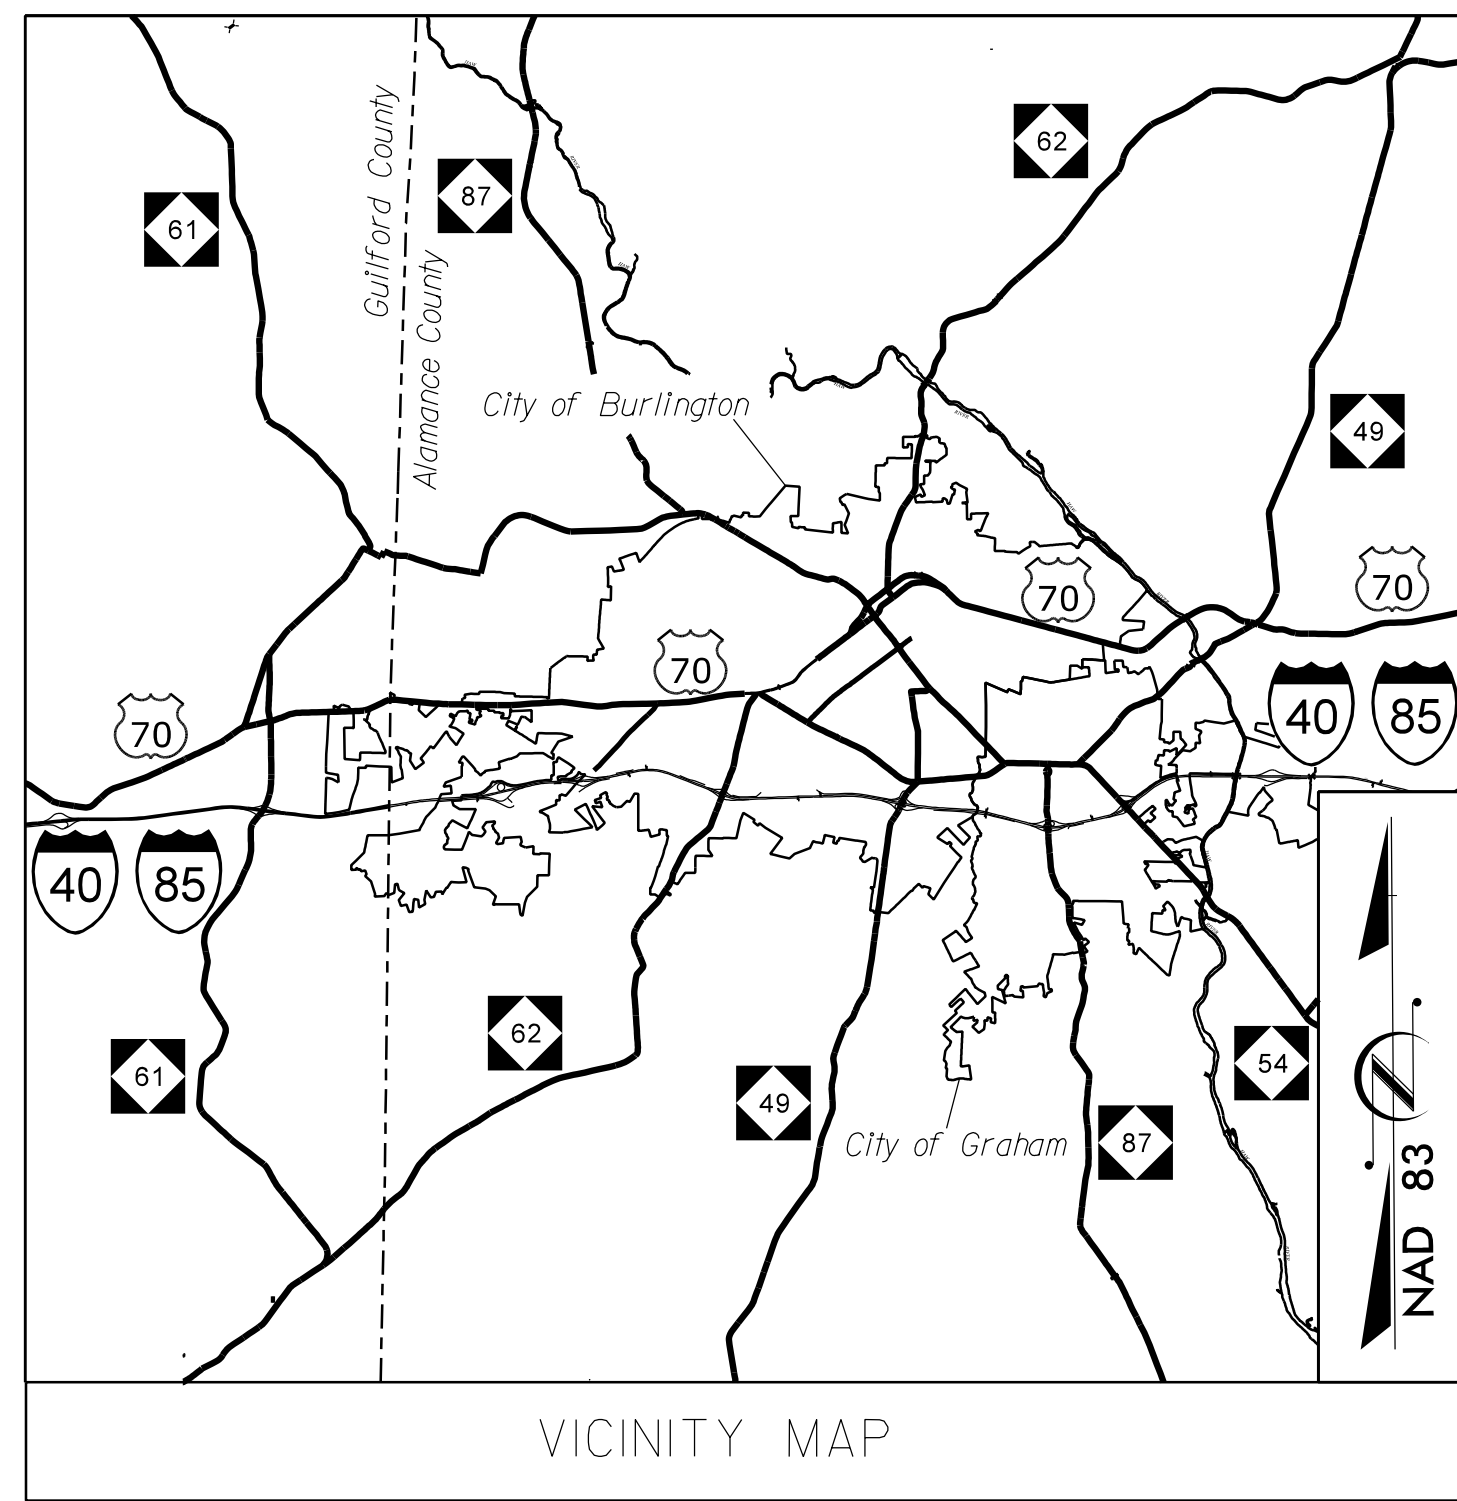


NORTH CAROLINA
DEPARTMENT OF TRANSPORTATION

PLANS FOR PROPOSED IMPROVEMENTS
CITIES OF BURLINGTON & GRAHAM
COMPUTERIZED TRAFFIC SIGNAL SYSTEM

REPLACEMENT OF EXISTING SIGNAL SYSTEM WITH A NEW COMPUTERIZED TRAFFIC SIGNAL SYSTEM.
RELATED WORK INCLUDES:
UPGRADING LOCAL INTERSECTION CONTROLLERS, CABINETS, AND SYSTEM DETECTORS WITH LIMITED SIGNAL WIRING AND SIGNAL HEAD UPGRADES WHEN NECESSARY; UPGRADE AND EXPANSION OF CCTV MONITORING NETWORK; INSTALLING CENTRAL EQUIPMENT AND CENTRAL SOFTWARE; AND INSTALLATION OF AN ETHERNET COMMUNICATIONS NETWORK COMPRISED OF FIBER-OPTIC CABLE AND WIRELESS TECHNOLOGY WITH ALL RELATED EQUIPMENT.

STATE	STATE PROJECT REFERENCE NO.	SHEET NO.	TOTAL SHEETS
N.C.	U-6015	Sig. 101.A	
STATE PROJ. NO.	F.A. PROJ. NO.	DESCRIPTION	
47160.1.1		PE	
47160.3.1	STBG-0701 (036)	CONST	

**DOCUMENT NOT CONSIDERED FINAL
UNLESS ALL SIGNATURES COMPLETED**

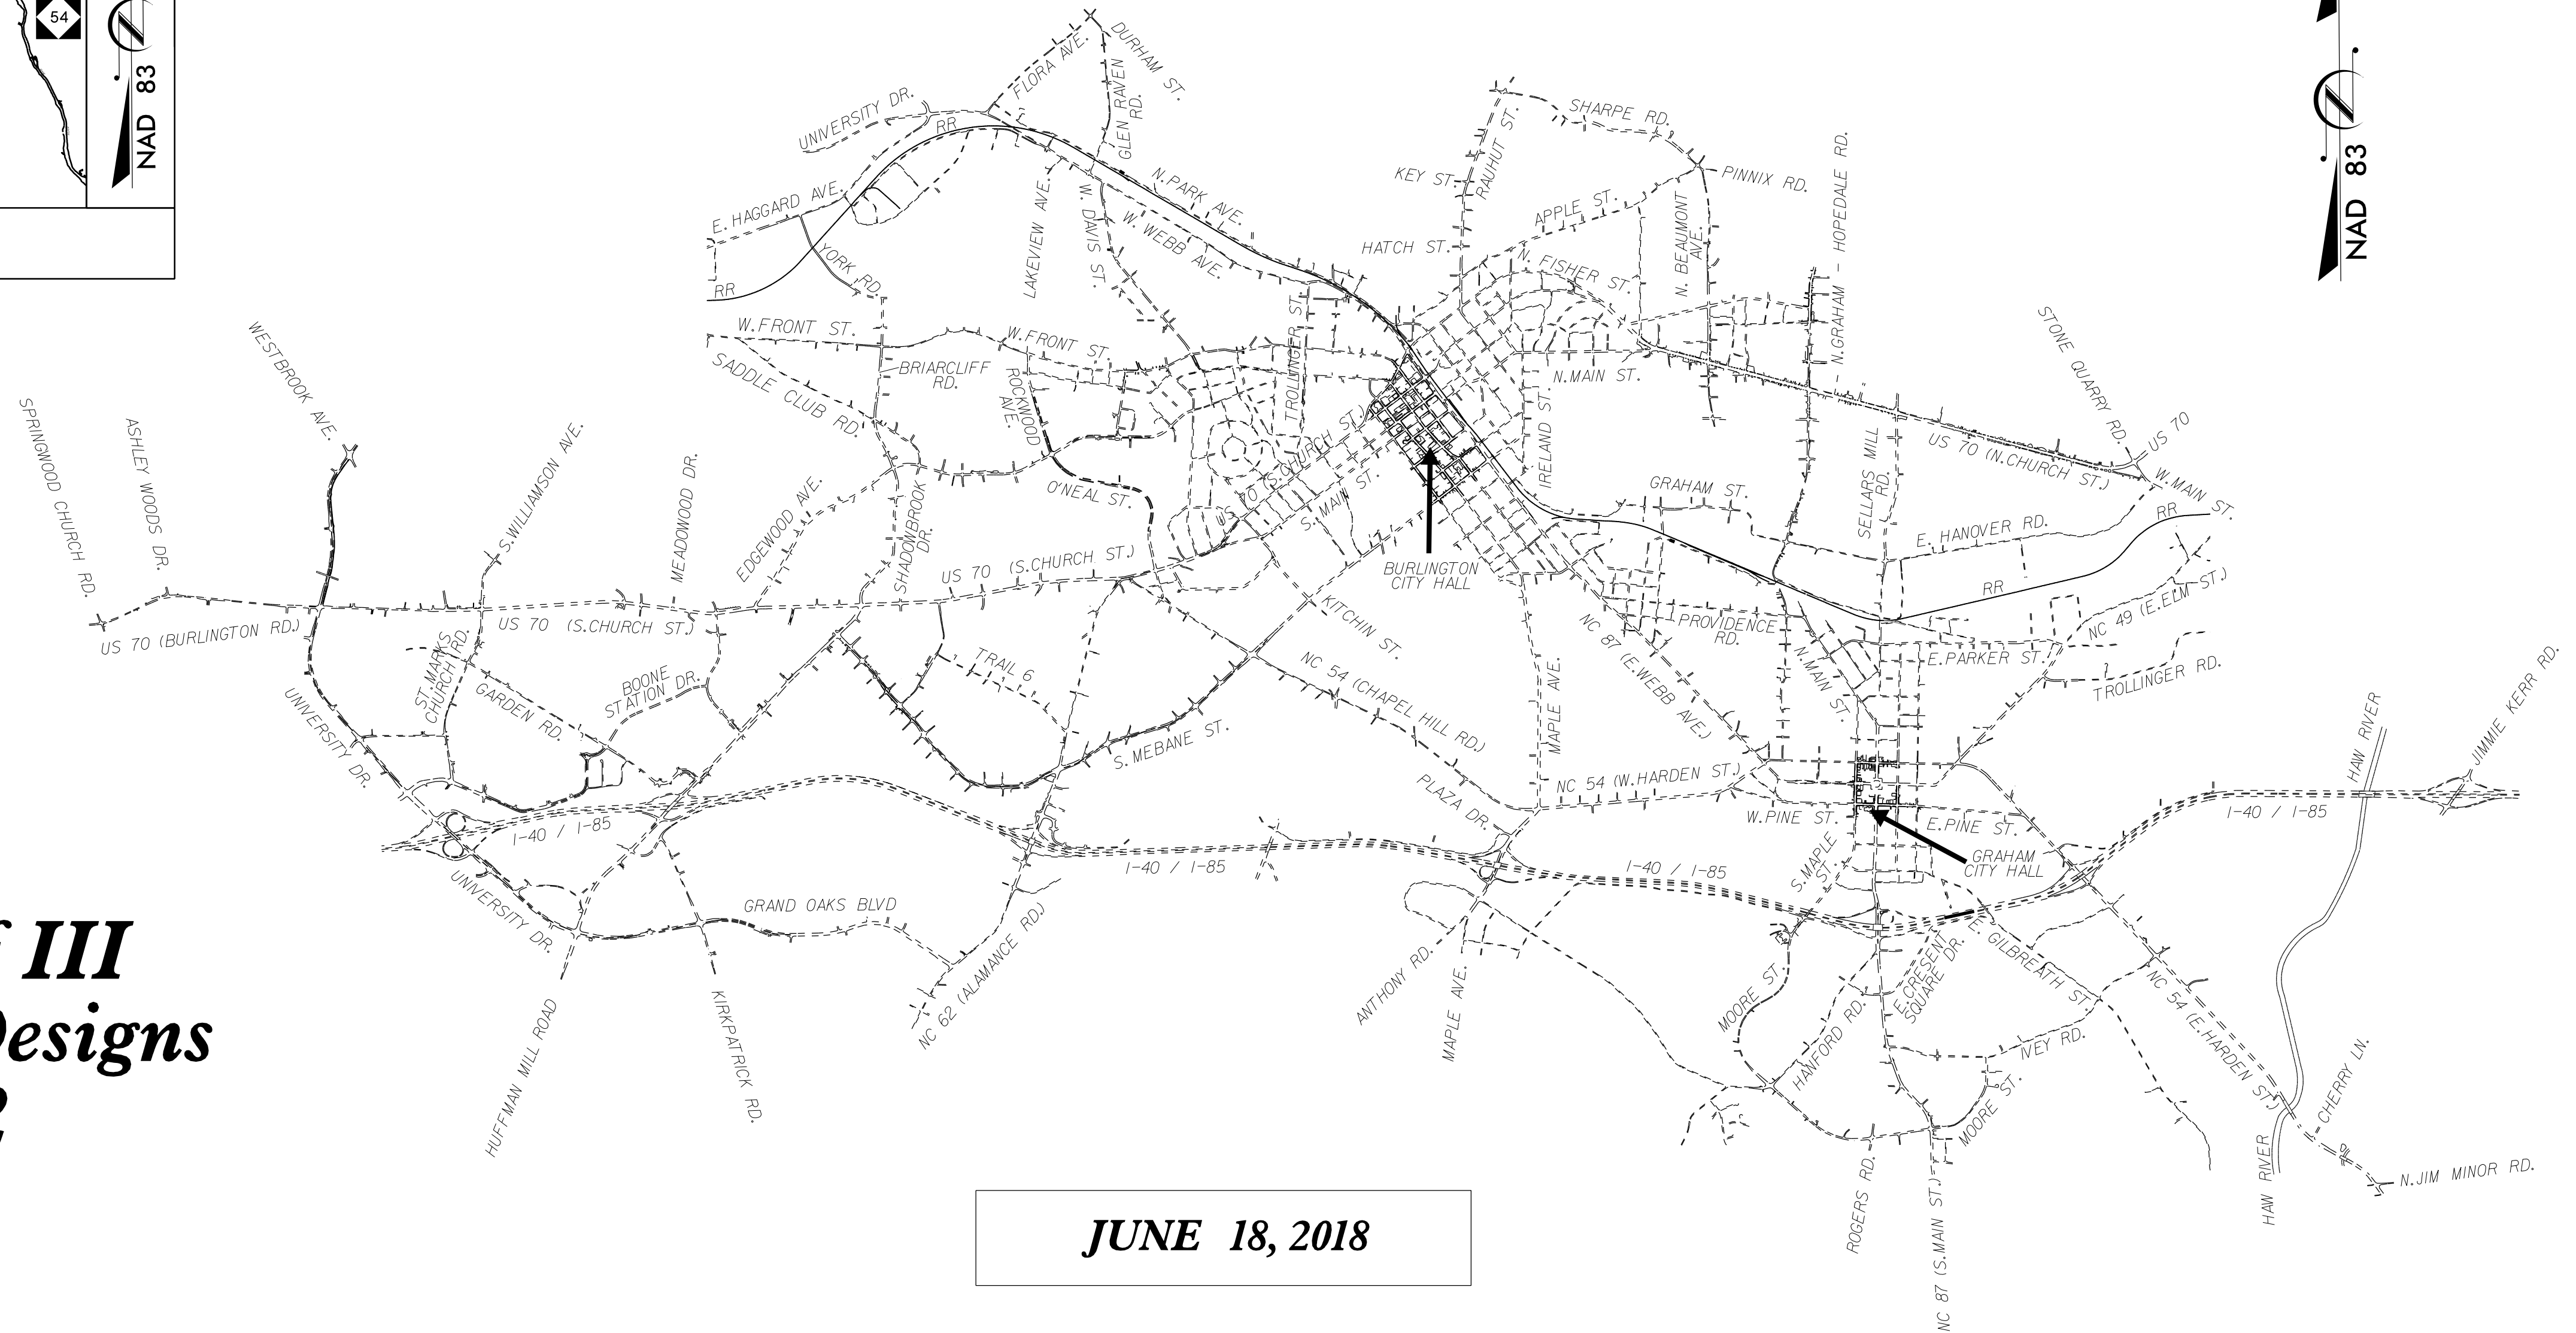


**Volume III of III
Traffic Signal Designs
Part 2 of 2**

JUNE 18, 2018


2018 STANDARD SPECIFICATIONS
LETTING DATE: SEPTEMBER 18, 2018
PROJECT LENGTH = 55 MILES



750 Greenfield Parkway, Garner, NC 27529
NCDOT CONTACTS:
TRANSPORTATION MOBILITY & SAFETY DIVISION
INTELLIGENT TRANSPORTATION SYSTEMS SECTION
SHERRY YOW - METRO SYSTEMS PROJECT ENGINEER
WILLIAM B. HAIRSTON, III - PROJECT DESIGN ENGINEER
CYNTHIA MULDROW - DESIGN ENGINEER




1616 EAST MILLBROOK ROAD, SUITE 160
RALEIGH, NORTH CAROLINA 27609
(919) 876-6888 NCBEEES #F-0326




MELISSA B. TOTH, PE - ATKINS PROJECT MANAGER
PAMELA L. ALEXANDER, PE - ATKINS SENIOR PROJECT ENGINEER
ANTHONY M. ENCARNACION, PE - ATKINS PROJECT ENGINEER

SEAL



DocuSigned by:
Melissa B. Toth 6/18/2018
SIGNATURE DATE


DEFAULT PHASING DIAGRAM

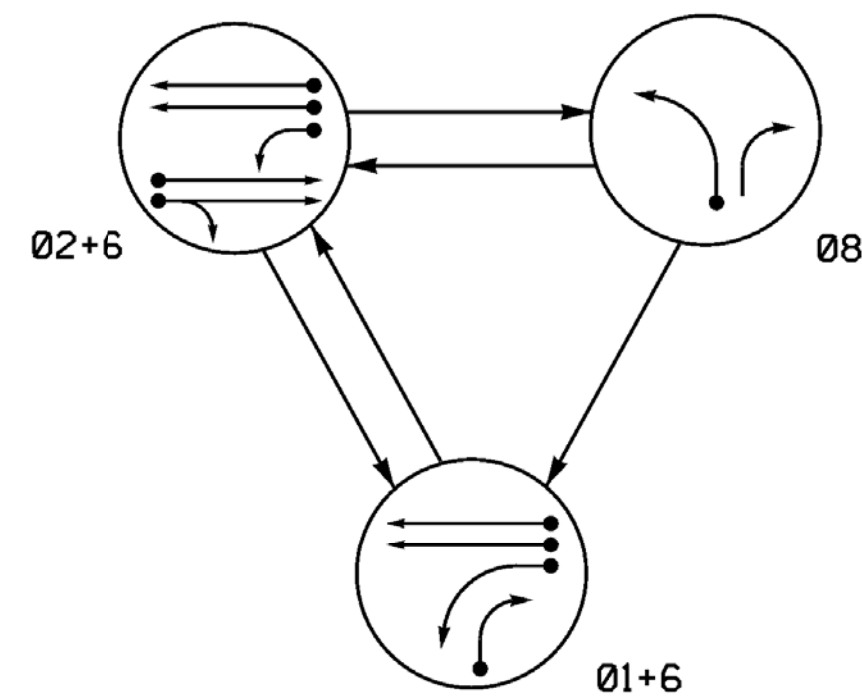

DEFAULT TABLE OF OPERATION

SIGNAL FACE	PHASE			
	01+6	02+6	08	FLASH
11	Y	R	R	Y
21, 22	R	G	R	Y
61, 62	G	G	R	Y
81	R	R	G	R
82	R	R	G	R

ALTERNATE PHASING DIAGRAM

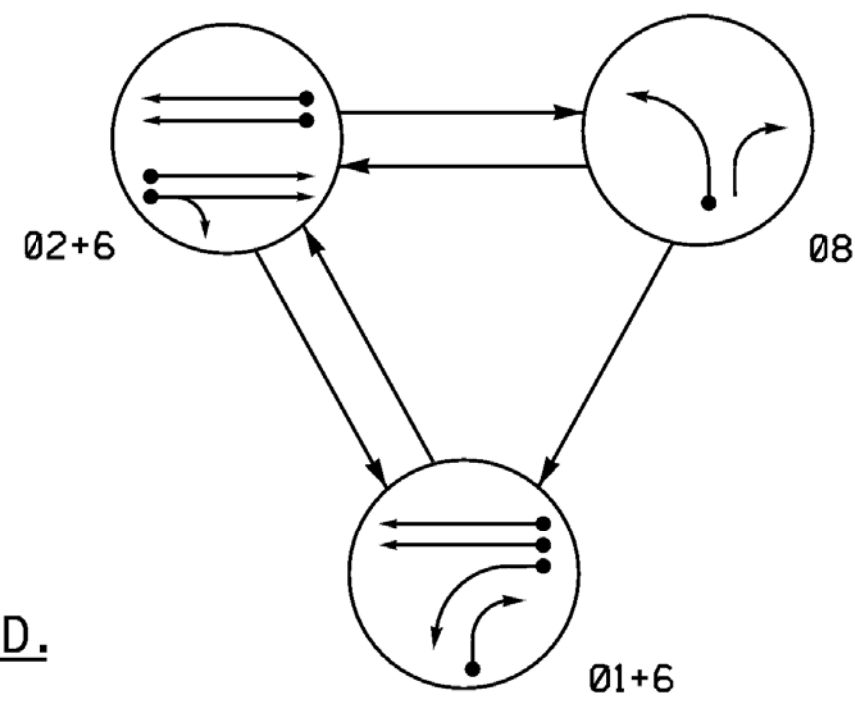

ALTERNATE TABLE OF OPERATION

SIGNAL FACE	PHASE			
	01+6	02+6	08	FLASH
11	Y	R	R	Y
21, 22	R	G	R	Y
61, 62	G	G	R	Y
81	R	R	G	R
82	R	R	G	R

ASC/3 DETECTOR INSTALLATION CHART


LOOP	SIZE (FT)	DISTANCE FROM STOPBAR (FT)	TURNS	NEW LOOP	PROGRAMMING							
					PHASE	CALLING	EXTEND TIME	DELAY TIME	USE ADDED INITIAL	TYPE	SYSTEM LOOP	NEW CARD
1A	6x60	0	2-4-2	-	1	Yes	-	15*	-	S	-	X
1B	6x60	0	2-4-2	-	1	Yes	-	15	-	S	-	X
2A,2B	6x6	90	4	-	2	Yes	-	-	-	S	-	X
6A,6B	6x6	90	4	-	6	Yes	-	-	-	S	-	X
8A	6x60	0	2-4-2	-	8	Yes	-	3	-	S	-	X

3 Phase Fully Actuated (Burlington-Graham Signal System)

NOTES



1. Refer to "Roadway Standard Drawings NCDOT" dated January 2018 and "Standard Specifications for Roads and Structures" dated January 2018.
2. Do not program signal for late night flashing operation unless otherwise directed by the Engineer.
3. Phase 1 may be lagged.
4. Reposition existing signal heads numbered 41, 61, and 62.
5. Set all detector units to presence mode.
6. In the event of loop replacement, refer to the current ITS and Signals Design Manual and submit a Plan of Record to the Signal Design Section.
7. Locate new cabinet so as not to obstruct sight distance of vehicles turning right on red.
8. Pavement markings are existing.
9. The City Traffic Engineer will determine the hours of use for each phasing plan.
10. Maximum times shown in timing chart are for free-run operation only. Coordinated signal system timing values supersede these values.

PHASING DIAGRAM DETECTION LEGEND

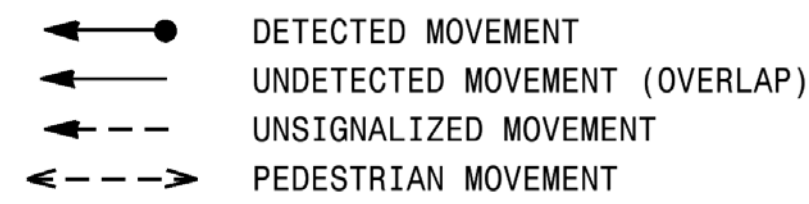

SIGNAL FACE I.D.

All Heads L.E.D.

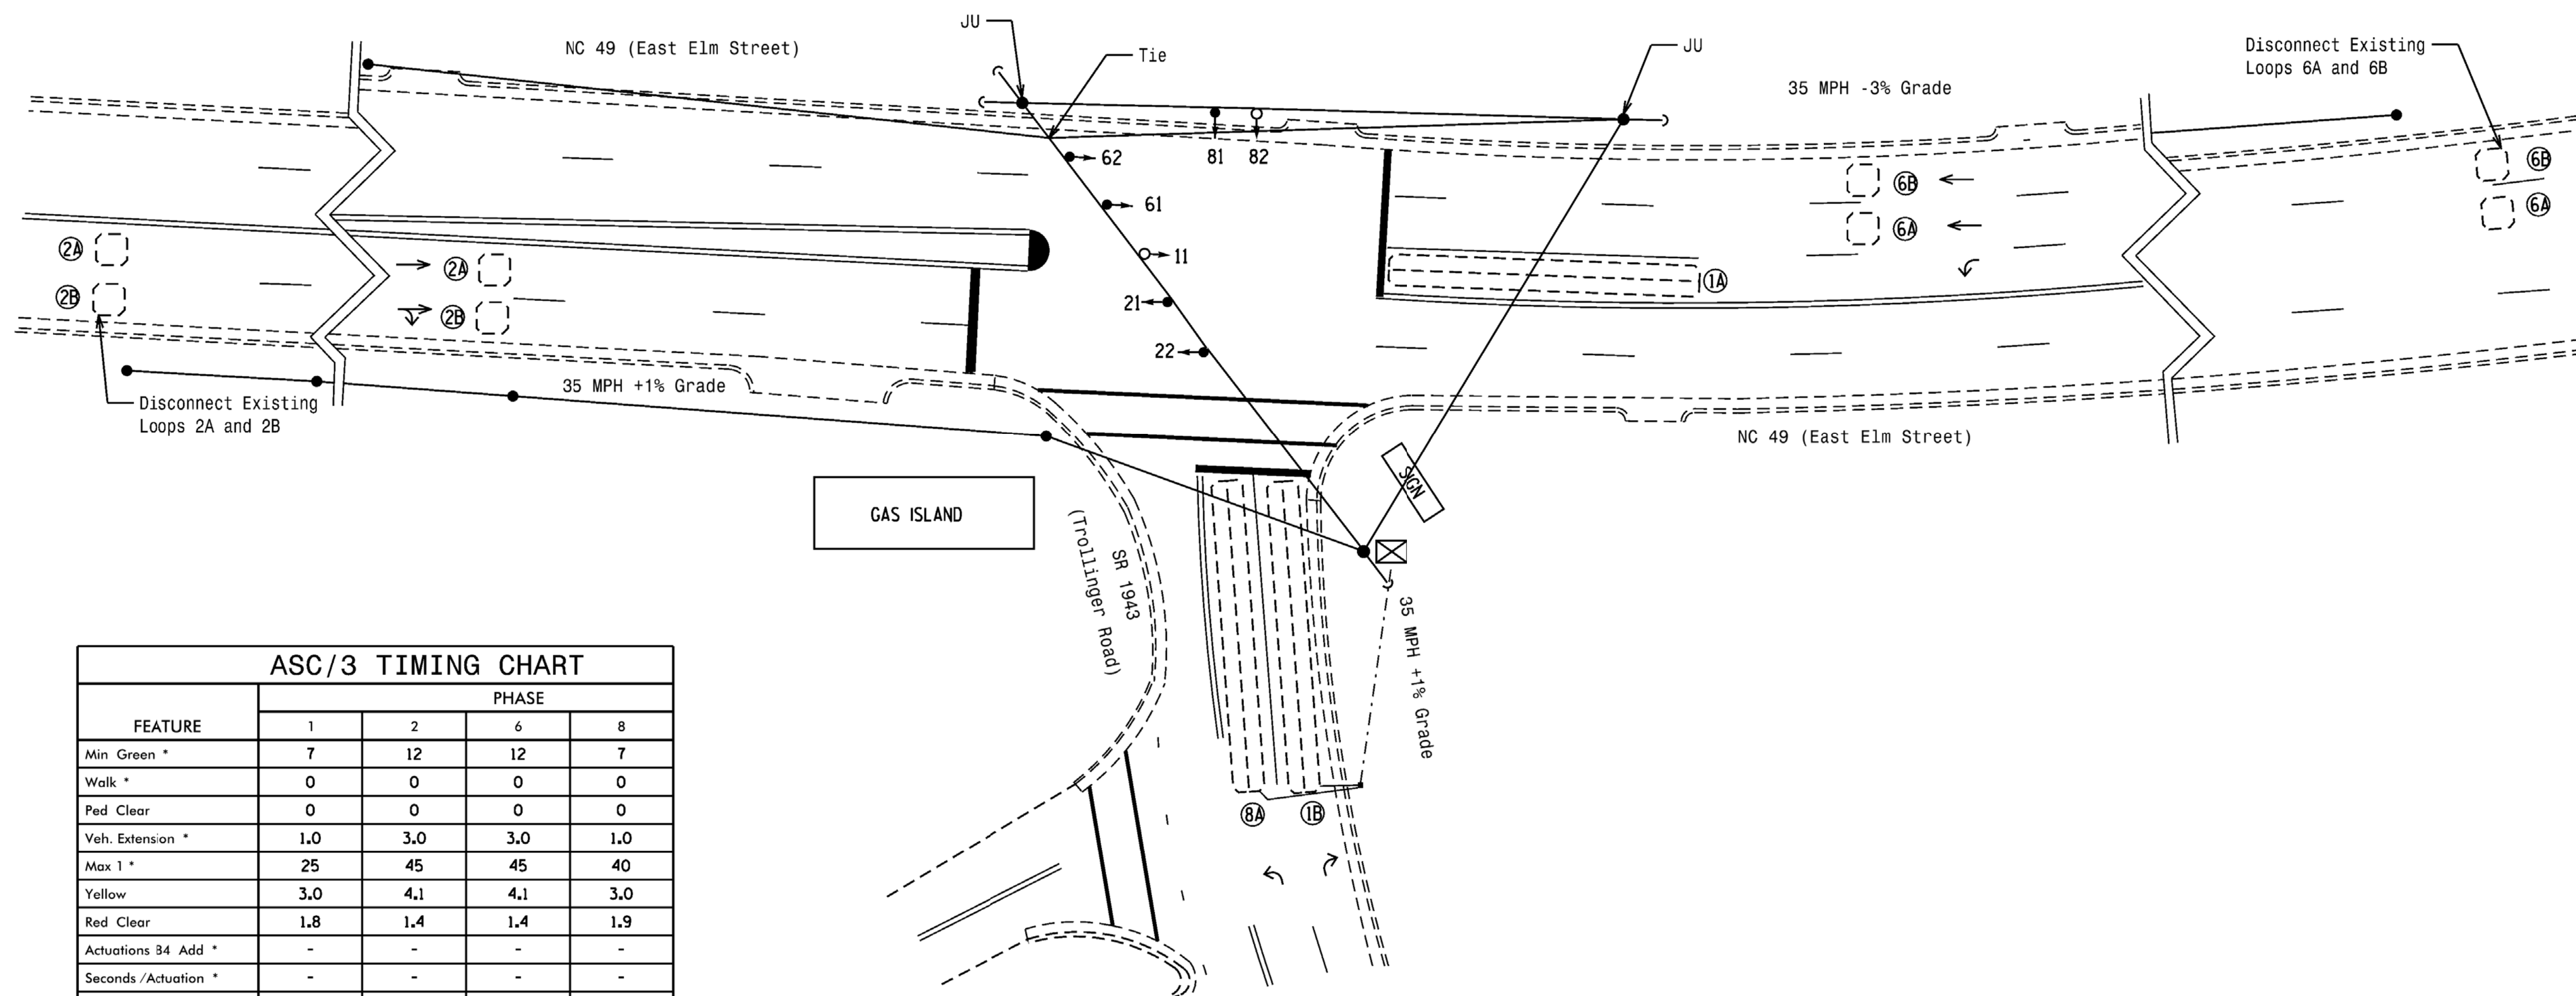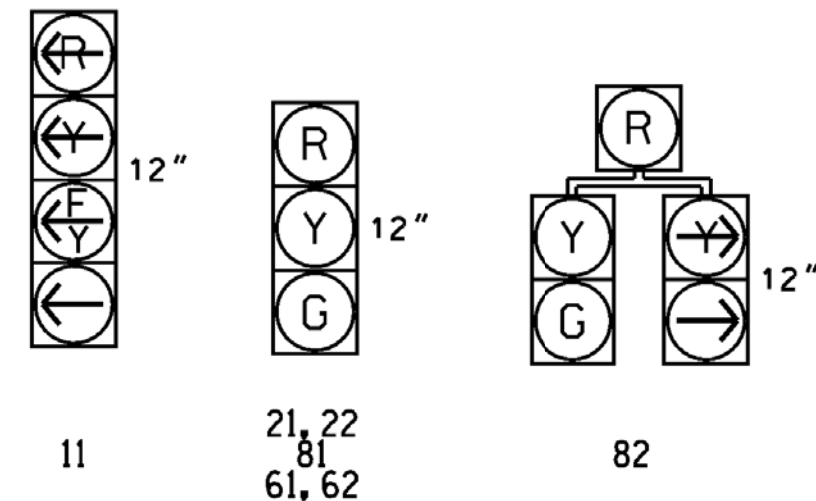


ASC/3 TIMING CHART

FEATURE	PHASE			
	1	2	6	8
Min Green *	7	12	12	7
Walk *	0	0	0	0
Ped Clear	0	0	0	0
Veh. Extension *	1.0	3.0	3.0	1.0
Max 1 *	25	45	45	40
Yellow	3.0	4.1	4.1	3.0
Red Clear	1.8	1.4	1.4	1.9
Actuations 34 Add *	-	-	-	-
Seconds /Actuation *	-	-	-	-
Max Initial *	-	-	-	-
Time Before Reduction *	-	-	-	-
Time To Reduce *	-	-	-	-
Minimum Gap	-	-	-	-
Locking Detector	-	X	X	-
Recall Position	-	VEH. RECALL	VEH. RECALL	-
Dual Entry	-	-	-	-
Simultaneous Gap	X	X	X	X

* These values may be field adjusted. Do not adjust Min Green and Extension times for phases 2 and 6 lower than what is shown. Min Green for all other phases should not be lower than 4 seconds.

LEGEND

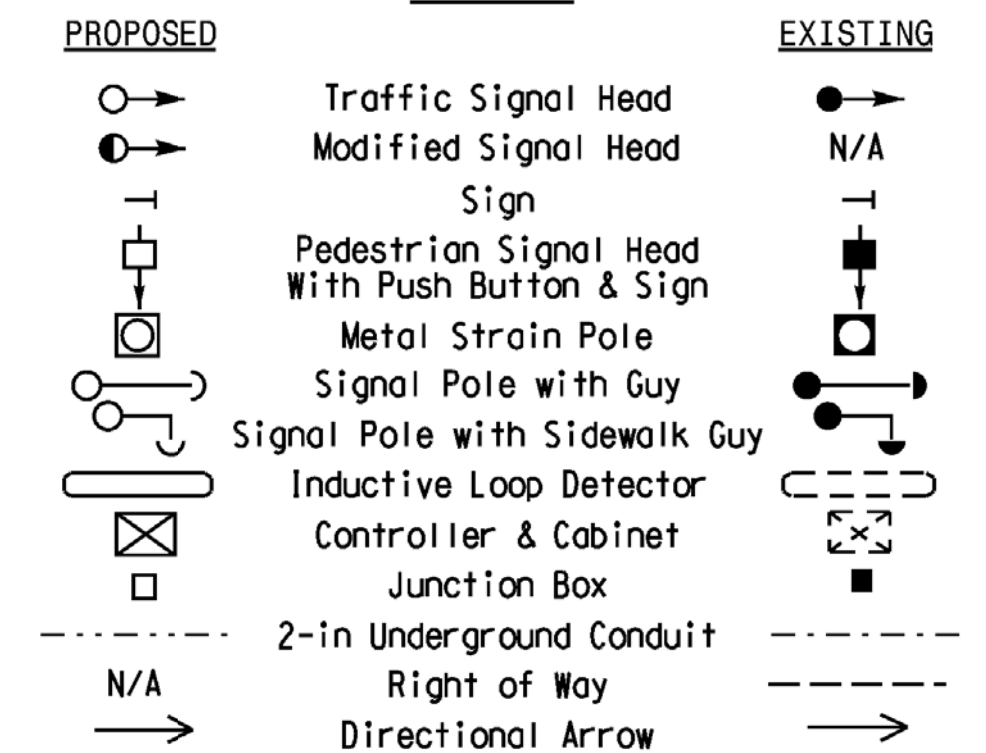

*****SYTIME*****
*****BUSERNAME*****



12 BROAD STREET
ASHEVILLE, NORTH CAROLINA 28801
(828) 254-2201
FAX (828) 254-4562
NC LIC. NO. C-1154

Signal Upgrade

Prepared for the Offices of:

 750 N. Greenfield Pkwy, Garner, NC 27529
 SCALE 1"=40'

DOCUMENT NOT CONSIDERED FINAL UNLESS ALL SIGNATURES COMPLETED

NC 49 (East Elm Street) at SR 1943 (Trollinger Road)

Division 7 Alamance County Graham

PLAN DATE: March 2018 REVIEWED BY: JB Voso

PREPARED BY: SE Greene REVIEWED BY:

REVISIONS



INIT. DATE

James B. Voso
 ENGINEER
 SEAL 022599
 6/13/2018
 DATE

SIG. INVENTORY NO. 07-1056

EDI MODEL 2018ECLip-NC CONFLICT MONITOR PROGRAMMING DETAIL

(remove jumpers and set switches as shown)

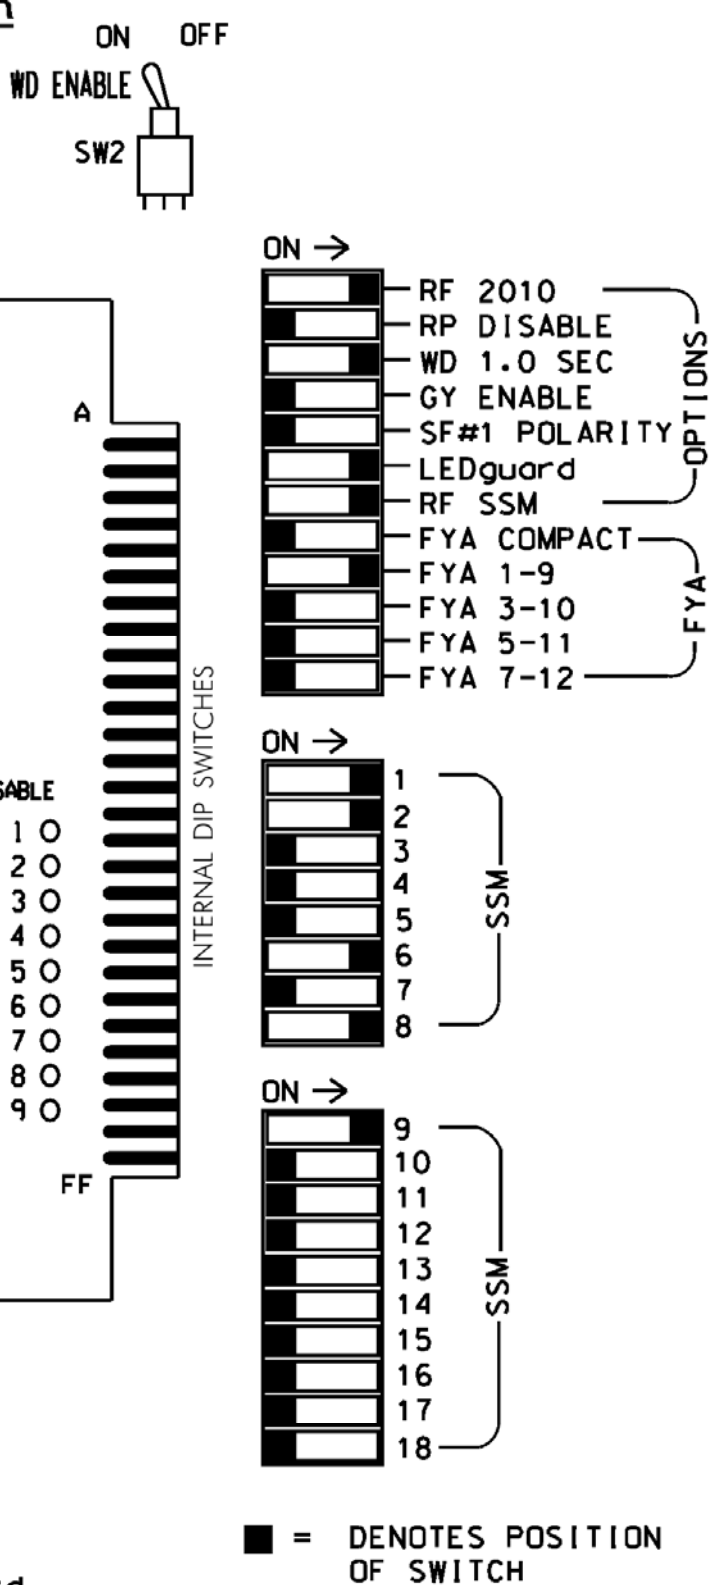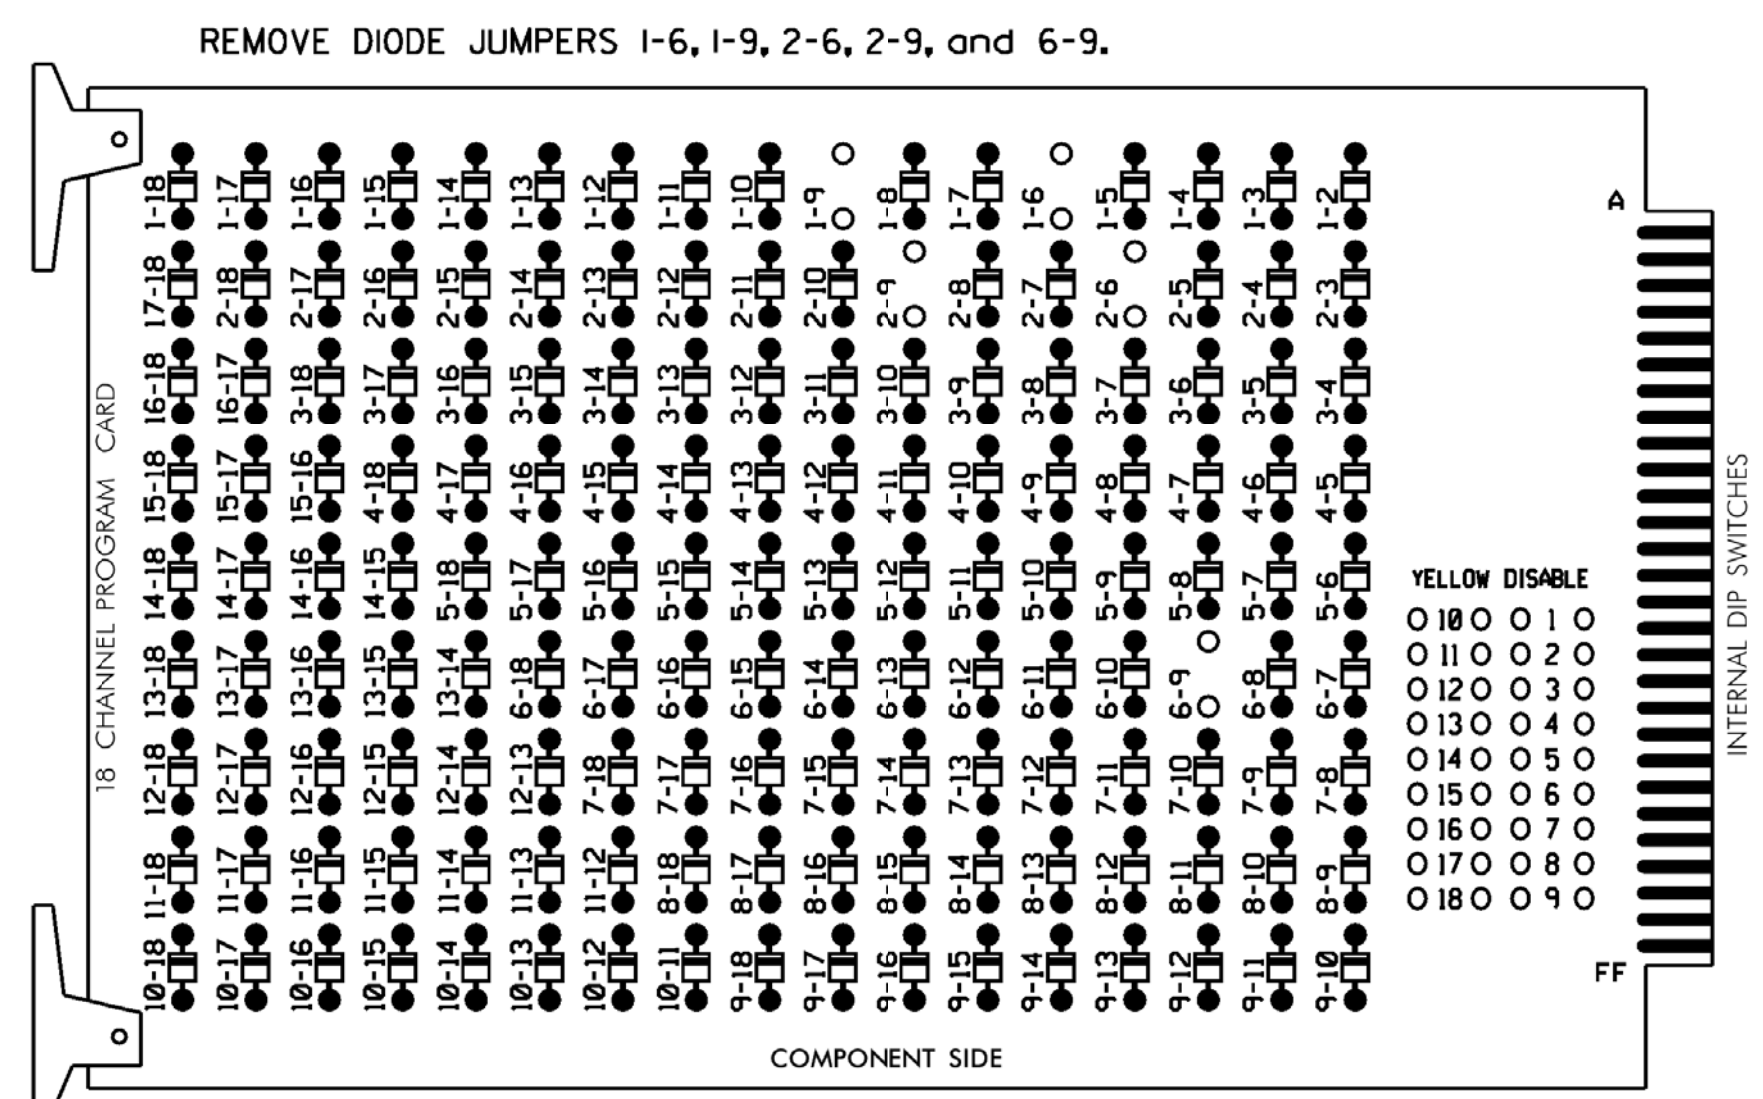

- NOTES:**
- Card is provided with all diode jumpers in place. Removal of any jumper allows its channels to run concurrently.
 - Ensure jumpers SEL2-SEL5 and SEL9 are present on the monitor board.
 - Ensure that Red Enable is active at all times during normal operation.
 - Integrate monitor with Ethernet network in cabinet.

NOTES

- To prevent "flash-conflict" problems, insert red flash program blocks for all unused vehicle load switches in the output file. The installer shall verify that signal heads flash in accordance with the Signal Plans.
- Program controller to start up in phase 2 Green and 6 Green.
- The cabinet and controller are part of the Burlington-Graham Signal System.

EQUIPMENT INFORMATION

CONTROLLER.....2070LX
 CABINET.....332 W/AUX
 SOFTWARE.....ECONOLITE ASC/3-2070
 CABINET MOUNT.....BASE
 OUTPUT FILE POSITIONS...18 WITH AUX. OUTPUT FILE
 LOAD SWITCHES USED.....S1,S2,S8,S11,AUX S1
 PHASES USED.....1,2,6,8
 OVERLAP "A".....*
 OVERLAP "B".....NOT USED
 OVERLAP "C".....NOT USED
 OVERLAP "D".....NOT USED

* See overlap programming detail on sheet 2


SIGNAL HEAD HOOK-UP CHART

LOAD SWITCH NO.	S1	S2	S3	S4	S5	S6	S7	S8	S9	S10	S11	S12	AUX S1	AUX S2	AUX S3	AUX S4	AUX S5	AUX S6
CNU CHANNEL NO.	1	2	13	3	4	14	5	6	15	7	8	16	9	10	17	11	12	18
PHASE	1	2	2 PED	3	4	4 PED	5	6	6 PED	7	8	8 PED	OLA	OLB	SPARE	OLC	OLD	SPARE
SIGNAL HEAD NO.	11	82	21,22	NU	NU	NU	NU	61,62	NU	NU	81,82	NU	11	NU	NU	NU	NU	NU
RED	*	128						134			107							
YELLOW		129						135			108							
GREEN		130						136			109							
RED ARROW													A121					
YELLOW ARROW		126											A122					
FLASHING YELLOW ARROW													A123					
GREEN ARROW	127	127																

NU = Not Used
 * Denotes install load resistor. See load resistor installation detail this sheet.
 * See pictorial of head wiring in detail this sheet.

INPUT FILE POSITION LAYOUT

(front view)

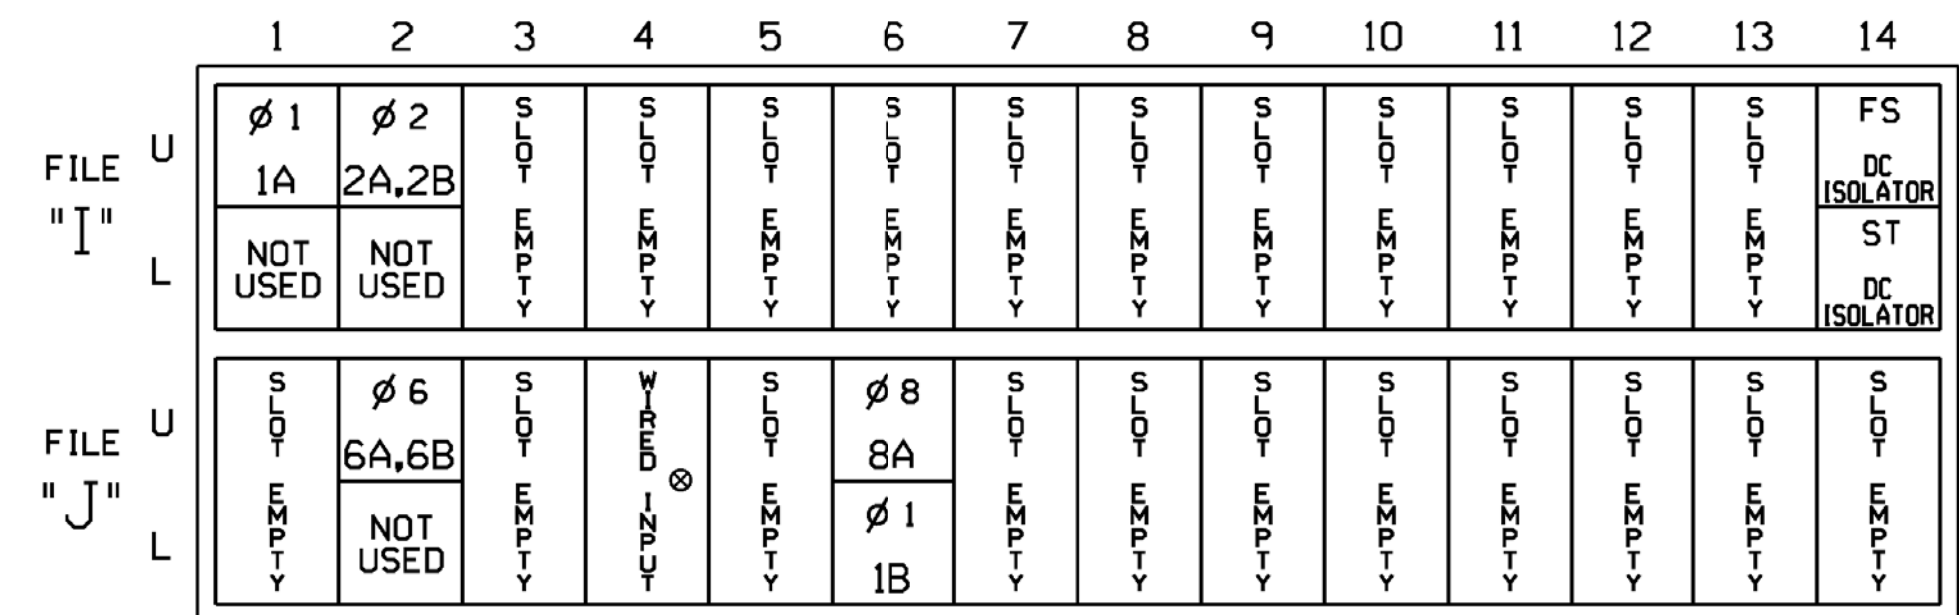

EX.: 1A, 2A, ETC. = LOOP NO.'S
 FS = FLASH SENSE
 ST = STOP TIME


⊗ Wired Input - Do not populate slot with detector cord

INPUT FILE CONNECTION & PROGRAMMING CHART

LOOP NO.	LOOP TERMINAL	INPUT FILE POS.	PIN NO.	DETECTOR NO.	NEMA PHASE	CALL	EXTEND TIME	DELAY TIME	ADDED INITIAL	DETECTOR TYPE
1A ¹	TB2-1,2	I1U	56	1	1	YES		15		S
	-	J4U	48	26	6	YES				S
2A,2B	TB2-5,6	I2U	39	2	2	YES				S
6A,6B	TB3-5,6	J2U	40	6	6	YES				S
8A	TB5-9,10	J6U	42	8	8	YES		3		S
1B	TB5-11,12	J6L	46	18	1	YES		15		S


- ¹Add jumper from I1-W to J4-W, on rear of input file.
 * For the detectors to work as shown on the signal design plan, see the Vehicle Detector Setup Programming Detail for Alternate Phasing on sheet 3.

INPUT FILE POSITION LEGEND:

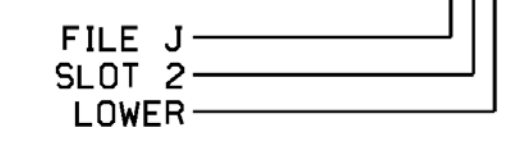

FYA SIGNAL WIRING DETAIL

(wire signal head as shown)

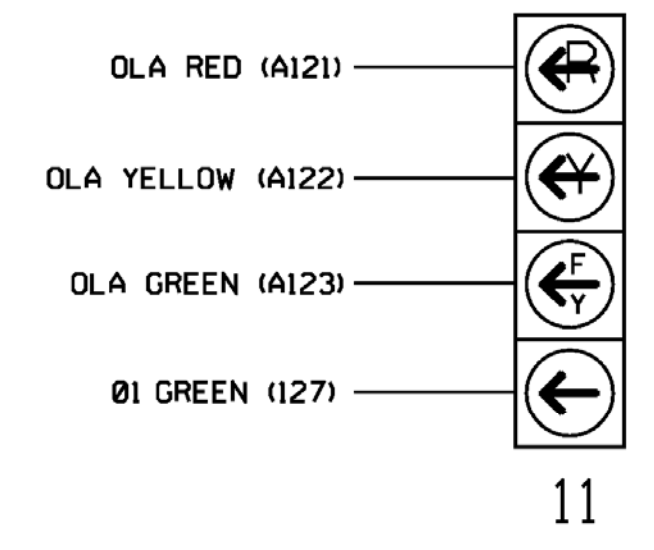


LOAD RESISTOR INSTALLATION DETAIL

(install resistor as shown)

ACCEPTABLE VALUES

VALUE (ohms)	WATTAGE
1.5K - 1.9K	25W (min)
2.0K - 3.0K	10W (min)

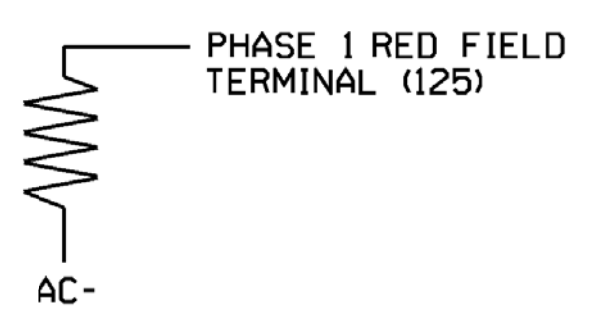

Electrical Detail - Sheet 1 of 4

Mattern & Craig
 ENGINEERS • SURVEYORS

12 BROAD STREET
 ASHEVILLE, NORTH CAROLINA 28801
 (828) 254-2201
 FAX (828) 254-4562
 NC LIC. NO. C-1154

THIS ELECTRICAL DETAIL IS FOR THE SIGNAL DESIGN: 07-1056
 DESIGNED: March 2018
 SEALED: 6/13/2018
 REVISED: NA

Electrical and Programming Details For:
 NC 49 (East Elm Street) at SR 1943 (Trollinger Road)

Division 7 Alamance County Graham
 PLAN DATE: March 2018 REVIEWED BY: JB Voso
 PREPARED BY: SE Greene REVIEWED BY:

REVISIONS: INIT. DATE

James Voso
 PROFESSIONAL ENGINEER
 SEAL 022599
 DATE 6/13/2018

DOCUMENT NOT CONSIDERED FINAL UNLESS ALL SIGNATURES COMPLETED

SIG. INVENTORY NO. 07-1056

*****SYTIME*****
 *****D*****
 *****USER*****

ECONOLITE ASC/3-2070 OVERLAP PROGRAMMING DETAIL

(program controller as shown)

1. From Main Menu select 2. CONTROLLER
2. From CONTROLLER Submenu select 2. VEHICLE OVERLAPS

OVERLAP A

Select TMG VEH OVLP [A] and 'PPLT FYA'

```

TMG VEH OVLP...[A] TYPE: ....PPLT FYA
PROTECTED LEFT TURN... PHASE 1
OPPOSING THROUGH..... PHASE 2

FLASHING ARROW OUTPUT....CH9 ISOLATE
DELAY START OF: FYA..0.0 CLEARANCE..0.0
ACTION PLAN SF BIT DISABLE..... 1
```


← NOTICE ACTION
PLAN SF BIT "1"

END PROGRAMMING

THIS ELECTRICAL DETAIL IS FOR
 THE SIGNAL DESIGN: 07-1056
 DESIGNED: March 2018
 SEALED: 6/13/2018
 REVISED: NA


Electrical Detail - Sheet 2 of 4

DOCUMENT NOT CONSIDERED
FINAL UNLESS ALL
SIGNATURES COMPLETED

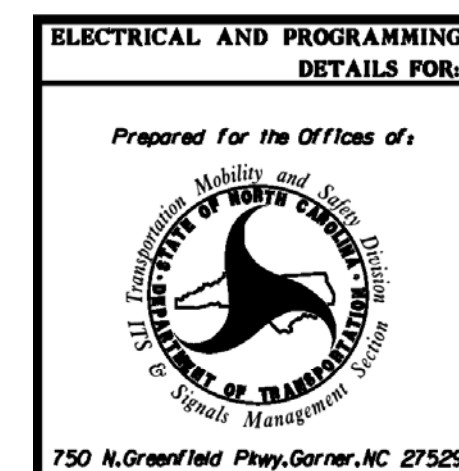

**NC 49 (East Elm Street)
at
SR 1943 (Trollinger Road)**

Division 7		Alamance County		Graham
PLAN DATE:	March 2018	REVIEWED BY:	JB Voso	
PREPARED BY:	SE Greene	REVIEWED BY:		
REVISIONS	INIT.	DATE		

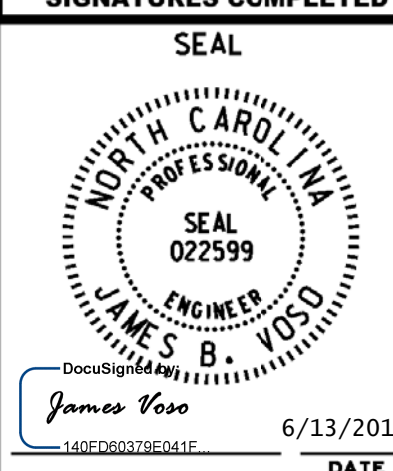

***** SYSTEM *****
 ***** USER NAME *****

ECONOLITE ASC/3-2070 VEHICLE DETECTOR SETUP PROGRAMMING DETAIL FOR ALTERNATE PHASING

LOOP 1A

(program controller as shown)

IMPORTANT!

Program detectors per the input file connection and programming chart shown on sheet 1 before proceeding.

1. From Main Menu select **8. UTILITIES**
2. From UTILITIES Submenu select **1. COPY/CLEAR**
3. Copy from DETECTOR PLAN "1" to DETECTOR PLAN "2".

```
COPY / CLEAR UTILITY
FROM            TO
PHASE TIMING.... > PHASE TIMING....
TIMING PLAN..... > TIMING PLAN.....
PH DET OPT PLAN. > PH DET OPT PLAN.
DETECTOR PLAN... 1 > DETECTOR PLAN... 2
TOGGLE TO SELECT A "FROM" AND A "TO"
THEN PRESS ENTER
```

4. From Main Menu select **6. DETECTORS**
5. From DETECTOR Submenu select **2. VEHICLE DETECTOR SETUP**
6. Place cursor in VEH DET PLAN [] position and enter "2".
- Place cursor in VEH DETECTOR [] position and enter "1".
- Set delay time to "0".

```
VEH DETECTOR [ 1]   VEH DET PLAN [ 2]
TYPE: S-STANDARD
TS2 DETECTOR..... ECPI LOG.....  NO
DET PH - 1 2 3 4 5 6 7 8 9 0 1 2 3 4 5 6
      1 1 .....
EXTEND TIME... 0.0 DELAY TIME...  0.0
USE ADDED INITIAL . CROSS SWITCH PH.. 0
LOCK IN..... NONE NTCIP VOL . OR OCC .
PMT QUEUE DELAY. NO
```

← NOTICE VEH DET PLAN 2

← ENSURE DELAY IS SET TO '0'

- ↓
- Place cursor in VEH DETECTOR [] position and enter "26".
 - Set assigned phase to "0".

```
VEH DETECTOR [26]  VEH DET PLAN [ 2]
TYPE: S-STANDARD
TS2 DETECTOR..... ECPI LOG.....  NO
DET PH - 1 2 3 4 5 6 7 8 9 0 1 2 3 4 5 6
      26 0 .....
EXTEND TIME... 0.0 DELAY TIME...  0.0
USE ADDED INITIAL . CROSS SWITCH PH.. 0
LOCK IN..... NONE NTCIP VOL . OR OCC .
PMT QUEUE DELAY. NO
```


← NOTICE VEH DET PLAN 2

→ ENSURE PHASE IS SET TO "0"

END PROGRAMMING


THIS ELECTRICAL DETAIL IS FOR THE SIGNAL DESIGN: 07-1056
DESIGNED: March 2018
SEALED: 6/13/2018
REVISED: NA

 **Mattern & Craig**
ENGINEERS • SURVEYORS
12 BROAD STREET
ASHEVILLE, NORTH CAROLINA 28801
(828) 254-2201
FAX (828) 254-4562
NC LIC. NO. C-1154

ELECTRICAL AND PROGRAMMING DETAILS FOR:
Prepared for the Offices of:

750 N. Greenfield Pkwy, Garner, NC 27529

NC 49 (East Elm Street) at SR 1943 (Trollinger Road)	
Division 7	Alamance County
PLANNED BY: March 2018	REVIEWED BY: JB Voso
PREPARED BY: SE Greene	REVIEWED BY:
REVISIONS	
INIT.	DATE

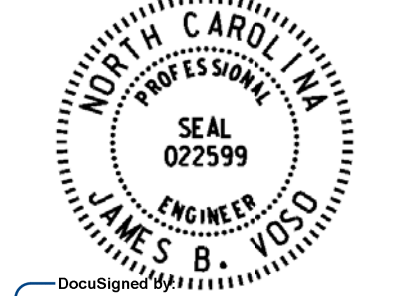DOCUMENT NOT CONSIDERED FINAL UNLESS ALL SIGNATURES COMPLETED

SEAL

SEAL 022599
JAMES B. VOSO
6/13/2018
DATE
SIG. INVENTORY NO. 07-1056

ALTERNATE PHASING ACTIVATION DETAIL

TO RUN ALT. PHASING DURING FREE RUN - PROGRAM CHANGES (SHOWN BELOW) IN A TIME BASED ACTION PLAN. SCHEDULE A DAY PLAN THAT INCLUDES THE ACTION PLAN PROGRAMMED TO SELECT VEH DET PLAN 2 AND ENABLE SF BIT 1.

TO RUN ALT. PHASING DURING COORDINATION - SELECT THE TIME BASED ACTION PLAN THAT IS PROGRAMMED TO SELECT VEH DET PLAN 2 AND ENABLE SF BIT 1.

PHASING	VEH DET PLAN	SF BITS ENABLED
ACTIONS REQUIRED TO RUN <u>DEFAULT PHASING</u>	1	NONE
ACTIONS REQUIRED TO RUN <u>ALTERNATE PHASING</u>	2	1

IMPORTANT: IF ALT. PHASING IS USED DURING FREE RUN AND COORDINATION, DO NOT OPERATE TIME OF DAY EVENTS CONCURRENTLY WITH COORDINATION PLAN EVENTS IN THE EVENT SCHEDULER. (EX. FREE RUN EVENT SHOULD END BEFORE COORDINATION PLAN EVENT STARTS AND VICE-VERSA).

ALTERNATE PHASING CHANGE SUMMARY

THE FOLLOWING IS A SUMMARY OF WHAT TAKES PLACE WHEN SF BIT 1 AND VEH DET PLAN 2 ACTIVATE TO CALL THE "ALTERNATE PHASING":

SF BIT 1: Modifies overlap parent phase for head 11 to run protected turns only.

VEH DET PLAN 2: Disables phase 6 call on loop 1A and reduces delay time for phase 1 call on loop 1A to 0 seconds.

ECONOLITE ASC/3-2070 ACTION PLAN PROGRAMMING DETAIL

1. From Main Menu select 5. TIME BASE
2. From TIME BASE Submenu select 2. ACTION PLAN

```

ACTION PLAN...[ 1]
PATTERN.....AUTO  SYS OVERRIDE.... NO
TIMING PLAN..... 0  SEQUENCE..... 0
VEH DETECTOR PLAN.. 2  DET LOG.....NONE
FLASH..... --  RED REST..... NO
VEH DET DIAG PLN... 0  PED DET DIAG PLN..0
DIMMING ENABLE.. NO  PRIORITY RETURN. NO
PED PR RETURN.. NO  QUEUE DELAY..... NO
PMT COND DELAY  NO
  PHASE  1  2  3  4  5  6  7  8  9  0  1  2  3  4  5  6
PED RCL  .  .  .  .  .  .  .  .  .  .  .  .  .  .  .  .
WALK 2   .  .  .  .  .  .  .  .  .  .  .  .  .  .  .  .
VEX 2    .  .  .  .  .  .  .  .  .  .  .  .  .  .  .  .
VEH RCL  .  .  .  .  .  .  .  .  .  .  .  .  .  .  .  .
MAX RCL  .  .  .  .  .  .  .  .  .  .  .  .  .  .  .  .
MAX 2    .  .  .  .  .  .  .  .  .  .  .  .  .  .  .  .
  PHASE  1  2  3  4  5  6  7  8  9  0  1  2  3  4  5  6
MAX 3    .  .  .  .  .  .  .  .  .  .  .  .  .  .  .  .
CS INH   .  .  .  .  .  .  .  .  .  .  .  .  .  .  .  .
OMIT     .  .  .  .  .  .  .  .  .  .  .  .  .  .  .  .
SPC FCT  X  .  .  .  .  .  .  .  .  .  .  .  .  .  .  .  .
AUX FCT  .  .  .  (1-3)
  1  2  3  4  5  6  7  8  9  0  1  2  3  4  5
LP 1-15  .  .  .  .  .  .  .  .  .  .  .  .  .  .  .  .
LP 16-30 .  .  .  .  .  .  .  .  .  .  .  .  .  .  .  .
LP 31-45 .  .  .  .  .  .  .  .  .  .  .  .  .  .  .  .
LP 46-60 .  .  .  .  .  .  .  .  .  .  .  .  .  .  .  .
LP 61-75 .  .  .  .  .  .  .  .  .  .  .  .  .  .  .  .
LP 76-90 .  .  .  .  .  .  .  .  .  .  .  .  .  .  .  .
LP 91-100.  .  .  .  .  .  .  .  .  .  .  .  .  .  .  .
    
```

Mattern & Craig
ENGINEERS • SURVEYORS

12 BROAD STREET
ASHEVILLE, NORTH CAROLINA 28801
(828) 254-2201
FAX (828) 254-4562
NC LIC. NO. C-1154

THIS ELECTRICAL DETAIL IS FOR
THE SIGNAL DESIGN: 07-1056
DESIGNED: March 2018
SEALED: 6/13/2018
REVISED: NA


Electrical Detail - Sheet 4 of 4

<p style="font-size: x-small;">ELECTRICAL AND PROGRAMMING DETAILS FOR:</p> <p style="font-size: x-small;">Prepared for the Offices of: 1750 N. Greenfield Pkwy, Garner, NC 27529</p>	<p>NC 49 (East Elm Street) at SR 1943 (Trollinger Road)</p> <p style="font-size: x-small;">Division 7 Alamance County Graham</p> <p style="font-size: x-small;">PLAN DATE: March 2018 REVIEWED BY: JB Voso</p> <p style="font-size: x-small;">PREPARED BY: SE Greene REVIEWED BY:</p> <table border="1" style="width: 100%; border-collapse: collapse;"> <thead> <tr> <th style="font-size: x-small;">REVISIONS</th> <th style="font-size: x-small;">INIT.</th> <th style="font-size: x-small;">DATE</th> </tr> </thead> <tbody> <tr><td> </td><td> </td><td> </td></tr> <tr><td> </td><td> </td><td> </td></tr> <tr><td> </td><td> </td><td> </td></tr> </tbody> </table>	REVISIONS	INIT.	DATE										<p style="text-align: center; font-size: x-small;">SEAL</p> <p style="font-size: x-small;">James Voso 6/13/2018 DATE</p> <p style="font-size: x-small;">SIG. INVENTORY NO. 07-1056</p>
REVISIONS	INIT.	DATE												

DOCUMENT NOT CONSIDERED
FINAL UNLESS ALL
SIGNATURES COMPLETED


*****SYTIME*****
*****USER*****

DEFAULT PHASING DIAGRAM

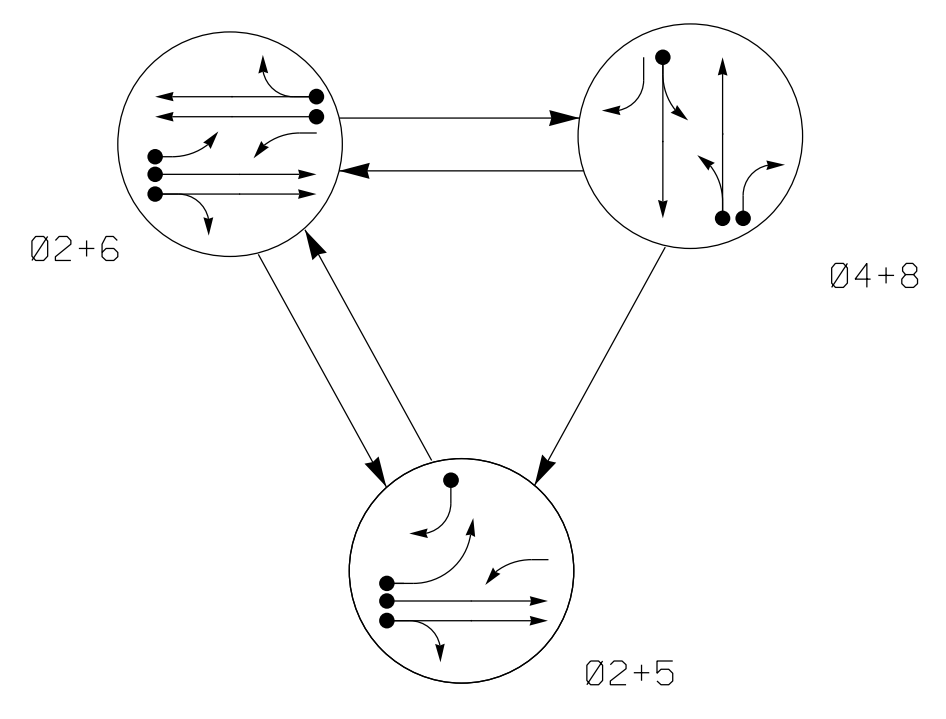

SIGNAL FACE	PHASE			
	02+5	02+6	04+8	02+5
21,22	G	G	R	Y
41,42	R	R	G	R
51	←	←	←	←
61	←	←	←	←
62,63	R	G	R	Y
81,82	R	R	G	R

ALTERNATE PHASING DIAGRAM

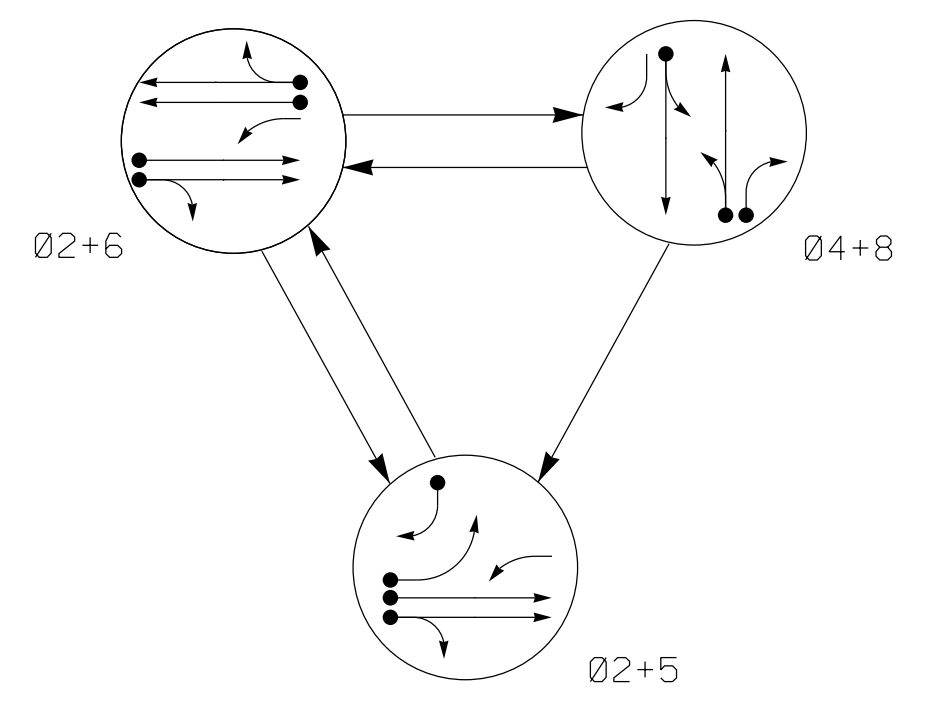

SIGNAL FACE	PHASE			
	02+5	02+6	04+8	02+5
21,22	G	G	R	Y
41,42	R	R	G	R
51	←	←	←	←
61	←	←	←	←
62,63	R	G	R	Y
81,82	R	R	G	R

ASC/3 DETECTOR INSTALLATION CHART												
DETECTOR				PROGRAMMING								
LOOP	SIZE (FT)	DISTANCE FROM STOPBAR (FT)	URNS	NEW LOOP	PHASE	CALLING	EXTEND TIME	DELAY TIME	USE ADDED INITIAL	TYPE	SYSTEM LOOP	NEW CARD
2A,2B	6X6	300	EXIST	-	2	Yes	-	-	X	N	-	X
4A	6X40	+5	2-4-2	-	4	Yes	-	3	-	S	-	X
5A	6X40	0	2-4-2	X	5	Yes	-	*15	-	G	-	X
5B	6X40	0	2-4-2	-	5	Yes	-	15	-	S	-	X
6A,6B	6X6	300	EXIST	-	6	Yes	-	-	X	N	-	X
8A	6X40	0	2-4-2	-	8	Yes	-	3	-	S	-	X
8B	6X40	+5	2-4-2	-	8	Yes	-	15	-	S	-	X

* Disable Delay During Alternate Phasing Operation.
 ** Disable Phase 2 Call For Loop 5A During Alternate Phasing Operation.

3 Phase Fully Actuated (Burlington-Graham Signal System)



NOTES

1. Refer to "Roadway Standard Drawings NCDOT" dated January 2018 and "Standard Specifications for Roads and Structures" dated January 2018.
2. Do not program signal for late night flashing operation unless otherwise directed by the Engineer.
3. Phase 5 may be lagged.
4. Reposition existing signal heads numbered 21, 22, 62 and 63.
5. Set all detector units to presence mode.
6. Locate new cabinet so as not to obstruct sight distance of vehicles turning right on red.
7. Pavement markings are existing.
8. The City Traffic Engineer will determine the hours of use for each phasing plan.
9. Maximum times shown in timing chart are for free-run operation only. Coordinated signal system timing values supersede these values.

PHASING DIAGRAM DETECTION LEGEND

- DETECTED MOVEMENT
- ◄ UNDETECTED MOVEMENT (OVERLAP)
- ◄ UNSIGNALIZED MOVEMENT
- ⇄ PEDESTRIAN MOVEMENT

SIGNAL FACE I.D.

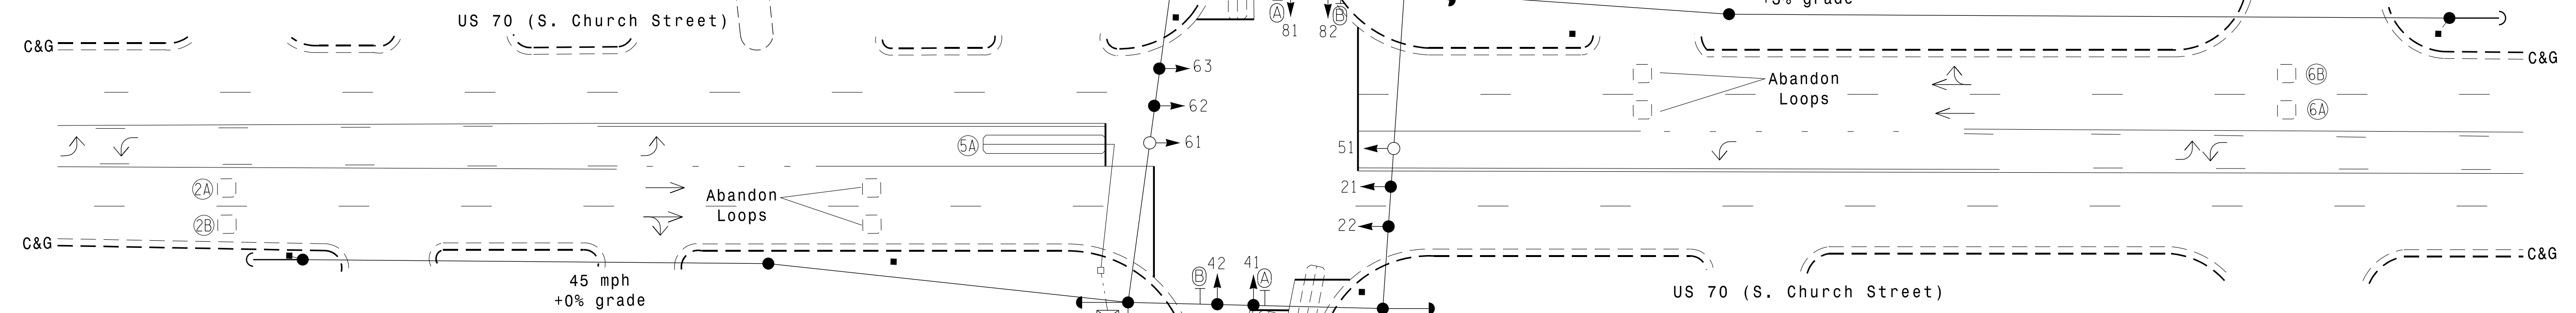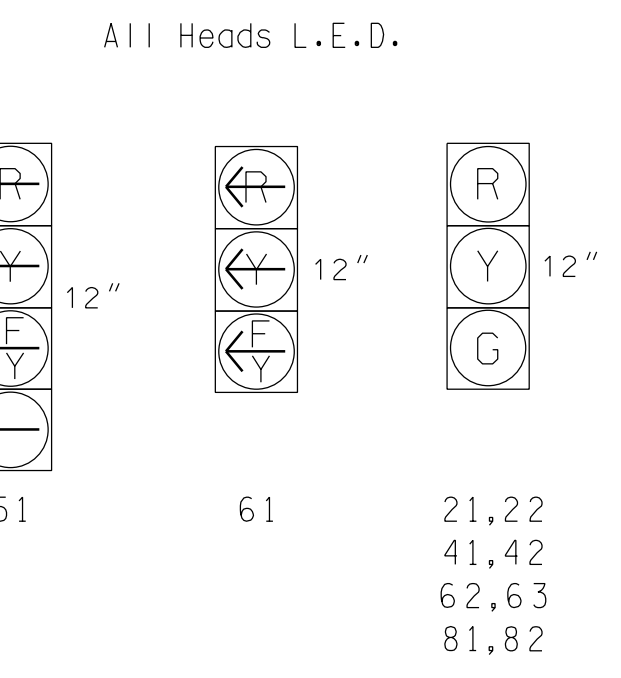

FEATURE	PHASE				
	2	4	5	6	8
Min Green *	12	7	7	12	7
Walk *	0	0	0	0	0
Ped Clear	0	0	0	0	0
Veh. Extension *	6.0	2.0	2.0	6.0	2.0
Max I *	90	20	20	90	20
Yellow	4.5	4.0	3.0	4.5	4.2
Red Clear	1.0	1.5	2.4	1.0	1.5
Actuations B4 Add *	0	-	-	0	-
Seconds / Actuation *	2.0	-	-	2.0	-
Max Initial *	34	-	-	34	-
Time Before Reduction *	15	-	-	15	-
Time To Reduce *	30	-	-	30	-
Minimum Gap	3.0	-	-	3.0	-
Locking Detector	X	-	-	X	-
Recall Position	VEH. RECALL	-	-	VEH. RECALL	-
Dual Entry	-	X	-	-	X
Simultaneous Gap	X	X	X	X	X

* These values may be field adjusted. Do not adjust Min Green and Extension times for phases 2 and 6 lower than what is shown. Min Green for all other phases should not be lower than 4 seconds.

LEGEND

- | PROPOSED | EXISTING |
|--|--|
| ○ → Traffic Signal Head | ● → Traffic Signal Head |
| ○ → Modified Signal Head | N/A |
| ⊥ Sign | ⊥ Sign |
| ⊥ Pedestrian Signal Head With Push Button & Sign | ⊥ Pedestrian Signal Head With Push Button & Sign |
| ○ → Signal Pole with Guy | ○ → Signal Pole with Guy |
| ○ → Signal Pole with Sidewalk Guy | ○ → Signal Pole with Sidewalk Guy |
| ⊠ Inductive Loop Detector | ⊠ Inductive Loop Detector |
| ⊠ Controller & Cabinet | ⊠ Controller & Cabinet |
| ⊠ Junction Box | ⊠ Junction Box |
| --- 2-in Underground Conduit | --- 2-in Underground Conduit |
| N/A Right of Way | --- Right of Way |
| → Directional Arrow | → Directional Arrow |
| (A) Combination Through and Left Arrows Sign (R3-6L) | (A) Combination Through and Left Arrows Sign (R3-6L) |
| (B) Right Arrow "ONLY" Sign (R3-5R) | (B) Right Arrow "ONLY" Sign (R3-5R) |

Signal Upgrade

1616 EAST MILLBROOK ROAD, SUITE 160
RALEIGH, NORTH CAROLINA 27609
(919) 876-6888 NCBEES #F-0326

US 70 (S. Church Street) at Gurney Street

Division 7 Alamance County Burlington

PLAN DATE: January 2018 REVIEWED BY: AM Encarnacion

PREPARED BY: VJ Paul REVIEWED BY: PL Alexander

SCALE 0 30 1"=30'

DOCUMENT NOT CONSIDERED FINAL UNLESS ALL SIGNATURES COMPLETED

SEAL
MORRIS CAROLINA PROFESSIONAL ENGINEER
PAMELA L. ALEXANDER
023489


DATE 6/7/2018

SIG. INVENTORY NO. 07-1062

07-JUN-2018 11:15
 O:\Projects\2018\11115\11115.dwg
 O:\Projects\2018\11115\11115.dwg
 ALEX3361 AT LUS3361

EDI MODEL 2018ECLIP-NC CONFLICT MONITOR PROGRAMMING DETAIL

(remove jumpers and set switches as shown)

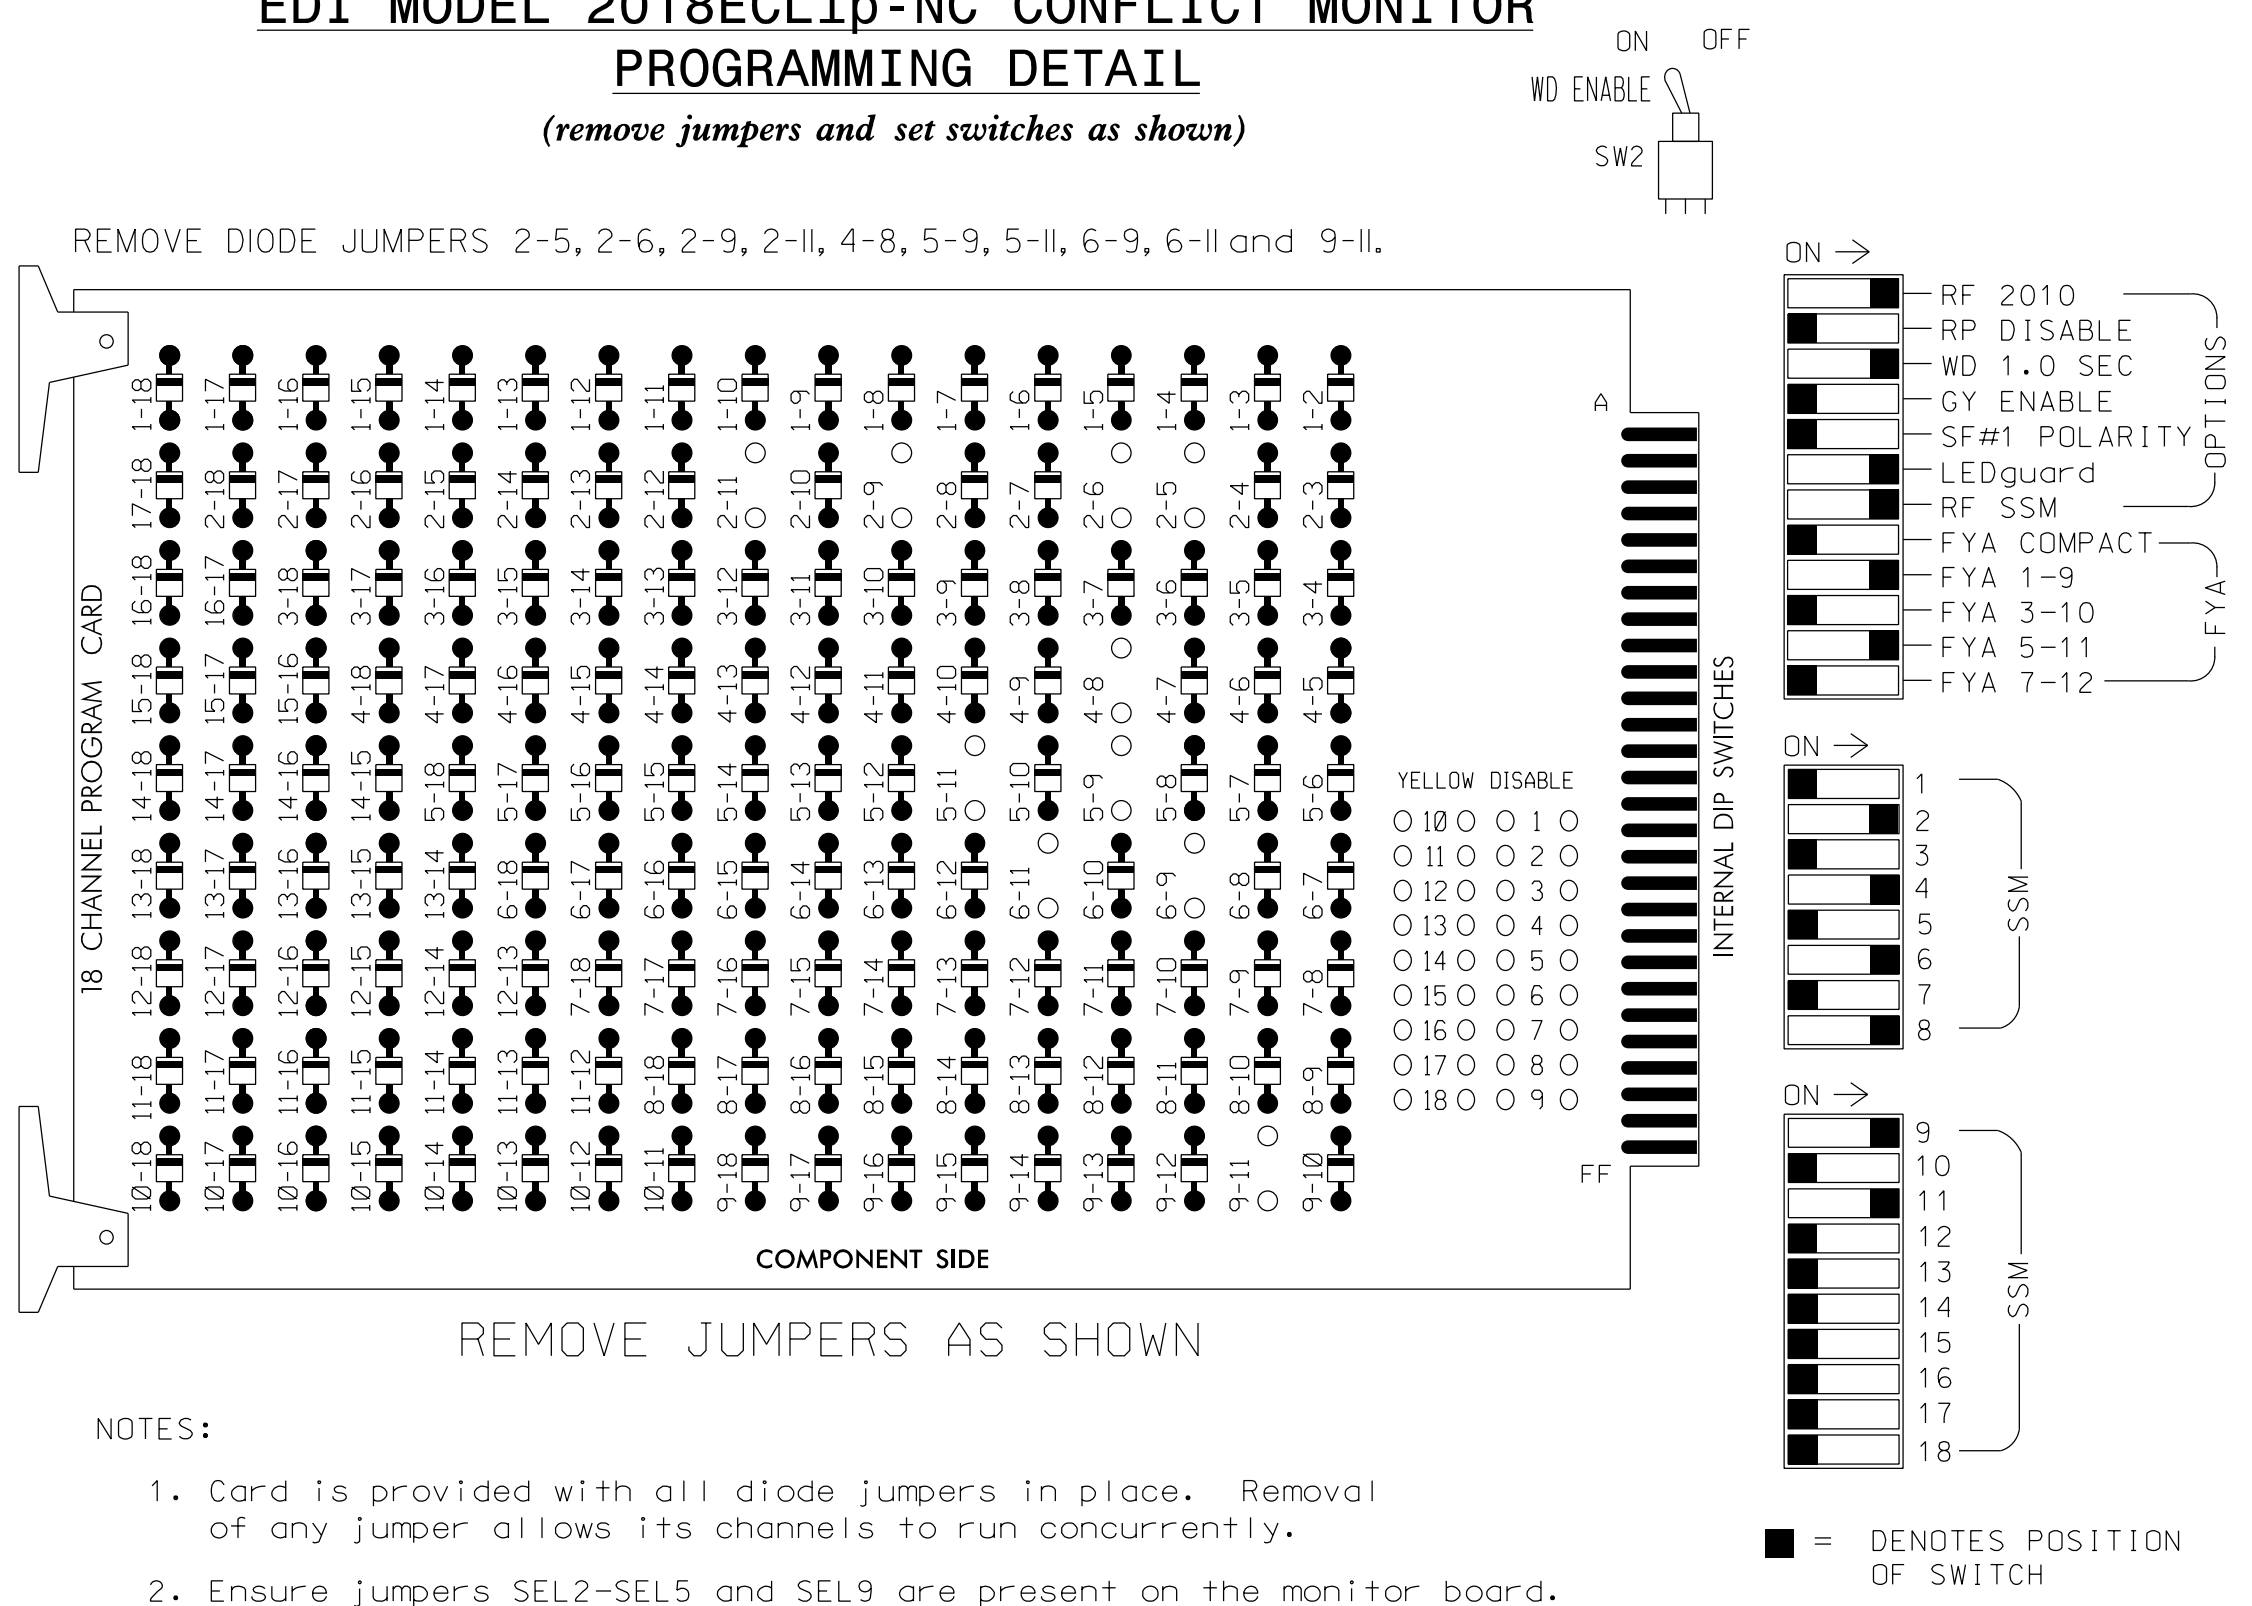

- REMOVE DIODE JUMPERS 2-5, 2-6, 2-9, 2-11, 4-8, 5-9, 5-11, 6-9, 6-11 and 9-11.
- REMOVE JUMPERS AS SHOWN
- NOTES:
- Card is provided with all diode jumpers in place. Removal of any jumper allows its channels to run concurrently.
 - Ensure jumpers SEL2-SEL5 and SEL9 are present on the monitor board.
 - Ensure that Red Enable is active at all times during normal operation.
 - Integrate monitor with Ethernet network in cabinet.

NOTES

- To prevent "flash-conflict" problems, insert red flash program blocks for all unused vehicle load switches in the output file. The installer shall verify that signal heads flash in accordance with the Signal Plans.
- Program phases 4 and 8 for Dual Entry.
- Program controller to start up in phase 2 Green and 6 Green.
- The cabinet and controller are part of the Burlington-Graham Signal System.

EQUIPMENT INFORMATION

CONTROLLER.....2070LX
 CABINET.....332 W/AUX
 SOFTWARE.....ECONOLITE ASC/3-2070
 CABINET MOUNT.....BASE
 OUTPUT FILE POSITIONS...18 WITH AUX. OUTPUT FILE
 LOAD SWITCHES USED.....S2,S5,S7,S8,S11,AUX S1
 AUX S4
 PHASES USED.....2,4,5,6,8
 OVERLAP "A".....*
 OVERLAP "B".....NOT USED
 OVERLAP "C".....*
 OVERLAP "D".....NOT USED
 * See overlap programming detail on sheet 2


SIGNAL HEAD HOOK-UP CHART

LOAD SWITCH NO.	S1	S2	S3	S4	S5	S6	S7	S8	S9	S10	S11	S12	AUX S1	AUX S2	AUX S3	AUX S4	AUX S5	AUX S6
CMU CHANNEL NO.	1	2	13	3	4	14	5	6	15	7	8	16	9	10	17	11	12	18
PHASE	1	2	2 PED	3	4	4 PED	5	6	6 PED	7	8	8 PED	OLA	OLB	SPARE	OLC	OLD	SPARE
SIGNAL HEAD NO.	NU	21,22	NU	NU	41,42	NU	51*	62,63	NU	NU	81,82	NU	61*	NU	NU	51*	NU	NU
RED		128			101			134			107							
YELLOW		129			102		*	135			108							
GREEN		130			103			136			109							
RED ARROW													A121			A114		
YELLOW ARROW													A122			A115		
FLASHING YELLOW ARROW													A123			A116		
GREEN ARROW							133											

NU = Not Used
 * Denotes install load resistor. See load resistor installation detail this sheet.
 ★ See pictorial of head wiring in detail this sheet.

INPUT FILE POSITION LAYOUT


(front view)

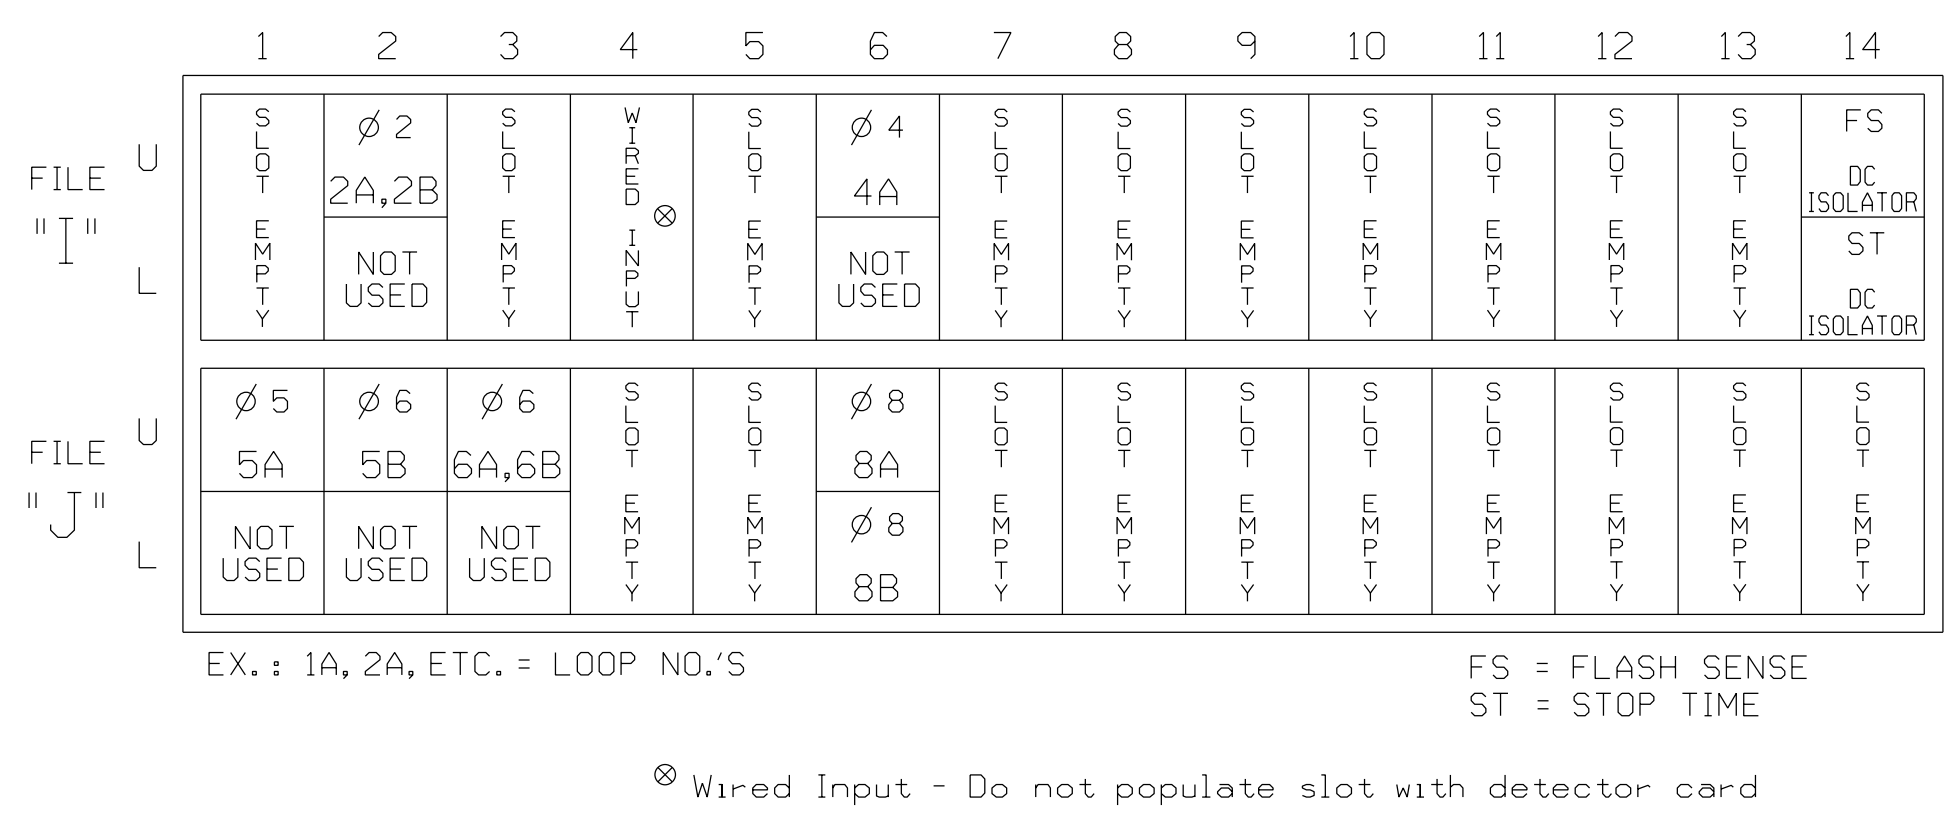

INPUT FILE CONNECTION & PROGRAMMING CHART


LOOP NO.	LOOP TERMINAL	INPUT FILE POS.	PIN NO.	DETECTOR NO.	NEMA PHASE	CALL	EXTEND TIME	DELAY TIME	USE ADDED INITIAL	DETECTOR TYPE
2A,2B	TB2-5,6	I2U	39	2	2	YES			X	N
4A	TB4-9,10	I6U	41	4	4	YES		3		S
5A ¹	TB3-1,2	J1U	55	5 ★	5	YES		15		S
	-	I4U	47	22 ★	2	YES		3		G
5B	TB3-5,6	J2U	40	6	5	YES		15		S
6A,6B	TB3-9,10	J3U	64	36	6	YES			X	N
8A	TB5-9,10	J6U	42	8	8	YES		3		S
8B	TB5-11,12	J6L	46	18	8	YES		15		S

★ See the Vehicle Detector Setup Programming Detail for Alternate Phasing on sheet 2.
¹ Add jumper from J1-W to I4-W, on rear of input file.

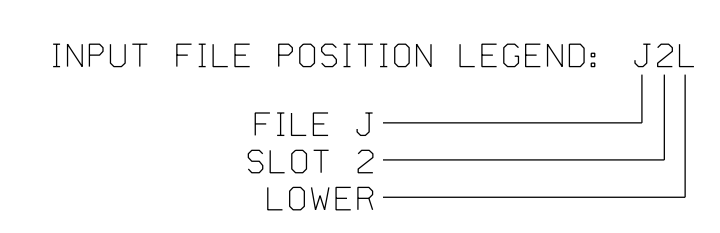


FYA SIGNAL WIRING DETAIL

(wire signal heads as shown)

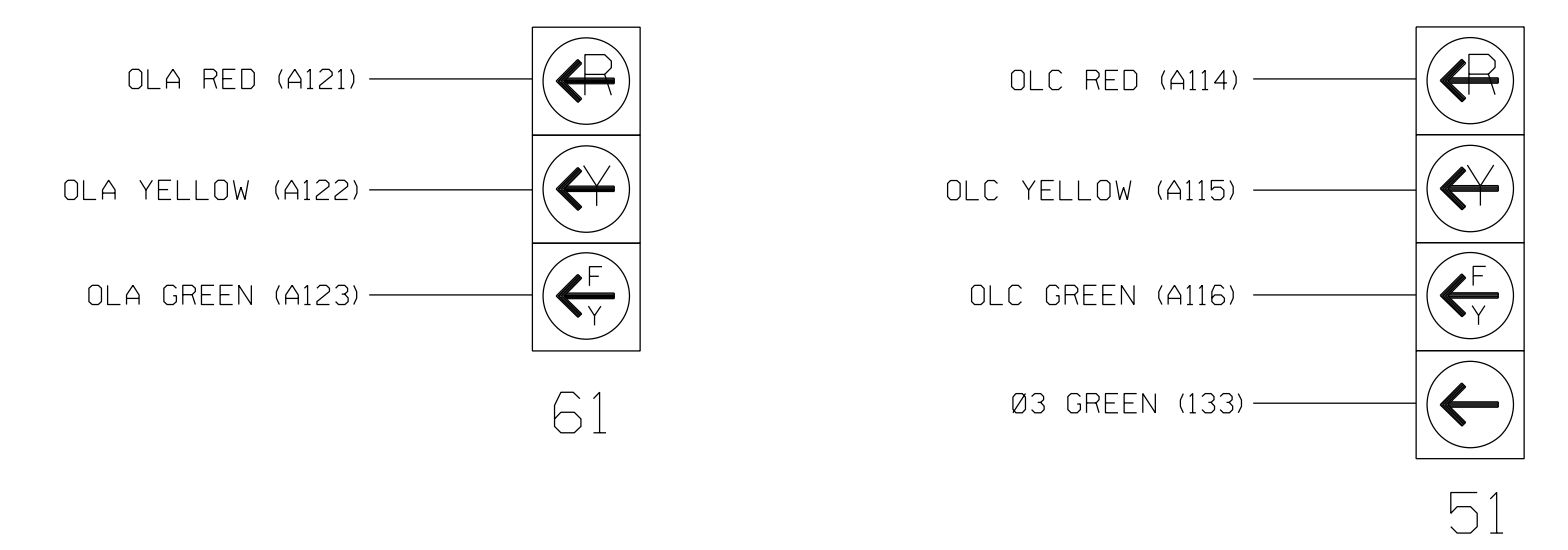

LOAD RESISTOR INSTALLATION DETAIL

(install resistor as shown)

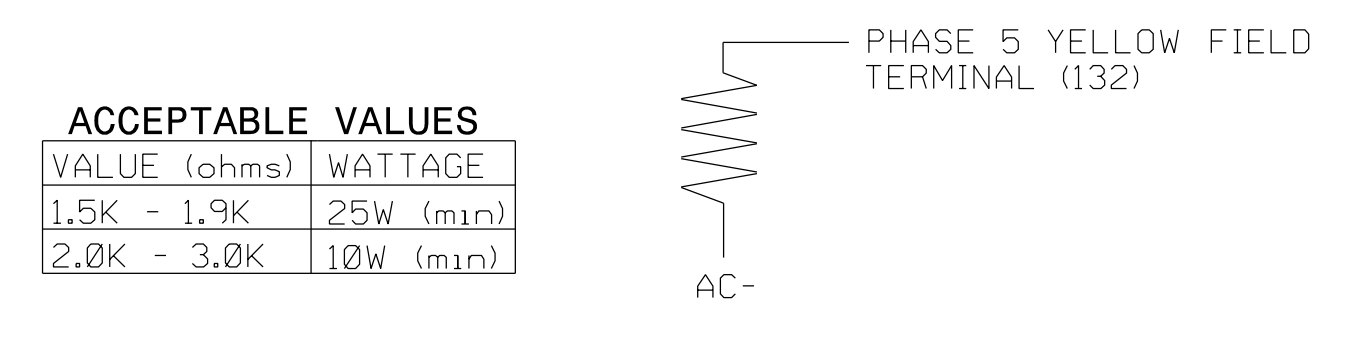

THIS ELECTRICAL DETAIL IS FOR THE SIGNAL DESIGN: 07-1062
 DESIGNED: January 2018
 SEALED: 6/7/2018
 REVISED: N/A

Electrical Detail - Sheet 1 of 3

DOCUMENT NOT CONSIDERED FINAL UNLESS ALL SIGNATURES COMPLETED

Electrical and Programming Details For:

Prepared for the Offices of:

US 70 (S. Church Street) at Gurney Street

Division 7 Alamance County Burlington

PLAN DATE: January 2018 REVIEWED BY: AM Encarnacion

PREPARED BY: VJ Paul REVIEWED BY: PL Alexander

REVISIONS INIT. DATE

Sealed by: Pamela Alexander 6/9/2018

SIG. INVENTORY NO. 07-1062

ECONOLITE ASC/3-2070 OVERLAP PROGRAMMING DETAIL

(program controller as shown)

- From Main Menu select **2. CONTROLLER**
- From CONTROLLER Submenu select **2. VEHICLE OVERLAPS**

OVERLAP A
Select TMG VEH OVLP [A] and 'OTHER/ECONOLITE'

```

TMG VEH OVLP... [A] TYPE: OTHER/ECONOLITE
PHASES 1 2 3 4 5 6 7 8 9 0 1 2 3 4 5 6
INCLUDED . X . . . . .
PROTECT . . . . .
PED PRTC . . . . .
NOT OVLP . . . . .
FLSH GRN . 1 . . . . .
LAG X PH . . . . .
LAG 2 PH . . . . .

LAG GRN 0.0 YEL 0.0 RED 0.0 ADV GRN 0.0
    
```

Toggle Twice

OVERLAP C

Select TMG VEH OVLP [C] and 'PPLT FYA'

```

TMG VEH OVLP... [C] TYPE: . . . . . PPLT FYA
PROTECTED LEFT TURN... PHASE 5
OPPOSING THROUGH..... PHASE 6

FLASHING ARROW OUTPUT.....CH11 ISOLATE
DELAY START OF: FYA..0.0 CLEARANCE..0.0
ACTION PLAN SF BIT DISABLE..... 5
    
```

NOTICE ACTION PLAN SF BIT "5"

END PROGRAMMING

ECONOLITE ASC/3-2070 VEHICLE DETECTOR SETUP PROGRAMMING DETAIL

FOR ALTERNATE PHASING LOOP 5A

(program controller as shown)

IMPORTANT!

Program detectors per the input file connection and programming chart shown on sheet 1 before proceeding.

- From Main Menu select **8. UTILITIES**
- From UTILITIES Submenu select **1. COPY/CLEAR**
- Copy from DETECTOR PLAN "1" to DETECTOR PLAN "2".

```

COPY / CLEAR UTILITY
FROM TO
PHASE TIMING.... > PHASE TIMING....
TIMING PLAN..... > TIMING PLAN....
PH DET OPT PLAN. > PH DET OPT PLAN.
DETECTOR PLAN... 1 > DETECTOR PLAN... 2
TOGGLE TO SELECT A "FROM" AND A "TO"
THEN PRESS ENTER
    
```

- From Main Menu select **6. DETECTORS**
- From DETECTOR Submenu select **2. VEHICLE DETECTOR SETUP**
- Place cursor in VEH DET PLAN [] position and enter "2".

- Place cursor in VEH DETECTOR [] position and enter "5".
- Set delay time to "0".

```

VEH DETECTOR [ 5] VEH DET PLAN [ 2]
TYPE: S-STANDARD
TS2 DETECTOR..... ECPI LOG..... NO
DET PH - 1 2 3 4 5 6 7 8 9 0 1 2 3 4 5 6
5 5 . . . . .
EXTEND TIME... 0.0 DELAY TIME... 0.0
USE ADDED INITIAL . CROSS SWITCH PH.. 0
LOCK IN..... NONE NTCIP VOL . OR OCC .
PMT QUEUE DELAY. NO
    
```

NOTICE VEH DET PLAN 2

ENSURE DELAY IS SET TO '0'

- Place cursor in VEH DETECTOR [] position and enter "22".
- Set assigned phase to "0".

```

VEH DETECTOR [22] VEH DET PLAN [ 2]
TYPE: G-GREEN EXTENSION/DELAY
TS2 DETECTOR..... ECPI LOG..... NO
DET PH - 1 2 3 4 5 6 7 8 9 0 1 2 3 4 5 6
22 0 . . . . .
EXTEND TIME... 0.0 DELAY TIME... 3.0
USE ADDED INITIAL . CROSS SWITCH PH.. 0
LOCK IN..... NONE NTCIP VOL . OR OCC .
PMT QUEUE DELAY. NO
    
```

NOTICE VEH DET PLAN 2

ENSURE PHASE IS SET TO "0"

THIS ELECTRICAL DETAIL IS FOR THE SIGNAL DESIGN: 07-1062
DESIGNED: January 2018
SEALED: 6/7/2018
REVISED: N/A


END PROGRAMMING

09-JUN-2018 14:14 D:\T\consort\at\work\office\curr\100056469 U-6015 B-G S1g Sys\Task 05_11_Signal\Des\gr\mtr\ing\07-1062E.dgn ALEX3361 AT LUS33069

Electrical Detail - Sheet 2 of 3

DOCUMENT NOT CONSIDERED FINAL UNLESS ALL SIGNATURES COMPLETED


Prepared for the Offices of:

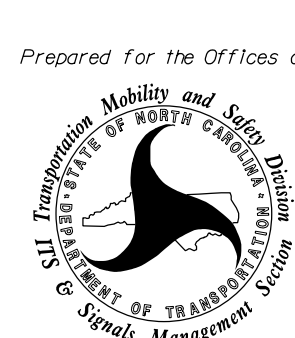

750 N. Greenfield Pkwy, Garner, NC 27529

US 70 (S. Church Street) at Gurney Street	
Division 7	Alamance County Burlington
PLAN DATE: January 2018	REVIEWED BY: AM Encarnacion
PREPARED BY: VJ Paul	REVIEWED BY: PL Alexander
REVISIONS	INIT. DATE

SEAL

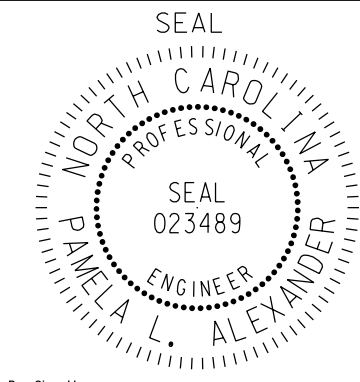

SEAL 023489
PAMELA L. ALEXANDER
ENGINEER

6/9/2018
DATE

SIG. INVENTORY NO. 07-1062

ALTERNATE PHASING ACTIVATION DETAIL

TO RUN ALT. PHASING DURING FREE RUN - PROGRAM CHANGES (SHOWN BELOW) IN A TIME BASED ACTION PLAN. SCHEDULE A DAY PLAN THAT INCLUDES THE ACTION PLAN PROGRAMMED TO SELECT VEH DET PLAN 2 AND ENABLE SF BIT 5.

TO RUN ALT. PHASING DURING COORDINATION - SELECT THE TIME BASED ACTION PLAN THAT IS PROGRAMMED TO SELECT VEH DET PLAN 2 AND ENABLE SF BIT 5.

PHASING	VEH DET PLAN	SF BITS ENABLED
ACTIONS REQUIRED TO RUN <u>DEFAULT PHASING</u>	1	NONE
ACTIONS REQUIRED TO RUN <u>ALTERNATE PHASING</u>	2	5

IMPORTANT: IF ALT. PHASING IS USED DURING FREE RUN AND COORDINATION, DO NOT OPERATE TIME OF DAY EVENTS CONCURRENTLY WITH COORDINATION PLAN EVENTS IN THE EVENT SCHEDULER. (EX. FREE RUN EVENT SHOULD END BEFORE COORDINATION PLAN EVENT STARTS AND VICE-VERSA).

ALTERNATE PHASING CHANGE SUMMARY

THE FOLLOWING IS A SUMMARY OF WHAT TAKES PLACE WHEN SF BIT 5 AND VEH DET PLAN 2 ACTIVATE TO CALL THE "ALTERNATE PHASING":

SF BITS 5: Modifies overlap parent phases for heads 51 to run protected turns only.

VEH DET PLAN 2: Disables phase 2 call on loop 5A and reduces delay time for phase 5 call on loop 5A to 0 seconds.

ECONOLITE ASC/3-2070 ACTION PLAN PROGRAMMING DETAIL

- From Main Menu select 5. TIME BASE
- From TIME BASE Submenu select 2. ACTION PLAN

```

ACTION PLAN...[ 1]
PATTERN.....AUTO   SYS OVERRIDE.... NO
TIMING PLAN..... 0   SEQUENCE..... 0
VEH DETECTOR PLAN.. 2  DET LOG.....NONE
FLASH..... --   RED REST..... NO
VEH DET DIAG PLN... 0  PED DET DIAG PLN..0
DIMMING ENABLE.. NO  PRIORITY RETURN. NO
PED PR RETURN.. NO  QUEUE DELAY..... NO
PMT COND DELAY   NO



  PHASE  1  2  3  4  5  6  7  8  9  0  1  2  3  4  5  6
PED RCL   .  .  .  .  .  .  .  .  .  .  .  .  .  .  .  .
WALK 2    .  .  .  .  .  .  .  .  .  .  .  .  .  .  .  .
VEX 2     .  .  .  .  .  .  .  .  .  .  .  .  .  .  .  .
VEH RCL   .  .  .  .  .  .  .  .  .  .  .  .  .  .  .  .
MAX RCL   .  .  .  .  .  .  .  .  .  .  .  .  .  .  .  .
MAX 2     .  .  .  .  .  .  .  .  .  .  .  .  .  .  .  .
  PHASE  1  2  3  4  5  6  7  8  9  0  1  2  3  4  5  6
MAX 3     .  .  .  .  .  .  .  .  .  .  .  .  .  .  .  .
CS INH    .  .  .  .  .  .  .  .  .  .  .  .  .  .  .  .
OMIT      .  .  .  .  .  .  .  .  .  .  .  .  .  .  .  .
SPC FCT   .  .  .  .  X  .  .  .  .  .  .  .  .  .  .  .
AUX FCT   .  .  .  .  (1-3)

  1  2  3  4  5  6  7  8  9  0  1  2  3  4  5
LP 1-15   .  .  .  .  .  .  .  .  .  .  .  .  .  .  .  .
LP 16-30  .  .  .  .  .  .  .  .  .  .  .  .  .  .  .  .
LP 31-45  .  .  .  .  .  .  .  .  .  .  .  .  .  .  .  .
LP 46-60  .  .  .  .  .  .  .  .  .  .  .  .  .  .  .  .
LP 61-75  .  .  .  .  .  .  .  .  .  .  .  .  .  .  .  .
LP 76-90  .  .  .  .  .  .  .  .  .  .  .  .  .  .  .  .
LP 91-100 .  .  .  .  .  .  .  .  .  .  .  .  .  .  .  .
    
```


THIS ELECTRICAL DETAIL IS FOR
 THE SIGNAL DESIGN: 07-1062
 DESIGNED: January 2018
 SEALED: 6/7/2018
 REVISED: N/A

Electrical Detail - Sheet 3 of 3

DOCUMENT NOT CONSIDERED FINAL UNLESS ALL SIGNATURES COMPLETED

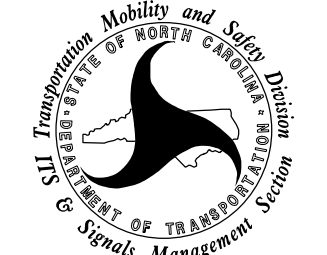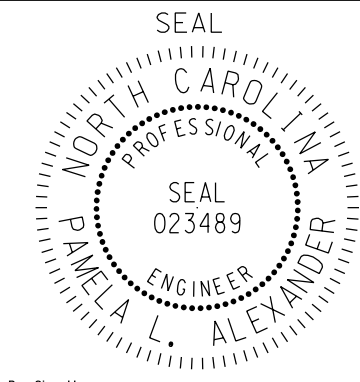ELECTRICAL AND PROGRAMMING DETAILS FOR: Prepared for the Offices of: 	US 70 (S. Church Street) at Gurney Street Division 7 Alamance County Burlington PLAN DATE: January 2018 REVIEWED BY: AM Encarnacion PREPARED BY: VJ Paul REVIEWED BY: PL Alexander	SEAL 								
<table border="1" style="width: 100%; border-collapse: collapse;"> <thead> <tr> <th>REVISIONS</th> <th>DATE</th> <th>INIT.</th> <th>DATE</th> </tr> </thead> <tbody> <tr> <td> </td> <td> </td> <td> </td> <td> </td> </tr> </tbody> </table>	REVISIONS	DATE	INIT.	DATE					Date: 6/9/2018 Signature: Pamela Alexander Date: _____ Date: _____	SEAL INVENTORY NO. 07-1062
REVISIONS	DATE	INIT.	DATE							

PHASING DIAGRAM

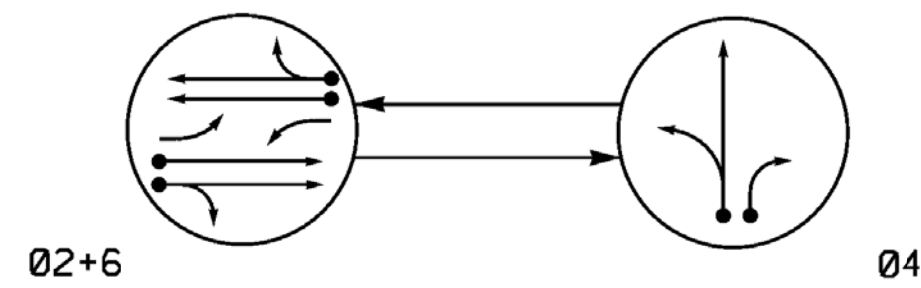

PHASING DIAGRAM DETECTION LEGEND


- ←●→ DETECTED MOVEMENT
- ←○→ UNDETECTED MOVEMENT (OVERLAP)
- ←- - - UN SIGNALIZED MOVEMENT
- ←- - - PEDESTRIAN MOVEMENT

TABLE OF OPERATION

SIGNAL FACE	PHASE		
	02+6	04	FLASH
21, 22	G	R	Y
41, 42	R	G	R
61, 62	G	R	Y

SIGNAL FACE I.D.

All Heads L.E.D.

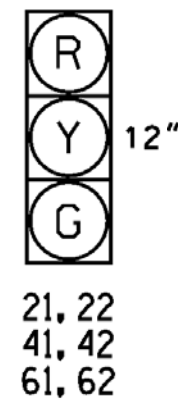


ASC/3 DETECTOR INSTALLATION CHART											
DETECTOR					PROGRAMMING						
LOOP	SIZE (FT)	DISTANCE FROM STOPBAR (FT)	TURNS	NEW LOOP	PHASE	CALLING	EXTEND TIME	DELAY TIME	USE ADDED INITIAL	TYPE	NEW CARD
2A,2B	6x6	270	4	-	2	Yes	-	-	X	N	- X
4A	6x40	+5	2-4-2	-	4	Yes	-	3	-	S	- X
4B	6x40	+5	2-4-2	-	4	Yes	-	15	-	S	- X
6A,6B	6x6	270	4	-	6	Yes	-	-	X	N	- X
S1	6x6	+260	EXIST.	-	-	Yes	-	-	-	N	- X
S2	6x6	+260	EXIST.	-	-	No	-	-	-	N	- X

2 Phase Fully Actuated (Burlington-Graham Signal System)

NOTES

- Refer to "Roadway Standard Drawings NCDOT" dated January 2018 and "Standard Specifications for Roads and Structures" dated January 2018.
- Do not program signal for late night flashing operation unless otherwise directed by the Engineer.
- Set all detector units to presence mode.
- In the event of loop replacement, refer to the current ITS and Signals Design Manual and submit a Plan of Record to the Signal Design Section.
- Locate new cabinet so as not to obstruct sight distance of vehicles turning right on red.
- The cabinet should be designed to include an Auxiliary Output file for future use.
- Maximum times shown in timing chart are for free-run operation only. Coordinated signal system timing values supersede these values.

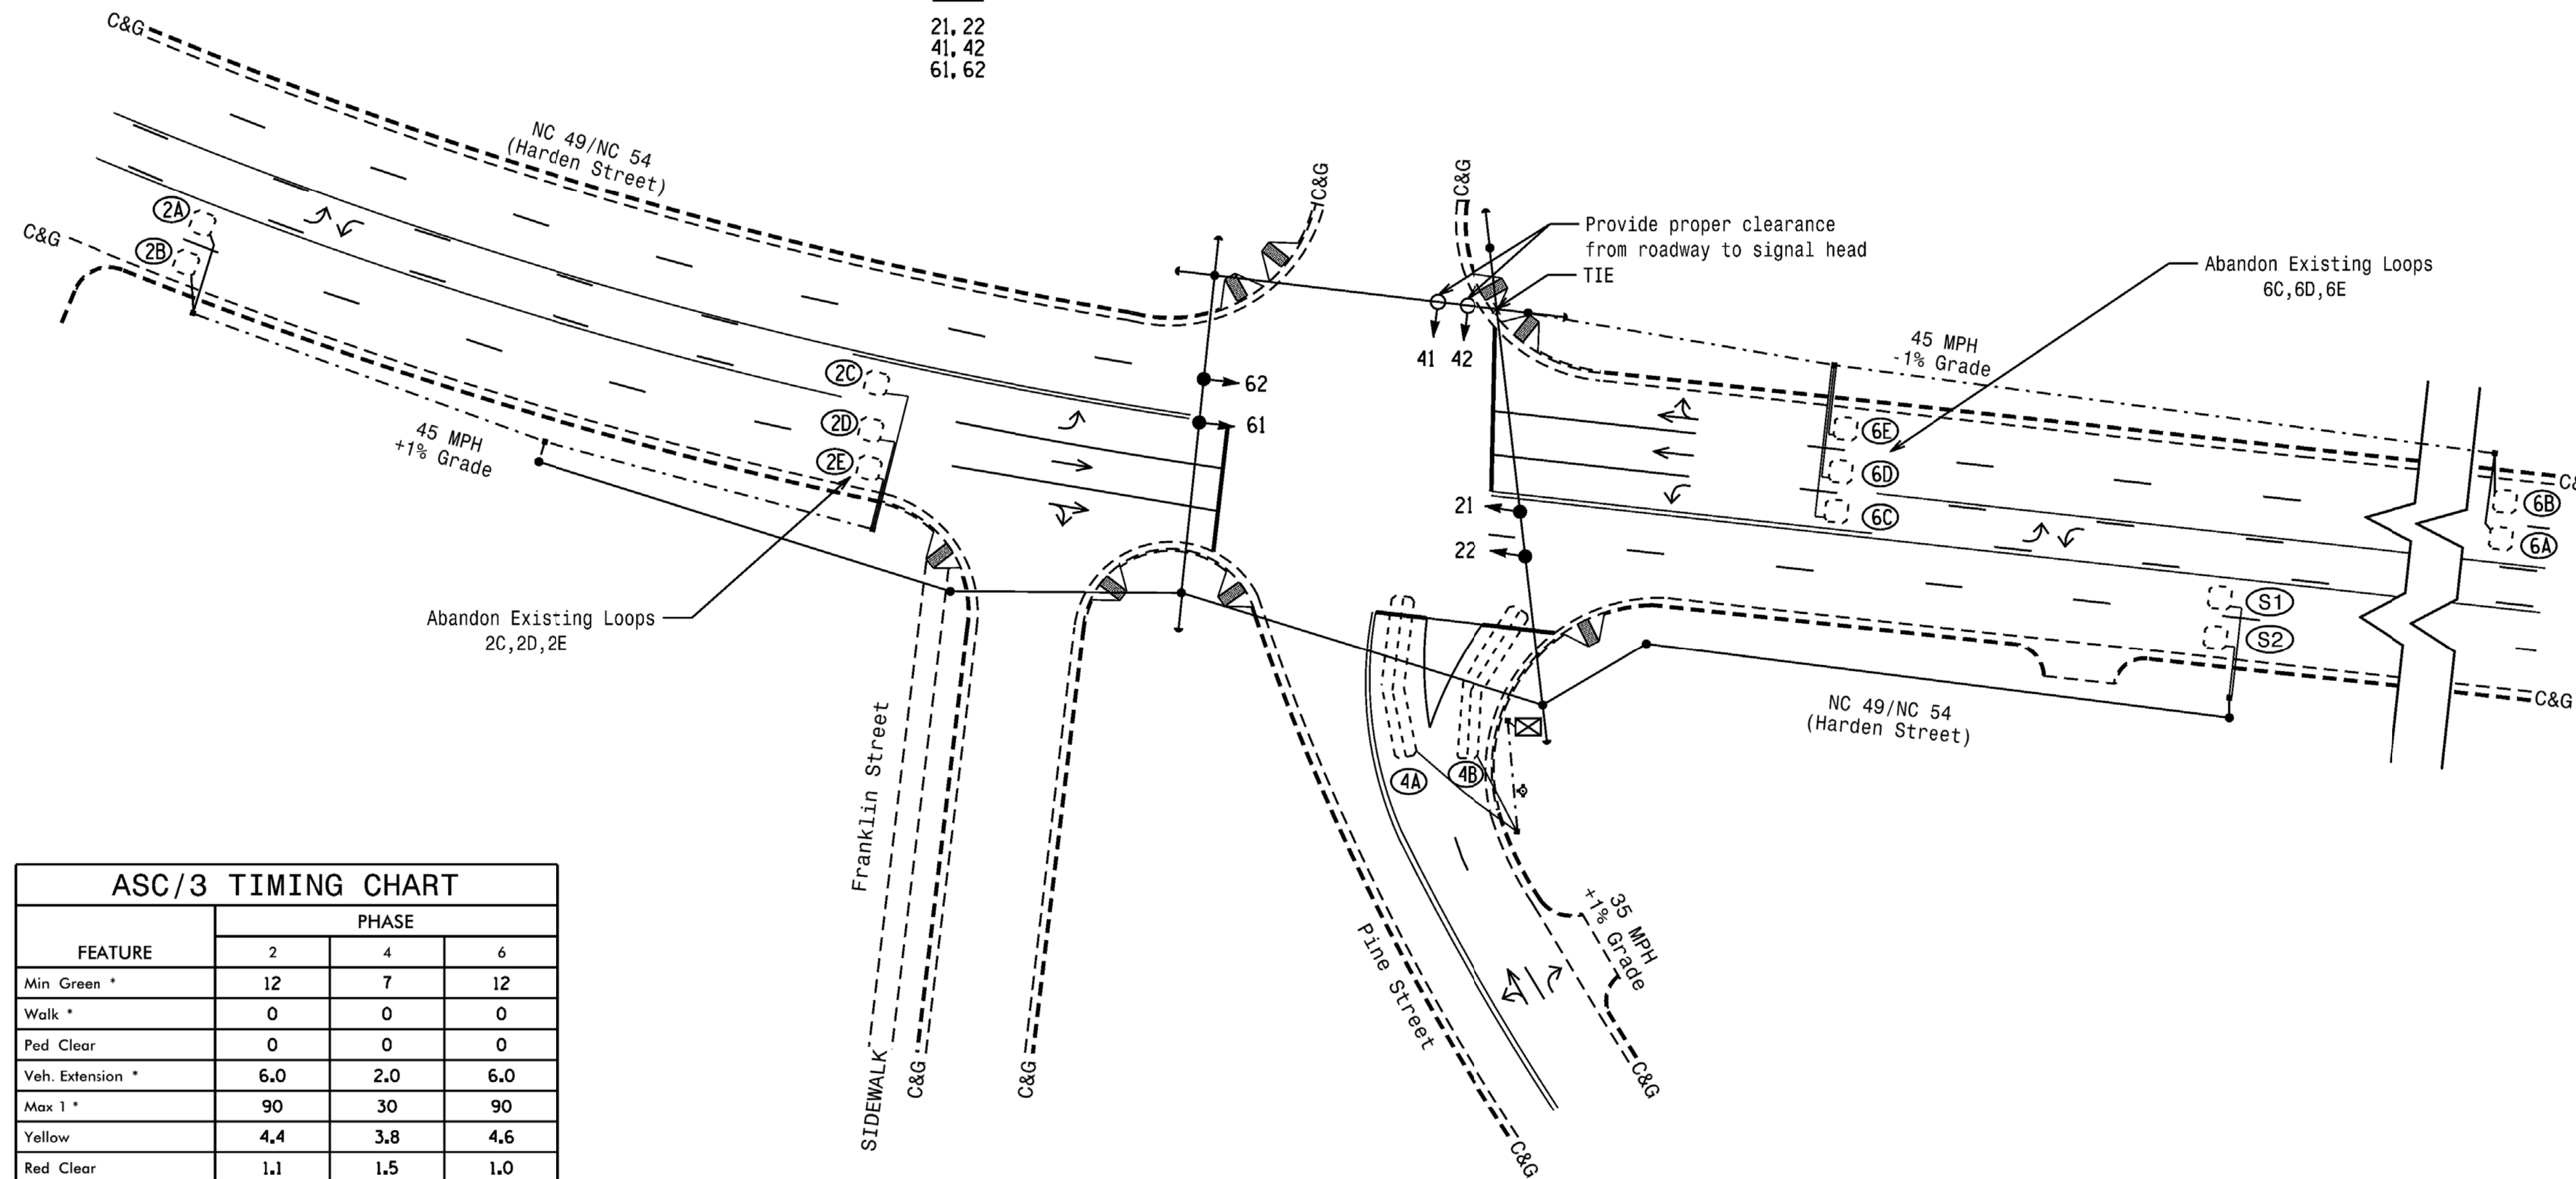

ASC/3 TIMING CHART

FEATURE	PHASE		
	2	4	6
Min Green *	12	7	12
Walk *	0	0	0
Ped Clear	0	0	0
Veh. Extension *	6.0	2.0	6.0
Max I *	90	30	90
Yellow	4.4	3.8	4.6
Red Clear	1.1	1.5	1.0
Actuations B4 Add *	0	-	0
Seconds / Actuation *	1.5	-	1.5
Max Initial *	31	-	31
Time Before Reduction *	30	-	30
Time To Reduce *	30	-	30
Minimum Gap	3.0	-	3.0
Locking Detector	X	-	X
Recall Position	VEH. RECALL	-	VEH. RECALL
Dual Entry	-	-	-
Simultaneous Gap	X	X	X

* These values may be field adjusted. Do not adjust Min Green and Extension times for phases 2 and 6 lower than what is shown. Min Green for all other phases should not be lower than 4 seconds.

PROPOSED	EXISTING
	N/A

Mattern & Craig
ENGINEERS • SURVEYORS

12 BROAD STREET
ASHEVILLE, NORTH CAROLINA 28801
(828) 254-2201
FAX (828) 254-4562
NC LIC. NO. C-1154

Signal Upgrade

Prepared for the Offices of:
TRANSPORTATION MOBILITY AND SAFETY DIVISION
SIGNAL DESIGN SECTION
750 N. Greenfield Pkwy, Garner, NC 27529

DOCUMENT NOT CONSIDERED FINAL UNLESS ALL SIGNATURES COMPLETED

NC 49/NC 54 (Harden Street) at Pine Street

Division 7 Alamance County Graham

PLAN DATE: March 2018 REVIEWED BY: JB Voso

PREPARED BY: SE Greene REVIEWED BY:


REVISIONS

INIT. DATE

SEAL
JAMES B. VOSO
ENGINEER
022599
6/13/2018
SIG. INVENTORY NO. 07-1064

*****SYSTEMS*****
*****BUSINESS*****

EDI MODEL 2018ECLip-NC CONFLICT MONITOR PROGRAMMING DETAIL
(remove jumpers and set switches as shown)

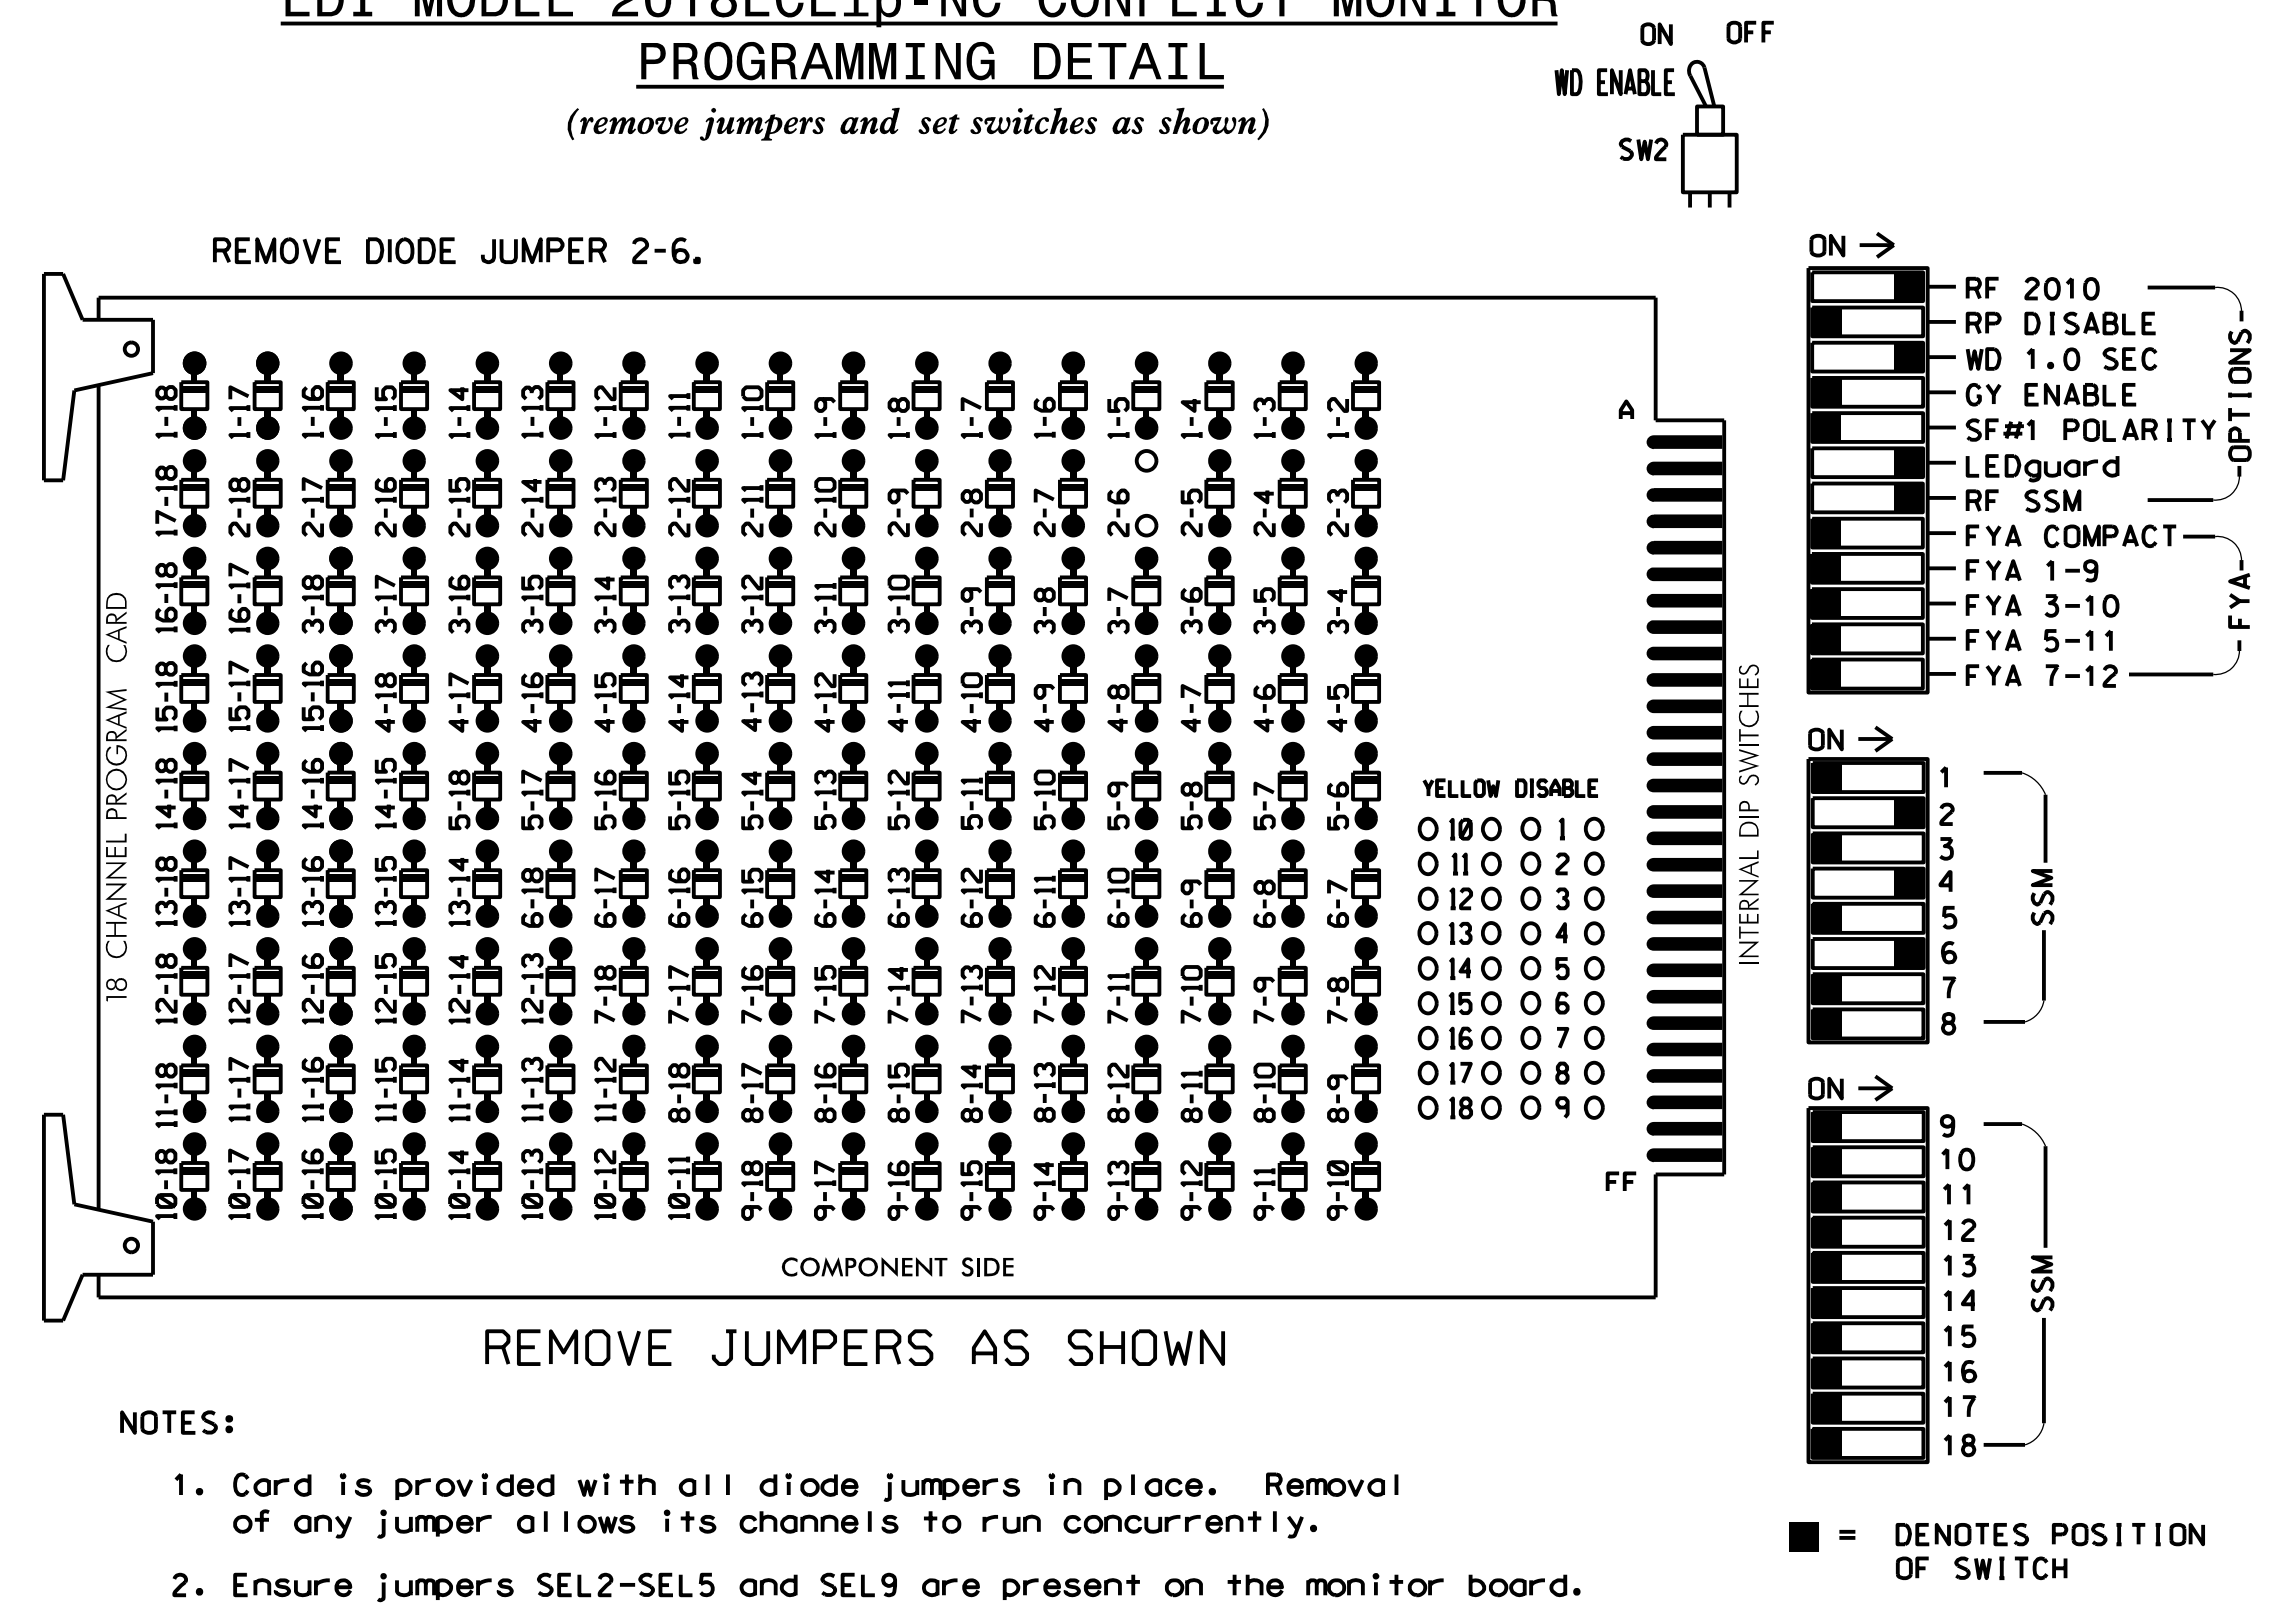

NOTES

- To prevent "flash-conflict" problems, insert red flash program blocks for all unused vehicle load switches in the output file. The installer shall verify that signal heads flash in accordance with the Signal Plans.
- Program controller to start up in phase 2 Green and 6 Green.
- The cabinet and controller are part of the Burlington-Graham Signal System.

SIGNAL HEAD HOOK-UP CHART


LOAD SWITCH NO.	S1	S2	S3	S4	S5	S6	S7	S8	S9	S10	S11	S12	AUX S1	AUX S2	AUX S3	AUX S4	AUX S5	AUX S6
CMU CHANNEL NO.	1	2	13	3	4	14	5	6	15	7	8	16	9	10	17	11	12	18
PHASE	1	2	2 PED	3	4	4 PED	5	6	6 PED	7	8	8 PED	OLA	OLB	SPARE	OLC	OLD	SPARE
SIGNAL HEAD NO.	NU	21,22	NU	NU	41,42	NU	NU	61,62	NU	NU	NU	NU	NU	NU	NU	NU	NU	NU
RED		128			101			134										
YELLOW		129			102			135										
GREEN		130			103			136										
RED ARROW																		
YELLOW ARROW																		
FLASHING YELLOW ARROW																		
GREEN ARROW																		

NU = Not Used

EQUIPMENT INFORMATION

CONTROLLER.....2070LX
 CABINET.....332 W/AUX
 SOFTWARE.....ECONOLITE ASC/3-2070
 CABINET MOUNT.....BASE
 OUTPUT FILE POSITIONS...18 WITH AUX. OUTPUT FILE
 LOAD SWITCHES USED.....S2,S5,S8
 PHASES USED.....2,4,6
 OVERLAP "A".....NOT USED
 OVERLAP "B".....NOT USED
 OVERLAP "C".....NOT USED
 OVERLAP "D".....NOT USED


INPUT FILE POSITION LAYOUT

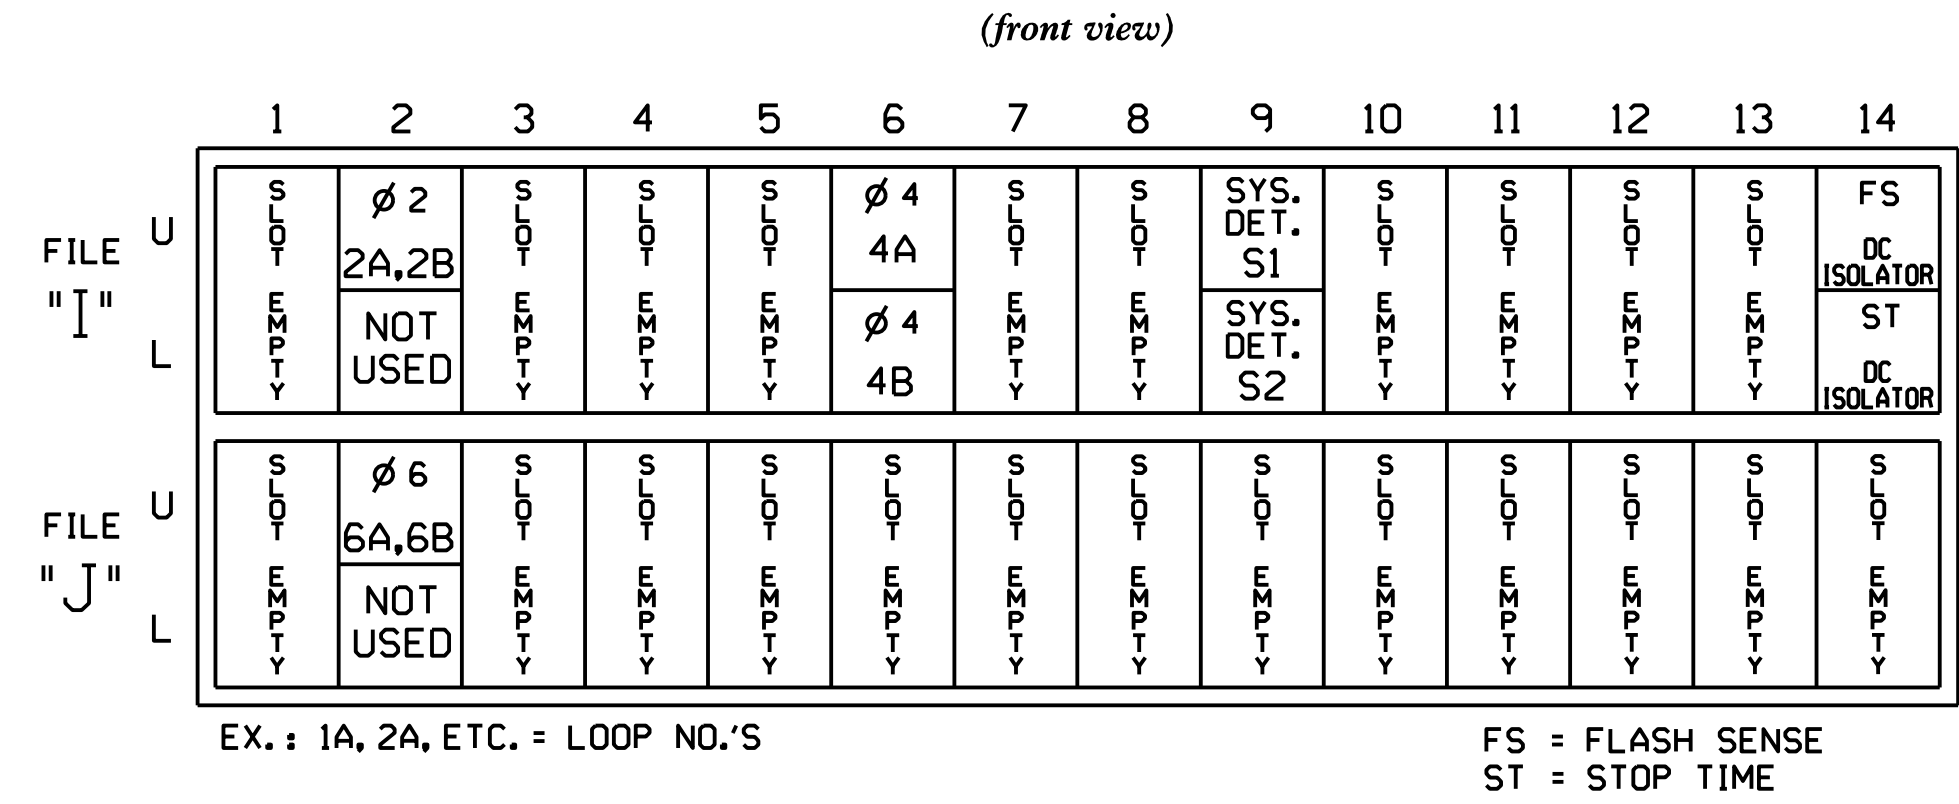

INPUT FILE CONNECTION & PROGRAMMING CHART

LOOP NO.	LOOP TERMINAL	INPUT FILE POS.	PIN NO.	DETECTOR NO.	NEMA PHASE	CALL	EXTEND TIME	DELAY TIME	ADDED INITIAL	DETECTOR TYPE
2A,2B	TB2-5,6	I2U	39	2	2	YES			X	N
4A	TB4-9,10	I6U	41	4	4	YES				S
4B	TB4-11,12	I6L	45	14	4	YES		15		S
* S1	TB6-9,10	I9U	60	11	SYS	NO				N
* S2	TB6-11,12	I9L	62	13	SYS	NO				N
6A,6B	TB3-5,6	J2U	40	6	6	YES			X	N

* System detector only. Remove any assigned vehicle phase.

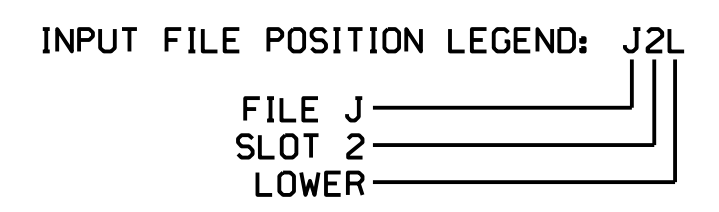

THIS ELECTRICAL DETAIL IS FOR THE SIGNAL DESIGN: 07-1064
 DESIGNED: March 2018
 SEALED: 6/13/2018
 REVISED: NA

*****SYTIME*****
 *****DONG*****

Mattern & Craig
 ENGINEERS • SURVEYORS

12 BROAD STREET
 ASHEVILLE, NORTH CAROLINA 28801
 (828) 254-2201
 FAX (828) 254-4562
 NC LIC. NO. C-1154

Electrical Detail

DOCUMENT NOT CONSIDERED FINAL UNLESS ALL SIGNATURES COMPLETED

SEAL

Division 7 Alamance County Graham

PLAN DATE: March 2018 REVIEWED BY: JB Voso

PREPARED BY: SE Greene REVIEWED BY:


REVISIONS

INIT. DATE

James Voso
 6/13/2018
 DATE

SIG. INVENTORY NO. 07-1064

PHASING DIAGRAM

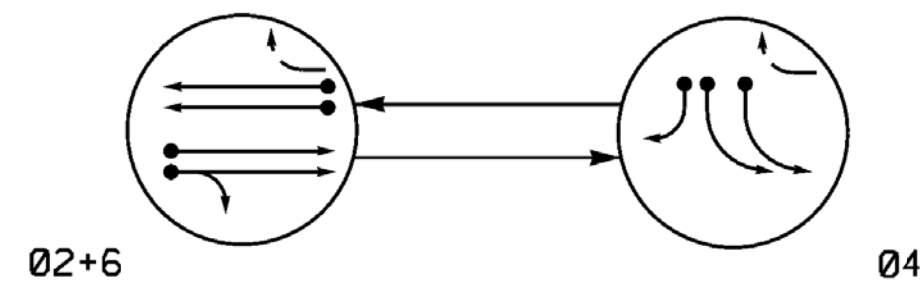


PHASING DIAGRAM DETECTION LEGEND

- ←● DETECTED MOVEMENT
- ← UNDETECTED MOVEMENT (OVERLAP)
- ←- UNSIGNALIZED MOVEMENT
- ←- - PEDESTRIAN MOVEMENT

SIGNAL FACE	PHASE		
	Ø2+6	Ø4	FLASH
21, 22	G	R	Y
41, 42	R	-	R
43	R	-	R
61, 62	G	R	Y

SIGNAL FACE I.D.

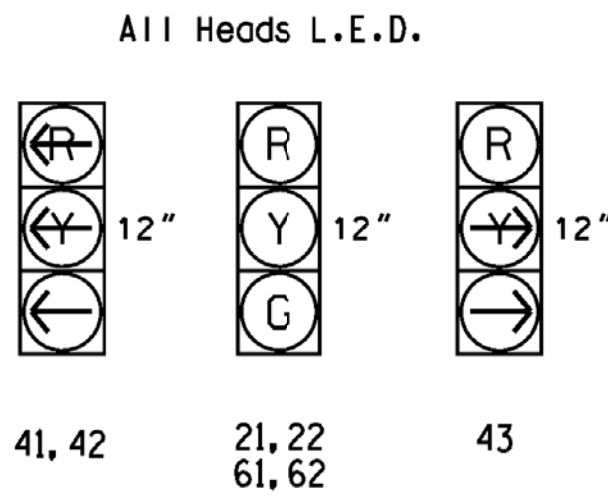


ASC/3 DETECTOR INSTALLATION CHART											
DETECTOR						PROGRAMMING					
LOOP	SIZE (FT)	DISTANCE FROM STOPBAR (FT)	TURNS	NEW LOOP	PHASE	CALLING	EXTEND TIME	DELAY TIME	USE ADDED INITIAL	TYPE	NEW CARD
2A, 2B	6x6	300	EXIST.	-	2	Yes	-	-	X	N	- X
4A, 4B	6x60	+5	2-4-2	-	4	Yes	-	-	-	S	- X
4C	6x60	+5	2-4-2	-	4	Yes	-	15	-	S	- X
6A, 6B	6x6	300	EXIST.	-	6	Yes	-	-	X	N	- X
S1	6x6	+220	EXIST.	-	-	No	-	-	-	N	X X
S2	6x6	+220	EXIST.	-	-	No	-	-	-	N	X X

2 Phase Fully Actuated (Burlington-Graham Signal System)

NOTES

- Refer to "Roadway Standard Drawings NCDOT" dated January 2018 and "Standard Specifications for Roads and Structures" dated January 2018.
- Do not program signal for late night flashing operation unless otherwise directed by the Engineer.
- Set all detector units to presence mode.
- In the event of loop replacement, refer to the current ITS and Signals Design Manual and submit a Plan of Record to the Signal Design Section.
- Locate new cabinet so as not to obstruct sight distance of vehicles turning right on red.
- Pavement markings are existing.
- Maximum times shown in timing chart are for free-run operation only. Coordinated signal system timing values supersede these values.

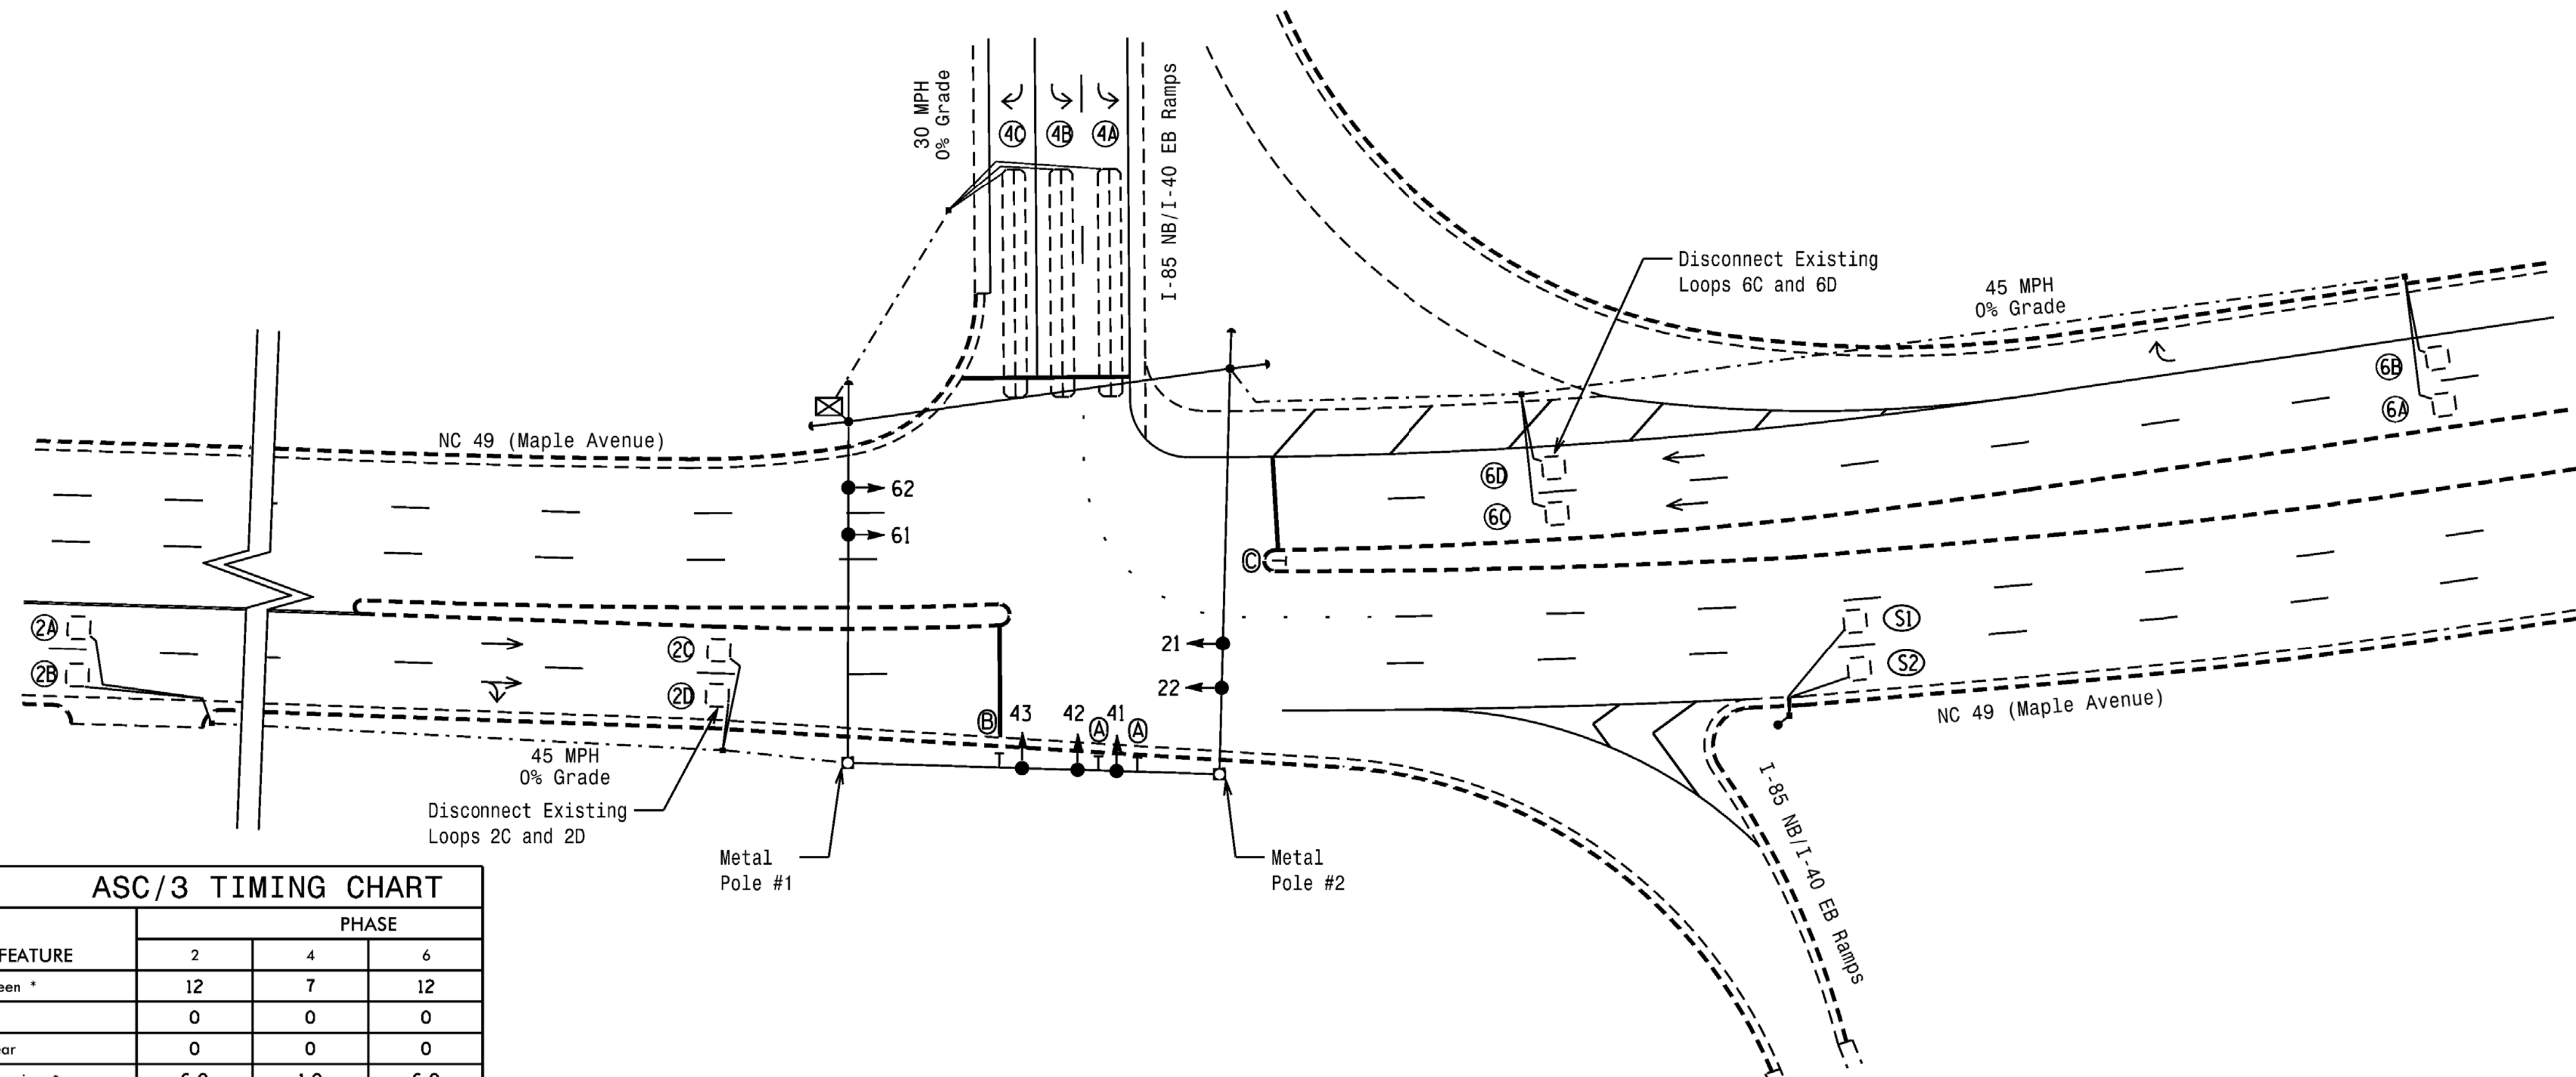

ASC/3 TIMING CHART

FEATURE	PHASE		
	2	4	6
Min Green *	12	7	12
Walk *	0	0	0
Ped Clear	0	0	0
Veh. Extension *	6.0	1.0	6.0
Max I *	45	30	45
Yellow	4.5	3.0	4.5
Red Clear	1.0	2.4	1.2
Actuations B4 Add *	0	-	0
Seconds / Actuation *	1.5	-	1.5
Max Initial *	34	-	34
Time Before Reduction *	15	-	15
Time To Reduce *	15	-	15
Minimum Gap	3.0	-	3.0
Locking Detector	X	-	X
Recall Position	VEH. RECALL	-	VEH. RECALL
Dual Entry	-	-	-
Simultaneous Gap	X	X	X

* These values may be field adjusted. Do not adjust Min Green and Extension times for phases 2 and 6 lower than what is shown. Min Green for all other phases should not be lower than 4 seconds.

LEGEND

- | | |
|---------------------------------------|---------------------------------------|
| PROPOSED | EXISTING |
| ○ → Traffic Signal Head | ● → N/A |
| ● → Modified Signal Head | — Sign |
| ⊥ Pedestrian Signal Head | ⊥ Signal Pole with Guy |
| ⊥ With Push Button & Sign | ⊥ Signal Pole with Sidewalk Guy |
| ⊥ Signal Pole with Guy | ⊥ Inductive Loop Detector |
| ⊥ Signal Pole with Sidewalk Guy | ⊥ Controller & Cabinet |
| ⊥ Inductive Loop Detector | ⊥ Junction Box |
| ⊥ Controller & Cabinet | ⊥ 2-in Underground Conduit |
| ⊥ Junction Box | ⊥ Right of Way |
| ⊥ 2-in Underground Conduit | → Directional Arrow |
| ⊥ Right of Way | ⊥ Metal Strain Pole |
| → Directional Arrow | ⊙ (A) Left Arrow "ONLY" Sign (R3-5L) |
| ⊥ Metal Strain Pole | ⊙ (B) Right Arrow "ONLY" Sign (R3-5R) |
| ⊙ (A) Left Arrow "ONLY" Sign (R3-5L) | ⊙ (C) No Left Turn Sign (R3-2) |
| ⊙ (B) Right Arrow "ONLY" Sign (R3-5R) | |
| ⊙ (C) No Left Turn Sign (R3-2) | |

Mattern & Craig
ENGINEERS • SURVEYORS

12 BROAD STREET
ASHEVILLE, NORTH CAROLINA 28801
(828) 254-2201
FAX (828) 254-4562
NC LIC. NO. C-1154

Signal Upgrade

DOCUMENT NOT CONSIDERED FINAL UNLESS ALL SIGNATURES COMPLETED

NC 49 (Maple Avenue) at I-85 NB/I-40 EB Ramps

Division 7 Alamance County Burlington

PLAN DATE: April 2018 REVIEWED BY: JB Voso

PREPARED BY: SE Greene REVIEWED BY:


REVISIONS	INIT.	DATE

SIG. INVENTORY NO. 07-1066

*****SYSTEM*****
 *****BUSINESS*****

EDI MODEL 2018ECLip-NC CONFLICT MONITOR PROGRAMMING DETAIL

(remove jumpers and set switches as shown)

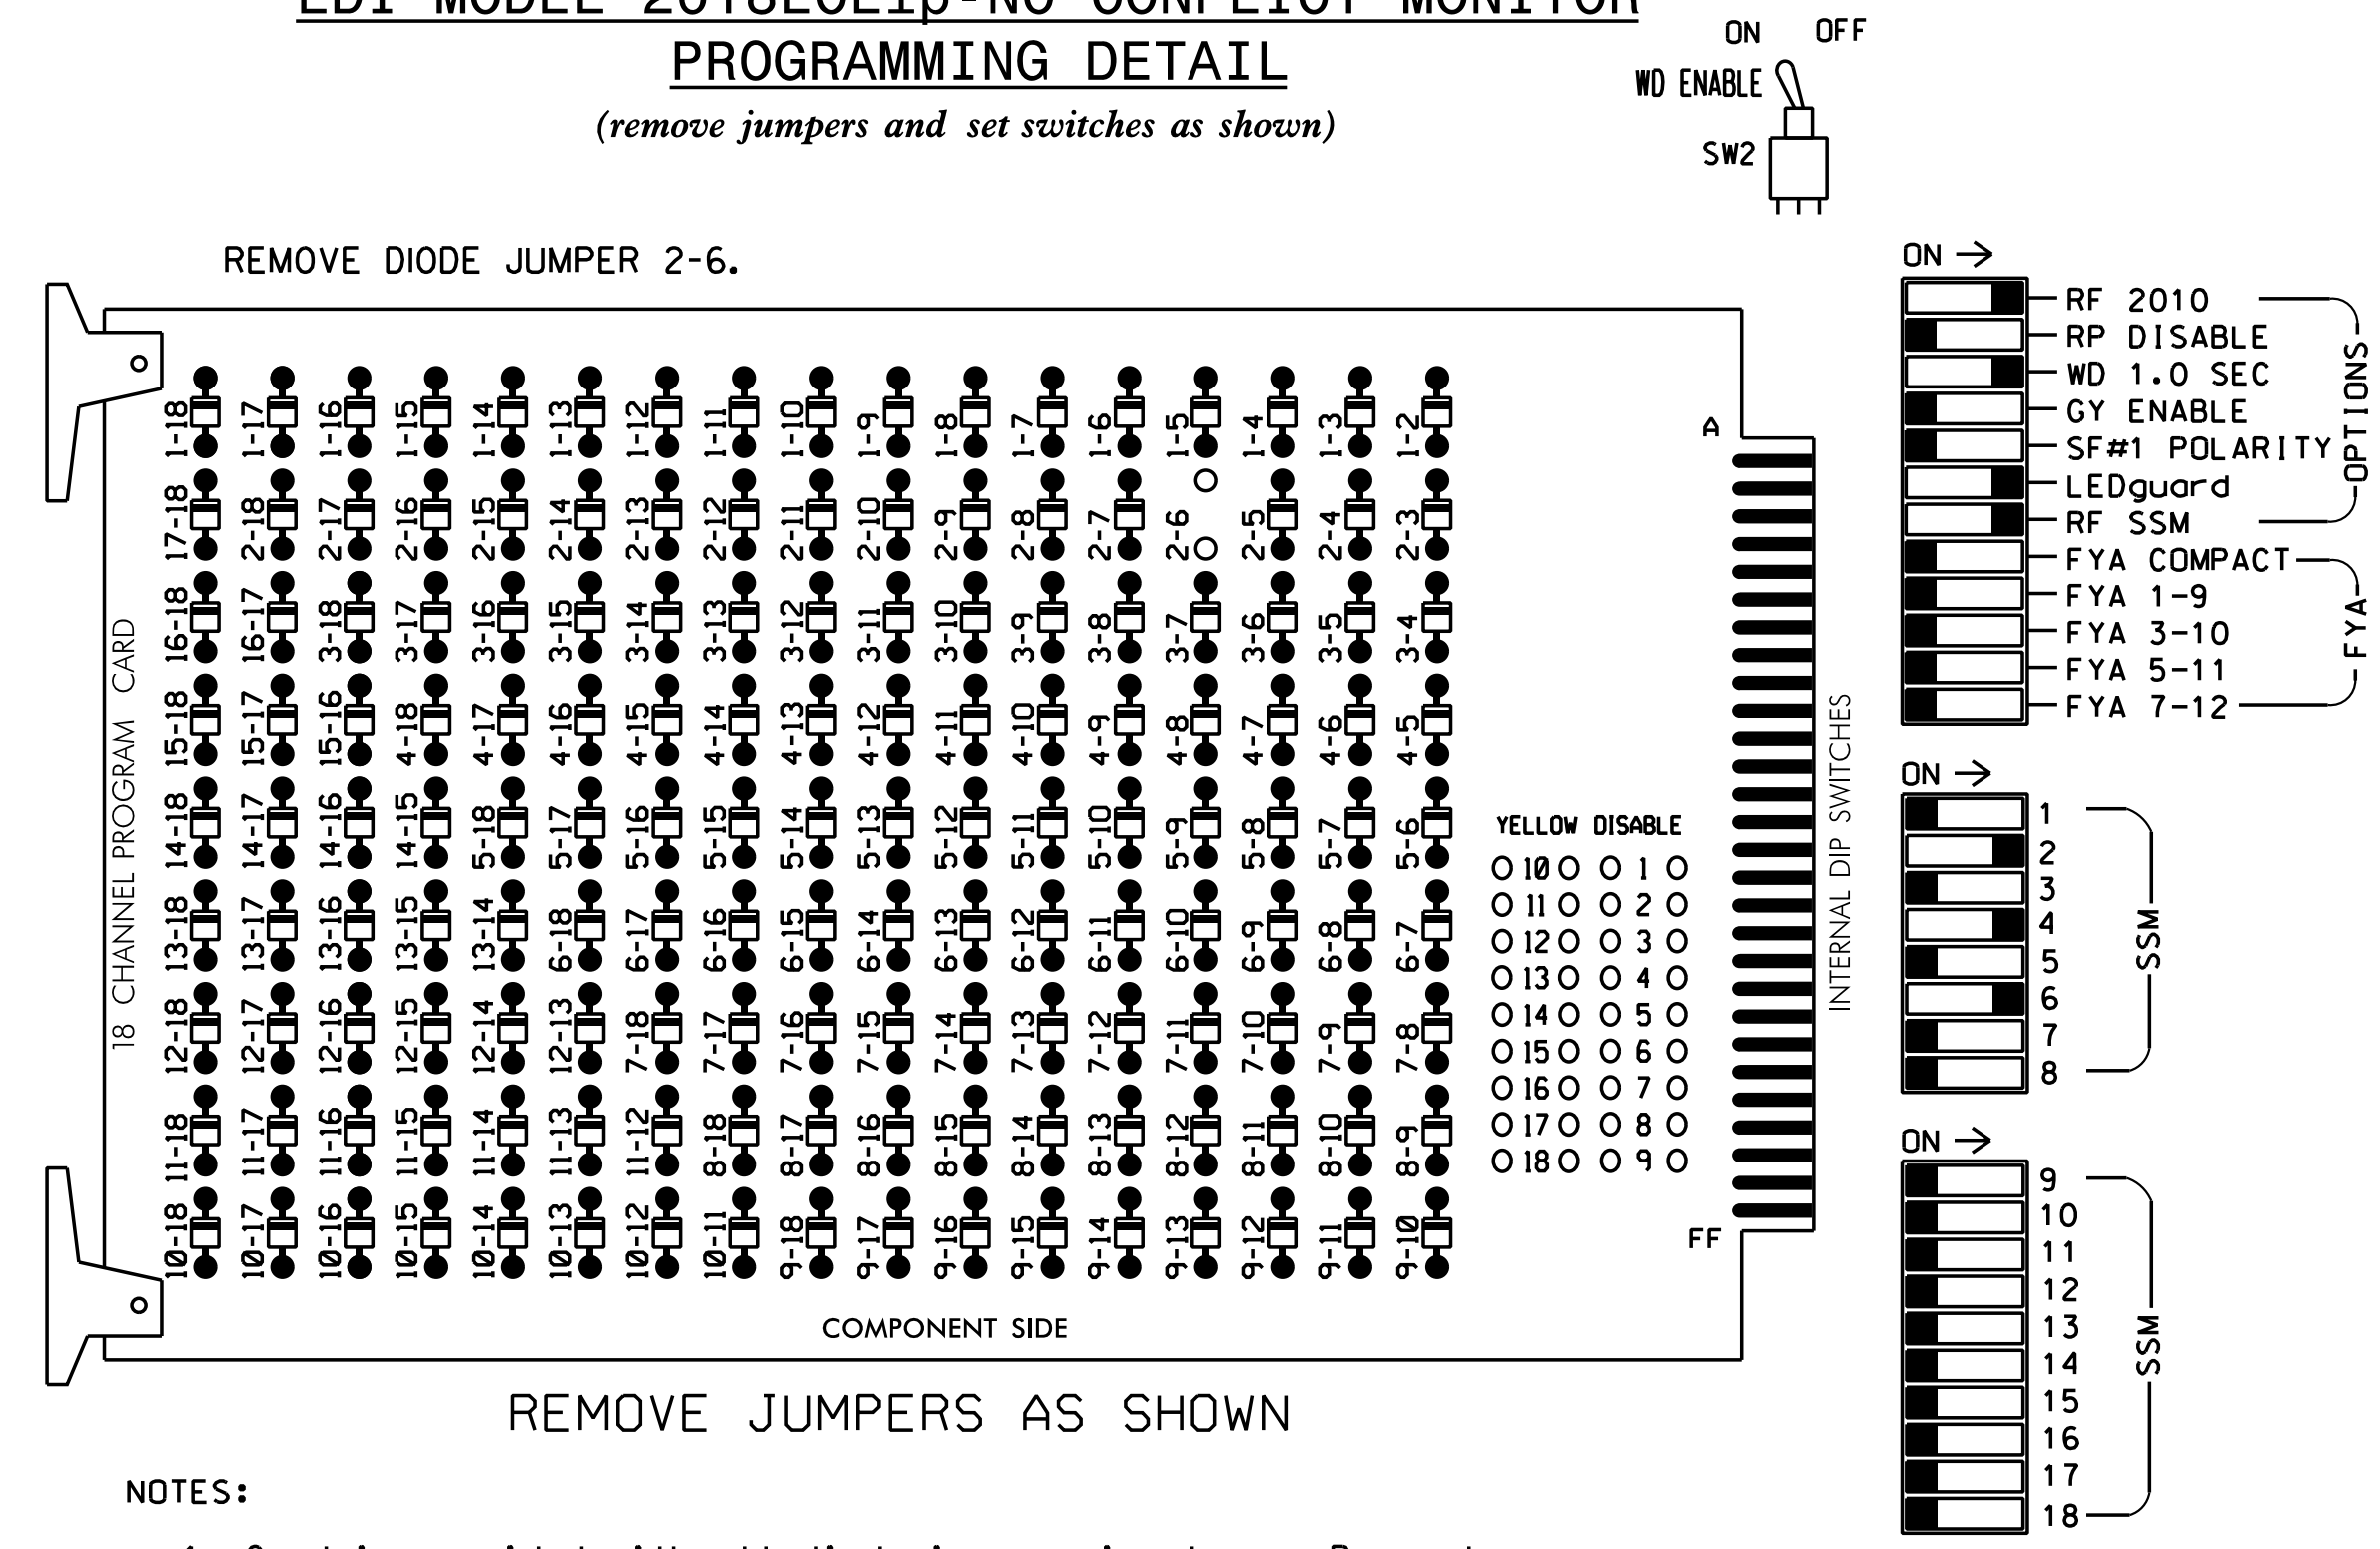

NOTES:

1. Card is provided with all diode jumpers in place. Removal of any jumper allows its channels to run concurrently.
2. Ensure jumpers SEL2-SEL5 and SEL9 are present on the monitor board.
3. Ensure that Red Enable is active at all times during normal operation.
4. Integrate monitor with Ethernet network in cabinet.

NOTES

1. To prevent "flash-conflict" problems, insert red flash program blocks for all unused vehicle load switches in the output file. The installer shall verify that signal heads flash in accordance with the Signal Plans.
2. Program controller to start up in phase 2 Green and 6 Green.
3. The cabinet and controller are part of the Burlington-Graham Signal System.

EQUIPMENT INFORMATION

CONTROLLER.....2070LX
 CABINET.....332
 SOFTWARE.....ECONOLITE ASC/3-2070
 CABINET MOUNT.....BASE
 OUTPUT FILE POSITIONS...12
 LOAD SWITCHES USED.....S2,S5,S8
 PHASES USED.....2,4,6
 OVERLAPS.....NONE


SIGNAL HEAD HOOK-UP CHART

LOAD SWITCH NO.	S1	S2	S3	S4	S5	S6	S7	S8	S9	S10	S11	S12
CMU CHANNEL NO.	1	2	13	3	4	14	5	6	15	7	8	16
PHASE	1	2	2 PED	3	4	4 PED	5	6	6 PED	7	8	8 PED
SIGNAL HEAD NO.	NU	21,22	NU	NU	41,42,43	NU	NU	61,62	NU	NU	NU	NU
RED		128			101			134				
YELLOW		129						135				
GREEN		130						136				
RED ARROW												
YELLOW ARROW					102							
GREEN ARROW					103							

NU = Not Used

INPUT FILE POSITION LAYOUT

(front view)

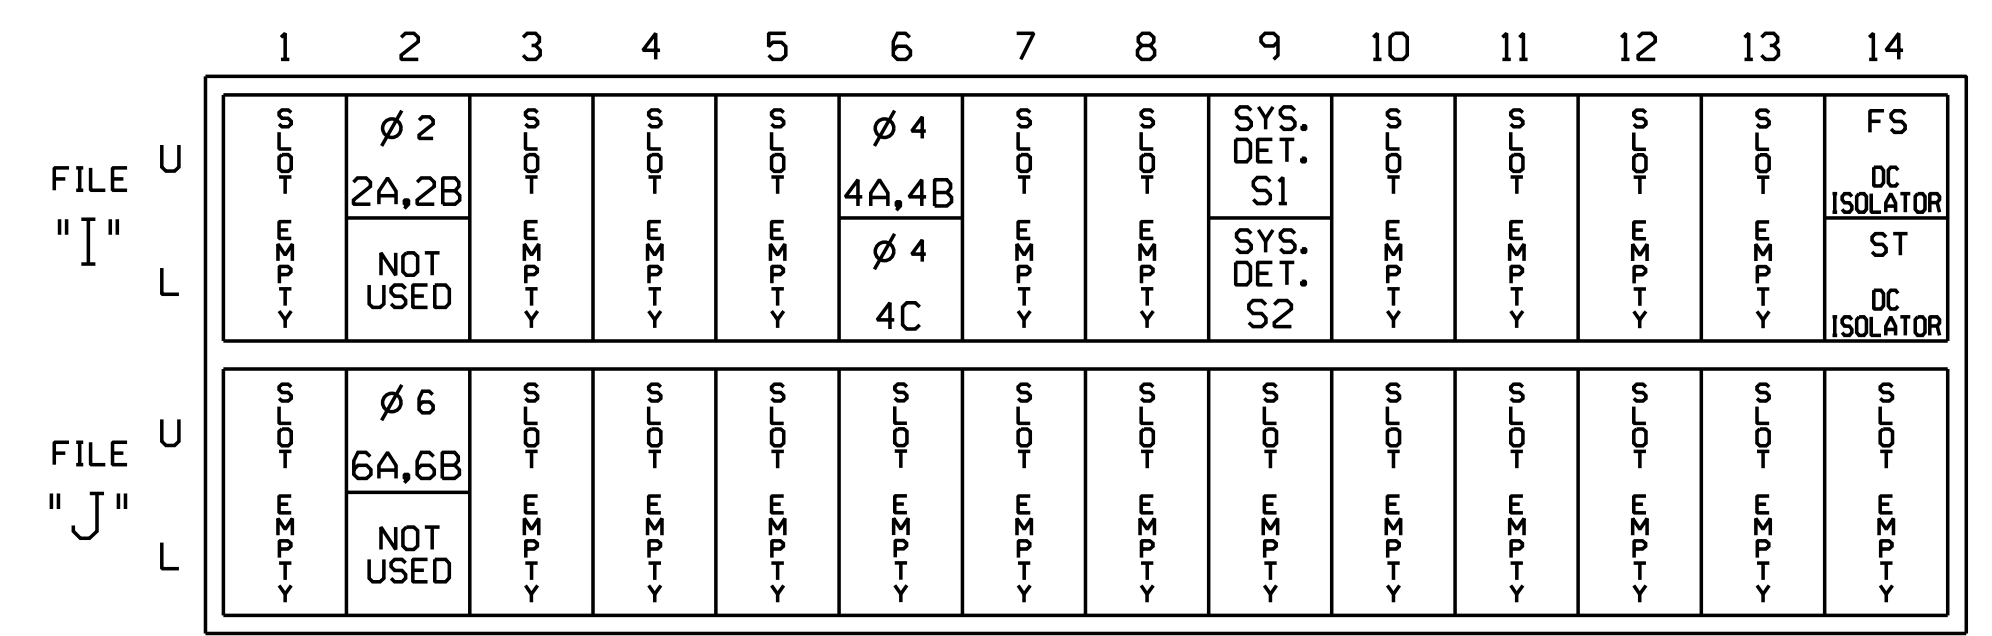

EX.: 1A, 2A, ETC. = LOOP NO.'S


FS = FLASH SENSE
 ST = STOP TIME

INPUT FILE CONNECTION & PROGRAMMING CHART

LOOP NO.	LOOP TERMINAL	INPUT FILE POS.	PIN NO.	DETECTOR NO.	NEMA PHASE	CALL	EXTEND TIME	DELAY TIME	ADDED INITIAL	DETECTOR TYPE
2A, 2B	TB2-5,6	I2U	39	2	2	YES			X	N
4A, 4B	TB4-9,10	I6U	41	4	4	YES				S
4C	TB4-11,12	I6L	45	14	4	YES		15		S
* S1	TB6-9,10	I9U	60	11	SYS	NO				N
* S2	TB6-11,12	I9L	62	13	SYS	NO				N
6A, 6B	TB3-5,6	J2U	40	6	6	YES			X	N

* System detector only. Remove any assigned vehicle phase.

INPUT FILE POSITION LEGEND: J2L

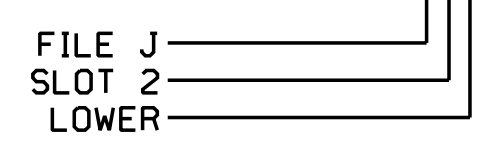

THIS ELECTRICAL DETAIL IS FOR THE SIGNAL DESIGN: 07-1066
 DESIGNED: April 2018
 SEALED: 6/13/2018
 REVISED: NA

2:52:37 PM 11/13/2018 - Burlington-Graham Signal System06 Working Folders (Replace Sub-folders with NCDOT File Structure if Working on NCDOT Project)dwg or DgnW07-1066-071066.ele.dsn.dgn jbvoso

Mattern & Craig
 ENGINEERS-SURVEYORS
 12 BROAD STREET
 ASHEVILLE, NORTH CAROLINA 28801
 (828) 254-2201
 FAX (828) 254-4562
 NC LIC. NO. C-1154

Electrical Detail

ELECTRICAL AND PROGRAMMING DETAILS FOR:
 Prepared for the Offices of:

 750 N. Greenfield Pkwy, Corner, NC 27529

NC 49 (Maple Avenue) at I-85 NB/I-40 EB Ramps


Division 7	Alamance County	Burlington
PLAN DATE: April 2018	REVIEWED BY: JB Voso	
PREPARED BY: SE Greene	REVIEWED BY:	
REVISIONS	INIT.	DATE

DOCUMENT NOT CONSIDERED FINAL UNLESS ALL SIGNATURES COMPLETED

SEAL

 James Voso
 6/13/2018
 DATE
 SIG. INVENTORY NO. 07-1066

PHASING DIAGRAM

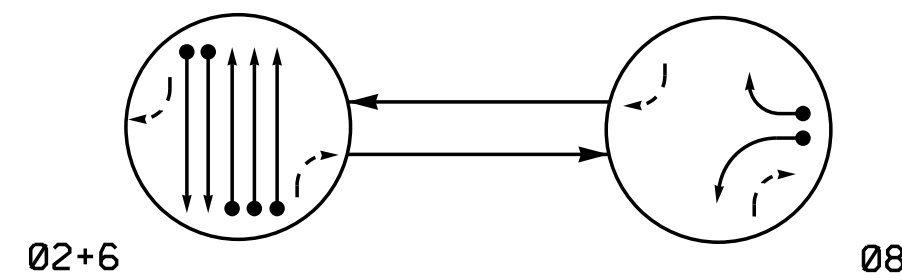

PHASING DIAGRAM DETECTION LEGEND


- ←●→ DETECTED MOVEMENT
- ←○→ UNDETECTED MOVEMENT (OVERLAP)
- ←- - -→ UNSIGNALIZED MOVEMENT
- ←- - -> PEDESTRIAN MOVEMENT

TABLE OF OPERATION

SIGNAL FACE	PHASE		
	02+6	08	FLASH
21, 22	G	R	Y
61, 62	G	R	Y
81, 82	R	G	R

SIGNAL FACE I.D.

 All Heads L.E.D.



21, 22
61, 62
81, 82

ASC/3 DETECTOR INSTALLATION CHART

LOOP	SIZE (FT)	DISTANCE FROM STOPBAR (FT)	TURNS	NEW LOOP	PROGRAMMING							
					PHASE	CALLING	EXTEND TIME	DELAY TIME	USE ADDED INITIAL	TYPE	SYSTEM LOOP	NEW CARD
2A	6x22	70	EXIST.	-	2	Yes	-	-	-	S	-	X
6A	6x32	70	EXIST.	-	6	Yes	-	-	-	S	-	X
S1	6x6	+125	EXIST.	-	-	No	-	-	-	N	X	X
S2	6x6	+125	EXIST.	-	-	No	-	-	-	N	X	X
8A	6x40	0	2-4-2	-	8	Yes	-	-	-	S	-	X
8B	6x40	0	2-4-2	-	8	Yes	-	15	-	S	-	X


2 Phase Fully Actuated (Burlington-Graham Signal System)

NOTES

- Refer to "Roadway Standard Drawings NCDOT" dated January 2018 and "Standard Specifications for Roads and Structures" dated January 2018.
- Do not program signal for late night flashing operation unless otherwise directed by the Engineer.
- Set all detector units to presence mode.
- In the event of loop replacement, refer to the current ITS and Signals Design Manual and submit a Plan of Record to the Signal Design Section.
- Locate new cabinet so as not to obstruct sight distance of vehicles turning right on red.
- The cabinet should be designed to include an Auxiliary Output file for future use.
- Pavement markings are existing.
- Maximum times shown in timing chart are for free-run operation only. Coordinated signal system timing values supersede these values.

FEATURE	PHASE		
	2	6	8
Min Green *	10	10	7
Walk *	0	0	0
Ped Clear	0	0	0
Veh. Extension *	3.0	3.0	1.0
Max 1 *	45	45	25
Yellow	3.9	3.8	3.0
Red Clear	1.0	1.2	2.6
Actuations B4 Add *	-	-	-
Seconds / Actuation *	-	-	-
Max Initial *	-	-	-
Time Before Reduction *	-	-	-
Time To Reduce *	-	-	-
Minimum Gap	-	-	-
Locking Detector	X	X	-
Recall Position	VEH. RECALL	VEH. RECALL	-
Dual Entry	-	-	-
Simultaneous Gap	X	X	X

* These values may be field adjusted. Do not adjust Min Green and Extension times for phases 2 and 6 lower than what is shown. Min Green for all other phases should not be lower than 4 seconds.

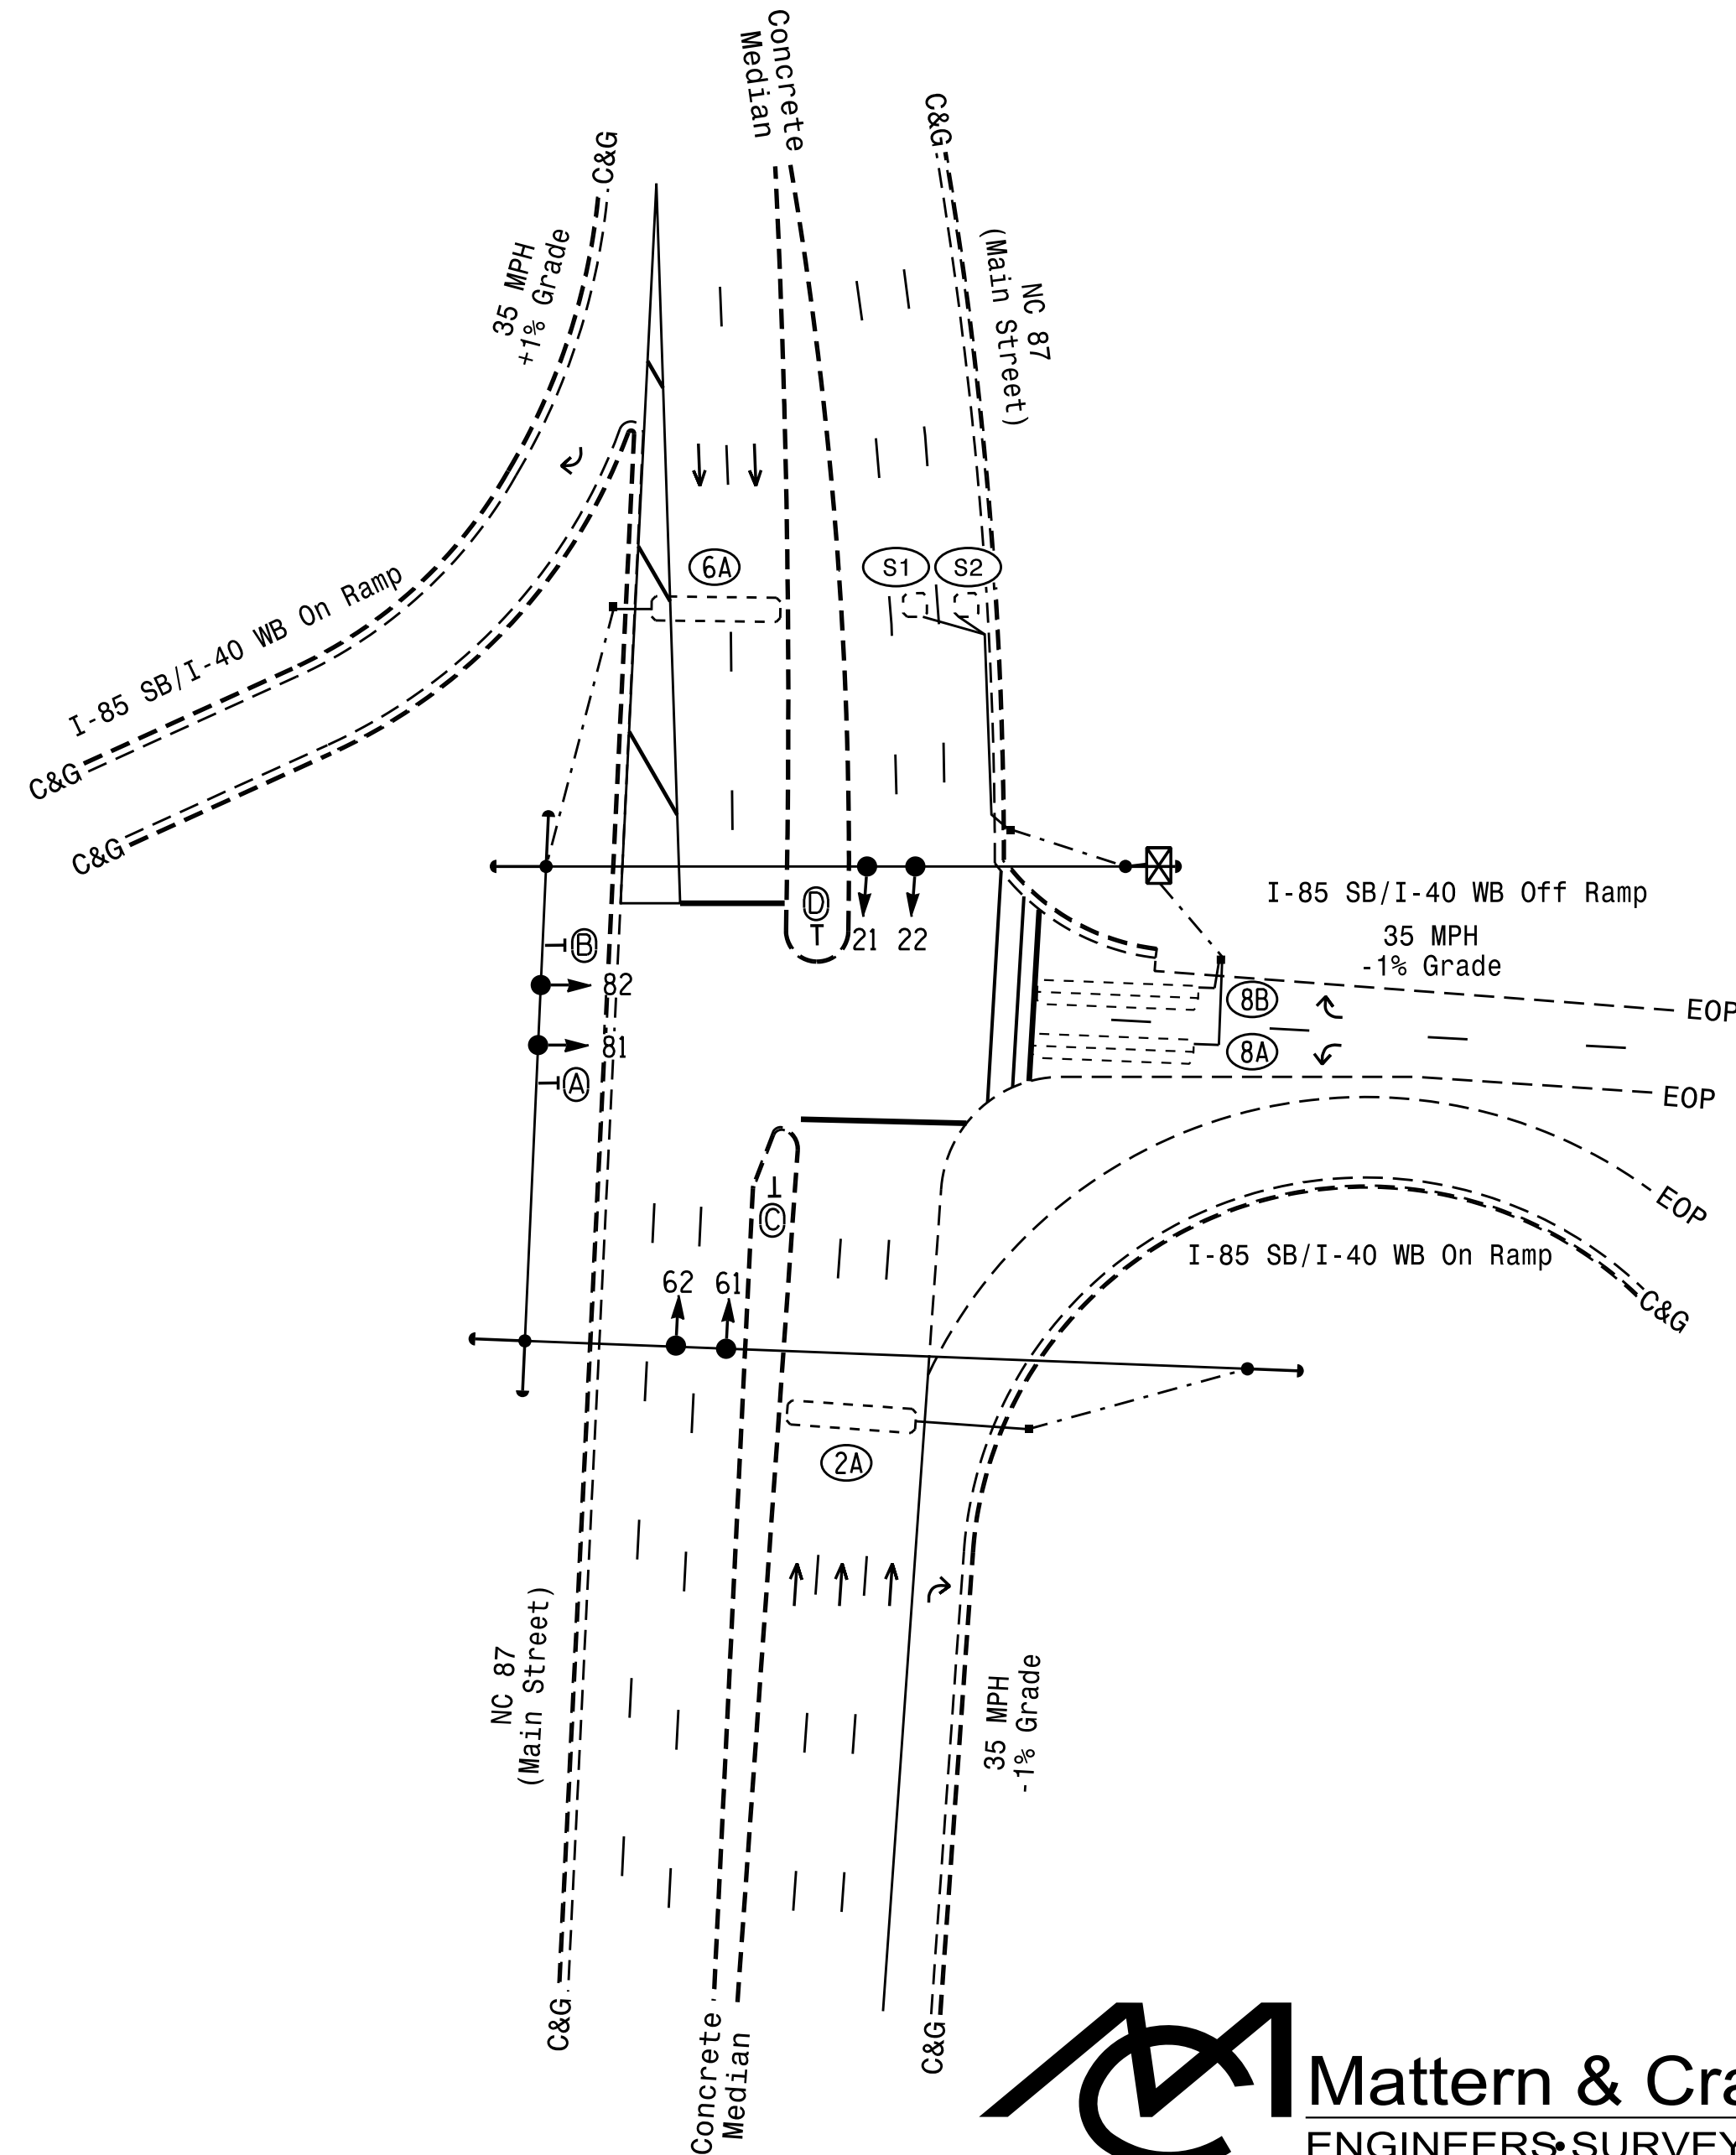


PROPOSED	EXISTING
	N/A
N/A	
(A) Left Arrow "ONLY" Sign (R3-5L)	(A) Left Arrow "ONLY" Sign (R3-5L)
(B) Right Arrow "ONLY" Sign (R3-5R)	(B) Right Arrow "ONLY" Sign (R3-5R)
(C) No U-Turn Sign (R3-4)	(C) No U-Turn Sign (R3-4)
(D) No Left Turn Sign (R3-2)	(D) No Left Turn Sign (R3-2)

Signal Upgrade



12 BROAD STREET
ASHEVILLE, NORTH CAROLINA 28801
(828) 254-2201
FAX (828) 254-4562
NC LIC. NO. C-1154

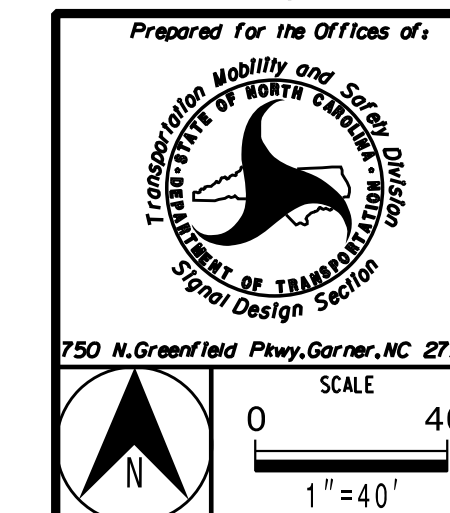


NC 87 (Main Street) at I-85 SB/I-40 WB Off-Ramp	
Division 7 Alamance County	Graham
PLAN DATE: March 2018	REVIEWED BY: JB Vosso
PREPARED BY: SE Greene	REVIEWED BY:
REVISIONS	INIT. DATE

DOCUMENT NOT CONSIDERED FINAL UNLESS ALL SIGNATURES COMPLETED

SEAL	DATE
	6/13/2018
SIGNATURE	DATE
James B. Vosso	6/13/2018
SIG. INVENTORY NO.	07-1067

EDI MODEL 2018ECLIP-NC CONFLICT MONITOR
PROGRAMMING DETAIL
(remove jumpers and set switches as shown)

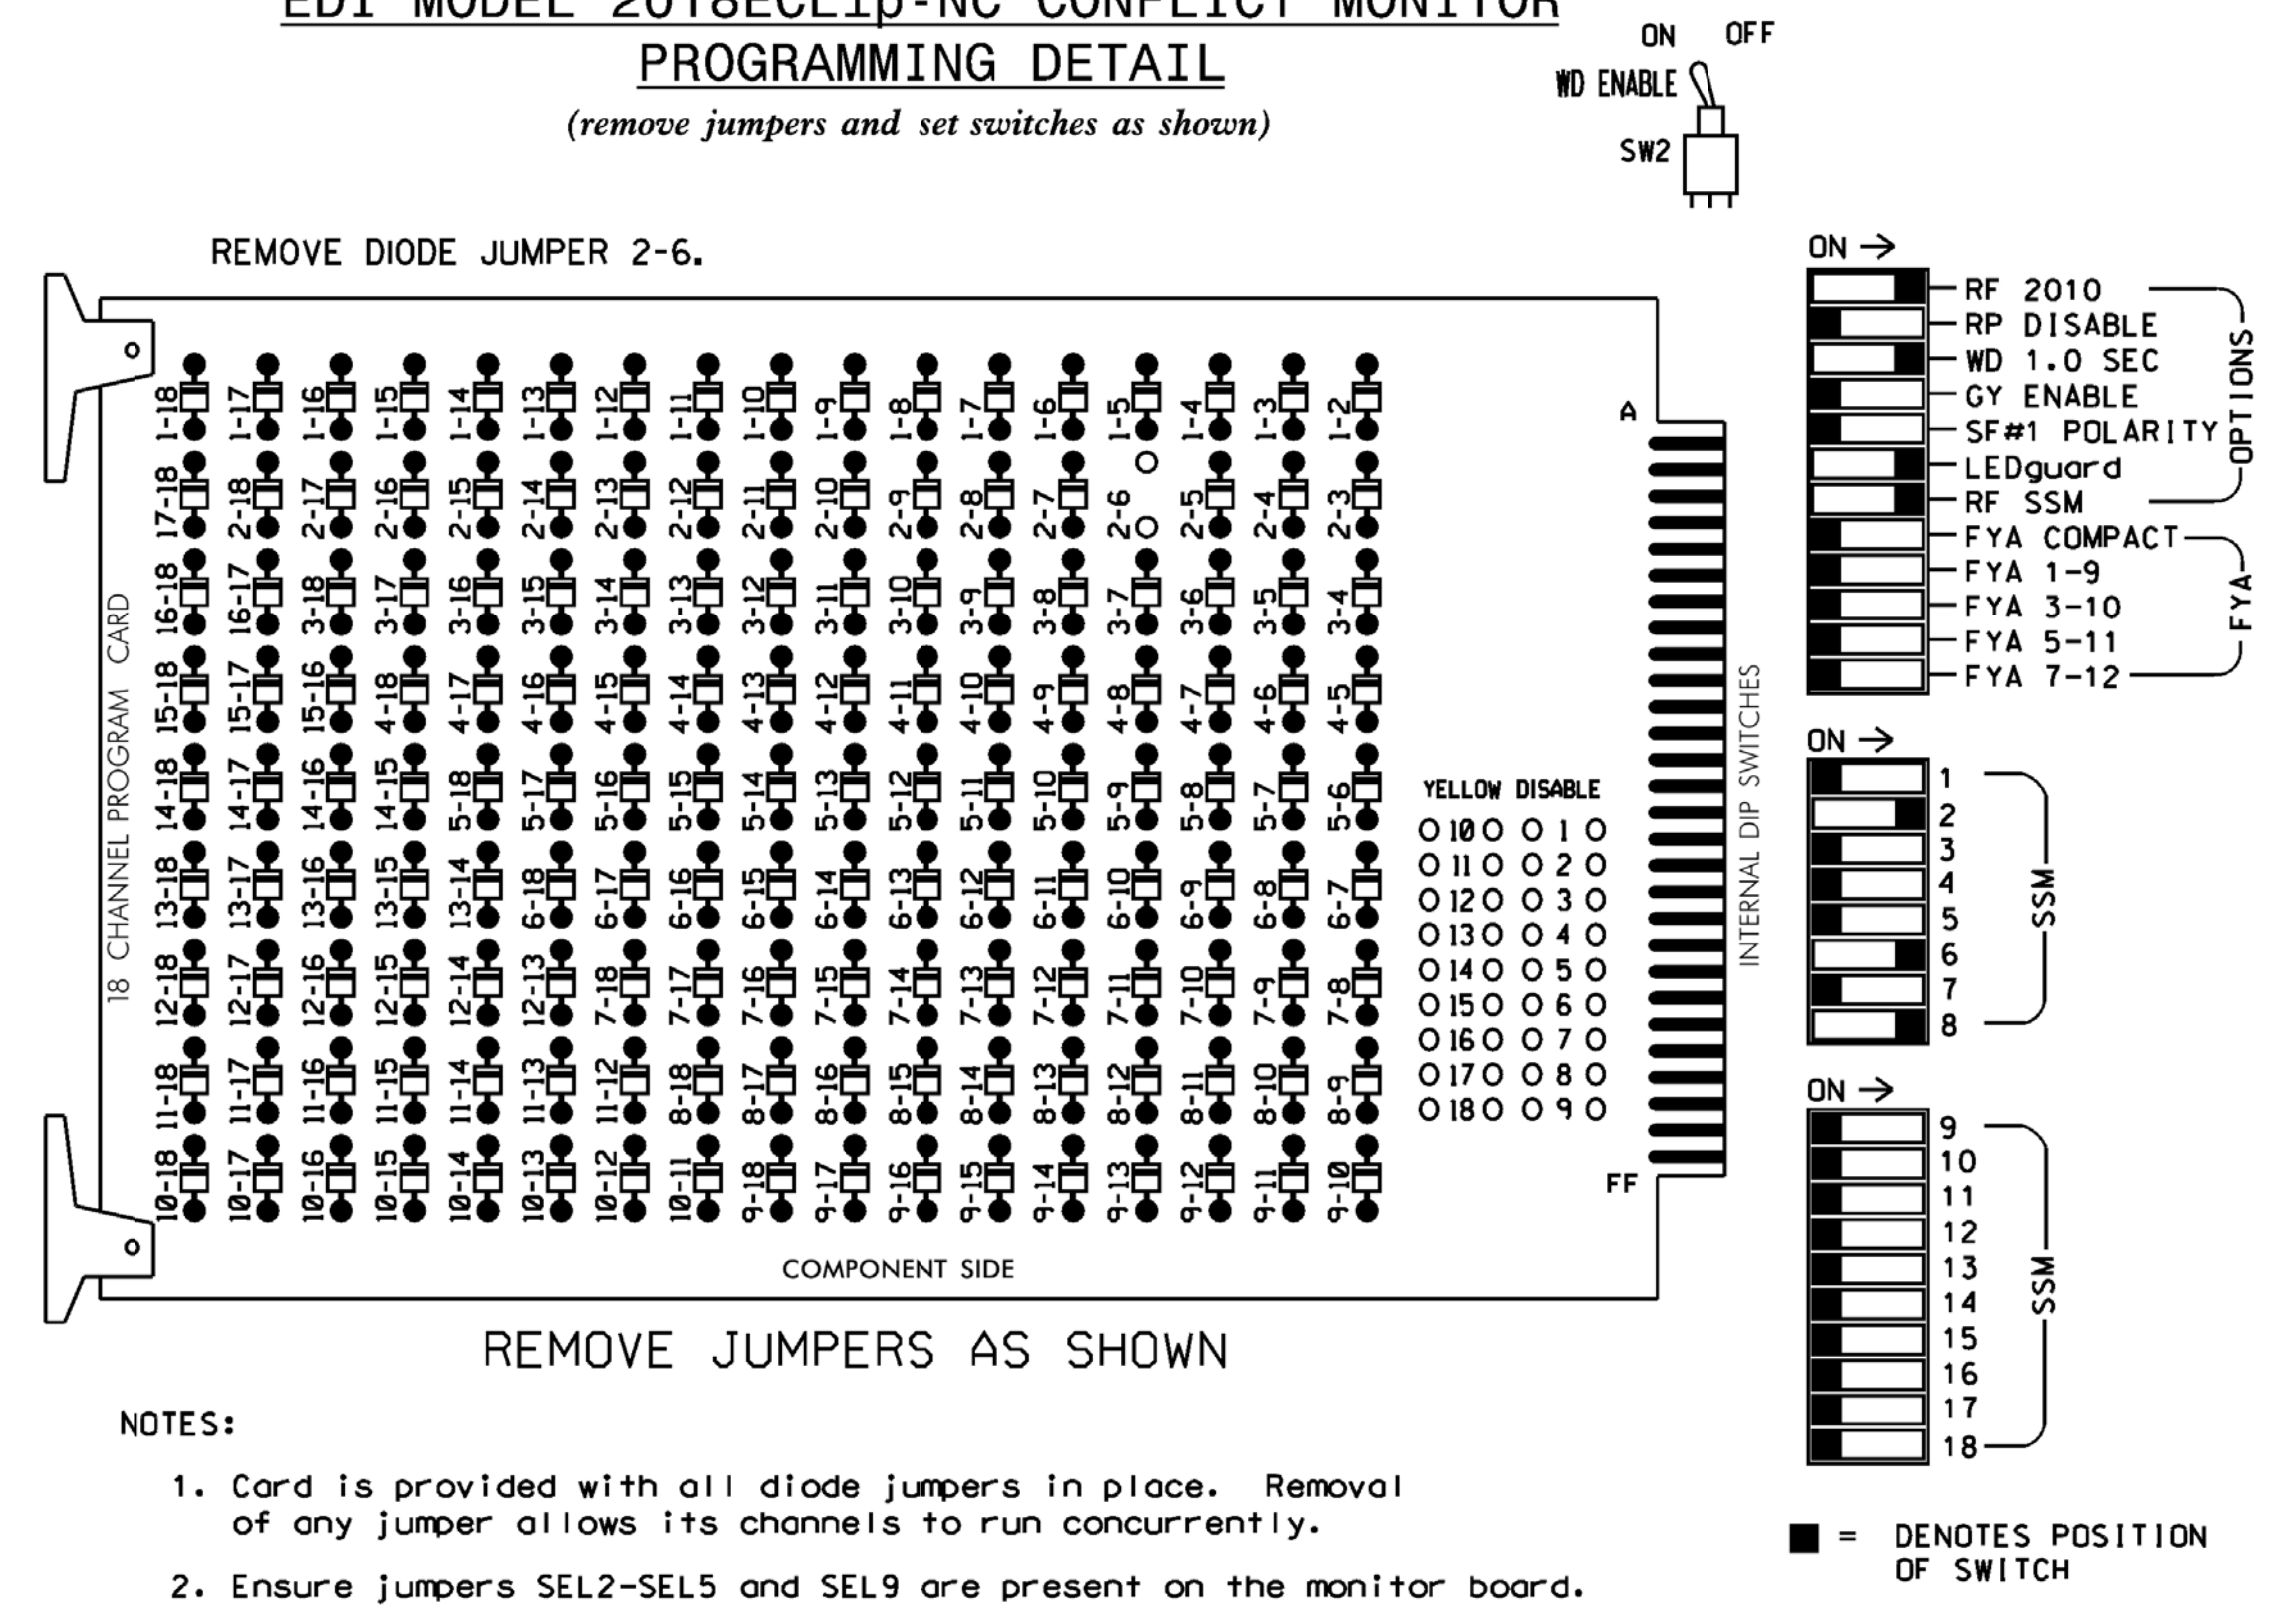

- NOTES:
- Card is provided with all diode jumpers in place. Removal of any jumper allows its channels to run concurrently.
 - Ensure jumpers SEL2-SEL5 and SEL9 are present on the monitor board.
 - Ensure that Red Enable is active at all times during normal operation.
 - Integrate monitor with Ethernet network in cabinet.

NOTES

- To prevent "flash-conflict" problems, insert red flash program blocks for all unused vehicle load switches in the output file. The installer shall verify that signal heads flash in accordance with the Signal Plans.
- Program controller to start up in phase 2 Green and 6 Green.
- The cabinet and controller are part of the Burlington-Graham Signal System.

SIGNAL HEAD HOOK-UP CHART


LOAD SWITCH NO.	S1	S2	S3	S4	S5	S6	S7	S8	S9	S10	S11	S12	AUX S1	AUX S2	AUX S3	AUX S4	AUX S5	AUX S6
CMU CHANNEL NO.	1	2	13	3	4	14	5	6	15	7	8	16	9	10	17	11	12	18
PHASE	1	2	2 PED	3	4	4 PED	5	6	6 PED	7	8	8 PED	OLA	OLB	SPARE	OLC	OLD	SPARE
SIGNAL HEAD NO.	NU	21,22	NU	NU	NU	NU	NU	61,62	NU	NU	81,82	NU	NU	NU	NU	NU	NU	NU
RED		128						134			107							
YELLOW		129						135			108							
GREEN		130						136			109							
RED ARROW																		
YELLOW ARROW																		
FLASHING YELLOW ARROW																		
GREEN ARROW																		

NU = Not Used

EQUIPMENT INFORMATION

CONTROLLER.....2070LX
 CABINET.....332 W/AUX
 SOFTWARE.....ECONOLITE ASC/3-2070
 CABINET MOUNT.....BASE
 OUTPUT FILE POSITIONS...18 WITH AUX. OUTPUT FILE
 LOAD SWITCHES USED.....S2,S8,S11
 PHASES USED.....2,6,8
 OVERLAP "A".....NOT USED
 OVERLAP "B".....NOT USED
 OVERLAP "C".....NOT USED
 OVERLAP "D".....NOT USED


INPUT FILE POSITION LAYOUT

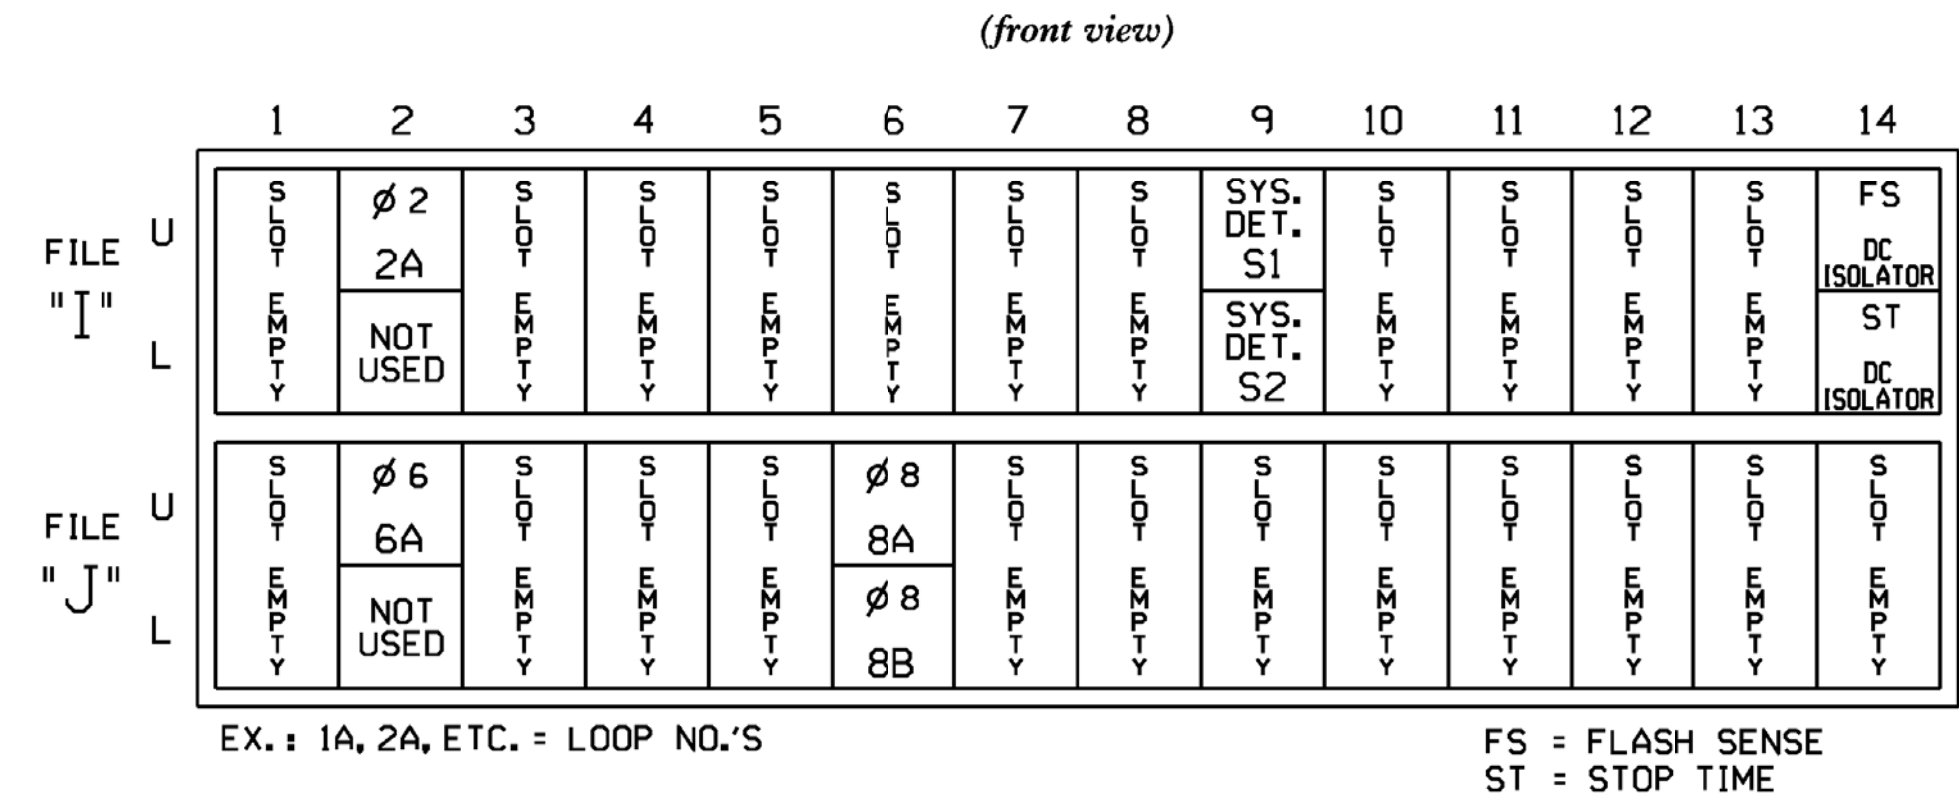

INPUT FILE CONNECTION & PROGRAMMING CHART

LOOP NO.	LOOP TERMINAL	INPUT FILE POS.	PIN NO.	DETECTOR NO.	NEMA PHASE	CALL	EXTEND TIME	DELAY TIME	ADDED INITIAL	DETECTOR TYPE
2A	TB2-5,6	I2U	39	2	2	YES				S
* S1	TB6-9,10	I9U	60	11	SYS	NO				N
* S2	TB6-11,12	I9L	62	13	SYS	NO				N
6A	TB3-5,6	J2U	40	6	6	YES				S
8A	TB5-9,10	J6U	42	8	8	YES				S
8B	TB5-11,12	J6L	46	18	8	YES		15		S

* System detector only. Remove any assigned vehicle phase.

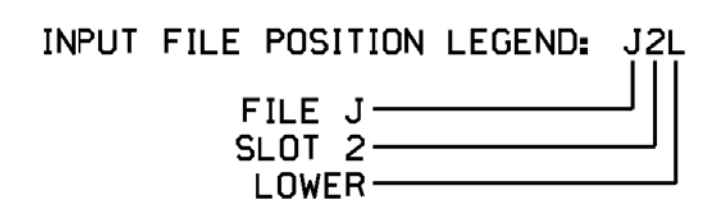

THIS ELECTRICAL DETAIL IS FOR
 THE SIGNAL DESIGN: 07-1067
 DESIGNED: March 2018
 SEALED: 6/13/2018
 REVISED: NA

*****SYTIME*****
 *****D*****
 *****USER*****

Mattern & Craig
 ENGINEERS • SURVEYORS
 12 BROAD STREET
 ASHEVILLE, NORTH CAROLINA 28801
 (828) 254-2201
 FAX (828) 254-4562
 NC LIC. NO. C-1154

Electrical Detail

DOCUMENT NOT CONSIDERED FINAL UNLESS ALL SIGNATURES COMPLETED


SEAL
 NORTH CAROLINA PROFESSIONAL ENGINEER
 JAMES B. VOSE
 SEAL 022599

Division 7 Alamance County Graham
 PLAN DATE: March 2018 REVIEWED BY: JB Voso
 PREPARED BY: SE Greene REVIEWED BY:
 REVISIONS INIT. DATE

James Voso 6/13/2018
 DATE

SIG. INVENTORY NO. 07-1067

PHASING DIAGRAM

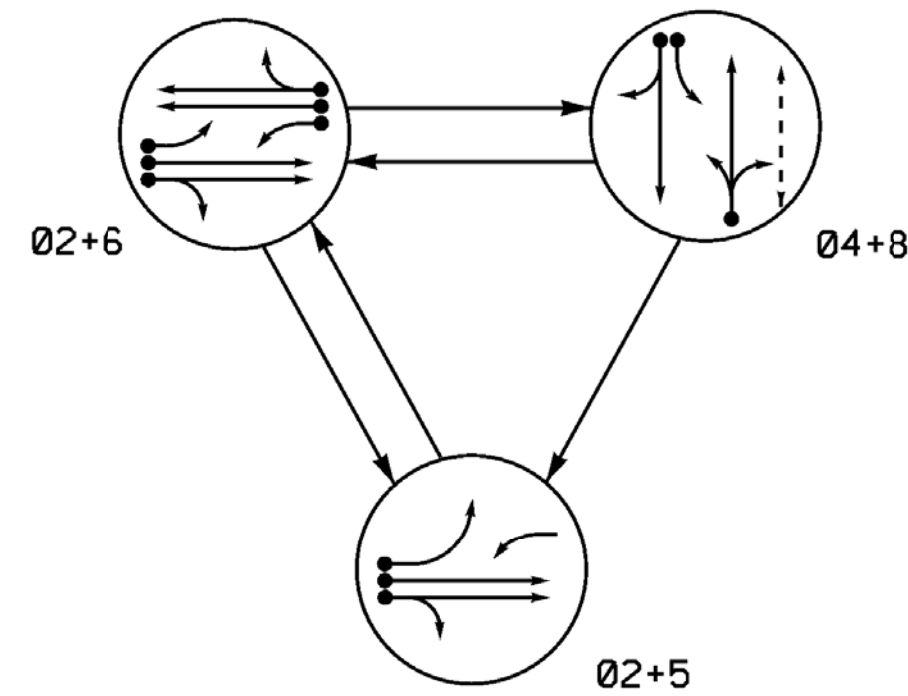

SIGNAL FACE	PHASE			
	02+5	02+6	04+8	FLASH
21, 22	G	G	R	Y
41, 42	R	R	G	R
51	-	F	R	-
61	F	F	R	-
62, 63	R	G	R	Y
81, 82	R	R	G	R
P81, P82	DW	DW	W	DRK

ASC/3 DETECTOR INSTALLATION CHART												
LOOP	DETECTOR				PROGRAMMING							
	SIZE (FT)	DISTANCE FROM STOPBAR (FT)	TURNS	NEW LOOP	PHASE	CALLING	EXTEND TIME	DELAY TIME	USE ADDED INITIAL	TYPE	SYSTEM LOOP	NEW CARD
2A	6x22	300	EXIST.	-	2	Yes	-	-	X	N	-	X
4A	6x60	+5	2-4-2	-	4	Yes	-	3	-	S	-	X
4B	6x60	+5	2-4-2	-	4	Yes	-	10	-	S	-	X
5A	6x60	+5	EXIST.	-	5	Yes	-	15	-	S	-	X
6A	6x22	300	EXIST.	-	6	Yes	-	3	-	G	-	X
8A	6x60	+10	2-4-2	-	8	Yes	-	5	-	S	-	X
S1	6x6	1184	EXIST.	-	-	No	-	-	-	N	X	X
S2	6x6	1184	EXIST.	-	-	No	-	-	-	N	X	X

3 Phase Fully Actuated (Burlington-Graham Signal System)




NOTES

- Refer to "Roadway Standard Drawings NCDOT" dated January 2018 and "Standard Specifications for Roads and Structures" dated January 2018.
- Do not program signal for late night flashing operation unless otherwise directed by the Engineer.
- Phase 5 may be lagged.
- Reposition existing signal heads numbered 22, 62, and 63.
- Set all detector units to presence mode.
- In the event of loop replacement, refer to the current ITS and Signals Design Manual and submit a Plan of Record to the Signal Design Section.
- Locate new cabinet so as not to obstruct sight distance of vehicles turning right on red.
- Omit "WALK" and flashing "DON'T WALK" with no pedestrian calls.
- Program pedestrian heads to countdown the flashing "Don't Walk" time only.
- Existing Left Arrow "ONLY" (R3-5L) and "LEFT TURN YIELD ON GREEN" ball (R10-12) signs may be removed at the discretion of the Regional Traffic Engineer.
- Pavement markings are existing.
- Maximum times shown in timing chart are for free-run operation only. Coordinated signal system timing values supersede these values.

SIGNAL FACE I.D.

All Heads L.E.D.


PHASING DIAGRAM DETECTION LEGEND

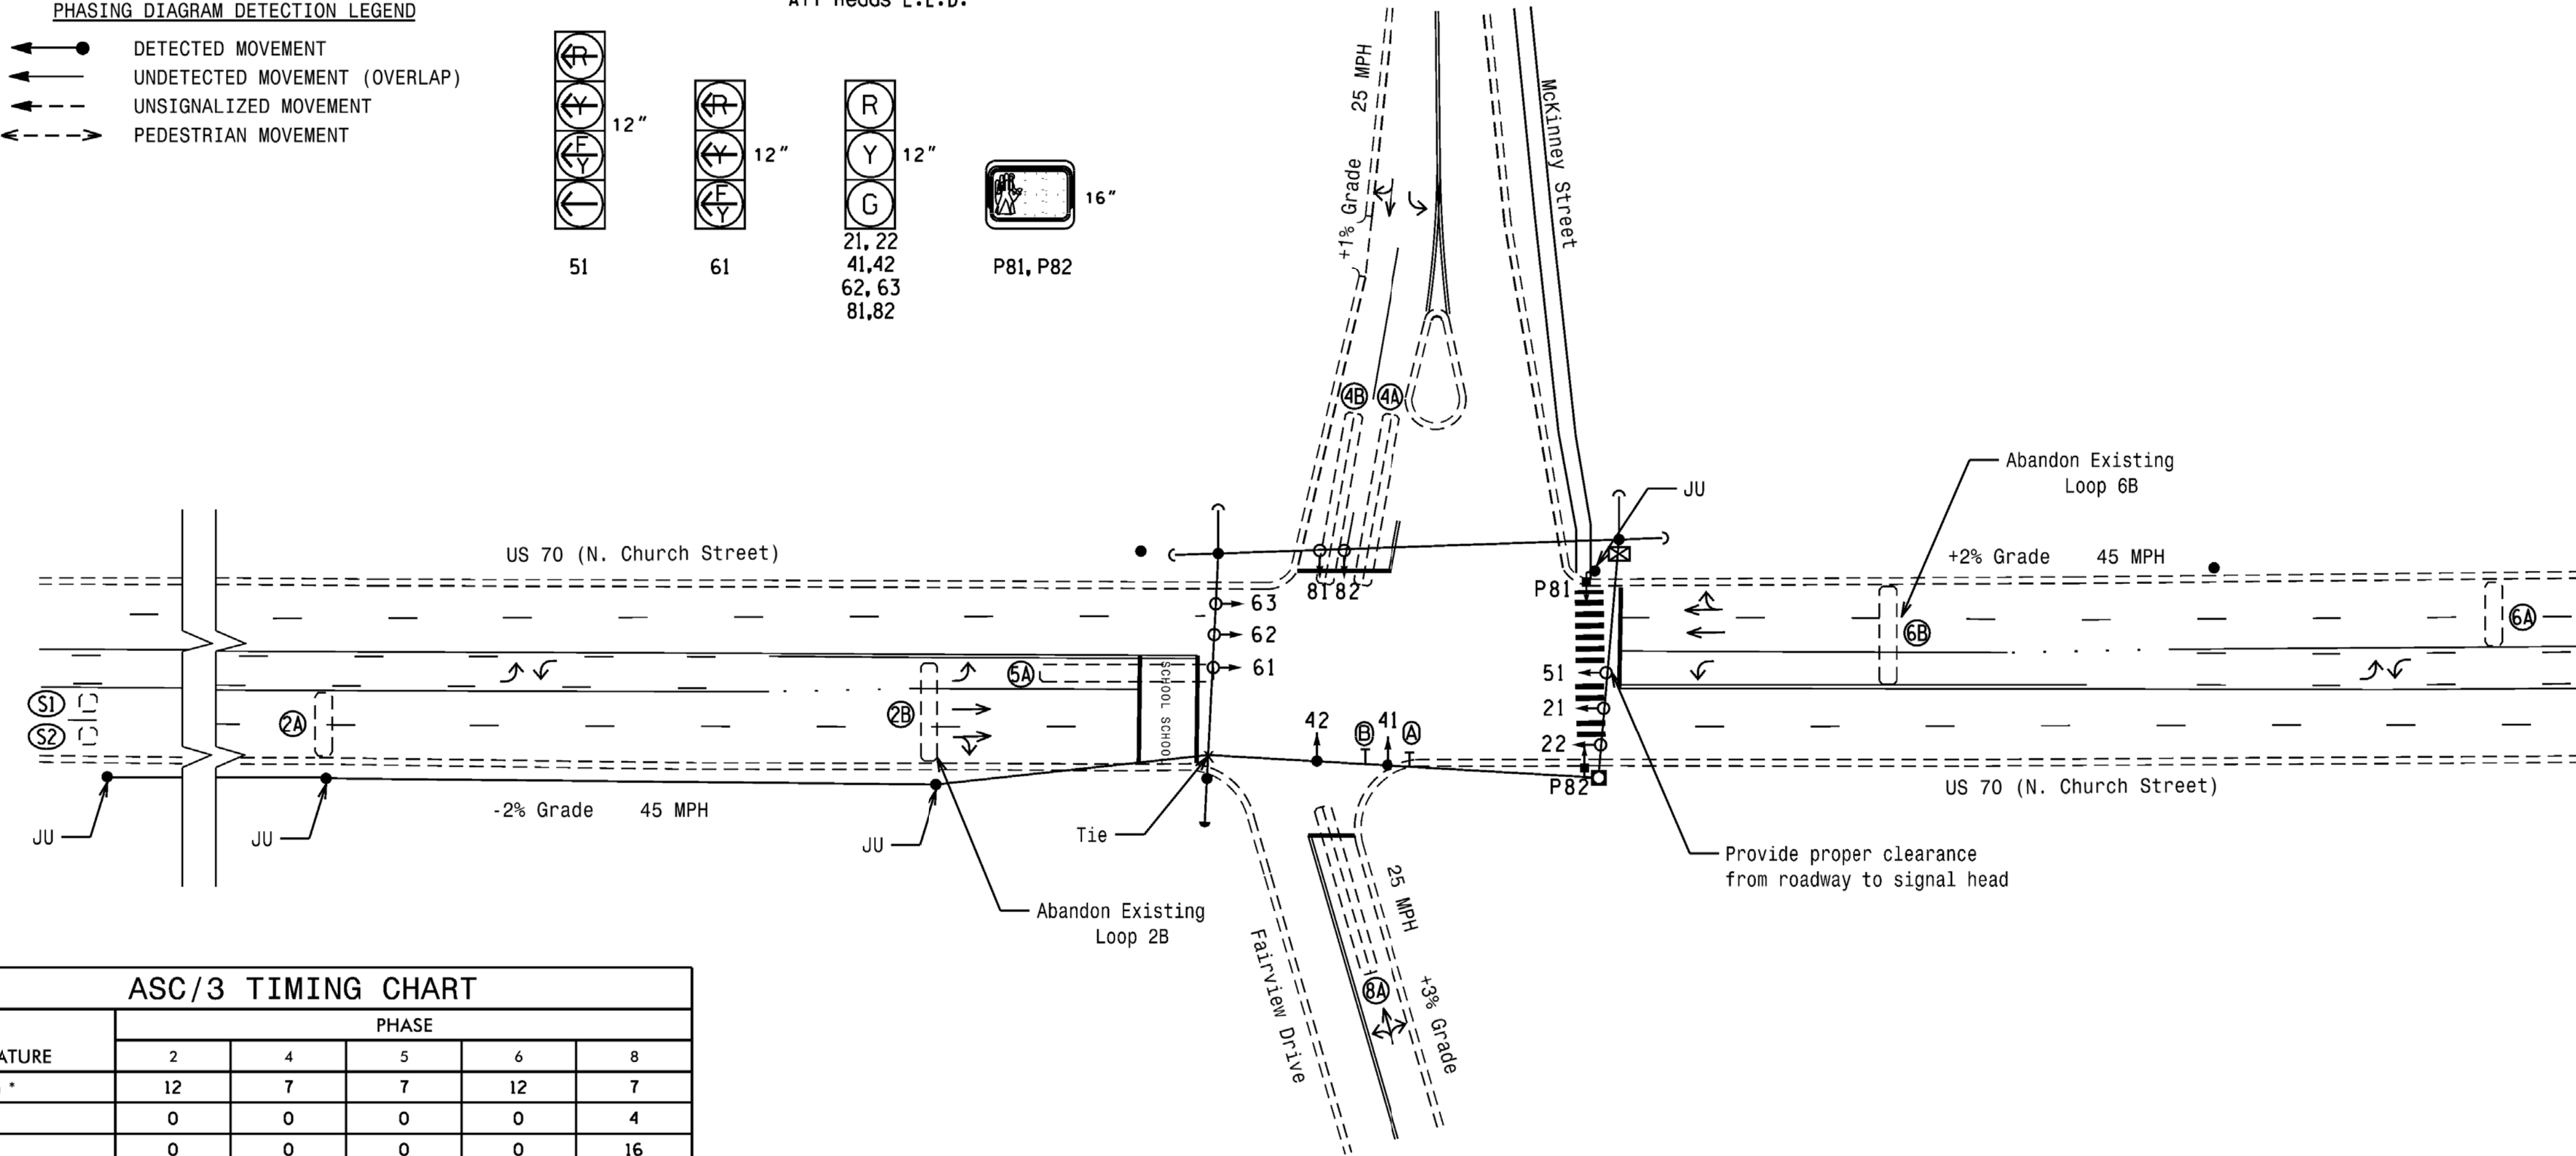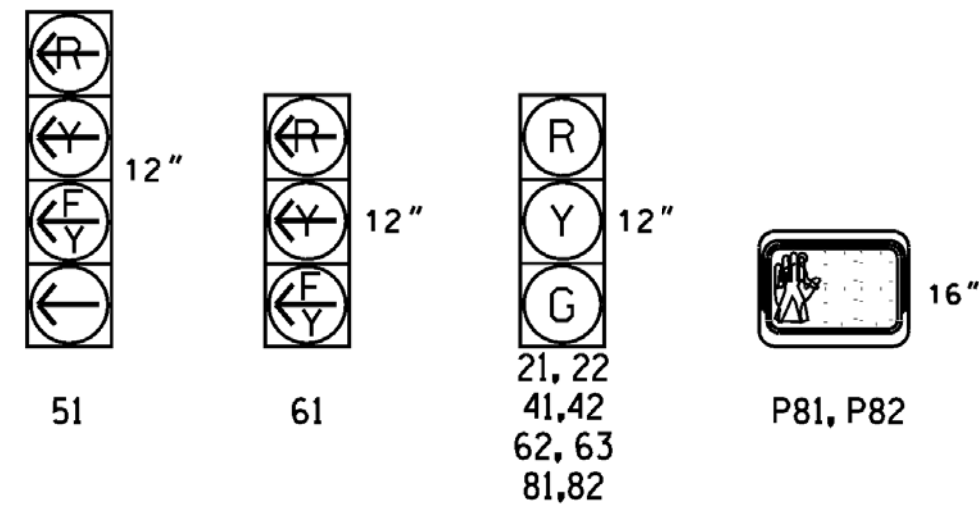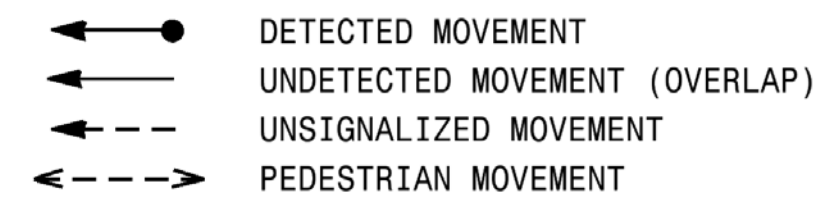

ASC/3 TIMING CHART

FEATURE	PHASE				
	2	4	5	6	8
Min Green *	12	7	7	12	7
Walk *	0	0	0	0	4
Ped Clear	0	0	0	0	16
Veh. Extension *	6.0	1.0	1.0	6.0	1.0
Max I *	90	25	15	90	25
Yellow	4.7	3.1	3.0	4.7	3.1
Red Clear	2.4	3.1	2.8	2.4	2.8
Actuations 34 Add *	0	-	-	0	-
Seconds /Actuation *	1.5	-	-	1.5	-
Max Initial *	34	-	-	34	-
Time Before Reduction *	30	-	-	30	-
Time To Reduce *	30	-	-	30	-
Minimum Gap	3.0	-	-	3.0	-
Locking Detector	X	-	-	X	-
Recall Position	VEH. RECALL	-	-	VEH. RECALL	-
Dual Entry	-	X	-	-	X
Simultaneous Gap	X	X	X	X	X

* These values may be field adjusted. Do not adjust Min Green and Extension times for phases 2 and 6 lower than what is shown. Min Green for all other phases should not be lower than 4 seconds.

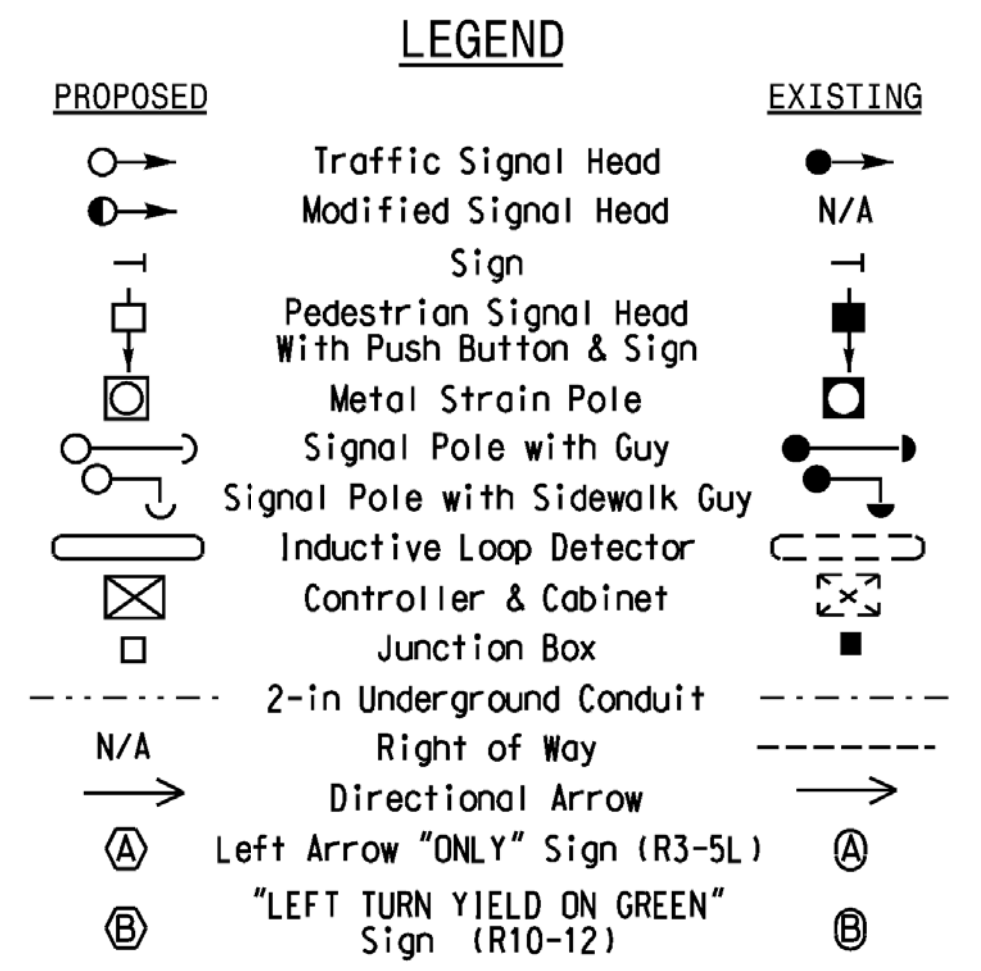

Mattern & Craig
ENGINEERS • SURVEYORS

12 BROAD STREET
ASHEVILLE, NORTH CAROLINA 28801
(828) 254-2201
FAX (828) 254-4562
NC LIC. NO. C-1154

Signal Upgrade

Prepared for the Offices of:

US 70 (N. Church Street) at McKinney Street/Fairview Drive

Division 7 Alamance County Burlington

PLAN DATE: March 2018 REVIEWED BY: JB Voso

PREPARED BY: SE Greene REVIEWED BY:

REVISIONS

SCALE 1"=40'

DOCUMENT NOT CONSIDERED FINAL UNLESS ALL SIGNATURES COMPLETED

SEAL NORTH CAROLINA PROFESSIONAL ENGINEER JAMES B. VOSS 022599


James Voss 6/13/2018

SIG. INVENTORY NO. 07-1150

*****SYSTEM *****
*****BUSINESS *****

EDI MODEL 2018ECLIP-NC CONFLICT MONITOR PROGRAMMING DETAIL
(remove jumpers and set switches as shown)




REMOVE DIODE JUMPERS 2-5, 2-6, 2-9, 2-11, 4-8, 4-16, 5-9, 5-11, 6-9, 6-11, 8-16, and 9-11.

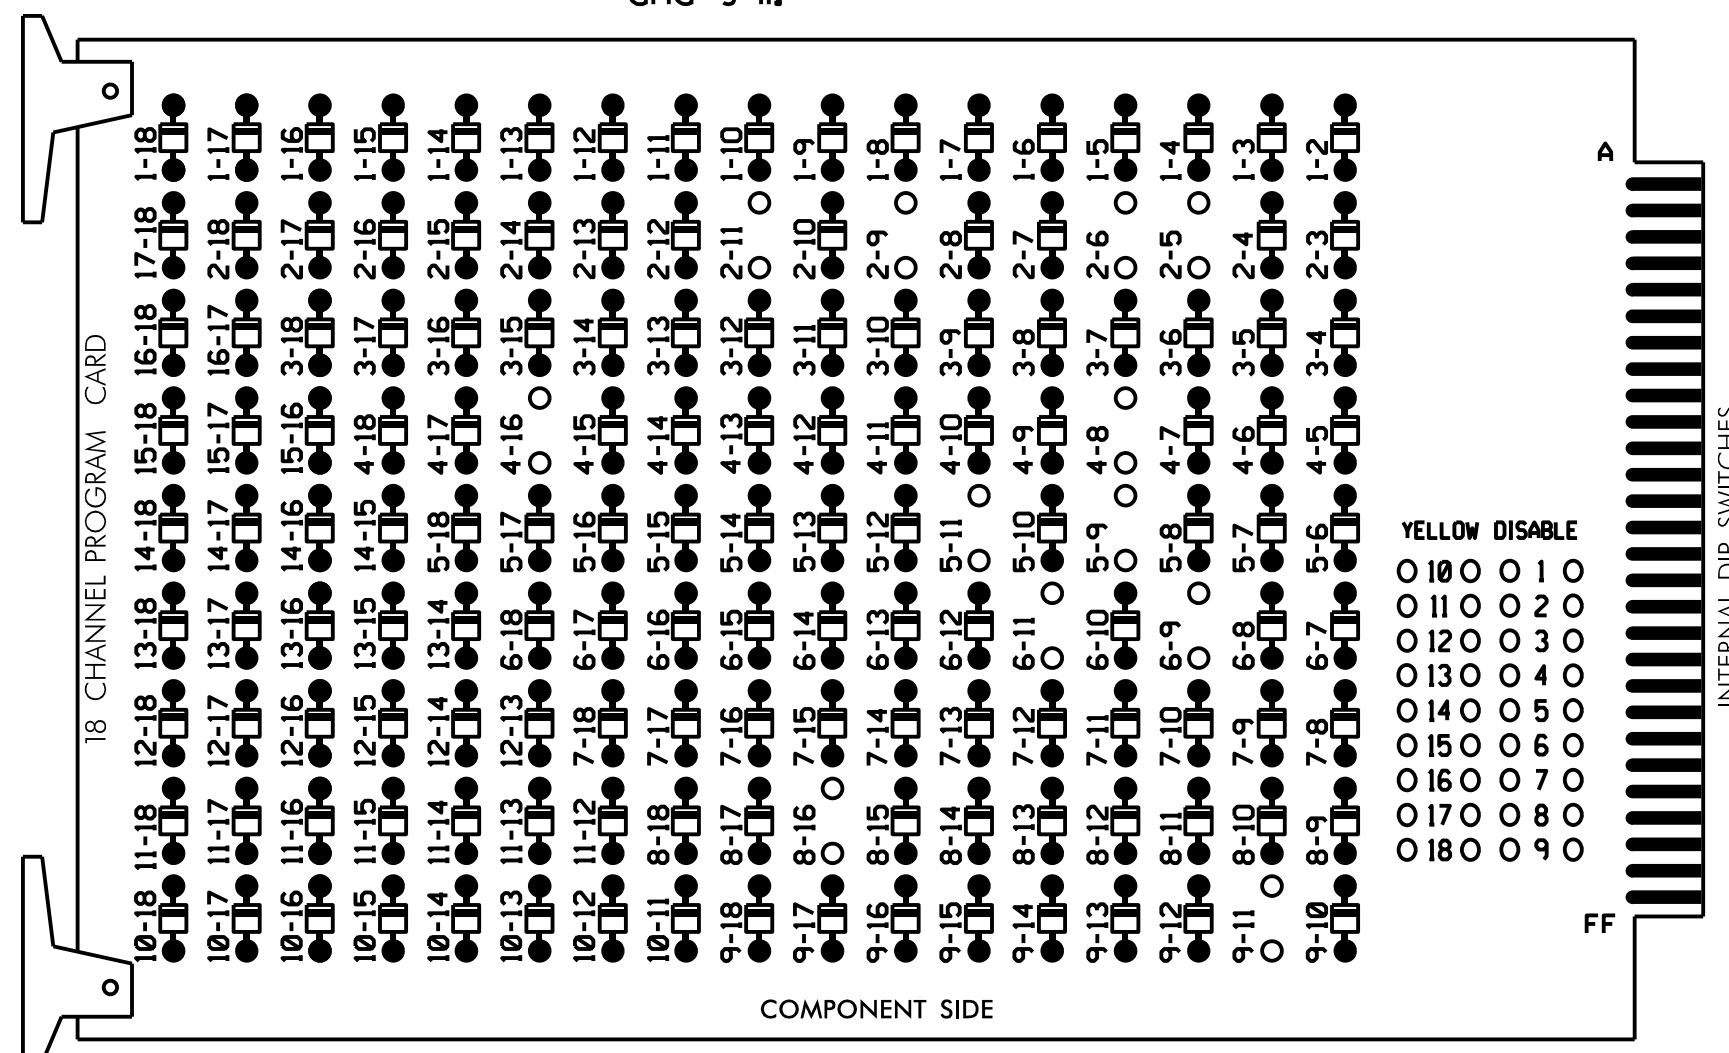

REMOVE JUMPERS AS SHOWN

NOTES:

- Card is provided with all diode jumpers in place. Removal of any jumper allows its channels to run concurrently.
- Ensure jumpers SEL2-SEL5 and SEL9 are present on the monitor board.
- Ensure that Red Enable is active at all times during normal operation.
- Integrate monitor with Ethernet network in cabinet.

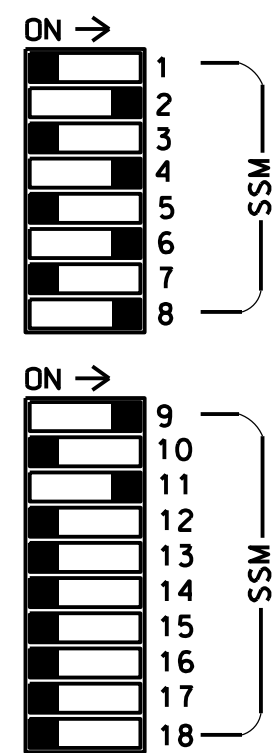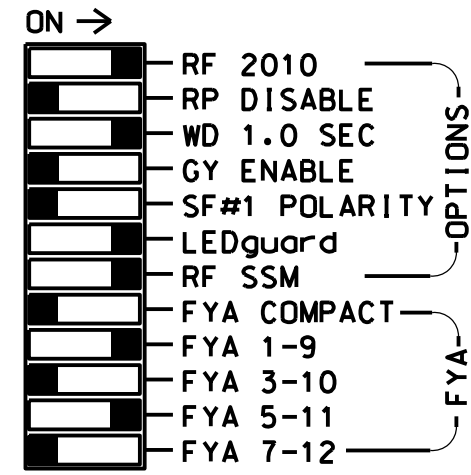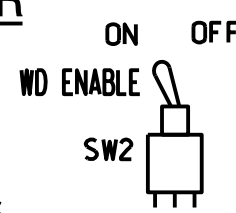

■ = DENOTES POSITION OF SWITCH

NOTES

- To prevent "flash-conflict" problems, insert red flash program blocks for all unused vehicle load switches in the output file. The installer shall verify that signal heads flash in accordance with the Signal Plans.
- Program phases 4 and 8 for Dual Entry.
- Program controller to start up in phase 2 Green and 6 Green.
- The cabinet and controller are part of the Burlington-Graham Signal System.

EQUIPMENT INFORMATION

CONTROLLER.....2070LX
 CABINET.....332 W/AUX
 SOFTWARE.....ECONOLITE ASC/3-2070
 CABINET MOUNT.....BASE
 OUTPUT FILE POSITIONS...18 WITH AUX. OUTPUT FILE
 LOAD SWITCHES USED.....S2,S5,S7,S8,S11,S12,
 AUX S1,AUX S4
 PHASES USED.....2,4,5,6,8,8PED
 OVERLAP "A".....*
 OVERLAP "B".....NOT USED
 OVERLAP "C".....*
 OVERLAP "D".....NOT USED
 * See overlap programming detail on sheet 2

SIGNAL HEAD HOOK-UP CHART

LOAD SWITCH NO.	S1	S2	S3	S4	S5	S6	S7	S8	S9	S10	S11	S12	AUX S1	AUX S2	AUX S3	AUX S4	AUX S5	AUX S6
CMU CHANNEL NO.	1	2	13	3	4	14	5	6	15	7	8	16	9	10	17	11	12	18
PHASE	1	2	2 PED	3	4	4 PED	5	6	6 PED	7	8	8 PED	OLA	OLB	SPARE	OLC	OLD	SPARE
SIGNAL HEAD NO.	NU	21,22	NU	NU	41,42	NU	51*	62,63	NU	NU	81,82	P81, P82	61*	NU	NU	51*	NU	NU
RED		128			101			134			107							
YELLOW		129			102		*	135			108							
GREEN		130			103			136			109							
RED ARROW																A121		A114
YELLOW ARROW																A122		A115
FLASHING YELLOW ARROW																A123		A116
GREEN ARROW								133										
Hand icon												110						
Walking person icon												112						


NU = Not Used

* Denotes install load resistor. See load resistor installation detail this sheet.

* See pictorial of head wiring in detail below.

INPUT FILE POSITION LAYOUT

(front view)

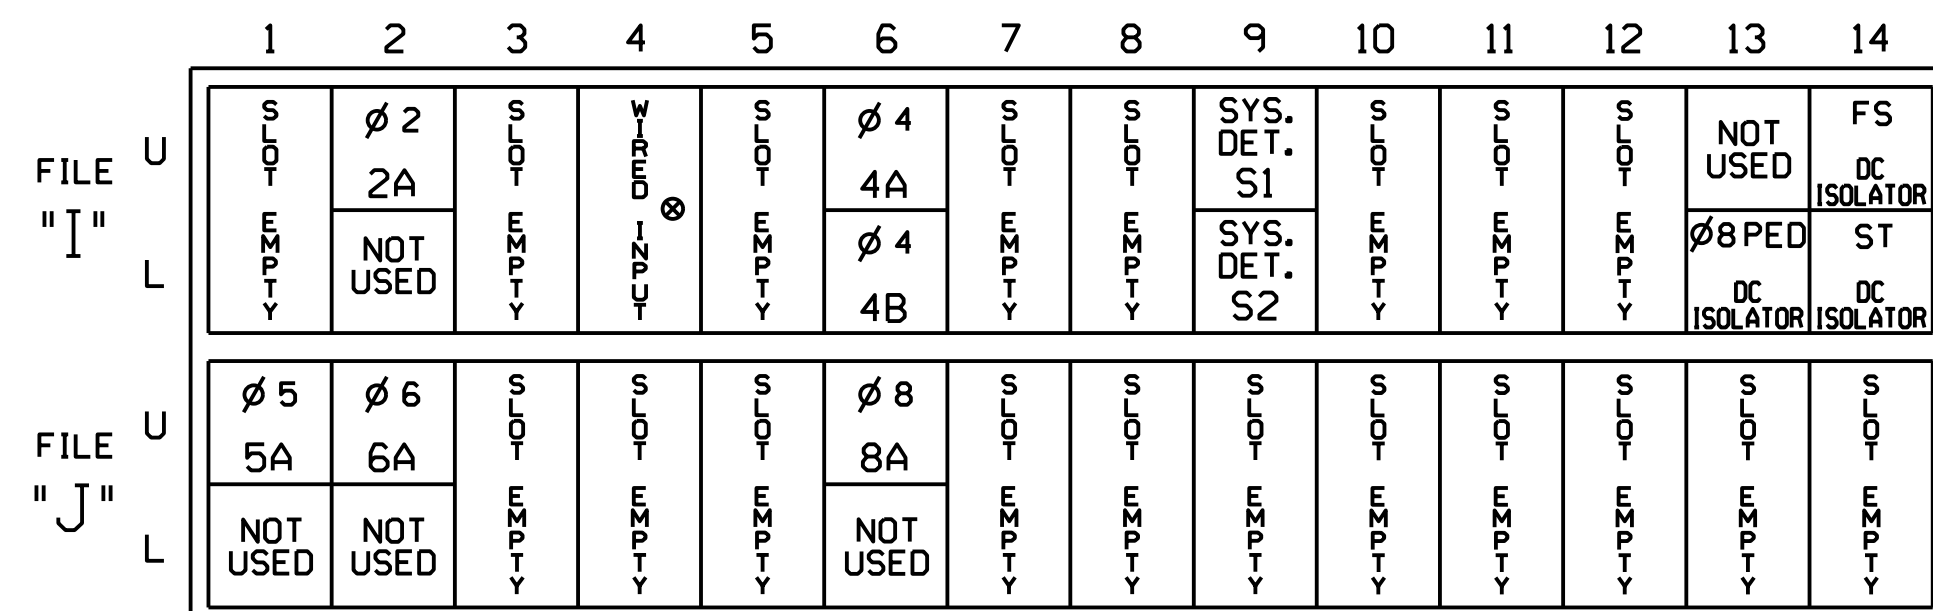

EX.: 1A, 2A, ETC. = LOOP NO.'S

FS = FLASH SENSE
 ST = STOP TIME

* Wired Input - Do not populate slot with detector card


INPUT FILE CONNECTION & PROGRAMMING CHART

LOOP NO.	LOOP TERMINAL	INPUT FILE POS.	PIN NO.	DETECTOR NO.	NEMA PHASE	CALL	EXTEND TIME	DELAY TIME	ADDED INITIAL	DETECTOR TYPE
2A	TB2-5,6	I2U	39	2	2	YES	-		X	N
4A	TB4-9,10	I6U	41	4	4	YES		3		S
4B	TB4-11,12	I6L	45	14	4	YES		10		S
* S1	TB6-9,10	I9U	60	11	SYS	NO				N
* S2	TB6-11,12	I9L	62	13	SYS	NO				N
5A ¹	TB3-1,2	J1U	55	5	5	YES		15		S
	-	I4U	47	22	2	YES		3		G
6A	TB3-5,6	J2U	40	6	6	YES			X	N
8A	TB5-9,10	J6U	42	8	8	YES		5		S
PED PUSH BUTTONS										
P81,P82	TB8-8,9	I13L	70	PED 8	8 PED					

NOTE:
 INSTALL DC ISOLATORS IN INPUT FILE SLOT I13.


- * System detector only. Remove any assigned vehicle phase.
- ¹Add jumper from J1-W to I4-W, on rear of input file.

INPUT FILE POSITION LEGEND: J2L

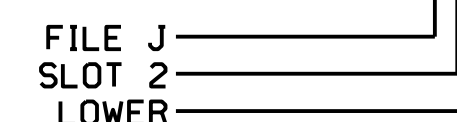

FYA SIGNAL WIRING DETAIL

(wire signal heads as shown)

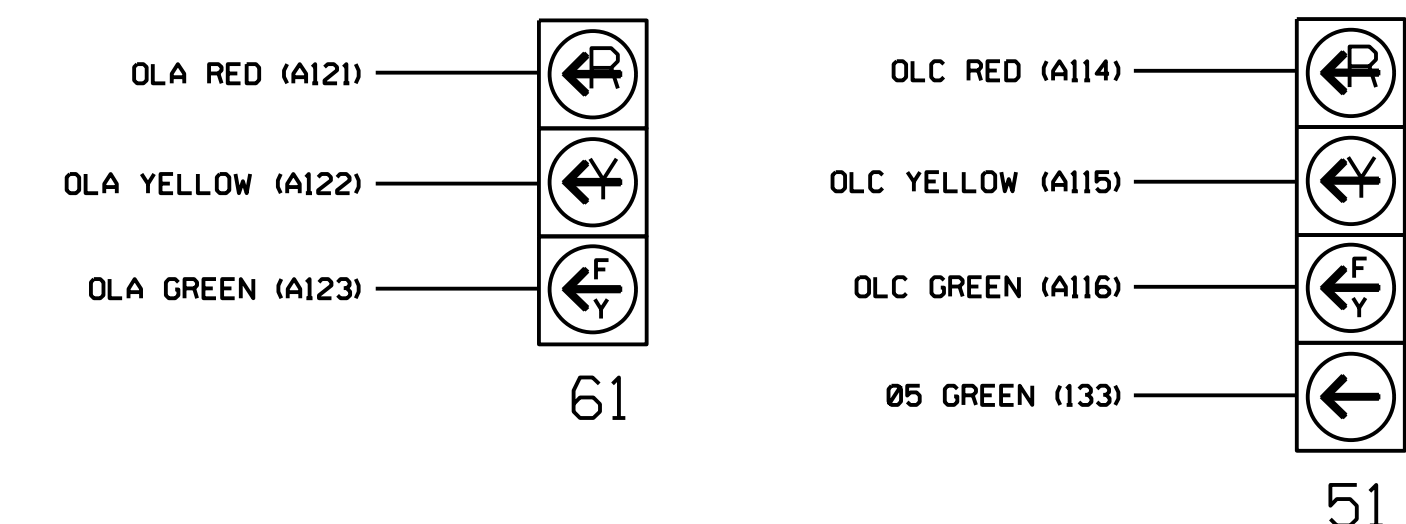

COUNTDOWN PEDESTRIAN SIGNAL OPERATION


Countdown Ped Signals are required to display timing only during Ped Clearance Interval. Consult Ped Signal Module user's manual for instructions on selecting this feature.

THIS ELECTRICAL DETAIL IS FOR THE SIGNAL DESIGN: 07-1150
 DESIGNED: March 2018
 SEALED: 6/13/2018
 REVISED: NA

LOAD RESISTOR INSTALLATION DETAIL


(install resistor as shown)

VALUE (ohms)	WATTAGE
1.5K - 1.9K	25W (min)
2.0K - 3.0K	10W (min)

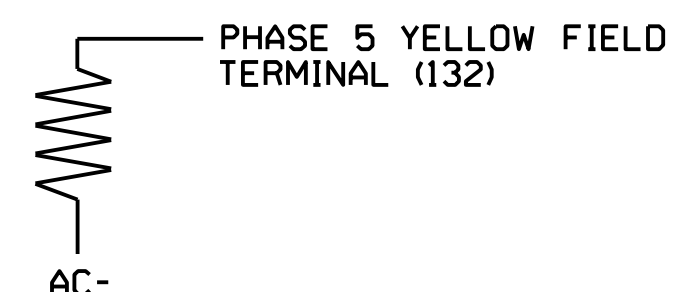

Electrical Detail - Sheet 1 of 2

ELECTRICAL AND PROGRAMMING DETAILS FOR:

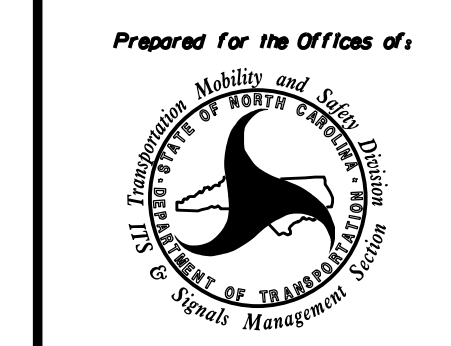

US 70 (N. Church Street) at McKinney Street/Fairview Drive

Division 7 Alamance County Burlington

PLAN DATE: March 2018 REVIEWED BY: JB Vosso

PREPARED BY: SE Greene REVIEWED BY:

REVISIONS	INIT.	DATE

DOCUMENT NOT CONSIDERED FINAL UNLESS ALL SIGNATURES COMPLETED

DATE	BY
6/13/2018	James Vosso

SIG. INVENTORY NO. 07-1150

Mattern & Craig
 ENGINEERS • SURVEYORS

12 BROAD STREET
 ASHEVILLE, NORTH CAROLINA 28801
 (828) 254-2201
 FAX (828) 254-4562
 NC LIC. NO. C-1154

750 N. Greenfield Pkwy, Corner, NC 27529

ECONOLITE ASC/3-2070 OVERLAP PROGRAMMING DETAIL
(program controller as shown)

1. From Main Menu select 2. CONTROLLER
2. From CONTROLLER Submenu select 2. VEHICLE OVERLAPS

OVERLAP A

Select TMG VEH OVLP [A] and 'OTHER/ECONOLITE'

```

TMG VEH OVLP...[A] TYPE:OTHER/ECONOLITE
PHASES 1 2 3 4 5 6 7 8 9 0 1 2 3 4 5 6
INCLUDED . X . . . . .
PROTECT . . . . .
PED PRTC . . . . .
NOT OVLP . . . . .
FLSH GRN . 1 . . . . .
LAG X PH . . . . .
LAG 2 PH . . . . .

LAG GRN 0.0 YEL 0.0 RED 0.0 ADV GRN 0.0
        
```

Toggle Twice

↓

OVERLAP C

Select TMG VEH OVLP [C] and 'PPLT FYA'

```


TMG VEH OVLP...[C] TYPE: . . . . .PPLT FYA
PROTECTED LEFT TURN.... PHASE 5
OPPOSING THROUGH..... PHASE 6

FLASHING ARROW OUTPUT....CH11 ISOLATE
DELAY START OF: FYA..0.0 CLEARANCE..0.0
ACTION PLAN SF BIT DISABLE..... 0
        
```

END PROGRAMMING

THIS ELECTRICAL DETAIL IS FOR
THE SIGNAL DESIGN: 07-1150
DESIGNED: March 2018
SEALED: 6/13/2018
REVISED: NA



\$\$\$\$\$\$SYTIME\$\$\$\$\$\$
 \$\$\$\$\$\$DATE\$\$\$\$\$\$
 \$\$\$\$\$\$USERNAME\$\$\$\$\$\$

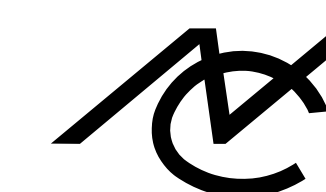


Mattern & Craig
ENGINEERS • SURVEYORS

12 BROAD STREET
ASHEVILLE, NORTH CAROLINA 28801
(828) 254-2201
FAX (828) 254-4562
NC LIC. NO. C-1154

Electrical Detail - Sheet 2 of 2

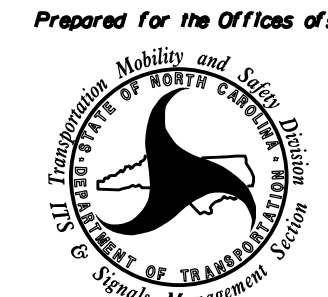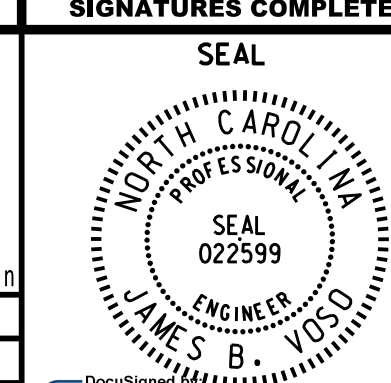ELECTRICAL AND PROGRAMMING DETAILS FOR: Prepared for the Offices of:  City of Charlotte Signal Management Section 750 N. Greenfield Pkwy, Corner, NC 27529	US 70 (N. Church Street) at McKinney Street/Fairview Drive		DOCUMENT NOT CONSIDERED FINAL UNLESS ALL SIGNATURES COMPLETED
	Division 7 Alamance County Burlington		
PLAN DATE: March 2018 PREPARED BY: SE Greene	REVIEWED BY: JB Voso	SEAL  JAMES S. B. VOSO ENGINEER SEAL 022599	
REVISIONS	INIT. DATE	James Voso 6/13/2018 DATE	SIG. INVENTORY NO. 07-1150


PHASING DIAGRAM

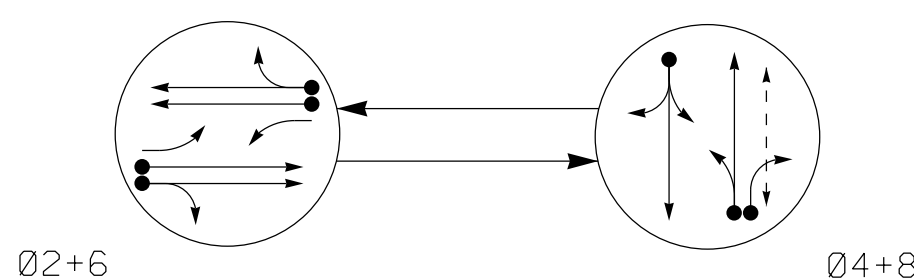

PHASING DIAGRAM DETECTION LEGEND

- DETECTED MOVEMENT
- UNDETECTED MOVEMENT (OVERLAP)
- ⋯ UNSIGNALIZED MOVEMENT
- ⇄ PEDESTRIAN MOVEMENT

EV PREEMPT PHASE
(Medium Priority)

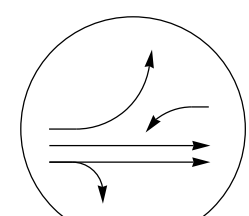


PREEMPT 2 (Ø2+5)

TABLE OF OPERATION

SIGNAL FACE	PHASE			
	Ø2+6	Ø4+8	P81,P82	F
21,22	G	R	G	Y
41,42	R	G	R	R
51	F	R	←	→
61	F	R	←	→
62,63	G	R	R	Y
81,82	R	G	R	R
P81,P82	DW	W	DW	DRK

SIGNAL FACE I.D.

All Heads L.E.D.

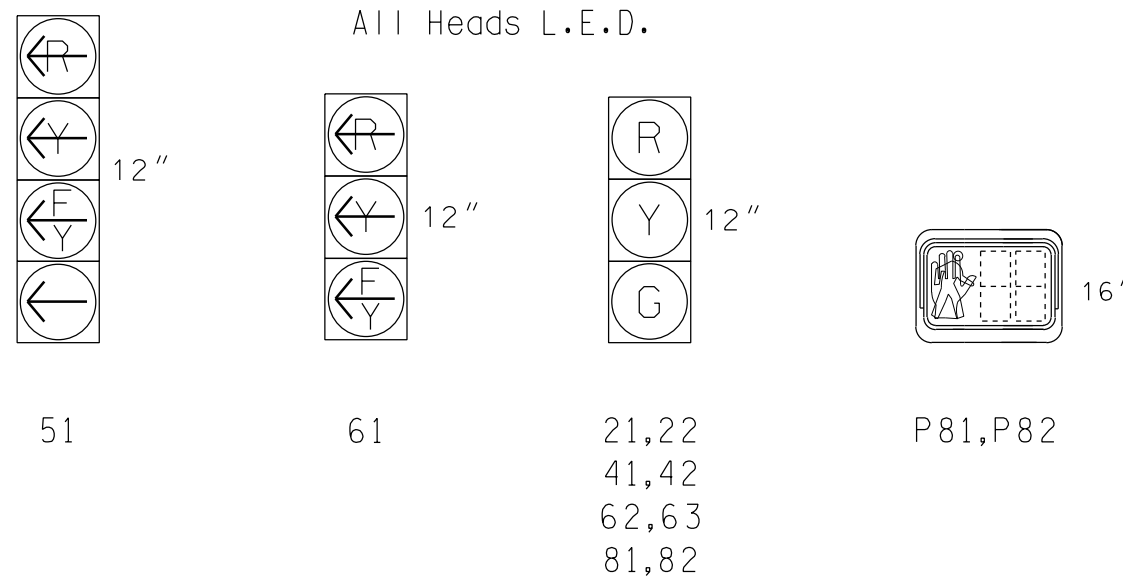


ASC/3 DETECTOR INSTALLATION CHART

LOOP	SIZE (FT)	DISTANCE FROM STOPBAR (FT)	TURNS	NEW LOOP	PHASE	PROGRAMMING						
						CALLING	EXTEND TIME	DELAY TIME	USE ADDED INITIAL	TYPE	LOOP	NEW CARD
2A,2B	6X6	300	EXIST	-	2	Yes	-	-	X	N	-	X
4A	6X15	0	EXIST	-	4	Yes	-	5	-	S	-	X
6A,6B	6X6	300	EXIST	-	6	Yes	-	-	X	N	-	X
8A	6X40	+5	2-4-2	-	8	Yes	-	-	-	S	-	X
8B	6X40	+5	2-4-2	-	8	Yes	-	15	-	S	-	X

2 Phase Fully Actuated w/ EV Preemption (Burlington-Graham Signal System)

NOTES

- Refer to "Roadway Standard Drawings NCDOT" dated January 2018 and "Standard Specifications for Roads and Structures" dated January 2018.
- Do not program signal for late night flashing operation unless otherwise directed by Engineer.
- Reposition existing signal heads numbered 22, 62, and 63.
- Set all detector units to presence mode.
- In the event of loop replacement, refer to the current ITS and Signals Design Manual and submit a Plan of Record to the Signal Design Section.
- Locate new cabinet so as not to obstruct sight distance of vehicles turning right on red.
- Omit "WALK" and flashing "DON'T WALK" with no pedestrian calls.
- Program pedestrian heads to countdown the flashing "DON'T WALK" time only.
- Remove existing Left Arrow "ONLY" Sign (R3-5L).
- Pavement markings are existing.
- Emergency vehicle preemption switch is located in Burlington Fire Station #4.
- The Division Traffic Engineer will determine the Delay Time and Minimum Dwell Time for the emergency vehicle preemption timing.
- Maximum times shown in timing chart are for free-run operation only. Coordinated signal system timing values supersede these values.

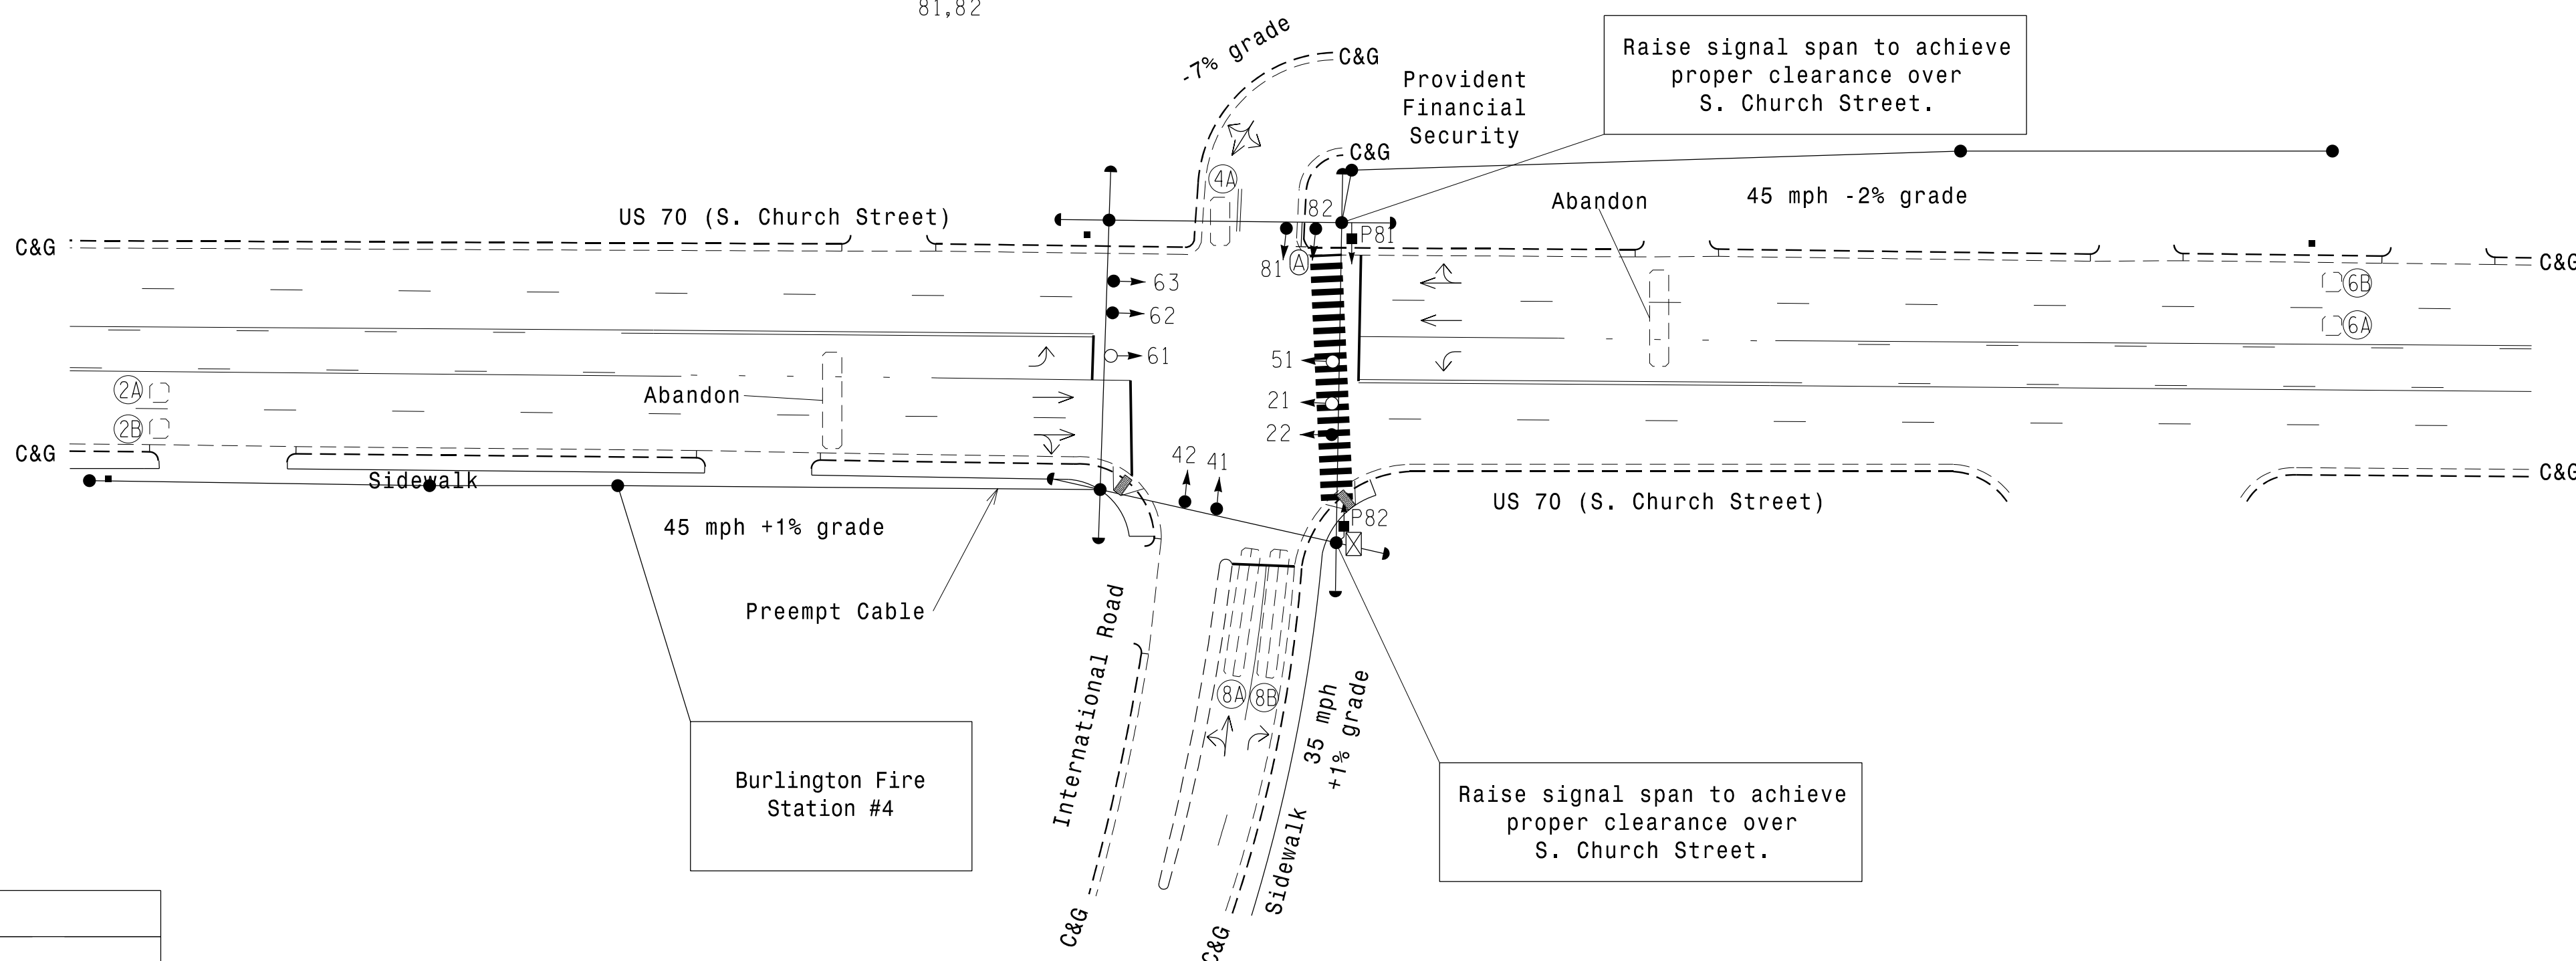

LEGEND

PROPOSED	EXISTING
○ → Traffic Signal Head	● → N/A
● → Modified Signal Head	→ Sign
⊞ Pedestrian Signal Head With Push Button & Sign	⊞
○ Signal Pole with Guy	● Signal Pole with Sidewalk Guy
⊞ Inductive Loop Detector	⊞ Controller & Cabinet
⊞ Junction Box	⊞
⊞ 2-in Underground Conduit	⊞
N/A → Right of Way	→ Directional Arrow
N/A → Curb Ramp	⊞
⊞ Right Arrow "ONLY" Sign (R3-5R)	⊞

ASC/3 TIMING CHART

FEATURE	PHASE			
	2	4	6	8
Min Green *	12	7	12	7
Walk *	0	0	0	4
Ped Clear	0	0	0	19
Veh. Extension *	6.0	2.0	6.0	2.0
Max 1 *	90	25	90	25
Yellow	4.7	3.6	4.7	3.8
Red Clear	1.0	2.0	1.0	2.0
Actuations B4 Add *	0	-	0	-
Seconds / Actuation *	2.0	-	2.0	-
Max Initial *	34	-	34	-
Time Before Reduction *	15	-	15	-
Time To Reduce *	30	-	30	-
Minimum Gap	3.0	-	3.0	-
Locking Detector	X	-	X	-
Recall Position	VEH. RECALL	-	VEH. RECALL	-
Dual Entry	-	X	-	X
Simultaneous Gap	X	X	X	X

ASC/3 EV PREEMPT

FUNCTION	PRE 2
Exit Phase(s)	4,8
Preempt Override	OFF
Delay Time	0 **
Ped Clear Through Yellow	Y
Terminate Phases	N
Entrance Walk	1
Entrance Ped Clear	255*
Entrance Min Green	1
Entrance Yellow Change	25.5*
Entrance Red Clear	25.5*
Minimum Dwell Time	25 **
Preempt Input Extension Time	0
Preempt Max Time	0
Exit Yellow Change	4.7
Exit Red Clear	1.0

* These values may be field adjusted. Do not adjust Min Green and Extension times for phases 2 and 6 lower than what is shown. Min Green for all other phases should not be lower than 4 seconds.

* Allows normal phase times to be used.
** See note 12.

Signal Upgrade

DOCUMENT NOT CONSIDERED FINAL UNLESS ALL SIGNATURES COMPLETED

Prepared For the Offices of:

US 70 (S. Church Street) at International Road/ Provident Financial Security

Division 7 Alamance County Burlington

PLAN DATE: March 2018 REVIEWED BY: PL Alexander

PREPARED BY: NA Ptak REVIEWED BY: AM Encarnacion

REVISIONS: INIT. DATE

750 N. Greenfield Pkwy, Garner, NC 27529

SCALE: 0 40 1"=40'

6/7/2018

SIG. INVENTORY NO. 07-1215


ATKINS 1616 EAST MILLBROOK ROAD, SUITE 160
RALEIGH, NORTH CAROLINA 27609
(919) 876-6888 NCBES #F-0326

07-JUN-2018 11:15 U:\Projects\Traffic\05-11-Signals\Design\Task 05-11-Signals\Design\Task 05-11-Signals.dgn ALEX3361 AT LUS340649

EDI MODEL 2018ECLip-NC CONFLICT MONITOR PROGRAMMING DETAIL

(remove jumpers and set switches as shown)


REMOVE DIODE JUMPERS 2-5, 2-6, 2-9, 2-11, 4-8, 4-16, 5-9, 5-11, 6-9, 6-11, 8-16, and 9-11.

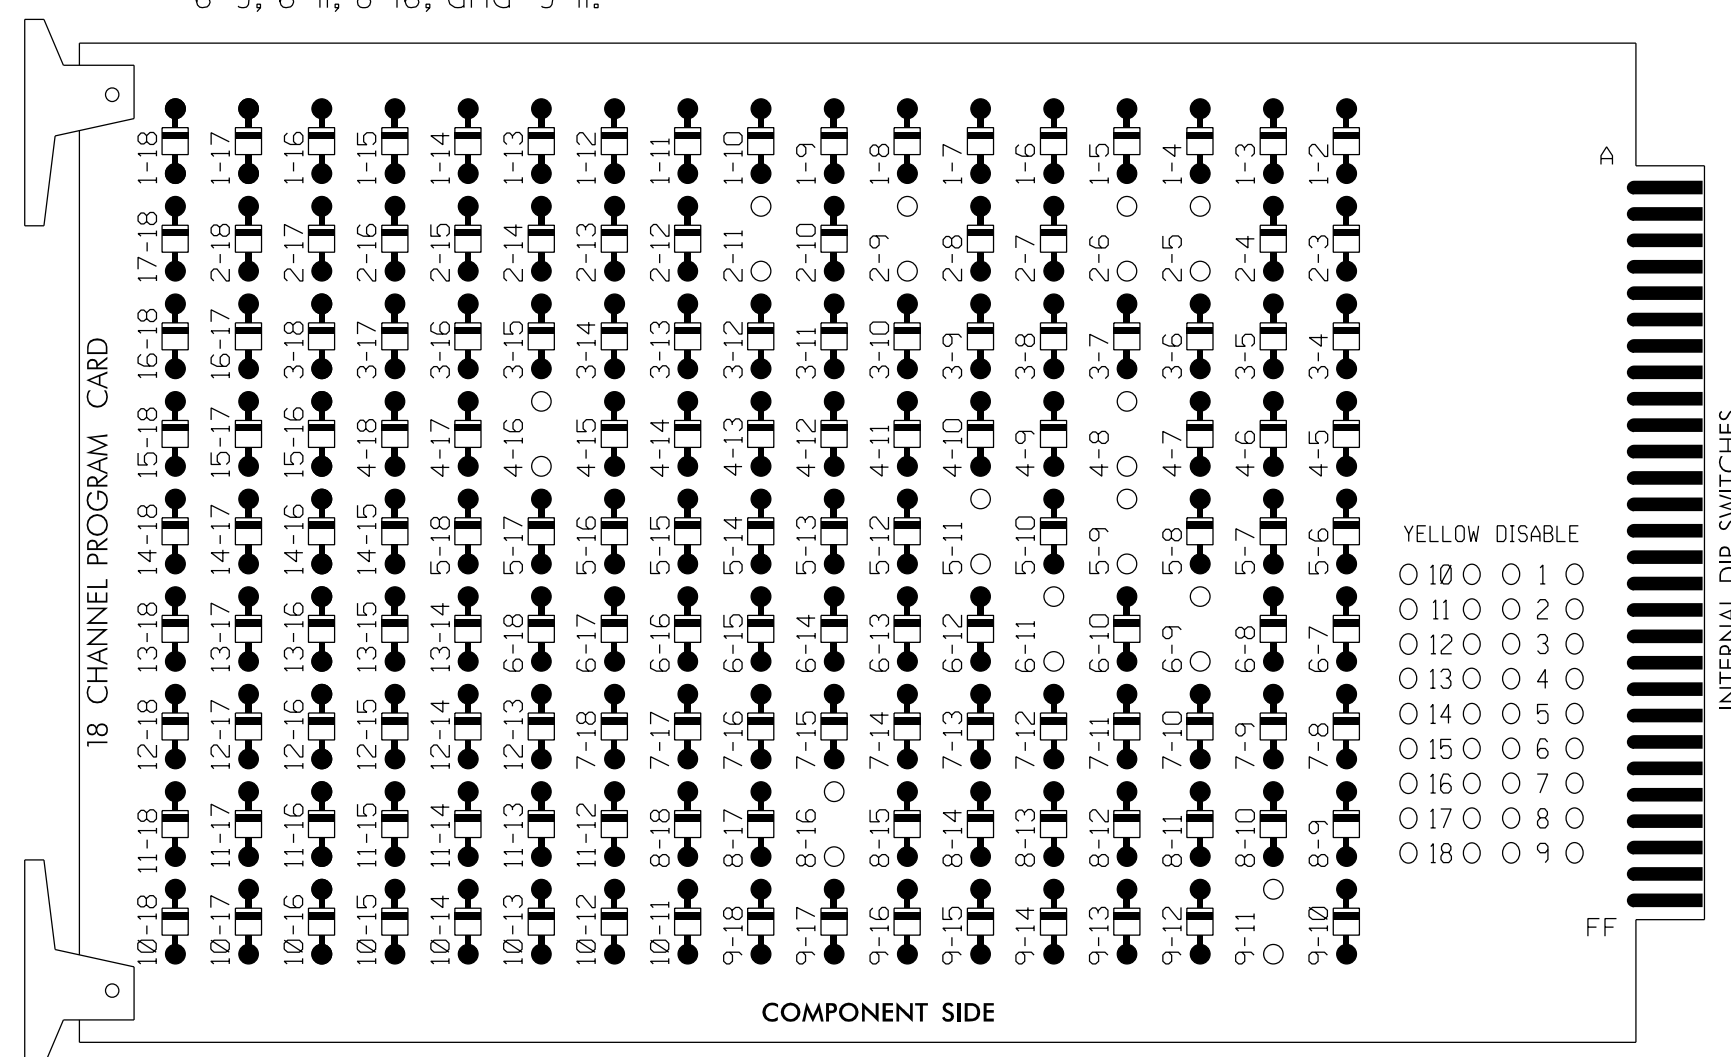

REMOVE JUMPERS AS SHOWN

NOTES:

- Card is provided with all diode jumpers in place. Removal of any jumper allows its channels to run concurrently.
- Ensure jumpers SEL2-SEL5 and SEL9 are present on the monitor board.
- Ensure that Red Enable is active at all times during normal operation.
- Integrate monitor with Ethernet network in cabinet.

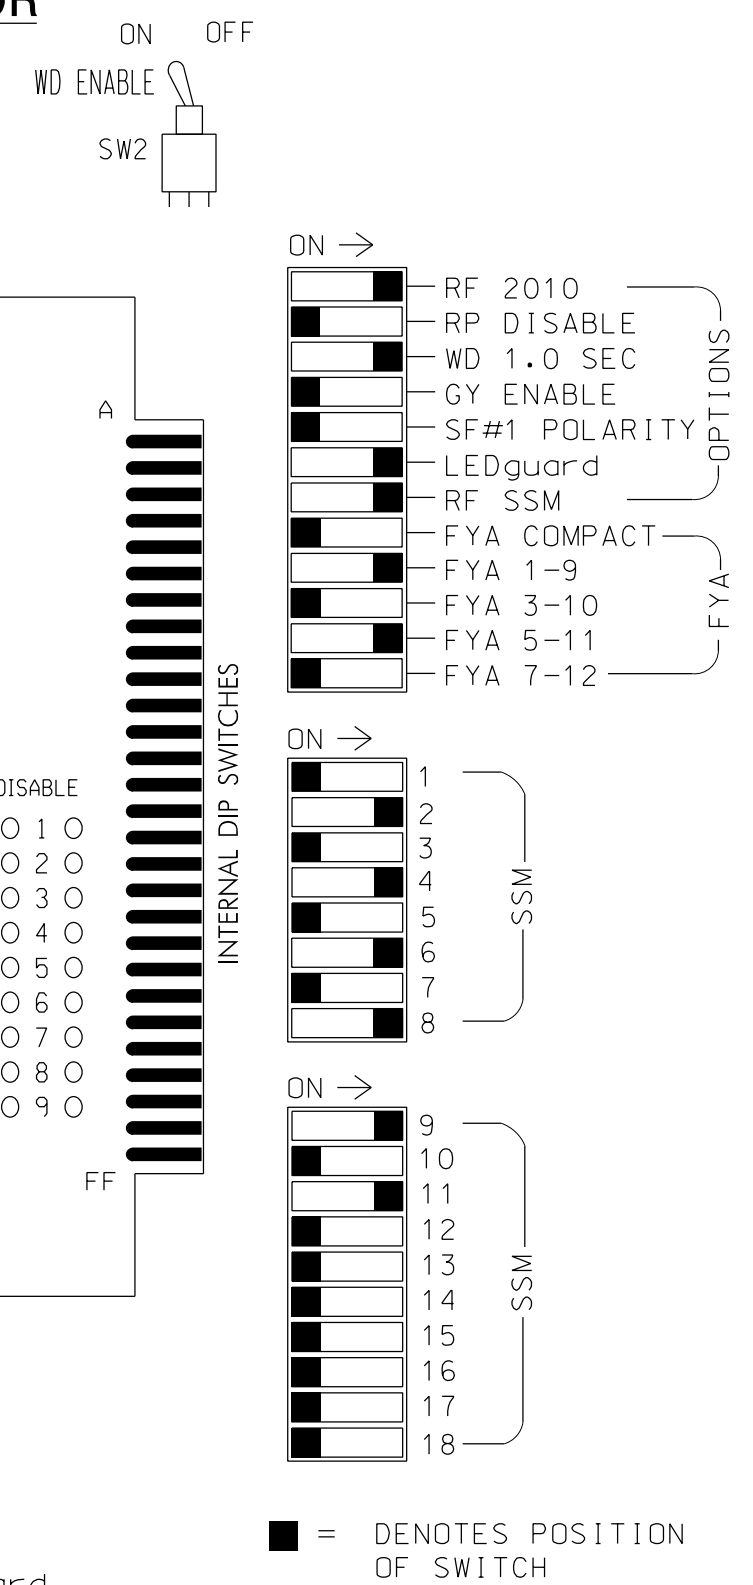

NOTES

- To prevent "flash-conflict" problems, insert red flash program blocks for all unused vehicle load switches in the output file. The installer shall verify that signal heads flash in accordance with the Signal Plans.
- Program phases 4 and 8 for Dual Entry.
- Program controller to start up in phase 2 Green and 6 Green.
- The cabinet and controller are part of the Burlington-Graham Signal System.

EQUIPMENT INFORMATION

CONTROLLER.....2070LX
 CABINET.....332 W/AUX
 SOFTWARE.....ECONDLITE ASC/3-2070
 CABINET MOUNT.....BASE
 OUTPUT FILE POSITIONS...18 WITH AUX. OUTPUT FILE LOAD SWITCHES USED.....S2,S5,S7,S8,S11,S12, AUX S1,AUX S4
 PHASES USED.....2,4,5*,6,8,8PED
 OVERLAP "A".....*
 OVERLAP "B".....NOT USED
 OVERLAP "C".....*
 OVERLAP "D".....NOT USED
 * See overlap programming detail on sheet 2
 ★ Used only during preempt

SIGNAL HEAD HOOK-UP CHART

LOAD SWITCH NO.	S1	S2	S3	S4	S5	S6	S7	S8	S9	S10	S11	S12	AUX S1	AUX S2	AUX S3	AUX S4	AUX S5	AUX S6				
CMU CHANNEL NO.	1	2	13	3	4	14	5	6	15	7	8	16	9	10	17	11	12	18				
PHASE	1	2	2 PED	3	4	4 PED	5	6	6 PED	7	8	8 PED	OLA	OLB	SPARE	OLC	OLD	SPARE				
SIGNAL HEAD NO.	NU	21,22	NU	NU	41,42	NU	51	62,63	NU	NU	81,82	P81, P82	61	NU	NU	51	NU	NU				
RED		128			101			134			107											
YELLOW		129			102		*	135			108											
GREEN		130			103			136			109											
RED ARROW																			A121	A114		
YELLOW ARROW																				A122	A115	
FLASHING YELLOW ARROW																				A123	A116	
GREEN ARROW																						
Hand																					110	
Walking																						112

NU = Not Used
 * Denotes install load resistor. See load resistor installation detail this sheet.
 ★ See pictorial of head wiring in detail this sheet.

INPUT FILE POSITION LAYOUT

(front view)

FILE	1	2	3	4	5	6	7	8	9	10	11	12	13	14
U	∅ 2 2A,2B	∅ 3	∅ 4	∅ 5	∅ 6	∅ 7	∅ 8	∅ 9	∅ 10	∅ 11	∅ 12	∅ 13	∅ 14	∅ 15
L	NOT USED	∅ 16	∅ 17	∅ 18	∅ 19	∅ 20	∅ 21	∅ 22	∅ 23	∅ 24	∅ 25	∅ 26	∅ 27	∅ 28
U	∅ 6 6A,6B	∅ 7	∅ 8	∅ 9	∅ 10	∅ 11	∅ 12	∅ 13	∅ 14	∅ 15	∅ 16	∅ 17	∅ 18	∅ 19
L	NOT USED	∅ 20	∅ 21	∅ 22	∅ 23	∅ 24	∅ 25	∅ 26	∅ 27	∅ 28	∅ 29	∅ 30	∅ 31	∅ 32


EX. : 1A, 2A, ETC. = LOOP NO.'S

FS = FLASH SENSE
 ST = STOP TIME
 PRE = PREEMPT

INPUT FILE CONNECTION & PROGRAMMING CHART


LOOP NO.	LOOP TERMINAL	INPUT FILE POS.	PIN NO.	DETECTOR NO.	NEMA PHASE	CALL	EXTEND TIME	DELAY TIME	ADDED INITIAL	DETECTOR TYPE
2A,2B	TB2-5,6	I2U	39	2	2	YES			X	N
4A	TB4-9,10	I6U	41	4	4	YES		5		S
6A,6B	TB3-5,6	J2U	40	6	6	YES			X	N
8A	TB5-9,10	J6U	42	8	8	YES				S
8B	TB5-11,12	J6L	46	18	8	YES		15		S
PED PUSH BUTTONS										
P81,P82	TB8-8,9	I13L	70	PED 8	8 PED					

NOTE: INSTALL DC ISOLATORS IN INPUT FILE SLOT 113.

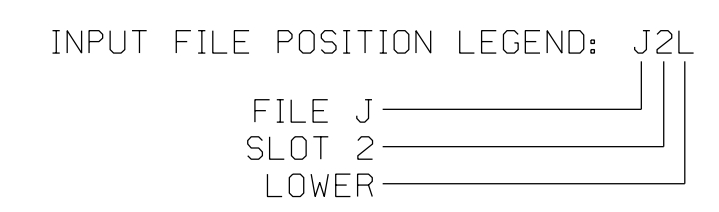

FYA SIGNAL WIRING DETAIL

(wire signal heads as shown)

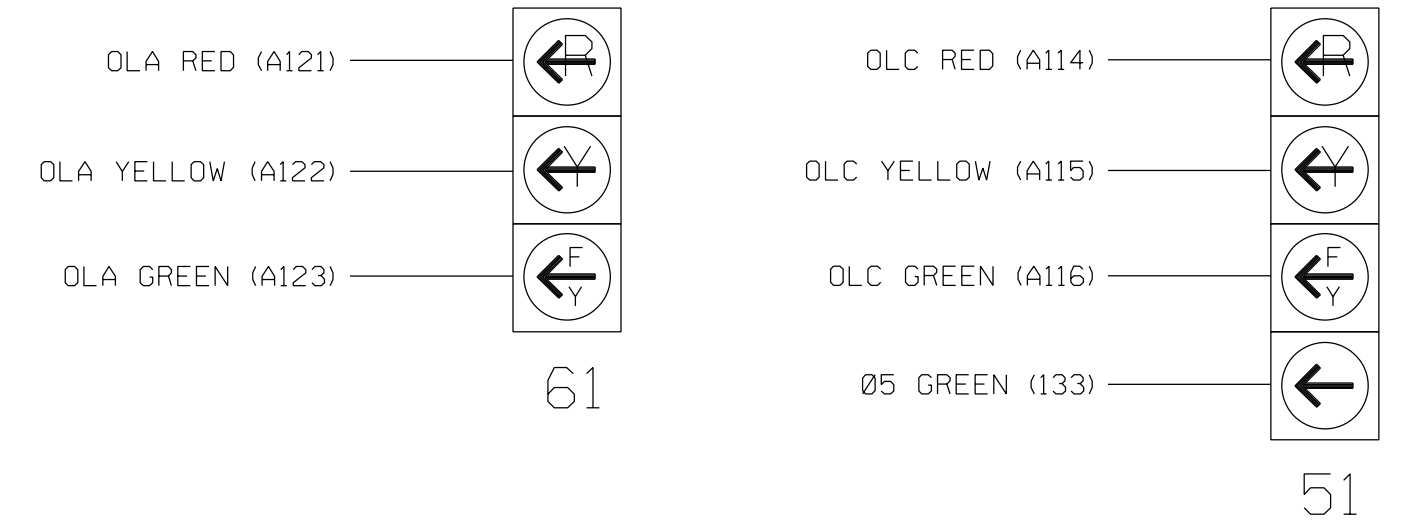


COUNTDOWN PEDESTRIAN SIGNAL OPERATION

Countdown Ped Signals are required to display timing only during Ped Clearance Interval. Consult Ped Signal Module user's manual for instructions on selecting this feature.

LOAD RESISTOR INSTALLATION DETAIL

(install resistor as shown)

ACCEPTABLE VALUES	
VALUE (ohms)	WATTAGE
1.5K - 1.9K	25W (min)
2.0K - 3.0K	10W (min)

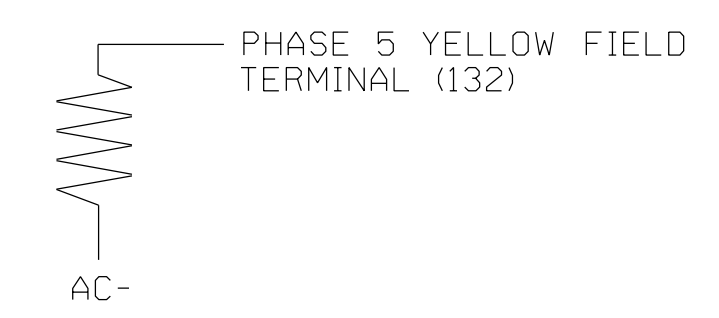

Electrical Details - Sheet 1 of 3

DOCUMENT NOT CONSIDERED FINAL UNLESS ALL SIGNATURES COMPLETED

Prepared for the Offices of:
US 70 (S. Church Street) at International Road/Provident Financial Security
 Division 7 Alamance County Burlington
 PLAN DATE: March 2018 REVIEWED BY: PL Alexander
 PREPARED BY: NA Ptak REVIEWED BY: AM Encarnacion

REVISIONS	INIT.	DATE

Sealed by: **Pamela Alexander** 6/9/2018
 SEAL 023489
 SIG. INVENTORY NO. 07-1215

ATKINS 1616 EAST MILLBROOK ROAD, SUITE 160
 RALEIGH, NORTH CAROLINA 27609
 (919) 876-6888 NCBEES #F-0326

09-JUN-2018 14:14 D:\Transpor\at\work\office\cur\100056469 U-6015 B-C S19 Sys\Task 05_11_Signal\Des\g\m\ir\ing\07-1215E.dgn ALEX3361 AT LUS310649

ECONOLITE ASC/3-2070 OVERLAP PROGRAMMING DETAIL (program controller as shown)

1. From Main Menu select 2. CONTROLLER
2. From CONTROLLER Submenu select 2. VEHICLE OVERLAPS

```

OVERLAP A
Select TMG VEH OVLP [A] and 'OTHER/ECONOLITE'
TMG VEH OVLP...[A] TYPE: OTHER/ECONOLITE
  PHASES 1 2 3 4 5 6 7 8 9 0 1 2 3 4 5 6
INCLUDED . X . . . . .
PROTECT . . . . .
PED PRTC . . . . .
NOT OVLP . . . . .
FLSH GRN . 1 . . . . .
LAG X PH . . . . .
LAG 2 PH . . . . .
LAG GRN 0.0 YEL 0.0 RED 0.0 ADV GRN 0.0

```

Toggle Twice

```

OVERLAP C
Select TMG VEH OVLP [C] and 'PPLT FYA'
TMG VEH OVLP...[C] TYPE: PPLT FYA
PROTECTED LEFT TURN.... PHASE 5
OPPOSING THROUGH..... PHASE 6

FLASHING ARROW OUTPUT....CH11 ISOLATE
DELAY START OF: FYA..0.0 CLEARANCE..0.0
ACTION PLAN SF BIT DISABLE..... 0

```


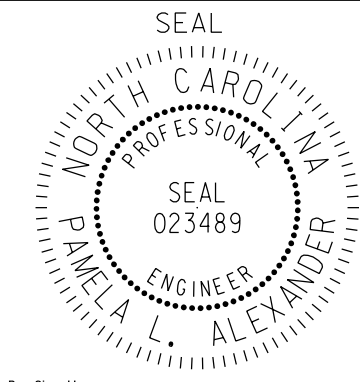
END PROGRAMMING

THIS ELECTRICAL DETAIL IS FOR
 THE SIGNAL DESIGN: 07-1215
 DESIGNED: March 2018
 SEALED: 6/7/2018
 REVISED: N/A

09-JUN-2018 14:14
 D:\T\consort\at\off\c\cur\100056469 U-6015 B-G S1g Sys\Task 05_11_Signal\Des\gn\wlr\ing\07-1215E.dgn
 ALEX3361 AT LUS210649

Electrical Details - Sheet 2 of 3

DOCUMENT NOT CONSIDERED FINAL UNLESS ALL SIGNATURES COMPLETED

ELECTRICAL AND PROGRAMMING DETAILS FOR: Prepared for the Offices of:  750 N. Greenfield Pkwy, Garner, NC 27529	US 70 (S. Church Street) at International Road/ Provident Financial Security							
	Division 7 Alamance County Burlington	PLAN DATE: March 2018 REVIEWED BY: AM Encarnacion PREPARED BY: NA Ptak REVIEWED BY: PL Alexander						
<table border="1"> <thead> <tr> <th>REVISIONS</th> <th>INIT.</th> <th>DATE</th> </tr> </thead> <tbody> <tr> <td> </td> <td> </td> <td> </td> </tr> </tbody> </table>	REVISIONS	INIT.	DATE				6/9/2018 Pamela Alexander	DATE
REVISIONS	INIT.	DATE						
SIG. INVENTORY NO. 07-1215			DATE					

ATKINS 1616 EAST MILLBROOK ROAD, SUITE 160
 RALEIGH, NORTH CAROLINA 27609
 (919) 876-6888 NCBEE #F-0326

ECONOLITE ASC/3-2070 EMERGENCY VEHICLE

PREEMPT PROGRAMMING DETAIL

(program controller as shown)

- From Main Menu select 4. PREEMPTOR/TSP
- From PREEMPTOR/TSP/SCP Submenu select 1. PREEMPT PLAN 1-10


Place cursor in [] next to Preempt Plan and press 2. Then press the right cursor arrow and toggle the controller to YES. Next cursor down. This will select Emergency Vehicle Preempt #2.

PREEMPT PLAN [2]	ENABLE....YES
VEH/PED 1 2 3 4 5 6 7 8 9 0 1 2 3 4 5 6	
OVERLAP A B C D E F G H I J K L M N O P	
TRKCLR V	
TRKCLR 0	
ENA TRL	
DWEL VEH . X . . X	
DWEL PED	
DWEL OLP F1 . F1	
CYC VEH	
CYC PED	
CYC OLP	
EXIT PH . . . X . . . X	
EXIT CAL	
SP FUNC	

ENABLE... YES	IPMT	OVRIDE..	INTERLOCK.	NO
DET LOCK... X	IDELAY..	OINHIBIT...	0	
OVERIDE FL. .	IDURATION	OICLR-GRN...	NO	
TERM OLP. NO	IPC>YEL	YESITERM PH	NO	
PED DARK.. NO	ITC RESRV	YESIDWELL FL	OFF	
LINK PMT....O	IX FLCOLR	REDIEXIT OPT.	OFF	
X TMG PLN...O	IRE-SERV..	OIFLT TYPE.HARD		
FREE DUR PMT	R1 NOIR2	NOIR3 NOIR4	NO	
--TIMING----	WALKIPED	CLIMN GRI YELI	RED	
ENTRANCE TM.	11 2551	1125.5125.5		
-----MIN	GRIEXT	GRIMX GRI YELI	RED	
TRACK CLEAR	01 01	0125.5125.5		
-----MIN	DLIPMTEXTIMX	TMI YELI	RED	
DWL/CYC-EXIT	01 0.01	01 4.71 1.0		
PMT ACTIVE OUT..	ON	PMT ACT DWELL...	NO	
OTHER - PRI	PMT.OFF	NON-PRI PMT....	OFF	
INH EXT TIME...	0.0	PED PR RETURN...	OFF	
PRIORITY RETURN..	OFF	QUEUE DELAY....	OFF	
COND DELAY.....	OFF			
PHASES	1 2 3 4 5 6 7 8			
PR RTN%	0 0 0 0 0 0 0 0			
PHASES	9 10 11 12 13 14 15 16			
PR RTN%	0 0 0 0 0 0 0 0			

EV Preemption Control Box Wiring Detail

(wire as shown below)

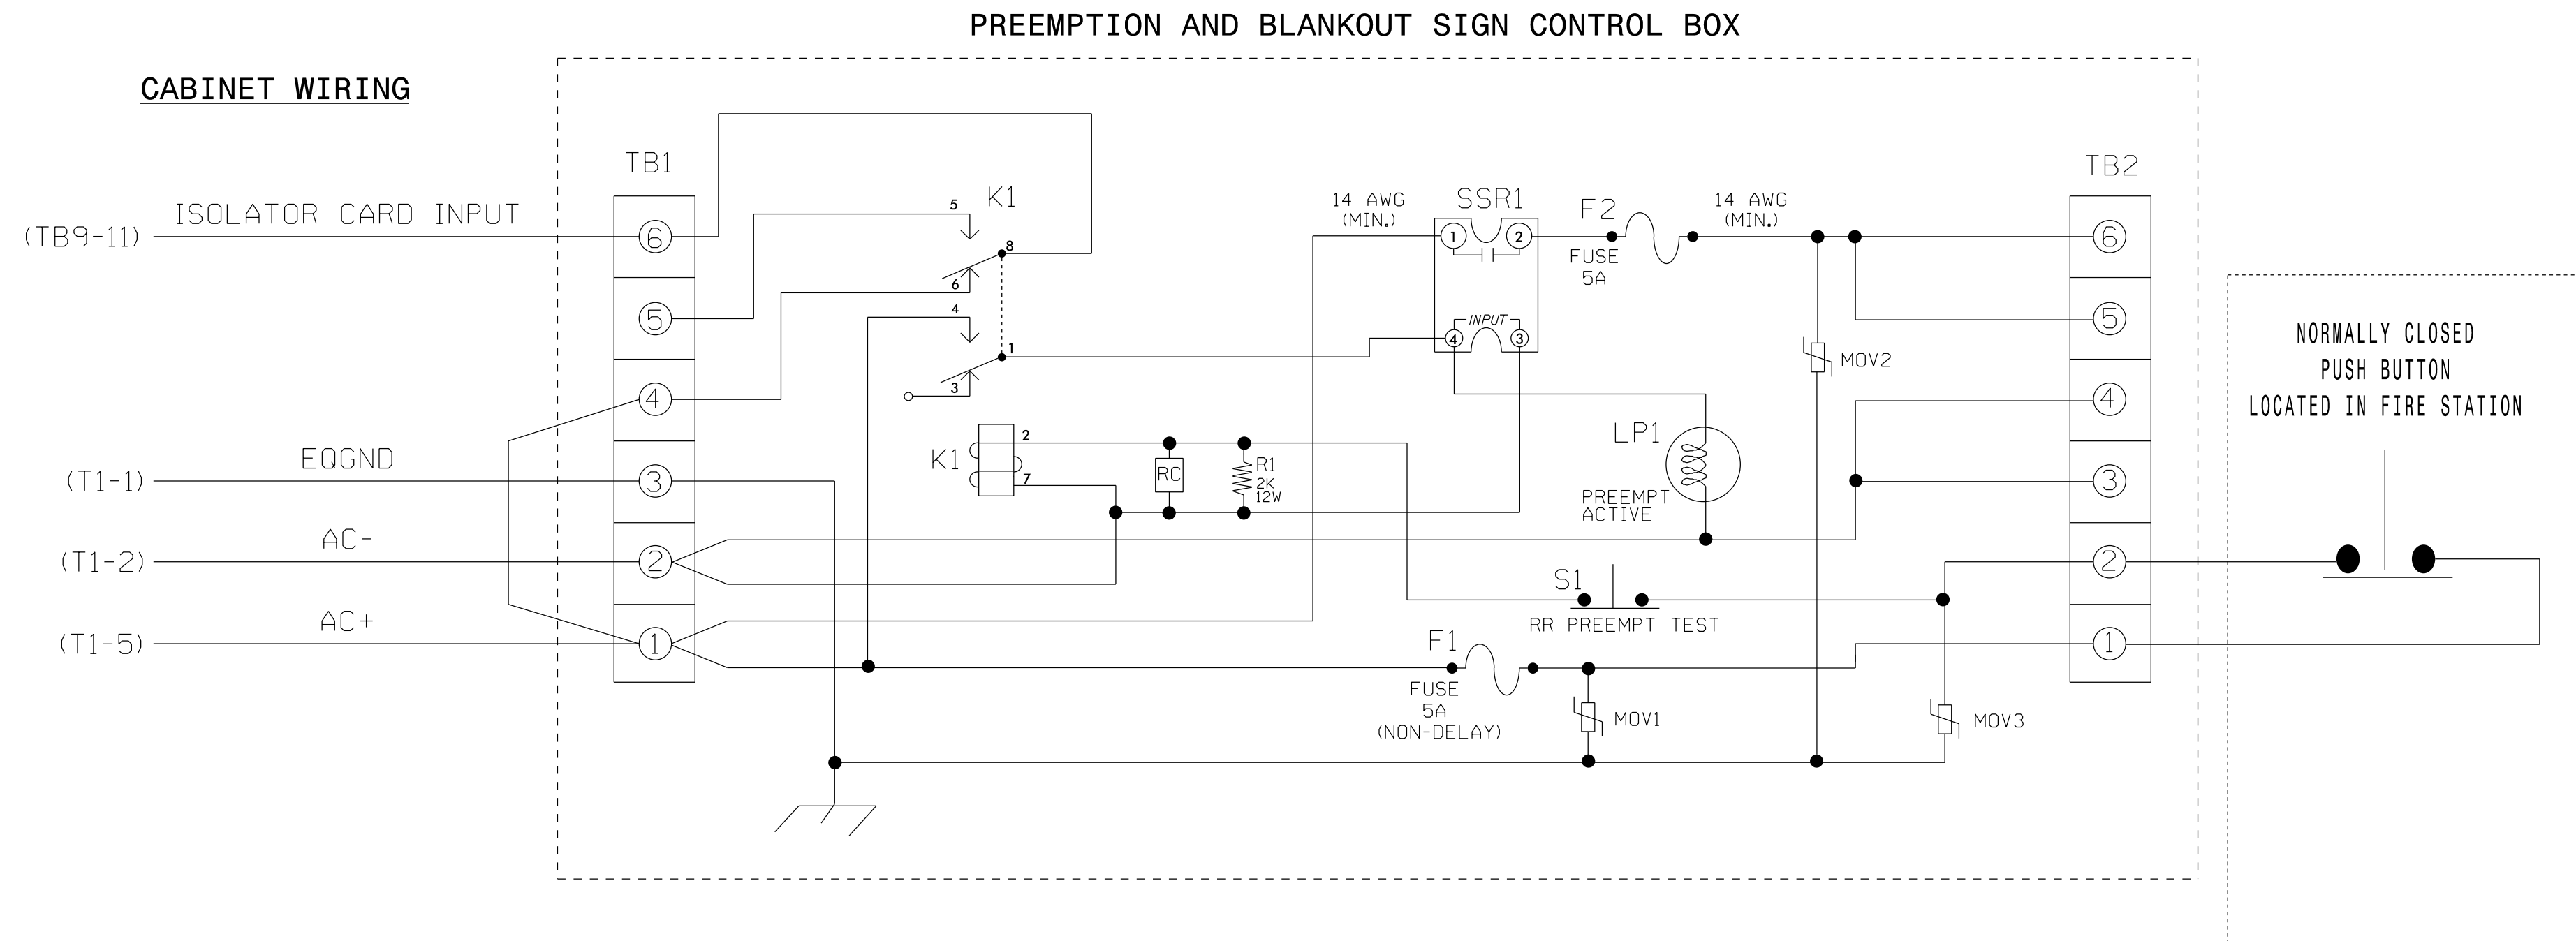


NOTES

- Relay K1 is shown in the energized (Preempt not active) normal operation state.
- Relay 'K1' is an enclosed DPDT general purpose relay with a 120VAC coil, 10A contacts, and octal-style plug.
- Relay SSR1 is a SPST (normally open) Solid State Relay with AC input and AC (25 amp) output.
- AC Isolator Card shall activate preemption upon removal of AC+ from the input (as shown above). To accomplish this, set invert dip switch on AC Isolator Card.
- IMPORTANT!! Terminal TB9-12 (on input panel) shall be connected to AC neutral (jumper may have to be added).


PREEMPT 2 AC ISOLATOR (MODEL 252) OUTPUT PROGRAMMING DETAIL

(set DIP switches as shown below)

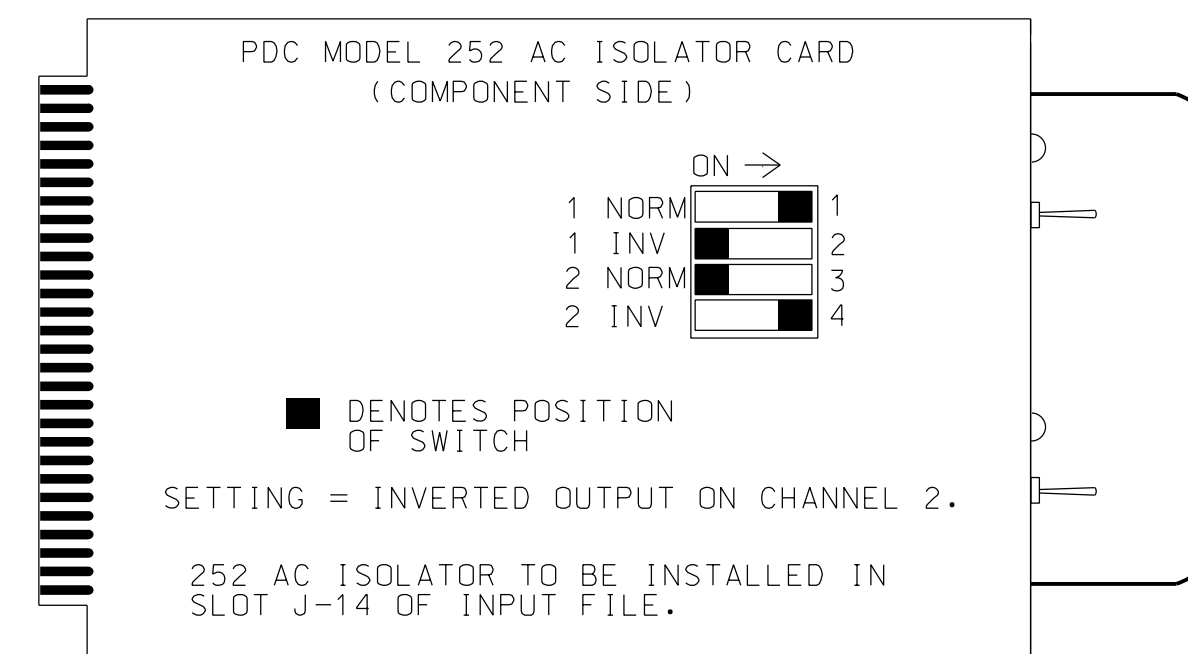

NOTE: IF ANOTHER MANUFACTURER TYPE OF AC ISOLATOR IS USED, OUTPUT PROGRAMMING IS LIKELY NOT TO EQUATE TO THAT SHOWN ABOVE.

FRONT VIEW

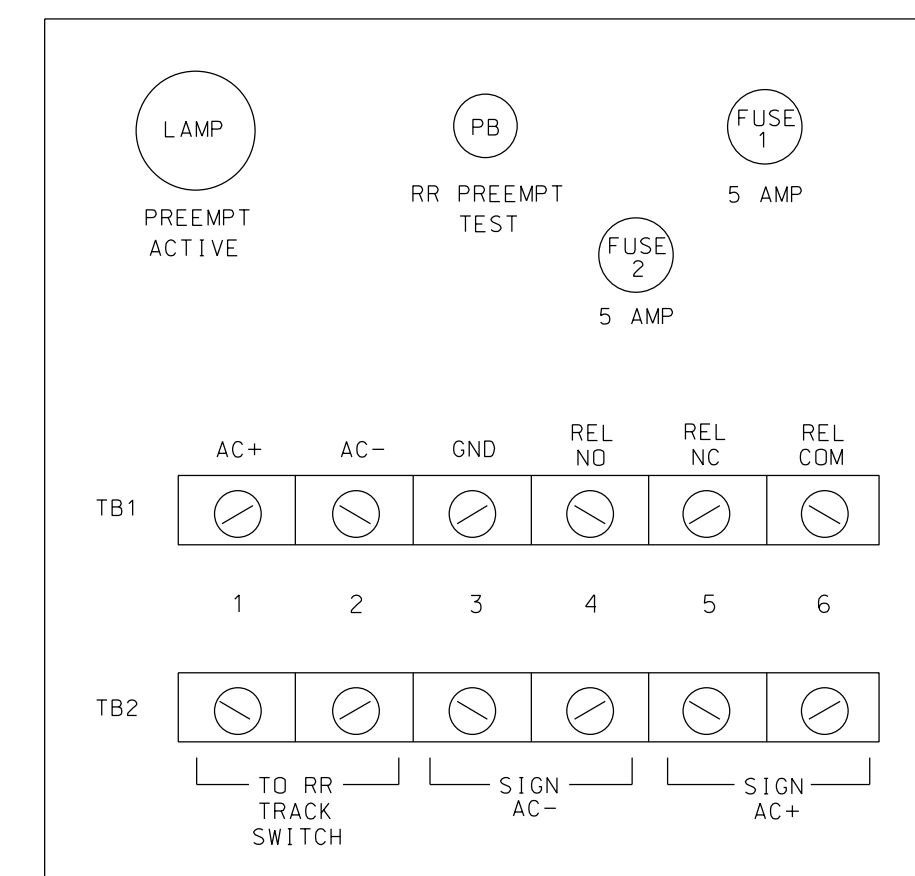


THIS ELECTRICAL DETAIL IS FOR THE SIGNAL DESIGN: 07-1215
 DESIGNED: March 2018
 SEALED: 6/7/2018
 REVISED: N/A

Electrical Details - Sheet 3 of 3

ELECTRICAL AND PROGRAMMING DETAILS FOR: Prepared for the Offices of: 	US 70 (S. Church Street) at International Road/ Provent Financial Security		SEAL NORTH CAROLINA PROFESSIONAL SEAL 023489 ENGINEER PAMELA L. ALEXANDER
	Division 7 Alamance County Burlington PLAN DATE: March 2018 REVIEWED BY: AM Encarnacion PREPARED BY: NA Ptak REVIEWED BY: PL Alexander	REVISIONS INIT. DATE	

PHASING DIAGRAM

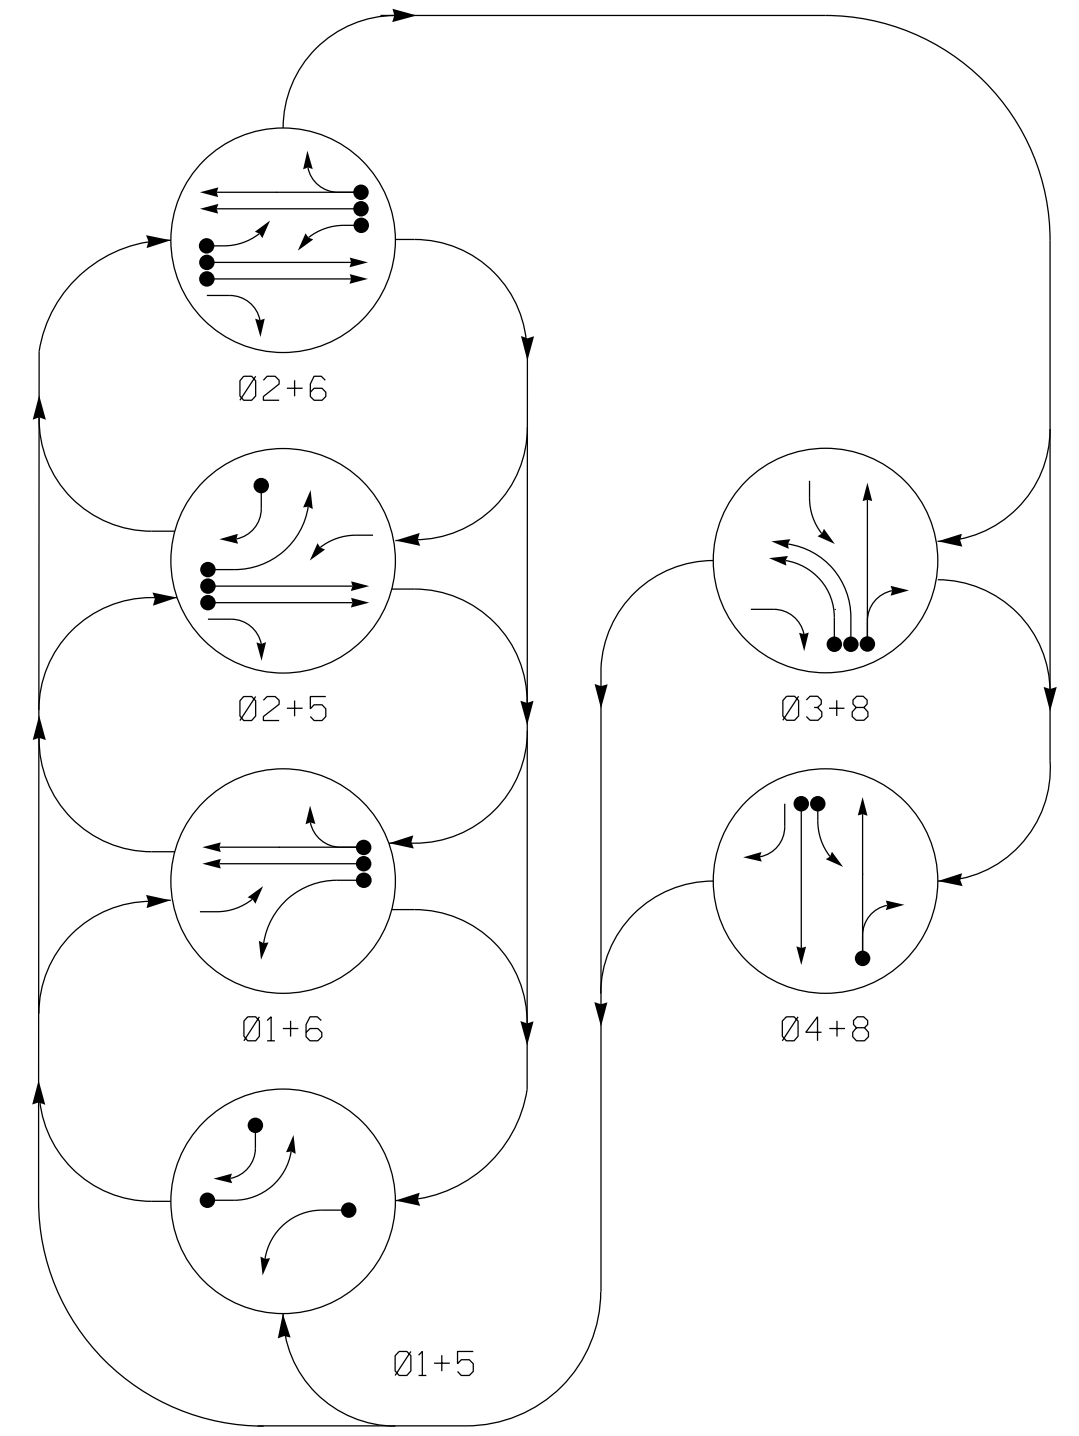

PHASING DIAGRAM DETECTION LEGEND
 ● DETECTED MOVEMENT
 ○ UNDETECTED MOVEMENT (OVERLAP)
 - - - UNSIGNALIZED MOVEMENT
 - - - PEDESTRIAN MOVEMENT

SIGNAL FACE I.D.

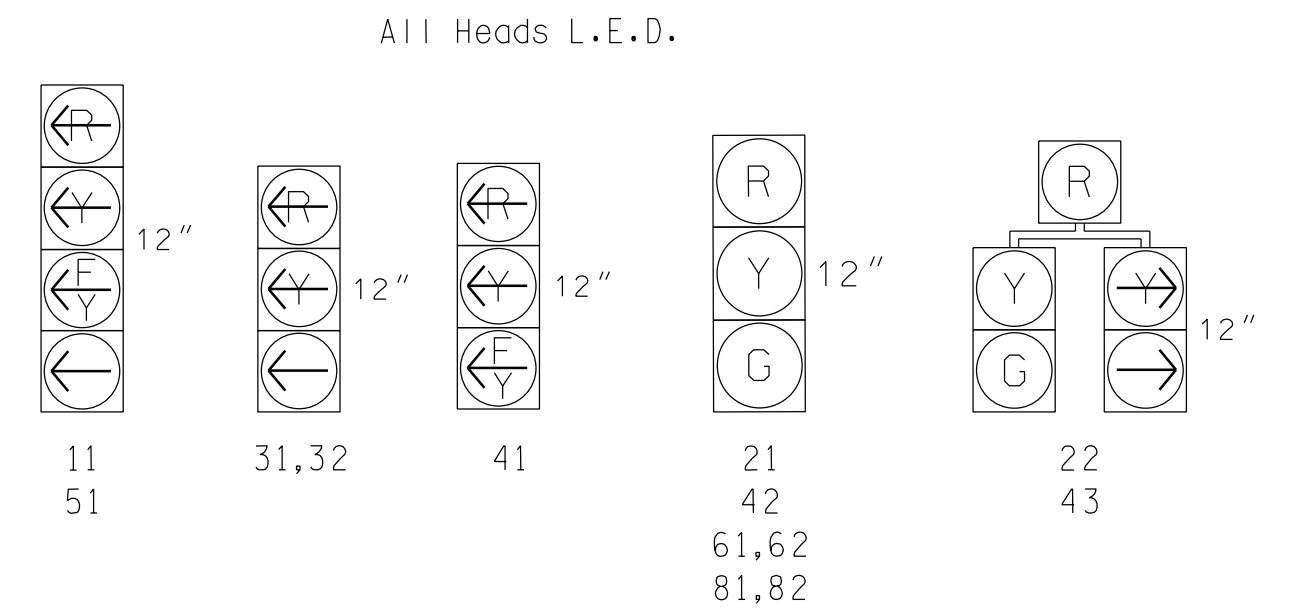


TABLE OF OPERATION

SIGNAL FACE	PHASE							
	01+5	01+6	02+5	02+6	03+8	04+8	H	L
11	←	←	←	←	←	←	←	←
21	R	R	G	G	R	R	Y	
22	R	R	G	G	R	R	Y	
31,32	←	←	←	←	←	←	←	←
41	←	←	←	←	←	←	←	←
42	R	R	R	R	R	G	R	
43	R	R	R	R	R	G	R	
51	←	←	←	←	←	←	←	←
61,62	R	G	R	G	R	R	Y	
81,82	R	R	R	G	G	R		


ASC/3 DETECTOR INSTALLATION CHART

LOOP	SIZE (FT)	DISTANCE FROM STOPBAR (FT)	TURNS	NEW LOOP	PROGRAMMING							
					PHASE	CALLING	EXTEND TIME	DELAY TIME	USE ADDED INITIAL	TYPE	LOOP	NEW CARD
1A	6X60	0	2-4-2		1	Yes	-	15	-	S	-	X
					6	Yes	-	-	-	S	-	X
2A,2B	6X6	70	EXIST	-	2	Yes	-	-	-	S	-	X
3A	6X40	0	2-4-2	-	3	Yes	-	-	-	S	-	X
3B	6X40	0	2-4-2	-	3	Yes	-	-	-	S	-	X
4A	6X40	0	2-4-2	-	4	Yes	-	3	-	S	-	X
4B	6X40	0	2-4-2	-	4	Yes	-	-	-	S	-	X
5A	6X40	0	2-4-2		5	Yes	-	15	-	S	-	X
					2	Yes	-	-	-	S	-	X
5B	6X40	0	2-4-2	-	5	Yes	-	15	-	S	-	X
6A	6X27	70	EXIST	-	6	Yes	-	-	-	S	-	X
8A	6X40	0	2-4-2	-	8	Yes	-	10	-	S	-	X

6 Phase Fully Actuated (Burlington-Graham Signal System)


NOTES

1. Refer to "Roadway Standard Drawings NCDOT" dated January 2018 and "Standard Specifications for Roads and Structures" dated January 2018.
2. Do not program signal for late night flashing operation unless otherwise directed by the Engineer.
3. Phase 1 and/or phase 5 may be lagged.
4. Phase 3 may be lagged.
5. Reposition existing signal heads numbered 42, 43, and 62.
6. Set all detector units to presence mode.
7. In the event of loop replacement, refer to the current ITS and Signals Design Manual and submit a Plan of Record to the Signal Design Section.
8. Locate new cabinet so as not to obstruct sight distance of vehicles turning right on red.
9. Pavement markings are existing.
10. Maximum times shown in timing chart are for free-run operation only. Coordinated signal system timing values supersede these values.

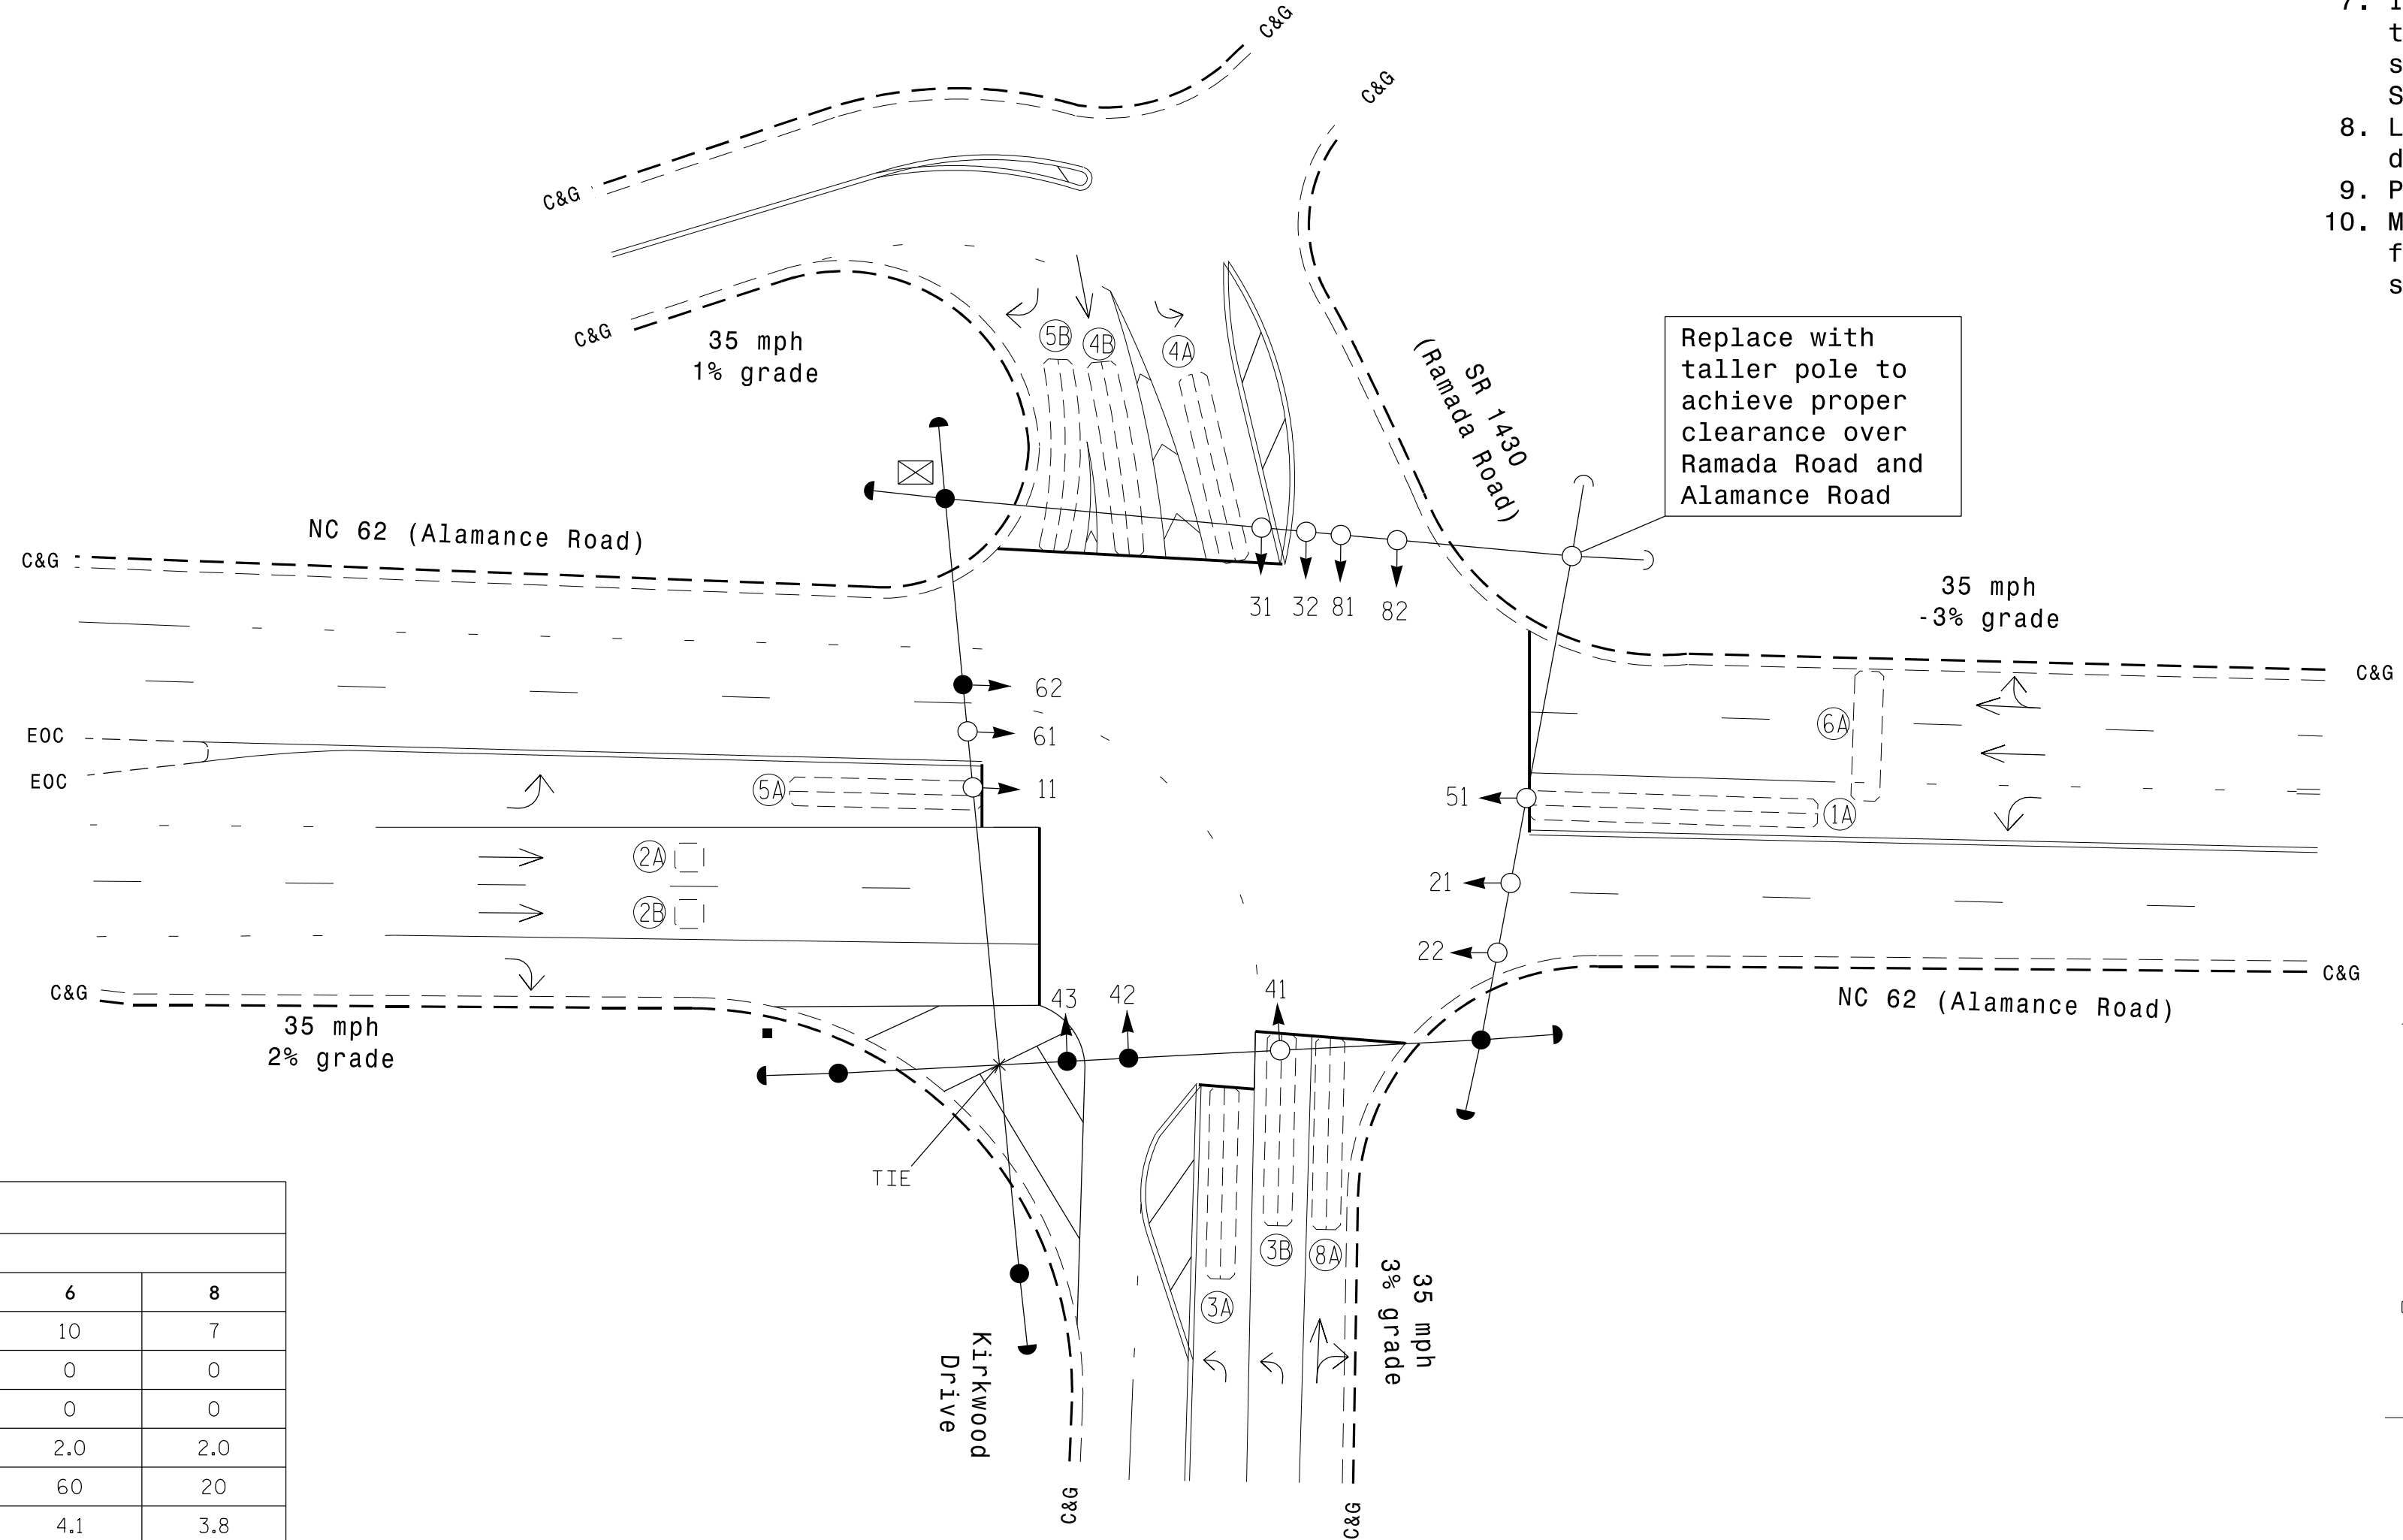

Replace with taller pole to achieve proper clearance over Ramada Road and Alamance Road

LEGEND

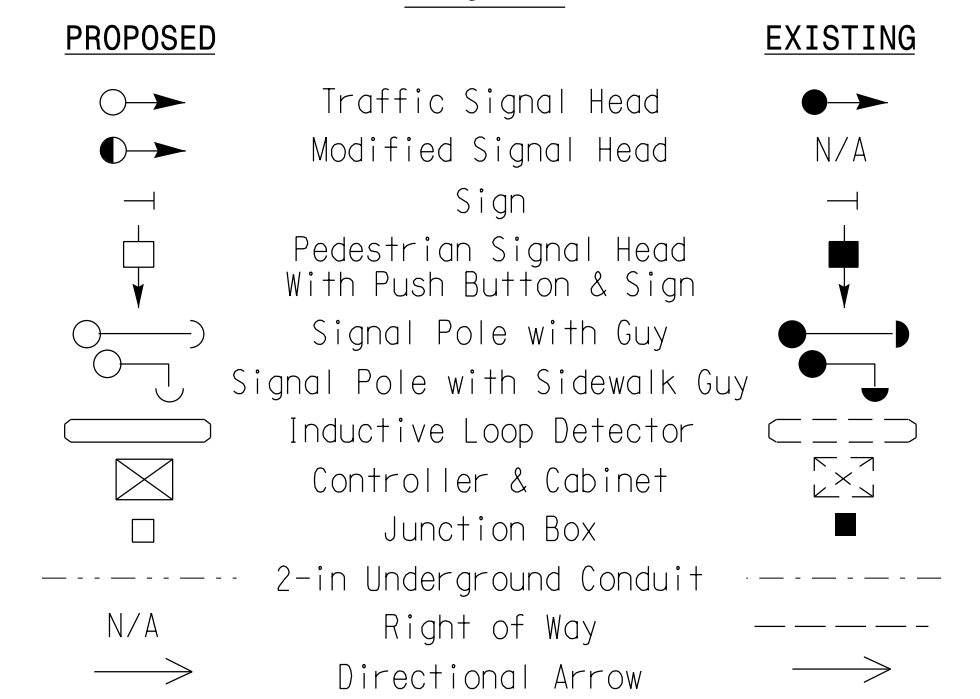

ASC/3 TIMING CHART

FEATURE	PHASE							
	1	2	3	4	5	6	8	
Min Green *	7	10	7	7	7	10	7	
Walk *	0	0	0	0	0	0	0	
Ped Clear	0	0	0	0	0	0	0	
Veh. Extension *	2.0	3.0	2.0	2.0	3.0	2.0	2.0	
Max I *	15	60	20	15	20	60	20	
Yellow	3.0	4.1	3.0	3.8	3.0	4.1	3.8	
Red Clear	3.2	2.1	3.1	1.9	2.8	2.1	1.9	
Actuations B4 Add *	-	-	-	-	-	-	-	
Seconds / Actuation *	-	-	-	-	-	-	-	
Max Initial *	-	-	-	-	-	-	-	
Time Before Reduction *	-	-	-	-	-	-	-	
Time To Reduce *	-	-	-	-	-	-	-	
Minimum Gap	-	-	-	-	-	-	-	
Locking Detector	-	X	-	-	-	X	-	
Recall Position	-	VEH. RECALL	-	-	-	VEH. RECALL	-	
Dual Entry	-	-	-	-	-	-	X	
Simultaneous Gap	X	X	X	X	X	X	X	

* These values may be field adjusted. Do not adjust Min Green and Extension times for phases 2 and 6 lower than what is shown. Min Green for all other phases should not be lower than 4 seconds.

Signal Upgrade

Prepared for the Offices of:
 Transportation Mobility and Safety Division
 STATE OF NORTH CAROLINA
 Signal Design Section
 750 N. Greenfield Pkwy, Garner, NC 27529

NC 62 (Alamance Road) at SR 1430 (Ramada Road)/ Kirkwood Drive

Division 7 Alamance County Burlington
 PLAN DATE: November 2017 REVIEWED BY: AM Encarnacion
 PREPARED BY: NA Ptak REVIEWED BY: PL Alexander

SCALE: 1"=30'

REVISIONS: _____ INIT. DATE

DOCUMENT NOT CONSIDERED FINAL UNLESS ALL SIGNATURES COMPLETED


SEAL: PAMELA L. ALEXANDER, PROFESSIONAL ENGINEER, NO. 023489, STATE OF NORTH CAROLINA

Sig. INVENTORY NO. 07-1230

EDI MODEL 2018EClip-NC CONFLICT MONITOR PROGRAMMING DETAIL

(remove jumpers and set switches as shown)

REMOVE DIODE JUMPERS 1-5, 1-6, 1-9, 1-II, 2-5, 2-6, 2-9, 2-II, 3-8, 3-12, 4-8, 4-12, 5-9, 5-II, 6-9, 6-II, 8-12, and 9-II.

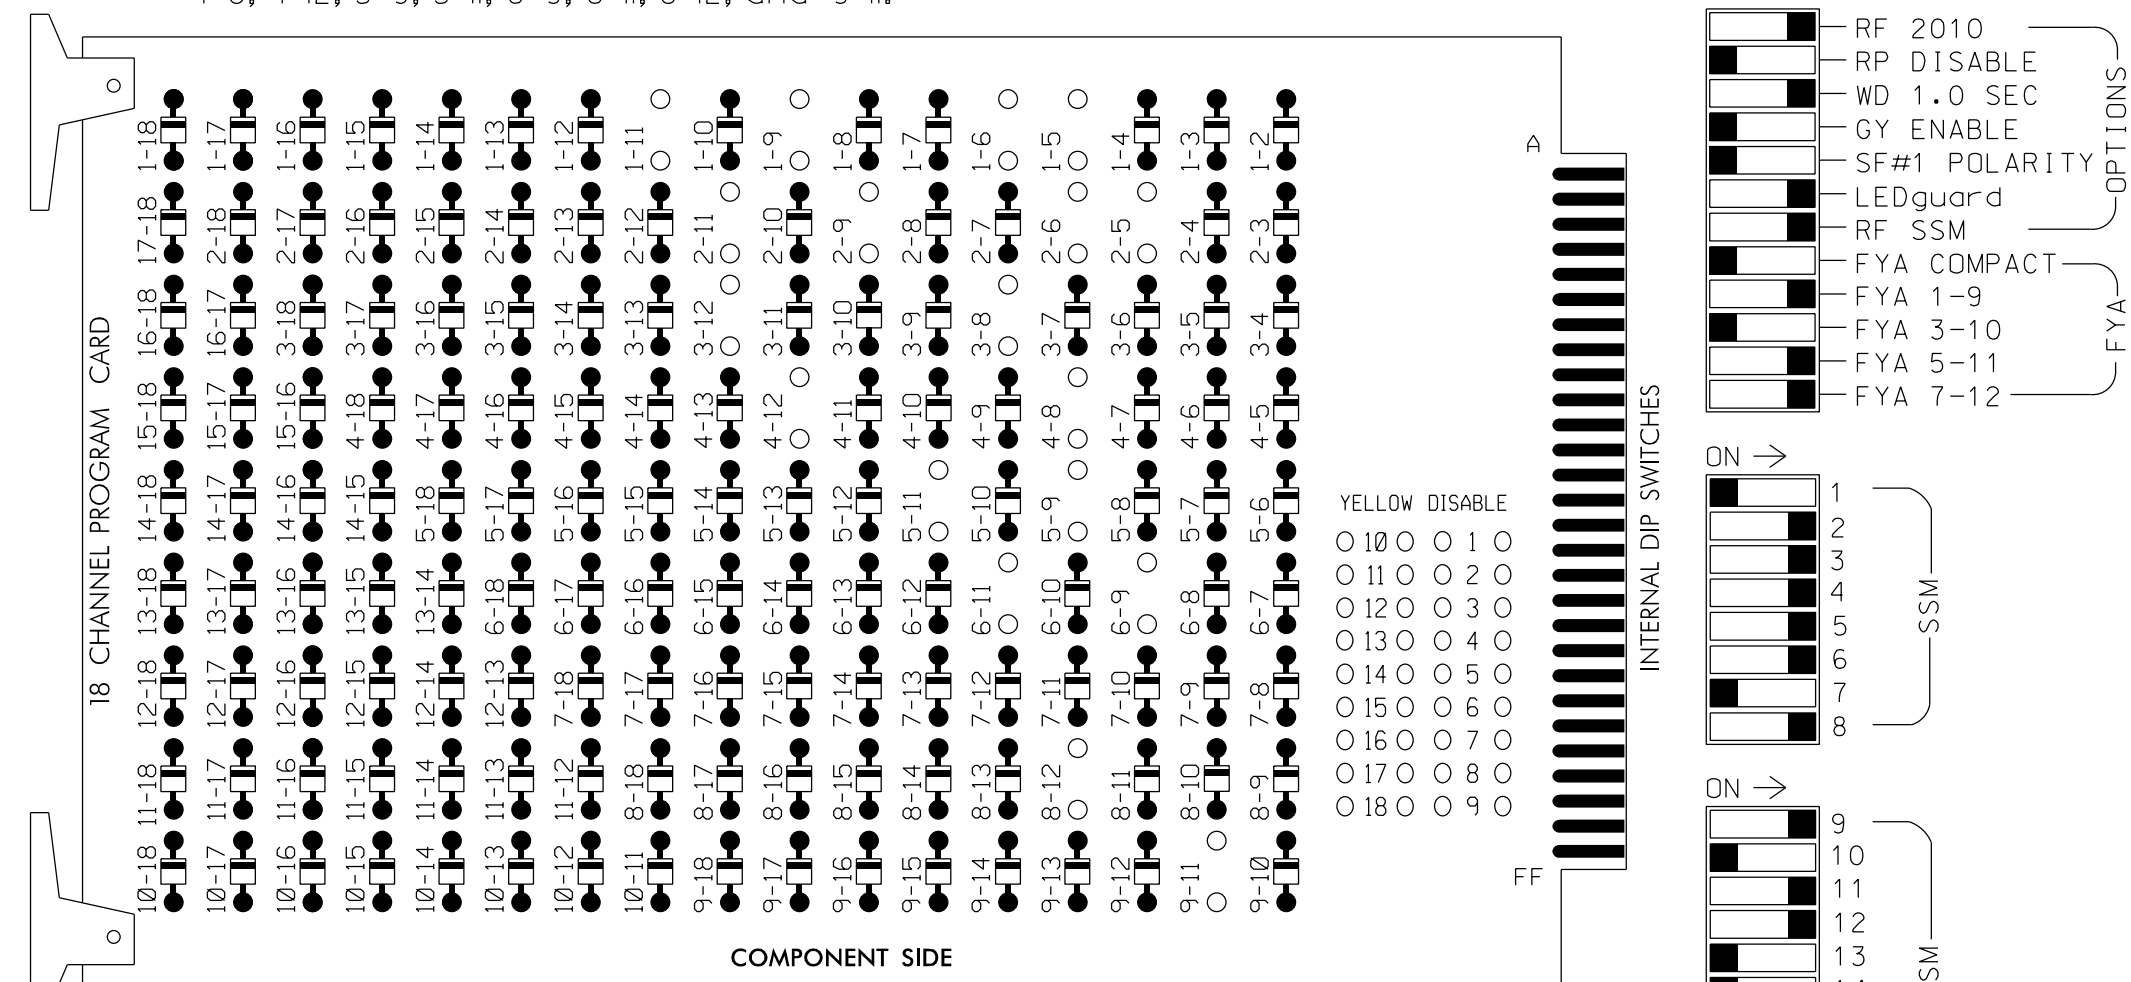

REMOVE JUMPERS AS SHOWN

NOTES:

- Card is provided with all diode jumpers in place. Removal of any jumper allows its channels to run concurrently.
- Ensure jumpers SEL2-SEL5 and SEL9 are present on the monitor board.
- Ensure that Red Enable is active at all times during normal operation.
- Integrate monitor with Ethernet network in cabinet.

NOTES

- To prevent "flash-conflict" problems, insert red flash program blocks for all unused vehicle load switches in the output file. The installer shall verify that signal heads flash in accordance with the Signal Plans.
- Program phase 8 for Dual Entry.
- Program controller to start up in phase 2 Green and 6 Green.
- The cabinet and controller are part of the Burlington-Graham Signal System.

EQUIPMENT INFORMATION

CONTROLLER.....2070LX
 CABINET.....332 W/AUX
 SOFTWARE.....ECONOLITE ASC/3-2070
 CABINET MOUNT.....BASE
 OUTPUT FILE POSITIONS...18 WITH AUX. OUTPUT FILE
 LOAD SWITCHES USED.....S1,S2,S4,S5,S7,S8,S11,AUX S1,
 AUX S4,AUX S5
 PHASES USED.....1,2,3,4,5,6,8
 OVERLAP "A".....*
 OVERLAP "B".....NOT USED
 OVERLAP "C".....*
 OVERLAP "D".....*
 * See overlap programming detail on sheet 2

SIGNAL HEAD HOOK-UP CHART

LOAD SWITCH NO.	S1	S2	S3	S4	S5	S6	S7	S8	S9	S10	S11	S12	AUX S1	AUX S2	AUX S3	AUX S4	AUX S5	AUX S6	
CMU CHANNEL NO.	1	2	13	3	4	14	5	6	15	7	8	16	9	10	17	11	12	18	
PHASE	1	2	2 PED	3	4	4 PED	5	6	6 PED	7	8	8 PED	OLA	OLB	SPARE	OLC	OLD	SPARE	
SIGNAL HEAD NO.	11	21,22	NU	22	31,32	42,43	NU	43	51	61,62	NU	NU	81,82	NU	11	NU	NU	51	41
RED		128			101		*	134		107									
YELLOW	*	129			102			135		108									
GREEN		130			103			136		109									
RED ARROW				116									A121			A114	A101		
YELLOW ARROW				117	117		132						A122			A115	A102		
FLASHING YELLOW ARROW													A123			A116	A103		
GREEN ARROW	127			118	118			133	133										

NU = Not Used

* Denotes install load resistor. See load resistor installation detail this sheet.

★ See pictorial of head wiring in detail this sheet.

INPUT FILE POSITION LAYOUT

(front view)

FILE "I"	1	2	3	4	5	6	7	8	9	10	11	12	13	14
U	∅ 1 1A	∅ 2 2A,2B	∅ 3 3A	∅ 3 3B	∅ 4 4A	∅ 4 4B	∅ 5 5A	∅ 5 5B	∅ 6 6A	∅ 7 7A	∅ 7 7B	∅ 8 8A	∅ 8 8B	∅ 9 9A
L	NOT USED	NOT USED	NOT USED	NOT USED	NOT USED	NOT USED	NOT USED	NOT USED	NOT USED	NOT USED	NOT USED	NOT USED	NOT USED	NOT USED
U	∅ 5 5A	∅ 5 5B	∅ 6 6A	∅ 7 7A	∅ 7 7B	∅ 8 8A	∅ 8 8B	∅ 9 9A	∅ 9 9B	∅ 10 10A	∅ 10 10B	∅ 11 11A	∅ 11 11B	∅ 12 12A
L	NOT USED	NOT USED	NOT USED	NOT USED	NOT USED	NOT USED	NOT USED	NOT USED	NOT USED	NOT USED	NOT USED	NOT USED	NOT USED	NOT USED

EX. : 1A, 2A, ETC. = LOOP NO.*S

FS = FLASH SENSE
 ST = STOP TIME

* Wired Input - Do not populate slot with detector card

INPUT FILE CONNECTION & PROGRAMMING CHART


LOOP NO.	LOOP TERMINAL	INPUT FILE POS.	PIN NO.	DETECTOR NO.	NEMA PHASE	CALL	EXTEND TIME	DELAY TIME	ADDED INITIAL	DETECTOR TYPE
1A ¹	TB2-1,2	I1U	56	1	1	YES		15		S
	-	J4U	48	26	6	YES				S
	2A,2B	TB2-5,6	I2U	39	2	YES				S
	3A	TB4-5,6	I5U	58	3	YES				S
3B	TB4-9,10	I6U	41	4	YES				S	
4A	TB6-1,2	I7U	65	34	4	YES		3		S
4B	TB6-3,4	I7L	78	44	4	YES				S
5A ²	TB3-1,2	J1U	55	5	5	YES		15		S
	-	I4U	47	22	2	YES				S
	5B	TB3-5,6	J2U	40	6	YES		15		S
	6A	TB3-9,10	J3U	64	36	6	YES			S
8A	TB5-9,10	J6U	42	8	8	YES		10		S

¹Add jumper from I1-W to J4-W, on rear of input file.

²Add jumper from J1-W to I4-W, on rear of input file.

FYA PPLT SIGNAL WIRING DETAIL

(wire signal heads as shown)

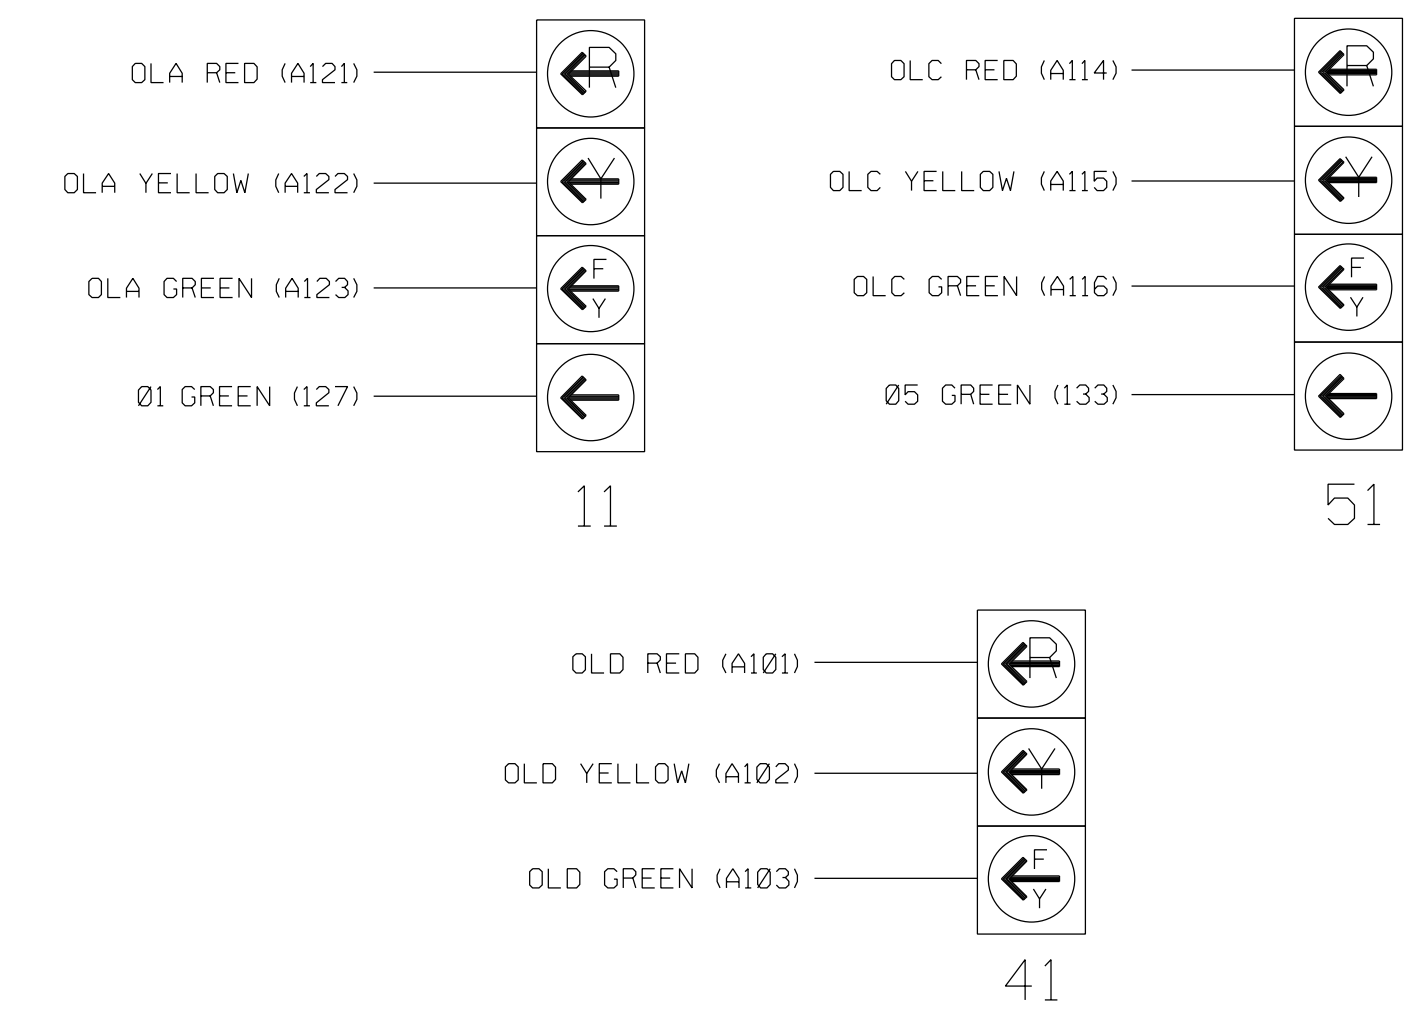


LOAD RESISTOR INSTALLATION DETAIL


(install resistors as shown)

ACCEPTABLE VALUES

VALUE (ohms)	WATTAGE
1.5K - 1.9K	25W (min)
2.0K - 3.0K	10W (min)

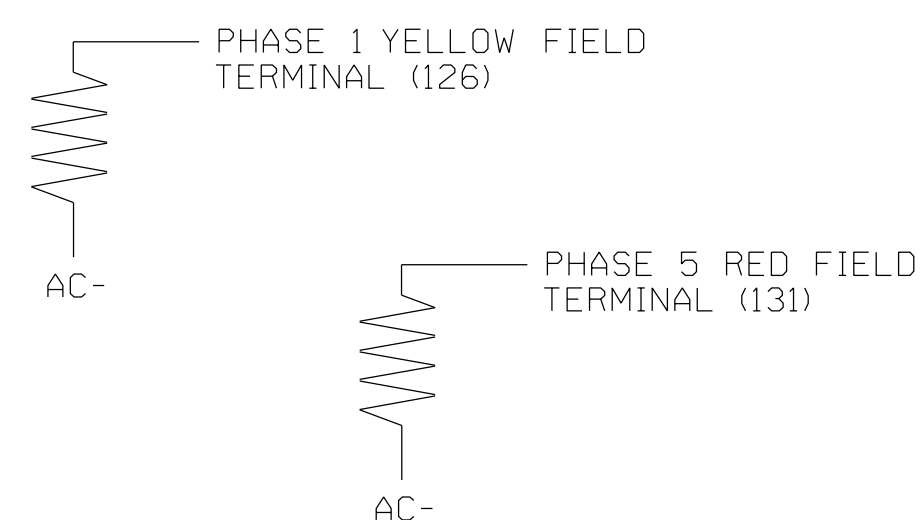


INPUT FILE POSITION LEGEND: J2L

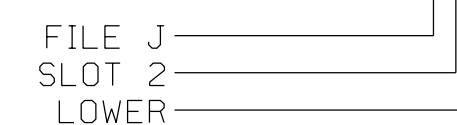

Electrical Detail - Sheet 1 of 2

ELECTRICAL AND PROGRAMMING DETAILS FOR:

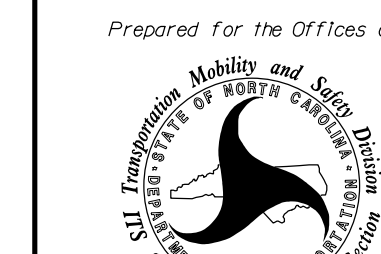


NC 62 (Alamance Road)
 at
 SR 1430 (Ramada Road)/
 Kirkwood Drive

Division 7 Alamance County Burlington
 PLAN DATE: November 2017 REVIEWED BY: AM Encarnacion
 PREPARED BY: NA Ptak REVIEWED BY: PL Alexander

750 N.Greenfield Pkwy, Garner, NC 27529

ATKINS 1616 EAST MILLBROOK ROAD, SUITE 160 RALEIGH, NORTH CAROLINA 27609 (919) 876-6888 NCBEES #F-0326

DOCUMENT NOT CONSIDERED FINAL UNLESS ALL SIGNATURES COMPLETED

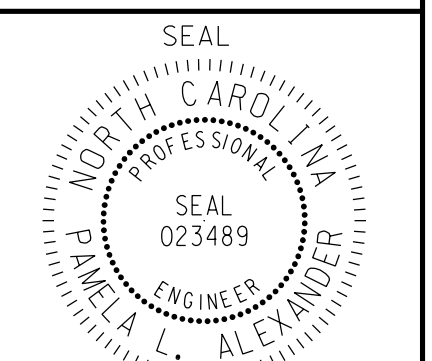

Revisions table with columns: REVISIONS, INIT., DATE. Includes signature of Pamela Alexander and date 6/9/2018.

SIG. INVENTORY NO. 07-1230

ECONOLITE ASC/3-2070 OVERLAP PROGRAMMING DETAIL

(program controller as shown)

1. From Main Menu select 2. CONTROLLER
2. From CONTROLLER Submenu select 2. VEHICLE OVERLAPS

OVERLAP A

Select TMG VEH OVLP [A] and 'PPLT FYA'

TMG VEH OVLP...[A] TYPE:PPLT FYA

PROTECTED LEFT TURN.... PHASE 1
OPPOSING THROUGH..... PHASE 2

FLASHING ARROW OUTPUT.....CH9 ISOLATE

DELAY START OF: FYA..0.0 CLEARANCE..0.0
ACTION PLAN SF BIT DISABLE..... 0

Toggle Twice

OVERLAP C

Select TMG VEH OVLP [C] and 'PPLT FYA'

TMG VEH OVLP...[C] TYPE:PPLT FYA

PROTECTED LEFT TURN.... PHASE 5
OPPOSING THROUGH..... PHASE 6

FLASHING ARROW OUTPUT.....CH11 ISOLATE

DELAY START OF: FYA..0.0 CLEARANCE..0.0
ACTION PLAN SF BIT DISABLE..... 0

Toggle Once

OVERLAP D

Select TMG VEH OVLP [D] and 'OTHER/ECONOLITE'

TMG VEH OVLP...[D] TYPE:OTHER/ECONOLITE

PHASES 1 2 3 4 5 6 7 8 9 0 1 2 3 4 5 6

INCLUDED X

PROTECT

PED PRTC

NOT OVLP

FLSH GRN 1

LAG X PH

LAG 2 PH

LAG GRN 0.0 YEL 0.0 RED 0.0 ADV GRN 0.0

END PROGRAMMING

FLASHER CIRCUIT MODIFICATION DETAIL

IN ORDER TO ENSURE THAT SIGNALS FLASH CONCURRENTLY ON THE SAME APPROACH, MAKE THE FOLLOWING FLASHER CIRCUIT CHANGES:

1. ON REAR OF PDA - REMOVE WIRE FROM TERM. T2-4 AND TERMINATE ON T2-2.
2. ON REAR OF PDA - REMOVE WIRE FROM TERM. T2-5 AND TERMINATE ON T2-3.
3. REMOVE FLASHER UNIT 2.

THE CHANGES LISTED ABOVE TIES ALL PHASES AND OVERLAPS TO FLASHER UNIT 1.

THIS ELECTRICAL DETAIL IS FOR
THE SIGNAL DESIGN: 07-1230
DESIGNED: November 2017
SEALED: 6/7/2018
REVISED: N/A

09-JUN-2018 14:14
D:\Consolidation\Projects\00056469 U-6015 B-G S19 SysTask 05_11_Signal\Des\gn\wlr\ing\07-1230E.dgn
ALEX3361 AT LUS33069

Electrical Detail - Sheet 2 of 2

**DOCUMENT NOT CONSIDERED
FINAL UNLESS ALL
SIGNATURES COMPLETED**

<p style="font-size: small;">ELECTRICAL AND PROGRAMMING DETAILS FOR:</p> <p style="font-size: x-small;">Prepared for the Offices of:</p> <p style="font-size: x-small;">750 N. Greenfield Pkwy, Garner, NC 27529</p>	<p>NC 62 (Alamance Road) at SR 1430 (Ramada Road)/ Kirkwood Drive</p> <p style="font-size: x-small;">Division 7 Alamance County Burlington</p> <p>PLAN DATE: November 2017 REVIEWED BY: AM Encarnacion</p> <p>PREPARED BY: NA Ptak REVIEWED BY: PL Alexander</p> <table style="width: 100%; border-collapse: collapse;"> <thead> <tr> <th style="font-size: x-small;">REVISIONS</th> <th style="font-size: x-small;">INIT.</th> <th style="font-size: x-small;">DATE</th> </tr> </thead> <tbody> <tr> <td> </td> <td> </td> <td> </td> </tr> </tbody> </table>	REVISIONS	INIT.	DATE				<p style="font-size: x-small;">SEAL</p> <p style="font-size: x-small;">SEAL 023489 PAMELA L. ALEXANDER ENGINEER</p> <p style="font-size: x-small;">Digitally signed by Pamela Alexander 6/9/2018 DATE</p> <p style="font-size: x-small;">SIG. INVENTORY NO. 07-1230</p>
REVISIONS	INIT.	DATE						

ATKINS 1616 EAST MILLBROOK ROAD, SUITE 160
RALEIGH, NORTH CAROLINA 27609
(919) 876-6888 NCBEES #F-0326

PHASING DIAGRAM


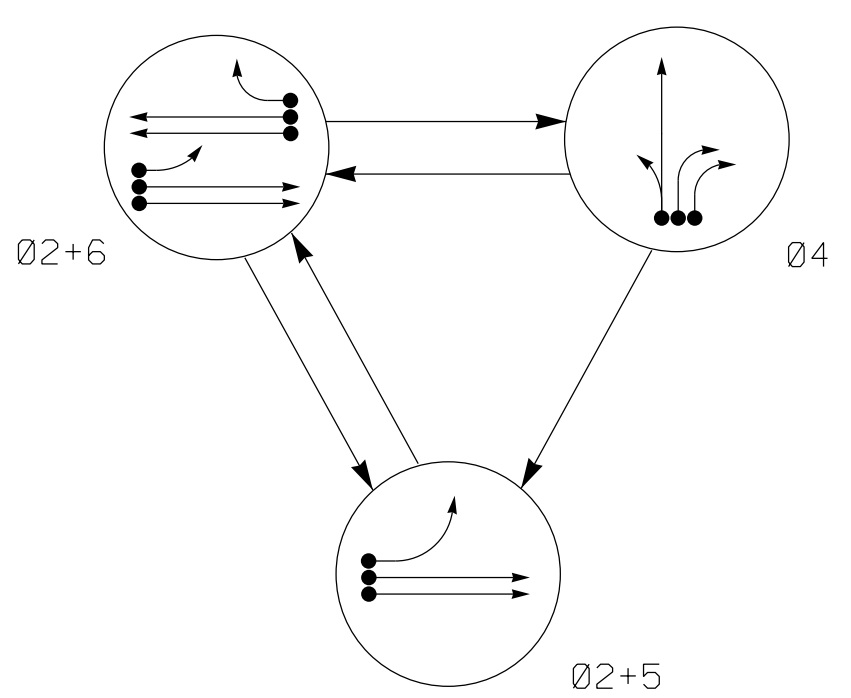


TABLE OF OPERATION

SIGNAL FACE	PHASE			FLASH
	Ø2+6	Ø4	Ø2+5	
21,22	G	R	Y	
41,42,43	R	R	R	
51	—	—	—	—
61,62	R	G	Y	

SIGNAL FACE I.D.

All Heads L.E.D.

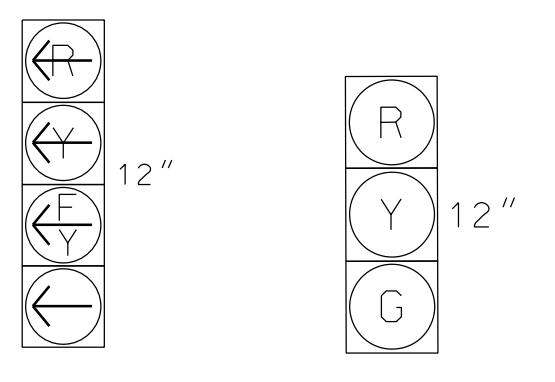

ASC/3 DETECTOR INSTALLATION CHART



LOOP	SIZE (FT)	DISTANCE FROM STOPBAR (FT)	PROGRAMMING									
			DETECTOR	PHASE	CALLING	EXTEND TIME	DELAY TIME	USE ADDED INITIAL	TYPE	SYSTEM LOOP	NEW CARD	
2A	6X30	70	EXIST	-	2	Yes	-	-	-	S	-	X
4A	6X60	0	2-4-2	-	4	Yes	-	-	-	S	-	X
4B	6X60	0	2-4-2	-	4	Yes	-	15	-	S	-	X
4C	6X60	0	2-4-2	-	4	Yes	-	15	-	S	-	X
5A	6X60	+5	2-4-2	-	5	Yes	-	15	-	S	-	X
6A	6X30	70	EXIST	-	6	Yes	-	-	-	S	-	X
S1	6X6	+140	EXIST	-	-	NO	-	-	-	N	X	X
S2	6X6	+140	EXIST	-	-	NO	-	-	-	N	X	X

3 Phase Fully Actuated (Burlington-Graham Signal System)

NOTES

1. Refer to "Roadway Standard Drawings NCDOT" dated January 2018 and "Standard Specifications for Roads and Structures" dated January 2018.
2. Do not program signal for late night flashing operation unless otherwise directed by the Engineer.
3. Phase 5 may be lagged.
4. Set all detector units to presence mode.
5. In the event of loop replacement, refer to the current ITS and Signals Design Manual and submit a Plan of Record to the Signal Design Section.
6. Locate new cabinet so as not to obstruct sight distance of vehicles turning right on red.
7. Pavement markings are existing.
8. Maximum times shown in timing chart are for free-run operation only. Coordinated signal system timing values supersede these values.

PHASING DIAGRAM DETECTION LEGEND

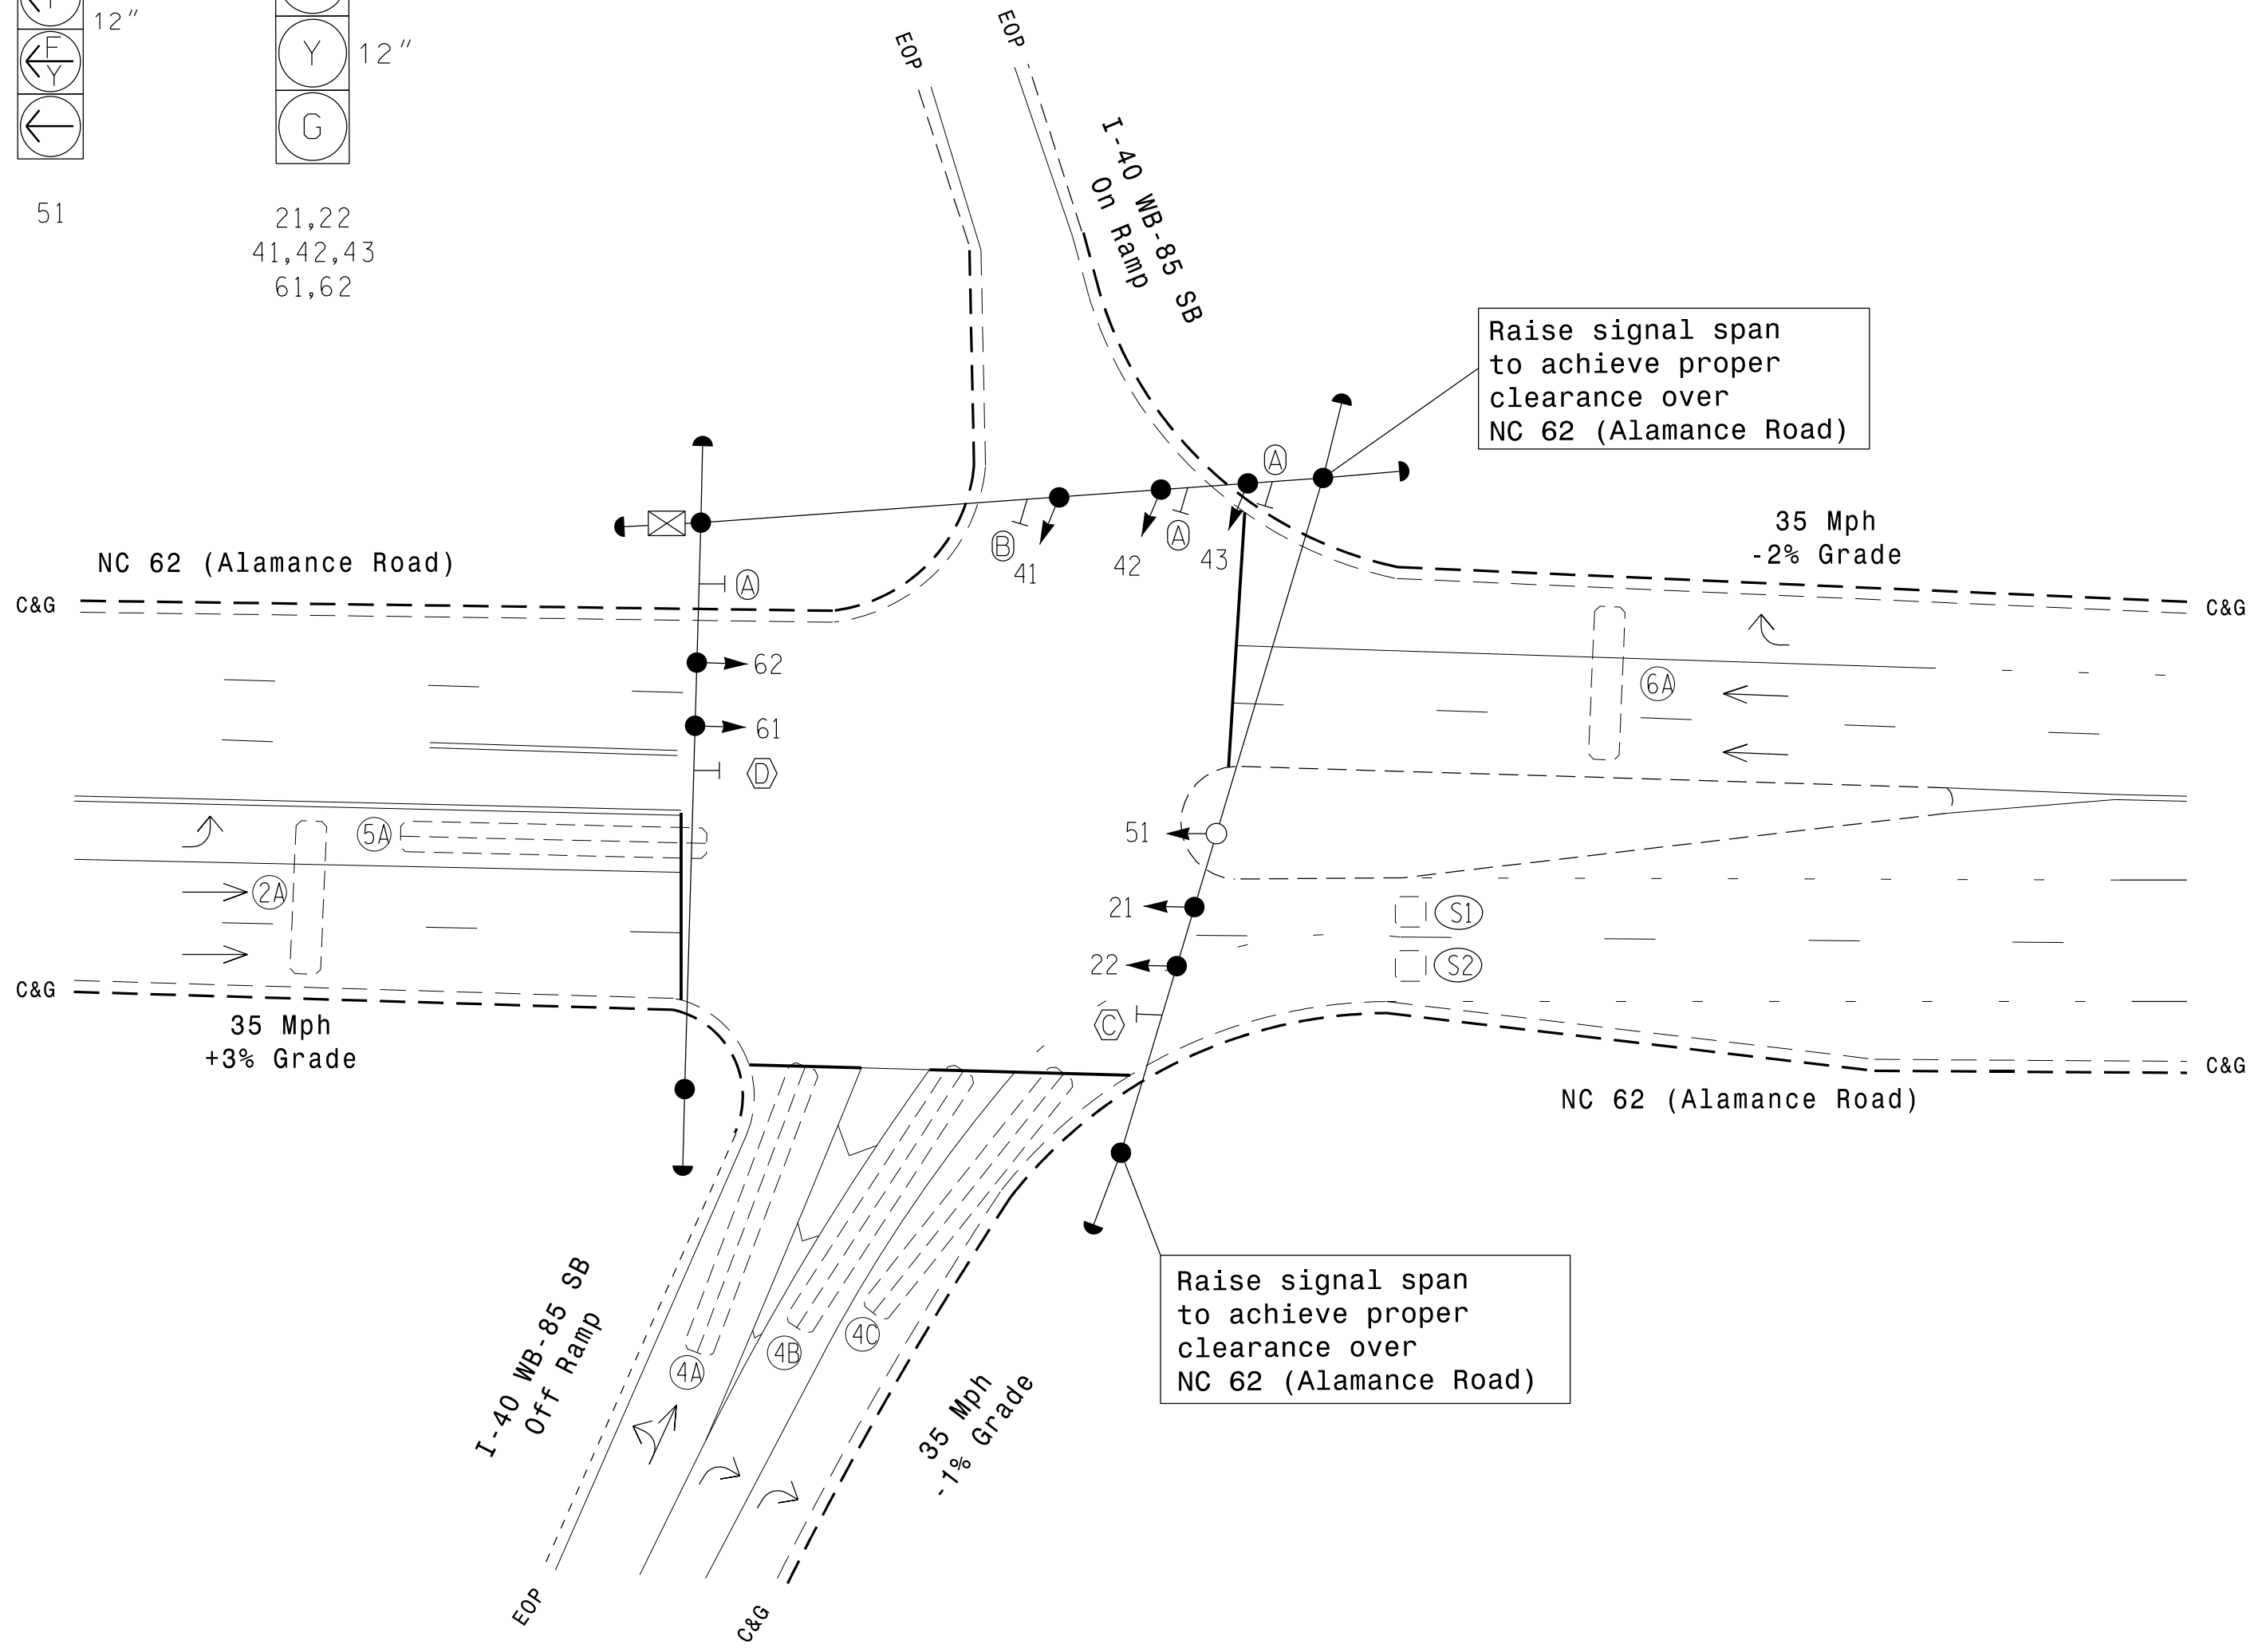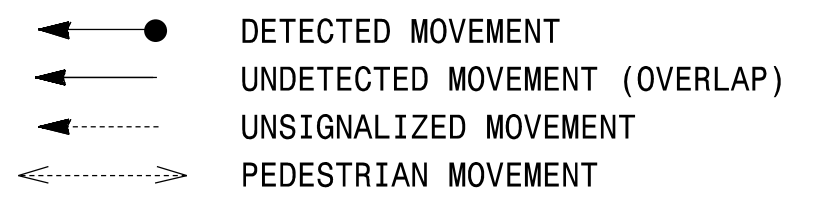


ASC/3 TIMING CHART

FEATURE	PHASE			
	2	4	5	6
Min Green *	10	7	7	10
Walk *	0	0	0	0
Ped Clear	0	0	0	0
Veh. Extension *	3.0	2.0	2.0	3.0
Max 1 *	45	30	20	45
Yellow	4.0	3.9	3.0	4.0
Red Clear	2.2	2.2	2.9	2.2
Actuations B4 Add *	-	-	-	-
Seconds / Actuation *	-	-	-	-
Max Initial *	-	-	-	-
Time Before Reduction *	-	-	-	-
Time To Reduce *	-	-	-	-
Minimum Gap	-	-	-	-
Locking Detector	X	-	-	X
Recall Position	VEH. RECALL	-	-	VEH. RECALL
Dual Entry	-	-	-	-
Simultaneous Gap	X	X	X	X

* These values may be field adjusted. Do not adjust Min Green and Extension times for phases 2 and 6 lower than what is shown. Min Green for all other phases should not be lower than 4 seconds.

LEGEND

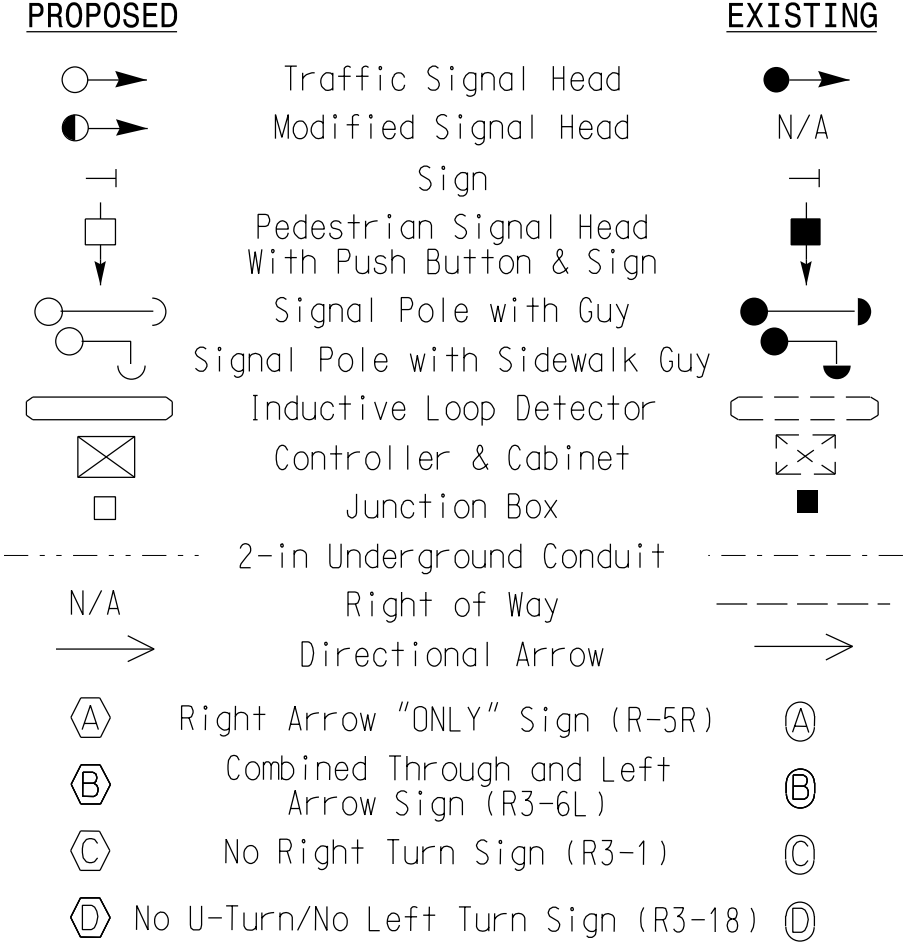

Signal Upgrade

Prepared for the Offices of:

 750 N. Greenfield Pkwy, Garner, NC 27529

**NC 62 (Alamance Road)
at
I-40 WB-85 SB Ramps**

Division 7 Alamance County Burlington

PLAN DATE: November 2017 REVIEWED BY: AM Encarnacion

PREPARED BY: NA Ptak REVIEWED BY: PL Alexander

REVISIONS

DOCUMENT NOT CONSIDERED FINAL
UNLESS ALL SIGNATURES COMPLETED

SEAL

 PAMELA L. ALEXANDER
 ENGINEER

SCALE: 0 30
1"=30'

DATE: 6/7/2018
 SIGNATURE: Pamela Alexander
 DATE: 6/7/2018
 SIG. INVENTORY NO. 07-1231


ATKINS 1616 EAST MILLBROOK ROAD, SUITE 160
 RALEIGH, NORTH CAROLINA 27609
 (919) 876-6888 NCBES #F-0326

07-JUN-2018 11:15 D:\Projects\2018\Projects\Task\00056469 U-6015 B-6 Sig Sys\Task 05_11_Signals\Des\gnm07-1231.dgn ALEX3561 AT LUS35669

EDI MODEL 2018ECLip-NC CONFLICT MONITOR PROGRAMMING DETAIL

(remove jumpers and set switches as shown)


REMOVE DIODE JUMPERS 2-5, 2-6, 2-11, 5-11, and 6-11.

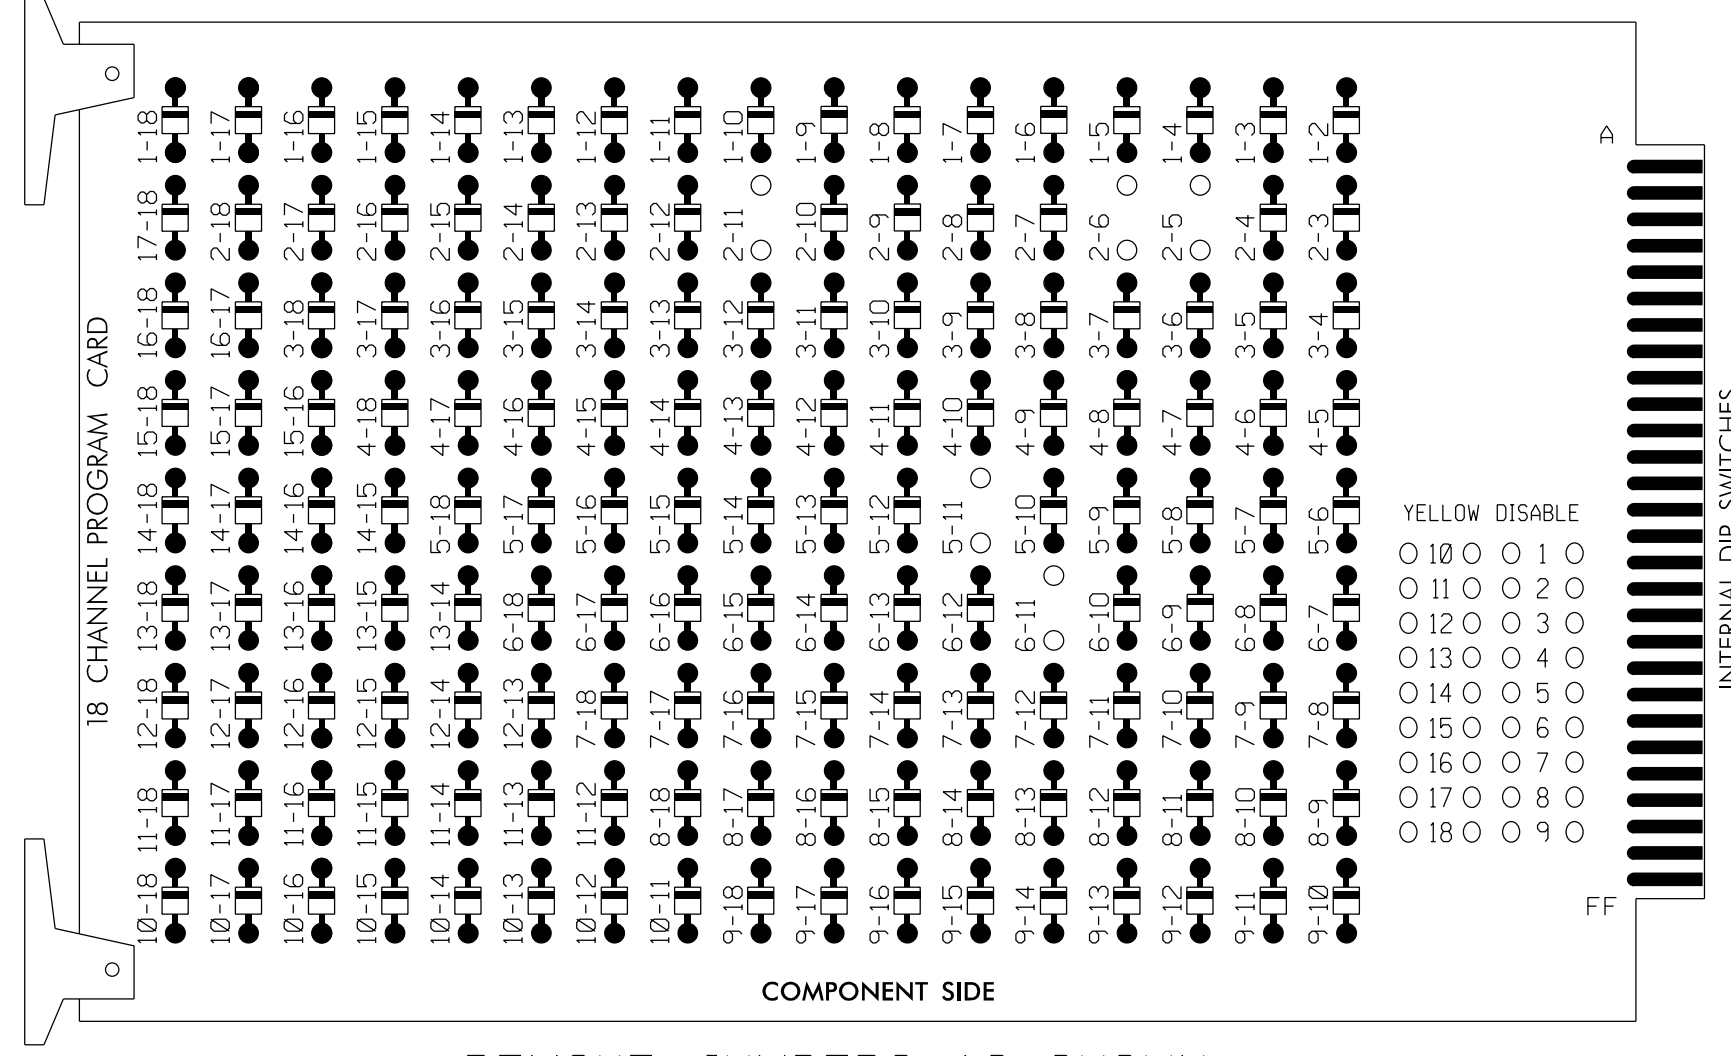

REMOVE JUMPERS AS SHOWN

NOTES:

1. Card is provided with all diode jumpers in place. Removal of any jumper allows its channels to run concurrently.
2. Ensure jumpers SEL2-SEL5 and SEL9 are present on the monitor board.
3. Ensure that Red Enable is active at all times during normal operation.
4. Integrate monitor with Ethernet network in cabinet.

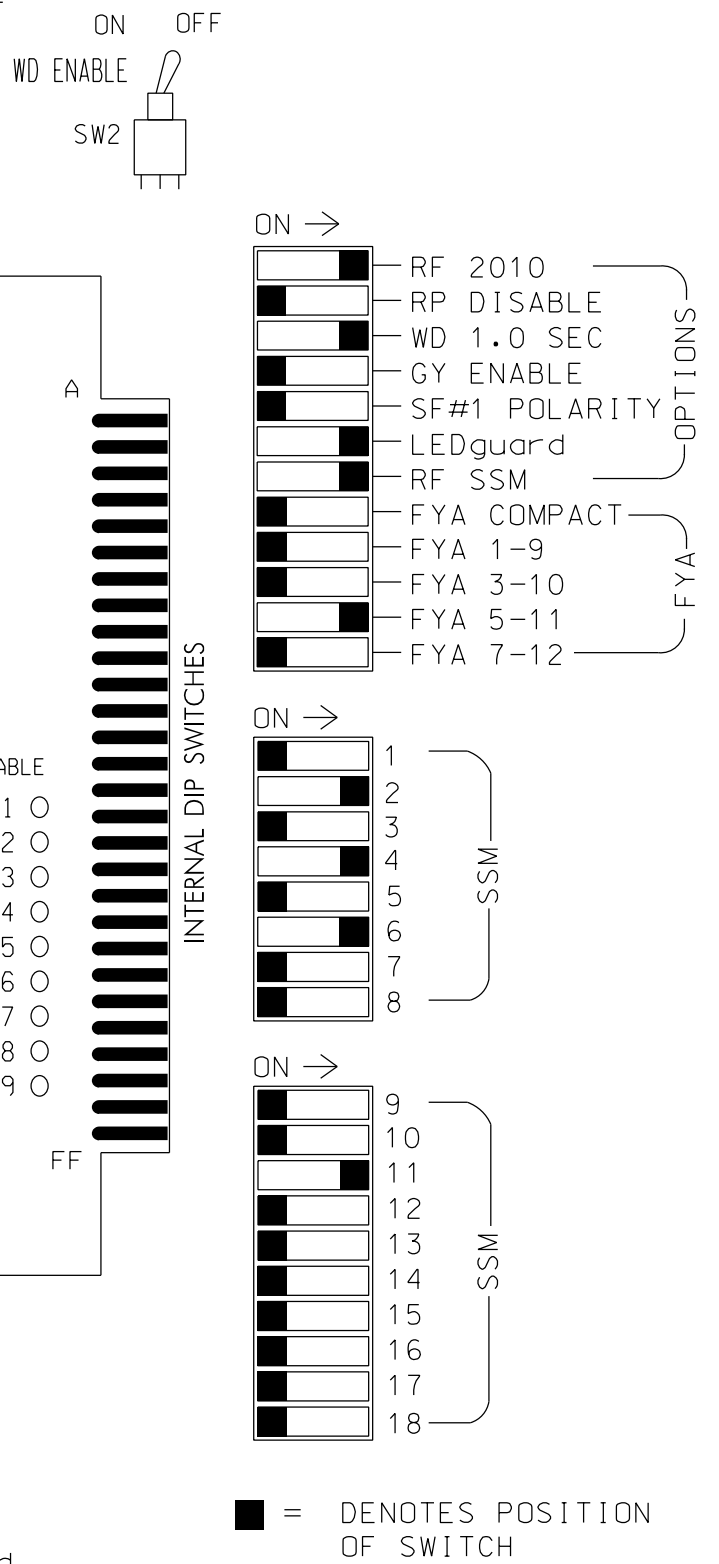

NOTES

1. To prevent "flash-conflict" problems, insert red flash program blocks for all unused vehicle load switches in the output file. The installer shall verify that signal heads flash in accordance with the Signal Plans.
2. Program controller to start up in phase 2 Green and 6 Green.
3. The cabinet and controller are part of the Burlington-Graham Signal System.

EQUIPMENT INFORMATION

CONTROLLER.....2070LX
 CABINET.....332 W/AUX
 SOFTWARE.....ECONDLITE ASC/3-2070
 CABINET MOUNT.....BASE
 OUTPUT FILE POSITIONS...18 WITH AUX. OUTPUT FILE
 LOAD SWITCHES USED.....S2,S5,S7,S8,AUX S4
 PHASES USED.....2,4,5,6
 OVERLAP "A".....NOT USED
 OVERLAP "B".....NOT USED
 OVERLAP "C".....*
 OVERLAP "D".....NOT USED

* See sheet 2 for overlap programming.

PROJECT REFERENCE NO.	SHEET NO.
U-6015	Sig. 109.1

SIGNAL HEAD HOOK-UP CHART


LOAD SWITCH NO.	S1	S2	S3	S4	S5	S6	S7	S8	S9	S10	S11	S12	AUX S1	AUX S2	AUX S3	AUX S4	AUX S5	AUX S6	
CMU CHANNEL NO.	1	2	13	3	4	14	5	6	15	7	8	16	9	10	17	11	12	18	
PHASE	1	2	2 PED	3	4	4 PED	5	6	6 PED	7	8	8 PED	OLA	OLB	SPARE	OLC	OLD	SPARE	
SIGNAL HEAD NO.	NU	21,22	NU	NU	41,42,43	NU	51	61,62	NU	NU	NU	NU	NU	NU	NU	51	NU	NU	
RED		128			101			134											
YELLOW		129			102		*	135											
GREEN		130			103			136											
RED ARROW																		A114	
YELLOW ARROW																			A115
FLASHING YELLOW ARROW																			A116
GREEN ARROW								133											

NU = Not Used

- * See pictorial of head wiring in detail this sheet.
- * Denotes install load resistor. See load resistor installation detail this sheet.

INPUT FILE POSITION LAYOUT

(front view)

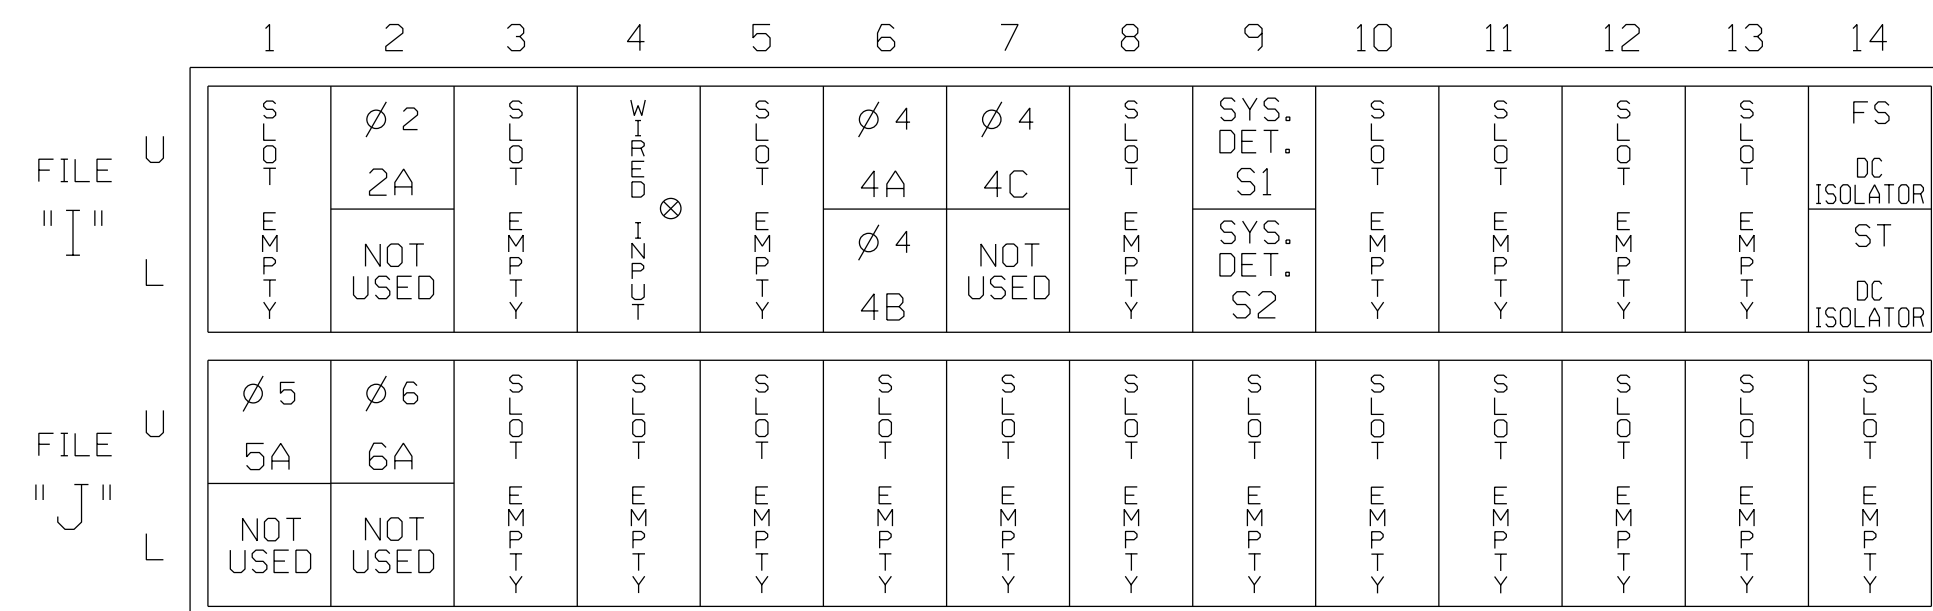

EX.: 1A, 2A, ETC. = LOOP NO.'S

FS = FLASH SENSE
 ST = STOP TIME

⊗ Wired Input - Do not populate slot with detector card


INPUT FILE CONNECTION & PROGRAMMING CHART

LOOP NO.	LOOP TERMINAL	INPUT FILE POS.	PIN NO.	DETECTOR NO.	NEMA PHASE	CALL	EXT TIME	DELAY TIME	ADDED INITIAL	DETECTOR TYPE
2A	TB2-5,6	I2U	39	2	2	YES				S
4A	TB4-9,10	I6U	41	4	4	YES				S
4B	TB4-11,12	I6L	45	14	4	YES		15		S
4C	TB6-1,2	I7U	65	34	4	YES		15		S
5A ¹	TB3-1,2	J1U	55	5	5	YES		15		S
	-	I4U	47	22	2	YES				S
6A	TB3-5,6	J2U	40	6	6	YES				S
* S1	TB6-9,10	I9U	60	11	SYS	NO				N
* S2	TB6-11,12	I9L	62	13	SYS	NO				N

¹Add jumper from J1-W to I4-W, on rear of input file.


* System detector only. Remove any assigned vehicle phase.

INPUT FILE POSITION LEGEND: J2L

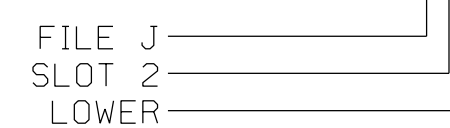

FYA SIGNAL WIRING DETAIL

(wire signal head as shown)

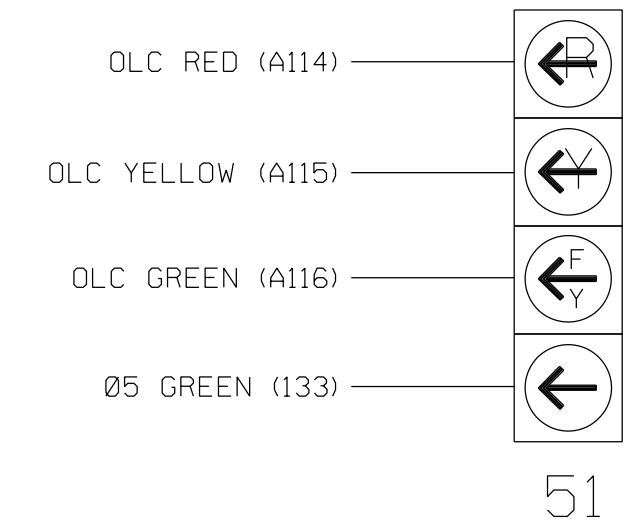


LOAD RESISTOR INSTALLATION DETAIL

(install resistor as shown)

ACCEPTABLE VALUES

VALUE (ohms)	WATTAGE
1.5K - 1.9K	25W (min)
2.0K - 3.0K	10W (min)

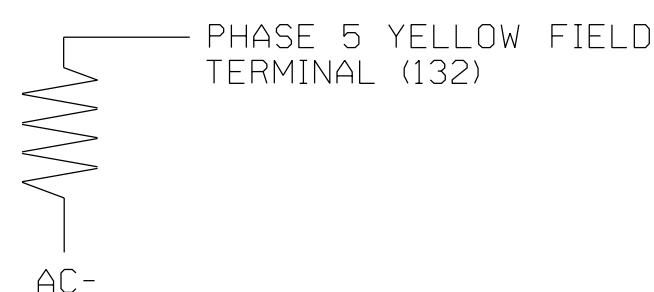

Electrical Detail - Sheet 1 of 2

DOCUMENT NOT CONSIDERED FINAL UNLESS ALL SIGNATURES COMPLETED

Prepared for the Offices of: 	NC 62 (Alamance Road) at I-40 WB-85 SB Ramps		SEAL NORTH CAROLINA PROFESSIONAL ENGINEER PAMELA L. ALEXANDER 023489
	Division 7 Alamance County Burlington	PLAN DATE: November 2017 REVIEWED BY: AM Encarnacion	
PREPARED BY: NA Ptak	REVIEWED BY: PL Alexander		Date: 6/9/2018 Signature: Pamela Alexander
REVISIONS	INIT.	DATE	
SIG. INVENTORY NO. 07-1231			DATE

ATKINS 1616 EAST MILLBROOK ROAD, SUITE 160
 RALEIGH, NORTH CAROLINA 27609
 (919) 876-6888 NCBEES #F-0326

750 N. Greenfield Pkwy, Garner, NC 27529

ECONOLITE ASC/3-2070 OVERLAP PROGRAMMING DETAIL

(program controller as shown)

1. From Main Menu select 2. CONTROLLER
2. From CONTROLLER Submenu select 2. VEHICLE OVERLAPS

Toggle Twice

OVERLAP C

Select TMG VEH OVLP [C] and 'PPLT FYA'

```

TMG VEH OVLP...[C] TYPE: .....PPLT FYA
PROTECTED LEFT TURN.... PHASE 5
OPPOSING THROUGH..... PHASE 6

FLASHING ARROW OUTPUT.....CH11 ISOLATE
DELAY START OF: FYA..0.0 CLEARANCE..0.0
ACTION PLAN SF BIT DISABLE..... 0
    
```

END PROGRAMMING

THIS ELECTRICAL DETAIL IS FOR
 THE SIGNAL DESIGN: 07-1231
 DESIGNED: November 2017
 SEALED: 6/7/2018
 REVISED: N/A

09-JUN-2018 14:14
 D:\Transpor\at\at\off\c\cur\100056469 U-6015 B-G S1g Sys\Task 05_11_Signal\Des\gn\w\tr\ing\07-1231E.dgn
 ALEX3361 AT LUS210649

Electrical Detail - Sheet 2 of 2


**DOCUMENT NOT CONSIDERED
 FINAL UNLESS ALL
 SIGNATURES COMPLETED**

<p style="text-align: center; font-size: small;">ELECTRICAL AND PROGRAMMING DETAILS FOR:</p> <p style="text-align: center; font-size: x-small;">Prepared for the Offices of:</p> <p style="text-align: center; font-size: x-small;">750 N. Greenfield Pkwy, Garner, NC 27529</p>	<p>NC 62 (Alamance Road) at I-40 WB-85 SB Ramps</p> <p style="font-size: small;">Division 7 Alamance County Burlington</p> <p style="font-size: x-small;">PLAN DATE: November 2017 REVIEWED BY: AM Encarnacion PREPARED BY: NA Ptak REVIEWED BY: PL Alexander</p> <table border="1" style="width: 100%; border-collapse: collapse;"> <thead> <tr> <th style="font-size: x-small;">REVISIONS</th> <th style="font-size: x-small;">INIT.</th> <th style="font-size: x-small;">DATE</th> </tr> </thead> <tbody> <tr> <td> </td> <td> </td> <td> </td> </tr> </tbody> </table>	REVISIONS	INIT.	DATE				<p style="font-size: x-small;">SEAL</p> <p style="font-size: x-small;">Sealed by: Pamela Alexander DATE: 6/9/2018</p> <p style="font-size: x-small;">SIG. INVENTORY NO. 07-1231</p>
REVISIONS	INIT.	DATE						

ATKINS

1616 EAST MILLBROOK ROAD, SUITE 160
 RALEIGH, NORTH CAROLINA 27609
 (919) 876-6888 NCBEES #F-0326

PHASING DIAGRAM

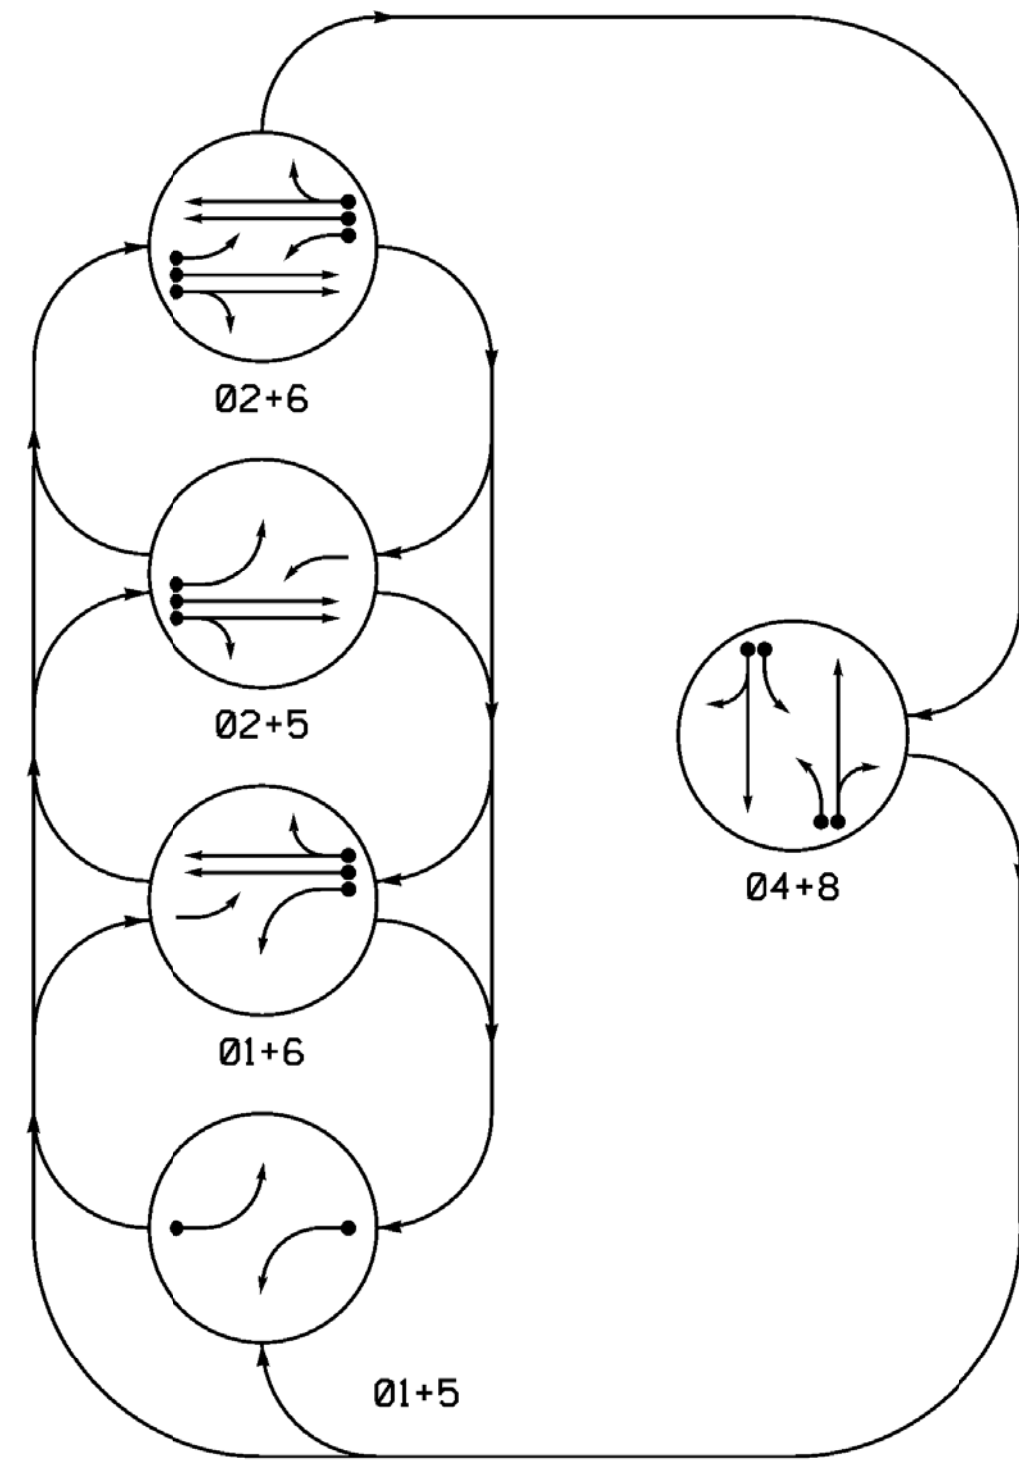

PHASING DIAGRAM DETECTION LEGEND


- DETECTED MOVEMENT
- UNDETECTED MOVEMENT (OVERLAP)
- UNSIGNALIZED MOVEMENT
- PEDESTRIAN MOVEMENT

TABLE OF OPERATION

SIGNAL FACE	PHASE						
	01+5	02+6	02+5	04+8	F	L	R
11	-	-	F	F	R	Y	
21, 22	R	R	G	G	R	Y	
41, 42	R	R	R	R	G	R	
43	R	R	R	R	F	R	
51	-	F	-	F	R	Y	
61, 62	R	G	R	G	R	Y	
81, 82	R	R	R	R	G	R	
83	R	R	R	R	F	R	

SIGNAL FACE I.D.

All Heads L.E.D.

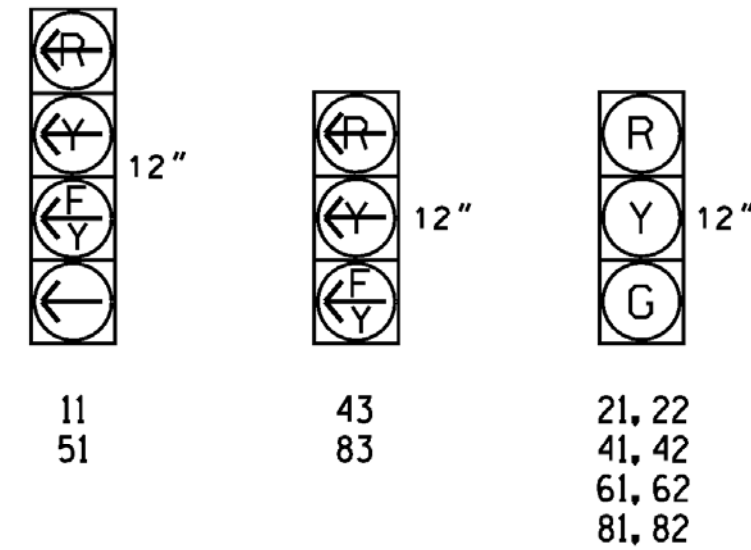


ASC/3 DETECTOR INSTALLATION CHART

LOOP	SIZE (FT)	DISTANCE FROM STOPBAR (FT)	TURNS	NEW LOOP	PROGRAMMING							
					PHASE	CALLING	EXTEND TIME	DELAY TIME	USE ADDED INITIAL	TYPE	LOOP	NEW CARD
1A	6x60	+5	2-4-2	-	1	Yes	-	15	-	S	-	X
					6	Yes	-	3	-	G	-	X
2A	6x6	250	4	X	2	Yes	-	-	X	N	-	X
2B	6x6	250	4	X	2	Yes	-	-	X	N	-	X
4A	6x60	+5	2-4-2	-	4	Yes	-	3	-	S	-	X
4B	6x60	+5	2-4-2	-	4	Yes	-	10	-	S	-	X
5A	6x60	+5	2-4-2	-	5	Yes	-	15	-	S	-	X
					2	Yes	-	3	-	G	-	X
6A	6x6	250	4	X	6	Yes	-	-	X	N	-	X
6B	6x6	250	4	X	6	Yes	-	-	X	N	-	X
8A	6x60	+10	2-4-2	-	8	Yes	-	3	-	S	-	X
8B	6x60	+10	2-4-2	-	8	Yes	-	10	-	S	-	X

5 Phase Fully Actuated (Burlington-Graham Signal System)

NOTES

- Refer to "Roadway Standard Drawings NCDOT" dated January 2018 and "Standard Specifications for Roads and Structures" dated January 2018.
- Do not program signal for late night flashing operation unless otherwise directed by the Engineer.
- Phase 1 and/or phase 5 may be lagged.
- Reposition existing signal heads numbered 22, 41, 42, 62, 81, and 82.
- Set all detector units to presence mode.
- In the event of loop replacement, refer to the current ITS and Signals Design Manual and submit a Plan of Record to the Signal Design Section.
- Locate new cabinet so as not to obstruct sight distance of vehicles turning right on red.
- Remove existing Left Arrow "ONLY" signs (R3-5L) and existing "LEFT TURN YIELD ON GREEN" ball signs (R10-12).
- Pavement markings are existing.
- Maximum times shown in timing chart are for free-run operation only. Coordinated signal system timing values supersede these values.

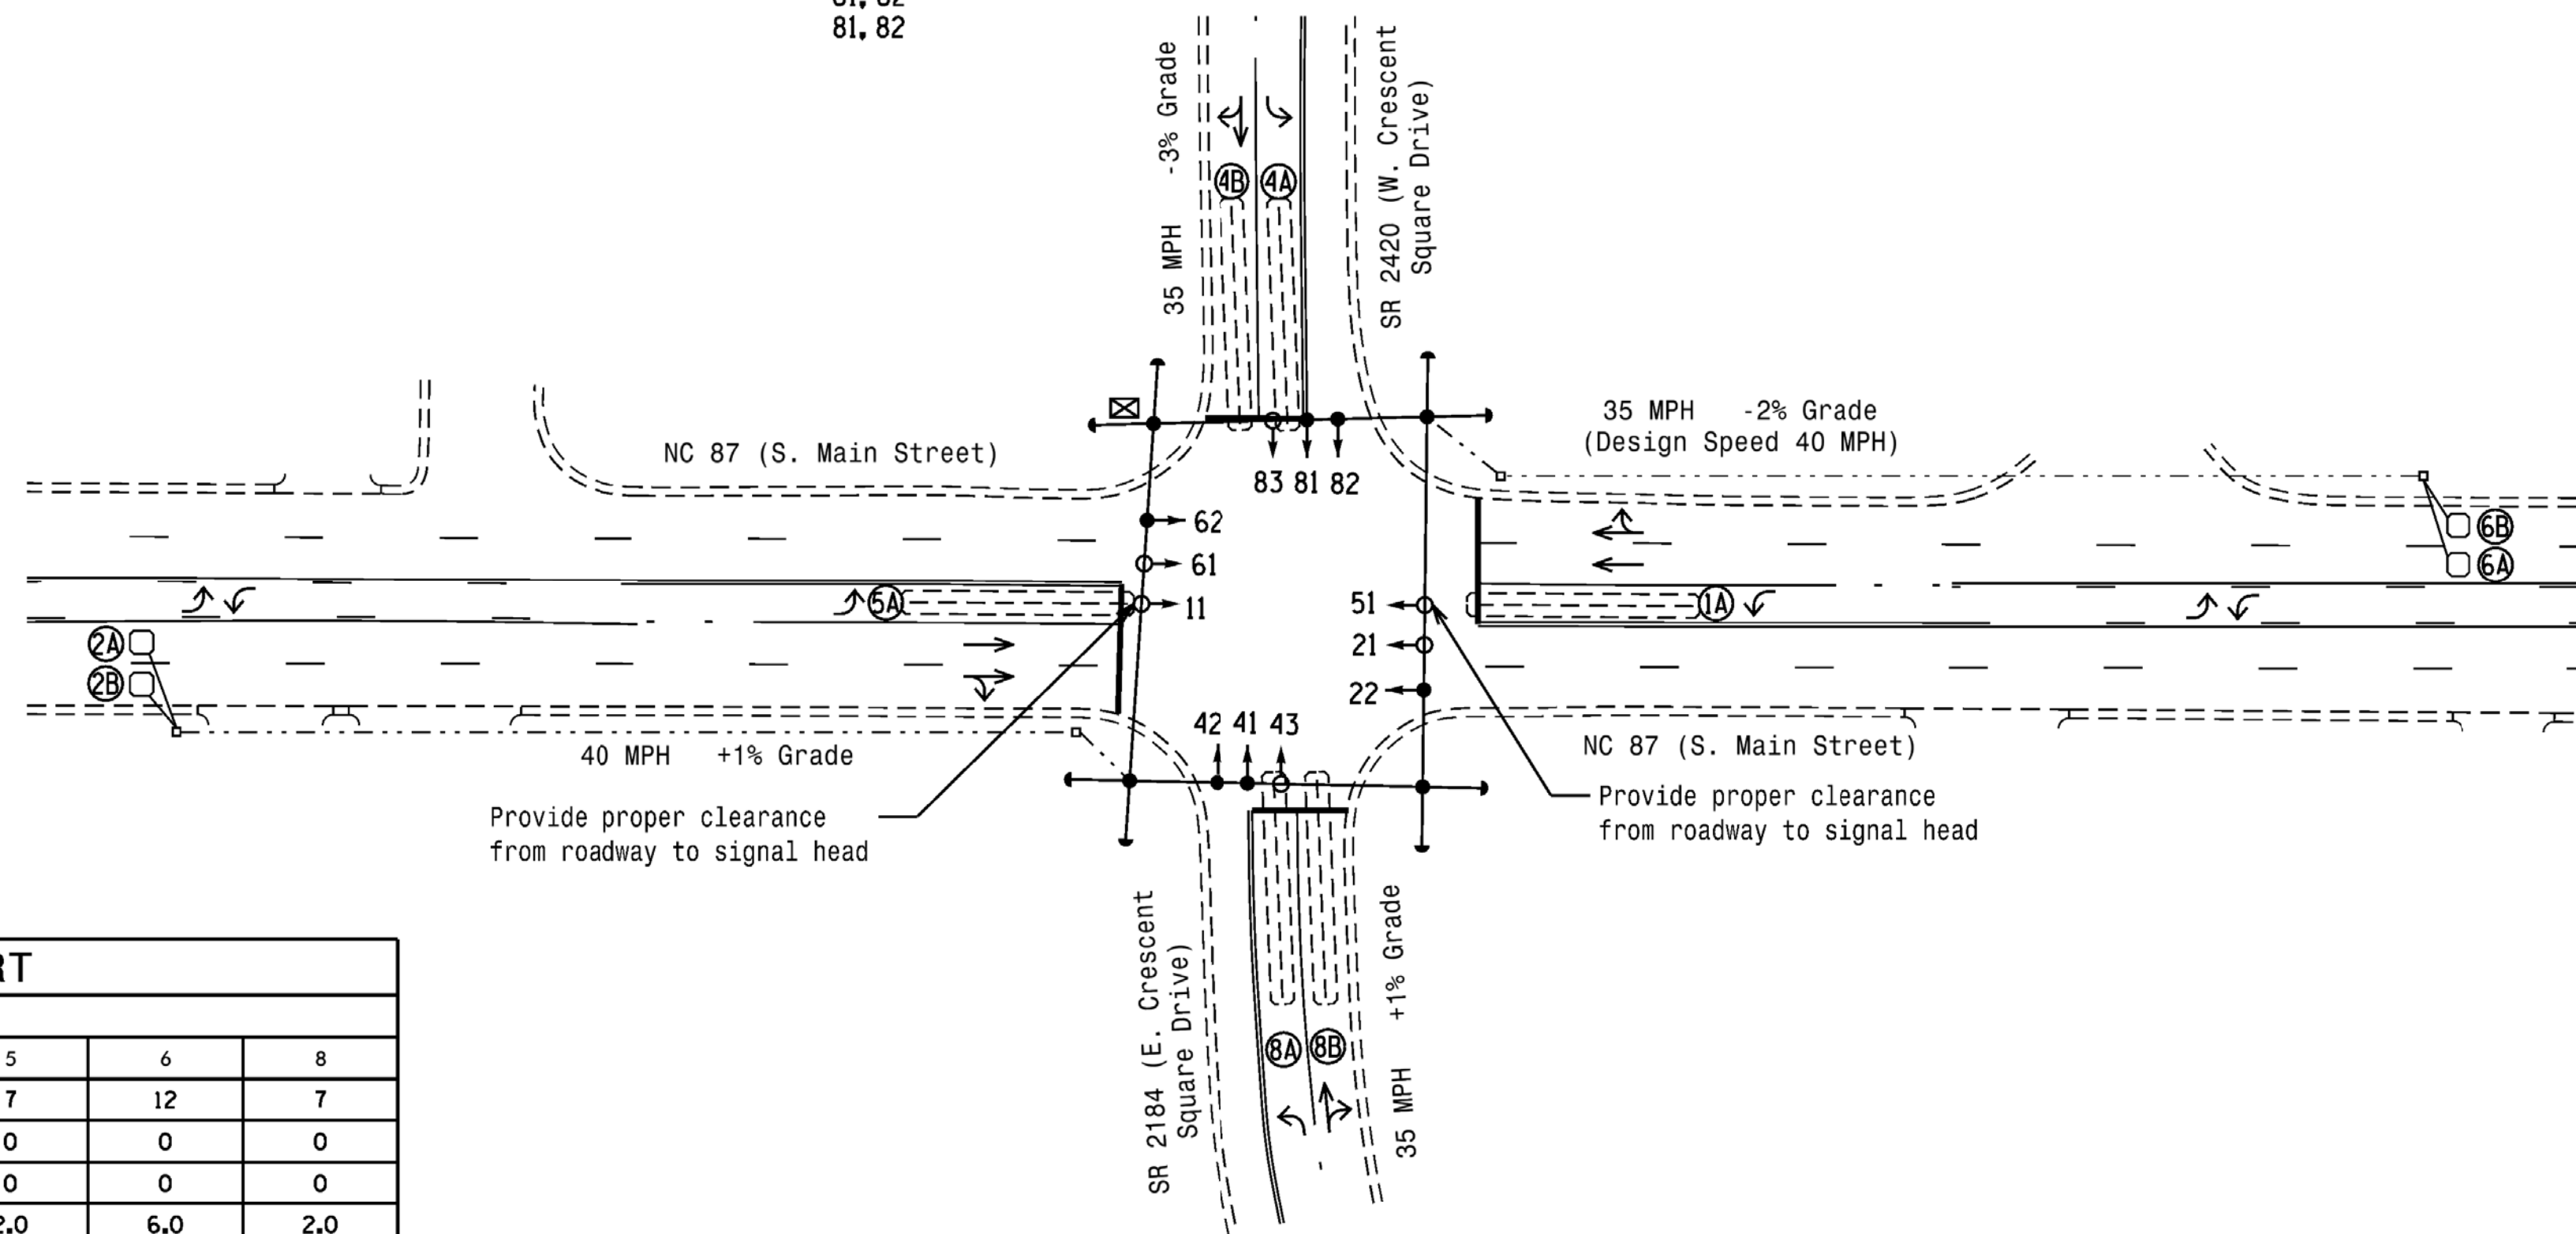

LEGEND

- | PROPOSED | | EXISTING |
|----------|--|----------|
| | Traffic Signal Head | N/A |
| | Modified Signal Head | N/A |
| | Pedestrian Signal Head With Push Button & Sign | N/A |
| | Signal Pole with Guy | N/A |
| | Signal Pole with Sidewalk Guy | N/A |
| | Inductive Loop Detector | N/A |
| | Controller & Cabinet | N/A |
| | Junction Box | N/A |
| | 2-in Underground Conduit | N/A |
| | Right of Way | N/A |
| | Directional Arrow | N/A |

FEATURE	ASC/3 TIMING CHART						
	1	2	4	5	6	8	
Min Green *	7	12	7	7	12	7	
Walk *	0	0	0	0	0	0	
Ped Clear	0	0	0	0	0	0	
Veh. Extension *	2.0	6.0	2.0	2.0	6.0	2.0	
Max 1 *	15	45	25	15	45	25	
Yellow	3.0	4.3	4.1	3.0	4.3	4.1	
Red Clear	2.4	1.2	1.7	2.1	1.2	1.7	
Actuations B4 Add *	-	0	-	-	0	-	
Seconds / Actuation *	-	1.5	-	-	1.5	-	
Max Initial *	-	29	-	-	29	-	
Time Before Reduction *	-	15	-	-	15	-	
Time To Reduce *	-	30	-	-	30	-	
Minimum Gap	-	3.0	-	-	3.0	-	
Locking Detector	-	X	-	-	X	-	
Recall Position	-	VEH. RECALL	-	-	VEH. RECALL	-	
Dual Entry	-	-	X	-	-	X	
Simultaneous Gap	X	X	X	X	X	X	

* These values may be field adjusted. Do not adjust Min Green and Extension times for phases 2 and 6 lower than what is shown. Min Green for all other phases should not be lower than 4 seconds.

Mattern & Craig
ENGINEERS • SURVEYORS

12 BROAD STREET
ASHEVILLE, NORTH CAROLINA 28801
(828) 254-2201
FAX (828) 254-4562
NC LIC. NO. C-1154

Signal Upgrade

	NC 87 (South Main Street) at SR 2184/SR 2420 (Crescent Square Drive)		
	Prepared for the Offices of: TRANSPORTATION MOBILITY AND SAFETY DIVISION NORTH CAROLINA DEPARTMENT OF TRANSPORTATION Signal Design Section 750 N. Greenfield Pkwy, Garner, NC 27529	Division 7 Alamance County Graham PLAN DATE: January 2018 REVIEWED BY: JB Voso PREPARED BY: SE Greene REVIEWED BY:	
DOCUMENT NOT CONSIDERED FINAL UNLESS ALL SIGNATURES COMPLETED		SEAL JAMES B. VOSO ENGINEER 6/13/2018	SEAL JAMES B. VOSO ENGINEER 022599 6/13/2018

*****SYSTEM *****
*****BUSINESS *****

ECONOLITE ASC/3-2070 OVERLAP PROGRAMMING DETAIL

(program controller as shown)

1. From Main Menu select 2. CONTROLLER
2. From CONTROLLER Submenu select 2. VEHICLE OVERLAPS

OVERLAP A

Select TMG VEH OVLP [A] and 'PPLT FYA'

TMG VEH OVLP...[A] TYPE:	PPLT FYA
PROTECTED LEFT TURN....	PHASE 1
OPPOSING THROUGH.....	PHASE 2
FLASHING ARROW OUTPUT.....CH9 ISOLATE	
DELAY START OF: FYA..0.0 CLEARANCE..0.0	
ACTION PLAN SF BIT DISABLE..... 0	

Toggle Once

OVERLAP B

Select TMG VEH OVLP [B] and 'OTHER/ECONOLITE'

TMG VEH OVLP...[B] TYPE:	OTHER/ECONOLITE
PHASES 1 2 3 4 5 6 7 8 9 0 1 2 3 4 5 6	
INCLUDED . . . X	
PROTECT	
PED PRTC	
NOT OVLP	
FLSH GRN . . . 1	
LAG X PH	
LAG 2 PH	
LAG GRN 0.0 YEL 0.0 RED 0.0 ADV GRN 0.0	

Toggle Once

OVERLAP C

Select TMG VEH OVLP [C] and 'PPLT FYA'

TMG VEH OVLP...[C] TYPE:	PPLT FYA
PROTECTED LEFT TURN....	PHASE 5
OPPOSING THROUGH.....	PHASE 6
FLASHING ARROW OUTPUT.....CH11 ISOLATE	
DELAY START OF: FYA..0.0 CLEARANCE..0.0	
ACTION PLAN SF BIT DISABLE..... 0	

Toggle Once

OVERLAP D

Select TMG VEH OVLP [D] and 'OTHER/ECONOLITE'

TMG VEH OVLP...[D] TYPE:	OTHER/ECONOLITE
PHASES 1 2 3 4 5 6 7 8 9 0 1 2 3 4 5 6	
INCLUDED X	
PROTECT	
PED PRTC	
NOT OVLP	
FLSH GRN 1	
LAG X PH	
LAG 2 PH	
LAG GRN 0.0 YEL 0.0 RED 0.0 ADV GRN 0.0	


END PROGRAMMING

FLASHER CIRCUIT MODIFICATION DETAIL

IN ORDER TO ENSURE THAT SIGNALS FLASH CONCURRENTLY ON THE SAME APPROACH, MAKE THE FOLLOWING FLASHER CIRCUIT CHANGES:

1. ON REAR OF PDA - REMOVE WIRE FROM TERM. T2-4 AND TERMINATE ON T2-2.
2. ON REAR OF PDA - REMOVE WIRE FROM TERM. T2-5 AND TERMINATE ON T2-3.
3. REMOVE FLASHER UNIT 2.



THE CHANGES LISTED ABOVE TIES ALL PHASES AND OVERLAPS TO FLASHER UNIT 1.



12 BROAD STREET
ASHEVILLE, NORTH CAROLINA 28801
(828) 254-2201
FAX (828) 254-4562
NC LIC. NO. C-1154


THIS ELECTRICAL DETAIL IS FOR
THE SIGNAL DESIGN: 07-1232
DESIGNED: January 2018
SEALED: 6/13/2018
REVISED: NA

Electrical Detail - Sheet 2 of 2

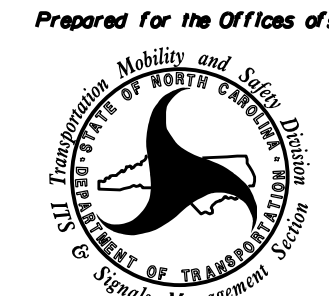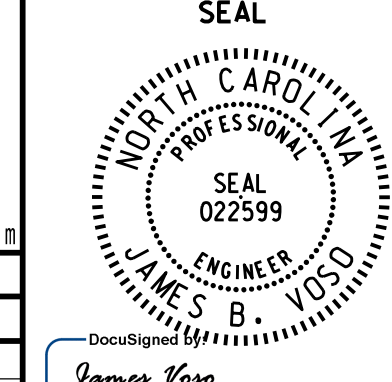
<p><small>ELECTRICAL AND PROGRAMMING DETAILS FOR:</small></p> <p style="font-size: small;">Prepared for the Offices of:</p>  <p style="font-size: x-small;">750 N. Greenfield Hwy, Correr, NC 27529</p>	<p>NC 87 (South Main Street) at SR 2184/SR 2420 (Crescent Square Drive)</p> <p style="font-size: x-small;">Division 7 Alamance County Graham</p> <p>PLAN DATE: January 2018 REVIEWED BY: JB Voso</p> <p>PREPARED BY: SE Greene REVIEWED BY:</p>	<p>DOCUMENT NOT CONSIDERED FINAL UNLESS ALL SIGNATURES COMPLETED</p> <p style="font-size: x-small;">SEAL</p>  <p style="font-size: x-small;">James Voso 6/13/2018 DATE</p> <p style="font-size: x-small;">SIG. INVENTORY NO. 07-1232</p>
--	--	--

\$\$\$\$\$SYTIME\$\$\$\$\$
\$\$\$\$\$SYTIME\$\$\$\$\$
\$\$\$\$\$SYTIME\$\$\$\$\$

DEFAULT PHASING DIAGRAM

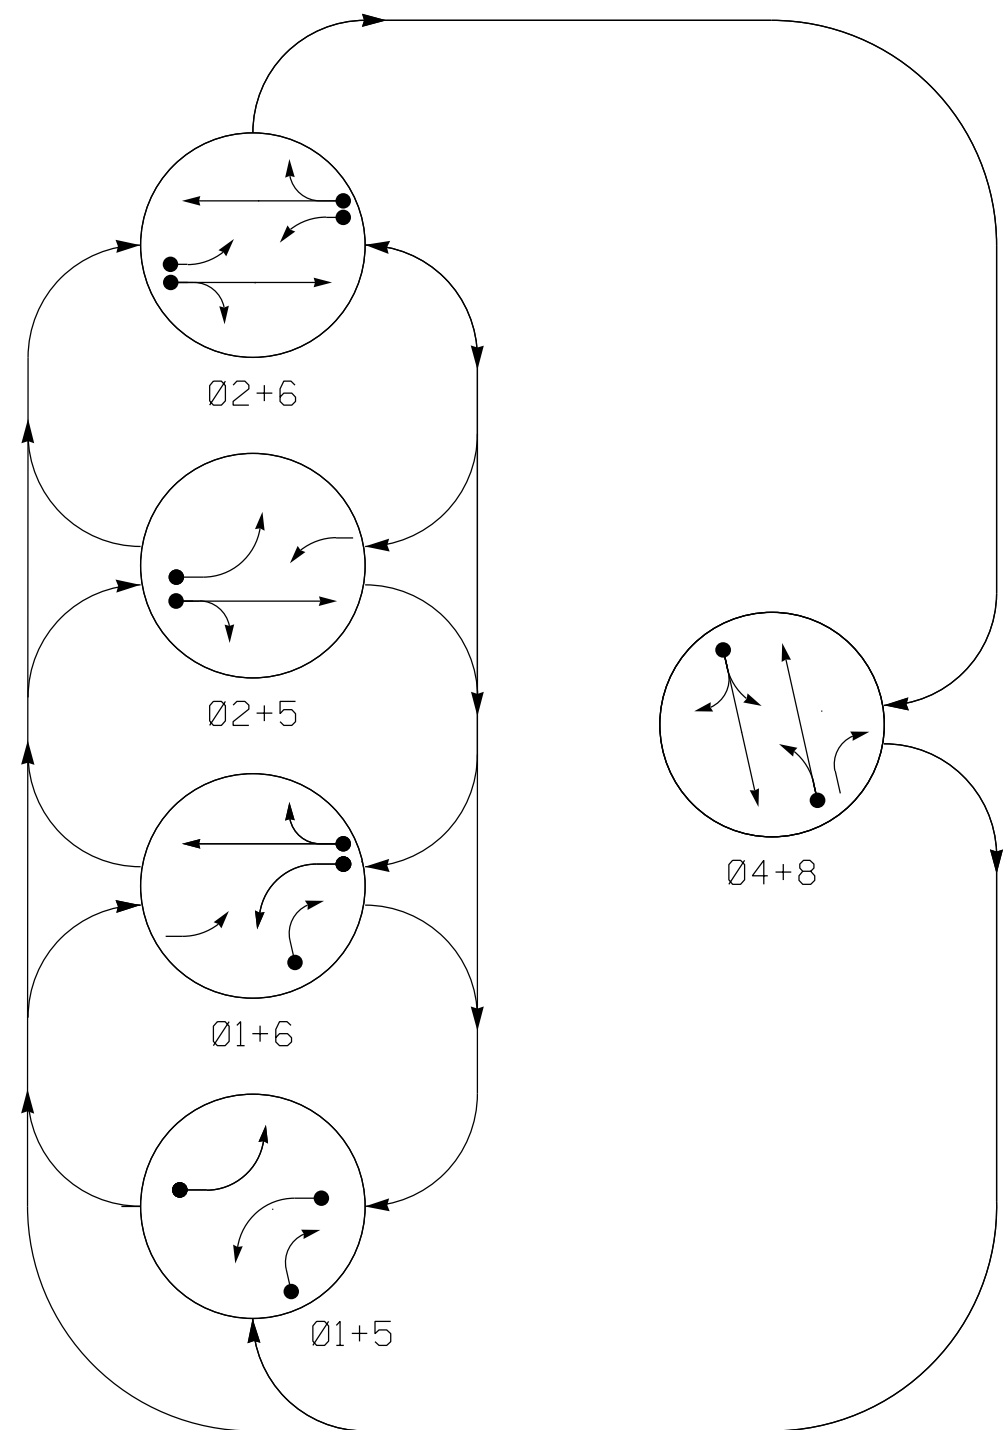

ALTERNATE PHASING DIAGRAM

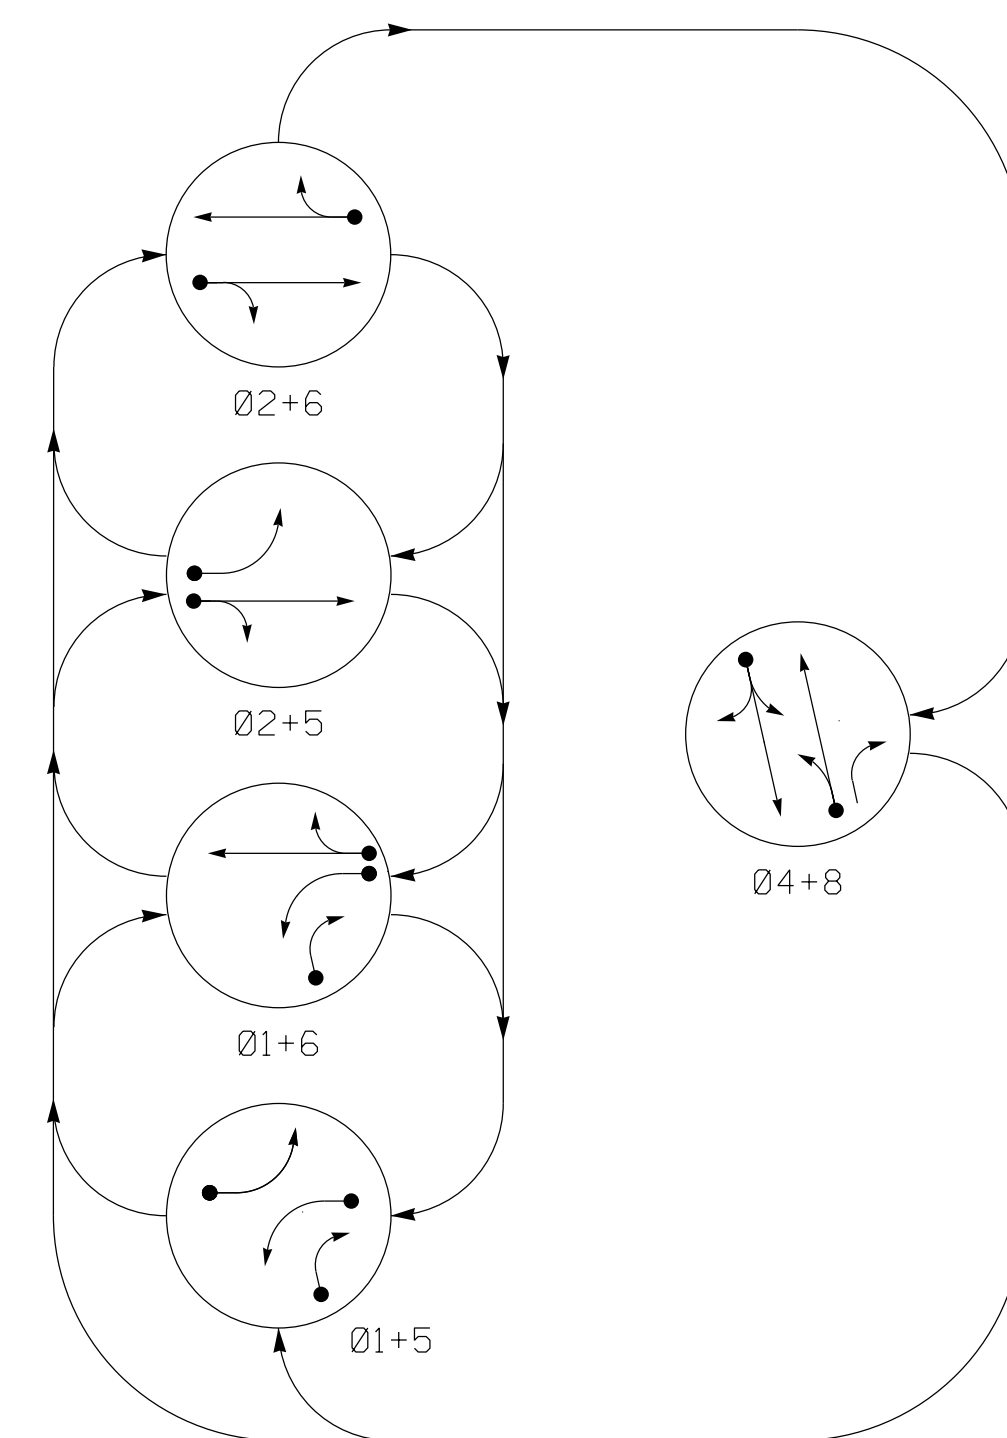

PHASING DIAGRAM DETECTION LEGEND

- DETECTED MOVEMENT
UNDETECTED MOVEMENT (OVERLAP)
UNSIGNALIZED MOVEMENT
PEDESTRIAN MOVEMENT


DEFAULT PHASING TABLE OF OPERATION

Table with columns: SIGNAL FACE, PHASE (0, 1, 2, 4, FLASH), and rows for signal faces 11, 21, 22, 41, 42, 51, 61, 62, 81, 82.

ALTERNATE PHASING TABLE OF OPERATION

Table with columns: SIGNAL FACE, PHASE (0, 1, 2, 4, FLASH), and rows for signal faces 11, 21, 22, 41, 42, 51, 61, 62, 81, 82.


SIGNAL FACE I.D.

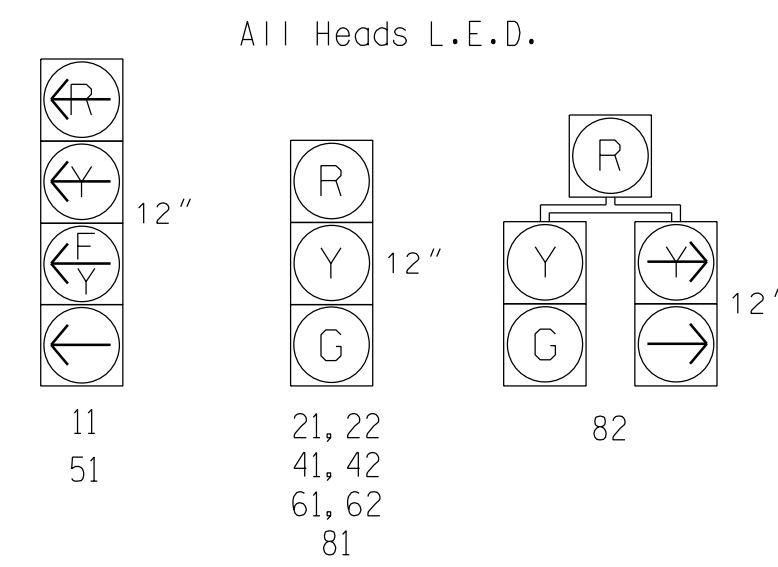

ASC/3 DETECTOR INSTALLATION CHART

Table with columns: LOOP, SIZE (FT), DISTANCE FROM STOPBAR (FT), TURNS, NEW LOOP, PHASE, CALLING, EXTEND TIME, DELAY TIME, USE ADDED INITIAL, TYPE, SYSTEM LOOP, NEW CARD.

- * Disable delay during alternate phasing operation.
** Disable phase 2 & 6 call during alternate phasing operation.

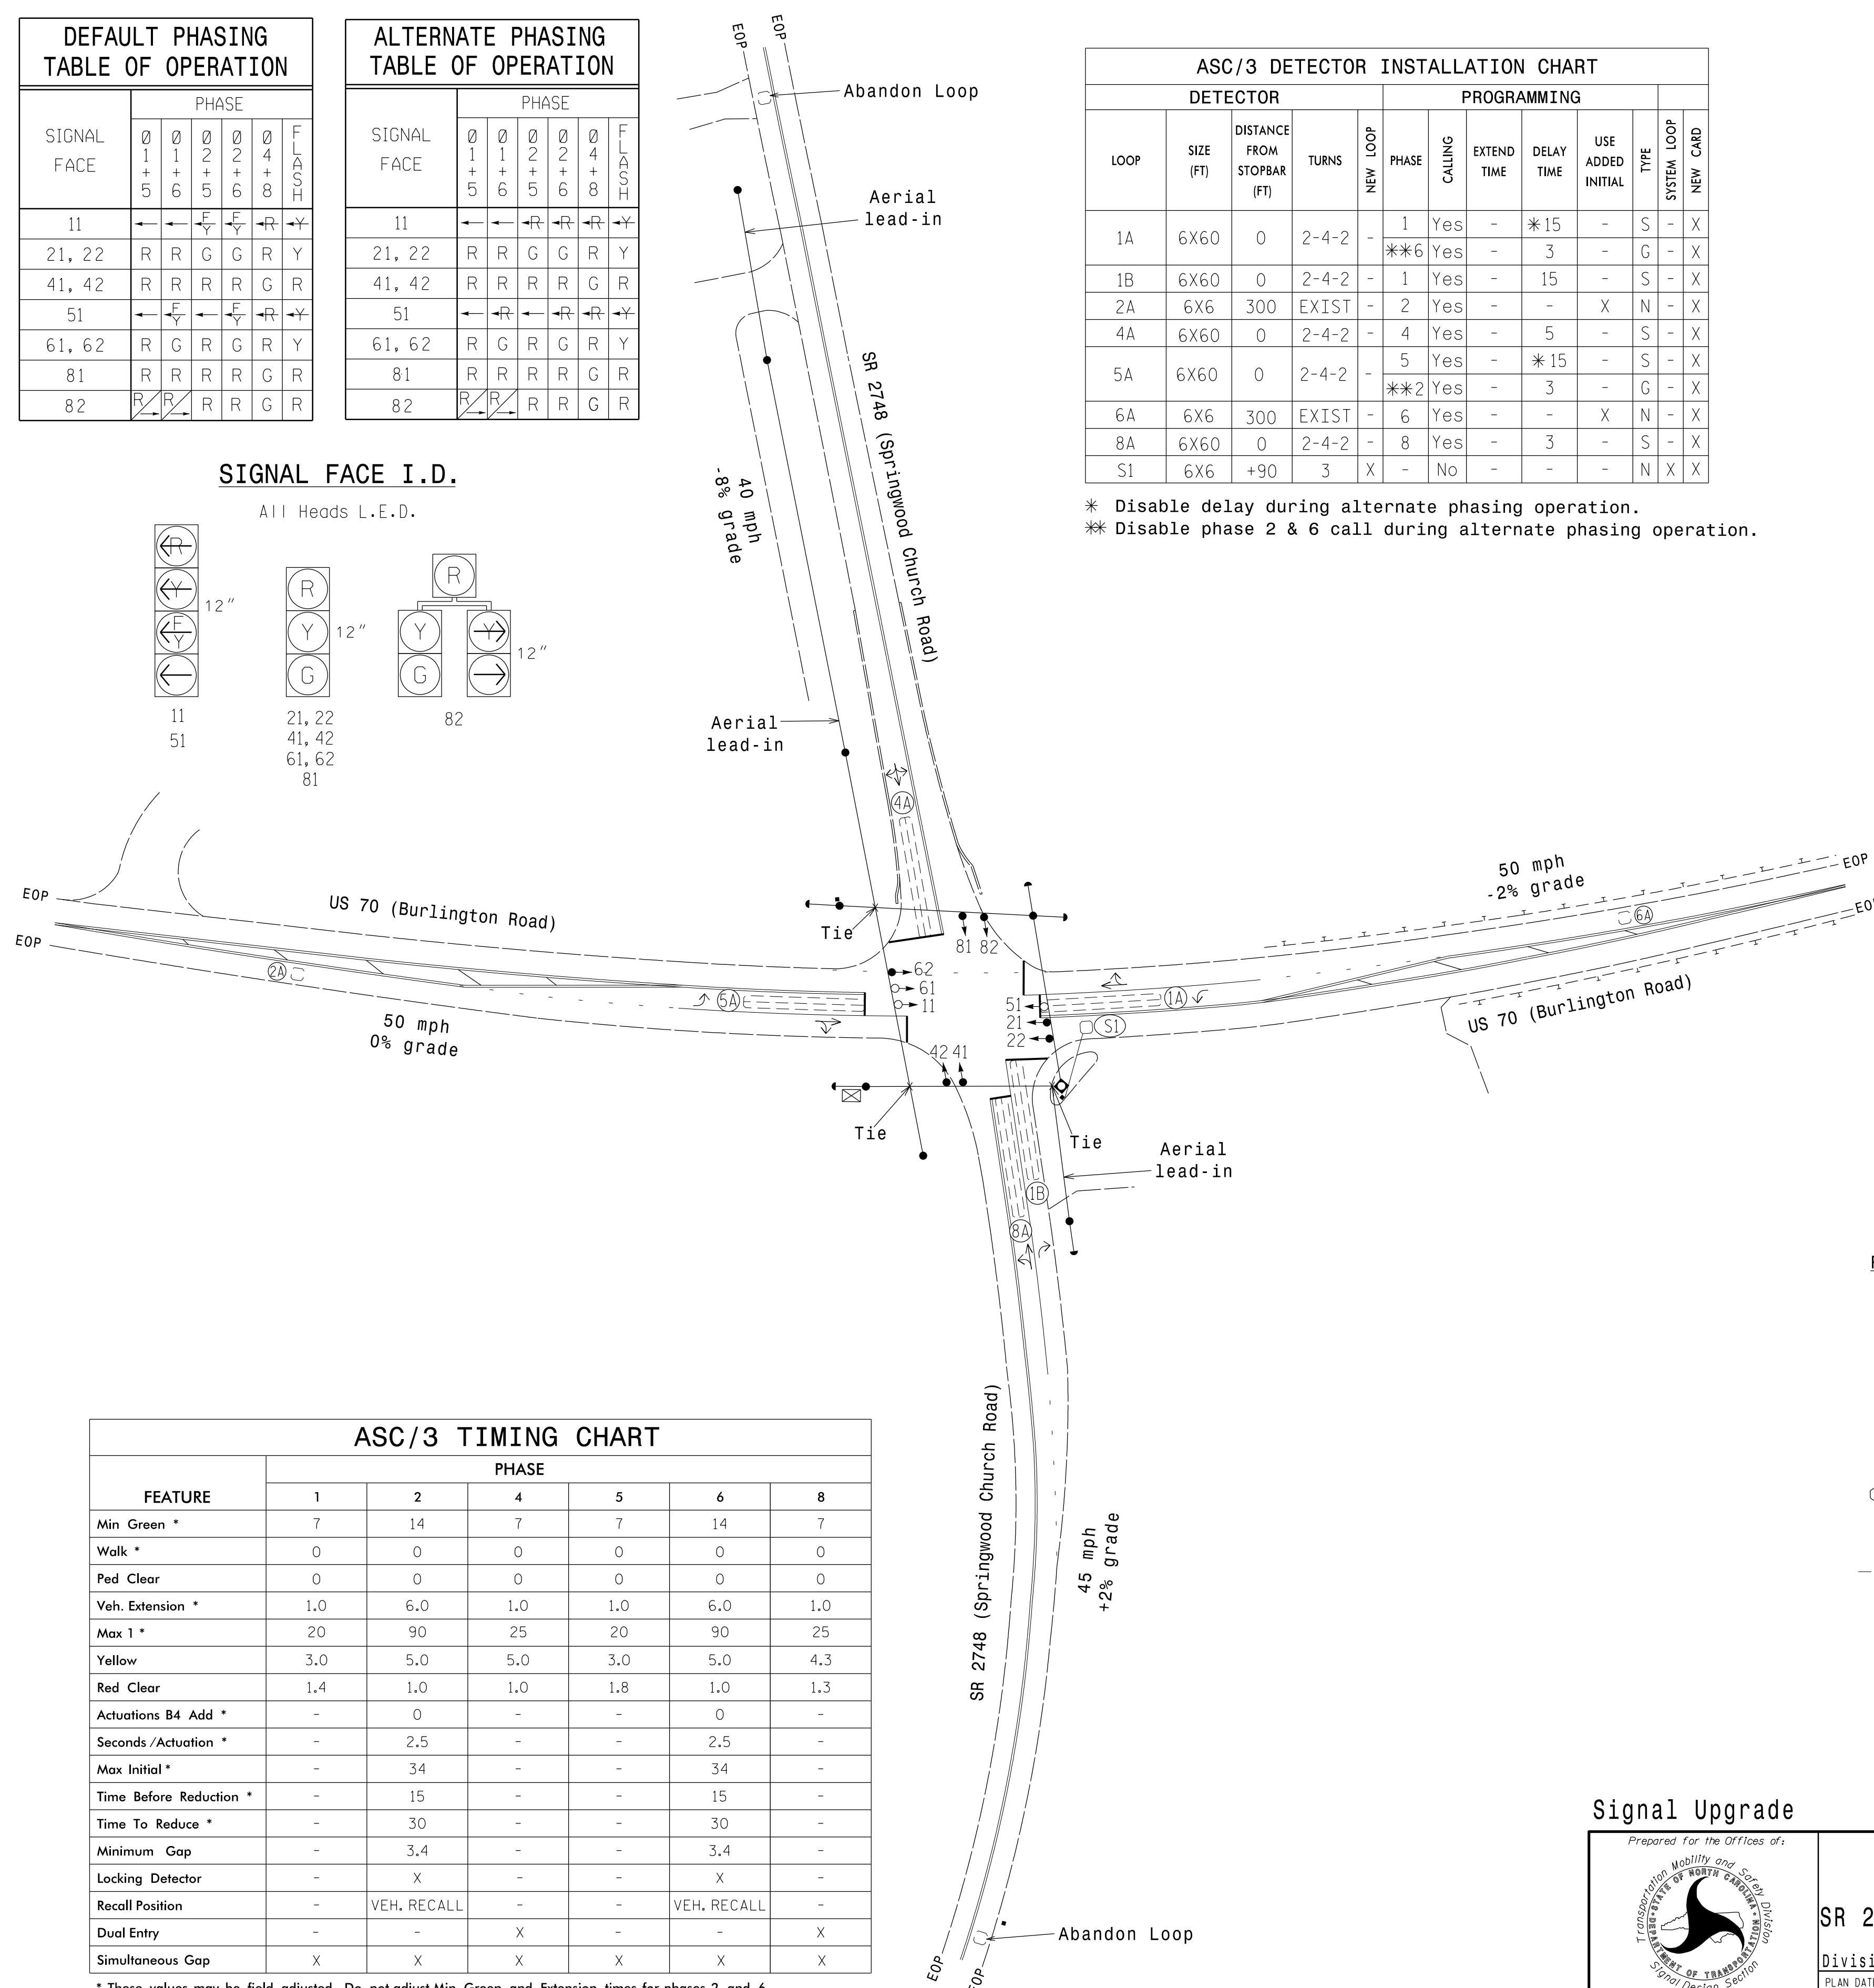

5 Phase Fully Actuated (Burlington-Graham Signal System)

NOTES

- 1. Refer to "Roadway Standard Drawings NCDOT" dated January 2018 and "Standard Specifications for Roads and Structures" dated January 2018.
2. Do not program signal for late night flashing operation unless otherwise directed by the Engineer.
3. Phase 1 and/or phase 5 may be lagged.
4. Reposition existing signal heads numbered 21, 22 and 62.
5. Install backplates for signal heads numbered 11, 51 and 61.
6. Set all detector units to presence mode.
7. In the event of loop replacement, refer to the current ITS and Signals Design Manual and submit a Plan of Record to the Signal Design Section.
8. Locate new cabinet so as not to obstruct sight distance of vehicles turning right on red.
9. Pavement markings are existing. The City Traffic Engineer will determine the hours of use for each phasing plan.
11. Maximum times shown in timing chart are for free-run operation only. Coordinated signal system timing values supersede these values.

LEGEND


- PROPOSED: Traffic Signal Head, Modified Signal Head, Sign, Pedestrian Signal Head With Push Button & Sign, Signal Pole with Guy, Signal Pole with Sidewalk Guy, Metal Strain Pole, Inductive Loop Detector, Controller & Cabinet, Junction Box, 2-in Underground Conduit, Right of Way, Directional Arrow.
EXISTING: N/A, Signal Pole with Guy, Metal Strain Pole, Junction Box, 2-in Underground Conduit, Right of Way, Directional Arrow.

ASC/3 TIMING CHART

Table with columns: FEATURE, PHASE (1, 2, 4, 5, 6, 8), and rows for various timing features like Min Green, Walk, Ped Clear, Veh. Extension, Max I, Yellow, Red Clear, etc.

* These values may be field adjusted. Do not adjust Min Green and Extension times for phases 2 and 6 lower than what is shown. Min Green for all other phases should not be lower than 4 seconds.

Signal Upgrade

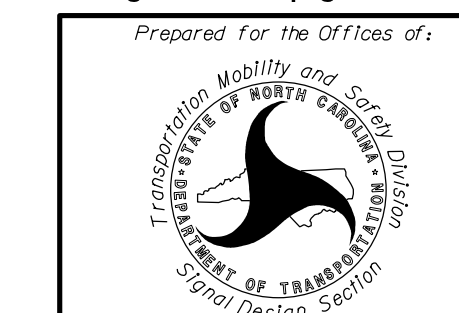

US 70 (Burlington Road) at SR 2748 (Springwood Church Road)
Division 7 Guilford County Burlington
Prepared by: JA Wiles, Reviewed by: PL Alexander

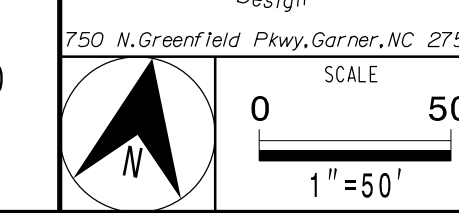



Table with columns: REVISIONS, INIT., DATE.

DATE: 6/7/2018
Signature: Pamela Alexander
SIC. INVENTORY NO. 07-1251

EDI MODEL 2018ECLIP-NC CONFLICT MONITOR PROGRAMMING DETAIL

(remove jumpers and set switches as shown)




REMOVE DIODE JUMPERS 1-5, 1-6, 1-9, 1-11, 2-5, 2-6, 2-9, 2-11, 4-8, 5-9, 5-11, 6-9, 6-11, and 9-11.

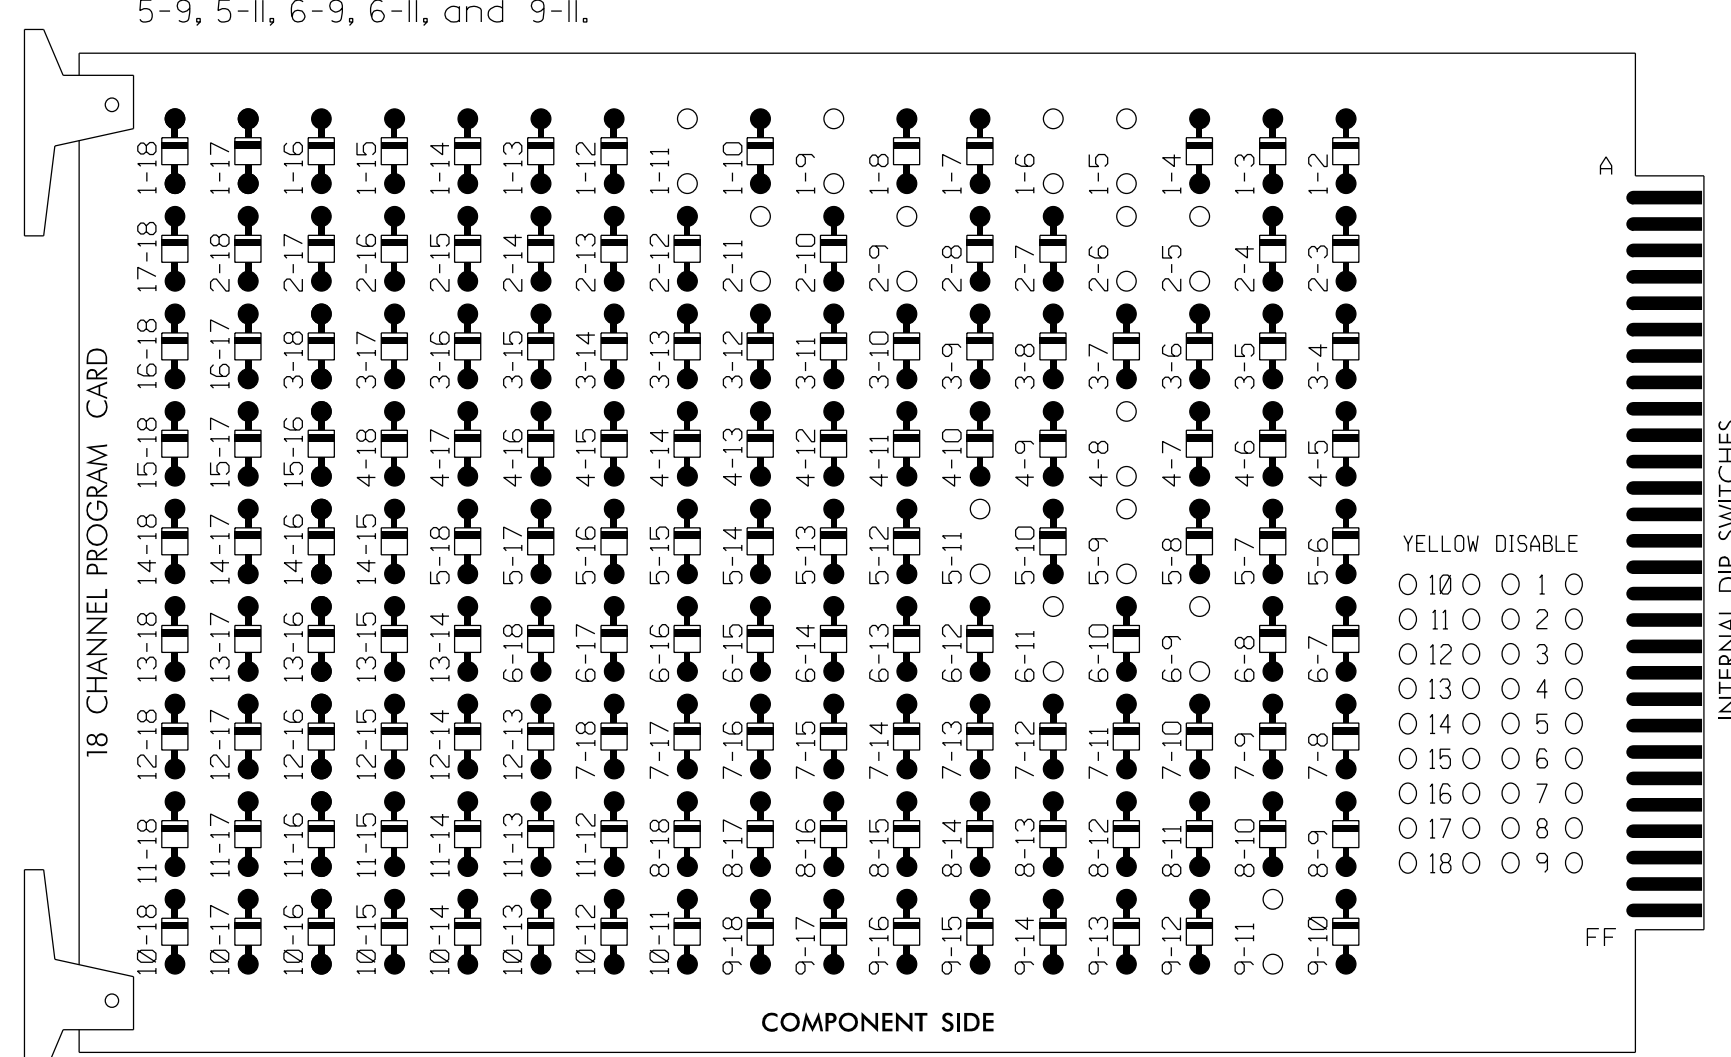

REMOVE JUMPERS AS SHOWN

NOTES:

- Card is provided with all diode jumpers in place. Removal of any jumper allows its channels to run concurrently.
- Ensure jumpers SEL2-SEL5 and SEL9 are present on the monitor board.
- Ensure that Red Enable is active at all times during normal operation.
- Integrate monitor with Ethernet network in cabinet.

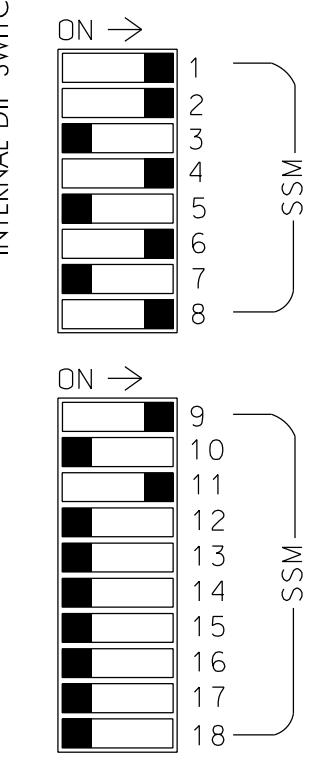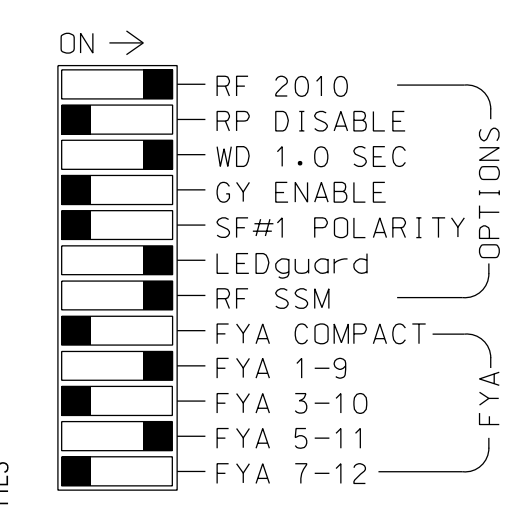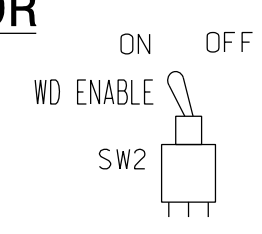

■ = DENOTES POSITION OF SWITCH

NOTES

- To prevent "flash-conflict" problems, insert red flash program blocks for all unused vehicle load switches in the output file. The installer shall verify that signal heads flash in accordance with the Signal Plans.
- Program phases 4 and 8 for Dual Entry.
- Program controller to start up in phase 2 Green and 6 Green.
- The cabinet and controller are part of the Burlington-Graham Signal System.

EQUIPMENT INFORMATION

CONTROLLER.....2070LX
 CABINET.....332 W/AUX
 SOFTWARE.....ECONOLITE ASC/3-2070
 CABINET MOUNT.....BASE
 OUTPUT FILE POSITIONS...18 WITH AUX. OUTPUT FILE
 LOAD SWITCHES USED.....S1,S2,S5,S7,S8,S11,AUX S1,AUX S4
 PHASES USED.....1,2,4,5,6,8
 OVERLAP "A".....*
 OVERLAP "B".....NOT USED
 OVERLAP "C".....*
 OVERLAP "D".....NOT USED

* See overlap programming detail on sheet 2

SIGNAL HEAD HOOK-UP CHART

LOAD SWITCH NO.	S1	S2	S3	S4	S5	S6	S7	S8	S9	S10	S11	S12	AUX S1	AUX S2	AUX S3	AUX S4	AUX S5	AUX S6
CMU CHANNEL NO.	1	2	13	3	4	14	5	6	15	7	8	16	9	10	17	11	12	18
PHASE	1	2	2 PED	3	4	4 PED	5	6	6 PED	7	8	8 PED	OLA	OLB	SPARE	OLC	OLD	SPARE
SIGNAL HEAD NO.	11★	82	21,22	NU	41,42	NU	51★	61,62	NU	81,82	NU	11★	NU	NU	51★	NU	NU	
RED	*	128			101			134		107								
YELLOW		129			102		*	135		108								
GREEN		130			103			136		109								
RED ARROW													A121				A114	
YELLOW ARROW	126												A122				A115	
FLASHING YELLOW ARROW													A123				A116	
GREEN ARROW	127	127						133										

NU = Not Used
 * Denotes install load resistor. See load resistor installation detail this sheet.
 ★ See pictorial of head wiring in detail this sheet.

INPUT FILE POSITION LAYOUT (front view)

FILE NO.	1	2	3	4	5	6	7	8	9	10	11	12	13	14
FILE 1	∅ 1 1A	∅ 1 1B	∅ 2 2A	∅ 4 4A	∅ 5 5A	∅ 6 6A	∅ 8 8A	SYS. DET. S1						FS DC ISOLATOR ST
FILE 2	NOT USED	NOT USED	NOT USED	NOT USED	NOT USED	NOT USED	NOT USED	NOT USED						DC ISOLATOR


EX.: 1A, 2A, ETC. = LOOP NO.'S
 FS = FLASH SENSE
 ST = STOP TIME

⊗ Wired Input - Do not populate slot with detector card

INPUT FILE CONNECTION & PROGRAMMING CHART


LOOP NO.	LOOP TERMINAL	INPUT FILE POS.	PIN NO.	DETECTOR NO.	NEMA PHASE	CALL	EXTEND TIME	DELAY TIME	ADDED INITIAL	DETECTOR TYPE
1A ¹	TB2-1,2	I1U	56	1★	1	YES		15		S
	-	J4U	48	26★	6	YES		3		G
1B	TB2-5,6	I2U	39	2	1	YES		15		S
2A	TB2-9,10	I3U	63	32	2	YES			X	N
4A	TB4-9,10	I6U	41	4	4	YES		5		S
* S1	TB6-9,10	I9U	60	11	SYS	NO				N
5A ²	TB3-1,2	J1U	55	5★	5	YES		15		S
	-	I4U	47	22★	2	YES		3		G
6A	TB3-5,6	J2U	40	6	6	YES			X	N
8A	TB5-9,10	J6U	42	8	8	YES		3		S

- Add jumper from I1-W to J4-W, on rear of input file.
 - Add jumper from J1-W to I4-W, on rear of input file.
- * System detector only. Remove any assigned vehicle phase.
- ★ See vehicle detector setup programming detail for alternate phasing on sheet 2.

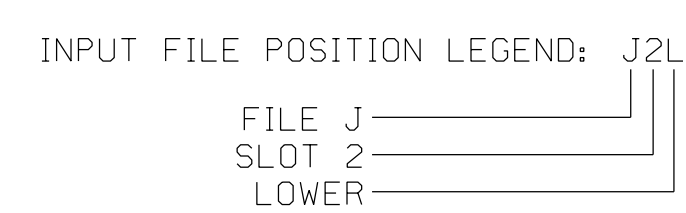


LOAD RESISTOR INSTALLATION DETAIL (install resistors as shown)

VALUE (ohms)	WATTAGE
1.5K - 1.9K	25W (min)
2.0K - 3.0K	10W (min)

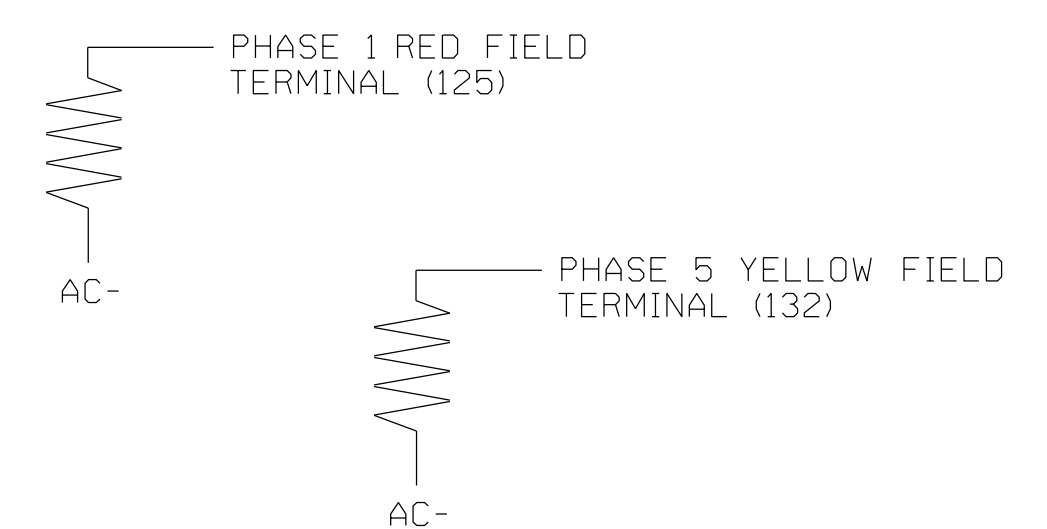

FYA SIGNAL WIRING DETAIL (wire signal heads as shown)

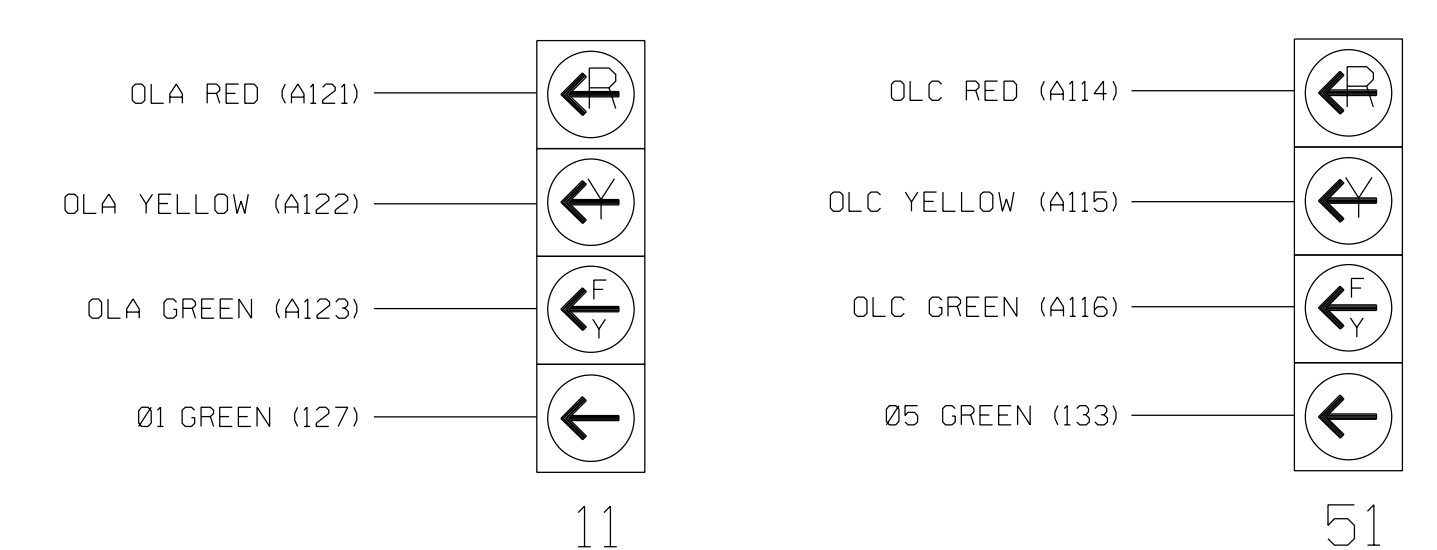

THIS ELECTRICAL DETAIL IS FOR THE SIGNAL DESIGN: 07-1251
 DESIGNED: December 2017
 SEALED: 6/7/2018
 REVISED: N/A

Electrical Detail - Sheet 1 of 3

DOCUMENT NOT CONSIDERED FINAL UNLESS ALL SIGNATURES COMPLETED

Electrical and Programming Details For: US 70 (Burlington Road) at SR 2748 (Springwood Church Road)

Division 7 Guilford County Burlington

Prepared for the Offices of:

PLAN DATE: December 2017 REVIEWED BY: AM Encarnacion

PREPARED BY: JA Wiles REVIEWED BY: PL Alexander

REVISIONS: INIT. DATE

SEAL: NORTH CAROLINA PROFESSIONAL ENGINEER PAMELA L. ALEXANDER SEAL 023489

6/9/2018

SIG. INVENTORY NO. 07-1251

09-JUN-2018 14:14
 D:\Transportation\tr-office\curr\100056469 U-6015 B-6 Sig Sys\Task 05-11-Signal\sig04as\gnw\F:Rng07-1251E.dgn
 ALEX3361 AT LUS340619

ECONOLITE ASC/3-2070 VEHICLE DETECTOR SETUP PROGRAMMING DETAIL FOR ALTERNATE PHASING LOOPS 1A, 5A

(program controller as shown)

IMPORTANT!

Program detectors per the input file connection and programming chart shown on sheet 1 before proceeding.

- From Main Menu select **8. UTILITIES**
- From UTILITIES Submenu select **1. COPY/CLEAR**
- Copy from DETECTOR PLAN "1" to DETECTOR PLAN "2".

```

COPY / CLEAR UTILITY
FROM          TO
PHASE TIMING... > PHASE TIMING...
TIMING PLAN... > TIMING PLAN...
PH DET OPT PLAN... > PH DET OPT PLAN...
DETECTOR PLAN... 1 > DETECTOR PLAN... 2
TOGGLE TO SELECT A "FROM" AND A "TO"
THEN PRESS ENTER
  
```

- From Main Menu select **6. DETECTORS**
- From DETECTOR Submenu select **2. VEHICLE DETECTOR SETUP**
- Place cursor in VEH DET PLAN [] position and enter "2".

- Place cursor in VEH DETECTOR [] position and enter "1".
- Set delay time to "0".

```

VEH DETECTOR [ 1]  VEH DET PLAN [ 2]
TYPE: S-STANDARD
TS2 DETECTOR..... ECPI LOG..... NO
DET PH - 1 2 3 4 5 6 7 8 9 0 1 2 3 4 5 6
1 1
EXTEND TIME... 0.0 DELAY TIME... 0.0
USE ADDED INITIAL . CROSS SWITCH PH.. 0
LOCK IN..... NONE NTCIP VOL . OR OCC .
PMT QUEUE DELAY. NO
  
```

- Place cursor in VEH DETECTOR [] position and enter "26".
- Set assigned phase to "0".

```

VEH DETECTOR [26]  VEH DET PLAN [ 2]
TYPE: G-GREEN EXTENSION/DELAY
TS2 DETECTOR..... ECPI LOG..... NO
DET PH - 1 2 3 4 5 6 7 8 9 0 1 2 3 4 5 6
26 0
EXTEND TIME... 0.0 DELAY TIME... 3.0
USE ADDED INITIAL . CROSS SWITCH PH.. 0
LOCK IN..... NONE NTCIP VOL . OR OCC .
PMT QUEUE DELAY. NO
  
```

- Place cursor in VEH DETECTOR [] position and enter "5".
- Set delay time to "0".

```

VEH DETECTOR [ 5]  VEH DET PLAN [ 2]
TYPE: S-STANDARD
TS2 DETECTOR..... ECPI LOG..... NO
DET PH - 1 2 3 4 5 6 7 8 9 0 1 2 3 4 5 6
5 5
EXTEND TIME... 0.0 DELAY TIME... 0.0
USE ADDED INITIAL . CROSS SWITCH PH.. 0
LOCK IN..... NONE NTCIP VOL . OR OCC .
PMT QUEUE DELAY. NO
  
```

- Place cursor in VEH DETECTOR [] position and enter "22".
- Set assigned phase to "0".

```

VEH DETECTOR [22]  VEH DET PLAN [ 2]
TYPE: G-GREEN EXTENSION/DELAY
TS2 DETECTOR..... ECPI LOG..... NO
DET PH - 1 2 3 4 5 6 7 8 9 0 1 2 3 4 5 6
22 0
EXTEND TIME... 0.0 DELAY TIME... 3.0
USE ADDED INITIAL . CROSS SWITCH PH.. 0
LOCK IN..... NONE NTCIP VOL . OR OCC .
PMT QUEUE DELAY. NO
  
```

END PROGRAMMING

ECONOLITE ASC/3-2070 OVERLAP PROGRAMMING DETAIL (program controller as shown)

- From Main Menu select **2. CONTROLLER**
- From CONTROLLER Submenu select **2. VEHICLE OVERLAPS**

OVERLAP A

Select TMG VEH OVLP [A] and 'PPLT FYA'

```

TMG VEH OVLP...[A] TYPE: ....PPLT FYA
PROTECTED LEFT TURN... PHASE 1
OPPOSING THROUGH..... PHASE 2

FLASHING ARROW OUTPUT.....CH9 ISOLATE
DELAY START OF: FYA..0.0 CLEARANCE..0.0
ACTION PLAN SF BIT DISABLE..... 1
  
```

NOTICE ACTION PLAN SF BIT "1"

Toggle Twice

OVERLAP C

Select TMG VEH OVLP [C] and 'PPLT FYA'

```

TMG VEH OVLP...[C] TYPE: ....PPLT FYA
PROTECTED LEFT TURN... PHASE 5
OPPOSING THROUGH..... PHASE 6



FLASHING ARROW OUTPUT.....CH11 ISOLATE
DELAY START OF: FYA..0.0 CLEARANCE..0.0
ACTION PLAN SF BIT DISABLE..... 5
  
```

NOTICE ACTION PLAN SF BIT "5"

END PROGRAMMING

THIS ELECTRICAL DETAIL IS FOR
THE SIGNAL DESIGN: 07-1251
DESIGNED: December 2017
SEALED: 6/7/2018
REVISED: N/A

09-JUN-2018 14:14 D:\Transportation\Triffle\Curran\00056469 U-6015 B-6 Sig Sys\Task 05-11-Signal\040as\gn\WIF:Prog07-1251E.dgn ALEX3361 AT LUS340619

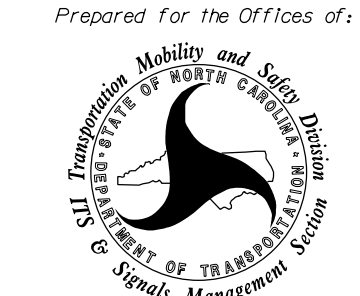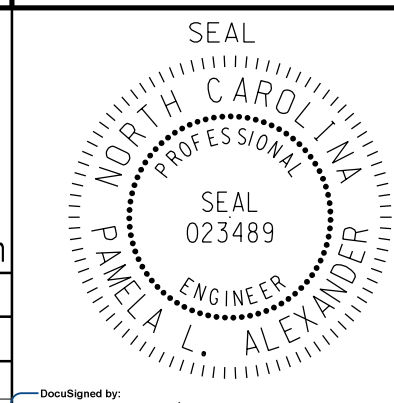Electrical Detail - Sheet 2 of 3		DOCUMENT NOT CONSIDERED FINAL UNLESS ALL SIGNATURES COMPLETED
ELECTRICAL AND PROGRAMMING DETAILS FOR: Prepared for the Offices of: 	US 70 (Burlington Road) at SR 2748 (Springwood Church Road) Division 7 Guilford County Burlington PLAN DATE: December 2017 REVIEWED BY: AM Encarnacion PREPARED BY: JA Wiles REVIEWED BY: PL Alexander	SEAL  SEAL 023489 ENGINEER PAMELA L. ALEXANDER 6/9/2018 DATE 07-1251 SIG. INVENTORY NO.

ECONOLITE ASC/3-2070 ACTION PLAN PROGRAMMING DETAIL

ALTERNATE PHASING ACTIVATION DETAIL

TO RUN ALT. PHASING DURING FREE RUN - PROGRAM CHANGES (SHOWN BELOW) IN A TIME BASED ACTION PLAN. SCHEDULE A DAY PLAN THAT INCLUDES THE ACTION PLAN PROGRAMMED TO SELECT VEH DET PLAN 2 AND ENABLE SF BITS 1 and 5.

TO RUN ALT. PHASING DURING COORDINATION - SELECT THE TIME BASED ACTION PLAN THAT IS PROGRAMMED TO SELECT VEH DET PLAN 2 AND ENABLE SF BITS 1 and 5.

PHASING	VEH DET PLAN	SF BITS ENABLED
ACTIONS REQUIRED TO RUN <u>DEFAULT PHASING</u>	1	NONE
ACTIONS REQUIRED TO RUN <u>ALTERNATE PHASING</u>	2	1, 5

IMPORTANT: IF ALT. PHASING IS USED DURING FREE RUN AND COORDINATION, DO NOT OPERATE TIME OF DAY EVENTS CONCURRENTLY WITH COORDINATION PLAN EVENTS IN THE EVENT SCHEDULER. (EX. FREE RUN EVENT SHOULD END BEFORE COORDINATION PLAN EVENT STARTS AND VICE-VERSA).

ALTERNATE PHASING CHANGE SUMMARY

THE FOLLOWING IS A SUMMARY OF WHAT TAKES PLACE WHEN SF BITS 1 AND 5 AND VEH DET PLAN 2 ACTIVATE TO CALL THE "ALTERNATE PHASING":

- SF BITS 1,5:** Modifies overlap parent phases for heads 11 and 51 to run protected turns only.
- VEH DET PLAN 2:** Disables phase 6 call on loop 1A and reduces delay time for phase 1 call on loop 1A to 0 seconds.
- Disables phase 2 call on loop 5A and reduces delay time for phase 5 call on loop 5A to 0 seconds.

1. From Main Menu select 5. TIME BASE
2. From TIME BASE Submenu select 2. ACTION PLAN

```

ACTION PLAN... [ 1 ]
PATTERN.....AUTO   SYS OVERRIDE.... NO
TIMING PLAN..... 0   SEQUENCE..... 0
VEH DETECTOR PLAN.. 2   DET LOG.....NONE
FLASH..... --   RED REST..... NO
VEH DET DIAG PLN... 0   PED DET DIAG PLN..0
DIMMING ENABLE.. NO   PRIORITY RETURN. NO
PED PR RETURN.. NO   QUEUE DELAY..... NO
PMT COND DELAY   NO

  PHASE  1  2  3  4  5  6  7  8  9  0  1  2  3  4  5  6
PED RCL  .  .  .  .  .  .  .  .  .  .  .  .  .  .  .  .
WALK 2   .  .  .  .  .  .  .  .  .  .  .  .  .  .  .  .
VEX 2    .  .  .  .  .  .  .  .  .  .  .  .  .  .  .  .
VEH RCL  .  .  .  .  .  .  .  .  .  .  .  .  .  .  .  .
MAX RCL  .  .  .  .  .  .  .  .  .  .  .  .  .  .  .  .
MAX 2    .  .  .  .  .  .  .  .  .  .  .  .  .  .  .  .
  PHASE  1  2  3  4  5  6  7  8  9  0  1  2  3  4  5  6
MAX 3    .  .  .  .  .  .  .  .  .  .  .  .  .  .  .  .
CS INH   .  .  .  .  .  .  .  .  .  .  .  .  .  .  .  .
OMIT     .  .  .  .  .  .  .  .  .  .  .  .  .  .  .  .
SPC FCT  X  .  .  .  X  .  .  .  (1-8)
AUX FCT  .  .  .  (1-3)
          1  2  3  4  5  6  7  8  9  0  1  2  3  4  5
LP 1-15  .  .  .  .  .  .  .  .  .  .  .  .  .  .  .  .
LP 16-30 .  .  .  .  .  .  .  .  .  .  .  .  .  .  .  .
LP 31-45 .  .  .  .  .  .  .  .  .  .  .  .  .  .  .  .
LP 46-60 .  .  .  .  .  .  .  .  .  .  .  .  .  .  .  .
LP 61-75 .  .  .  .  .  .  .  .  .  .  .  .  .  .  .  .
LP 76-90 .  .  .  .  .  .  .  .  .  .  .  .  .  .  .  .
LP 91-100 .  .  .  .  .  .  .  .  .  .  .  .  .  .  .  .
    
```


THIS ELECTRICAL DETAIL IS FOR
THE SIGNAL DESIGN: 07-1251
DESIGNED: December 2017
SEALED: 6/7/2018
REVISED: N/A

Electrical Detail - Sheet 3 of 3

DOCUMENT NOT CONSIDERED
FINAL UNLESS ALL
SIGNATURES COMPLETED

ELECTRICAL AND PROGRAMMING
DETAILS FOR:

Prepared for the Offices of:

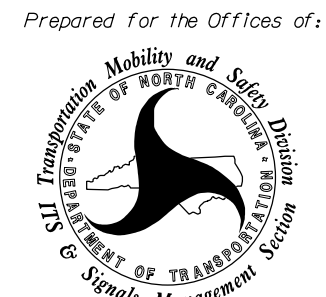

750 N. Greenfield Pkwy, Garner, NC 27529


**US 70 (Burlington Road)
at
SR 2748 (Springwood Church Road)**

Division 7 Guilford County Burlington

PLAN DATE: December 2017	REVIEWED BY: AM Encarnacion
PREPARED BY: JA Wiles	REVIEWED BY: PL Alexander

REVISIONS	INIT.	DATE

SEAL

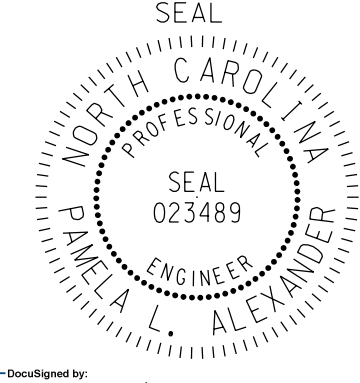

Seal of Pamela L. Alexander, Professional Engineer, License No. 023489, State of North Carolina.

6/9/2018
DATE

SIG. INVENTORY NO. 07-1251

ATKINS 1616 EAST MILLBROOK ROAD, SUITE 160
RALEIGH, NORTH CAROLINA 27609
(919) 876-6888 NCBES #F-0326

PHASING DIAGRAM

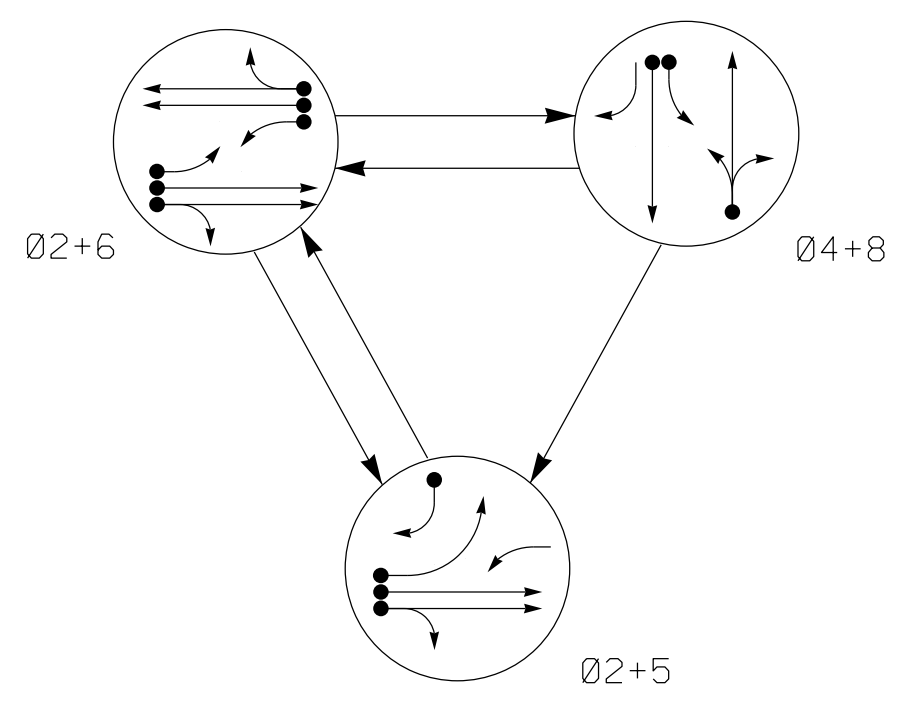


TABLE OF OPERATION

Table with columns: SIGNAL FACE, PHASE (0 2 + 5, 0 2 + 6, 0 4 + 8, F, H, O, L, L, F), and rows of signal face numbers and phase assignments.

ASC/3 DETECTOR INSTALLATION CHART


Table with columns: LOOP, SIZE (FT), DISTANCE FROM STOPBAR (FT), TURNS, NEW LOOP, PHASE, CALLING, EXTEND TIME, DELAY TIME, USE ADDED INITIAL, TYPE, SYSTEM LOOP, NEW CARD.

3 Phase Fully Actuated (Burlington-Graham Signal System)

NOTES



- 1. Refer to "Roadway Standard Drawings NCDOT" dated January 2018 and "Standard Specifications for Roads and Structures" dated January 2018.
2. Do not program signal for late night flashing operation unless otherwise directed by the Engineer.
3. Phase 5 may be lagged.
4. Reposition existing signal heads numbered 22, 62, and 63.
5. Set all detector units to presence mode.
6. In the event of loop replacement, refer to the current ITS and Signals Design Manual and submit a Plan of Record to the Signal Design Section.
7. Locate new cabinet so as not to obstruct sight distance of vehicles turning right on red.
8. Remove existing Left Arrow "ONLY" (R3-5L) signs.
9. Pavement markings are existing.
10. Maximum times shown in timing chart are for free-run operation only. Coordinated signal system timing values supersede these values.

PHASING DIAGRAM DETECTION LEGEND

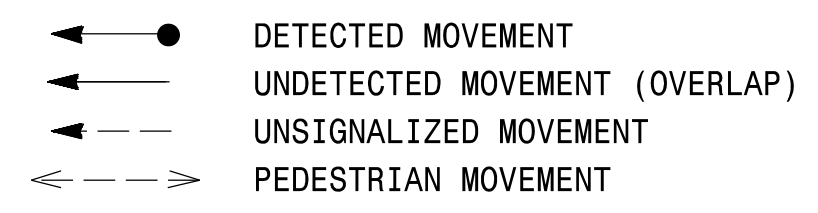

SIGNAL FACE I.D.

All Heads L.E.D.

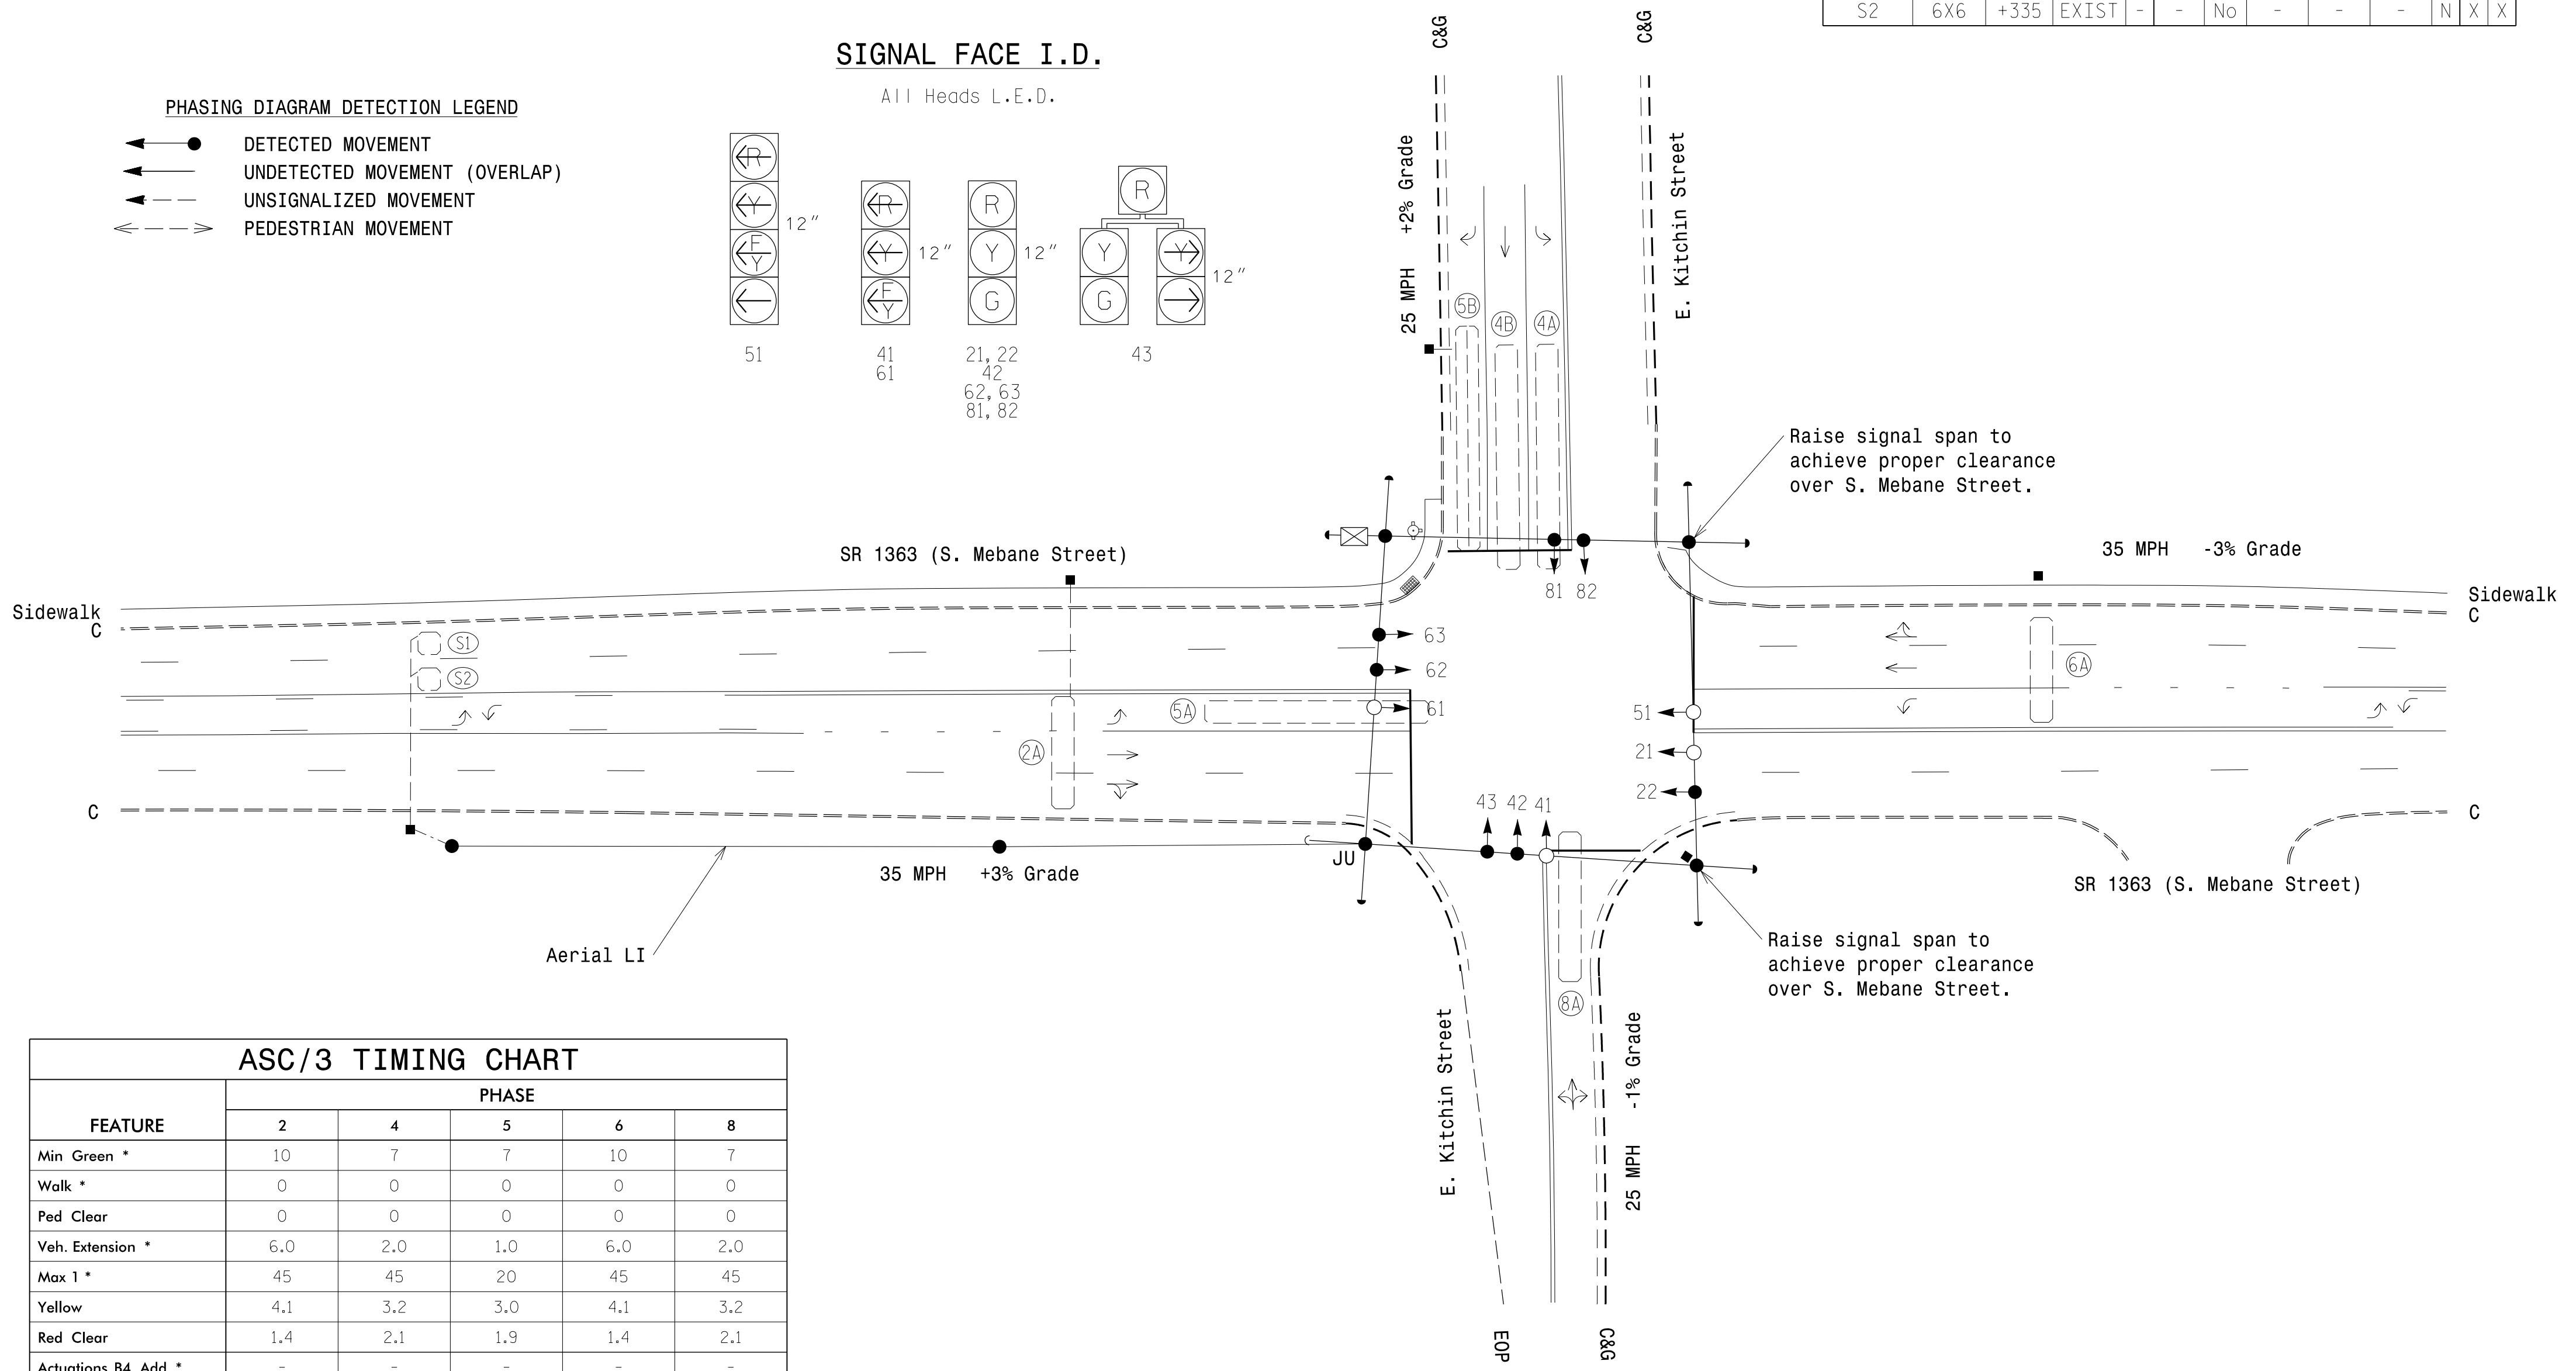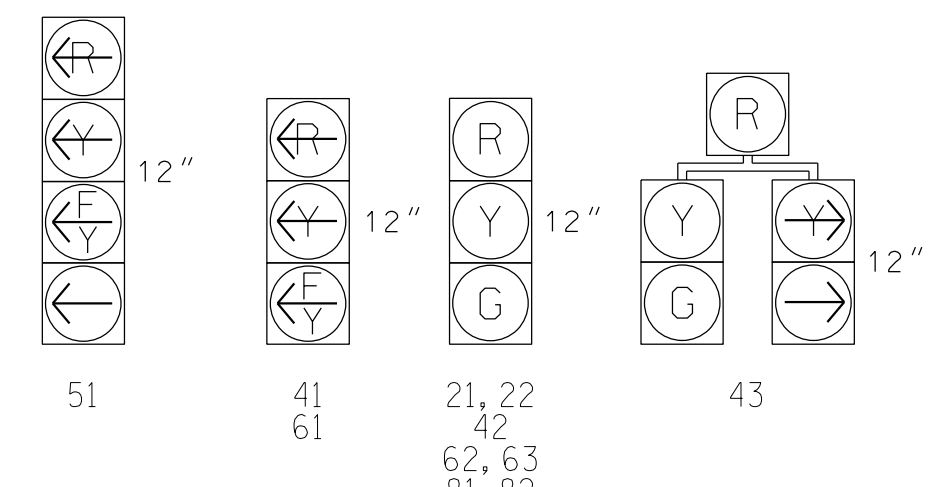

ASC/3 TIMING CHART table with columns: FEATURE, PHASE (2, 4, 5, 6, 8) and rows of timing values for various features like Min Green, Walk, Ped Clear, etc.

LEGEND table with columns: PROPOSED, EXISTING and rows of symbols for traffic signal heads, pedestrian heads, poles, detectors, junction boxes, conduits, arrows, domes, and fire hydrants.

Signal Upgrade

DOCUMENT NOT CONSIDERED FINAL UNLESS ALL SIGNATURES COMPLETED

DRMP logo and contact information: 750 N. Greenfield Pkwy, Garner, NC 27529, DRMP, Inc., 8000 Regency Parkway, Suite 175, Cary, NC 27518, NC License No. C-2213 (919) 650-1038



Project details: SR 1363 (S. Mebane Street) at E. Kitchin Street, Division 7, Alamance County, Burlington. Prepared by: DJ White, Reviewed by: AJ Davis, LM Moon. Date: 6/13/2018.

Professional Engineer Seal for Lisa M. Moon, License No. 022516, dated 6/13/2018.

13-JUN-2018 17:45 RE:U6015*P1off/ckm5:gnms:gnai(s)407-1257-dgn KANDERSON, AT CHA-KANDERSON

EDI MODEL 2018ECLip-NC CONFLICT MONITOR PROGRAMMING DETAIL

(remove jumpers and set switches as shown)

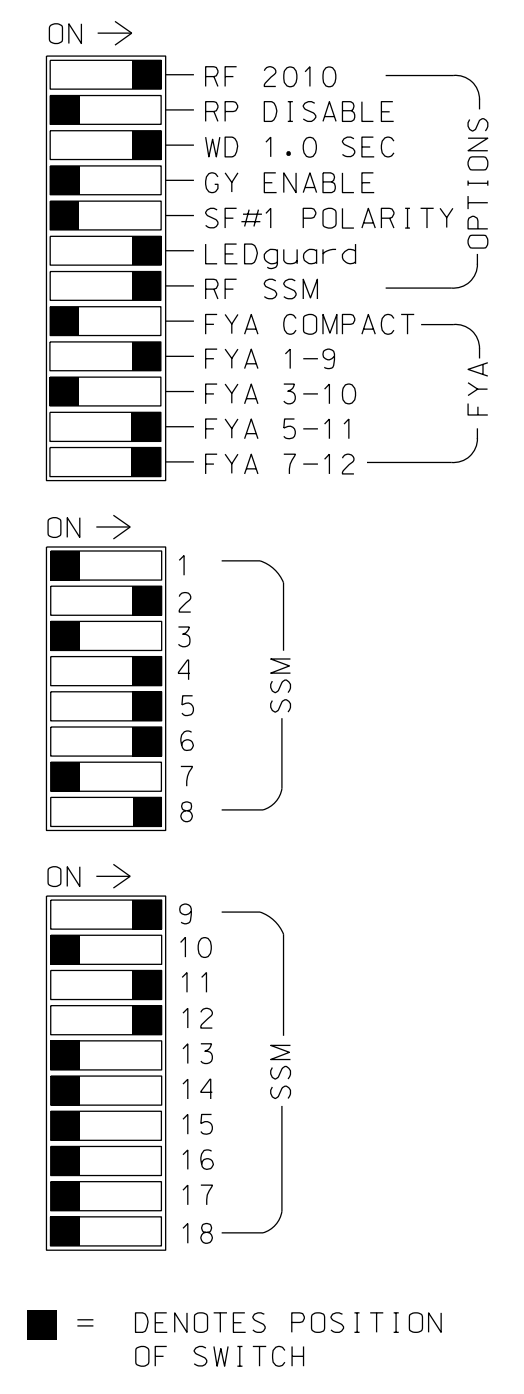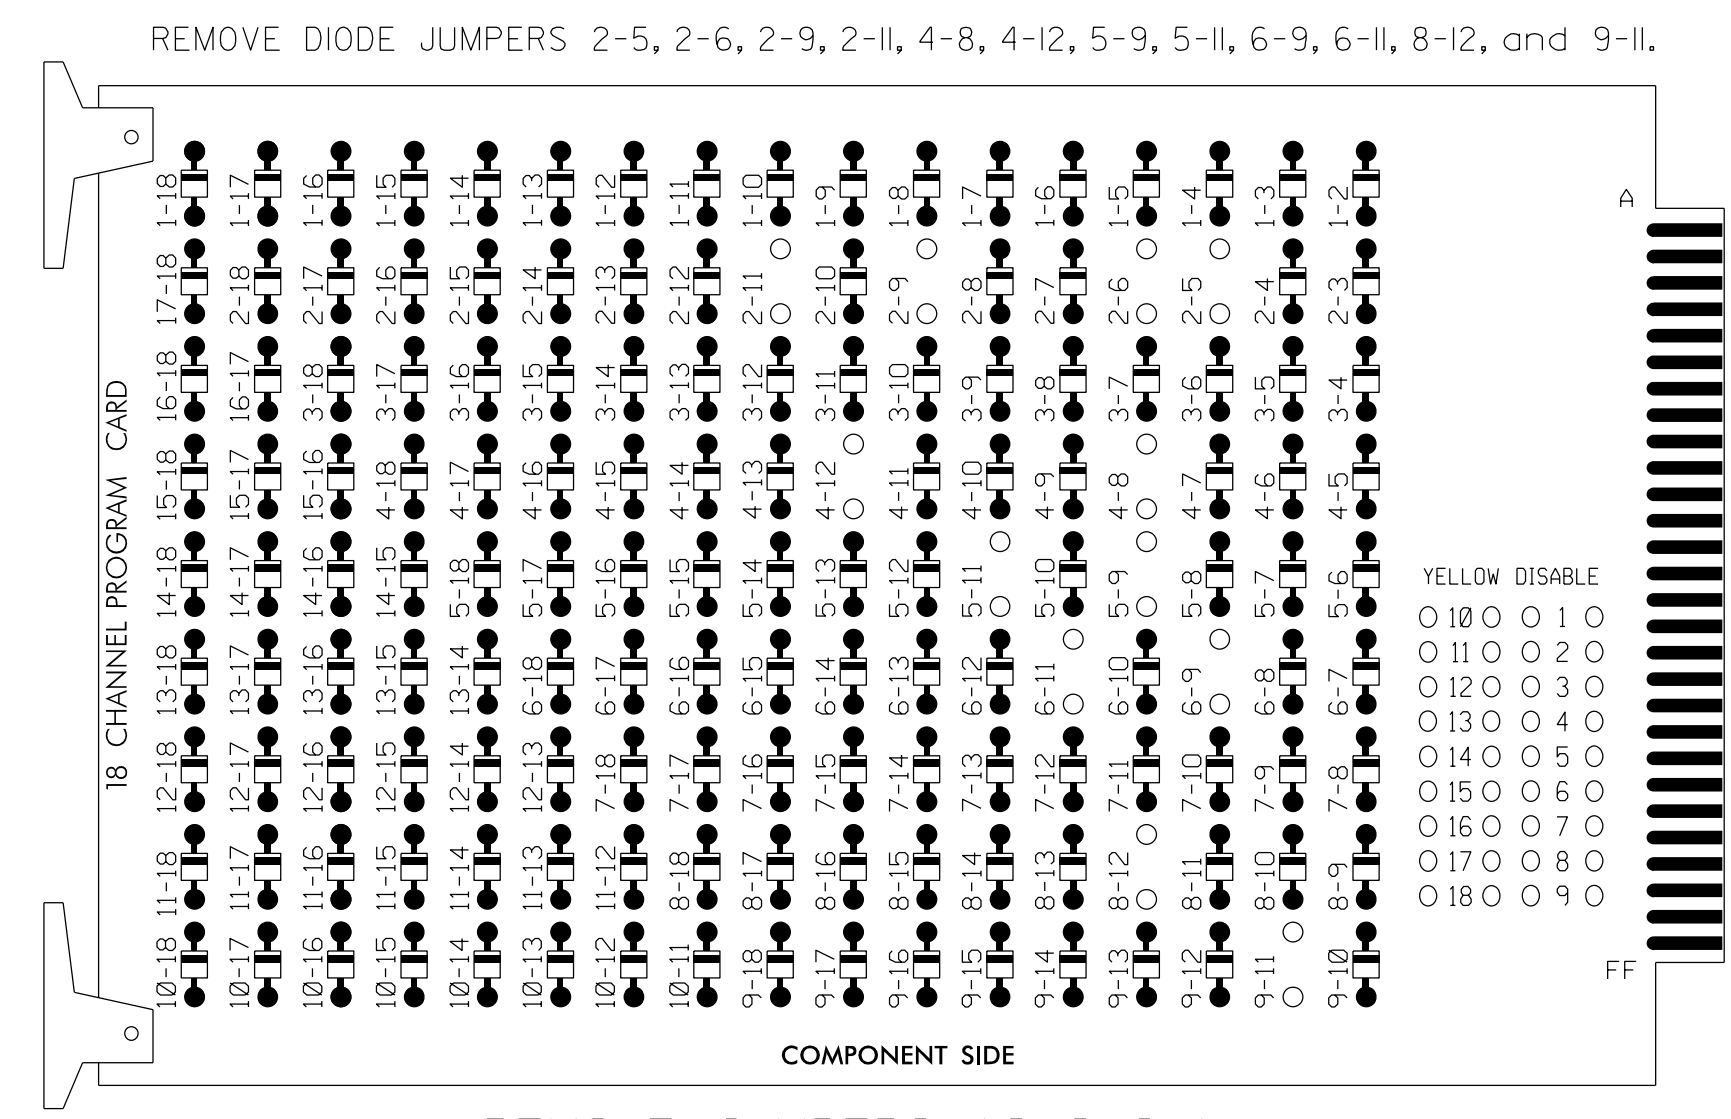

- NOTES:
- Card is provided with all diode jumpers in place. Removal of any jumper allows its channels to run concurrently.
 - Ensure jumpers SEL2-SEL5 and SEL9 are present on the monitor board.
 - Ensure that Red Enable is active at all times during normal operation.
 - Integrate monitor with Ethernet network in cabinet.

NOTES

- To prevent "flash-conflict" problems, insert red flash program blocks for all unused vehicle load switches in the output file. The installer shall verify that signal heads flash in accordance with the Signal Plans.
- Program phases 4 and 8 for Dual Entry.
- Program controller to start up in phase 2 Green and 6 Green.
- The cabinet and controller are part of the Burlington-Graham Signal System.

EQUIPMENT INFORMATION

CONTROLLER.....2070LX
 CABINET.....332 W/AUX
 SOFTWARE.....ECONOLITE ASC/3-2070
 CABINET MOUNT.....BASE
 OUTPUT FILE POSITIONS...18 WITH AUX. OUTPUT FILE
 LOAD SWITCHES USED.....S2,S5,S7,S8,S11,
 AUX S1,AUX S4,AUX S5
 PHASES USED.....2,4,5,6,8
 OVERLAP "A".....*
 OVERLAP "B".....NONE
 OVERLAP "C".....*
 OVERLAP "D".....*
 * See overlap programming detail on sheet 2


SIGNAL HEAD HOOK-UP CHART

LOAD SWITCH NO.	S1	S2	S3	S4	S5	S6	S7	S8	S9	S10	S11	S12	AUX S1	AUX S2	AUX S3	AUX S4	AUX S5	AUX S6
CMU CHANNEL NO.	1	2	13	3	4	14	5	6	15	7	8	16	9	10	17	11	12	18
PHASE	1	2	2 PED	3	4	4 PED	5	6	6 PED	7	8	8 PED	DLA	DLB	SPARE	OLC	OLD	SPARE
SIGNAL HEAD NO.	NU	21,22	NU	NU	42,43	NU	43	51	62,63	NU	NU	81,82	NU	61	NU	51	41	NU
RED		128			101		*		134			107						
YELLOW		129			102				135			108						
GREEN		130			103				136			109						
RED ARROW													A121			A114	A101	
YELLOW ARROW								132					A122			A115	A102	
FLASHING YELLOW ARROW													A123			A116	A103	
GREEN ARROW							133	133										

NU = Not Used
 * Denotes install load resistor. See load resistor installation detail this sheet.
 ★ See pictorial of head wiring in detail this sheet.

INPUT FILE POSITION LAYOUT


(front view)

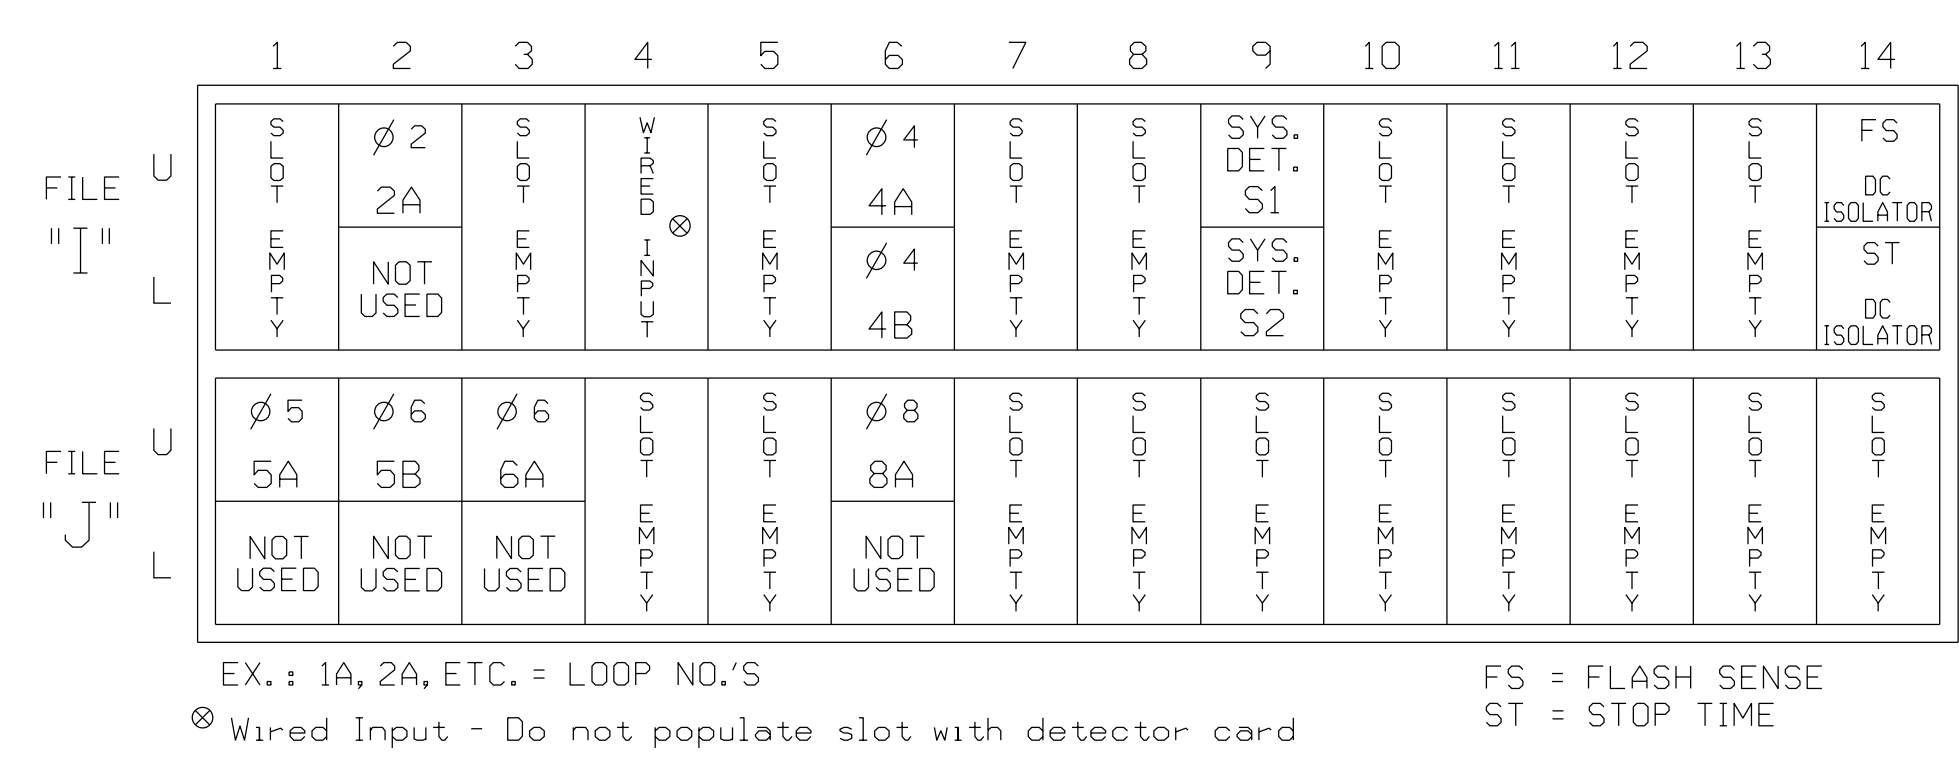

INPUT FILE CONNECTION & PROGRAMMING CHART


LOOP NO.	LOOP TERMINAL	INPUT FILE POS.	PIN NO.	DETECTOR NO.	NEMA PHASE	CALL	EXTEND TIME	DELAY TIME	ADDED INITIAL	DETECTOR TYPE
2A	TB2-5,6	I2U	39	2	2	YES				S
4A	TB4-9,10	I6U	41	4	4	YES		3		S
4B	TB4-11,12	I6L	45	14	4	YES				S
* S1	TB6-9,10	I9U	60	11	SYS	NO				N
* S2	TB6-11,12	I9L	62	13	SYS	NO				N
5A ¹	TB3-1,2	J1U	55	5	5	YES		15		S
		I4U	47	22	2	YES				S
5B	TB3-5,6	J2U	40	6	5	YES		15		S
6A	TB3-9,10	J3U	64	36	6	YES				S
8A	TB5-9,10	J6U	42	8	8	YES		10		S

* System detector only. Remove any assigned vehicle phase.
¹Add jumper from J1-W to I4-W, on rear of input file.

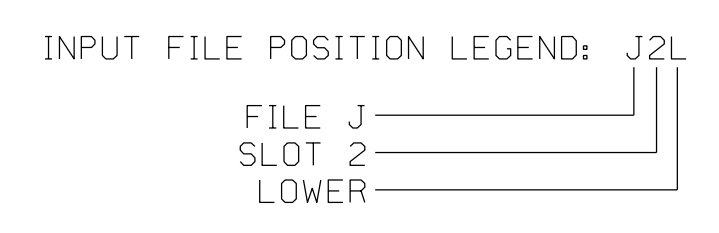


FYA SIGNAL WIRING DETAIL

(wire signal heads as shown)

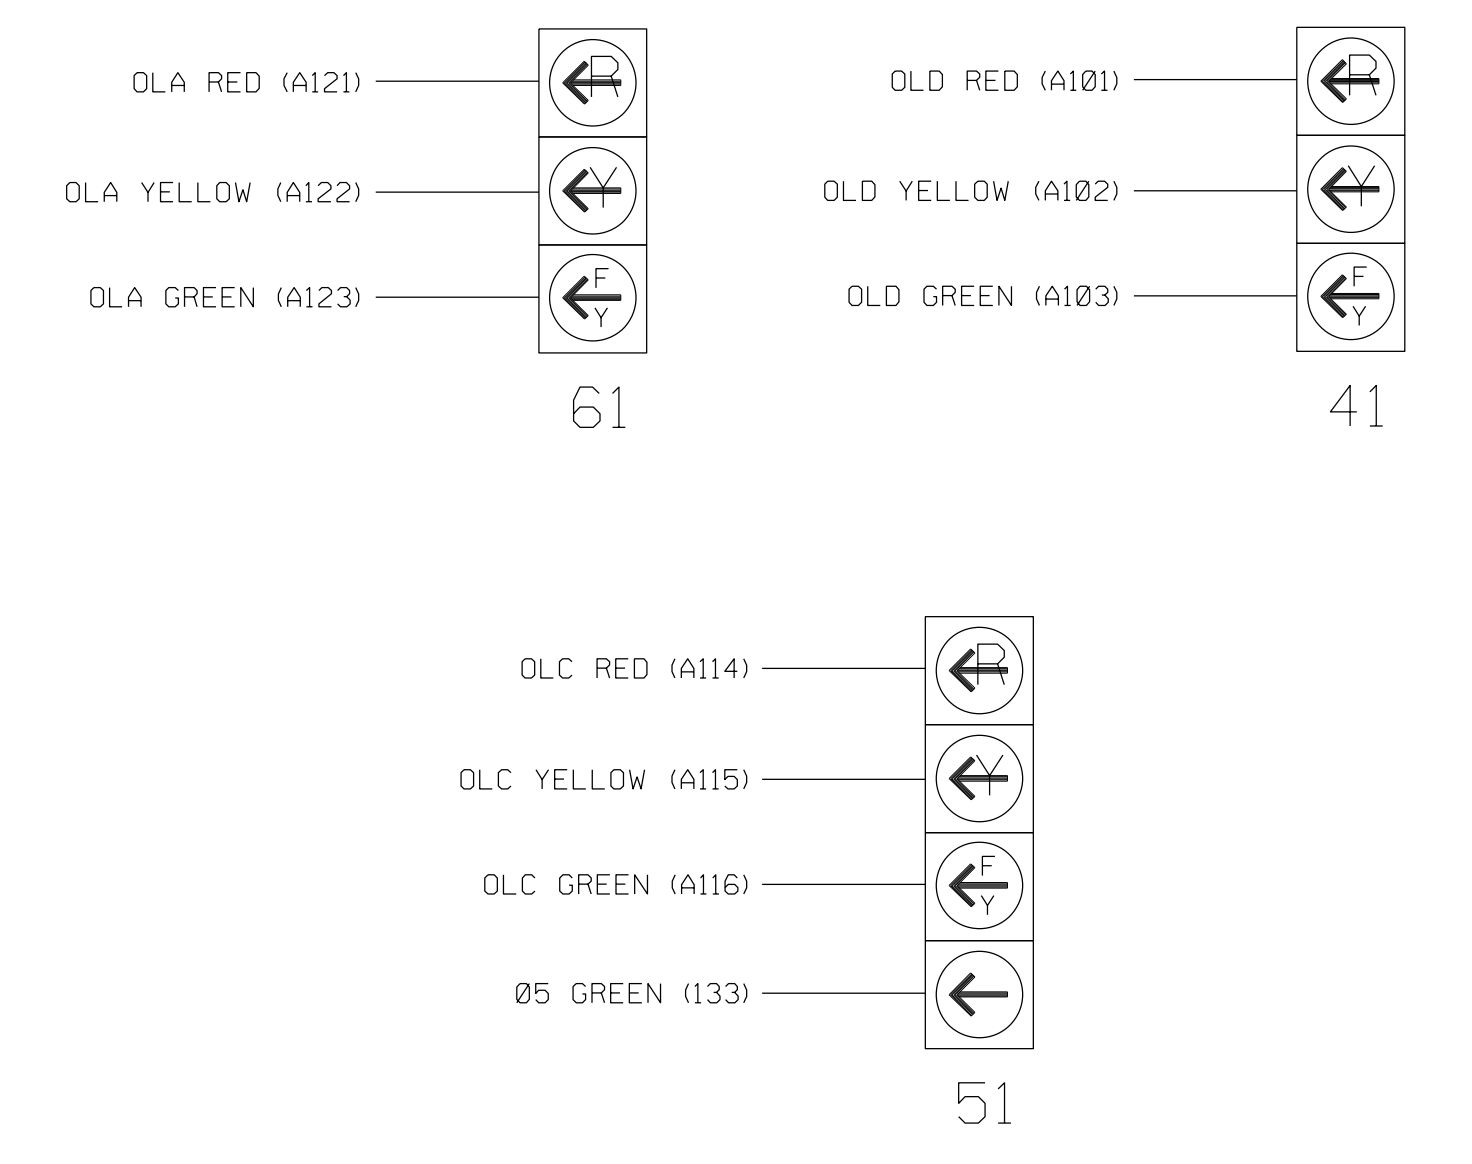

LOAD RESISTOR INSTALLATION DETAIL

(install resistor as shown)

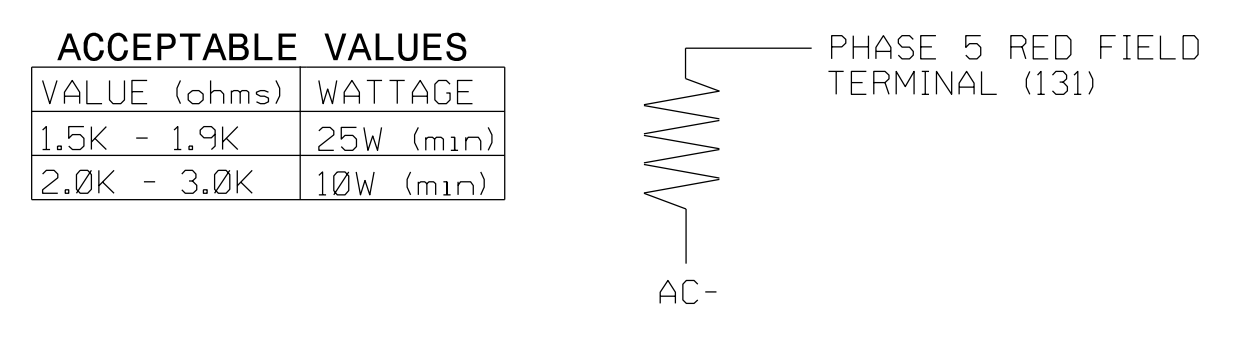

ACCEPTABLE VALUES

VALUE (ohms)	WATTAGE
1.5K - 1.9K	25W (min)
2.0K - 3.0K	10W (min)

Electrical Detail - Sheet 1 of 2

Electrical and Programming Details For:
 Prepared for the Offices of:

 DRMP, Inc.
 8000 Regency Parkway, Suite 175
 Cary, NC 27518
 NC License No. C-2413 (019) 650-1038

SR 1363 (S. Mebane Street) at E. Kitchin Street
 Division 7 Alamance County Burlington
 PLAN DATE: December 2017 REVIEWED BY: AJ Davis
 PREPARED BY: DJ White REVIEWED BY: LM Moon
 REVISIONS INIT. DATE

DOCUMENT NOT CONSIDERED FINAL UNLESS ALL SIGNATURES COMPLETED

SEAL

 DocuSigned by:
 Lisa M. Moon
 6/13/2018
 DATE
 SIG. INVENTORY NO. 07-1257

ECONOLITE ASC/3-2070 OVERLAP PROGRAMMING DETAIL (program controller as shown)

- 1. From Main Menu select 2. CONTROLLER
2. From CONTROLLER Submenu select 2. VEHICLE OVERLAPS

OVERLAP A
Select TMG VEH OVLP [A] and 'OTHER/ECONOLITE'
TMG VEH OVLP... [A] TYPE: OTHER/ECONOLITE
PHASES 1 2 3 4 5 6 7 8 9 0 1 2 3 4 5 6
INCLUDED . X
PROTECT
PED PRTC
NOT OVLP
FLSH GRN . 1
LAG X PH
LAG 2 PH
LAG GRN 0.0 YEL 0.0 RED 0.0 ADV GRN 0.0

Toggle Twice

OVERLAP C
Select TMG VEH OVLP [C] and 'PPLT FYA'
TMG VEH OVLP... [D] TYPE: PPLT FYA
PROTECTED LEFT TURN... PHASE 5
OPPOSING THROUGH... PHASE 6
FLASHING ARROW OUTPUT... CH11 ISOLATE
DELAY START OF: FYA..0.0 CLEARANCE..0.0
ACTION PLAN SF BIT DISABLE... 0

Toggle Once

OVERLAP D
Select TMG VEH OVLP [D] and 'OTHER/ECONOLITE'
TMG VEH OVLP... [D] TYPE: OTHER/ECONOLITE
PHASES 1 2 3 4 5 6 7 8 9 0 1 2 3 4 5 6
INCLUDED X
PROTECT
PED PRTC
NOT OVLP
FLSH GRN 1
LAG X PH
LAG 2 PH
LAG GRN 0.0 YEL 0.0 RED 0.0 ADV GRN 0.0

END PROGRAMMING

FLASHER CIRCUIT MODIFICATION DETAIL

IN ORDER TO ENSURE THAT SIGNALS FLASH CONCURRENTLY ON THE SAME APPROACH, MAKE THE FOLLOWING FLASHER CIRCUIT CHANGES:

- 1. ON REAR OF PDA - REMOVE WIRE FROM TERM. T2-4 AND TERMINATE ON T2-2.
2. ON REAR OF PDA - REMOVE WIRE FROM TERM. T2-5 AND TERMINATE ON T2-3.
3. REMOVE FLASHER UNIT 2.

THE CHANGES LISTED ABOVE TIES ALL PHASES AND OVERLAPS TO FLASHER UNIT 1.

THIS ELECTRICAL DETAIL IS FOR THE SIGNAL DESIGN: 07-1257 DESIGNED: DECEMBER 2017 SEALED: 06-13-2018 REVISED: N/A

Electrical Detail - Sheet 2 of 2

ELECTRICAL AND PROGRAMMING DETAILS FOR: Prepared for the Offices of: DRMP, Inc. 8000 Regency Parkway, Suite 175 Cary, NC 27519 NC License No. C-2215 (019) 650-1038

SR 1363 (S. Mebane Street) at E. Kitchin Street Division 7 Alamance County Burlington PLAN DATE: December 2017 REVIEWED BY: AJ Davis PREPARED BY: DJ White REVIEWED BY: LM Moon

DOCUMENT NOT CONSIDERED FINAL UNLESS ALL SIGNATURES COMPLETED SEAL NORTH CAROLINA PROFESSIONAL ENGINEER SEAL 022516 LISA M. MOON DocuSigned by: Lisa M. Moon 6/13/2018

13-JUN-2018 17:45 R:\66015\Work\Projects\Signal\ases\gn\wlr\mg07-1257e.dgn KANDERSON AT CHA-Y.ANDERSON

THIS SHEET LEFT INTENTIONALLY BLANK

18-JUN-2018 15:11
 ***work files.com\projects\USRL\Transportation\Traffic\Cur\100056489 U-6015 B-C S1a Sys*Task 05-11_Signals\Design\07-125B - FUTURE.dgn
 P183836 AT US40478

Signal Upgrade



Prepared for the Offices of:
**US 70 (S. Church Street)
 at
 Wade Cable Drive (Future)**
 Division 7 Alamance County Burlington
 PLAN DATE: June 2018 REVIEWED BY: MBT
 PREPARED BY: NAP REVIEWED BY: AME

DOCUMENT NOT CONSIDERED FINAL UNLESS ALL SIGNATURES COMPLETED

SEAL

SIGNATURE DATE


SIG. INVENTORY NO. 07-1258

ATKINS 1616 EAST MILLBROOK ROAD, SUITE 160
 RALEIGH, NORTH CAROLINA 27609
 (919) 876-6888 NCBEEES #F-0326

REVISIONS	INIT.	DATE

NTS

PHASING DIAGRAM

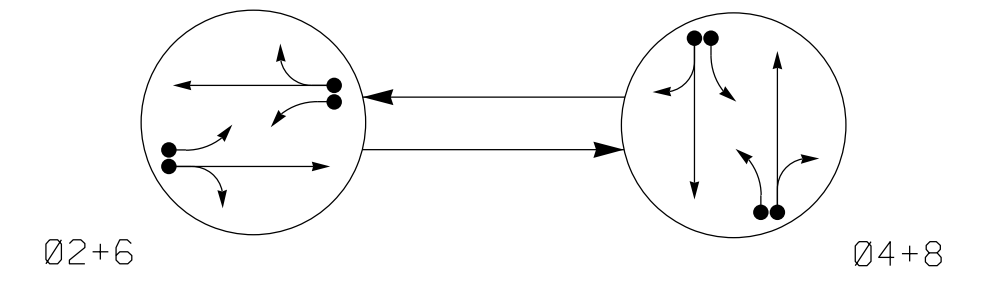

PHASING DIAGRAM DETECTION LEGEND


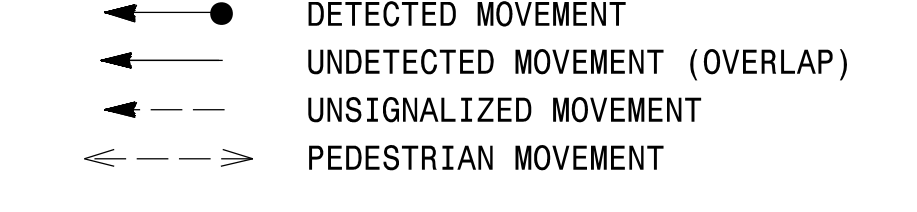


TABLE OF OPERATION

SIGNAL FACE	PHASE		
	02+6	04+8	FLASH
21, 22	G	R	Y
41, 42	R	G	R
61, 62	G	R	Y
81, 82	R	G	R


SIGNAL FACE I.D.

All Heads L.E.D.

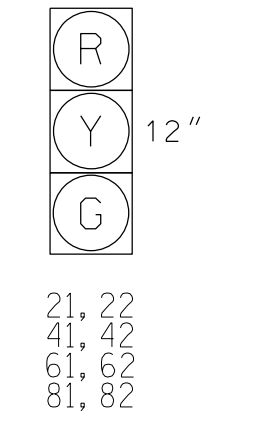

ASC/3 DETECTOR INSTALLATION CHART

LOOP	SIZE (FT)	DISTANCE FROM STOPBAR (FT)	TURNS	NEW LOOP	PHASE	PROGRAMMING						
						CALLING	EXTEND TIME	DELAY TIME	USE ADDED INITIAL	TYPE	LOOP	NEW CARD
2A	6X40	+5	2-4-2	-	2	Yes	-	3	-	S	-	X
2B	6X40	+5	2-4-2	-	2	Yes	-	-	-	S	-	X
4A	6X40	+5	2-4-2	-	4	Yes	-	3	-	S	-	X
4B	6X60	+5	2-4-2	-	4	Yes	-	10	-	S	-	X
6A	6X60	0	2-4-2	-	6	Yes	-	3	-	S	-	X
6B	6X60	+5	2-4-2	-	6	Yes	-	-	-	S	-	X
8A	6X40	+5	2-4-2	-	8	Yes	-	3	-	S	-	X
8B	6X60	+5	2-4-2	-	8	Yes	-	10	-	S	-	X

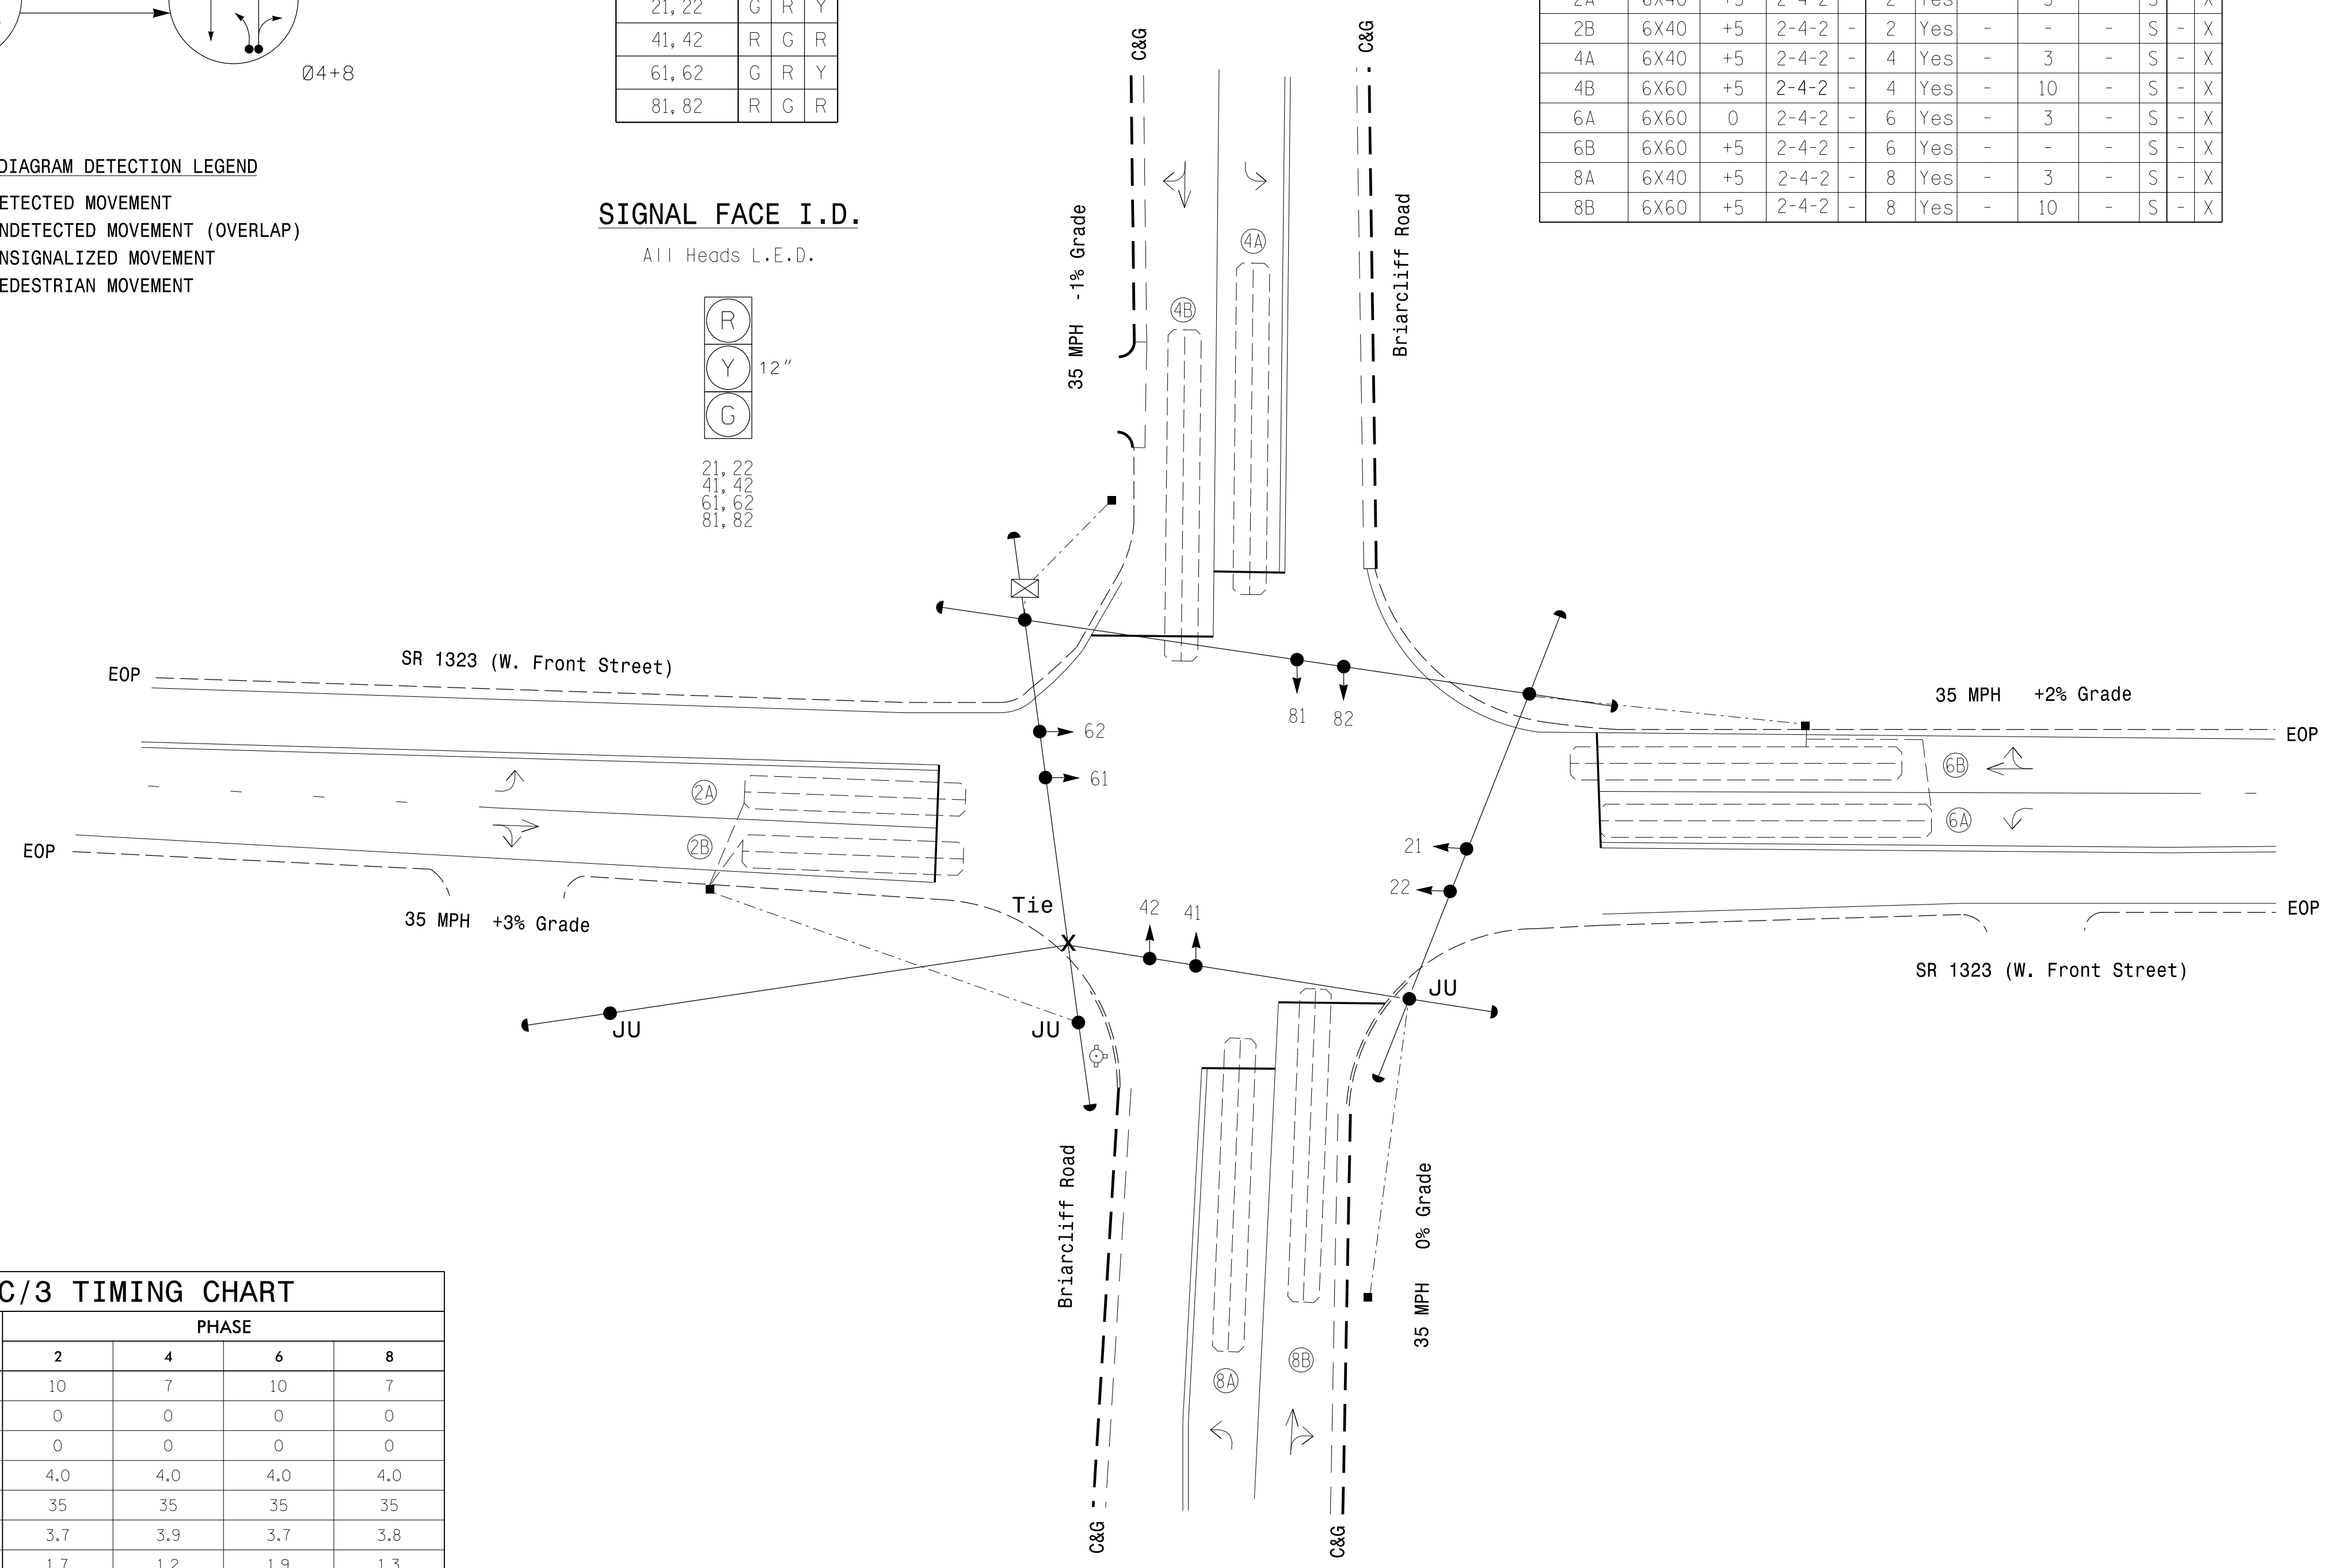

ASC/3 TIMING CHART

FEATURE	PHASE			
	2	4	6	8
Min Green *	10	7	10	7
Walk *	0	0	0	0
Ped Clear	0	0	0	0
Veh. Extension *	4.0	4.0	4.0	4.0
Max 1 *	35	35	35	35
Yellow	3.7	3.9	3.7	3.8
Red Clear	1.7	1.2	1.9	1.3
Actuations B4 Add *	-	-	-	-
Seconds /Actuation *	-	-	-	-
Max Initial *	-	-	-	-
Time Before Reduction *	-	-	-	-
Time To Reduce *	-	-	-	-
Minimum Gap	-	-	-	-
Locking Detector	-	-	-	-
Recall Position	VEH. RECALL	-	VEH. RECALL	-
Dual Entry	-	X	-	X
Simultaneous Gap	X	X	X	X


* These values may be field adjusted. Do not adjust Min Green and Extension times for phases 2 and 6 lower than what is shown. Min Green for all other phases should not be lower than 4 seconds.

2 Phase Fully Actuated (Burlington-Graham Signal System)

NOTES


1. Refer to "Roadway Standard Drawings NCDOT" dated January 2018 and "Standard Specifications for Roads and Structures" dated January 2018.
2. Do not program signal for late night flashing operation unless otherwise directed by the Engineer.
3. Reposition all existing signal heads to center over respective through lane.
4. Loop data based on previous plan and field observations
5. Set all detector units to presence mode.
6. In the event of loop replacement, refer to the current ITS and Signals Design Manual and submit a Plan of Record to the Signal Design Section.
7. Locate new cabinet so as not to obstruct sight distance of vehicles turning right on red.
8. The cabinet should be designed to include an Auxiliary Output file for future use.
9. Pavement markings are existing.
10. Maximum times shown in timing chart are for free-run operation only. Coordinated signal system timing values supersede these values.

LEGEND

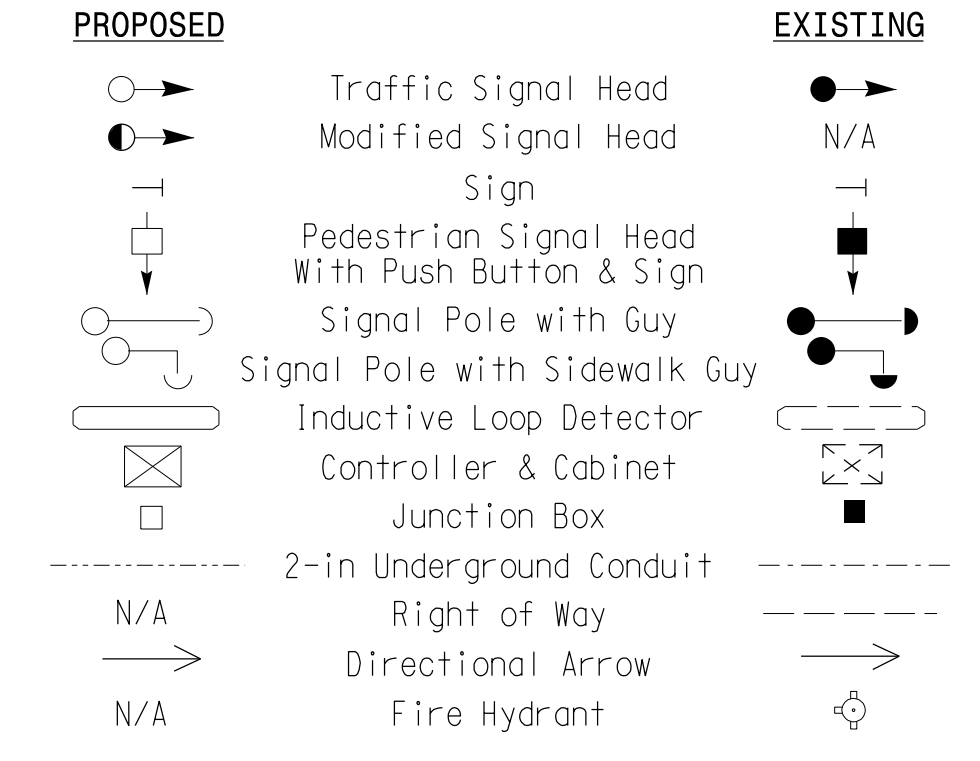

Signal Upgrade

DOCUMENT NOT CONSIDERED FINAL UNLESS ALL SIGNATURES COMPLETED

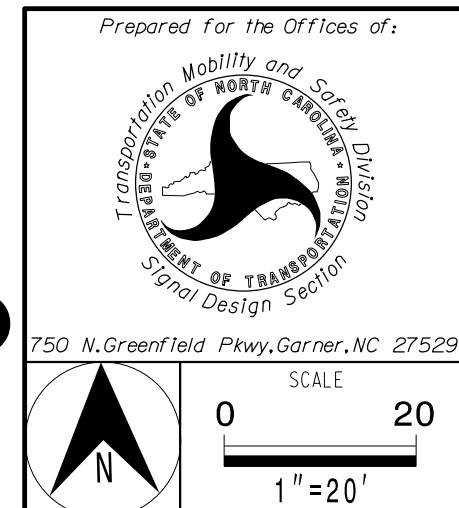


SR 1323 (W. Front Street) at Briarcliff Road

Division 7 Alamance County Burlington



PLAN DATE: November 2017 REVIEWED BY: AJ Davis

PREPARED BY: RD Lawton REVIEWED BY: LM Moon

REVISIONS	INIT.	DATE

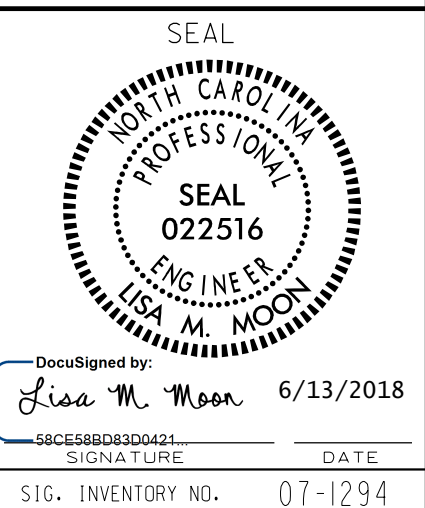


13-UNA-2018-17-46
R:\6015\6015_17\off\csl\gms\gms\signal\13-UNA-2018-17-46.dgn
KANDERSON AT CHA-Y.ANDERSON

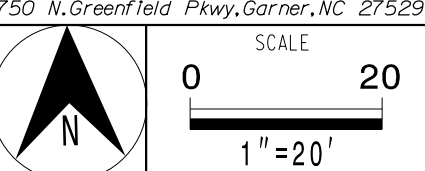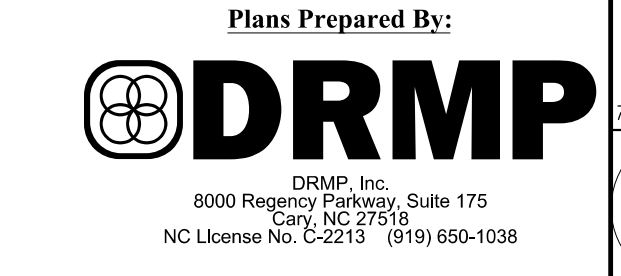

SIG. INVENTORY NO. 07-1294

EDI MODEL 2018EClip-NC CONFLICT MONITOR PROGRAMMING DETAIL

(remove jumpers and set switches as shown)

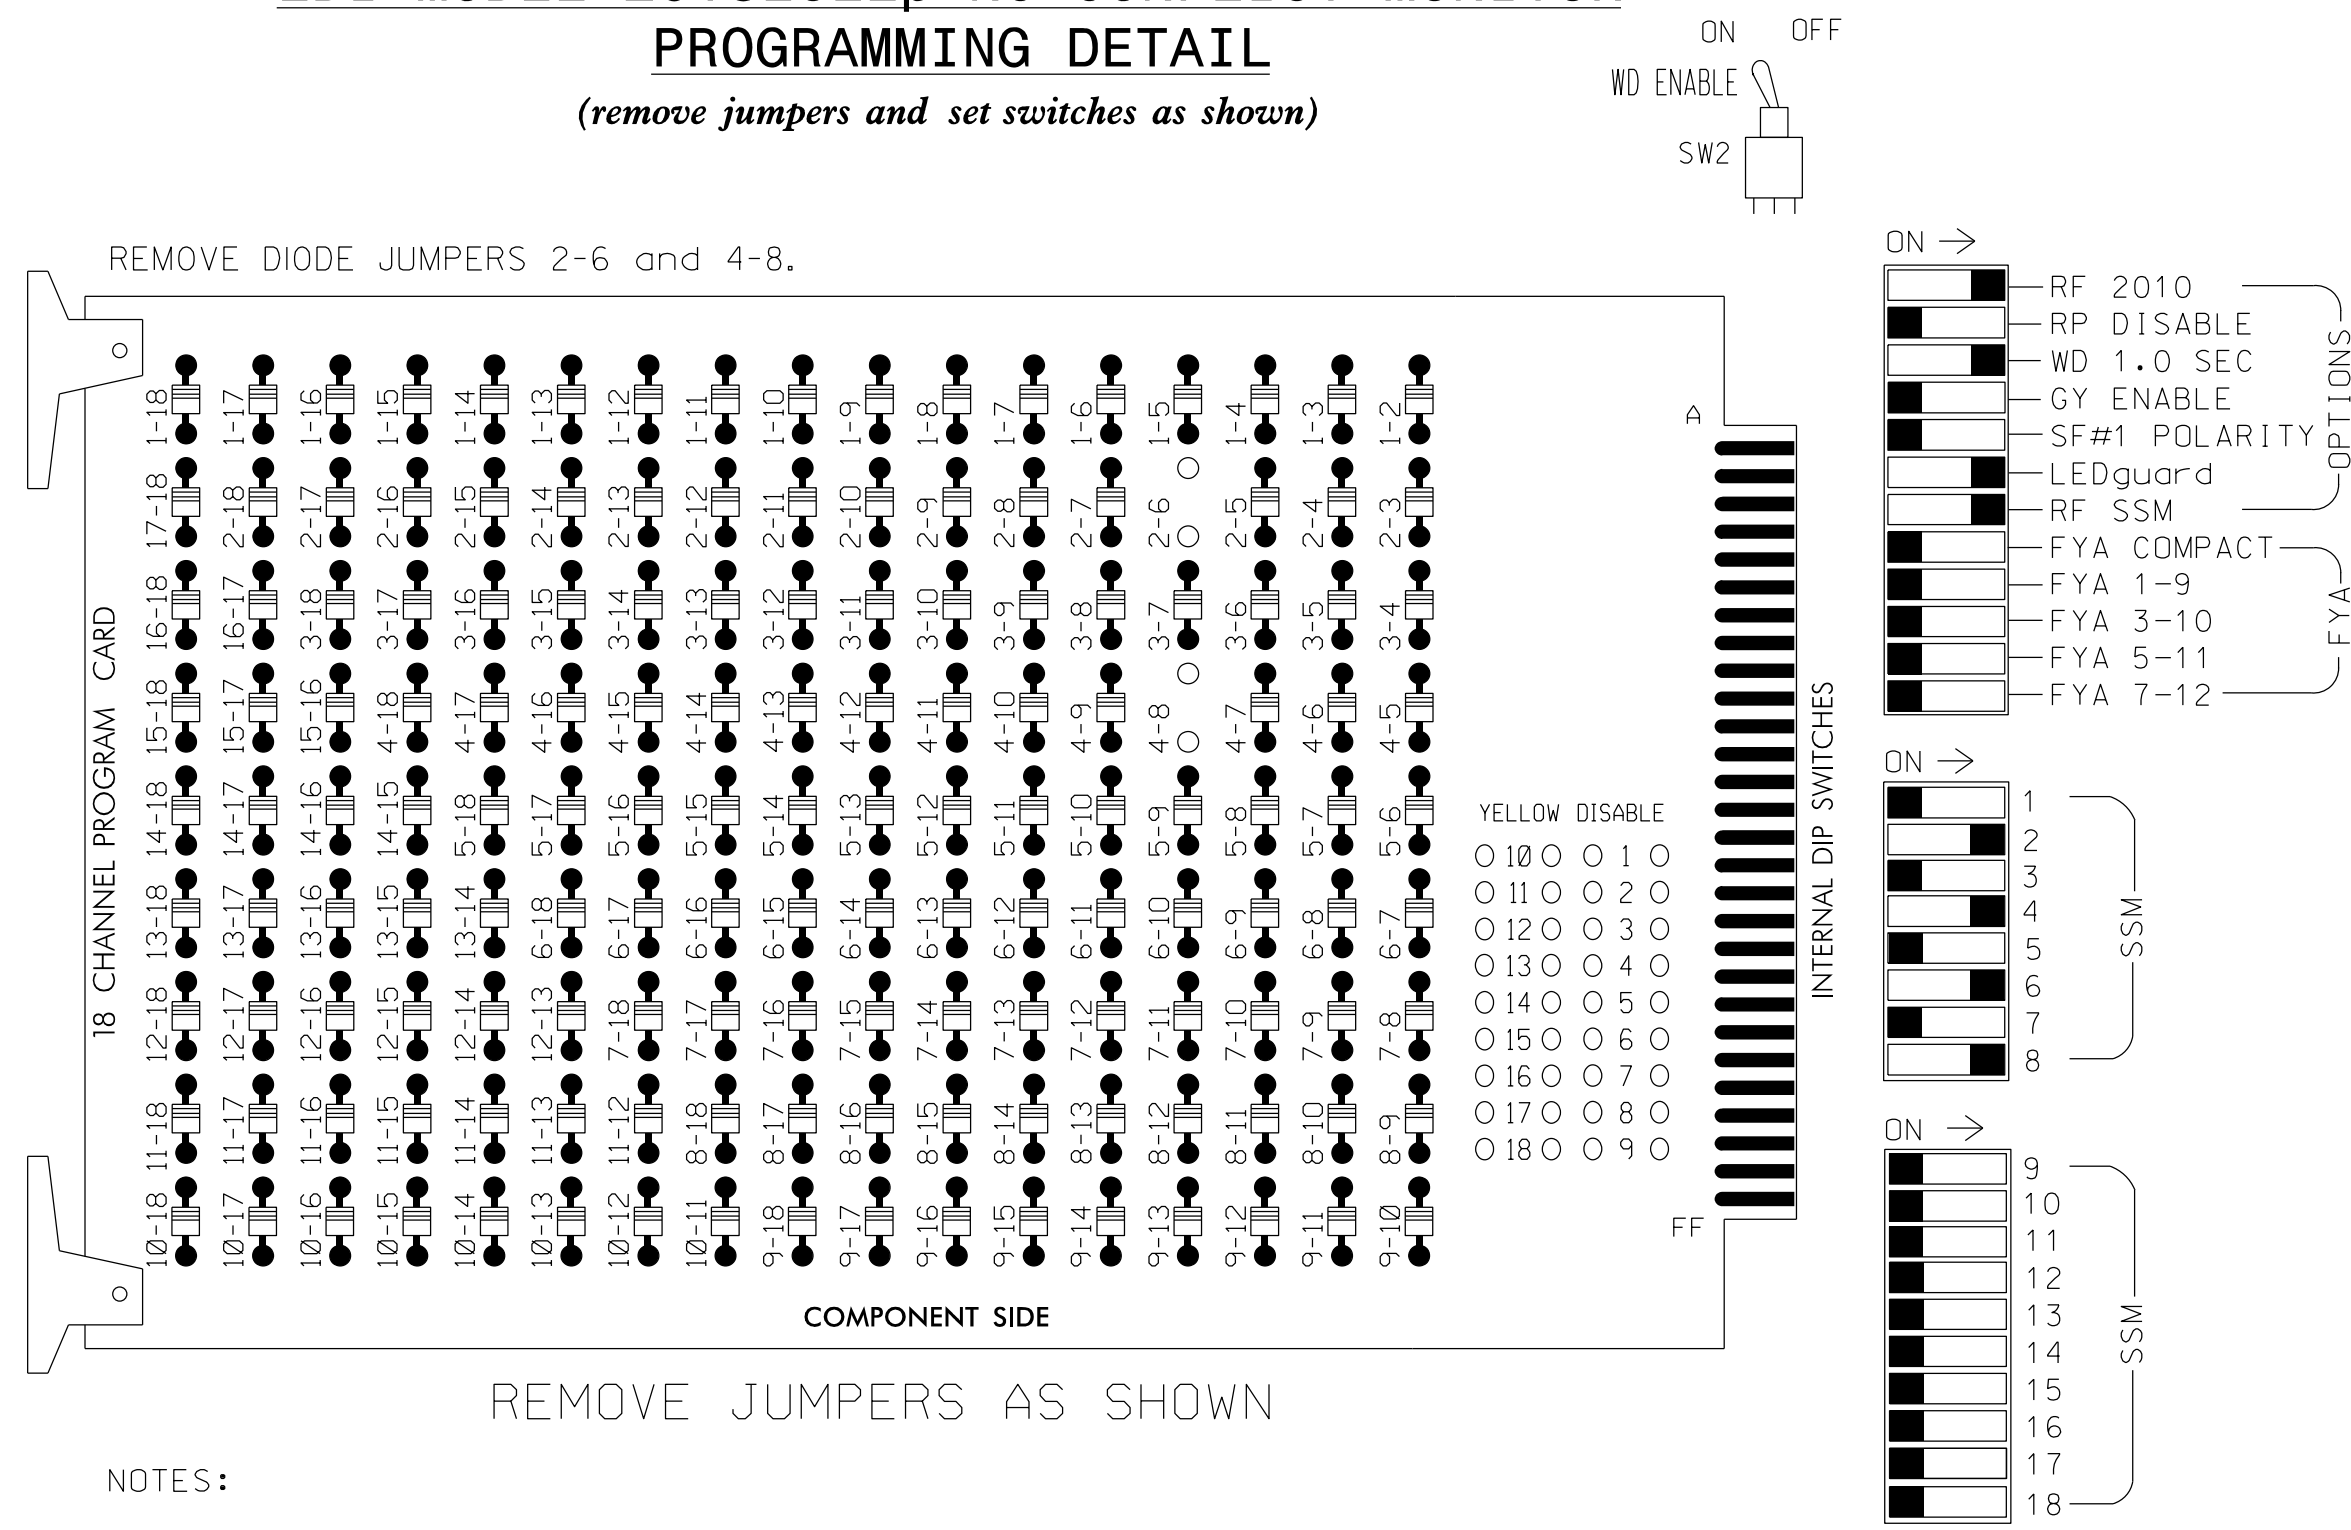

NOTES:

- Card is provided with all diode jumpers in place. Removal of any jumper allows its channels to run concurrently.
- Ensure jumpers SEL2-SEL5 and SEL9 are present on the monitor board.
- Ensure that Red Enable is active at all times during normal operation.
- Ensure Conflict Monitor Ethernet port is connected to a Switch port located within the cabinet.

NOTES

- To prevent "flash-conflict" problems, insert red flash program blocks for all unused vehicle load switches in the output file. The installer shall verify that signal heads flash in accordance with the Signal Plans.
- Program phases 4 and 8 for Dual Entry.
- Program controller to start up in phase 2 Green and 6 Green.
- The cabinet and controller are part of the Burlington-Graham Signal System.

EQUIPMENT INFORMATION

CONTROLLER.....2070LX
 CABINET.....332 W/AUX
 SOFTWARE.....ECONOLITE ASC/3-2070
 CABINET MOUNT.....BASE
 OUTPUT FILE POSITIONS...18 WITH AUX. OUTPUT FILE
 LOAD SWITCHES USED.....S2,S5,S8,S11
 PHASES USED.....2,4,6,8
 OVERLAP "A".....NOT USED
 OVERLAP "B".....NOT USED
 OVERLAP "C".....NOT USED
 OVERLAP "D".....NOT USED


SIGNAL HEAD HOOK-UP CHART

LOAD SWITCH NO.	S1	S2	S3	S4	S5	S6	S7	S8	S9	S10	S11	S12	AUX S1	AUX S2	AUX S3	AUX S4	AUX S5	AUX S6
CMU CHANNEL NO.	1	2	13	3	4	14	5	6	15	7	8	16	9	10	17	11	12	18
PHASE	1	2	2 PED	3	4	4 PED	5	6	6 PED	7	8	8 PED	OLA	OLB	SPARE	OLC	OLD	SPARE
SIGNAL HEAD NO.	NU	21,22	NU	NU	41,42	NU	NU	61,62	NU	NU	81,82	NU	NU	NU	NU	NU	NU	NU
RED		128			101			134			107							
YELLOW		129			102			135			108							
GREEN		130			103			136			109							
RED ARROW																		
YELLOW ARROW																		
GREEN ARROW																		

NU = Not Used

INPUT FILE POSITION LAYOUT


(front view)

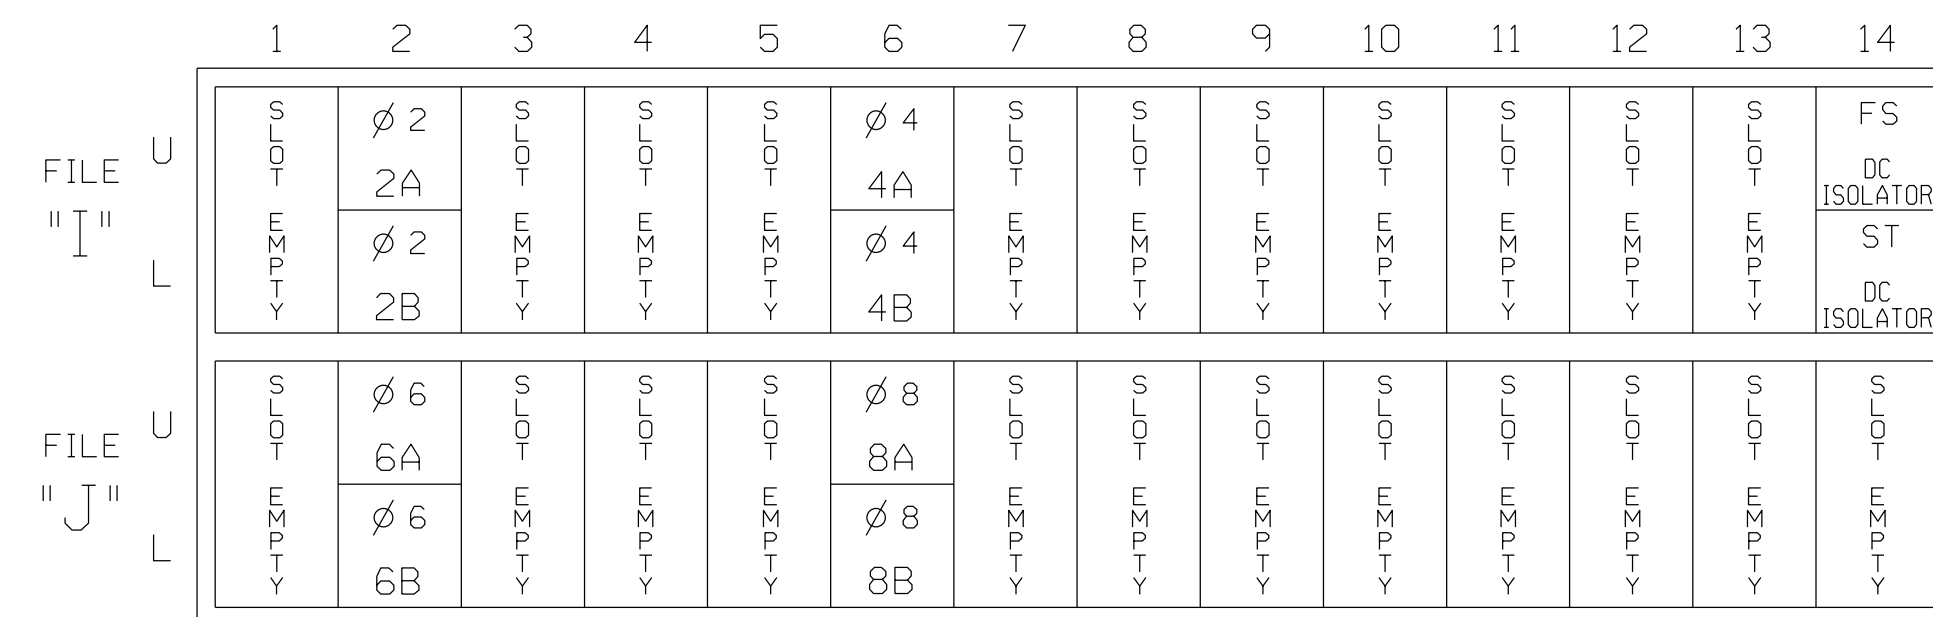

INPUT FILE CONNECTION & PROGRAMMING CHART

LOOP NO.	LOOP TERMINAL	INPUT FILE POS.	PIN NO.	DETECTOR NO.	NEMA PHASE	CALL	EXTEND TIME	DELAY TIME	ADDED INITIAL	DETECTOR TYPE
2A	TB2-5,6	I2U	39	2	2	YES		3		S
2B	TB2-7,8	I2L	43	12	2	YES				S
4A	TB4-9,10	I6U	41	4	4	YES		3		S
4B	TB4-11,12	I6L	45	14	4	YES		10		S
6A	TB3-5,6	J2U	40	6	6	YES		3		S
6B	TB3-7,8	J2L	44	16	6	YES				S
8A	TB5-9,10	J6U	42	8	8	YES		3		S
8B	TB5-11,12	J6L	46	18	8	YES		10		S

INPUT FILE POSITION LEGEND: J2L

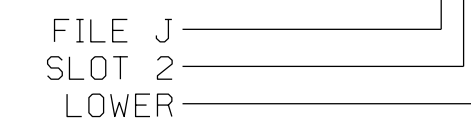

THIS ELECTRICAL DETAIL IS FOR THE SIGNAL DESIGN: 07-1294
 DESIGNED: NOVEMBER 2017
 SEALED: 06-13-2018
 REVISED: N/A

Electrical Detail

ELECTRICAL AND PROGRAMMING DETAILS FOR:

Prepared for the Offices of:



SR 1323 (W. Front Street) at Briarcliff Road

Division 7 Alamance County Burlington

PLAN DATE: November 2017 REVIEWED BY: AJ Davis

PREPARED BY: RD Lawton REVIEWED BY: LM Moon

REVISIONS INIT. DATE

750 N. Greenfield Pkwy, Garner, NC 27529

DOCUMENT NOT CONSIDERED FINAL UNLESS ALL SIGNATURES COMPLETED



DocuSigned by: Lisa M. Moon 6/13/2018


SIG. INVENTORY NO. 07-1294

5 Phase Fully Actuated (Burlington-Graham Signal System)

NOTES

1. Refer to "Roadway Standard Drawings NCDOT" dated January 2018 and "Standard Specifications for Roads and Structures" dated January 2018.
2. Do not program signal for late night flashing operation unless otherwise directed by the Engineer.
3. Phase 1 and/or phase 5 may be lagged.
4. Reposition existing signal heads numbered 21, 22, and 61.
5. Set all detector units to presence mode.
6. In the event of loop replacement, refer to the current ITS and Signals Design Manual and submit a Plan of Record to the Signal Design Section.
7. Locate new cabinet so as not to obstruct sight distance of vehicles turning right on red.
8. Pavement markings are existing.
9. The City Traffic Engineer will determine the hours of use for each phasing plan.
10. Maximum times shown in timing chart are for free-run operation only. Coordinated signal system timing values supersede these values.


DEFAULT PHASING DIAGRAM

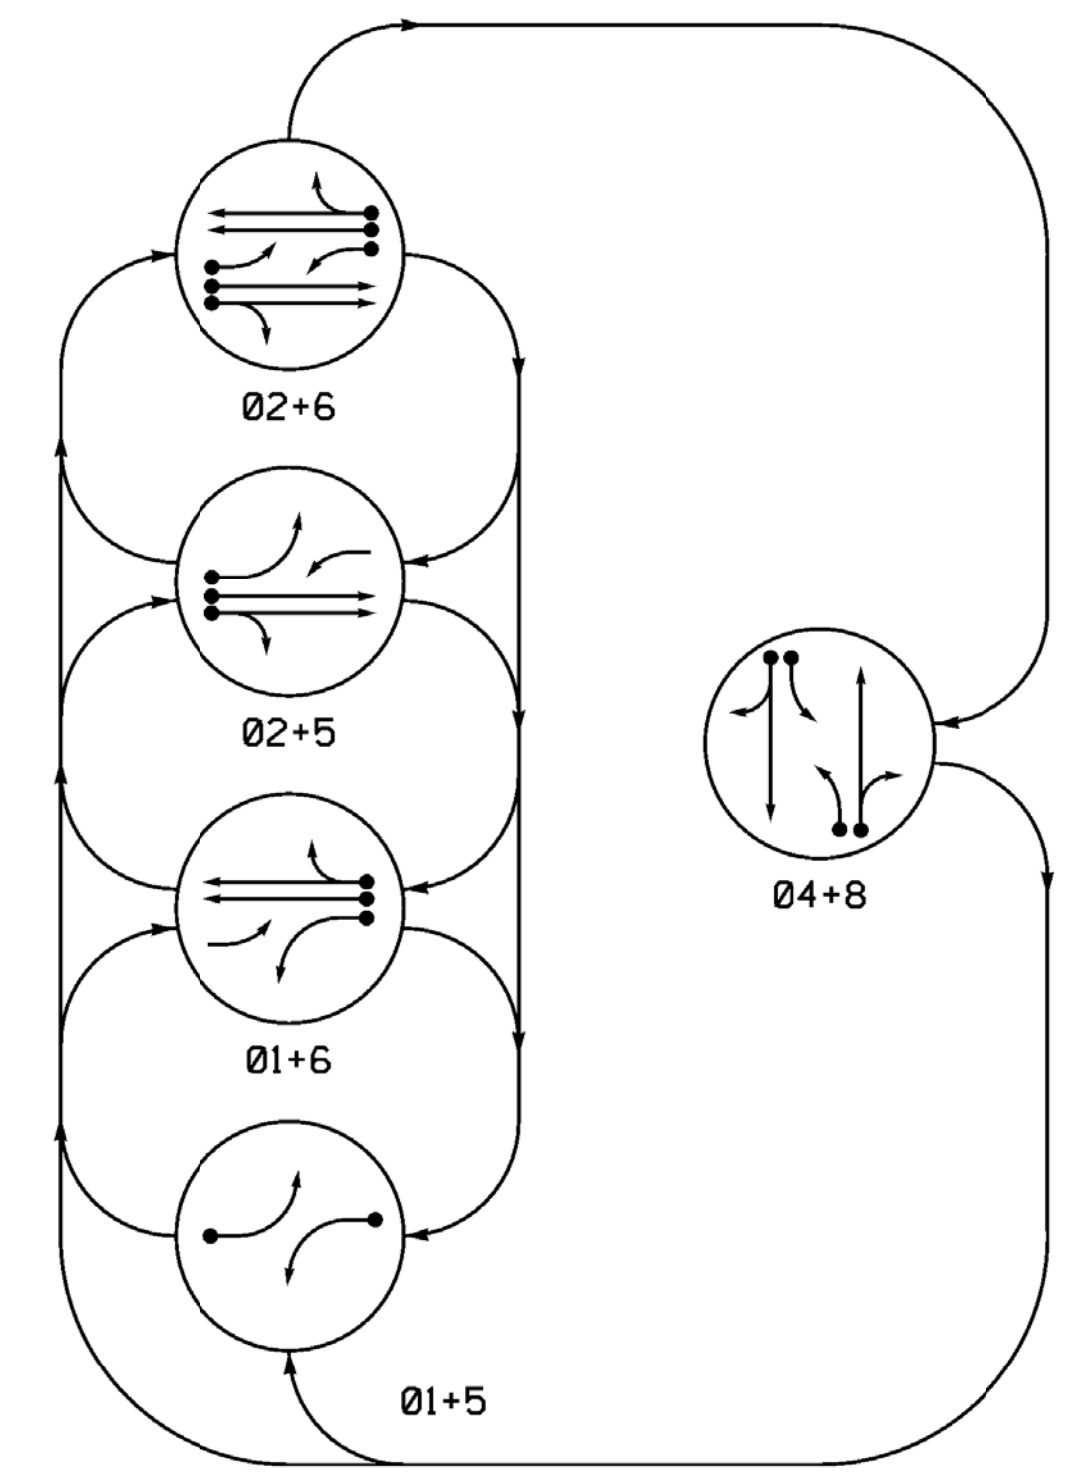


DEFAULT TABLE OF OPERATION

SIGNAL FACE	PHASE					
	01+5	01+6	02+5	02+6	04+8	FLASH
11	-	-	F	F	R	Y
21, 22	R	R	G	G	R	Y
41, 42	R	R	R	R	G	R
51	-	F	-	F	R	Y
61, 62	R	G	R	G	R	Y
81, 82	R	R	R	R	G	R

SIGNAL FACE I.D.

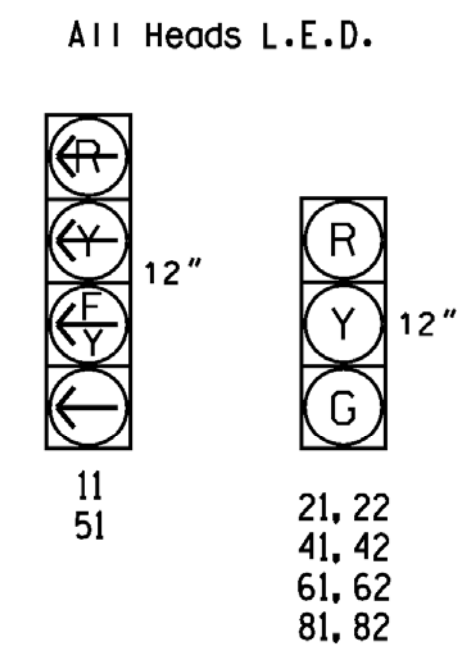

ALTERNATE PHASING DIAGRAM

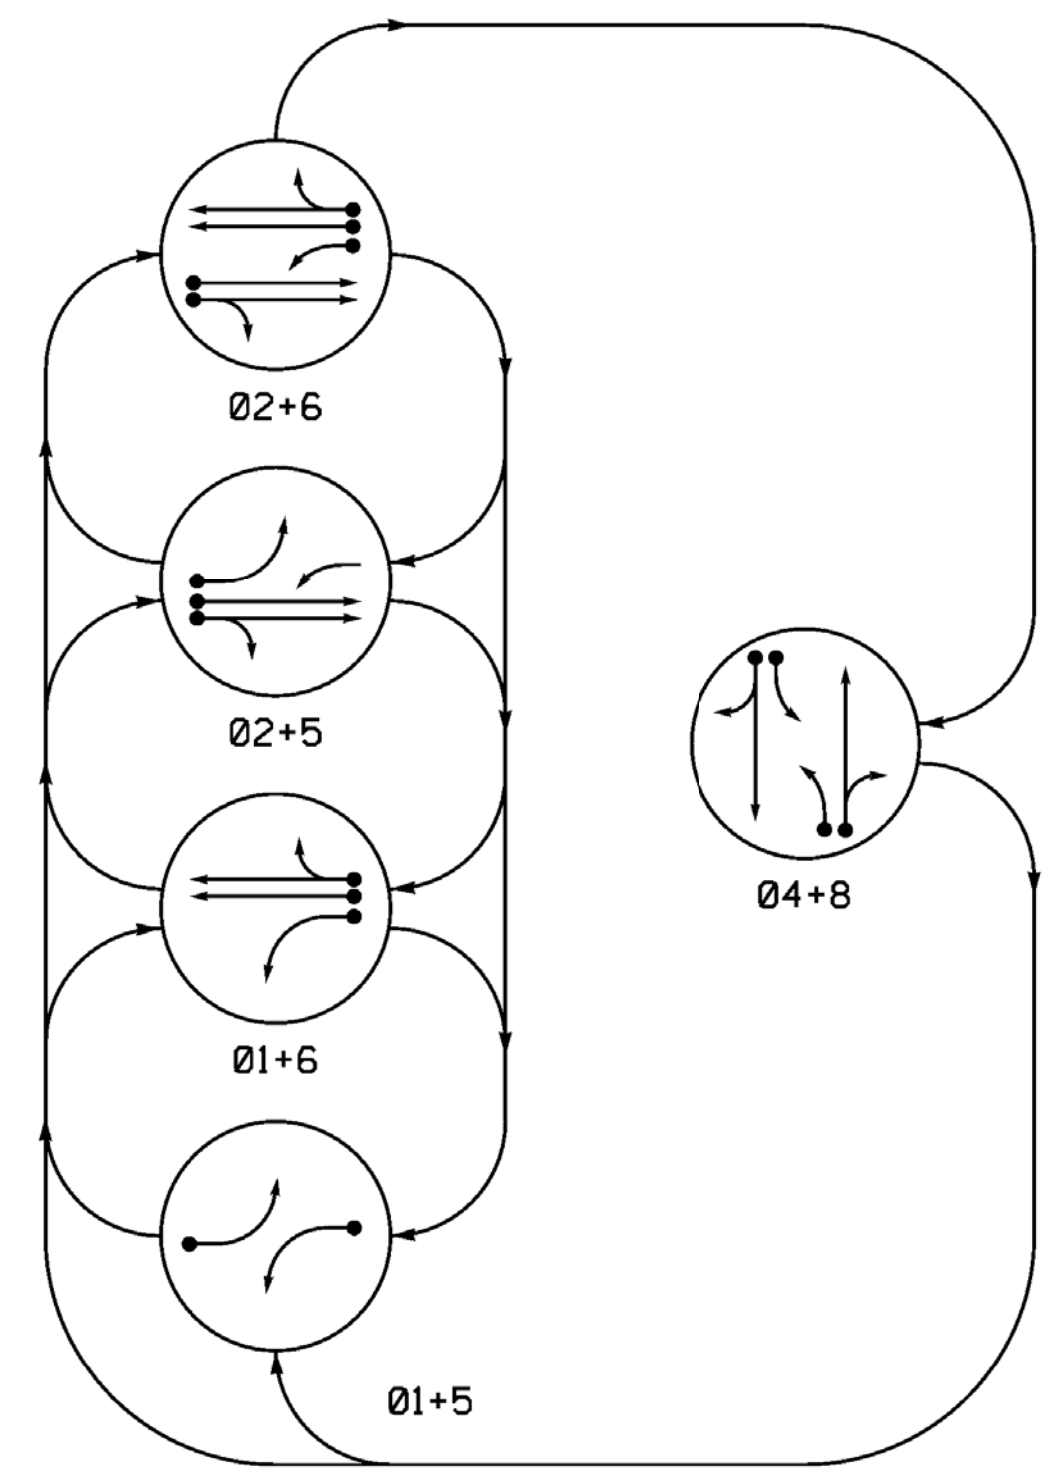

ALTERNATE TABLE OF OPERATION

SIGNAL FACE	PHASE					
	01+5	01+6	02+5	02+6	04+8	FLASH
11	-	-	F	F	R	Y
21, 22	R	R	G	G	R	Y
41, 42	R	R	R	R	G	R
51	-	R	-	R	R	Y
61, 62	R	G	R	G	R	Y
81, 82	R	R	R	R	G	R

PHASING DIAGRAM DETECTION LEGEND

- DETECTED MOVEMENT
- UNDETECTED MOVEMENT (OVERLAP)
- UNSIGNALIZED MOVEMENT
- PEDESTRIAN MOVEMENT


PHASING DIAGRAM DETECTION LEGEND

- DETECTED MOVEMENT
- UNDETECTED MOVEMENT (OVERLAP)
- UNSIGNALIZED MOVEMENT
- PEDESTRIAN MOVEMENT

ASC/3 DETECTOR INSTALLATION CHART

LOOP	SIZE (FT)	DISTANCE FROM STOPBAR (FT)	TURNS	NEW LOOP	PROGRAMMING							
					PHASE	CALLING	EXTEND TIME	DELAY TIME	USE ADDED INITIAL	TYPE	SYSTEM LOOP	NEW CARD
1A	6x60	+5	EXIST.	-	1	Yes	-	15	-	S	-	X
2A	6x20	300	EXIST.	-	2	Yes	-	-	-	S	-	X
2B	6x32	80	EXIST.	-	2	Yes	-	1.7	-	S	-	X
4A	6x50	+5	EXIST.	-	4	Yes	-	3	-	S	-	X
4B	6x50	+5	EXIST.	-	4	Yes	-	10	-	S	-	X
5A	6x40	0	2-4-2	X	5	Yes	-	15*	-	S	-	X
6A	6x20	300	EXIST.	-	6	Yes	-	1.7	-	S	-	X
6B	6x32	80	EXIST.	-	6	Yes	-	-	-	S	-	X
8A	6x60	+5	2-4-2	-	8	Yes	-	3	-	S	-	X
8B	6x60	+5	2-4-2	-	8	Yes	-	10	-	S	-	X

* Disable Delay During Alternate Phasing Operation.
 ** Disable Phase 2 Call for Loop 5A during Alternate Phasing Operation.

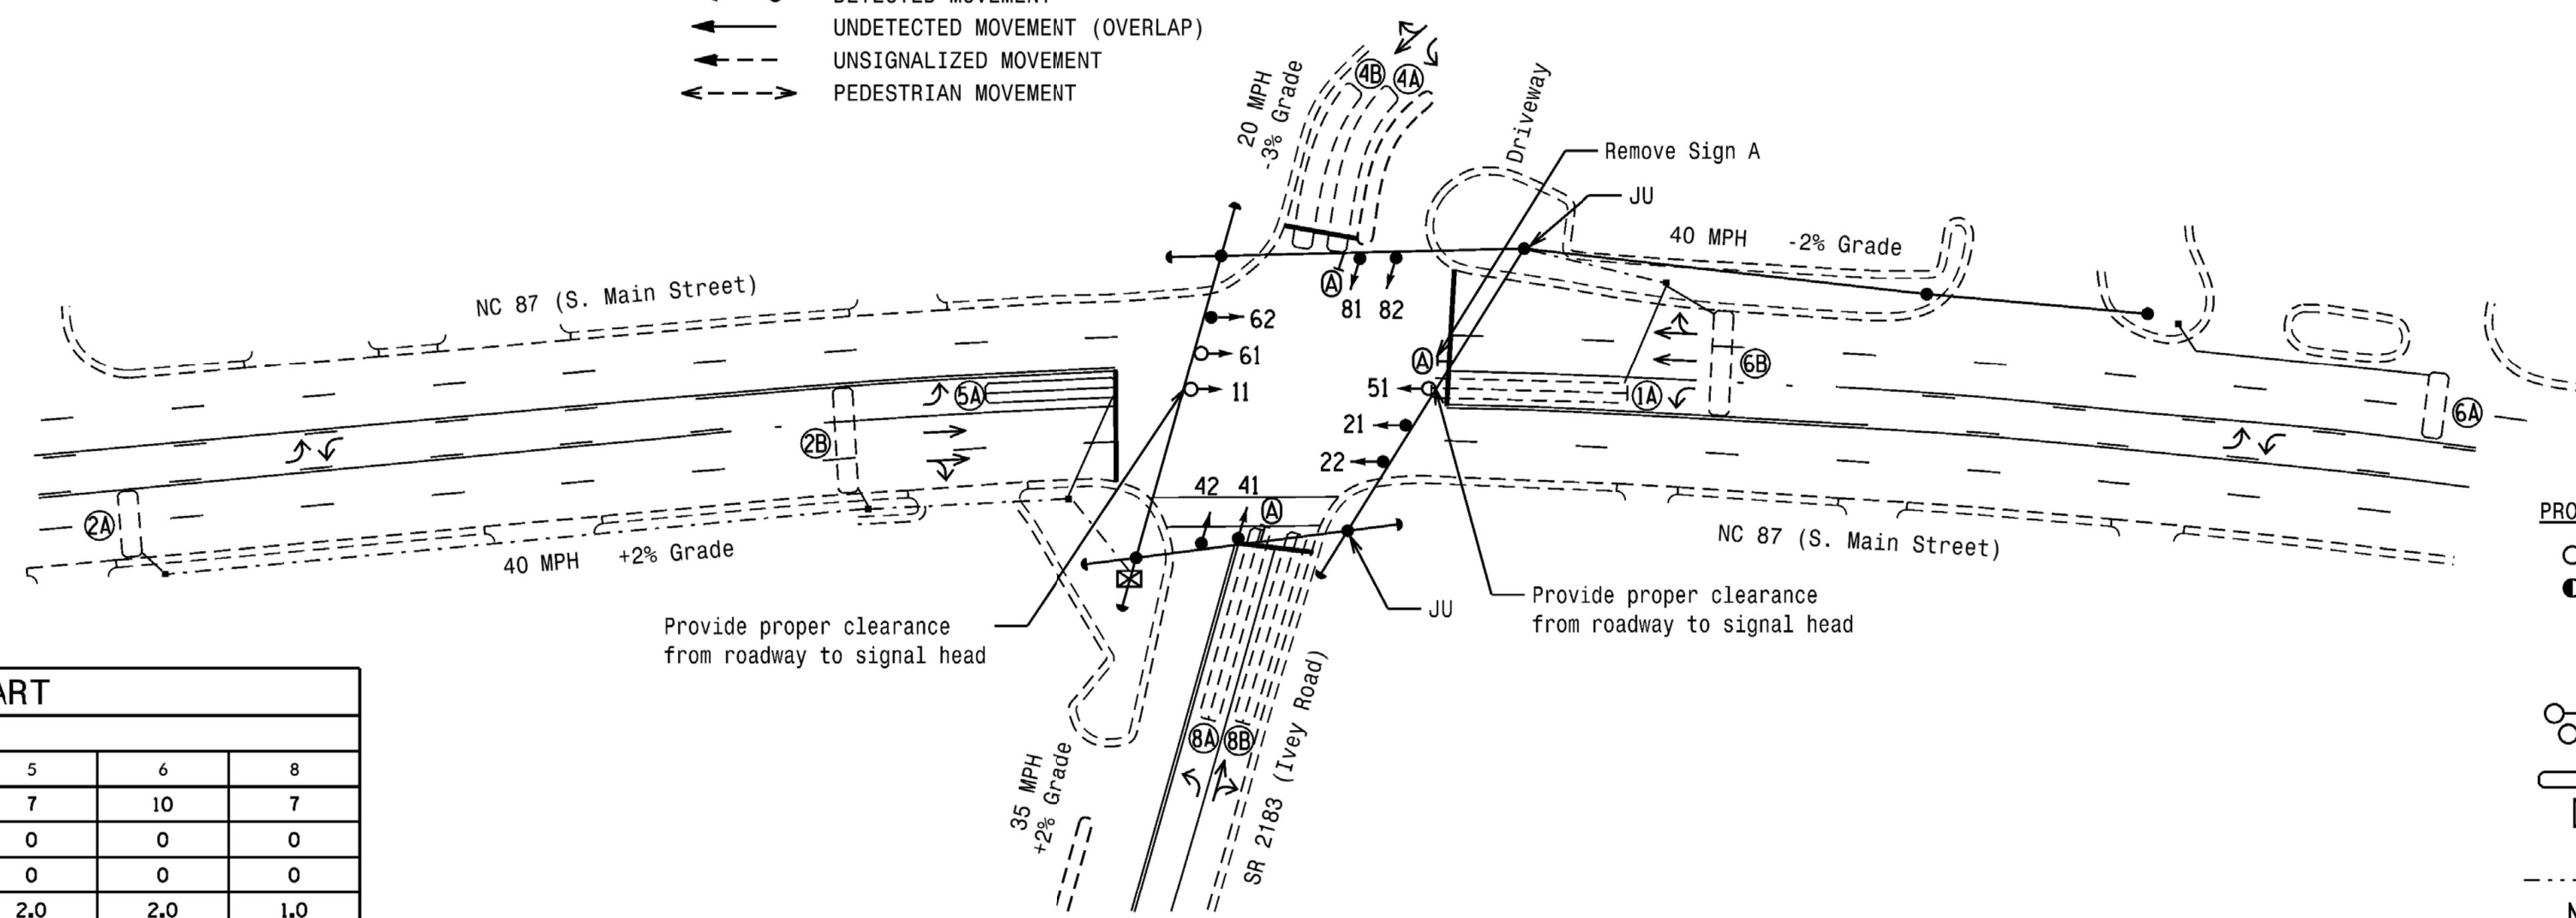

LEGEND

- | PROPOSED | EXISTING |
|----------|----------|
| | |
| | |
ASC/3 TIMING CHART

FEATURE	PHASE					
	1	2	4	5	6	8
Min Green *	7	10	7	7	10	7
Walk *	0	0	0	0	0	0
Ped Clear	0	0	0	0	0	0
Veh. Extension *	1.0	2.0	1.0	2.0	2.0	1.0
Max 1 *	15	45	30	15	45	30
Yellow	3.0	4.3	3.0	3.0	4.3	3.7
Red Clear	2.6	1.8	3.1	2.8	1.8	1.7
Actuations B4 Add *	-	-	-	-	-	-
Seconds /Actuation *	-	-	-	-	-	-
Max Initial *	-	-	-	-	-	-
Time Before Reduction *	-	-	-	-	-	-
Time To Reduce *	-	-	-	-	-	-
Minimum Gap	-	-	-	-	-	-
Locking Detector	-	X	-	-	X	-
Recall Position	-	VEH. RECALL	-	-	VEH. RECALL	-
Dual Entry	-	-	X	-	-	X
Simultaneous Gap	X	X	X	X	X	X

* These values may be field adjusted. Do not adjust Min Green and Extension times for phases 2 and 6 lower than what is shown. Min Green for all other phases should not be lower than 4 seconds.



12 BROAD STREET
 ASHEVILLE, NORTH CAROLINA 28801
 (828) 254-2201
 FAX (828) 254-4562
 NC LIC. NO. C-1154

Signal Upgrade

Prepared for the Offices of:
 TRANSPORTATION MOBILITY AND SAFETY DIVISION
 NORTH CAROLINA DEPARTMENT OF TRANSPORTATION
 Signal Design Section
 750 N. Greenfield Pkwy, Garner, NC 27529
 SCALE 0 40
 1"=40'

DOCUMENT NOT CONSIDERED FINAL UNLESS ALL SIGNATURES COMPLETED

NC 87 (S. Main Street) at SR 2183 (Ivey Road)

Division 7 Alamance County Graham

PLAN DATE: March 2018 REVIEWED BY: JB Voso

PREPARED BY: SE Greene REVIEWED BY:

REVISIONS

INIT. DATE

SEAL NORTH CAROLINA PROFESSIONAL ENGINEER SEAL 022599 JAMES B. VOSO

James Voso 6/13/2018


SIGNATURE DATE

SIG. INVENTORY NO. 07-1310

EDI MODEL 2018ECLIP-NC CONFLICT MONITOR PROGRAMMING DETAIL

(remove jumpers and set switches as shown)

REMOVE DIODE JUMPERS 1-5, 1-6, 1-9, 1-11, 2-5, 2-6, 2-9, 2-11, 4-8, 5-9, 5-11, 6-9, 6-11, and 9-11.

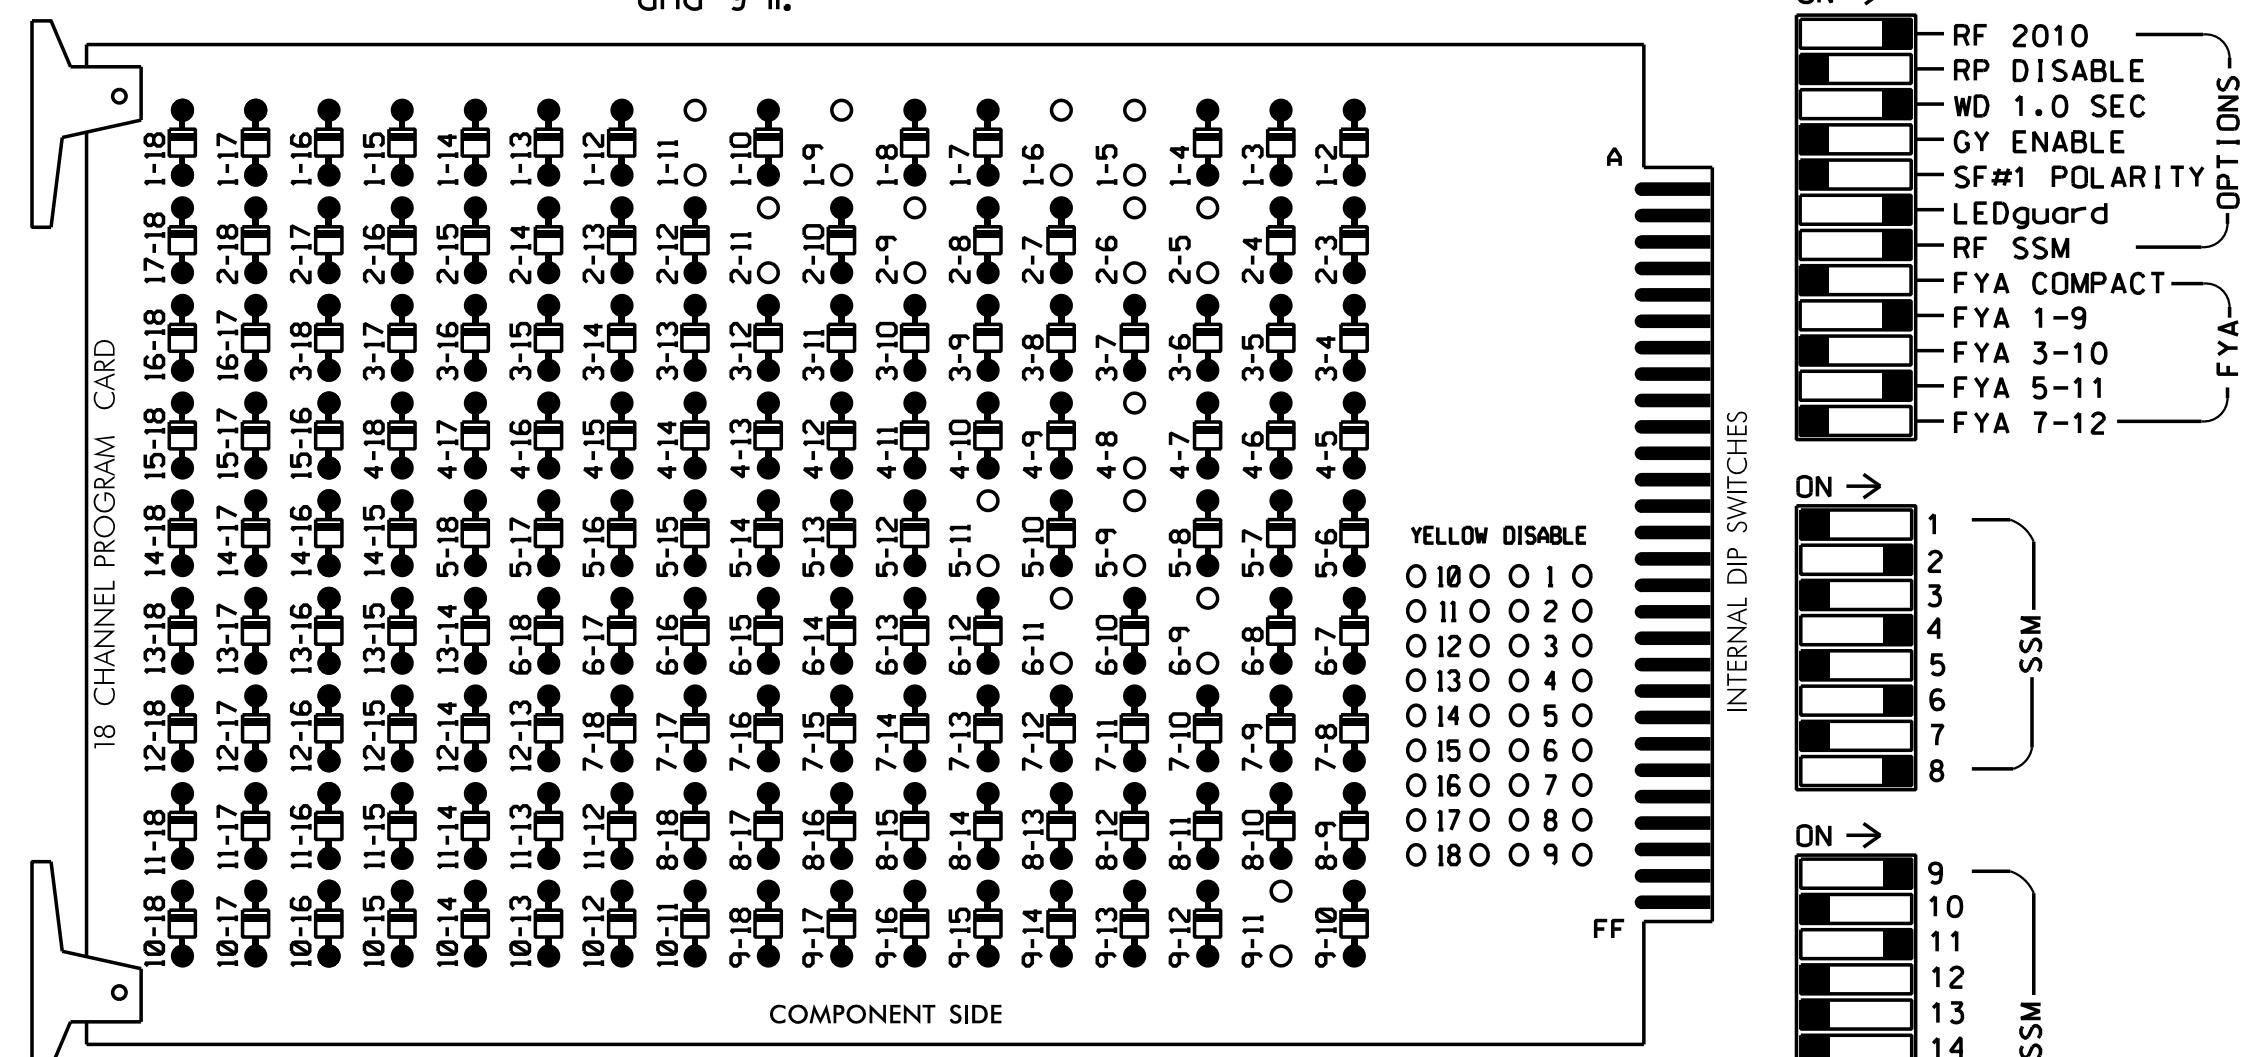

REMOVE JUMPERS AS SHOWN

- NOTES:
- Card is provided with all diode jumpers in place. Removal of any jumper allows its channels to run concurrently.
 - Ensure jumpers SEL2-SEL5 and SEL9 are present on the monitor board.
 - Ensure that Red Enable is active at all times during normal operation.
 - Integrate monitor with Ethernet network in cabinet.

NOTES

- To prevent "flash-conflict" problems, insert red flash program blocks for all unused vehicle load switches in the output file. The installer shall verify that signal heads flash in accordance with the Signal Plans.
- Program phases 4 and 8 for Dual Entry.
- Program controller to start up in phase 2 Green and 6 Green.
- The cabinet and controller are part of the Burlington-Graham Signal System.

EQUIPMENT INFORMATION

CONTROLLER.....2070LX
 CABINET.....332 W/AUX
 SOFTWARE.....ECONOLITE ASC/3-2070
 CABINET MOUNT.....BASE
 OUTPUT FILE POSITIONS...18 WITH AUX. OUTPUT FILE
 LOAD SWITCHES USED.....S1,S2,S5,S7,S8,S11,AUX S1
 AUX S4
 PHASES USED.....1,2,4,5,6,8
 OVERLAP "A".....*
 OVERLAP "B".....NOT USED
 OVERLAP "C".....*
 OVERLAP "D".....NOT USED

* See overlap programming detail on sheet 2


SIGNAL HEAD HOOK-UP CHART

LOAD SWITCH NO.	S1	S2	S3	S4	S5	S6	S7	S8	S9	S10	S11	S12	AUX S1	AUX S2	AUX S3	AUX S4	AUX S5	AUX S6
CMU CHANNEL NO.	1	2	13	3	4	14	5	6	15	7	8	16	9	10	17	11	12	18
PHASE	1	2	2 PED	3	4	4 PED	5	6	6 PED	7	8	8 PED	OLA	OLB	SPARE	OLC	OLD	SPARE
SIGNAL HEAD NO.	11	21,22	NU	NU	41,42	NU	51	61,62	NU	NU	81,82	NU	11	NU	NU	51	NU	NU
RED		128			101			134			107							
YELLOW	*	129			102		*	135			108							
GREEN		130			103			136			109							
RED ARROW													A121				A114	
YELLOW ARROW													A122				A115	
FLASHING YELLOW ARROW													A123				A116	
GREEN ARROW	127							133										

NU = Not Used
 * Denotes install load resistor. See load resistor installation detail this sheet.
 ★ See pictorial of head wiring in detail this sheet.

INPUT FILE POSITION LAYOUT

(front view)

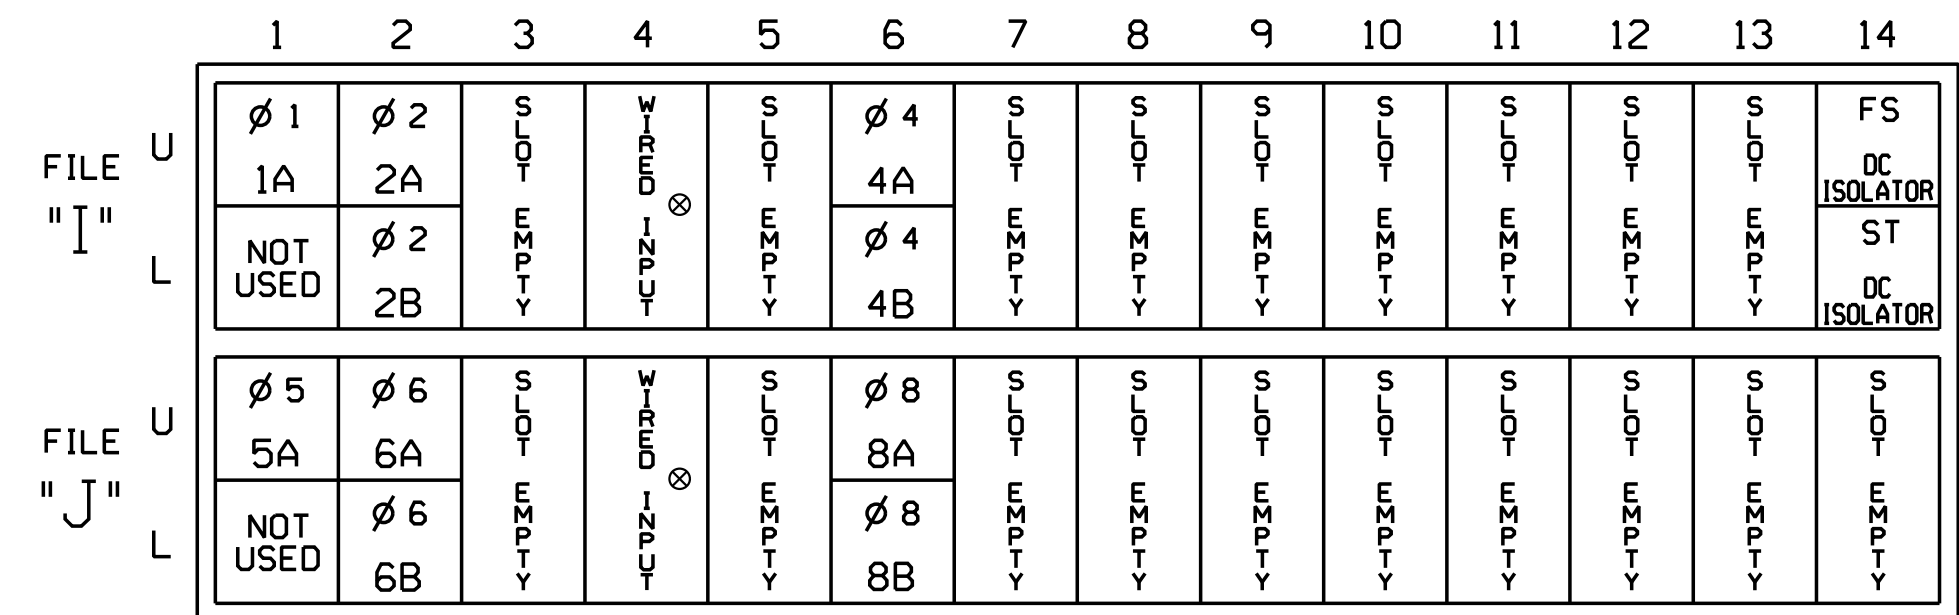

EX.: 1A, 2A, ETC. = LOOP NO.'S
 FS = FLASH SENSE
 ST = STOP TIME


⊗ Wired Input - Do not populate slot with detector card

INPUT FILE CONNECTION & PROGRAMMING CHART

LOOP NO.	LOOP TERMINAL	INPUT FILE POS.	PIN NO.	DETECTOR NO.	NEMA PHASE	CALL	EXTEND TIME	DELAY TIME	ADDED INITIAL	DETECTOR TYPE
1A ¹	TB2-1,2	I1U	56	1	1	YES		15		S
	-	J4U	48	26	6	YES				S
2A	TB2-5,6	I2U	39	2	2	YES	1.7			S
2B	TB2-7,8	I2L	43	12	2	YES				S
4A	TB4-9,10	I6U	41	4	4	YES		3		S
4B	TB4-11,12	I6L	45	14	4	YES		10		S
5A ²	TB3-1,2	J1U	55	5 ★	5	YES		15		S
	-	I4U	47	22 ★	2	YES				S
6A	TB3-5,6	J2U	40	6	6	YES	1.7			S
6B	TB3-7,8	J2L	44	16	6	YES				S
8A	TB5-9,10	J6U	42	8	8	YES		3		S
8B	TB5-11,12	J6L	46	18	8	YES		10		S

- Add jumper from I1-W to J4-W, on rear of input file.
 - Add jumper from J1-W to I4-W, on rear of input file.
- ★ For the detectors to work as shown on the signal design plan, see the Vehicle Detector Setup Programming Detail for Alternate Phasing on sheet 3.


INPUT FILE POSITION LEGEND: J2L

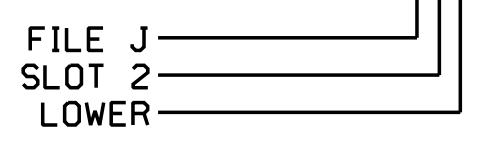

LOAD RESISTOR INSTALLATION DETAIL


(install resistors as shown)

VALUE (ohms)	WATTAGE
1.5K - 1.9K	25W (min)
2.0K - 3.0K	10W (min)

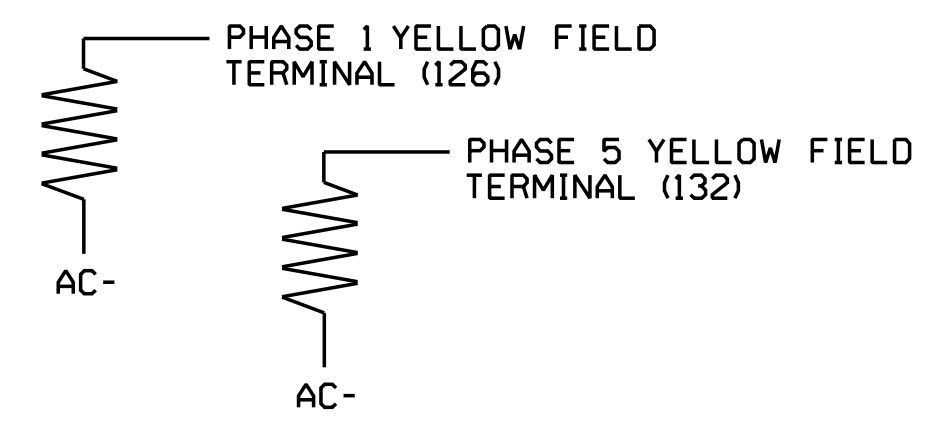

FYA SIGNAL WIRING DETAIL

(wire signal heads as shown)

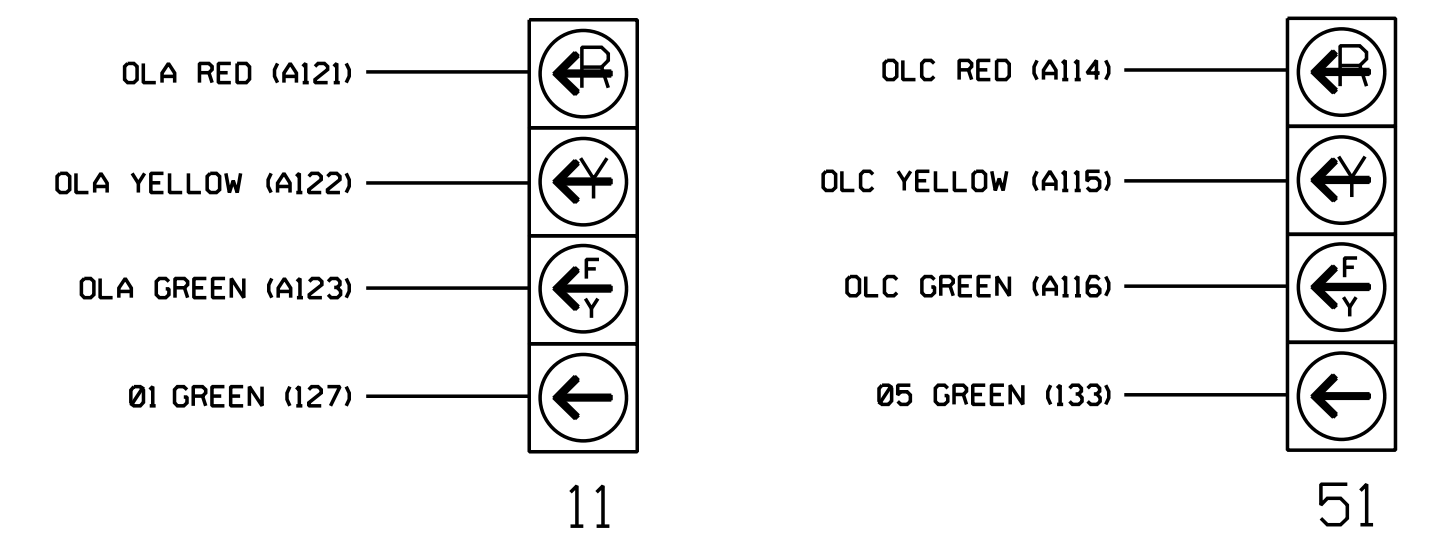

THIS ELECTRICAL DETAIL IS FOR THE SIGNAL DESIGN: 07-1310
 DESIGNED: March 2018
 SEALED: 6/13/2018
 REVISED: NA

Electrical Detail - Sheet 1 of 4

Mattern & Craig
 ENGINEERS • SURVEYORS
 12 BROAD STREET
 ASHEVILLE, NORTH CAROLINA 28801
 (828) 254-2201
 FAX (828) 254-4562
 NC LIC. NO. C-1154

ELECTRICAL AND PROGRAMMING DETAILS FOR:
 Prepared for the Offices of:

 750 N. Greenfield Pkwy, Corner, NC 27529

NC 87 (S. Main Street) at SR 2183 (Ivey Road)

Division 7	Alamance County	Graham
PLAN DATE: March 2018	REVIEWED BY: JB Voso	
PREPARED BY: SE Greene	REVIEWED BY:	
REVISIONS	INIT.	DATE

DOCUMENT NOT CONSIDERED FINAL UNLESS ALL SIGNATURES COMPLETED

SEAL

 James Voso
 6/13/2018
 DATE
 SIG. INVENTORY NO. 07-1310

11:06:28 AM 11/13/18 - Burlington-Graham Signal System06 Working Folders (Replace Sub-folders with NCDOT File Structure if Working on NCDOT Project)dwg or DgnW07-1310W071310_sm.ele-20131106.dgn

ECONOLITE ASC/3-2070 OVERLAP PROGRAMMING DETAIL

(program controller as shown)

1. From Main Menu select 2. CONTROLLER
2. From CONTROLLER Submenu select 2. VEHICLE OVERLAPS

OVERLAP A

Select TMG VEH OVLP [A] and 'PPLT FYA'

TMG VEH OVLP...[A] TYPE:PPLT FYA

PROTECTED LEFT TURN.... PHASE 1

OPPOSING THROUGH..... PHASE 2

FLASHING ARROW OUTPUT.....CH9 ISOLATE

DELAY START OF: FYA..0.0 CLEARANCE..0.0

ACTION PLAN SF BIT DISABLE..... 0

Toggle Twice

OVERLAP C

Select TMG VEH OVLP [C] and 'PPLT FYA'

TMG VEH OVLP...[C] TYPE:PPLT FYA

PROTECTED LEFT TURN.... PHASE 5

OPPOSING THROUGH..... PHASE 6

FLASHING ARROW OUTPUT.....CH11 ISOLATE

DELAY START OF: FYA..0.0 CLEARANCE..0.0


ACTION PLAN SF BIT DISABLE..... 5

← NOTICE ACTION PLAN SF BIT "5"

END PROGRAMMING

THIS ELECTRICAL DETAIL IS FOR
 THE SIGNAL DESIGN: 07-1310
 DESIGNED: March 2018
 SEALED: 6/13/2018
 REVISED: NA



11:07:10 AM
 I:\Projects\1310\Signal Systems\06 Working Folders with NCDOT File Structure if Working on NCDOT Project\DWG or Dgn\07-1310\071310-sm.ele_20131106.dgn
 jlkun

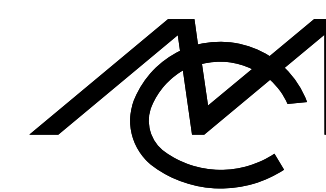

Mattern & Craig
 ENGINEERS • SURVEYORS

12 BROAD STREET
 ASHEVILLE, NORTH CAROLINA 28801
 (828) 254-2201
 FAX (828) 254-4562
 NC LIC. NO. C-1154

Electrical Detail - Sheet 2 of 4
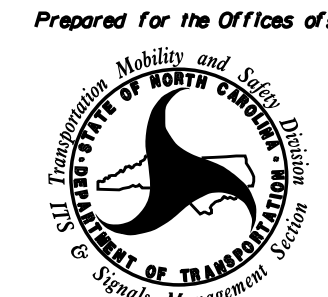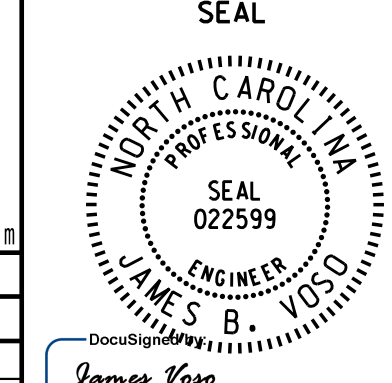
<p><small>ELECTRICAL AND PROGRAMMING DETAILS FOR:</small></p> <p style="text-align: center;">NC 87 (S. Main Street) at SR 2183 (Ivey Road)</p> <p><small>Prepared for the Offices of:</small></p>  <p><small>750 N. Greenfield Pkwy, Corner, NC 27529</small></p>	<p>Division 7 Alamance County Graham</p> <table border="1" style="width: 100%; border-collapse: collapse;"> <tr> <td>PLAN DATE: March 2018</td> <td>REVIEWED BY: JB Voso</td> </tr> <tr> <td>PREPARED BY: SE Greene</td> <td>REVIEWED BY:</td> </tr> </table> <table border="1" style="width: 100%; border-collapse: collapse;"> <thead> <tr> <th>REVISIONS</th> <th>INIT.</th> <th>DATE</th> </tr> </thead> <tbody> <tr> <td> </td> <td> </td> <td> </td> </tr> <tr> <td> </td> <td> </td> <td> </td> </tr> </tbody> </table>	PLAN DATE: March 2018	REVIEWED BY: JB Voso	PREPARED BY: SE Greene	REVIEWED BY:	REVISIONS	INIT.	DATE							<p style="text-align: center;"><small>DOCUMENT NOT CONSIDERED FINAL UNLESS ALL SIGNATURES COMPLETED</small></p> <p style="text-align: center;">SEAL</p>  <p style="text-align: center;"><small>DocuSign</small></p> <p style="text-align: center;">James Voso 6/13/2018</p> <p style="text-align: center;"><small>DATE</small></p> <p style="text-align: center;">SIG. INVENTORY NO. 07-1310</p>
PLAN DATE: March 2018	REVIEWED BY: JB Voso														
PREPARED BY: SE Greene	REVIEWED BY:														
REVISIONS	INIT.	DATE													

ECONOLITE ASC/3-2070 VEHICLE DETECTOR SETUP PROGRAMMING DETAIL FOR ALTERNATE PHASING

LOOP 5A

(program controller as shown)

IMPORTANT!

Program detectors per the input file connection and programming chart shown on sheet 1 before proceeding.

1. From Main Menu select **8. UTILITIES**
2. From UTILITIES Submenu select **1. COPY/CLEAR**
3. Copy from DETECTOR PLAN "1" to DETECTOR PLAN "2".

```

COPY / CLEAR UTILITY
FROM          TO
PHASE TIMING... > PHASE TIMING...
TIMING PLAN... > TIMING PLAN...
PH DET OPT PLAN. > PH DET OPT PLAN.
DETECTOR PLAN... 1 > DETECTOR PLAN... 2
TOGGLE TO SELECT A "FROM" AND A "TO"
THEN PRESS ENTER
    
```

4. From Main Menu select **6. DETECTORS**
 5. From DETECTOR Submenu select **2. VEHICLE DETECTOR SETUP**
 6. Place cursor in VEH DET PLAN [] position and enter "2".
- Place cursor in VEH DETECTOR [] position and enter "5".
 - Set delay time to "0".

```

VEH DETECTOR [ 5]  VEH DET PLAN [ 2]
TYPE: S-STANDARD
TS2 DETECTOR..... ECPI LOG..... NO
DET PH - 1 2 3 4 5 6 7 8 9 0 1 2 3 4 5 6
5 5
EXTEND TIME... 0.0 DELAY TIME... 0.0
USE ADDED INITIAL . CROSS SWITCH PH.. 0
LOCK IN..... NONE NTCIP VOL . OR OCC .
PMT QUEUE DELAY. NO
    
```

← NOTICE VEH DET PLAN 2

← ENSURE DELAY IS SET TO '0'

- Place cursor in VEH DETECTOR [] position and enter "22".
 - Set assigned phase to "0".

```

VEH DETECTOR [22]  VEH DET PLAN [ 2]
TYPE: S-STANDARD
TS2 DETECTOR..... ECPI LOG..... NO
DET PH - 1 2 3 4 5 6 7 8 9 0 1 2 3 4 5 6
22 0
EXTEND TIME... 0.0 DELAY TIME... 0.0
USE ADDED INITIAL . CROSS SWITCH PH.. 0
LOCK IN..... NONE NTCIP VOL . OR OCC .
PMT QUEUE DELAY. NO
    
```

← NOTICE VEH DET PLAN 2

ENSURE PHASE IS SET TO "0" →

END PROGRAMMING

THIS ELECTRICAL DETAIL IS FOR
 THE SIGNAL DESIGN: 07-1310
 DESIGNED: March 2018
 SEALED: 6/13/2018
 REVISED: NA



11:07:48 AM
 I:\31789 - Burlington Graham Signal System\06 Working Folders with NCDOT File Structure if Working on NCDOT Project\Wkg or Dgn\07-1310\071310_sm.ele_20131106.dgn
 jlkun



Mattern & Craig
 ENGINEERS • SURVEYORS

12 BROAD STREET
 ASHEVILLE, NORTH CAROLINA 28801
 (828) 254-2201
 FAX (828) 254-4562
 NC LIC. NO. C-1154

Electrical Detail - Sheet 3 of 4

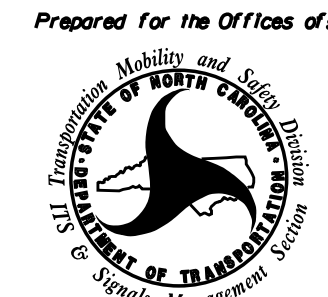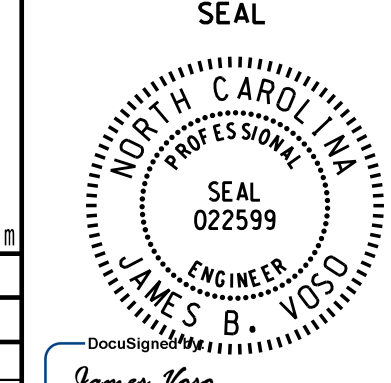ELECTRICAL AND PROGRAMMING DETAILS FOR: Prepared for the Offices of:  750 N. Greenfield Pkwy, Corner, NC 27529	NC 87 (S. Main Street) at SR 2183 (Ivey Road)	DOCUMENT NOT CONSIDERED FINAL UNLESS ALL SIGNATURES COMPLETED
Division 7 Alamance County Graham		
PLAN DATE: March 2018 REVIEWED BY: JB Voso		SEAL  SEAL 022599 JAMES B. VOSO ENGINEER 6/13/2018
PREPARED BY: SE Greene REVIEWED BY:		
REVISIONS		DATE
REVISIONS INIT. DATE		DATE
		DATE
SIG. INVENTORY NO. 07-1310		

ECONOLITE ASC/3-2070 ACTION PLAN PROGRAMMING DETAIL

ALTERNATE PHASING ACTIVATION DETAIL

TO RUN ALT. PHASING DURING FREE RUN - PROGRAM CHANGES (SHOWN BELOW) IN A TIME BASED ACTION PLAN. SCHEDULE A DAY PLAN THAT INCLUDES THE ACTION PLAN PROGRAMMED TO SELECT VEH DET PLAN 2 AND ENABLE SF BIT 5.

TO RUN ALT. PHASING DURING COORDINATION - SELECT THE TIME BASED ACTION PLAN THAT IS PROGRAMMED TO SELECT VEH DET PLAN 2 AND ENABLE SF BIT 5.

PHASING	VEH DET PLAN	SF BITS ENABLED
ACTIONS REQUIRED TO RUN <u>DEFAULT PHASING</u>	1	NONE
ACTIONS REQUIRED TO RUN <u>ALTERNATE PHASING</u>	2	5

IMPORTANT: IF ALT. PHASING IS USED DURING FREE RUN AND COORDINATION, DO NOT OPERATE TIME OF DAY EVENTS CONCURRENTLY WITH COORDINATION PLAN EVENTS IN THE EVENT SCHEDULER. (EX. FREE RUN EVENT SHOULD END BEFORE COORDINATION PLAN EVENT STARTS AND VICE-VERSA).

ALTERNATE PHASING CHANGE SUMMARY

THE FOLLOWING IS A SUMMARY OF WHAT TAKES PLACE WHEN SF BIT 5 AND VEH DET PLAN 2 ACTIVATE TO CALL THE "ALTERNATE PHASING":


SF BIT 5: Modifies overlap parent phases for head 51 to run protected turns only.

VEH DET PLAN 2: Disables phase 2 call on loop 5A and reduces delay time for phase 5 call on loop 5A to 0 seconds.

1. From Main Menu select 5. TIME BASE
2. From TIME BASE Submenu select 2. ACTION PLAN

```

ACTION PLAN...[ 1]
PATTERN.....AUTO   SYS OVERRIDE.... NO
TIMING PLAN..... 0   SEQUENCE..... 0
VEH DETECTOR PLAN.. 2   DET LOG.....NONE
FLASH..... --   RED REST..... NO
VEH DET DIAG PLN... 0   PED DET DIAG PLN..0
DIMMING ENABLE.. NO   PRIORITY RETURN. NO
PED PR RETURN.. NO   QUEUE DELAY..... NO
PMT COND DELAY   NO
  PHASE  1  2  3  4  5  6  7  8  9  0  1  2  3  4  5  6
PED RCL  .  .  .  .  .  .  .  .  .  .  .  .  .  .  .  .
WALK 2   .  .  .  .  .  .  .  .  .  .  .  .  .  .  .  .
VEX 2    .  .  .  .  .  .  .  .  .  .  .  .  .  .  .  .
VEH RCL  .  .  .  .  .  .  .  .  .  .  .  .  .  .  .  .
MAX RCL  .  .  .  .  .  .  .  .  .  .  .  .  .  .  .  .
MAX 2    .  .  .  .  .  .  .  .  .  .  .  .  .  .  .  .
  PHASE  1  2  3  4  5  6  7  8  9  0  1  2  3  4  5  6
MAX 3    .  .  .  .  .  .  .  .  .  .  .  .  .  .  .  .
CS INH   .  .  .  .  .  .  .  .  .  .  .  .  .  .  .  .
OMIT     .  .  .  .  .  .  .  .  .  .  .  .  .  .  .  .
SPC FCT  .  .  .  .  X  .  .  .  .  .  .  .  .  .  .  .
AUX FCT  .  .  .  .  (1-3)
  1  2  3  4  5  6  7  8  9  0  1  2  3  4  5
LP 1-15  .  .  .  .  .  .  .  .  .  .  .  .  .  .  .  .
LP 16-30 .  .  .  .  .  .  .  .  .  .  .  .  .  .  .  .
LP 31-45 .  .  .  .  .  .  .  .  .  .  .  .  .  .  .  .
LP 46-60 .  .  .  .  .  .  .  .  .  .  .  .  .  .  .  .
LP 61-75 .  .  .  .  .  .  .  .  .  .  .  .  .  .  .  .
LP 76-90 .  .  .  .  .  .  .  .  .  .  .  .  .  .  .  .
LP 91-100 .  .  .  .  .  .  .  .  .  .  .  .  .  .  .  .
  
```


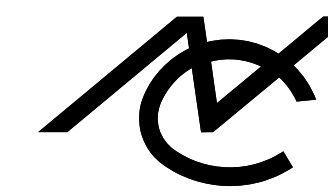


Mattern & Craig
ENGINEERS • SURVEYORS

12 BROAD STREET
ASHEVILLE, NORTH CAROLINA 28801
(828) 254-2201
FAX (828) 254-4562
NC LIC. NO. C-1154


THIS ELECTRICAL DETAIL IS FOR
THE SIGNAL DESIGN: 07-1310
DESIGNED: March 2018
SEALED: 6/13/2018
REVISED: NA

Electrical Detail - Sheet 4 of 4
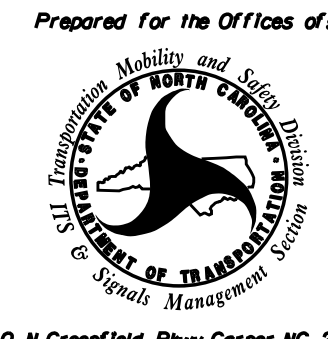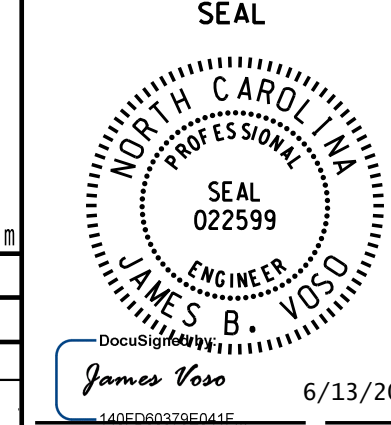
<p style="text-align: center; font-size: small;">ELECTRICAL AND PROGRAMMING DETAILS FOR:</p> <p style="text-align: center; font-size: x-small;">Prepared for the Offices of:</p>  <p style="text-align: center; font-size: x-small;">750 N. Greenfield Pkwy, Corner, NC 27529</p>	<p>NC 87 (S. Main Street) at SR 2183 (Ivey Road)</p> <p style="font-size: x-small;">Division 7 Alamance County Graham</p> <p style="font-size: x-small;">PLAN DATE: March 2018 REVIEWED BY: JB Voso</p> <p style="font-size: x-small;">PREPARED BY: SE Greene REVIEWED BY:</p> <table border="1" style="width: 100%; border-collapse: collapse; font-size: x-small;"> <thead> <tr> <th>REVISIONS</th> <th>INIT.</th> <th>DATE</th> </tr> </thead> <tbody> <tr><td> </td><td> </td><td> </td></tr> <tr><td> </td><td> </td><td> </td></tr> <tr><td> </td><td> </td><td> </td></tr> </tbody> </table>	REVISIONS	INIT.	DATE										<p style="text-align: center; font-size: x-small;">DOCUMENT NOT CONSIDERED FINAL UNLESS ALL SIGNATURES COMPLETED</p> <p style="text-align: center; font-size: x-small;">SEAL</p>  <p style="text-align: center; font-size: x-small;">James Voso 6/13/2018</p> <p style="text-align: center; font-size: x-small;">DATE</p> <p style="text-align: center; font-size: x-small;">SIG. INVENTORY NO. 07-1310</p>
REVISIONS	INIT.	DATE												

11:08:34 AM I:\3789 - Burlington Graham Signal System\06 Working Folders with NCDOT File Structure - If Working on NCDOT Project\dwg or Dgn\07-1310\071310-sm.ele-20131106.dgn


DEFAULT PHASING DIAGRAM

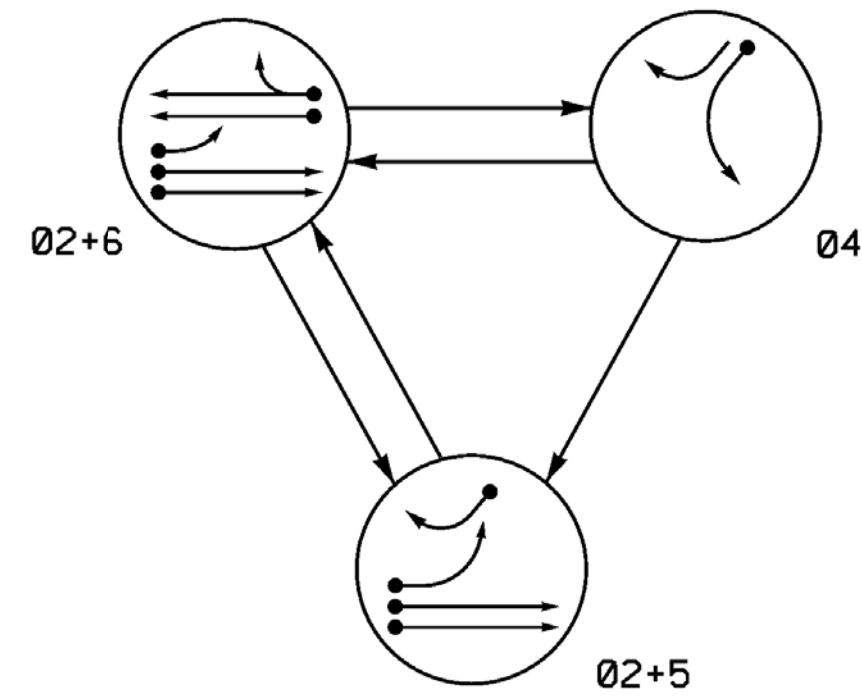

DEFAULT TABLE OF OPERATION

SIGNAL FACE	PHASE			
	02+5	02+6	04	FLASH
21, 22	G	G	R	Y
41	R	R	G	R
42	R	R	G	R
51	-	F	R	Y
61, 62	R	G	R	Y

ALTERNATE PHASING DIAGRAM

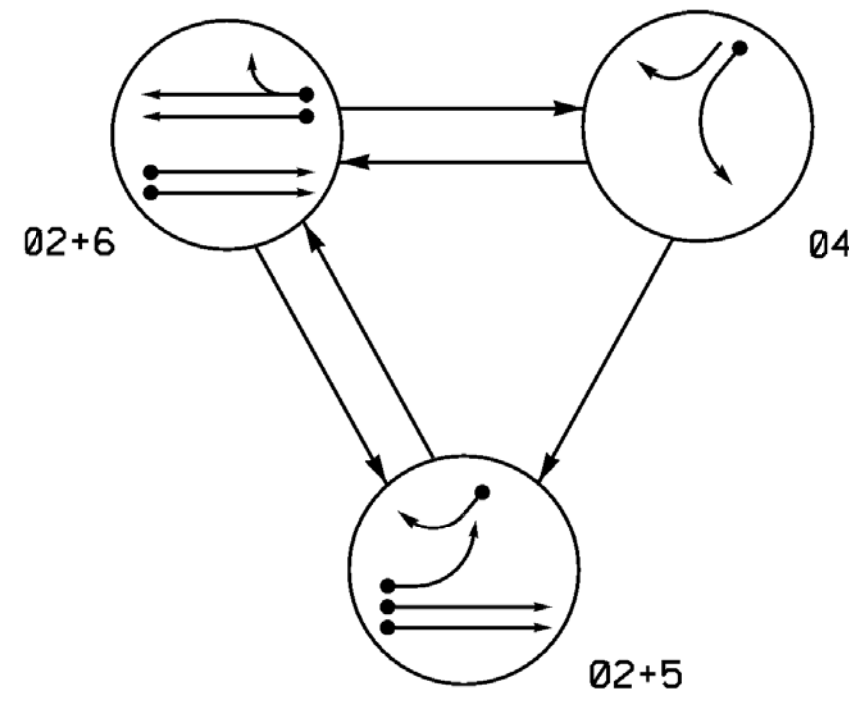

ALTERNATE TABLE OF OPERATION

SIGNAL FACE	PHASE			
	02+5	02+6	04	FLASH
21, 22	G	G	R	Y
41	R	R	G	R
42	R	R	G	R
51	-	R	R	Y
61, 62	R	G	R	Y

ASC/3 DETECTOR INSTALLATION CHART

LOOP	DETECTOR				PROGRAMMING							
	SIZE (FT)	DISTANCE FROM STOPBAR (FT)	TURNS	NEW LOOP	PHASE	CALLING	EXTEND TIME	DELAY TIME	USE ADDED INITIAL	TYPE	LOOP	NEW CARD
2A	6x6	300	EXIST	-	2	Yes	-	-	X	N	-	X
2B	6x6	300	EXIST	-	2	Yes	-	-	X	N	-	X
4A	6x60	0	2-4-2	-	4	Yes	-	3	-	S	-	X
5A	6x60	0	2-4-2	-	5	Yes	-	15*	-	S	-	X
5B	6x60	0	2-4-2	-	5	Yes	-	15	-	S	-	X
6A	6x6	300	EXIST	-	6	Yes	-	-	X	N	-	X
6B	6x6	300	EXIST	-	6	Yes	-	-	X	N	-	X


* Disable Delay During Alternate Phasing Operation.
 ** Disable Phase 2 Call for Loop 5A during Alternate Phasing Operation.

3 Phase Fully Actuated (Burlington-Graham Signal System)

NOTES



- Refer to "Roadway Standard Drawings NCDOT" dated January 2018 and "Standard Specifications for Roads and Structures" dated January 2018.
- Do not program signal for late night flashing operation unless otherwise directed by the Engineer.
- Phase 5 may be lagged.
- Reposition existing signal heads numbered 21, 22, and 41.
- Set all detector units to presence mode.
- In the event of loop replacement, refer to the current ITS and Signals Design Manual and submit a Plan of Record to the Signal Design Section.
- Locate new cabinet so as not to obstruct sight distance of vehicles turning right on red.
- Pavement markings are existing.
- The City Traffic Engineer will determine the hours of use for each phasing plan.
- Maximum times shown in timing chart are for free-run operation only. Coordinated signal system timing values supersede these values.

PHASING DIAGRAM DETECTION LEGEND

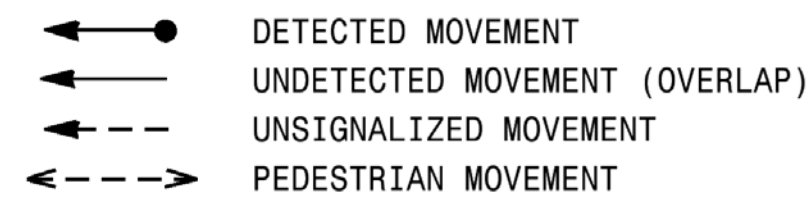

SIGNAL FACE I.D.

All Heads L.E.D.

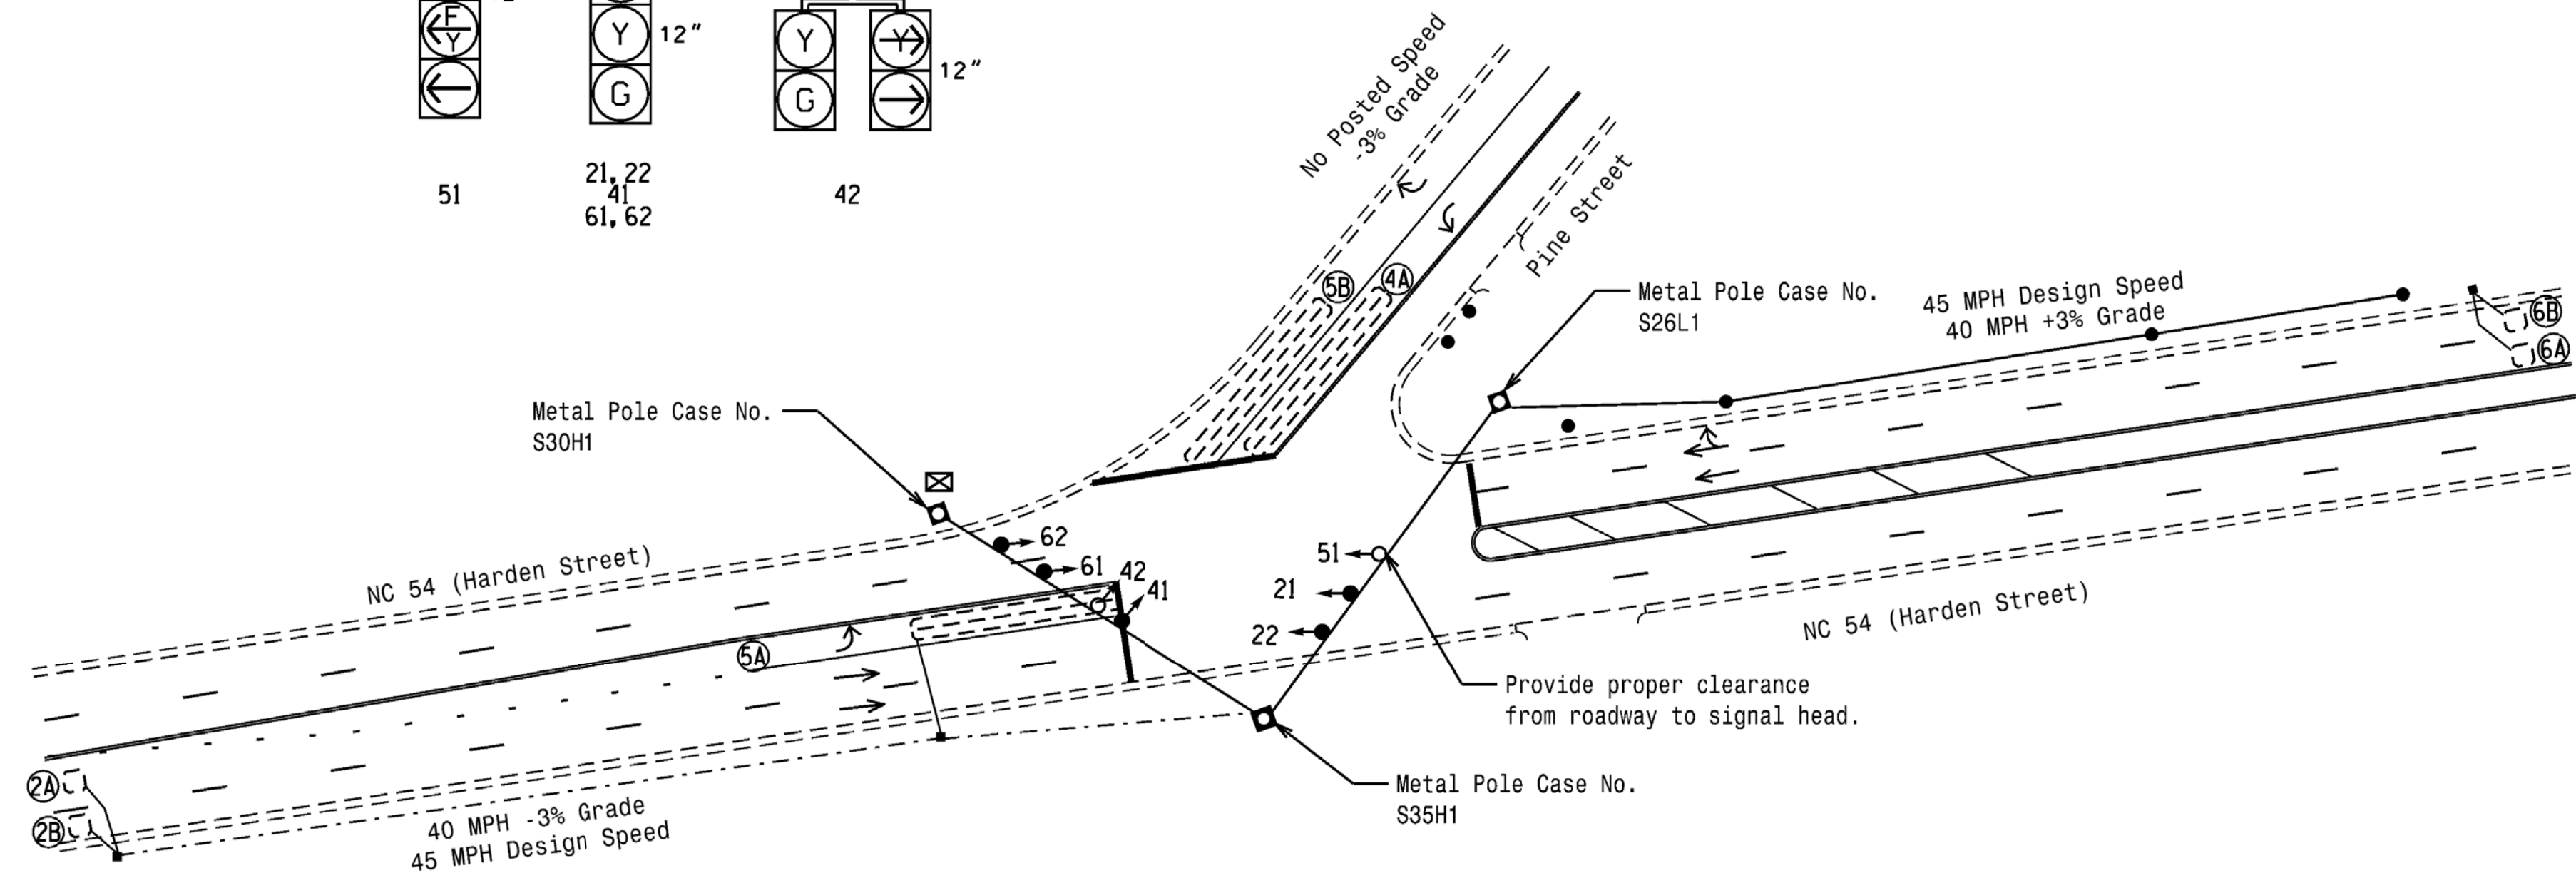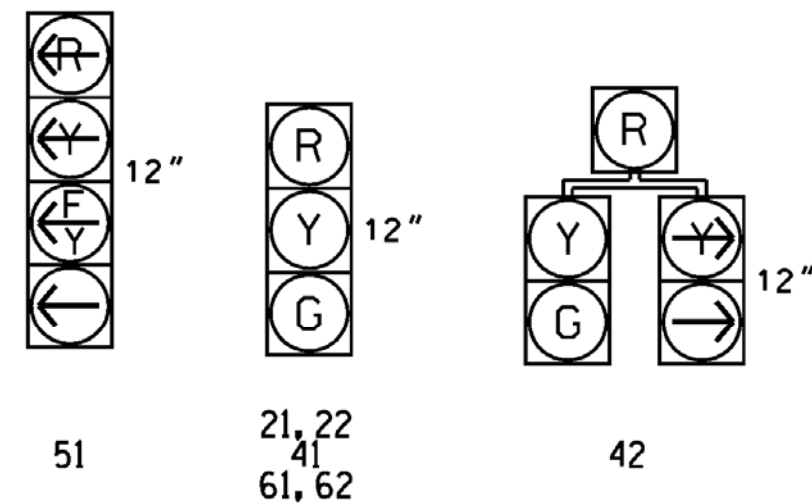


ASC/3 TIMING CHART

FEATURE	PHASE			
	2	4	5	6
Min Green *	12	7	7	12
Walk *	0	0	0	0
Ped Clear	0	0	0	0
Veh. Extension *	6.0	1.0	1.0	6.0
Max I *	60	28	15	60
Yellow	4.8	3.0	3.0	4.8
Red Clear	1.5	2.3	1.8	1.5
Actuations 34 Add *	0	-	-	0
Seconds /Actuation *	1.5	-	-	1.5
Max Initial *	34	-	-	34
Time Before Reduction *	15	-	-	15
Time To Reduce *	15	-	-	15
Minimum Gap	3.0	-	-	3.0
Locking Detector	X	-	-	X
Recall Position	VEH. RECALL	-	-	VEH. RECALL
Dual Entry	-	-	-	-
Simultaneous Gap	X	X	X	X

* These values may be field adjusted. Do not adjust Min Green and Extension times for phases 2 and 6 lower than what is shown. Min Green for all other phases should not be lower than 4 seconds.

LEGEND

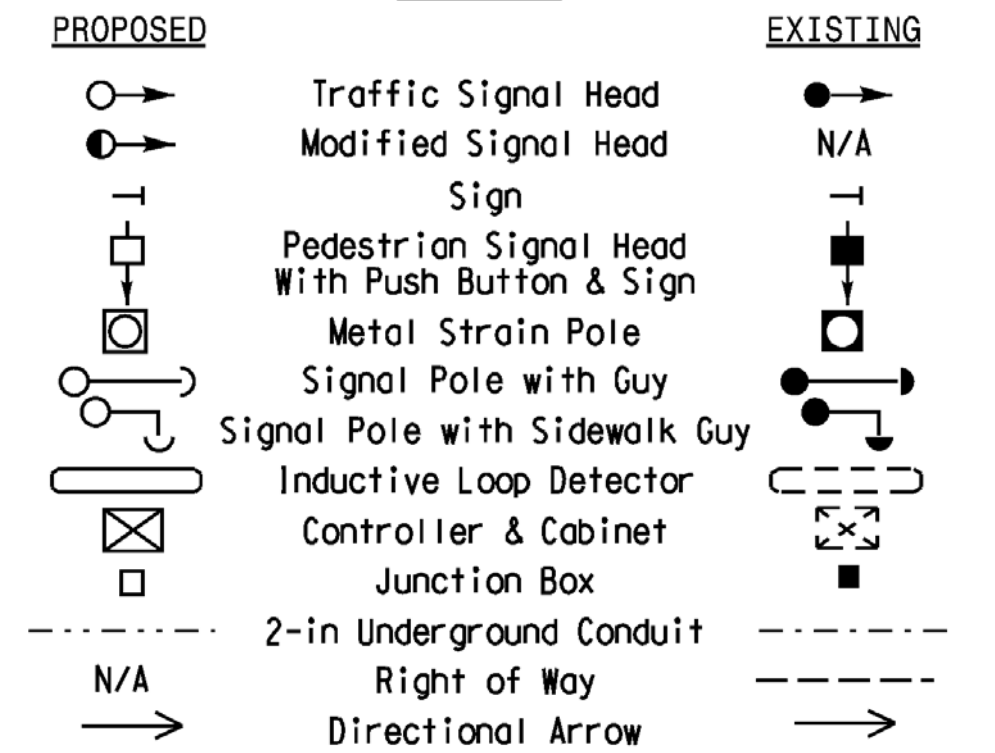

*****SYTIME*****
 *****USERNAME*****



12 BROAD STREET
 ASHEVILLE, NORTH CAROLINA 28801
 (828) 254-2201
 FAX (828) 254-4562
 NC LIC. NO. C-1154

Signal Upgrade

Prepared for the Offices of:
 TRANSPORTATION MOBILITY AND SAFETY DIVISION
 NORTH CAROLINA DEPARTMENT OF TRANSPORTATION
 Signal Design Section

NC 54 (Harden Street) at East Pine Street

Division 7 Alamance County Graham

PLAN DATE: March 2018 REVIEWED BY: JB Voso
 PREPARED BY: SE Greene REVIEWED BY:

SCALE: 0 40
 1"=40'

REVISIONS: INIT. DATE


DOCUMENT NOT CONSIDERED FINAL UNLESS ALL SIGNATURES COMPLETED

SEAL: JAMES B. VOSO, ENGINEER, SEAL 022599

6/13/2018
 DATE: 07-1364

EDI MODEL 2018ECLIP-NC CONFLICT MONITOR PROGRAMMING DETAIL

(remove jumpers and set switches as shown)

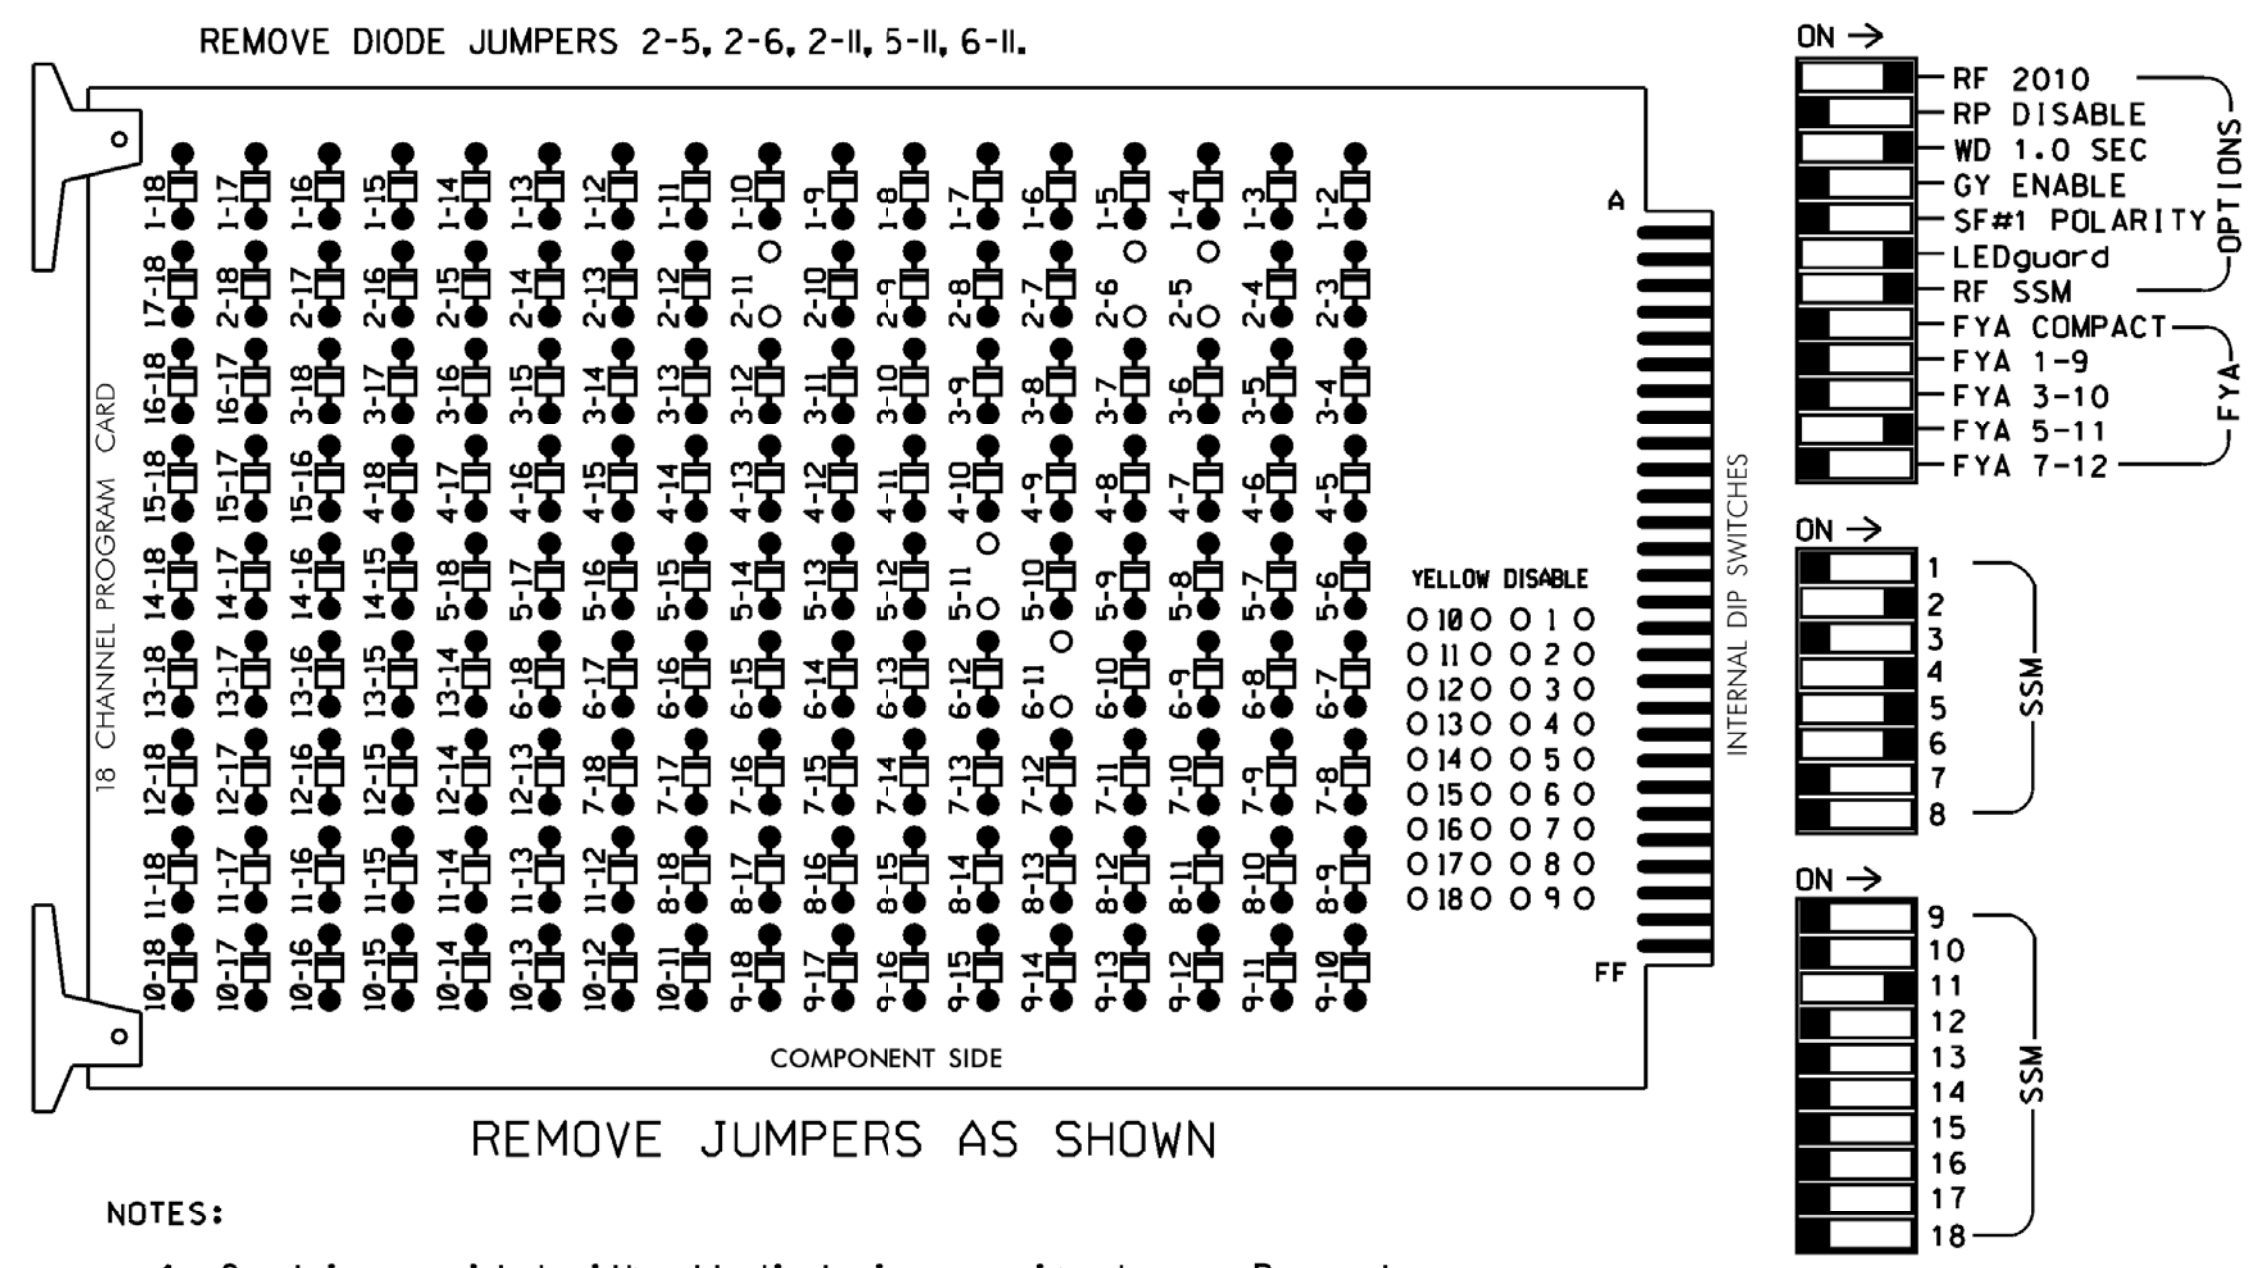

- NOTES:**
- Card is provided with all diode jumpers in place. Removal of any jumper allows its channels to run concurrently.
 - Ensure jumpers SEL2-SEL5 and SEL9 are present on the monitor board.
 - Ensure that Red Enable is active at all times during normal operation.
 - Integrate monitor with Ethernet network in cabinet.

NOTES

- To prevent "flash-conflict" problems, insert red flash program blocks for all unused vehicle load switches in the output file. The installer shall verify that signal heads flash in accordance with the Signal Plans.
- Program controller to start up in phase 2 Green and 6 Green.
- The cabinet and controller are part of the Burlington-Graham Signal System.

EQUIPMENT INFORMATION

CONTROLLER.....2070LX
 CABINET.....332 W/AUX
 SOFTWARE.....ECONOLITE ASC/3-2070
 CABINET MOUNT.....BASE
 OUTPUT FILE POSITIONS...18 WITH AUX. OUTPUT FILE
 LOAD SWITCHES USED.....S2,S5,S7,S8,AUX S4
 PHASES USED.....2,4,5,6
 OVERLAP "A".....NOT USED
 OVERLAP "B".....NOT USED
 OVERLAP "C".....*
 OVERLAP "D".....NOT USED

* See overlap programming detail on sheet 2


SIGNAL HEAD HOOK-UP CHART

LOAD SWITCH NO.	S1	S2	S3	S4	S5	S6	S7	S8	S9	S10	S11	S12	AUX S1	AUX S2	AUX S3	AUX S4	AUX S5	AUX S6
CNU CHANNEL NC.	1	2	13	3	4	14	5	6	15	7	8	16	9	10	17	11	12	18
PHASE	1	2	2 PED	3	4	4 PED	5	6	6 PED	7	8	8 PED	OLA	OLB	SPARE	OLC	OLD	SPARE
SIGNAL HEAD NO.	NU	21,22	NU	NU	41,42	NU	51*	42	61,62	NU	NU	NU	NU	NU	NU	51*	NU	NU
RED		128			101				134									
YELLOW		129			102		*		135									
GREEN		130			103				136									
RED ARROW																		A114
YELLOW ARROW									132									A115
FLASHING YELLOW ARROW																		A116
GREEN ARROW								133	133									

NU = Not Used
 * Denotes install load resistor. See load resistor installation detail this sheet.
 * See pictorial of head wiring in detail this sheet.

INPUT FILE POSITION LAYOUT

(front view)

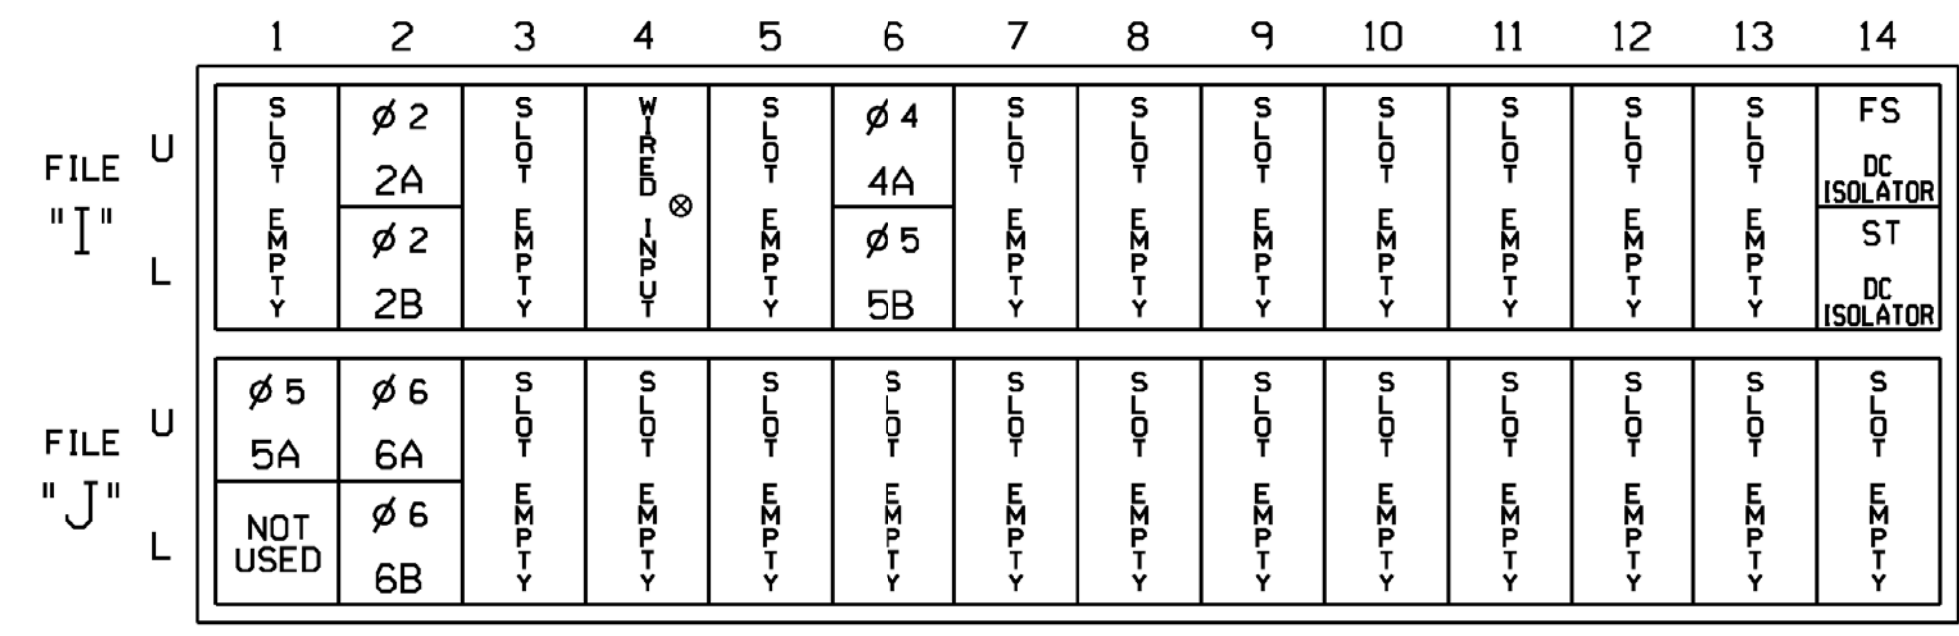


INPUT FILE CONNECTION & PROGRAMMING CHART

LOOP NO.	LOOP TERMINAL	INPUT FILE POS.	PIN NO.	DETECTOR NO.	NEMA PHASE	CALL	EXTEND TIME	DELAY TIME	ADDED INITIAL	DETECTOR TYPE
2A	TB2-5,6	J2U	39	2	2	YES			X	N
2B	TB2-7,8	J2L	43	12	2	YES			X	N
4A	TB4-9,10	J6U	41	4	4	YES		3		S
5B	TB4-11,12	J6L	45	14	4	YES		15		S
5A ¹	TB3-1,2	J1U	55	5*	5	YES		15		S
6A	TB3-5,6	J2U	40	6	6	YES		3		C
6B	TB3-7,8	J2L	44	16	6	YES			X	N


¹Add jumper from J1-W to J4-W, on rear of input file.
 * For the detectors to work as shown on the signal design plan, see the Vehicle Detector Setup Programming Detail for Alternate Phasing on sheet 3.

INPUT FILE POSITION LEGEND:

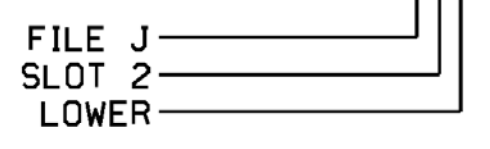

FYA SIGNAL WIRING DETAIL

(wire signal head as shown)

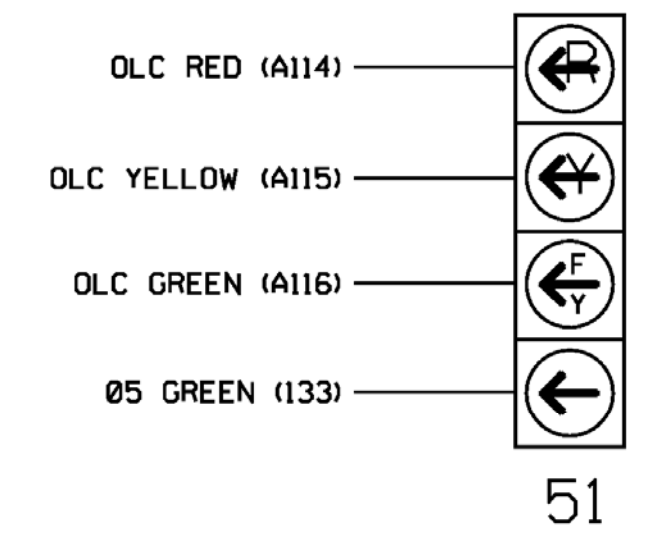


LOAD RESISTOR INSTALLATION DETAIL

(install resistor as shown)

ACCEPTABLE VALUES

VALUE (ohms)	WATTAGE
1.5K - 1.9K	25W (min)
2.0K - 3.0K	10W (min)

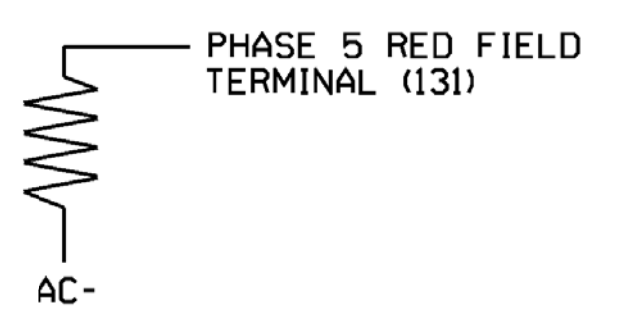

Mattern & Craig
 ENGINEERS • SURVEYORS

12 BROAD STREET
 ASHEVILLE, NORTH CAROLINA 28801
 (828) 254-2201
 FAX (828) 254-4562
 NC LIC. NO. C-1154

Electrical Detail - Sheet 1 of 4

ELECTRICAL AND PROGRAMMING DETAILS FOR:
 Prepared for the Offices of:
 CITY OF GREENSBORO, NORTH CAROLINA
 Signal Management

NC 54 (Harden Street)
 at
 East Pine Street

Division 7 Alamance County Graham

PLAN DATE: March 2018 REVIEWED BY: JB Voso
 PREPARED BY: SE Greene REVIEWED BY:

REVISIONS

NO.	INIT.	DATE

DOCUMENT NOT CONSIDERED FINAL UNLESS ALL SIGNATURES COMPLETED

SEAL
 NORTH CAROLINA PROFESSIONAL ENGINEER
 SEAL 022599
 JAMES B. VOSO
 6/13/2018
 DATE

*****SYTIME*****
 *****D*****
 *****USER*****

ECONOLITE ASC/3-2070 OVERLAP PROGRAMMING DETAIL
(program controller as shown)

1. From Main Menu select 2. CONTROLLER
2. From CONTROLLER Submenu select 2. VEHICLE OVERLAPS
 Toggle Twice

OVERLAP C

Select TMG VEH OVLP [C] and 'PPLT FYA'

```


TMG VEH OVLP...[C] TYPE: ....[PPLT FYA]
PROTECTED LEFT TURN... PHASE 5
OPPOSING THROUGH..... PHASE 6

FLASHING ARROW OUTPUT.....CH11 ISOLATE
DELAY START OF: FYA..0.0 CLEARANCE..0.0
ACTION PLAN SF BIT DISABLE..... 5
END PROGRAMMING
    
```

← NOTICE ACTION
PLAN SF BIT "5"



THIS ELECTRICAL DETAIL IS FOR
 THE SIGNAL DESIGN: 07-1364
 DESIGNED: March 2018
 SEALED: 6/13/2018
 REVISED: NA

\$\$\$\$\$SYTIME\$\$\$\$\$
 \$\$\$SYTIME\$\$\$\$\$
 \$\$\$SYTIME\$\$\$\$\$
 \$\$\$SYTIME\$\$\$\$\$

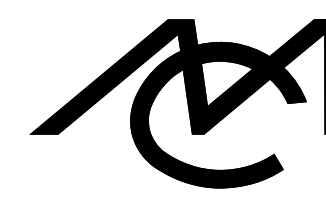

Mattern & Craig
 ENGINEERS • SURVEYORS
 12 BROAD STREET
 ASHEVILLE, NORTH CAROLINA 28801
 (828) 254-2201
 FAX (828) 254-4562
 NC LIC. NO. C-1154

Electrical Detail - Sheet 2 of 4

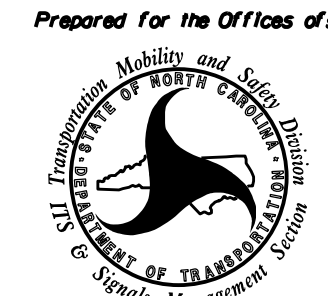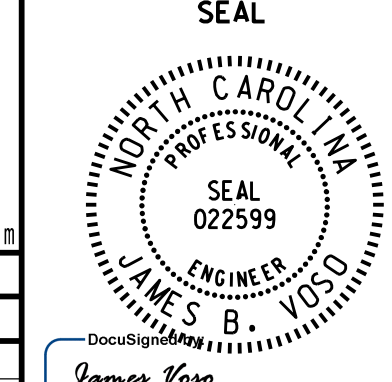ELECTRICAL AND PROGRAMMING DETAILS FOR: Prepared for the Offices of:  750 N. Greenfield Hwy, Corner, NC 27529	NC 54 (Harden Street) at East Pine Street		SEAL  SEAL 022599 ENGINEER JAMES B. VOSO
	Division 7 Alamance County Graham	PLAN DATE: March 2018 REVIEWED BY: JB Voso	PREPARED BY: SE Greene REVIEWED BY:
REVISIONS INIT. DATE	_____		SIG. INVENTORY NO. 07-1364

DOCUMENT NOT CONSIDERED
 FINAL UNLESS ALL
 SIGNATURES COMPLETED

ECONOLITE ASC/3-2070 VEHICLE DETECTOR SETUP PROGRAMMING DETAIL FOR ALTERNATE PHASING

LOOP 5A

(program controller as shown)

IMPORTANT!

Program detectors per the input file connection and programming chart shown on sheet 1 before proceeding.

1. From Main Menu select 8. UTILITIES
2. From UTILITIES Submenu select 1. COPY/CLEAR
3. Copy from DETECTOR PLAN "1" to DETECTOR PLAN "2".

COPY / CLEAR UTILITY
FROM TO
PHASE TIMING.... > PHASE TIMING....
TIMING PLAN..... > TIMING PLAN.....
PH DET OPT PLAN. . > PH DET OPT PLAN. .
DETECTOR PLAN... 1 > DETECTOR PLAN... 2
TOGGLE TO SELECT A "FROM" AND A "TO"
THEN PRESS ENTER

4. From Main Menu select 6. DETECTORS
5. From DETECTOR Submenu select 2. VEHICLE DETECTOR SETUP
6. Place cursor in VEH DET PLAN [] position and enter "2".
- Place cursor in VEH DETECTOR [] position and enter "5".
- Set delay time to "0".

VEH DETECTOR [5] VEH DET PLAN [2] ← NOTICE VEH DET PLAN 2
TYPE: S-STANDARD
TS2 DETECTOR..... ECPI LOG..... NO
DET PH - 1 2 3 4 5 6 7 8 9 0 1 2 3 4 5 6
5 5
EXTEND TIME... 0.0 DELAY TIME... 0.0 ← ENSURE DELAY IS SET TO '0'
USE ADDED INITIAL . CROSS SWITCH PH.. 0
LOCK IN..... NONE NTCIP VOL . OR OCC .
PMT QUEUE DELAY. NO


- Place cursor in VEH DETECTOR [] position and enter "22".
- Set assigned phase to "0".

VEH DETECTOR [22] VEH DET PLAN [2] ← NOTICE VEH DET PLAN 2
TYPE: S-STANDARD
TS2 DETECTOR..... ECPI LOG..... NO
DET PH - 1 2 3 4 5 6 7 8 9 0 1 2 3 4 5 6
22 0 ← ENSURE PHASE IS SET TO "0"
EXTEND TIME... 0.0 DELAY TIME... 3.0
USE ADDED INITIAL . CROSS SWITCH PH.. 0
LOCK IN..... NONE NTCIP VOL . OR OCC .
PMT QUEUE DELAY. NO

END PROGRAMMING


THIS ELECTRICAL DETAIL IS FOR
THE SIGNAL DESIGN: 07-1364
DESIGNED: March 2018
SEALED: 6/13/2018
REVISED: NA

*****SYSTEMS*****
*****USER*****



Mattern & Craig
ENGINEERS • SURVEYORS
12 BROAD STREET
ASHEVILLE, NORTH CAROLINA 28801
(828) 254-2201
FAX (828) 254-4562
NC LIC. NO. C-1154


Electrical Detail - Sheet 3 of 4

 <small>Seal of the State of North Carolina Department of Transportation Signal Management</small>	<p>DETAILS FOR:</p> <p>NC 54 (Harden Street) at East Pine Street</p>	<p>Division 7 Alamance County Graham</p>							
	<p>PLAN DATE: March 2018 REVIEWED BY: JB Voso</p>								
	<p>PREPARED BY: SE Greene REVIEWED BY:</p>								
	<table border="1" style="width: 100%; border-collapse: collapse;"> <thead> <tr> <th style="width: 50%;">REVISIONS</th> <th style="width: 25%;">INIT.</th> <th style="width: 25%;">DATE</th> </tr> </thead> <tbody> <tr> <td> </td> <td> </td> <td> </td> </tr> <tr> <td> </td> <td> </td> <td> </td> </tr> </tbody> </table>		REVISIONS	INIT.	DATE				
REVISIONS	INIT.	DATE							

DocuSign
James Voso 6/13/2018
140EP00378041E DATE

DOCUMENT NOT CONSIDERED
FINAL UNLESS ALL
SIGNATURES COMPLETED

SEAL

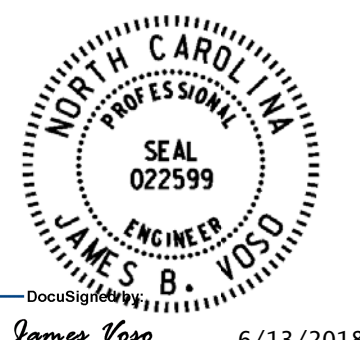

SIG. INVENTORY NO. 07-1364

ECONOLITE ASC/3-2070 ACTION PLAN PROGRAMMING DETAIL

ALTERNATE PHASING ACTIVATION DETAIL

TO RUN ALT. PHASING DURING FREE RUN - PROGRAM CHANGES (SHOWN BELOW) IN A TIME BASED ACTION PLAN. SCHEDULE A DAY PLAN THAT INCLUDES THE ACTION PLAN PROGRAMMED TO SELECT VEH DET PLAN 2 AND ENABLE SF BIT 5.

TO RUN ALT. PHASING DURING COORDINATION - SELECT THE TIME BASED ACTION PLAN THAT IS PROGRAMMED TO SELECT VEH DET PLAN 2 AND ENABLE SF BIT 5.

PHASING	VEH DET PLAN	SF BITS ENABLED
ACTIONS REQUIRED TO RUN <u>DEFAULT PHASING</u>	1	NONE
ACTIONS REQUIRED TO RUN <u>ALTERNATE PHASING</u>	2	5

IMPORTANT: IF ALT. PHASING IS USED DURING FREE RUN AND COORDINATION, DO NOT OPERATE TIME OF DAY EVENTS CONCURRENTLY WITH COORDINATION PLAN EVENTS IN THE EVENT SCHEDULER. (EX. FREE RUN EVENT SHOULD END BEFORE COORDINATION PLAN EVENT STARTS AND VICE-VERSA).

ALTERNATE PHASING CHANGE SUMMARY

THE FOLLOWING IS A SUMMARY OF WHAT TAKES PLACE WHEN SF BIT 5 AND VEH DET PLAN 2 ACTIVATE TO CALL THE "ALTERNATE PHASING":

SF BIT 5: Modifies overlap parent phase for head 51 to run protected turns only.

VEH DET PLAN 2: Disables phase 2 call on loop 5A and reduces delay time for phase 5 call on loop 5A to 0 seconds.


1. From Main Menu select 5. TIME BASE
2. From TIME BASE Submenu select 2. ACTION PLAN

```

ACTION PLAN...[ 1]
PATTERN.....AUTO   SYS OVERRIDE.... NO
TIMING PLAN..... 0   SEQUENCE..... 0
VEH DETECTOR PLAN.. 2   DET LOG.....NONE
FLASH..... --      RED REST..... NO
VEH DET DIAG PLN... 0   PED DET DIAG PLN..0
DIMMING ENABLE.. NO   PRIORITY RETURN. NO
PED PR RETURN.. NO   QUEUE DELAY..... NO
PMT COND DELAY   NO

  PHASE  1  2  3  4  5  6  7  8  9  0  1  2  3  4  5  6
PED RCL  .  .  .  .  .  .  .  .  .  .  .  .  .  .  .  .
WALK 2   .  .  .  .  .  .  .  .  .  .  .  .  .  .  .  .
VEX 2    .  .  .  .  .  .  .  .  .  .  .  .  .  .  .  .
VEH RCL  .  .  .  .  .  .  .  .  .  .  .  .  .  .  .  .
MAX RCL  .  .  .  .  .  .  .  .  .  .  .  .  .  .  .  .
MAX 2    .  .  .  .  .  .  .  .  .  .  .  .  .  .  .  .
  PHASE  1  2  3  4  5  6  7  8  9  0  1  2  3  4  5  6
MAX 3    .  .  .  .  .  .  .  .  .  .  .  .  .  .  .  .
CS INH   .  .  .  .  .  .  .  .  .  .  .  .  .  .  .  .
OMIT     .  .  .  .  .  .  .  .  .  .  .  .  .  .  .  .
SPC FCT  .  .  .  .  X  .  .  .  .  .  .  .  .  .  .  .
AUX FCT  .  .  .  .  (1-3)

  1  2  3  4  5  6  7  8  9  0  1  2  3  4  5
LP 1-15  .  .  .  .  .  .  .  .  .  .  .  .  .  .  .  .
LP 16-30 .  .  .  .  .  .  .  .  .  .  .  .  .  .  .  .
LP 31-45 .  .  .  .  .  .  .  .  .  .  .  .  .  .  .  .
LP 46-60 .  .  .  .  .  .  .  .  .  .  .  .  .  .  .  .
LP 61-75 .  .  .  .  .  .  .  .  .  .  .  .  .  .  .  .
LP 76-90 .  .  .  .  .  .  .  .  .  .  .  .  .  .  .  .
LP 91-100 .  .  .  .  .  .  .  .  .  .  .  .  .  .  .  .
  
```


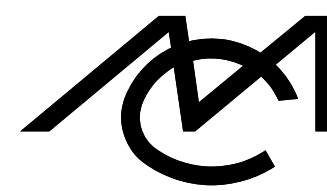


Mattern & Craig
ENGINEERS • SURVEYORS

12 BROAD STREET
ASHEVILLE, NORTH CAROLINA 28801
(828) 254-2201
FAX (828) 254-4562
NC LIC. NO. C-1154


THIS ELECTRICAL DETAIL IS FOR
THE SIGNAL DESIGN: 07-1364
DESIGNED: March 2018
SEALED: 6/13/2018
REVISED: NA

Electrical Detail - Sheet 4 of 4
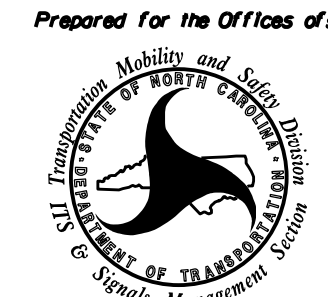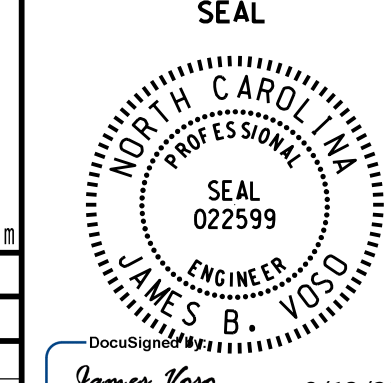
<p style="font-size: small;">ELECTRICAL AND PROGRAMMING DETAILS FOR:</p> <p style="font-size: x-small;">Prepared for the Offices of:</p>  <p style="font-size: x-small;">750 N. Greenfield Hwy, Corner, NC 27529</p>	<p>NC 54 (Harden Street) at East Pine Street</p> <p style="font-size: x-small;">Division 7 Alamance County Graham</p> <p>PLAN DATE: March 2018 REVIEWED BY: JB Voso</p> <p>PREPARED BY: SE Greene REVIEWED BY:</p> <table border="1" style="width: 100%; border-collapse: collapse;"> <thead> <tr> <th style="font-size: x-small;">REVISIONS</th> <th style="font-size: x-small;">INIT.</th> <th style="font-size: x-small;">DATE</th> </tr> </thead> <tbody> <tr> <td> </td> <td> </td> <td> </td> </tr> </tbody> </table>	REVISIONS	INIT.	DATE				<p style="font-size: x-small;">DOCUMENT NOT CONSIDERED FINAL UNLESS ALL SIGNATURES COMPLETED</p> <p style="text-align: center;">SEAL</p>  <p style="font-size: x-small;">James Voso 6/13/2018 DATE</p> <p style="font-size: x-small;">SIG. INVENTORY NO. 07-1364</p>
REVISIONS	INIT.	DATE						

\$\$\$\$\$SYTIME\$\$\$\$\$
\$\$\$\$\$\$\$\$\$\$DOCS\$\$\$\$\$
\$\$\$\$\$SERIAL\$\$\$\$\$

PHASING DIAGRAM

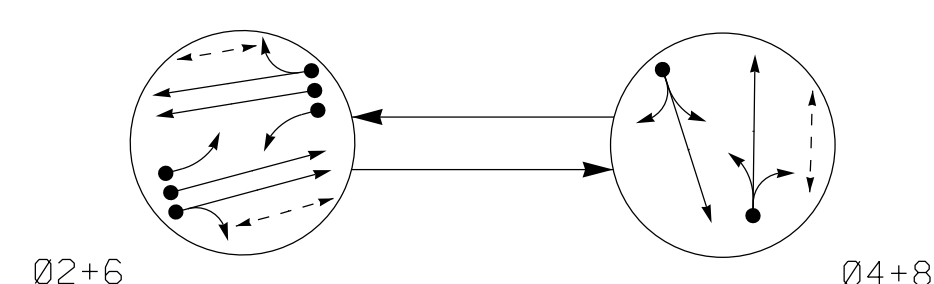


PHASING DIAGRAM DETECTION LEGEND

- DETECTED MOVEMENT
- ◄ UNDETECTED MOVEMENT (OVERLAP)
- ⋯ UNSIGNALIZED MOVEMENT
- ⇄ PEDESTRIAN MOVEMENT

TABLE OF OPERATION

SIGNAL FACE	PHASE		
	Ø 2+6	Ø 4+8	F L S H
21, 22	G R Y		
41, 42	R G R		
61, 62	G R Y		
81, 82	R G R		
P21, P22	W DW DRK		
P61, P62	W DW DRK		
P81, P82	DW W DRK		

SIGNAL FACE I.D.

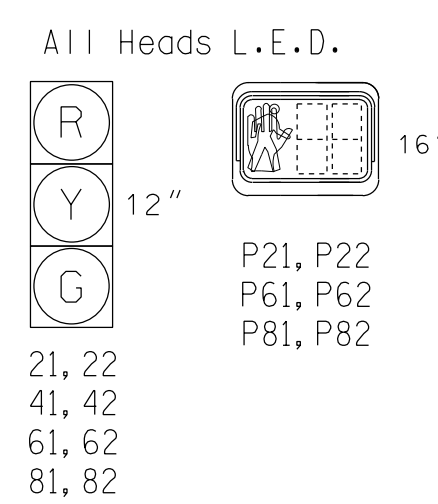


ASC/3 DETECTOR INSTALLATION CHART

LOOP	SIZE (FT)	DISTANCE FROM STOPBAR (FT)	TURNS	PROGRAMMING								
				NEW LOOP	PHASE	CALLING	EXTEND TIME	DELAY TIME	USE ADDED INITIAL	TYPE	SYSTEM LOOP NEW CARD	
2A	6X17	90	EXIST	-	2	Yes	-	-	-	S	-	X
2B	6X40	0	2-4-2	-	2	Yes	-	-	-	S	-	X
4A	6X40	0	2-4-2	-	4	Yes	-	-	-	S	-	X
4B	6X15	+5	EXIST	-	4	Yes	-	15	-	S	-	X
6A	6X20	70	EXIST	-	6	Yes	-	-	-	S	-	X
6B	6X50	+5	2-4-2	-	6	Yes	-	-	-	S	-	X
8A	6X40	0	2-4-2	-	8	Yes	-	10	-	S	-	X

2 Phase Fully Actuated (Burlington-Graham Signal System)

NOTES


- Refer to "Roadway Standard Drawings NCDOT" dated January 2018 and "Standard Specifications for Roads and Structures" dated January 2018.
- Do not program signal for late night flashing operation unless otherwise directed by the Engineer.
- Set all detector units to presence mode.
- In the event of loop replacement, refer to the current ITS and Signals Design Manual and submit a Plan of Record to the Signal Design Section.
- Locate new cabinet so as not to obstruct sight distance of vehicles turning right on red.
- The cabinet should be designed to include an Auxiliary Output File for future use.
- Omit "WALK" and flashing "DON'T WALK" with no pedestrian calls.
- Program pedestrian heads to countdown the flashing "Don't Walk" time only.
- Pavement markings are existing.
- Maximum times shown in timing chart are for free-run operation only. Coordinated signal system timing values supersede these values.

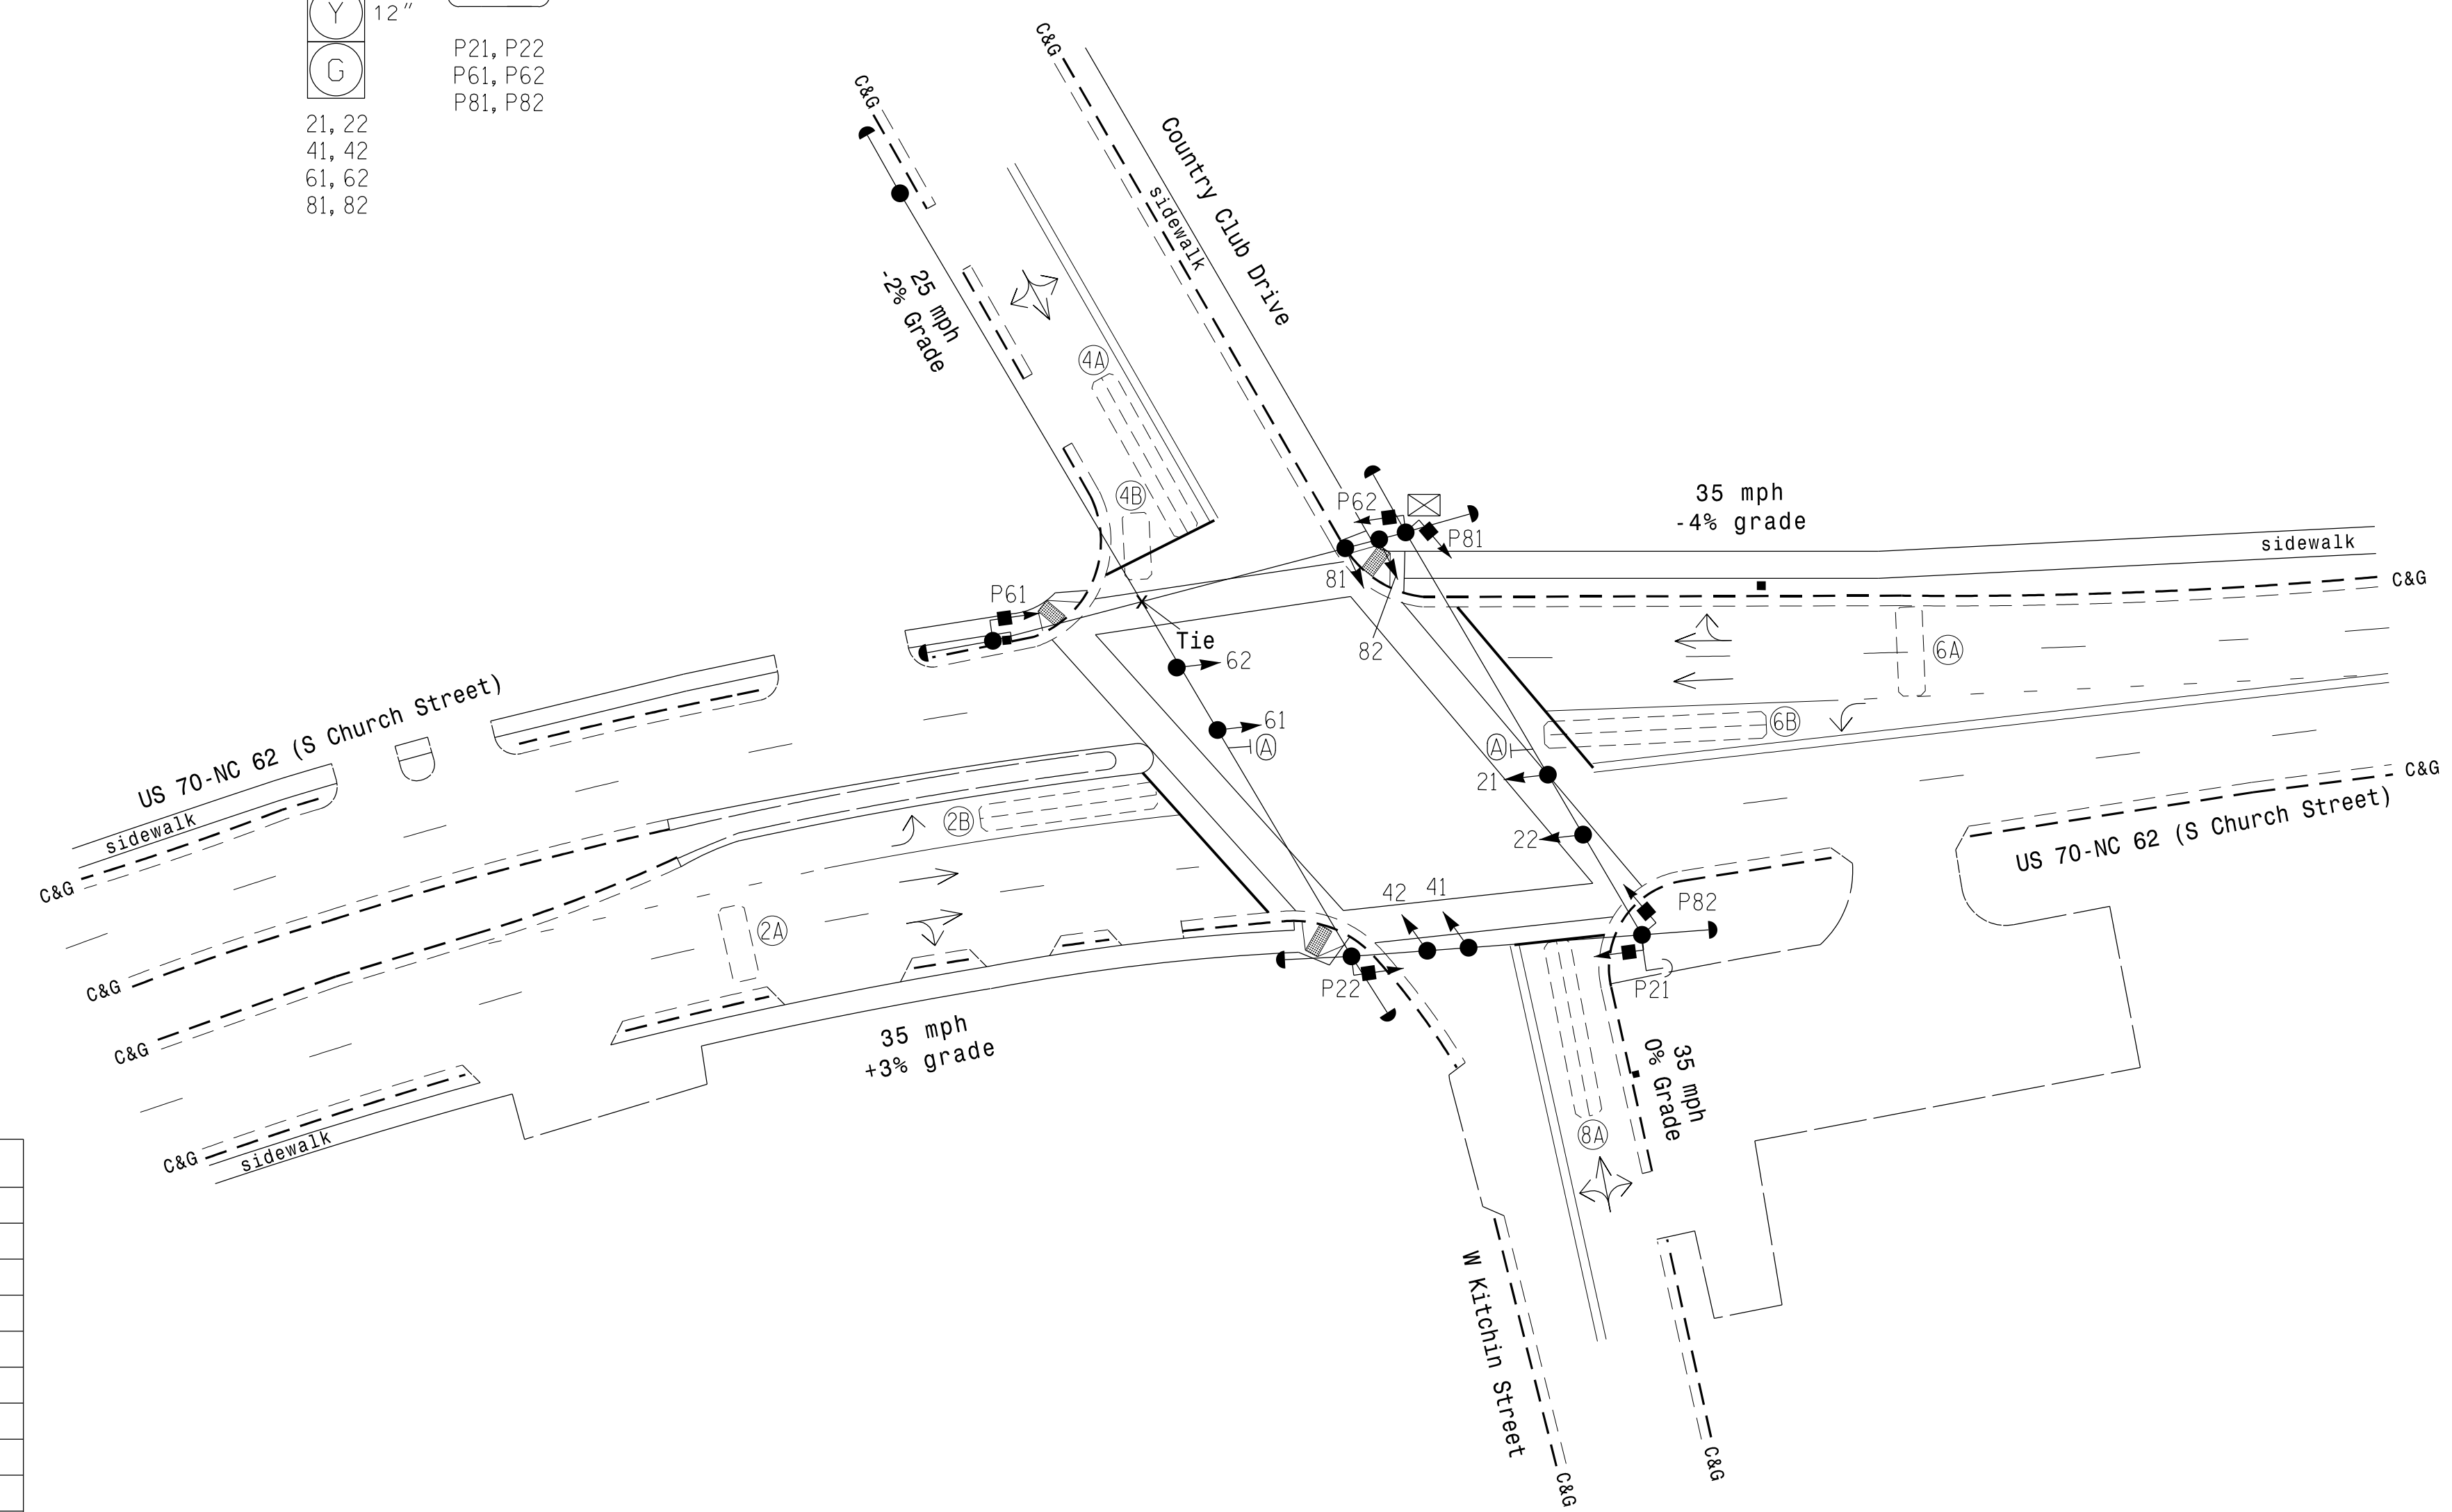

ASC/3 TIMING CHART

FEATURE	PHASE			
	2	4	6	8
Min Green *	10	7	10	7
Walk *	4	0	4	4
Ped Clear	16	0	15	24
Veh. Extension *	3.0	2.0	3.0	2.0
Max 1 *	65	25	65	25
Yellow	3.7	3.3	4.1	3.8
Red Clear	1.5	3.0	1.6	2.5
Actuations B4 Add *	-	-	-	-
Seconds / Actuation *	-	-	-	-
Max Initial *	-	-	-	-
Time Before Reduction *	-	-	-	-
Time To Reduce *	-	-	-	-
Minimum Gap	-	-	-	-
Locking Detector	X	-	X	-
Recall Position	VEH, RECALL	-	VEH, RECALL	-
Dual Entry	-	X	-	X
Simultaneous Gap	X	X	X	X

* These values may be field adjusted. Do not adjust Min Green and Extension times for phases 2 and 6 lower than what is shown. Min Green for all other phases should not be lower than 4 seconds.

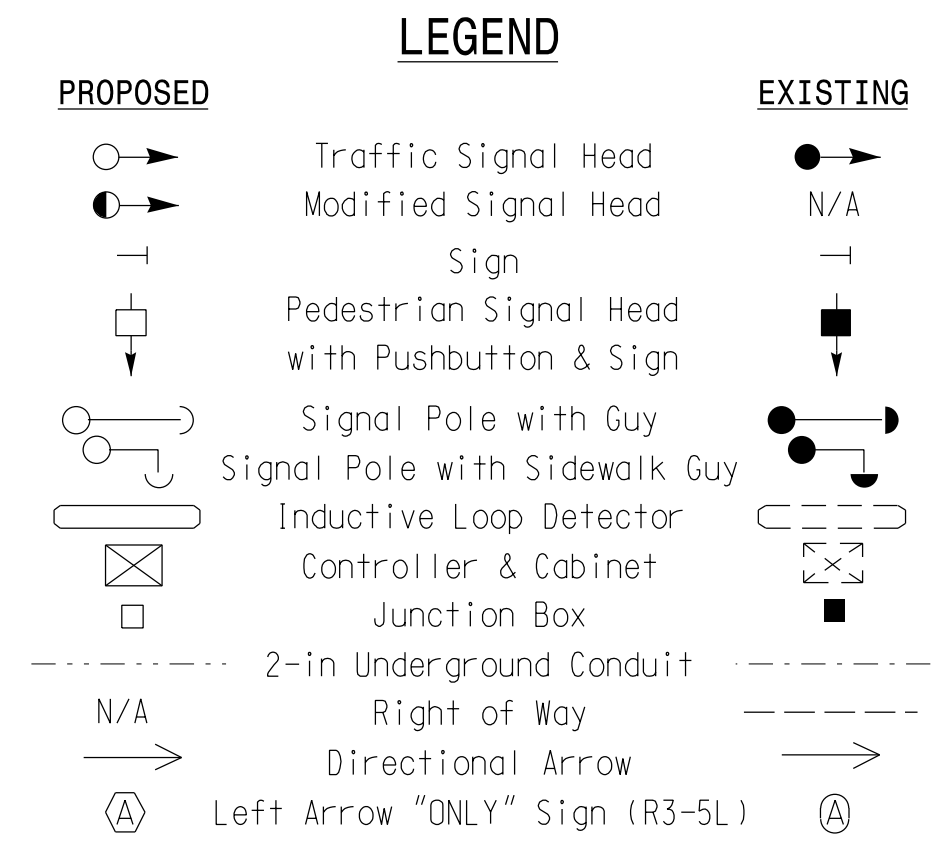

Signal Upgrade

Prepared for the Offices of:

US 70-NC 62 (S. Church Street) at W. Kitchin Street/ Country Club Drive

Division 7 Alamance County Burlington

PLAN DATE: November 2017 REVIEWED BY: AM Encarnacion

PREPARED BY: JA Wiles REVIEWED BY: PL Alexander

SCALE: 1"=30'

6/7/2018

SIG. INVENTORY NO. 07-1380


DOCUMENT NOT CONSIDERED FINAL UNLESS ALL SIGNATURES COMPLETED

07-JUN-2018 11:15 D:\Transpor\at\com\Facility\cur\100056469 U-6015 B-G S19 System\Task 05_11_Signal\Drawings\sig\07-1380.dgn ALEX3361 AT LUS210649

EDI MODEL 2018ECLip-NC CONFLICT MONITOR PROGRAMMING DETAIL

(remove jumpers and set switches as shown)



REMOVE DIODE JUMPERS 2-6, 2-13, 2-15, 4-8, 4-16, 6-13, 6-15, 8-16 and 13-15.

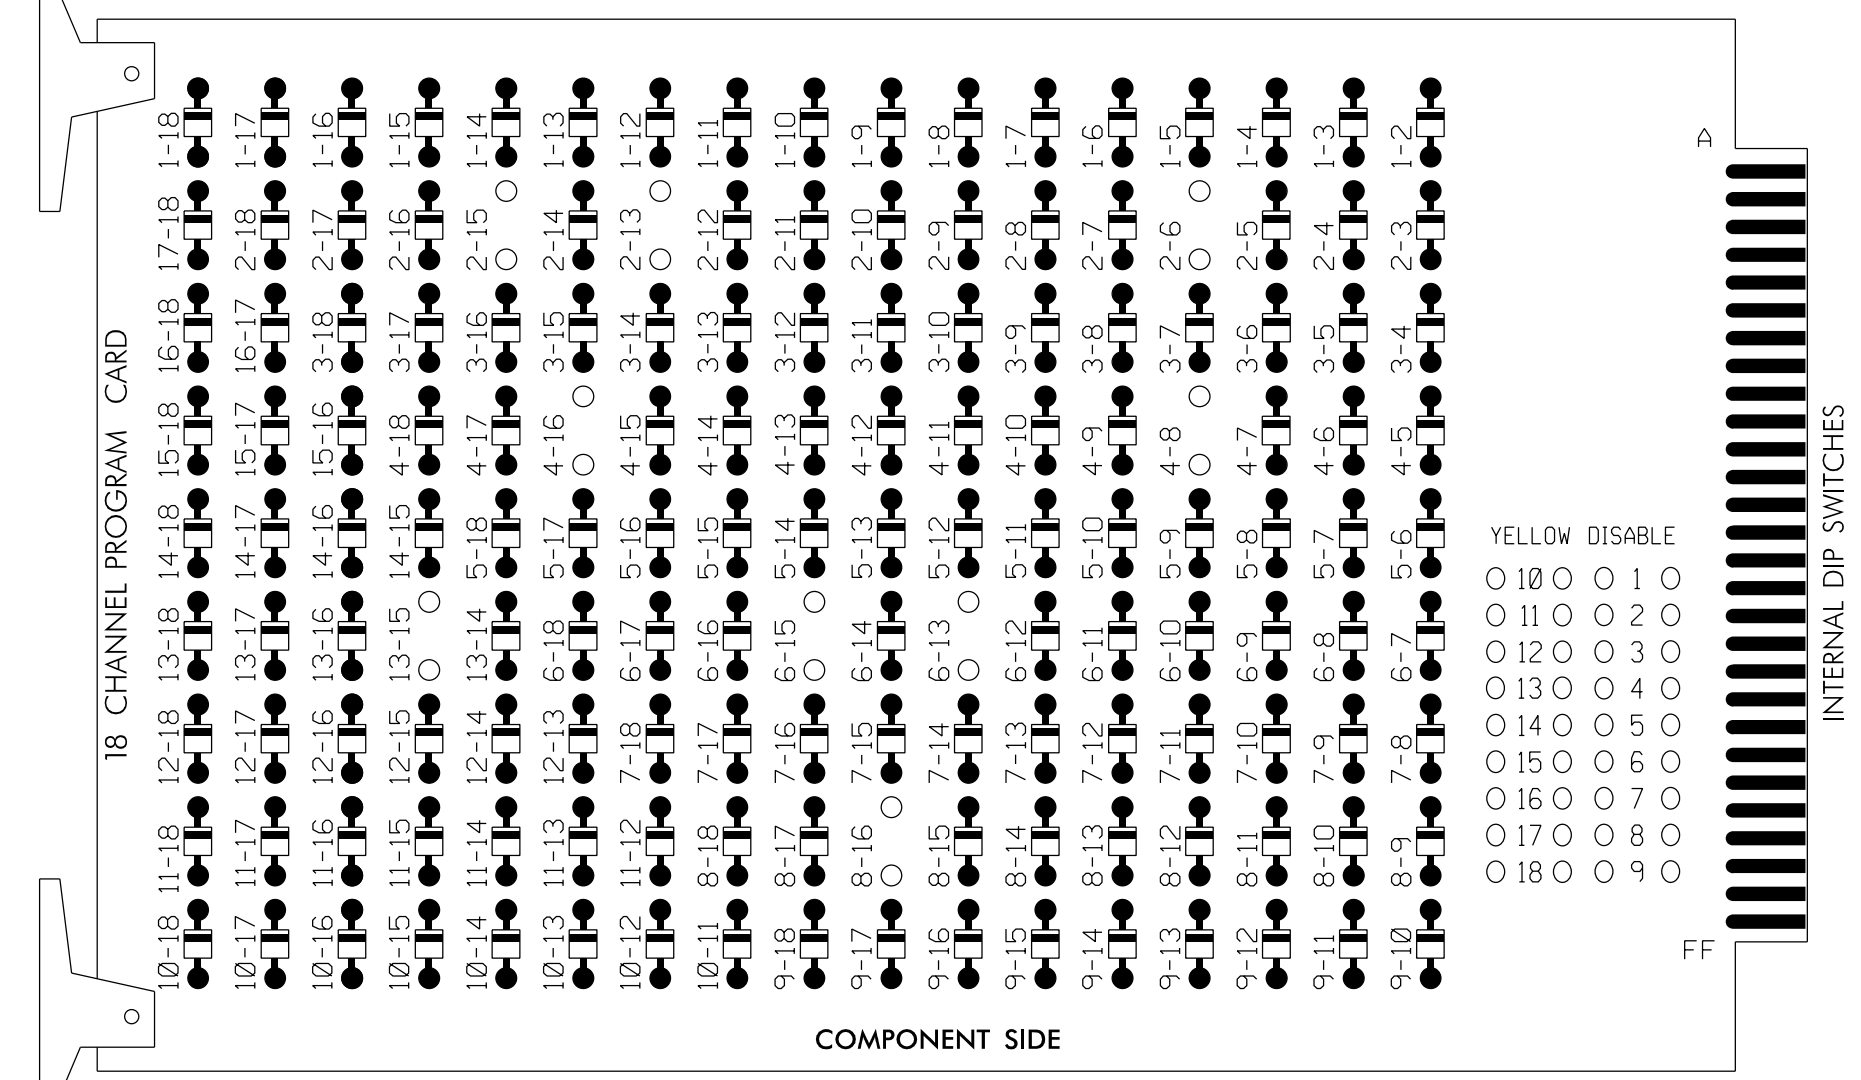

REMOVE JUMPERS AS SHOWN

NOTES:

1. Card is provided with all diode jumpers in place. Removal of any jumper allows its channels to run concurrently.
2. Ensure jumpers SEL2-SEL5 and SEL9 are present on the monitor board.
3. Ensure that Red Enable is active at all times during normal operation.
4. Integrate monitor with Ethernet network in cabinet.

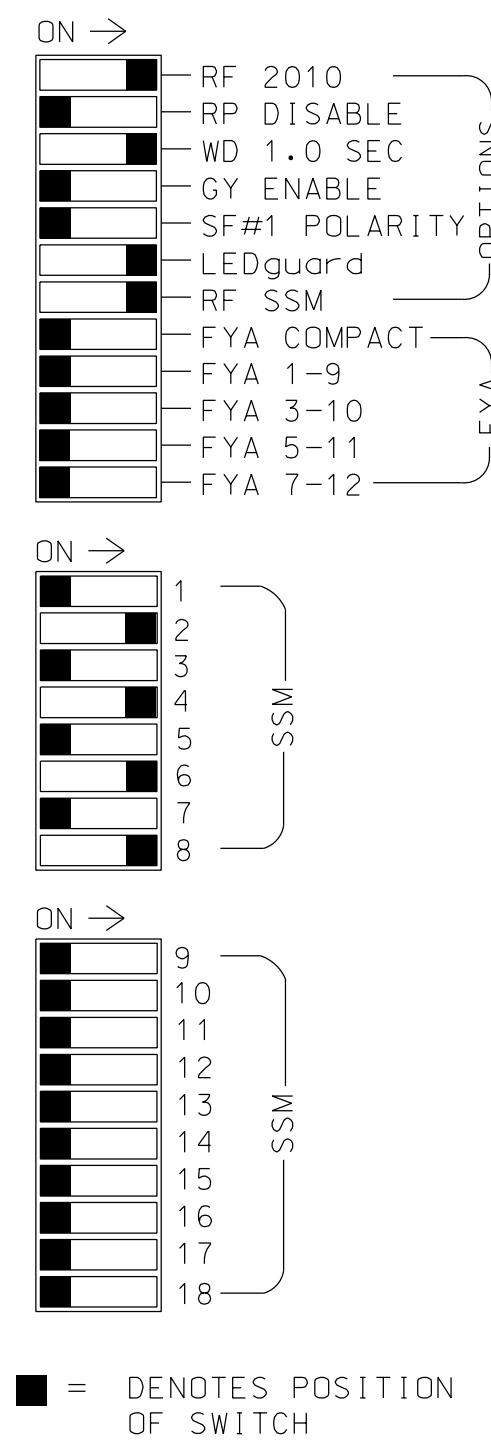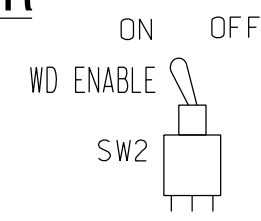

NOTES

1. To prevent "flash-conflict" problems, insert red flash program blocks for all unused vehicle load switches in the output file. The installer shall verify that signal heads flash in accordance with the Signal Plans.
2. Program phases 4 and 8 for dual entry.
3. Program controller to start up in phase 2 Walk and 6 Walk.
4. The cabinet and controller are part of the Burlington-Graham Signal System.

EQUIPMENT INFORMATION

CONTROLLER.....2070LX
 CABINET.....332 W/AUX
 SOFTWARE.....ECONOLITE ASC/3-2070
 CABINET MOUNT.....BASE
 OUTPUT FILE POSITIONS...18 WITH AUX. OUTPUT FILE
 LOAD SWITCHES USED.....S2,S3,S5,S8,S9,S11,S12
 PHASES USED.....2,2PED,4,6,6PED,8,8PED
 OVERLAPS.....NONE

PROJECT REFERENCE NO.	SHEET NO.
U-6015	Sig.117.1

SIGNAL HEAD HOOK-UP CHART

LOAD SWITCH NO.	S1	S2	S3	S4	S5	S6	S7	S8	S9	S10	S11	S12	AUX S1	AUX S2	AUX S3	AUX S4	AUX S5	AUX S6
CMU CHANNEL NO.	1	2	13	3	4	14	5	6	15	7	8	16	9	10	17	11	12	18
PHASE	1	2	2 PED	3	4	4 PED	5	6	6 PED	7	8	8 PED	OLA	OLB	SPARE	OLC	OLD	SPARE
SIGNAL HEAD NO.	NU	21,22	P21, P22	NU	41,42	NU	NU	61,62	P61, P62	NU	81,82	P81, P82	NU	NU	NU	NU	NU	NU
RED		128			101			134			107							
YELLOW		129			102			135			108							
GREEN		130			103			136			109							
RED ARROW																		
YELLOW ARROW																		
GREEN ARROW																		
Hand icon			113						119		110							
Walking person icon			115						121		112							


NU = Not Used

COUNTDOWN PEDESTRIAN SIGNAL OPERATION

Countdown Ped Signals are required to display timing only during Ped Clearance Interval. Consult Ped Signal Module user's manual for instructions on selecting this feature.

INPUT FILE POSITION LAYOUT

(front view)

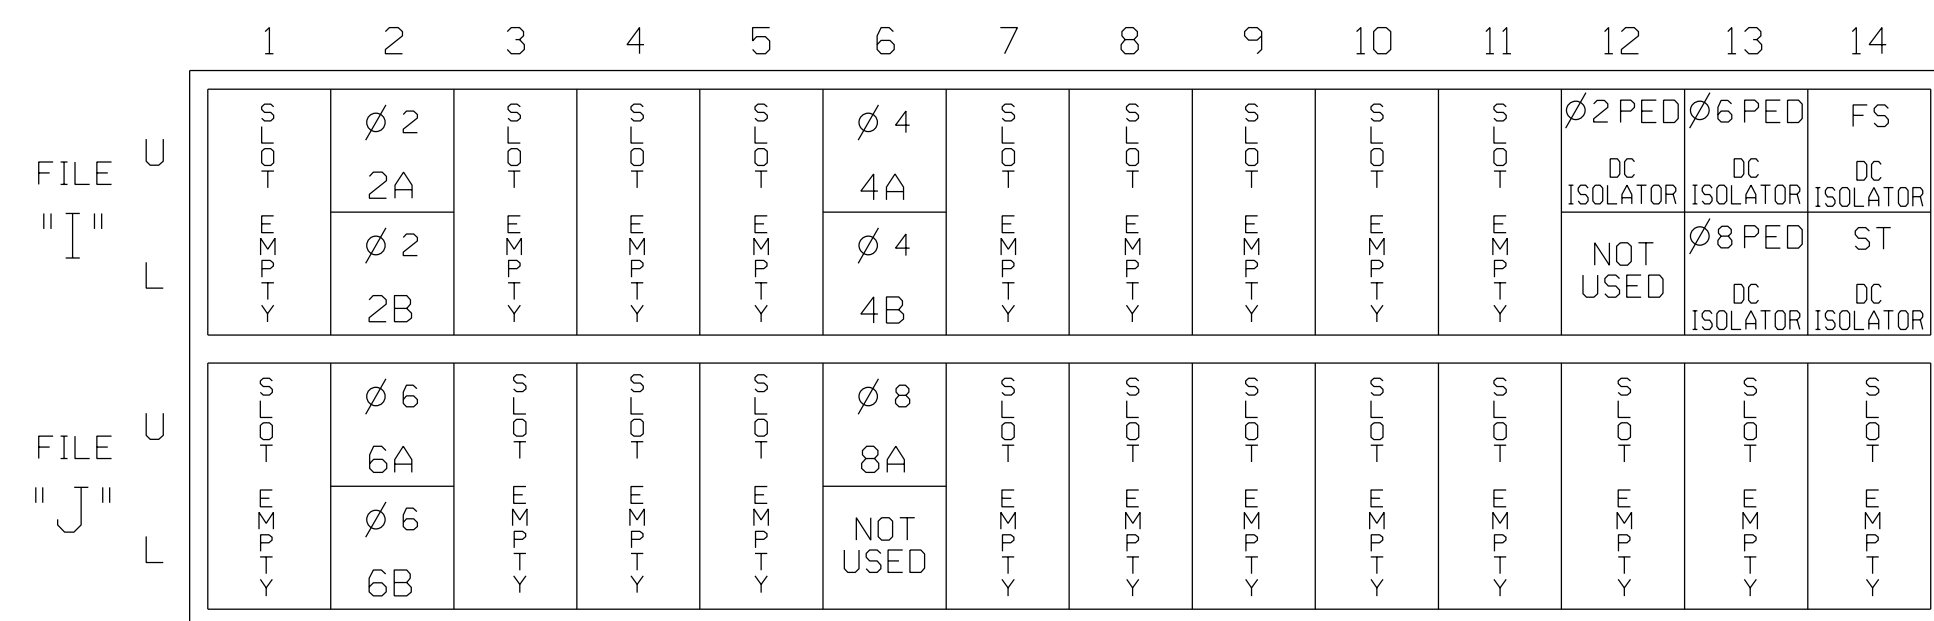

EX.: 1A, 2A, ETC. = LOOP NO.'S


FS = FLASH SENSE
 ST = STOP TIME

INPUT FILE CONNECTION & PROGRAMMING CHART

LOOP NO.	LOOP TERMINAL	INPUT FILE POS.	PIN NO.	DETECTOR NO.	NEMA PHASE	CALL	EXTEND TIME	DELAY TIME	ADDED INITIAL	DETECTOR TYPE
2A	TB2-5,6	I2U	39	2	2	YES				S
2B	TB2-7,8	I2L	43	12	2	YES				S
4A	TB4-9,10	I6U	41	4	4	YES				S
4B	TB4-11,12	I6L	45	14	4	YES		15		S
6A	TB3-5,6	J2U	40	6	6	YES				S
6B	TB3-7,8	J2L	44	16	6	YES				S
8A	TB5-9,10	J6U	42	8	8	YES		10		S
PED PUSH BUTTONS										
P21,P22	TB8-4,6	I12U	67	PED 2	2	PED				
P61,P62	TB8-7,9	I13U	68	PED 6	6	PED				
P81,P82	TB8-8,9	I13L	70	PED 8	8	PED				

NOTE:
 INSTALL DC ISOLATORS IN INPUT FILE SLOTS 112 AND 113.

INPUT FILE POSITION LEGEND: J2L

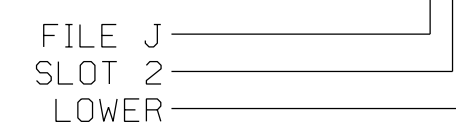


THIS ELECTRICAL DETAIL IS FOR THE SIGNAL DESIGN: 07-1380
 DESIGNED: NOVEMBER 2017
 SEALED: 6/7/2018
 REVISED: N/A

Electrical Detail

ELECTRICAL AND PROGRAMMING DETAILS FOR: Prepared for the Offices of: 	US 70-NC 62 (S. Church Street) at W. Kitchin Street/ Country Club Drive		SEAL NORTH CAROLINA PROFESSIONAL ENGINEER PAMELA L. ALEXANDER SEAL 023489
	Division 7 PLAN DATE: November 2017 PREPARED BY: JA Wiles	Alamance County REVIEWED BY: AM Encarnacion REVIEWED BY: PL Alexander	
REVISIONS: _____ INIT. _____ DATE _____			SIG. INVENTORY NO. 07-1380

PHASING DIAGRAM

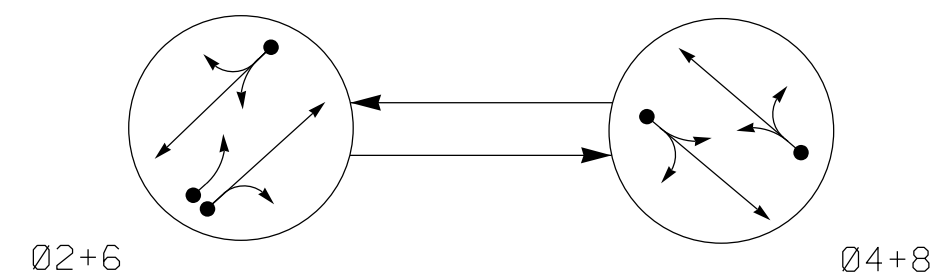


PHASING DIAGRAM DETECTION LEGEND

- ← DETECTED MOVEMENT
- ← UNDETECTED MOVEMENT (OVERLAP)
- UNSIGNALIZED MOVEMENT
- ⇄ PEDESTRIAN MOVEMENT

SIGNAL FACE	PHASE		
	02+6	04+8	FLASH
21, 22	G	R	Y
41, 42	R	G	R
61, 62	G	R	Y
81, 82	R	G	R

SIGNAL FACE I.D.

All Heads L.E.D.

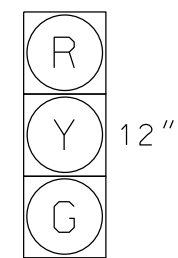

21, 22
41, 42
61, 62
81, 82

ASC/3 DETECTOR INSTALLATION CHART											
DETECTOR				PROGRAMMING							
LOOP	SIZE (FT)	DISTANCE FROM STOPBAR (FT)	TURNS	NEW LOOP	PHASE	CALLING	EXTEND TIME	DELAY TIME	USE ADDED INITIAL	TYPE	LOOP SYSTEM NEW CARD
2A	6X15	80	EXIST	-	2	Yes	-	-	-	S	- X
4A	6X40	+5	EXIST	-	4	Yes	-	3	-	S	- X
6A	6X6	295	EXIST	-	6	Yes	1.7	-	-	S	- X
6B	6X6	80	EXIST	-	6	Yes	-	-	-	S	- X
8A	6X40	+5	EXIST	-	8	Yes	-	3	-	S	- X
S1	6X6	+115	4	X	-	NO	-	-	-	N	X X

2 Phase Fully Actuated (Burlington-Graham Signal System)

NOTES


- Refer to "Roadway Standard Drawings NCDOT" dated January 2018 and "Standard Specifications for Roads and Structures" dated January 2018.
- Do not program signal for late night flashing operation unless otherwise directed by the Engineer.
- Set all detector units to presence mode.
- In the event of loop replacement, refer to the current ITS and Signals Design Manual and submit a Plan of Record to the Signal Design Section.
- Locate new cabinet so as not to obstruct sight distance of vehicles turning right on red.
- The cabinet should be designed to include an Auxiliary Output file for future use.
- Pavement markings are existing.
- Maximum times shown in timing chart are for free-run operation only. Coordinated signal system timing values supersede these values.

LEGEND

- | PROPOSED | EXISTING |
|--|-----------------------------------|
| ○ → Traffic Signal Head | ● → N/A |
| ● → Modified Signal Head | — Sign |
| ⊥ Pedestrian Signal Head With Push Button & Sign | ⊥ |
| ○ Signal Pole with Guy | ● Signal Pole with Guy |
| ○ Signal Pole with Sidewalk Guy | ○ Signal Pole with Sidewalk Guy |
| ⊠ Inductive Loop Detector | ⊠ Inductive Loop Detector |
| ⊠ Controller & Cabinet | ⊠ Junction Box |
| ⊠ Junction Box | ⊠ |
| --- 2-in Underground Conduit | --- 2-in Underground Conduit |
| N/A Right of Way | → Right of Way |
| → Directional Arrow | → Directional Arrow |
| ⊠ Right Arrow "ONLY" Sign (R3-5R) | ⊠ Right Arrow "ONLY" Sign (R3-5R) |

ASC/3 TIMING CHART				
FEATURE	PHASE			
	2	4	6	8
Min Green *	12	7	12	7
Walk *	-	-	-	-
Ped Clear	-	-	-	-
Veh. Extension *	2.0	2.0	2.0	2.0
Max 1 *	45	25	45	25
Yellow	3.8	4.0	4.5	3.8
Red Clear	1.0	1.1	1.0	1.0
Actions B4 Add *	-	-	-	-
Seconds / Actuation *	-	-	-	-
Max Initial *	-	-	-	-
Time Before Reduction *	-	-	-	-
Time To Reduce *	-	-	-	-
Minimum Gap	-	-	-	-
Locking Detector	X	-	X	-
Recall Position	VEH. RECALL	-	VEH. RECALL	-
Dual Entry	-	X	-	X
Simultaneous Gap	X	X	X	X

* These values may be field adjusted. Do not adjust Min Green and Extension times for phases 2 and 6 lower than what is shown. Min Green for all other phases should not be lower than 4 seconds.

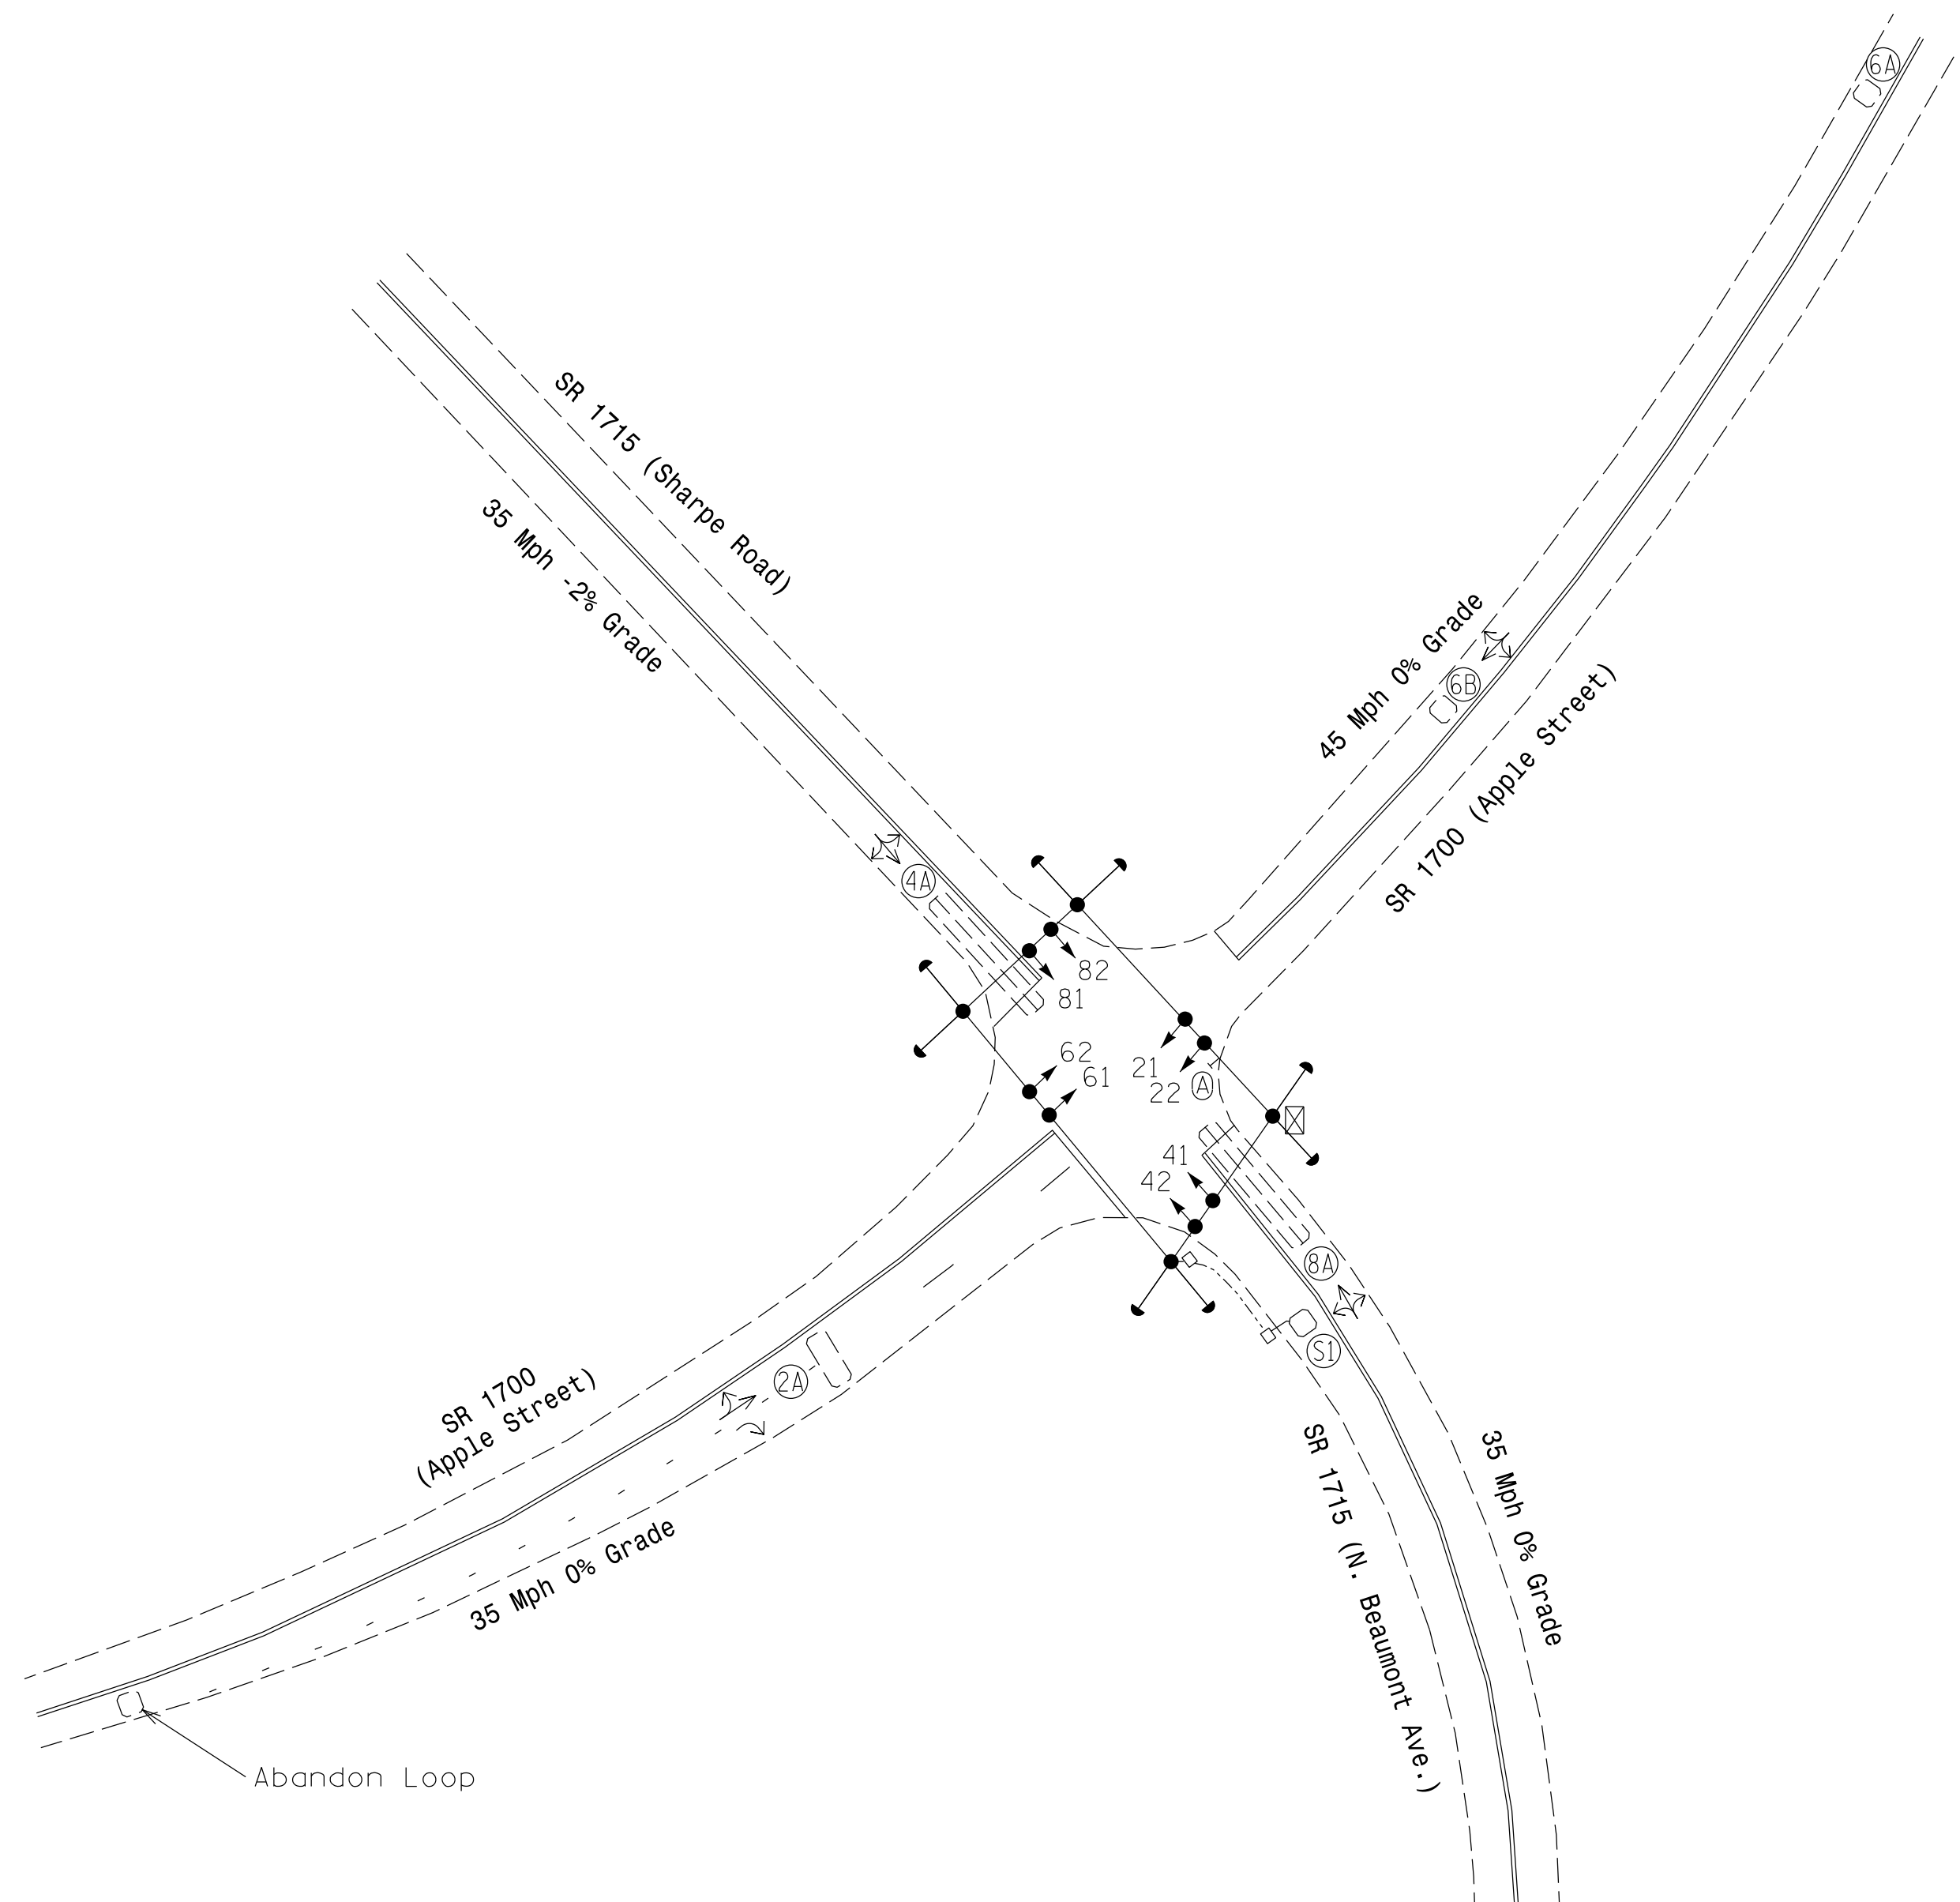

Signal Upgrade


DOCUMENT NOT CONSIDERED FINAL UNLESS ALL SIGNATURES COMPLETED

Prepared in the Office of: NC FIRM LICENSE No: P-0339 504 Meadowlands Drive Hillsborough, NC 27278 (919) 732-3883 (919) 732-6676 (FAX)	Prepared For: TRANSPORTATION MOBILITY AND SAFETY DIVISION SIGNAL DESIGN SECTION 750 N. Greenfield Pkwy, Garner, NC 27529	SR 1700 (Apple Street) At SR 1715 (Sharpe Road / N. Beaumont Avenue)		SEAL EDWARD W. SIRGANY
		Division 7 Alamance County Burlington	PLAN DATE: October 2017 REVIEWED BY: E. W. Sirgany	

EDI MODEL 2018ECLIP-NC CONFLICT MONITOR

PROGRAMMING DETAIL

(remove jumpers and set switches as shown)

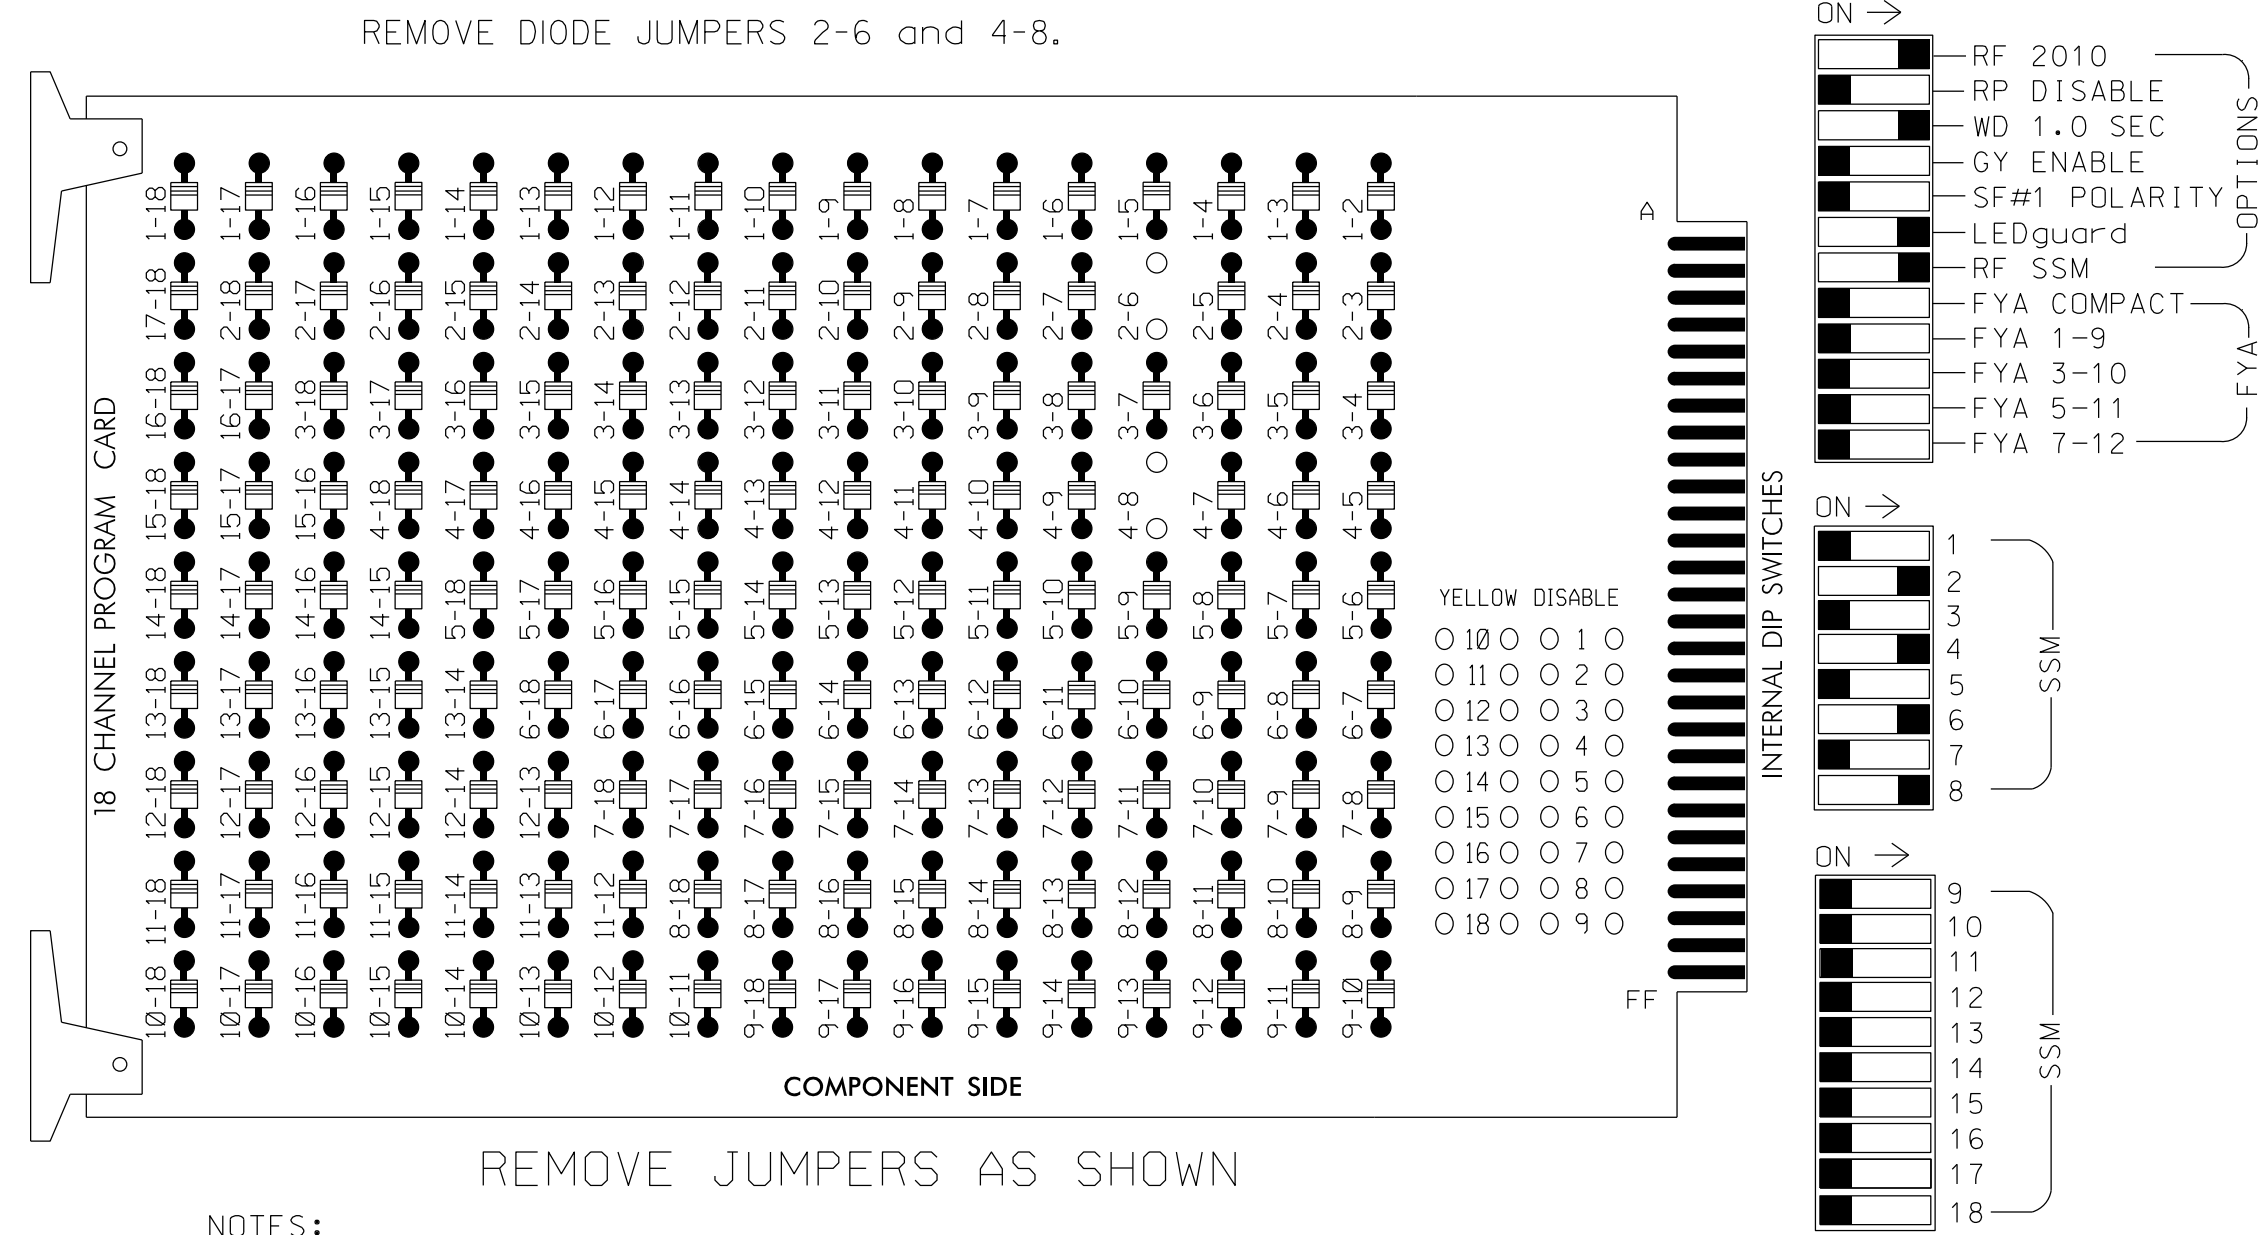

REMOVE JUMPERS AS SHOWN

NOTES:

1. Card is provided with all diode jumpers in place. Removal of any jumper allows its channels to run concurrently.
2. Ensure jumpers SEL2-SEL5 and SEL9 are present on the monitor board.
3. Ensure that Red Enable is active at all times during normal operation.
4. Integrate monitor with Ethernet network in cabinet.

NOTES

1. To prevent "flash-conflict" problems, insert red flash program blocks for all unused vehicle load switches in the output file. The installer shall verify that signal heads flash in accordance with the Signal Plans.
2. Program phases 4 and 8 for Dual Entry.
3. Program controller to start up in phase 2 Green and 6 Green.
4. The cabinet and controller are part of the Burlington-Graham Signal System.

SIGNAL HEAD HOOK-UP CHART

LOAD SWITCH NO.	S1	S2	S3	S4	S5	S6	S7	S8	S9	S10	S11	S12	AUX S1	AUX S2	AUX S3	AUX S4	AUX S5	AUX S6
CMU CHANNEL NO.	1	2	13	3	4	14	5	6	15	7	8	16	9	10	17	11	12	18
PHASE	1	2	2 PED	3	4	4 PED	5	6	6 PED	7	8	8 PED	OLA	OLB	SPARE	OLC	OLD	SPARE
SIGNAL HEAD NO.	NU	21,22	NU	NU	41,42	NU	NU	61,62	NU	NU	81,82	NU	NU	NU	NU	NU	NU	NU
RED		128			101			134			107							
YELLOW		129			102			135			108							
GREEN		130			103			136			109							
RED ARROW																		
YELLOW ARROW																		
GREEN ARROW																		


NU = Not Used

EQUIPMENT INFORMATION

CONTROLLER.....2070LX
 CABINET332 W/ AUX FILE
 SOFTWAREECONOLITE ASC/3-2070
 CABINET MOUNT.....BASE
 OUTPUT FILE POSITIONS..18 WITH AUX. OUTPUT FILE
 LOAD SWITCHES USED.....S2,S5,S8,S11
 PHASES USED.....2,4,6,8
 OVERLAPS.....NONE

INPUT FILE POSITION LAYOUT

(front view)

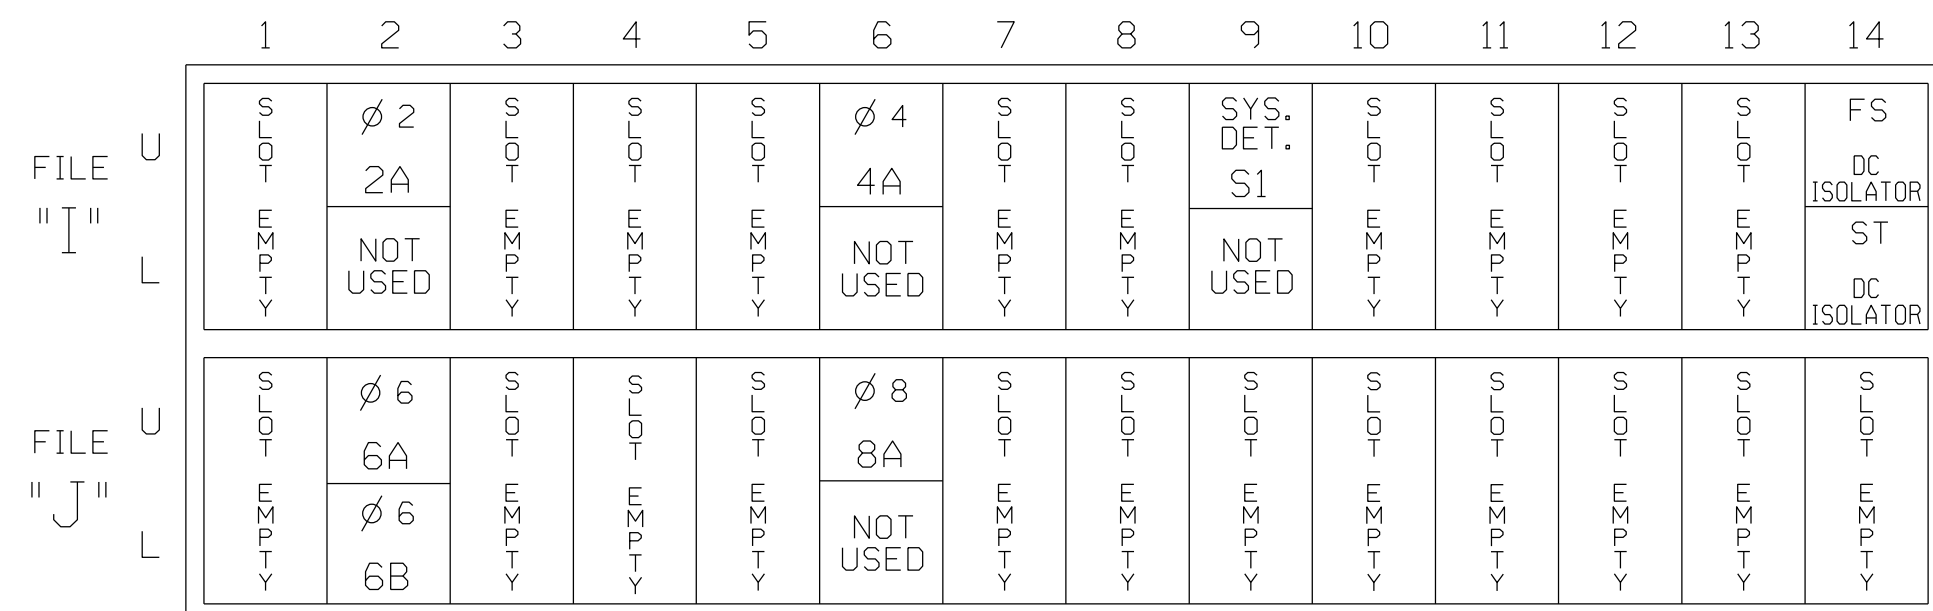

EX.: 1A, 2A, ETC. = LOOP NO.'S


FS = FLASH SENSE
 ST = STOP TIME

INPUT FILE CONNECTION & PROGRAMMING CHART

LOOP NO.	LOOP TERMINAL	INPUT FILE POS.	PIN NO.	DETECTOR NO.	NEMA PHASE	CALL	EXTEND TIME	DELAY TIME	ADDED INITIAL	DETECTOR TYPE
2A	TB2-5,6	I2U	39	2	2	YES				S
4A	TB4-9,10	I6U	41	4	4	YES		3		S
* S1	TB6-9,10	I9U	60	11	SYS	NO				N
6A	TB3-5,6	J2U	40	6	6	YES	1.7			S
6B	TB3-7,8	J2L	44	16	6	YES				S
8A	TB5-9,10	J6U	42	8	8	YES		3		S

* System detector only. Remove any assigned vehicle phase.

INPUT FILE POSITION LEGEND: J2L

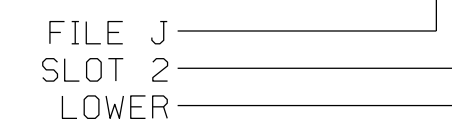

THIS ELECTRICAL DETAIL IS FOR
 THE SIGNAL DESIGN: 07-1386
 PREPARED: October 2017
 SEALED: 5/31/2018
 REVISED: N/A

Electrical Detail

Prepared in the Office of:

 NC FIRM LICENSE No: P-0339
 504 Meadowlands Drive
 Hillsborough, NC 27278
 (919) 732-3883
 (919) 732-6676 (FAX)

ELECTRICAL AND PROGRAMMING DETAILS FOR:
 Prepared For:

 750 N. Greenfield Pkwy, Garner, NC 27529

SR 1700 (Apple Street)
 at
 SR 1715 (Sharpe Road /
 N. Beaumont Avenue)

Division 7 Alamance County Burlington

PLAN DATE: October 2017 REVIEWED BY: E. W. Sirgany
 PREPARED BY: J. Smith REVIEWED BY:

REVISIONS INIT. DATE

DOCUMENT NOT CONSIDERED FINAL UNLESS ALL SIGNATURES COMPLETED


SEAL

DocuSigned by:
 Edward W Sirgany 5/31/2018
 DATE
 SIG. INVENTORY NO. 07-1386

EDI MODEL 2018ECLip-NC CONFLICT MONITOR PROGRAMMING DETAIL

(remove jumpers and set switches as shown)

REMOVE DIODE JUMPERS 1-6, 1-9, 1-11, 2-6, 2-9, 2-11, 3-7, 3-8, 3-10, 4-7, 4-8, 4-10, 6-9, 6-11, 7-10, 8-10 and 9-11.

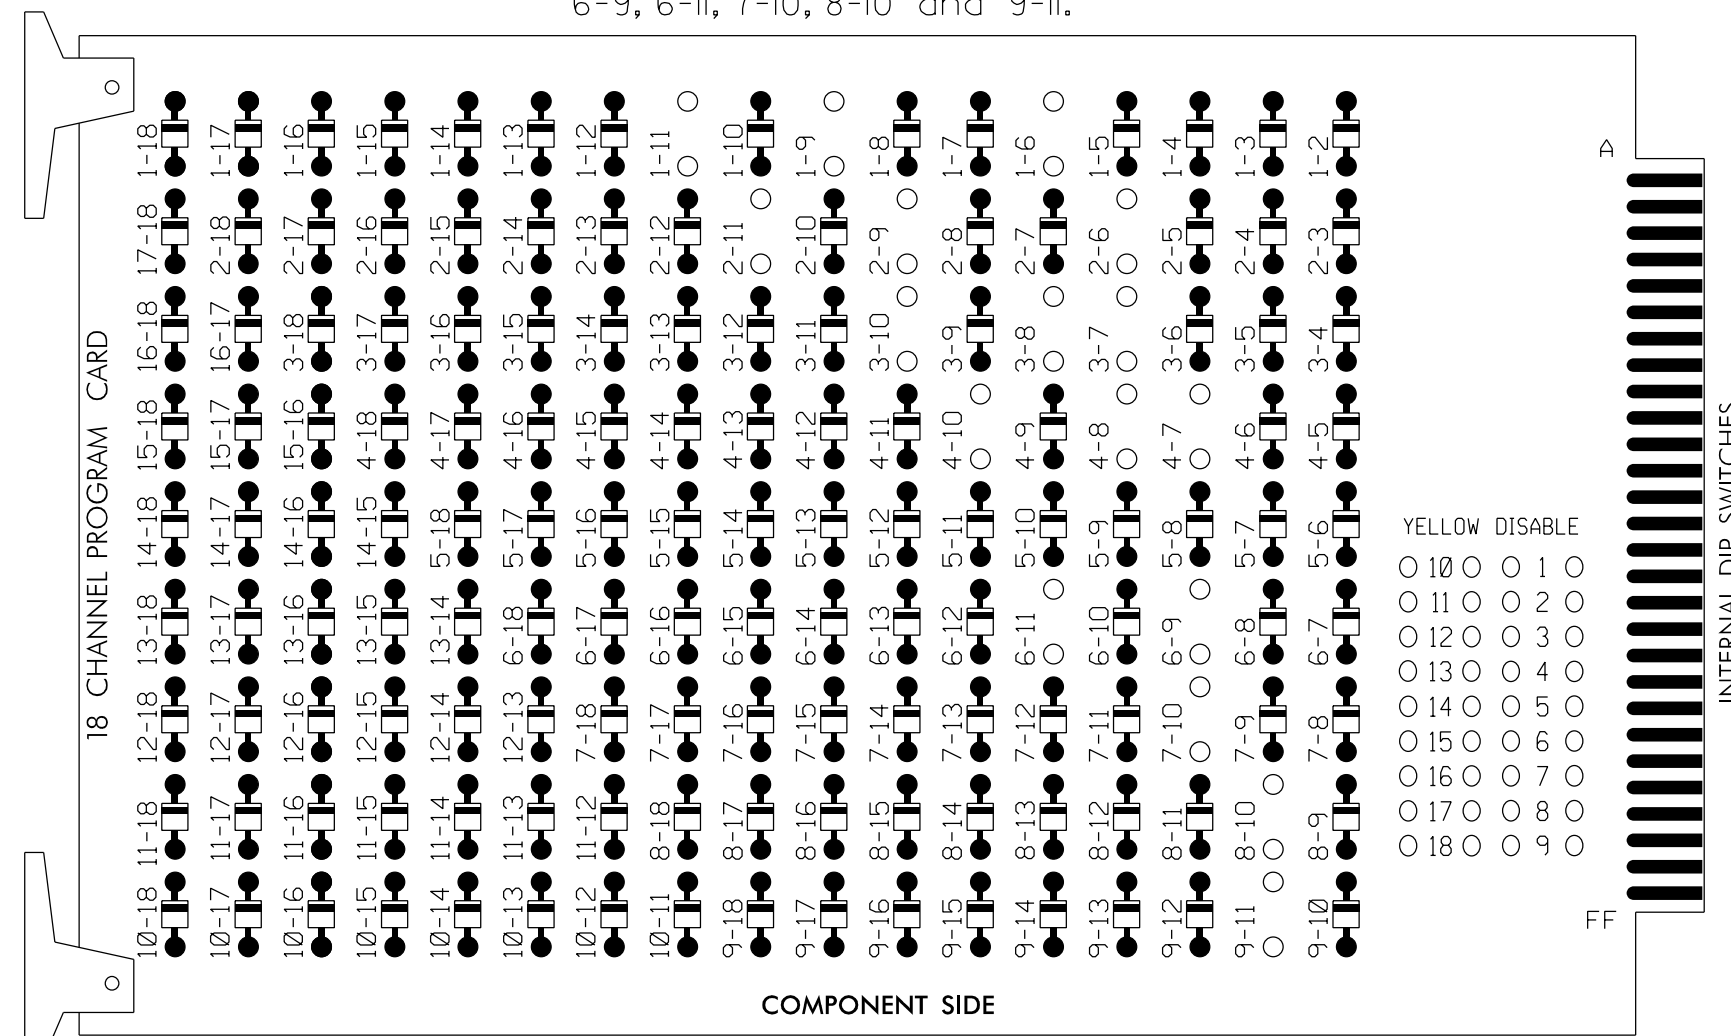

REMOVE JUMPERS AS SHOWN

NOTES:

- Card is provided with all diode jumpers in place. Removal of any jumper allows its channels to run concurrently.
- Ensure jumpers SEL2-SEL5 and SEL9 are present on the monitor board.
- Ensure that Red Enable is active at all times during normal operation.
- Integrate monitor with Ethernet network in cabinet.

NOTES

- To prevent "flash-conflict" problems, insert red flash program blocks for all unused vehicle load switches in the output file. The installer shall verify that signal heads flash in accordance with the Signal Plans.
- Program phase 4 for Dual Entry.
- Program controller to start up in phase 2 Green and 6 Green.
- The cabinet and controller are part of the Burlington-Graham Signal System.

EQUIPMENT INFORMATION

CONTROLLER.....2070LX
 CABINET.....332 W/AUX
 SOFTWARE.....ECONOLITE ASC/3-2070
 CABINET MOUNT.....BASE
 OUTPUT FILE POSITIONS...18 WITH AUX. OUTPUT FILE
 LOAD SWITCHES USED.....S1,S2,S4,S5,S8,S10,S11,
 AUX S1,AUX S2,AUX S4
 PHASES USED.....1,2,3,4,6,7,8
 OVERLAP "A".....*
 OVERLAP "B".....*
 OVERLAP "C".....*
 OVERLAP "D".....NOT USED
 * See overlap programming detail on sheet 2

SIGNAL HEAD HOOK-UP CHART

LOAD SWITCH NO.	S1	S2	S3	S4	S5	S6	S7	S8	S9	S10	S11	S12	AUX S1	AUX S2	AUX S3	AUX S4	AUX S5	AUX S6
CMU CHANNEL NO.	1	2	13	3	4	14	5	6	15	7	8	16	9	10	17	11	12	18
PHASE	1	2	2 PED	3	4	4 PED	5	6	6 PED	7	8	8 PED	OLA	OLB	SPARE	OLC	OLD	SPARE
SIGNAL HEAD NO.	11	82	22,23	NU	23	31	41,42	NU	61,62	62	71,72	81,82	11	31	NU	21	NU	NU
RED	*	128		*	101			134			107							
YELLOW		129			102			135			108							
GREEN		130			103			136			109							
RED ARROW										122			A121	A124		A114		
YELLOW ARROW	126			117						123	123		A122	A125		A115		
FLASHING YELLOW ARROW													A123	A126		A116		
GREEN ARROW	127	127		118	118					124	124							

NU = Not Used

* Denotes install load resistor. See load resistor installation detail this sheet.
 ★ See pictorial of head wiring in detail this sheet.

INPUT FILE POSITION LAYOUT

(front view)

FILE	1	2	3	4	5	6	7	8	9	10	11	12	13	14
U	∅ 1	∅ 1	∅ 2	∅ 3	∅ 4	∅ 5	∅ 6	∅ 7	∅ 8	∅ 9	∅ 10	∅ 11	∅ 12	∅ 13
L	1A	1B	2A,2B	3A	4A	5A	6A	7A	8A	9A	10A	11A	12A	13A
U	NOT USED	NOT USED	∅ 2	NOT USED	NOT USED	∅ 3	∅ 4	∅ 5	∅ 6	∅ 7	∅ 8	∅ 9	∅ 10	∅ 11
L	DC ISOLATOR	DC ISOLATOR	DC ISOLATOR	DC ISOLATOR	DC ISOLATOR	DC ISOLATOR	DC ISOLATOR	DC ISOLATOR	DC ISOLATOR	DC ISOLATOR	DC ISOLATOR	DC ISOLATOR	DC ISOLATOR	DC ISOLATOR

EX.: 1A, 2A, ETC. = LOOP NO.'S

FS = FLASH SENSE
 ST = STOP TIME

⊗ Wired Input - Do not populate slot with detector card


INPUT FILE CONNECTION & PROGRAMMING CHART

LOOP NO.	LOOP TERMINAL	INPUT FILE POS.	PIN NO.	DETECTOR NO.	NEMA PHASE	CALL	EXTEND TIME	DELAY TIME	ADDED INITIAL	DETECTOR TYPE
1A ¹	TB2-1,2	I1U	56	1	1	YES		15		S
1B	TB2-5,6	I2U	48	26	6	YES				S
2A, 2B	TB2-9,10	I3U	39	2	1	YES		15		S
2C	TB2-11,12	I3L	63	32	2	YES				S
3A ²	TB4-5,6	I5U	76	42	2	YES				S
	-	J8U	58	3	★	YES		15		S
4A	TB4-9,10	I6U	50	28	★	YES		3		S
6A	TB3-5,6	J2U	41	4	4	YES		10		S
7A	TB5-5,6	J5U	4	6	6	YES				S
7B	TB5-9,10	J6U	57	7	7	YES				S
8A	TB7-1,2	J7U	66	8	8	YES				S

- ¹Add jumper from I1-W to J4-W, on rear of input file.
²Add jumper from I5-W to J8-W, on rear of input file.
 ★ See the Vehicle Detector Setup Programming Detail for Alternate Phasing on sheet 2.

FYA SIGNAL WIRING DETAIL

(wire signal heads as shown)

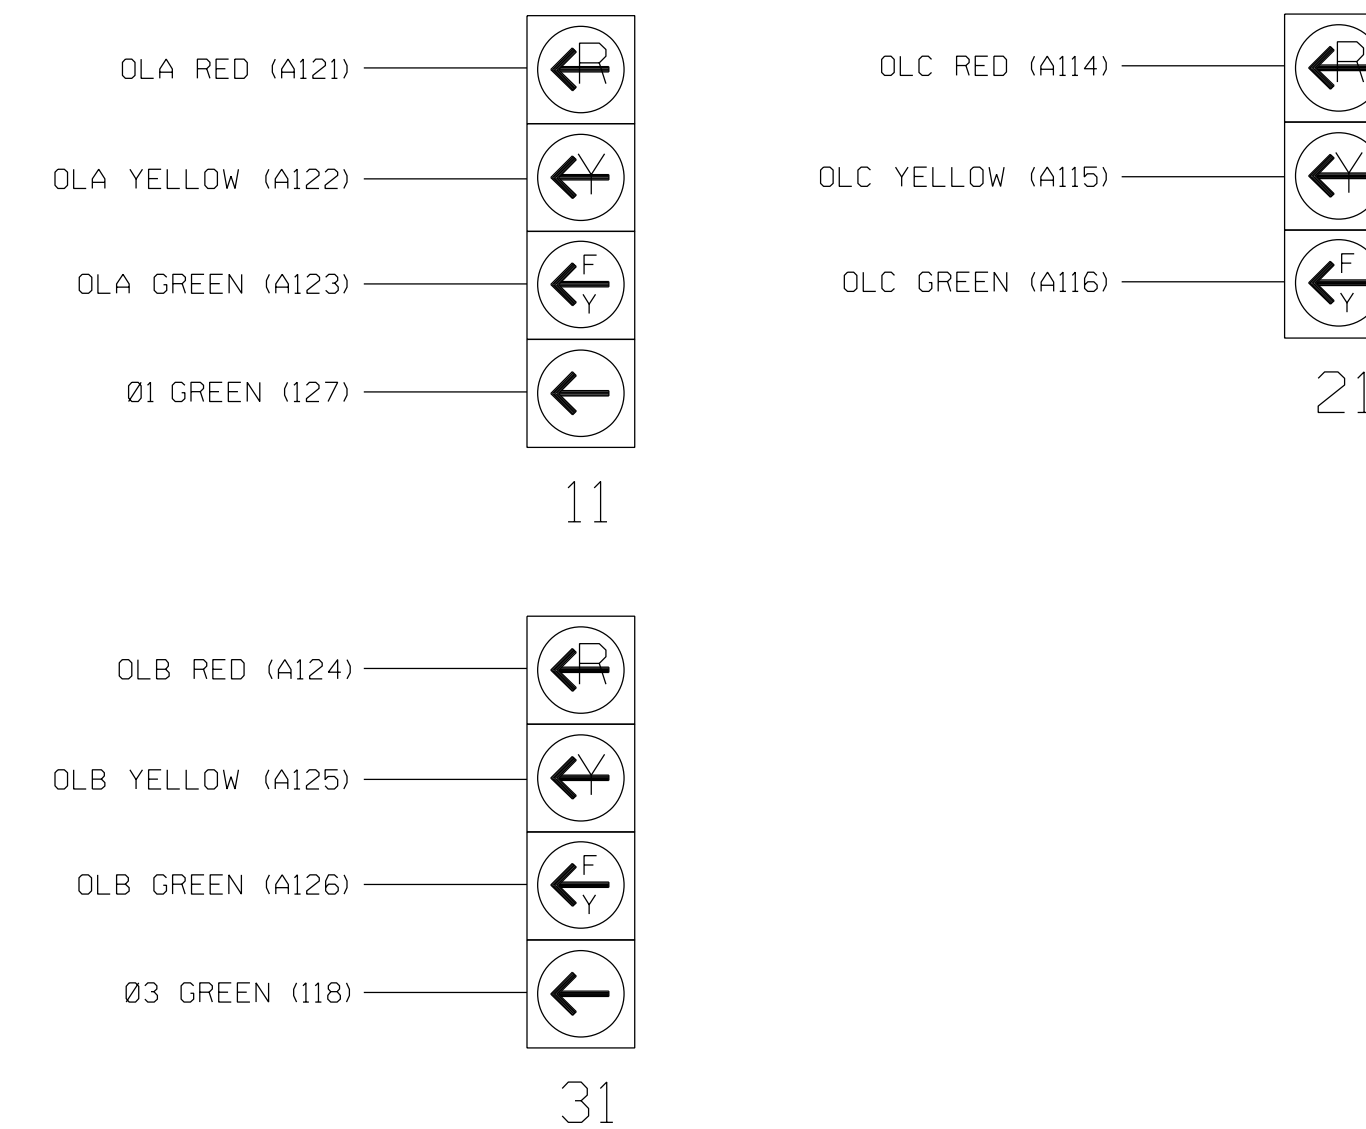


LOAD RESISTOR INSTALLATION DETAIL


(install resistors as shown)

ACCEPTABLE VALUES

VALUE (ohms)	WATTAGE
1.5K - 1.9K	25W (min)
2.0K - 3.0K	10W (min)

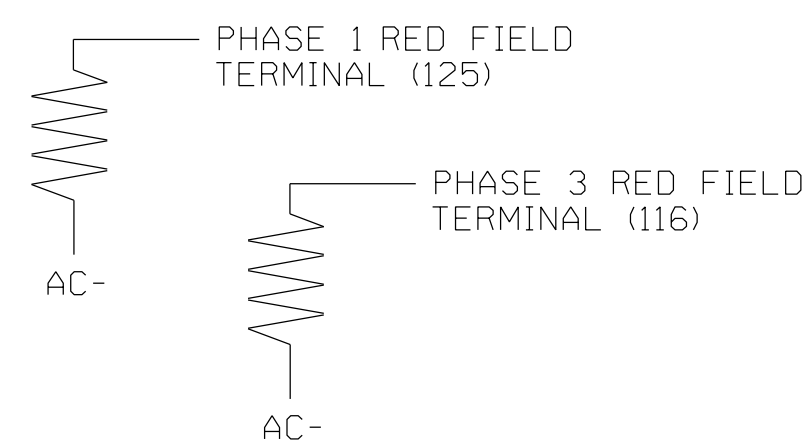

INPUT FILE POSITION LEGEND: J2L

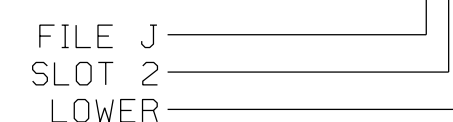

THIS ELECTRICAL DETAIL IS FOR THE SIGNAL DESIGN: 07-1422
 DESIGNED: March 2018
 SEALED: 6/7/2018
 REVISED: N/A

Electrical Detail - Sheet 1 of 3

DOCUMENT NOT CONSIDERED FINAL UNLESS ALL SIGNATURES COMPLETED

<p>Prepared for the Offices of:</p> <p>750 N. Greenfield Pkwy, Garner, NC 27529</p>	<p>SR 1308 (Garden Road) at Huffman Mill Plaza/ Chick-Fil-A</p>		<p>SEAL NORTH CAROLINA PROFESSIONAL ENGINEER SEAL 023489 PAMELA L. ALEXANDER</p>	
	<p>Division 7 Alamance County Burlington</p>	<p>PL Alexander</p>		<p>MB Toth</p>
	<p>REVISIONS</p>	<p>INIT.</p>		<p>DATE</p>

ATKINS 1616 EAST MILLBROOK ROAD, SUITE 160 RALEIGH, NORTH CAROLINA 27609 (919) 876-6888 NCBEES #F-0326

6/9/2018
 Pamela Alexander
 DATE

SIG. INVENTORY NO. 07-1422

ECONOLITE ASC/3-2070 VEHICLE DETECTOR SETUP PROGRAMMING DETAIL FOR ALTERNATE PHASING LOOP 3A *(program controller as shown)*

IMPORTANT!

Program detectors per the input file connection and programming chart shown on sheet 1 before proceeding.

- From Main Menu select **8. UTILITIES**
- From UTILITIES Submenu select **1. COPY/CLEAR**
- Copy from DETECTOR PLAN "1" to DETECTOR PLAN "2".

```

COPY / CLEAR UTILITY
FROM          TO
PHASE TIMING... > PHASE TIMING...
TIMING PLAN... > TIMING PLAN...
PH DET OPT PLAN. > PH DET OPT PLAN.
DETECTOR PLAN... 1 > DETECTOR PLAN... 2
TOGGLE TO SELECT A "FROM" AND A "TO"
THEN PRESS ENTER
  
```

- From Main Menu select **6. DETECTORS**
- From DETECTOR Submenu select **2. VEHICLE DETECTOR SETUP**
- Place cursor in VEH DET PLAN [] position and enter "2".

- Place cursor in VEH DETECTOR [] position and enter "3".
- Set delay time to "0".

```

VEH DETECTOR [ 3]  VEH DET PLAN [ 2]
TYPE: S-STANDARD
TS2 DETECTOR..... ECPI LOG..... NO
DET PH - 1 2 3 4 5 6 7 8 9 0 1 2 3 4 5 6
3 3
EXTEND TIME... 0.0 DELAY TIME... 0.0
USE ADDED INITIAL . CROSS SWITCH PH.. 0
LOCK IN..... NONE NTCIP VOL . OR OCC .
PMT QUEUE DELAY. NO
  
```

- Place cursor in VEH DETECTOR [] position and enter "28".
- Set assigned phase to "0".

```

VEH DETECTOR [28]  VEH DET PLAN [ 2]
TYPE: S-STANDARD
TS2 DETECTOR..... ECPI LOG..... NO
DET PH - 1 2 3 4 5 6 7 8 9 0 1 2 3 4 5 6
28 0
EXTEND TIME... 0.0 DELAY TIME... 3.0
USE ADDED INITIAL . CROSS SWITCH PH.. 0
LOCK IN..... NONE NTCIP VOL . OR OCC .
PMT QUEUE DELAY. NO
  
```

END PROGRAMMING

FLASHER CIRCUIT MODIFICATION DETAIL

IN ORDER TO ENSURE THAT SIGNALS FLASH CONCURRENTLY ON THE SAME APPROACH, MAKE THE FOLLOWING FLASHER CIRCUIT CHANGES:

- ON REAR OF PDA - REMOVE WIRE FROM TERM. T2-4 AND TERMINATE ON T2-2.
- ON REAR OF PDA - REMOVE WIRE FROM TERM. T2-5 AND TERMINATE ON T2-3.
- REMOVE FLASHER UNIT 2.

THE CHANGES LISTED ABOVE TIES ALL PHASES AND OVERLAPS TO FLASHER UNIT 1.

THIS ELECTRICAL DETAIL IS FOR
THE SIGNAL DESIGN: 07-1422
DESIGNED: March 2018
SEALED: 6/7/2018
REVISED: N/A

ECONOLITE ASC/3-2070 OVERLAP PROGRAMMING DETAIL *(program controller as shown)*

- From Main Menu select **2. CONTROLLER**
- From CONTROLLER Submenu select **2. VEHICLE OVERLAPS**

OVERLAP A

Select TMG VEH OVLP [A] and 'PPLT FYA'

```

TMG VEH OVLP...[A] TYPE: ....PPLT FYA
PROTECTED LEFT TURN.... PHASE 1
OPPOSING THROUGH..... PHASE 2

FLASHING ARROW OUTPUT....CH9 ISOLATE
DELAY START OF: FYA..0.0 CLEARANCE..0.0
ACTION PLAN SF BIT DISABLE..... 0
  
```

Toggle Once

OVERLAP B

Select TMG VEH OVLP [B] and 'PPLT FYA'

```

TMG VEH OVLP...[B] TYPE: ....PPLT FYA
PROTECTED LEFT TURN.... PHASE 3
OPPOSING THROUGH..... PHASE 4

FLASHING ARROW OUTPUT....CH10 ISOLATE
DELAY START OF: FYA..0.0 CLEARANCE..0.0
ACTION PLAN SF BIT DISABLE..... 3
  
```

← NOTICE ACTION
PLAN SF BIT "3"

Toggle Once

OVERLAP C

Select TMG VEH OVLP [C] and 'OTHER/ECONOLITE'

```


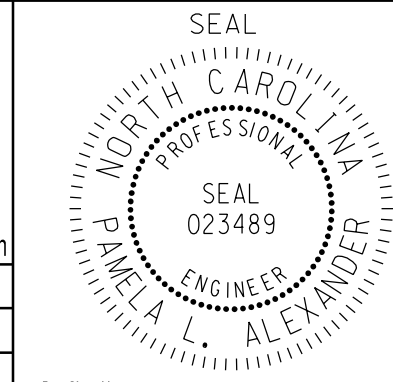
TMG VEH OVLP...[C] TYPE: OTHER/ECONOLITE
PHASES 1 2 3 4 5 6 7 8 9 0 1 2 3 4 5 6
INCLUDED . . . . . X . . . . .
PROTECT . . . . .
PED PRTC . . . . .
NOT OVLP . . . . .
FLSH GRN . . . . . 1 . . . . .
LAG X PH . . . . .
LAG 2 PH . . . . .

LAG GRN 0.0 YEL 0.0 RED 0.0 ADV GRN 0.0
  
```

END PROGRAMMING

Electrical Detail - Sheet 2 of 3

DOCUMENT NOT CONSIDERED
FINAL UNLESS ALL
SIGNATURES COMPLETED

	<p>SR 1308 (Garden Road) at Huffman Mill Plaza/ Chick-Fil-A</p> <p>Division 7 Alamance County Burlington</p> <p>PLAN DATE: March 2018 REVIEWED BY: MB Toth</p> <p>PREPARED BY: PL Alexander REVIEWED BY:</p>							
<table border="1" style="width: 100%; border-collapse: collapse;"> <thead> <tr> <th>REVISIONS</th> <th>INIT.</th> <th>DATE</th> </tr> </thead> <tbody> <tr> <td> </td> <td> </td> <td> </td> </tr> </tbody> </table>	REVISIONS	INIT.	DATE				<p>Drawn by: Pamela Alexander 6/9/2018</p> <p>DATE</p>	
REVISIONS	INIT.	DATE						
<p>SIG. INVENTORY NO. 07-1422</p>								

ALTERNATE PHASING ACTIVATION DETAIL

TO RUN ALT. PHASING DURING FREE RUN - PROGRAM CHANGES (SHOWN BELOW) IN A TIME BASED ACTION PLAN. SCHEDULE A DAY PLAN THAT INCLUDES THE ACTION PLAN PROGRAMMED TO SELECT VEH DET PLAN 2 AND ENABLE SF BIT 3.

TO RUN ALT. PHASING DURING COORDINATION - SELECT THE TIME BASED ACTION PLAN THAT IS PROGRAMMED TO SELECT VEH DET PLAN 2 AND ENABLE SF BIT 3.

PHASING	VEH DET PLAN	SF BITS ENABLED
ACTIONS REQUIRED TO RUN <u>DEFAULT PHASING</u>	1	NONE
ACTIONS REQUIRED TO RUN <u>ALTERNATE PHASING</u>	2	3

IMPORTANT: IF ALT. PHASING IS USED DURING FREE RUN AND COORDINATION, DO NOT OPERATE TIME OF DAY EVENTS CONCURRENTLY WITH COORDINATION PLAN EVENTS IN THE EVENT SCHEDULER. (EX. FREE RUN EVENT SHOULD END BEFORE COORDINATION PLAN EVENT STARTS AND VICE-VERSA).

ALTERNATE PHASING CHANGE SUMMARY

THE FOLLOWING IS A SUMMARY OF WHAT TAKES PLACE WHEN SF BIT 3 AND VEH DET PLAN 2 ACTIVATE TO CALL THE "ALTERNATE PHASING":

SF BIT 3: Modifies overlap parent phases for head 31 to run protected turns only.

VEH DET PLAN 2: Disables phase 8 call on loop 3A and reduces delay time for phase 3 call on loop 3A to 0 seconds.

ECONOLITE ASC/3-2070 ACTION PLAN PROGRAMMING DETAIL

- From Main Menu select 5. TIME BASE
- From TIME BASE Submenu select 2. ACTION PLAN

```

ACTION PLAN...[ 1]
PATTERN.....AUTO  SYS OVERRIDE.... NO
TIMING PLAN..... 0  SEQUENCE..... 0
VEH DETECTOR PLAN.. 2  DET LOG.....NONE
FLASH..... --  RED REST..... NO
VEH DET DIAG PLN... 0  PED DET DIAG PLN..0
DIMMING ENABLE.. NO  PRIORITY RETURN. NO
PED PR RETURN.. NO  QUEUE DELAY..... NO
PMT COND DELAY  NO


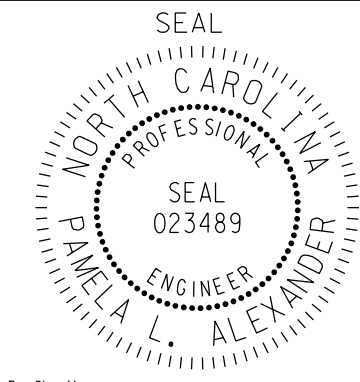
  PHASE  1  2  3  4  5  6  7  8  9  0  1  2  3  4  5  6
PED RCL  .  .  .  .  .  .  .  .  .  .  .  .  .  .  .  .
WALK 2   .  .  .  .  .  .  .  .  .  .  .  .  .  .  .  .
VEX 2    .  .  .  .  .  .  .  .  .  .  .  .  .  .  .  .
VEH RCL  .  .  .  .  .  .  .  .  .  .  .  .  .  .  .  .
MAX RCL  .  .  .  .  .  .  .  .  .  .  .  .  .  .  .  .
MAX 2    .  .  .  .  .  .  .  .  .  .  .  .  .  .  .  .
  PHASE  1  2  3  4  5  6  7  8  9  0  1  2  3  4  5  6
MAX 3    .  .  .  .  .  .  .  .  .  .  .  .  .  .  .  .
CS INH   .  .  .  .  .  .  .  .  .  .  .  .  .  .  .  .
OMIT     .  .  .  .  .  .  .  .  .  .  .  .  .  .  .  .
SPC FCT  .  .  X  .  .  .  .  .  .  .  .  .  .  .  .  .
AUX FCT  .  .  .  (1-3)

  1  2  3  4  5  6  7  8  9  0  1  2  3  4  5
LP 1-15  .  .  .  .  .  .  .  .  .  .  .  .  .  .  .
LP 16-30 .  .  .  .  .  .  .  .  .  .  .  .  .  .  .
LP 31-45 .  .  .  .  .  .  .  .  .  .  .  .  .  .  .
LP 46-60 .  .  .  .  .  .  .  .  .  .  .  .  .  .  .
LP 61-75 .  .  .  .  .  .  .  .  .  .  .  .  .  .  .
LP 76-90 .  .  .  .  .  .  .  .  .  .  .  .  .  .  .
LP 91-100 .  .  .  .  .  .  .  .  .  .  .  .  .  .  .
    
```

THIS ELECTRICAL DETAIL IS FOR
 THE SIGNAL DESIGN: 07-1422
 DESIGNED: March 2018
 SEALED: 6/7/2018
 REVISED: N/A


Electrical Detail - Sheet 3 of 3

DOCUMENT NOT CONSIDERED FINAL UNLESS ALL SIGNATURES COMPLETED

ELECTRICAL AND PROGRAMMING DETAILS FOR: Prepared for the Offices of: 	SR 1308 (Garden Road) at Huffman Mill Plaza/ Chick-Fil-A Division 7 Alamance County Burlington PLAN DATE: March 2018 REVIEWED BY: MB Toth PREPARED BY: PL Alexander REVIEWED BY:	SEAL  SEAL 023489 PAMELA L. ALEXANDER ENGINEER
REVISIONS INIT. DATE		Date: 6/9/2018 Signature: Pamela Alexander Date:
		SIG. INVENTORY NO. 07-1422

09-JUN-2018 14:14
 ***SIGNALS.COM\PROJECTS\SR1308\TransportationTraffic\Currr*00056469 U-6015 B-6 Sig Sys*Task 05-11-SIGNALS\06as\gn\WIF.rng\07-1422E.dgn
 ALEX3361 AT LUS510649

PHASING DIAGRAM

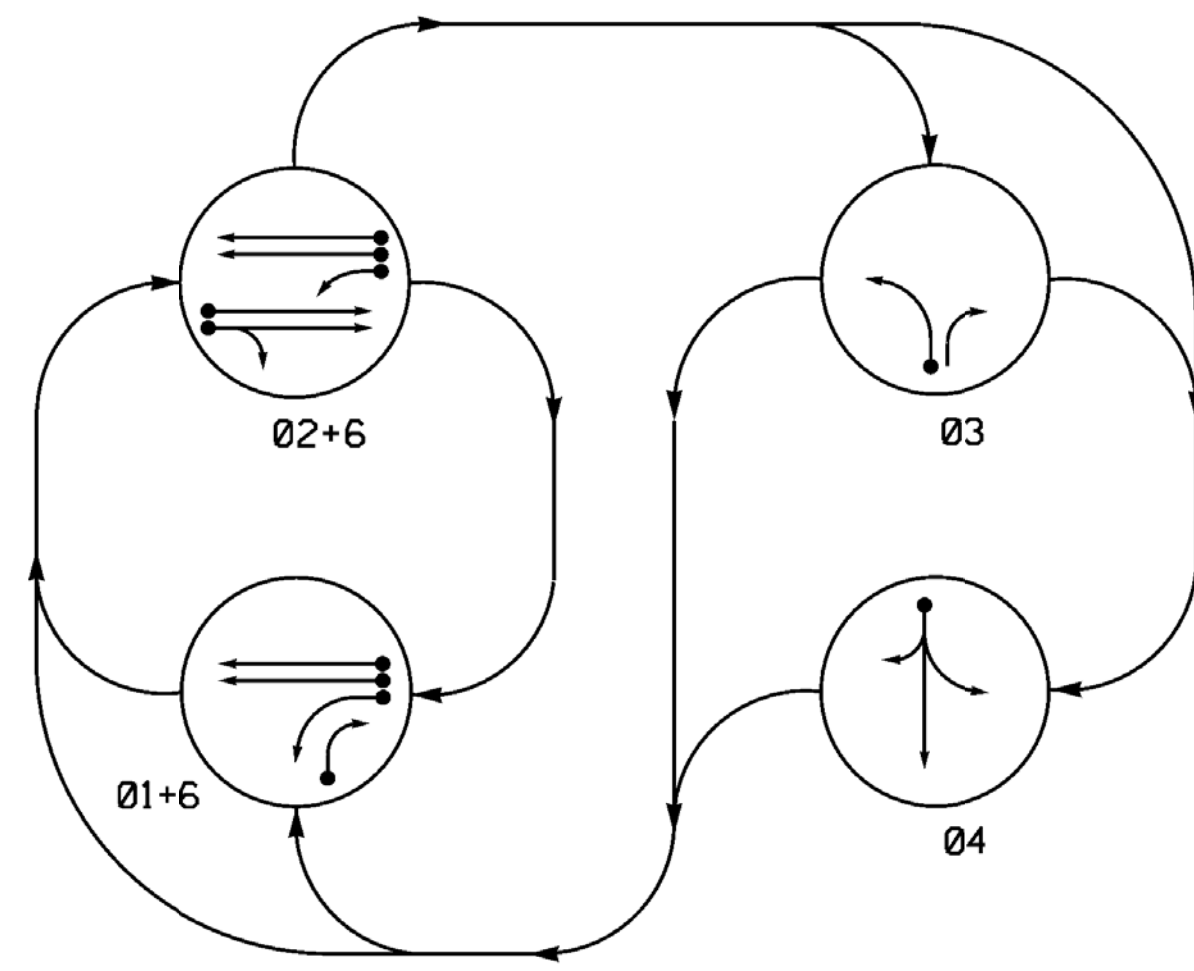


PHASING DIAGRAM DETECTION LEGEND

- ←●→ DETECTED MOVEMENT
- ←○→ UNDETECTED MOVEMENT (OVERLAP)
- ←---→ UNSIGNALIZED MOVEMENT
- ←- - -> PEDESTRIAN MOVEMENT

SIGNAL FACE	PHASE				
	01+6	02+6	03	04	FLASH
11	-	F	R	R	Y
21, 22	R	G	R	R	Y
31	R	R	G	R	R
32	R	R	G	R	R
41	R	R	R	G	R
42	R	R	R	G	R
61, 62	G	G	R	R	Y

SIGNAL FACE I.D.

All Heads L.E.D.

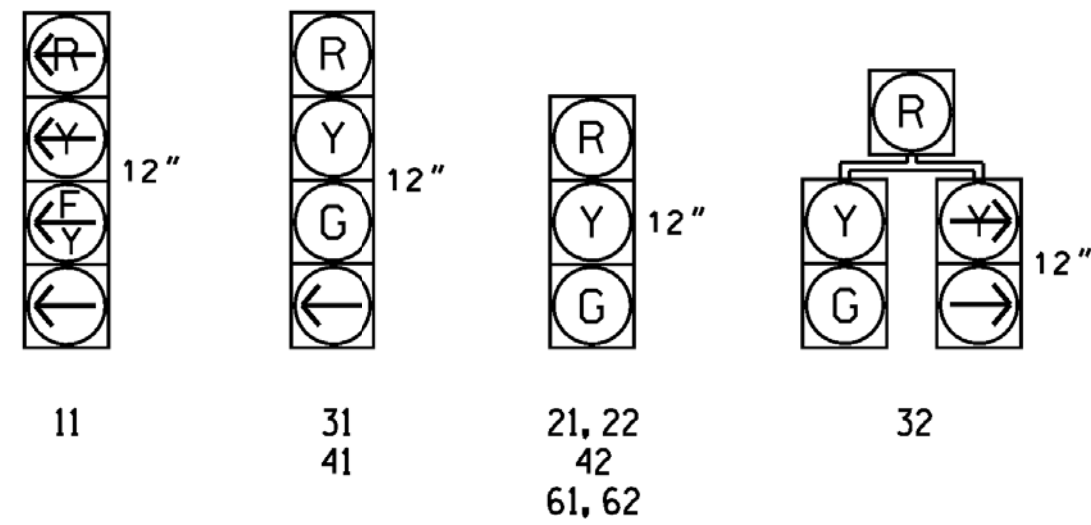


ASC/3 DETECTOR INSTALLATION CHART											
DETECTOR				PROGRAMMING							
LOOP	SIZE (FT)	DISTANCE FROM STOPBAR (FT)	TURNS	NEW LOOP	PHASE	CALLING	EXTEND TIME	DELAY TIME	USE ADDED INITIAL	TYPE	NEW CARD
1A	6X40	+5	2-4-2	-	1	Yes	-	15	-	S	X
					6	Yes	-	-	-	S	X
1B	6X60	0	EXIST	-	1	Yes	-	15	-	S	X
2A,2B	6X6	70	EXIST	-	2	Yes	-	-	-	S	X
3A	6X60	0	EXIST	-	3	Yes	-	3	-	S	X
4A	6X19	0	EXIST	-	4	Yes	-	10	-	S	X
6A,6B	6X60	70	EXIST	-	6	Yes	-	-	-	S	X

4 Phase Fully Actuated (Burlington-Graham Signal System)

NOTES

- Refer to "Roadway Standard Drawings NCDOT" dated January 2018 and "Standard Specifications for Roads and Structures" dated January 2018.
- Do not program signal for late night flashing operation unless otherwise directed by the Engineer.
- Phase 1 may be lagged.
- The order of phases 3 and 4 may be reversed.
- Reposition existing signal head number 62.
- Set all detector units to presence mode.
- In the event of loop replacement, refer to the current ITS and Signals Design Manual and submit a Plan of Record to the Signal Design Section.
- Locate new cabinet so as not to obstruct sight distance of vehicles turning right on red.
- Pavement markings are existing unless otherwise noted on plans.
- Maximum times shown in timing chart are for free-run operation only. Coordinated signal system timing values supersede these values.

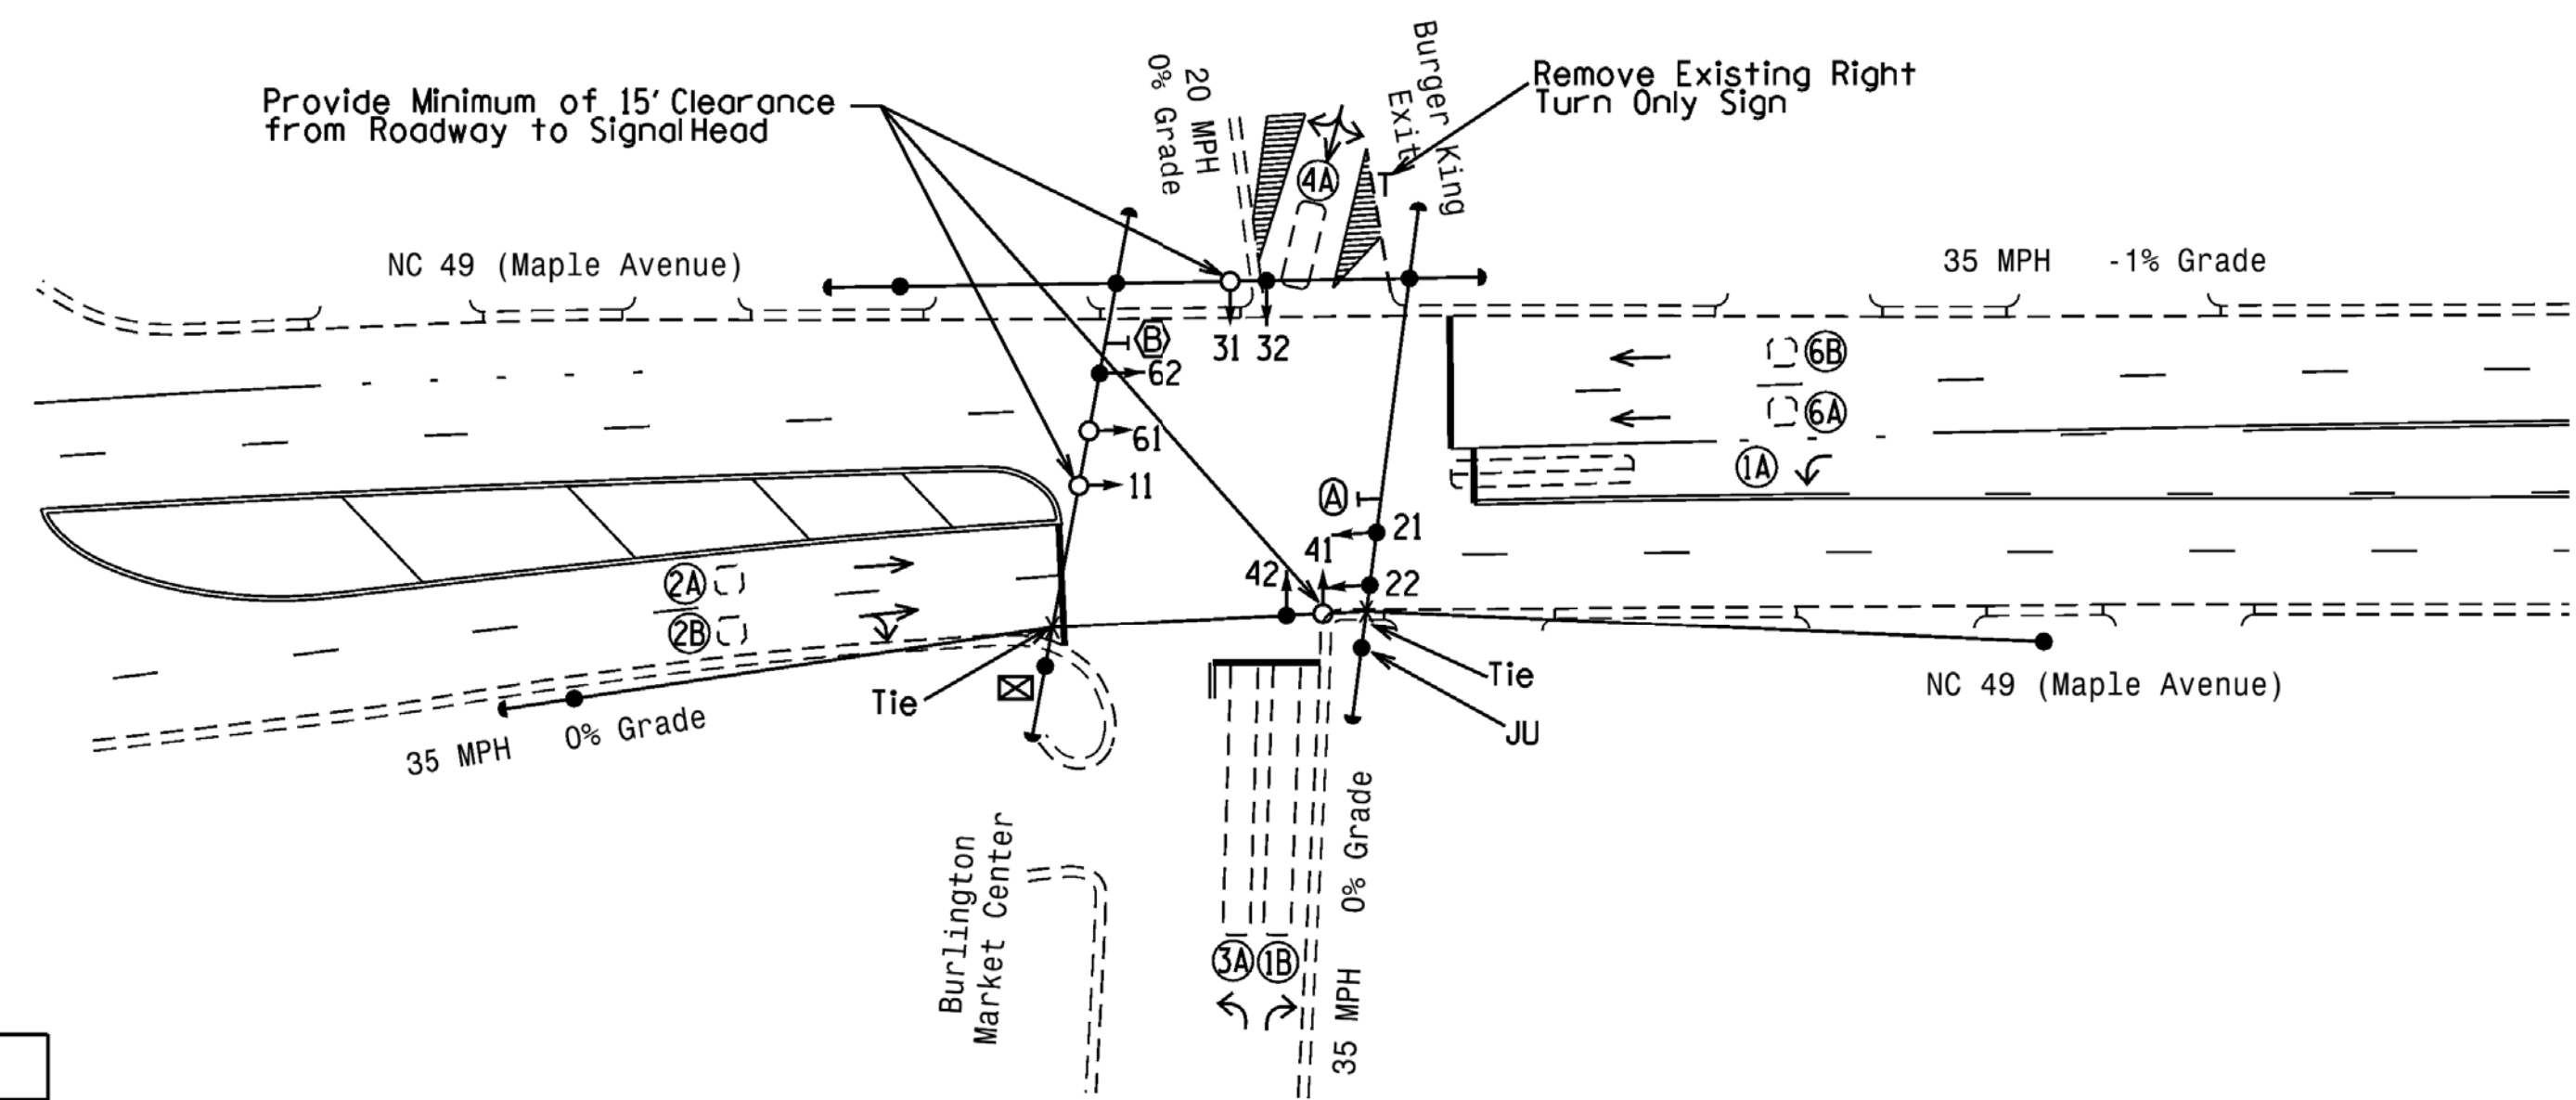

FEATURE	ASC/3 TIMING CHART				
	1	2	3	4	6
Min Green *	7	10	7	7	10
Walk *	0	0	0	0	0
Ped Clear	0	0	0	0	0
Veh. Extension *	2.0	3.0	2.0	3.5	3.0
Max I *	15	35	15	15	35
Yellow	3.0	3.9	3.0	3.0	3.9
Red Clear	2.3	1.4	1.9	2.6	1.4
Actuations B4 Add *	-	-	-	-	-
Seconds /Actuation *	-	-	-	-	-
Max Initial *	-	-	-	-	-
Time Before Reduction *	-	-	-	-	-
Time To Reduce *	-	-	-	-	-
Minimum Gap	-	-	-	-	-
Locking Detector	-	X	-	-	X
Recall Position	-	VEH. RECALL	-	-	VEH. RECALL
Dual Entry	-	-	-	-	-
Simultaneous Gap	X	X	X	X	X

* These values may be field adjusted. Do not adjust Min Green and Extension times for phases 2 and 6 lower than what is shown. Min Green for all other phases should not be lower than 4 seconds.

LEGEND

- | | | | |
|--|--|--|--|
| | PROPOSED Traffic Signal Head | | EXISTING Traffic Signal Head |
| | PROPOSED Modified Signal Head | | EXISTING N/A |
| | PROPOSED Pedestrian Signal Head | | EXISTING N/A |
| | PROPOSED Signal Pole with Guy | | EXISTING Signal Pole with Guy |
| | PROPOSED Signal Pole with Sidewalk Guy | | EXISTING Signal Pole with Sidewalk Guy |
| | PROPOSED Inductive Loop Detector | | EXISTING Inductive Loop Detector |
| | PROPOSED Controller & Cabinet | | EXISTING Junction Box |
| | PROPOSED Junction Box | | EXISTING Junction Box |
| | PROPOSED 2-in Underground Conduit | | EXISTING 2-in Underground Conduit |
| | PROPOSED Right of Way | | EXISTING Right of Way |
| | PROPOSED Directional Arrow | | EXISTING Directional Arrow |
| | PROPOSED No Left Turn Sign (R3-2) | | EXISTING No Left Turn Sign (R3-2) |
| | PROPOSED No Right Turn Sign (R3-1) | | EXISTING No Right Turn Sign (R3-1) |

*****SYSTEM*****
 *****USER*****

Mattern & Craig
ENGINEERS • SURVEYORS

12 BROAD STREET
ASHEVILLE, NORTH CAROLINA 28801
(828) 254-2201
FAX (828) 254-4562
NC LIC. NO. C-1154

Signal Upgrade

DOCUMENT NOT CONSIDERED FINAL UNLESS ALL SIGNATURES COMPLETED

Prepared for the Offices of:

 NC 49 (Maple Avenue) at Burger King Exit/ Burlington Market Center

Division 7 Alamance County Burlington
 PLAN DATE: November 2017 REVIEWED BY: J. Voso
 PREPARED BY: S. Homewood REVIEWED BY:


SCALE 1"=40'

SEAL

 James Voso 6/13/2018
 SIGNATURE DATE
 SIG. INVENTORY NO. 07-1423


EDI MODEL 2018EClip-NC CONFLICT MONITOR PROGRAMMING DETAIL

(remove jumpers and set switches as shown)

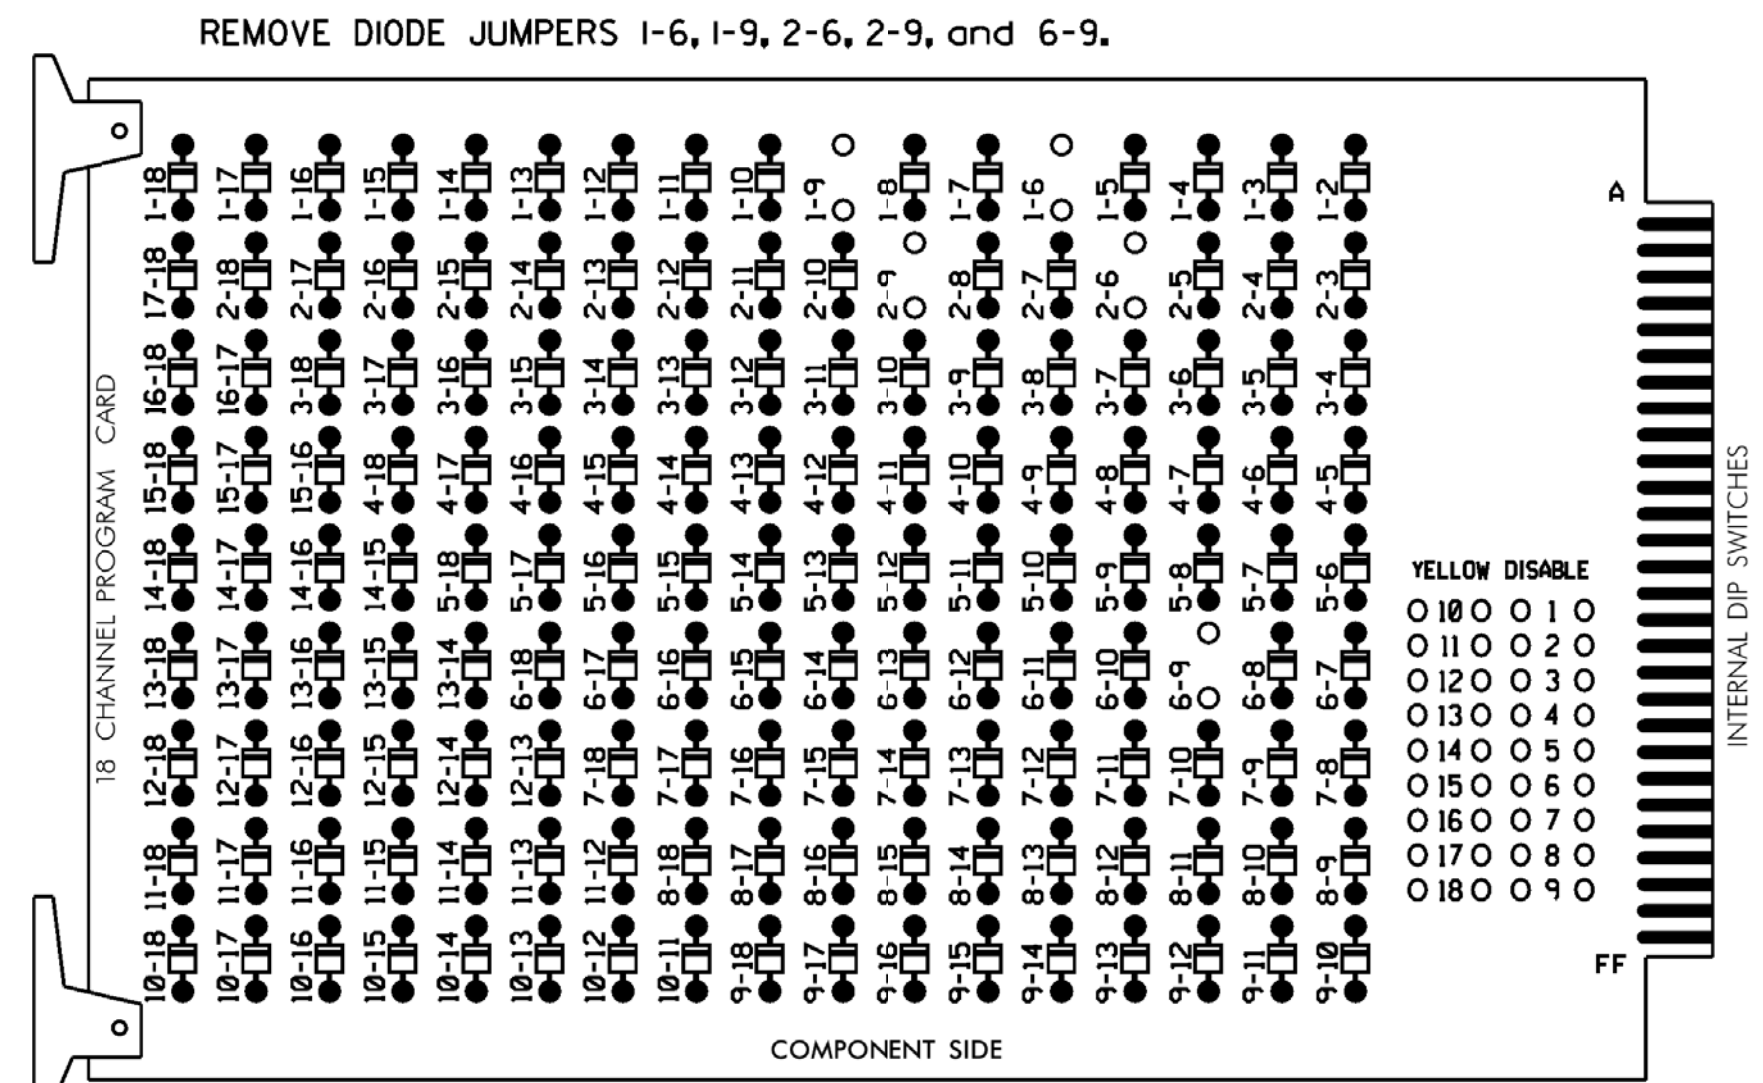

NOTES:

- Card is provided with all diode jumpers in place. Removal of any jumper allows its channels to run concurrently.
- Ensure jumpers SEL2-SEL5 and SEL9 are present on the monitor board.
- Ensure that Red Enable is active at all times during normal operation.
- Integrate monitor with Ethernet network in cabinet.

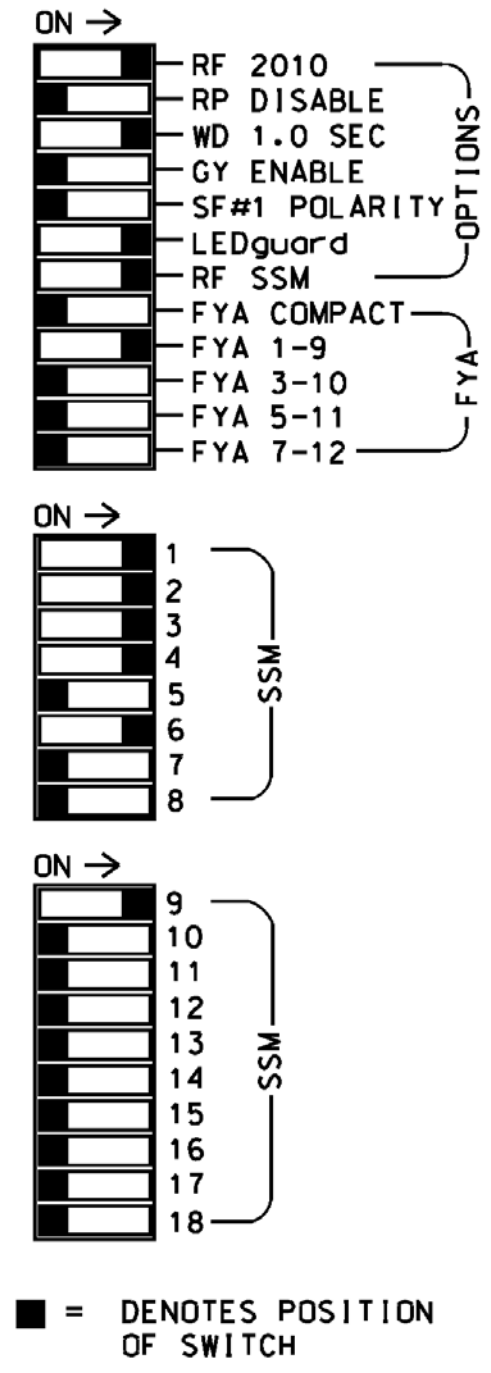

NOTES

- To prevent "flash-conflict" problems, insert red flash program blocks for all unused vehicle load switches in the output file. The installer shall verify that signal heads flash in accordance with the Signal Plans.
- Program controller to start up in phase 2 Green and 6 Green.
- The cabinet and controller are part of the Burlington-Graham Signal System.

EQUIPMENT INFORMATION

CONTROLLER.....2070LX
 CABINET.....332 W/AUX
 SOFTWARE.....ECONOLITE ASC/3-2070
 CABINET MOUNT.....BASE
 OUTPUT FILE POSITIONS...18 WITH AUX. OUTPUT FILE
 LOAD SWITCHES USED.....S1,S2,S4,S5,S8,AUX S1
 PHASES USED.....1,2,3,4,6
 OVERLAP "A".....*
 OVERLAP "B".....NOT USED
 OVERLAP "C".....NOT USED
 OVERLAP "D".....NOT USED

* See overlap programming detail on sheet 2

SIGNAL HEAD HOOK-UP CHART

LOAD SWITCH NO.	S1	S2	S3	S4	S5	S6	S7	S8	S9	S10	S11	S12	AUX S1	AUX S2	AUX S3	AUX S4	AUX S5	AUX S6	
GMU CHANNEL NO.	1	2	13	3	4	14	5	6	15	7	8	16	9	10	17	11	12	18	
PHASE	1	2	2 PED	3	4	4 PED	5	6	6 PED	7	8	8 PED	OLA	OLB	SPARE	OLC	OLD	SPARE	
SIGNAL HEAD NO.	11*	32	21,22	NU	31	32	41	42	NU	NU	61,62	NU	NU	NU	NU	NU	NU	NU	
RED	*	128		116	116	101	101				134								
YELLOW		129		117	117	102	102				135								
GREEN		130		118	118	103	103				136								
RED ARROW																		A121	
YELLOW ARROW		126																	A122
FLASHING YELLOW ARROW																			A123
GREEN ARROW	127	127		118	103														

NU = Not Used

* Denotes install load resistor. See load resistor installation detail this sheet.

* See pictorial of head wiring in detail this sheet.

INPUT FILE POSITION LAYOUT

(front view)

FILE "I"	1	2	3	4	5	6	7	8	9	10	11	12	13	14
U	∅ 1	∅ 2	∅ 1	S	∅ 3	∅ 4	S	S	S	S	S	S	S	S
L	1A	2A,2B	1B	NOT USED	3A	4A	NOT USED	NOT USED	NOT USED	NOT USED	NOT USED	NOT USED	NOT USED	NOT USED
U	NOT USED	NOT USED	NOT USED	S	∅ 6	S	S	S	S	S	S	S	S	S
L	DC ISOLATOR	DC ISOLATOR	DC ISOLATOR	DC ISOLATOR	DC ISOLATOR	DC ISOLATOR	DC ISOLATOR	DC ISOLATOR	DC ISOLATOR	DC ISOLATOR	DC ISOLATOR	DC ISOLATOR	DC ISOLATOR	DC ISOLATOR

EX.: 1A, 2A, ETC. = LOOP NO.'S

⊗ Wired Input - Do not populate slot with detector card


FS = FLASH SENSE
 ST = STOP TIME

INPUT FILE CONNECTION & PROGRAMMING CHART

LOOP NO.	LOOP TERMINAL	INPUT FILE POS.	PIN NO.	DETECTOR NO.	NEMA PHASE	CALL	EXTEND TIME	DELAY TIME	ADDED INITIAL	DETECTOR TYPE
1A ¹	TB2-1,2	I1U	56	1	1	YES		15		S
		J4U	48	26	6	YES				S
1B	TB2-9,10	I3U	63	32	1	YES		15		S
2A,2B	TB2-5,6	I2U	39	2	2	YES				S
3A	TB4-5,6	I5U	58	3	3	YES		3		S
4A	TB4-9,10	I6U	41	4	4	YES		10		S
6A	TB3-5,6	J2U	40	6	6	YES				S


¹Add jumper from I1-W to J4-W, on rear of input file.

INPUT FILE POSITION LEGEND: J2L

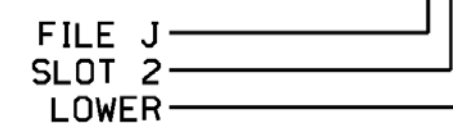

FYA SIGNAL WIRING DETAIL


(wire signal head as shown)

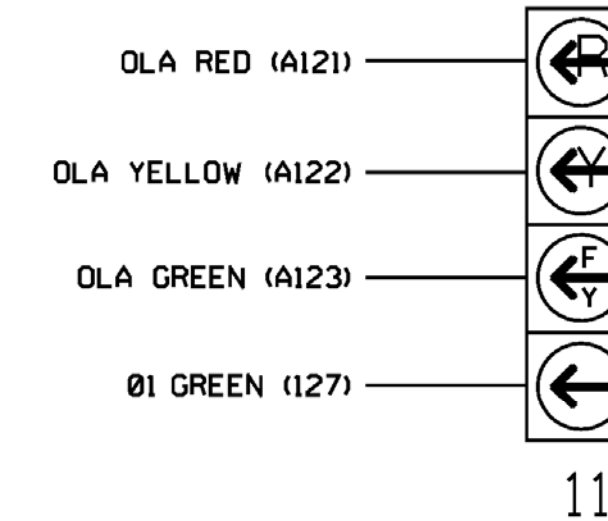

LOAD RESISTOR INSTALLATION DETAIL

(install resistor as shown below)

VALUE (ohms)	WATTAGE
1.5K - 1.9K	25W (min)
2.0K - 3.0K	10W (min)

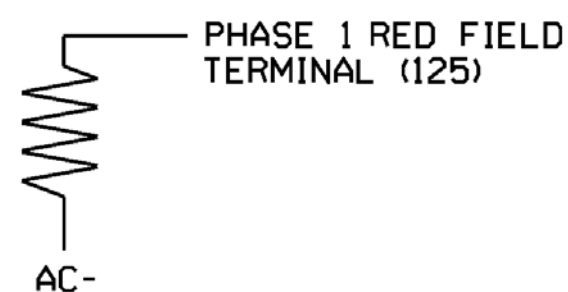

*****SYTIME*****



12 BROAD STREET
 ASHEVILLE, NORTH CAROLINA 28801
 (828) 254-2201
 FAX (828) 254-4562
 NC LIC. NO. C-1154

Electrical Detail - Sheet 1 of 2

DOCUMENT NOT CONSIDERED FINAL UNLESS ALL SIGNATURES COMPLETED

SEAL
 NORTH CAROLINA PROFESSIONAL ENGINEER
 JAMES B. VOSS
 022599
 6/13/2018

Prepared for the Offices of:
 City of Asheville, North Carolina
 Department of Public Works
 Signal Management

NC 49 (Maple Avenue) at Burger King Exit/Burlington Market Center
 Division 7, Alamance County, Burlington
 PLAN DATE: November 2017 REVIEWED BY: J. Vosso
 PREPARED BY: S. Homewood REVIEWED BY:

REVISIONS	INIT.	DATE

750 N. Greenfield Pkwy, Garner, NC 27529

ECONOLITE ASC/3-2070 OVERLAP PROGRAMMING DETAIL

(program controller as shown)

1. From Main Menu select 2. CONTROLLER
2. From CONTROLLER Submenu select 2. VEHICLE OVERLAPS

OVERLAP A

Select TMG VEH OVLP [A] and 'PPLT FYA'

```

TMG VEH OVLP...[A] TYPE: ....PPLT FYA
PROTECTED LEFT TURN.... PHASE 1
OPPOSING THROUGH..... PHASE 2

FLASHING ARROW OUTPUT....CH9 ISOLATE
DELAY START OF: FYA..0.0 CLEARANCE..0.0
ACTION PLAN SF BIT DISABLE..... 0
  
```

END PROGRAMMING


THIS ELECTRICAL DETAIL IS FOR
 THE SIGNAL DESIGN: 07-1423
 DESIGNED: November 2017
 SEALED: 6/13/2018
 REVISED: NA

Electrical Detail - Sheet 2 of 2



Mattern & Craig
 ENGINEERS • SURVEYORS
 12 BROAD STREET
 ASHEVILLE, NORTH CAROLINA 28801
 (828) 254-2201
 FAX (828) 254-4562
 NC LIC. NO. C-1154

ELECTRICAL AND PROGRAMMING
 DETAILS FOR:




Prepared for the Offices of:
 750 N. Greenfield Pkwy, Garner, NC 27529

NC 49 (Maple Avenue)	
at Burger King Exit/ Burlington Market Center	
Division 7	Alamance County Burlington
PLAN DATE: November 2017	REVIEWED BY: J. Vosso
PREPARED BY: S. Homewood	REVIEWED BY:
REVISIONS	INIT. DATE

**DOCUMENT NOT CONSIDERED
 FINAL UNLESS ALL
 SIGNATURES COMPLETED**

SEAL

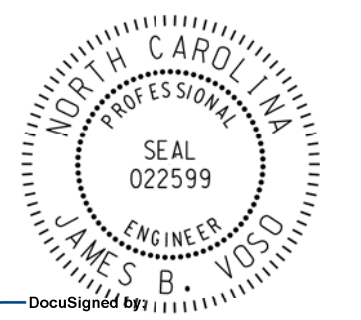

James Vosso
 6/13/2018
 1449FD603792044F
 DATE

SIG. INVENTORY NO. 07-1423

\$\$\$SYTIME\$\$\$\$
 \$\$\$DDON\$\$\$\$
 \$\$\$SERNAME\$\$\$\$

