



PROJECT REFERENCE NO. 1-5952	SHEET NO. 4
RW SHEET NO.	
ROADWAY DESIGN ENGINEER SCOTT A. JONES SEAL 045458 NORTH CAROLINA PROFESSIONAL ENGINEER	HYDRAULICS ENGINEER W. CALVIN BATES SEAL 022000 NORTH CAROLINA PROFESSIONAL ENGINEER
DocuSigned by: Scott Jones 9/19/2018	DocuSigned by: W. Calvin Bates 9/19/2018
<b>DOCUMENT NOT CONSIDERED FINAL UNLESS ALL SIGNATURES COMPLETED</b>	

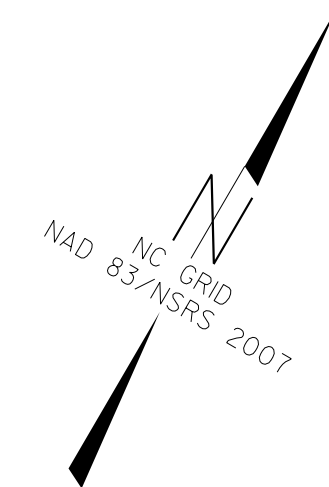

BEGIN PROJECT 1-5952  
END PROJECT 1-0911A  
-L- POT STA 210+00.00

PI Sta 232+16.32  
Δ = 13° 33' 16.3" (LT)  
D = 0' 30' 04.6"  
L = 2,704.01'  
T = 1,358.34'  
R = 11,430.00'

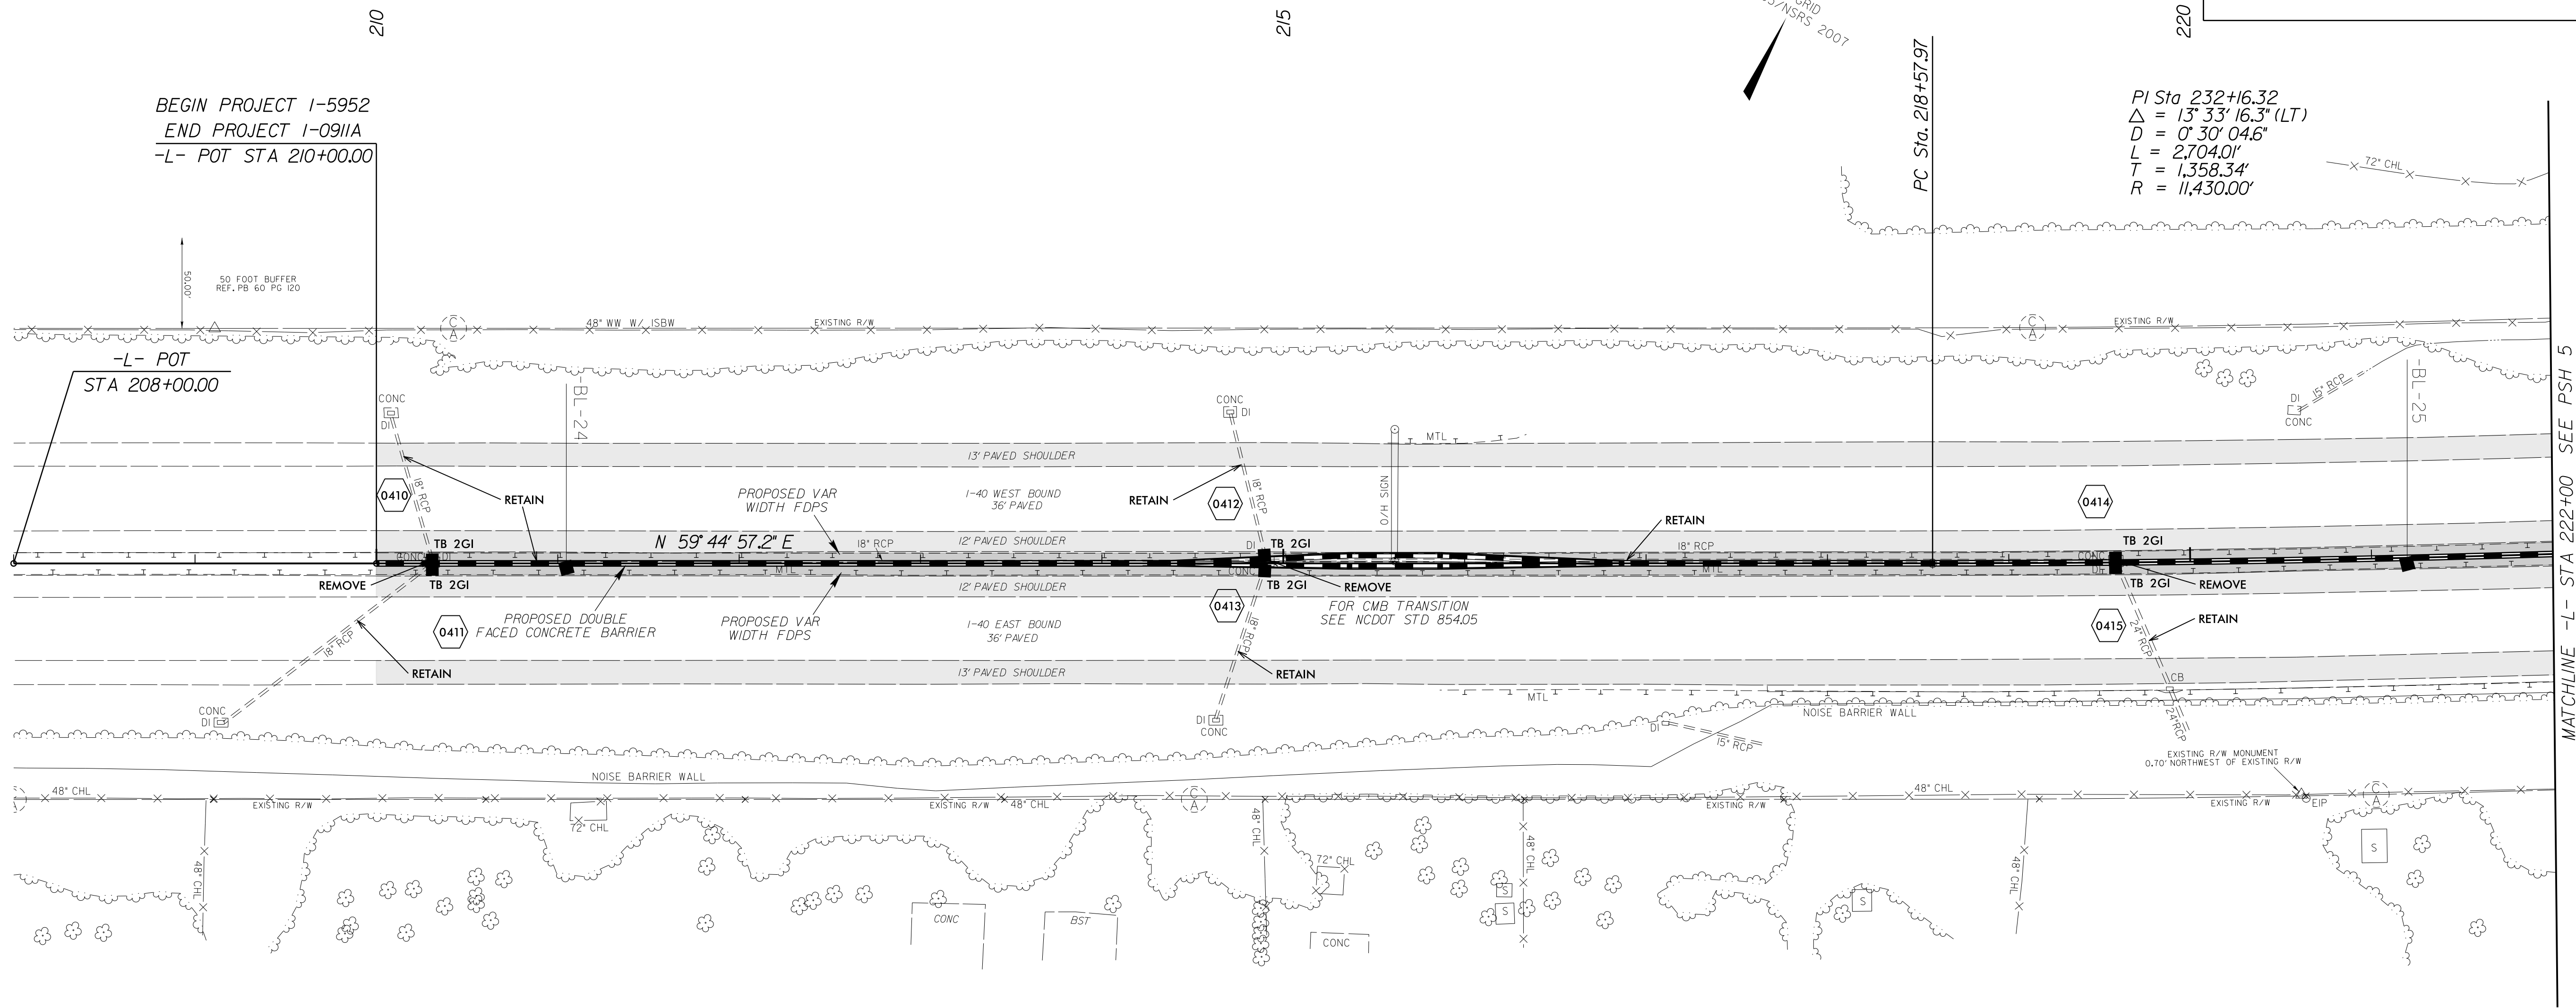

REVISIONS

MATCHLINE -L- STA 222+00 SEE PSH 5

8/17/99  
19 SEP 2018 10:02  
C:\Users\scottjones\Documents\TIP\_Projects\1-5952-40-West\_Forsyth\_Roadway\Design\_Files\1-5952-ddc\_psh4.dgn